




FED. ROAD DIST. NO.	STATE	FED. AID PROJ. NO.	FISCAL YEAR	SHEET NO.	TOTAL SHEETS
HAWAII	HAW.	STP-0700 (43)	1998	133	141

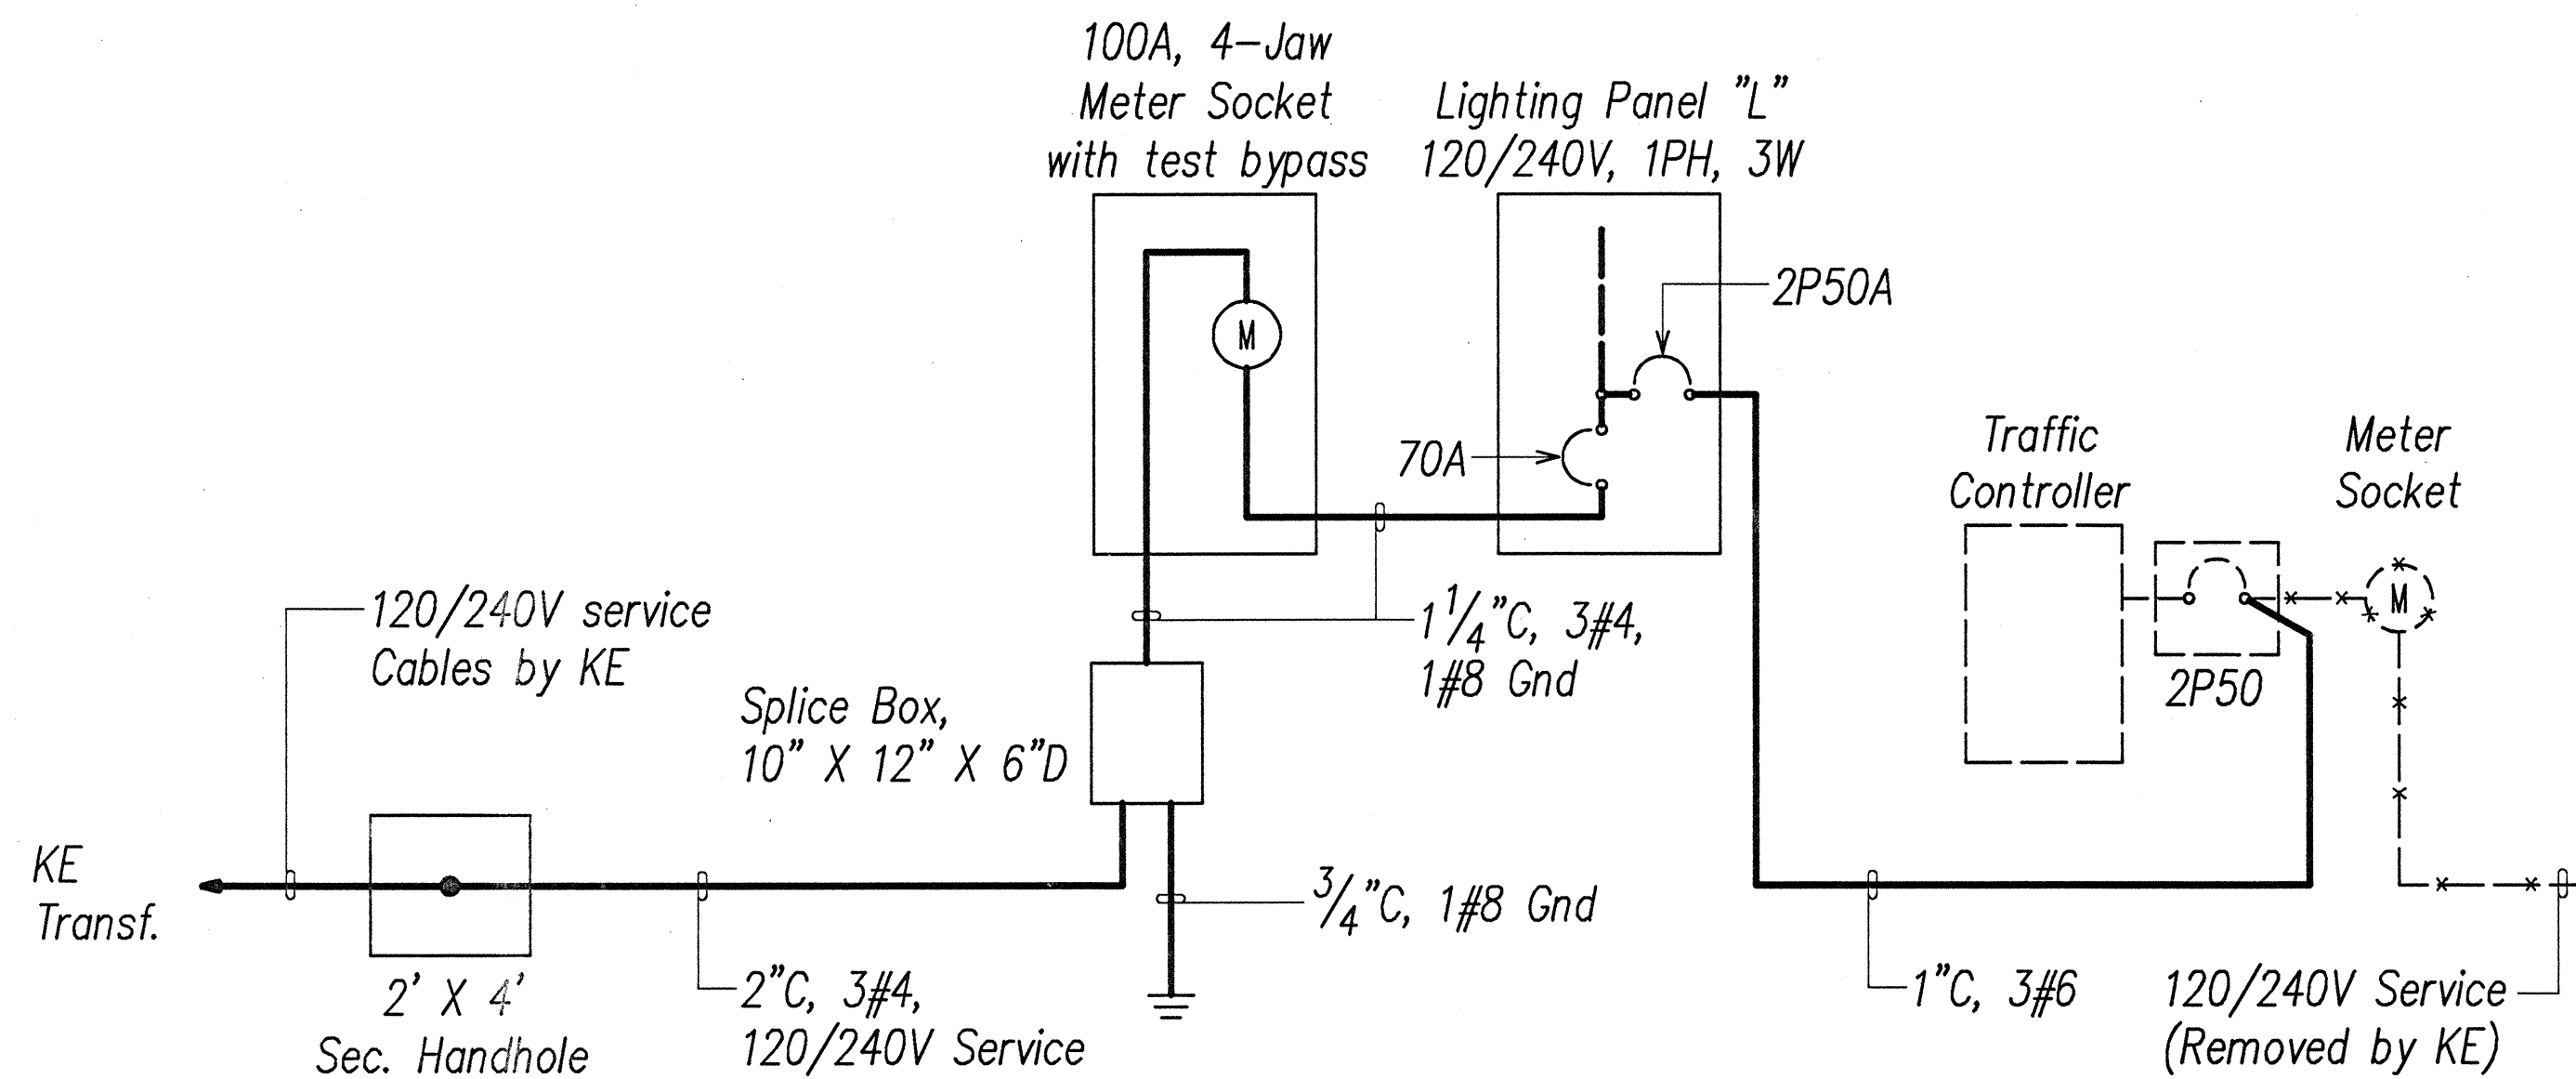


LANDSCAPE LIGHTING PANEL SERVICE DIAGRAM

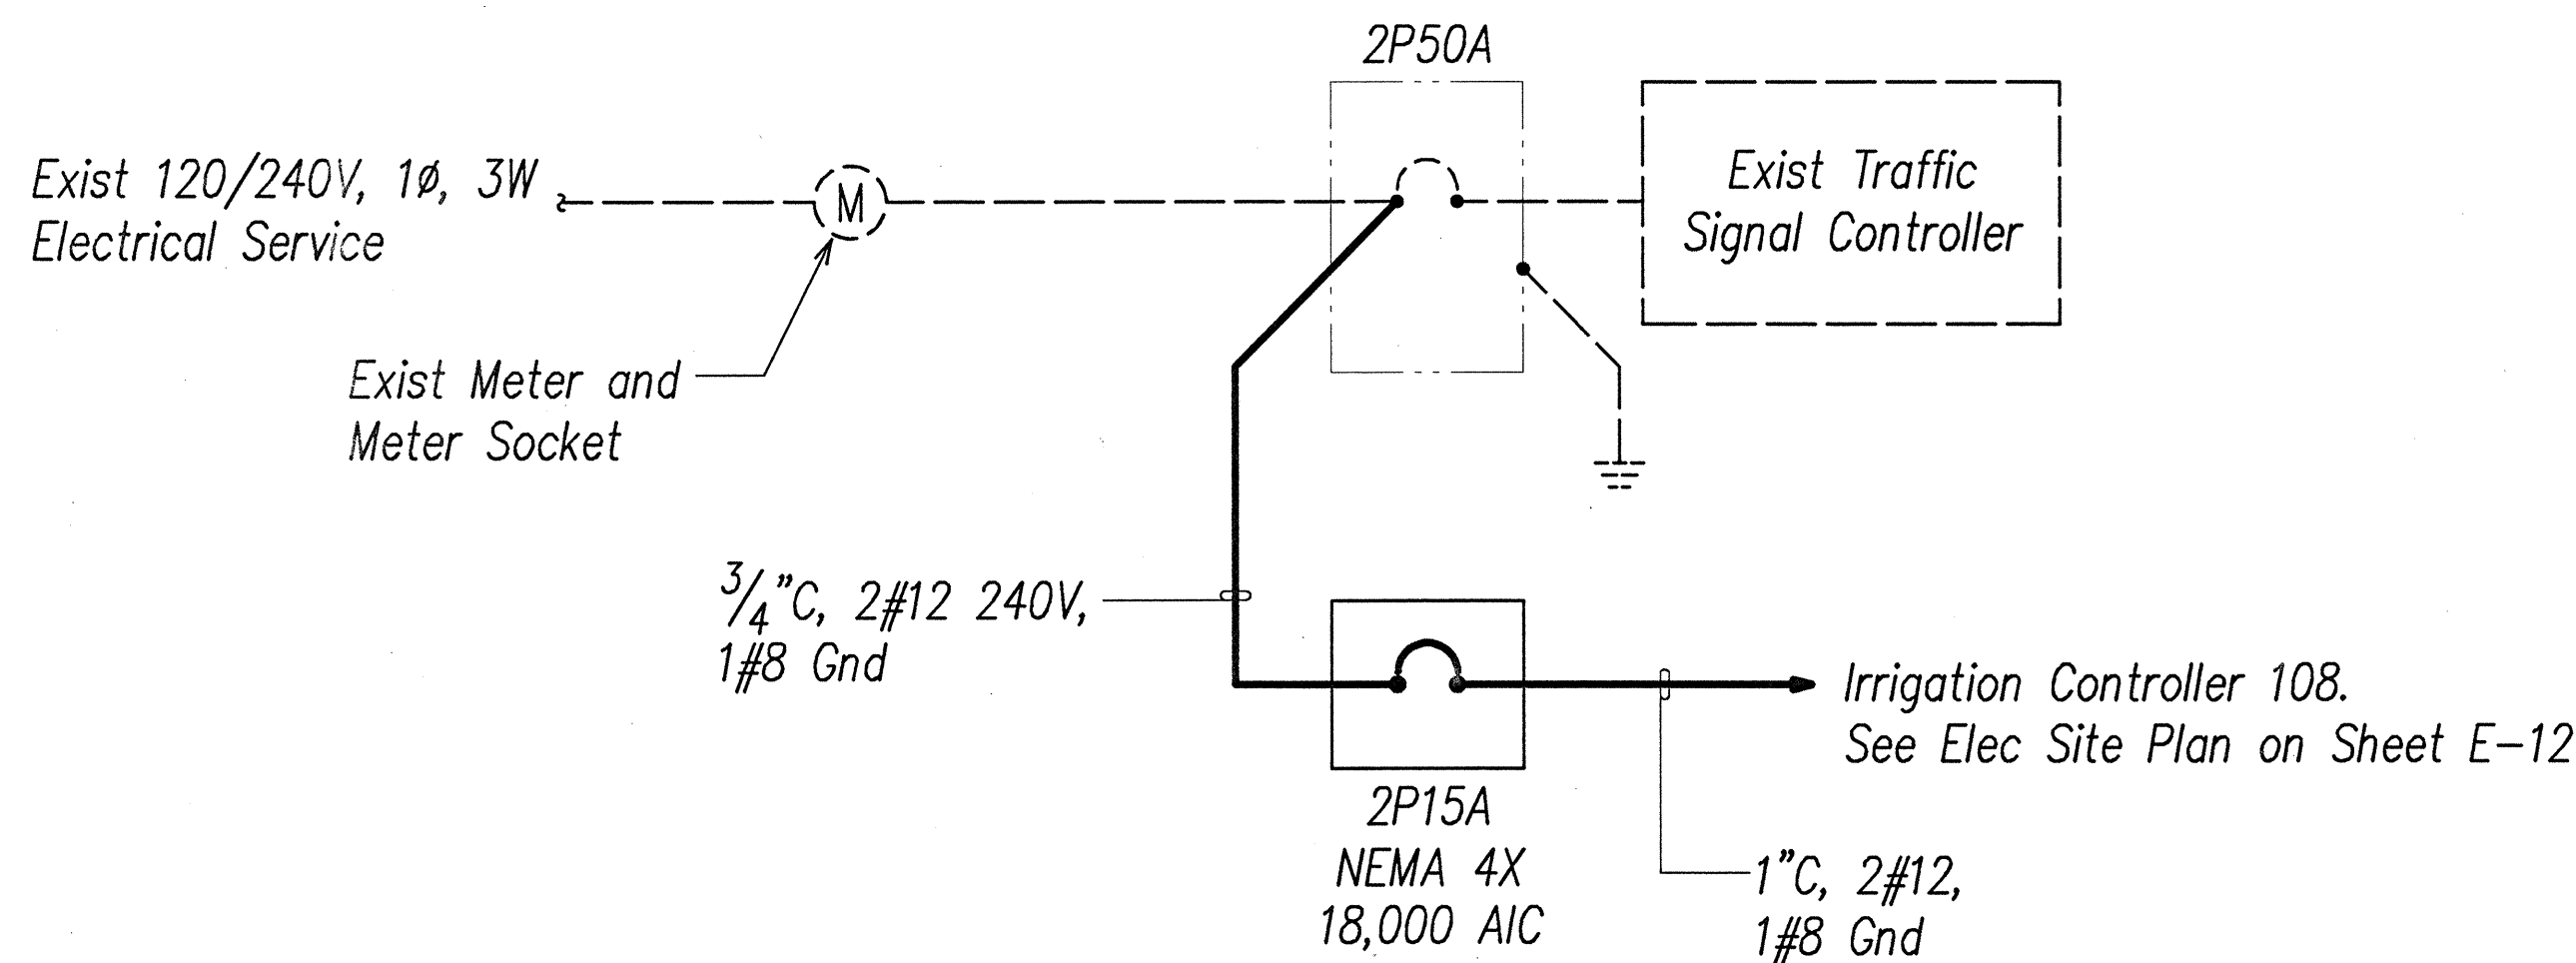

IRRIGATION CONTROLLER SERVICE DIAGRAM

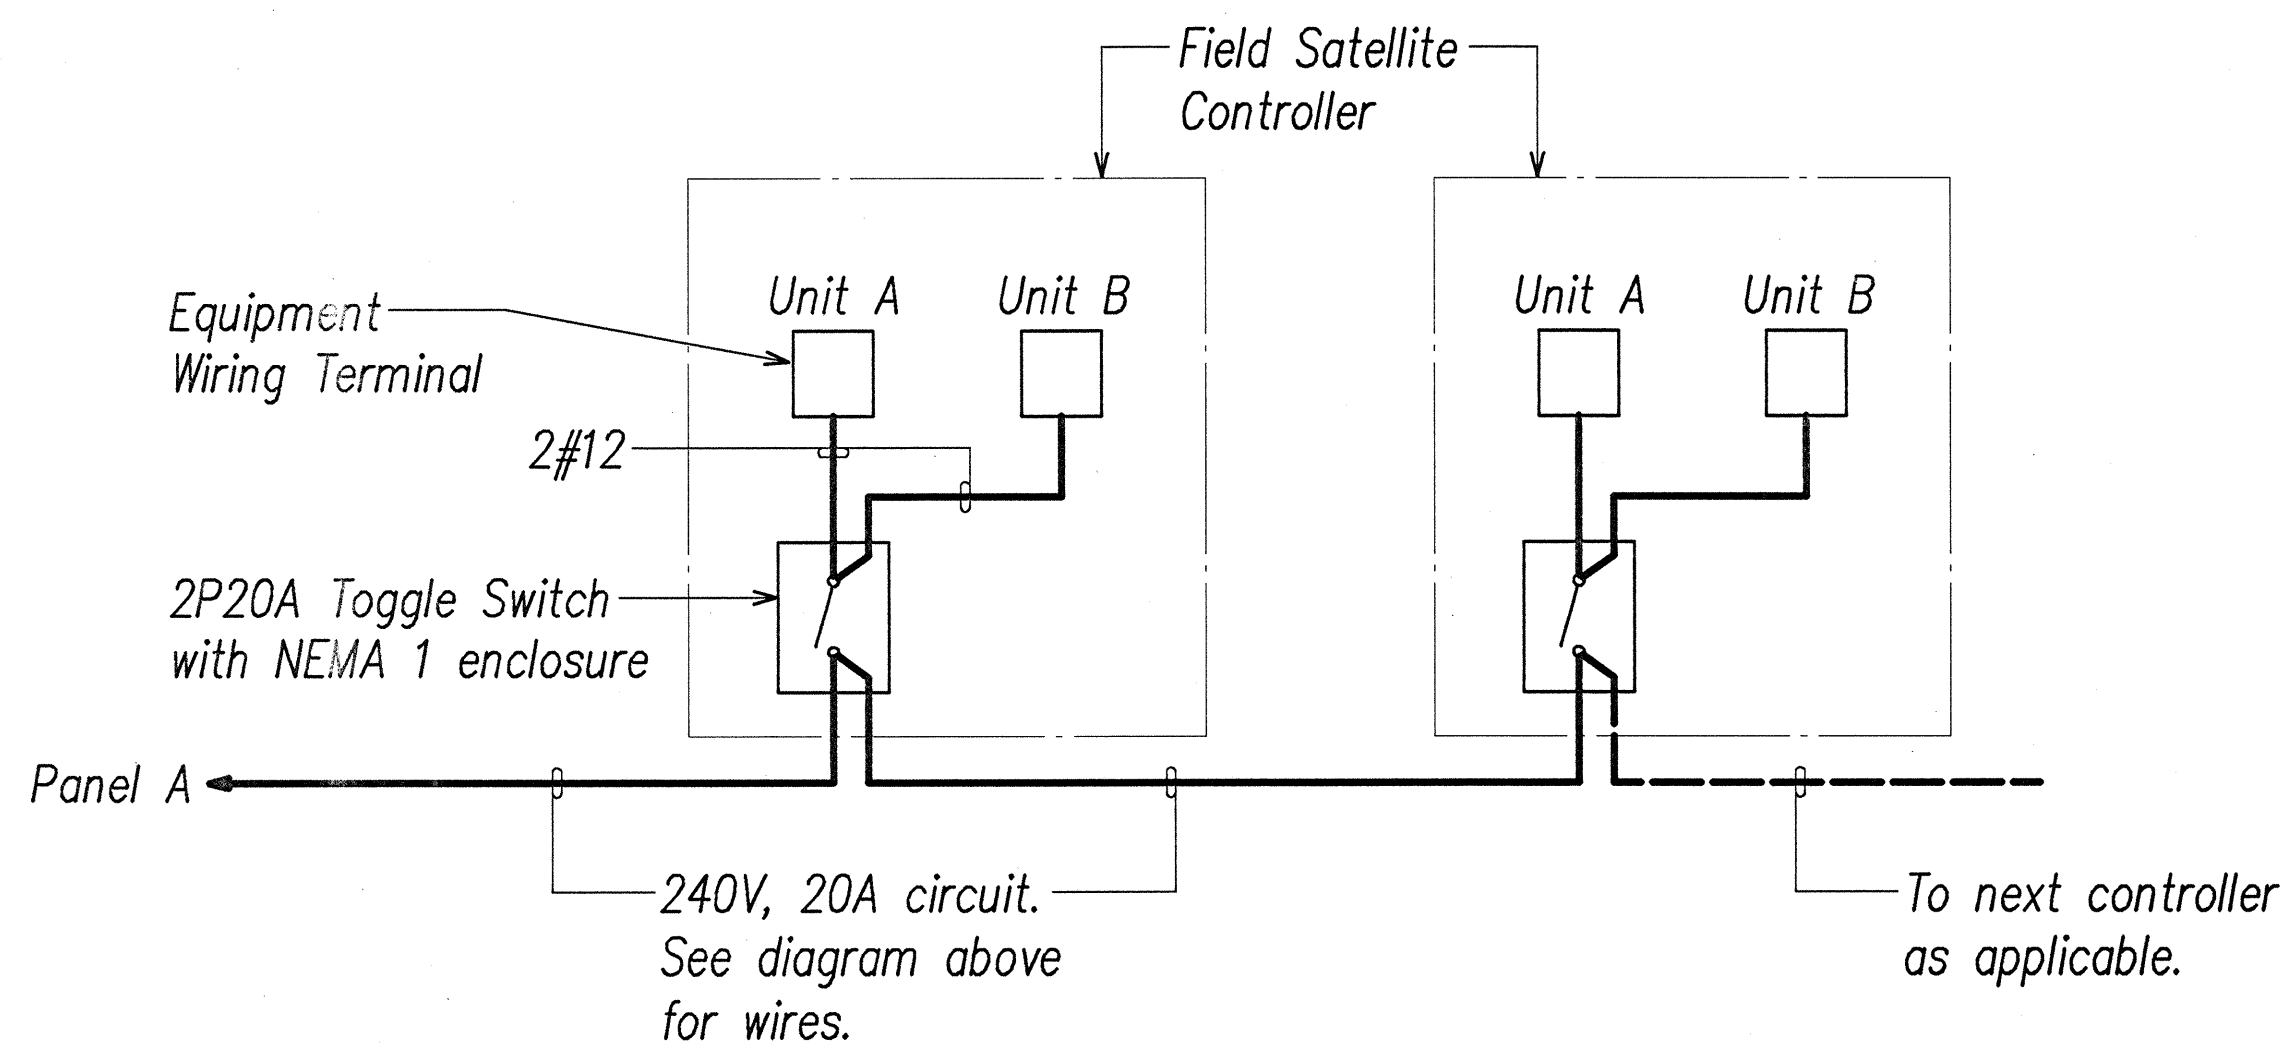


TYPICAL IRRIGATION CONTROLLER CIRCUIT DIAGRAM

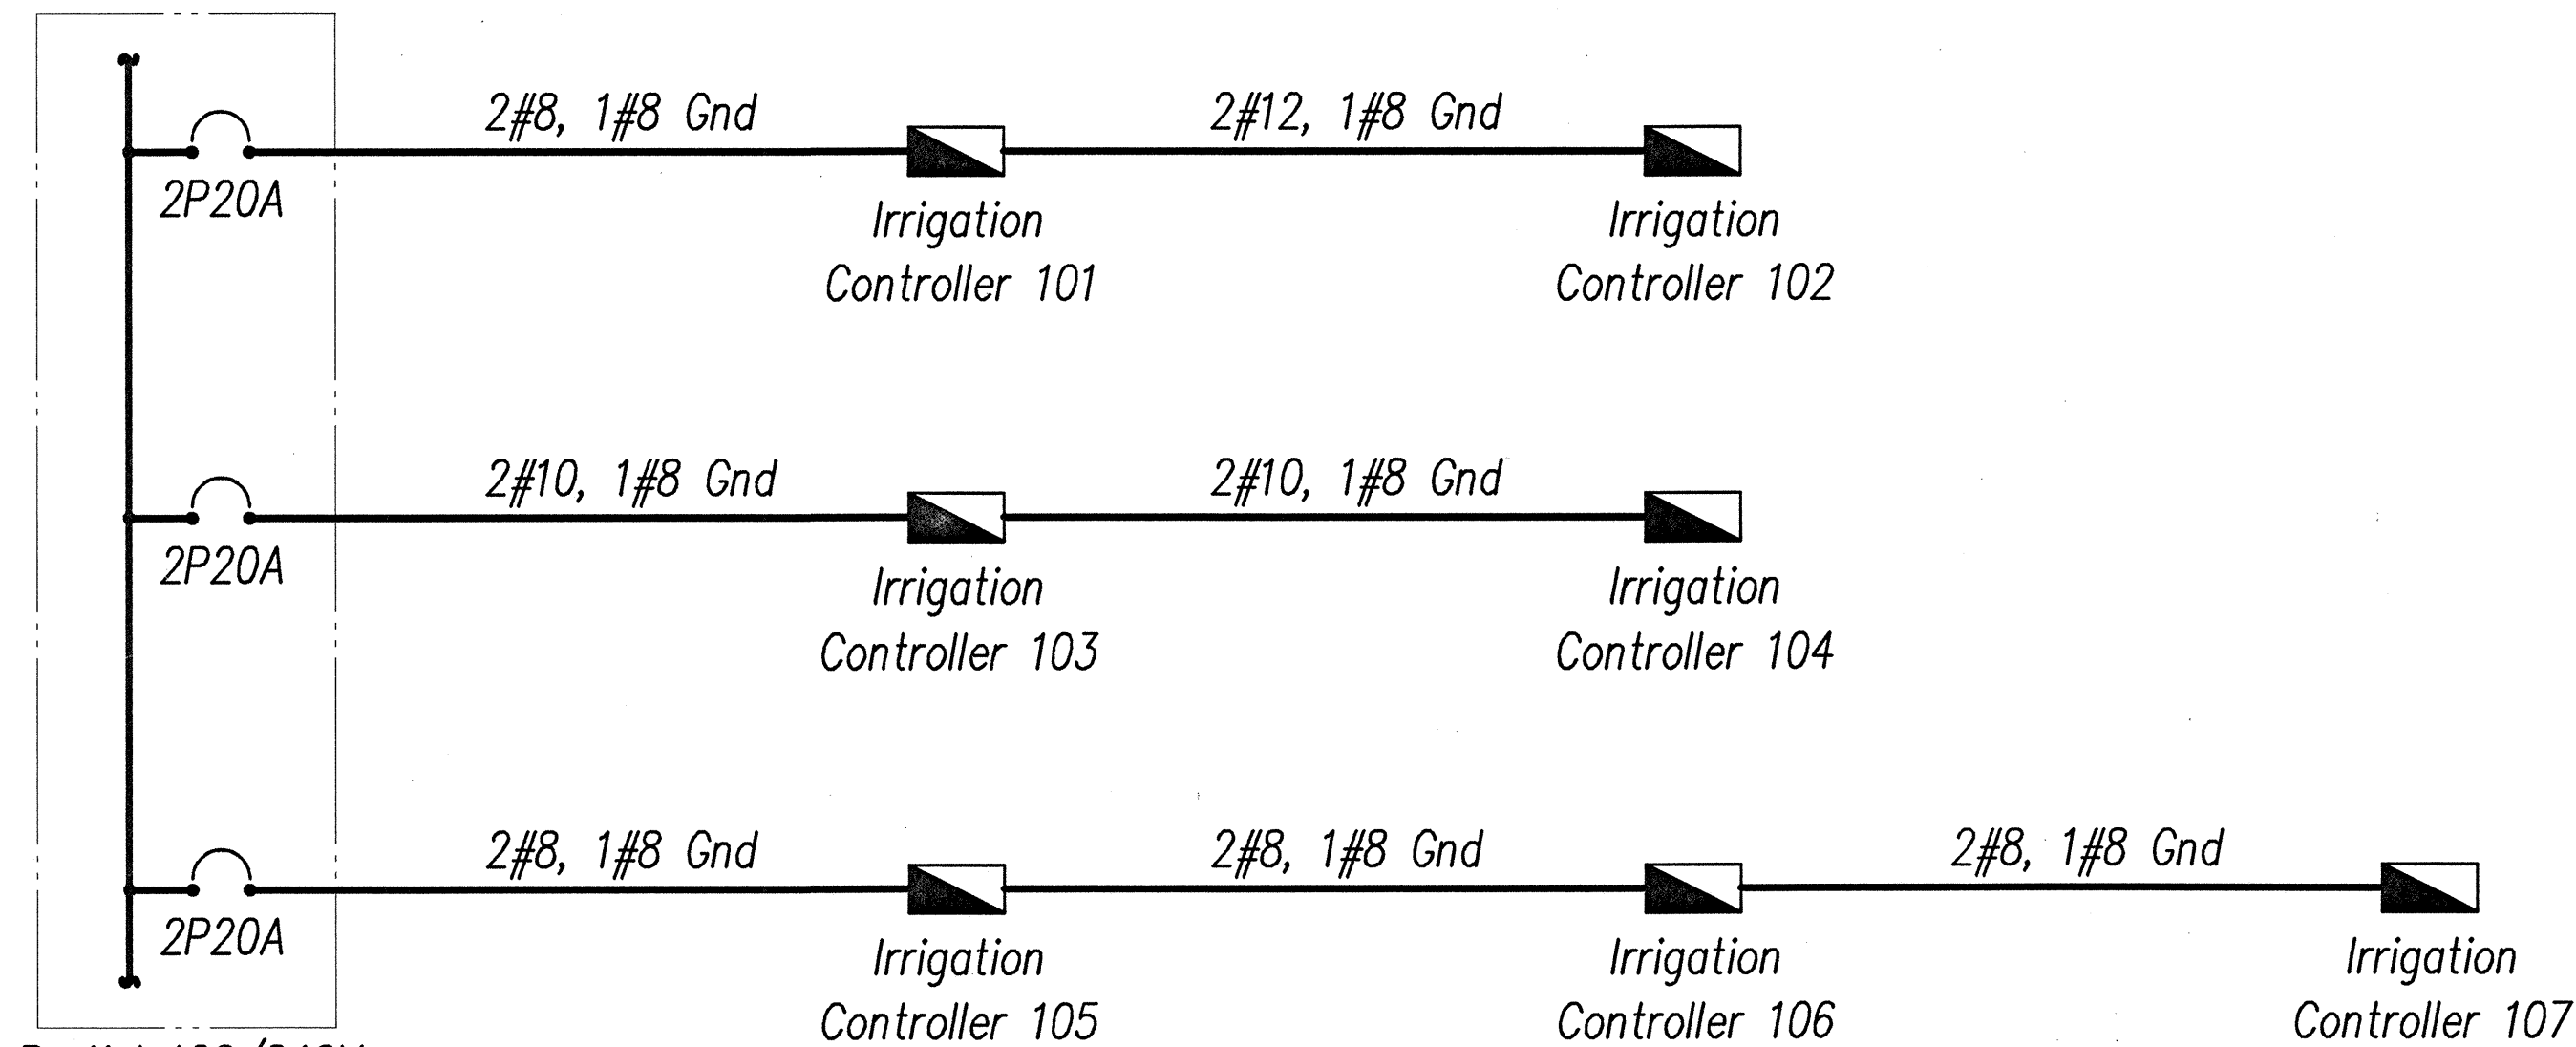

Conduit indicated on Electrical Site Plans, E-2 to E-15.

IRRIGATION CONTROLLER CIRCUITS DIAGRAM

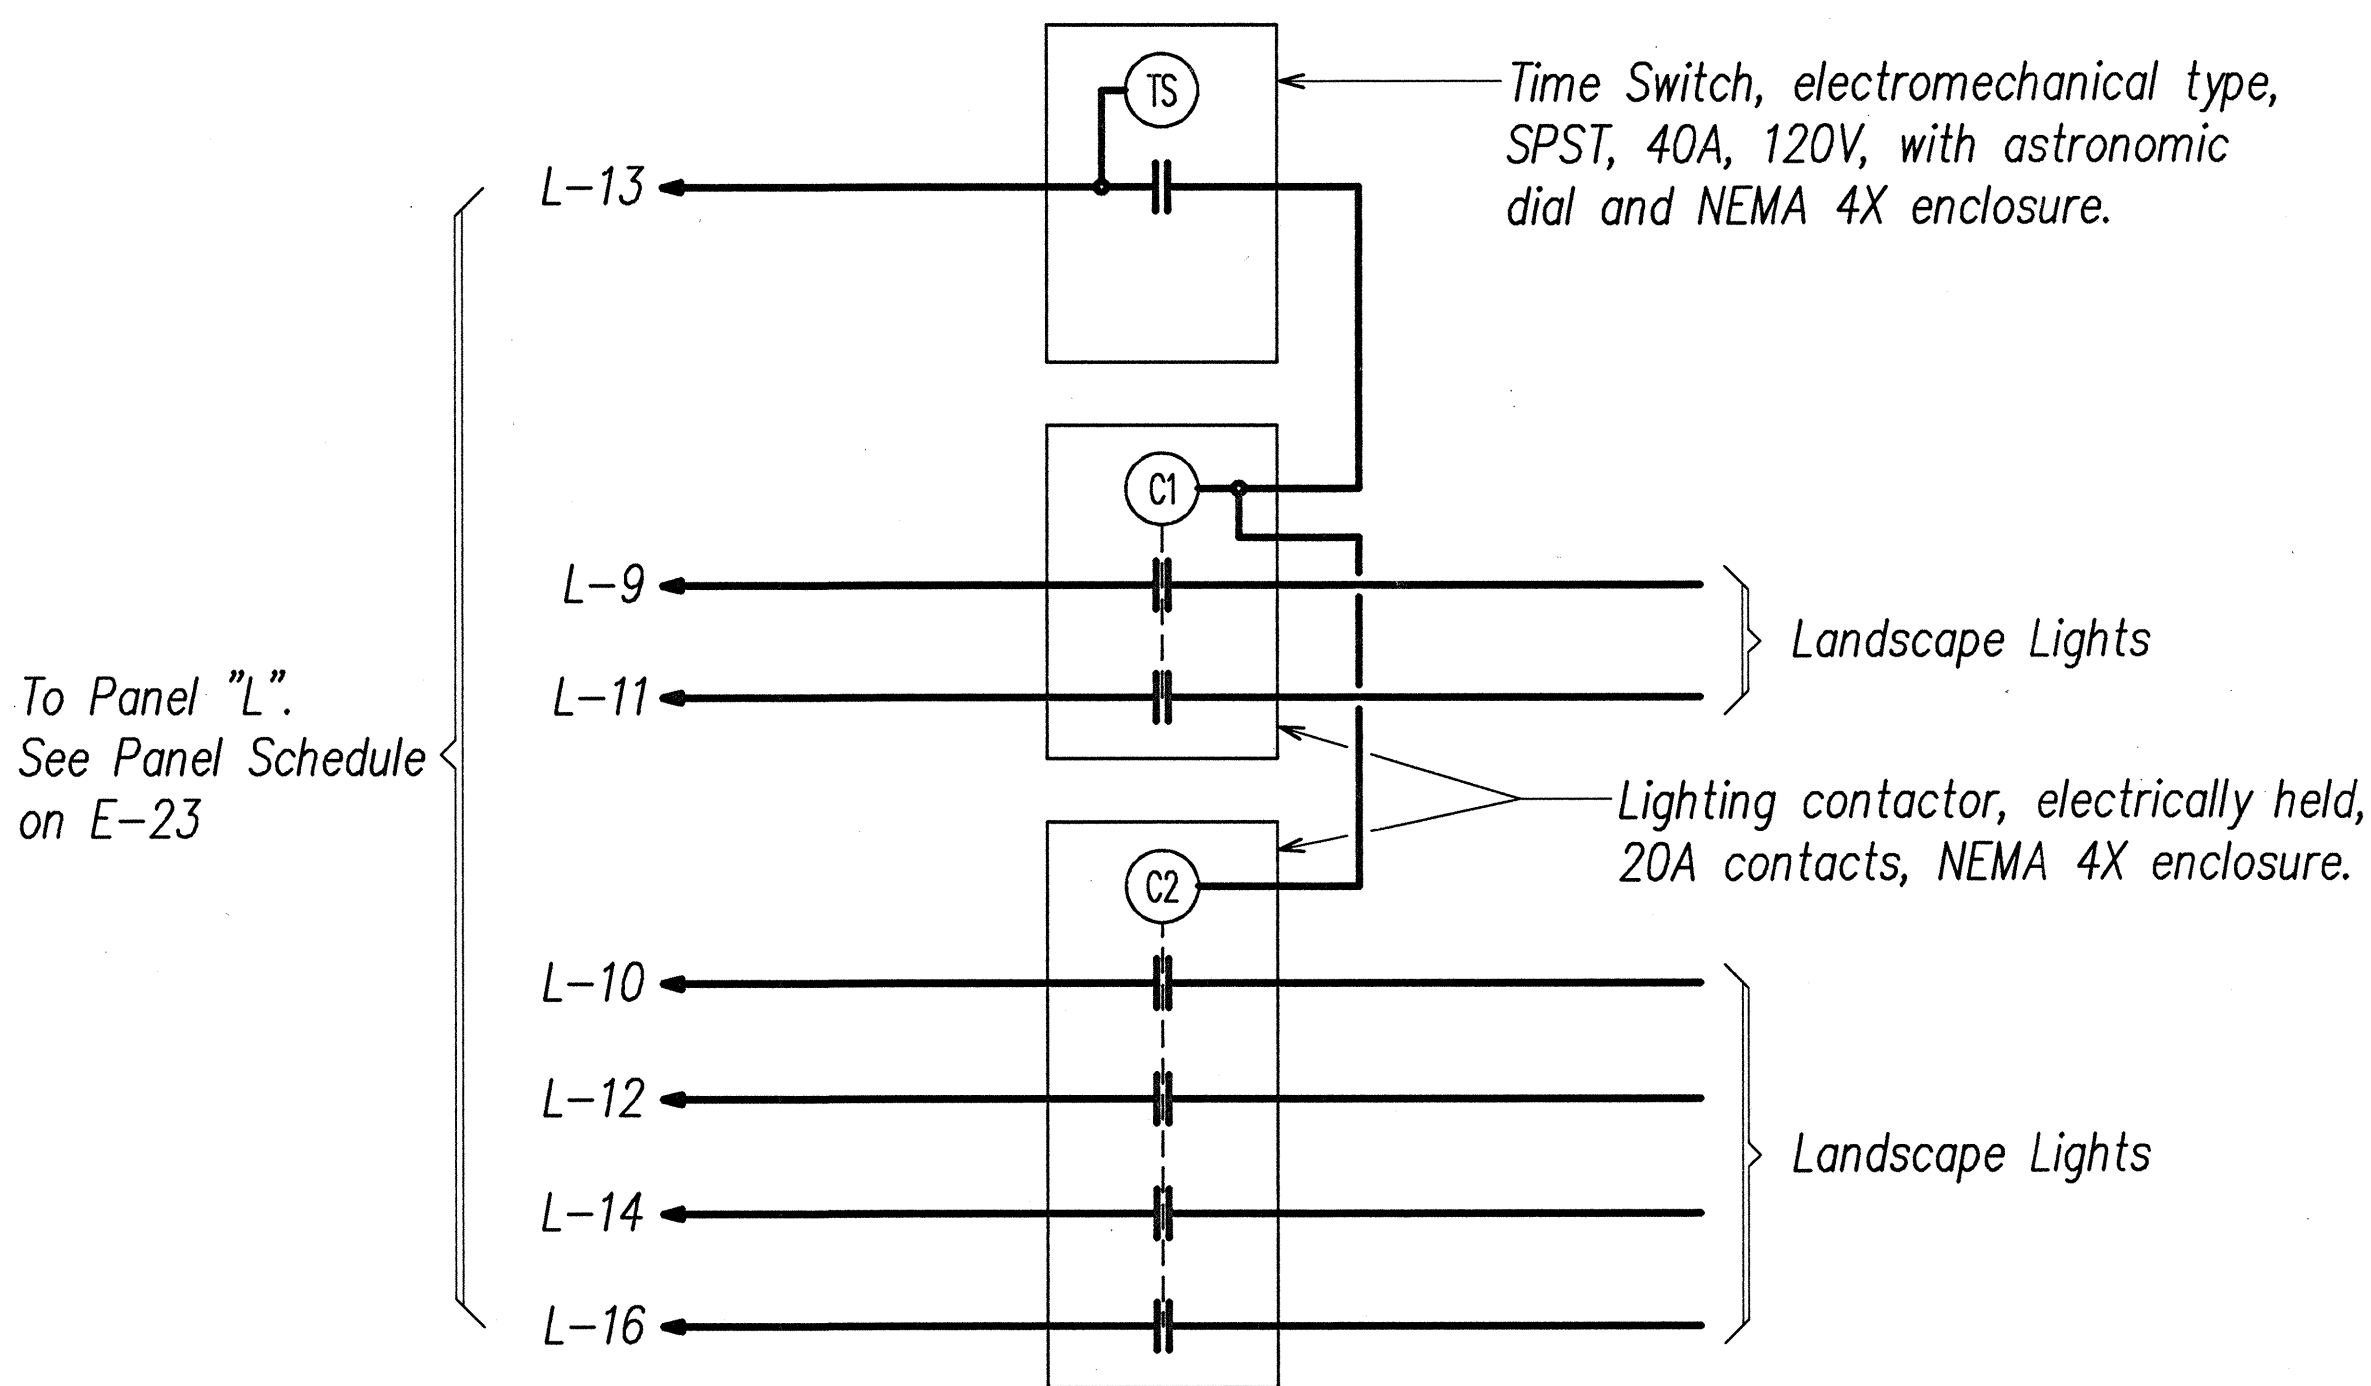

LIGHTS CONTROL DIAGRAM

APPROVED BY:

Debra A. Santiaño 2-18-99
KAUAI ELECTRIC DATE

STATE OF HAWAII

DEPARTMENT OF TRANSPORTATION

HIGHWAYS DIVISION

ELECTRICAL DIAGRAMS

LIHUE GATEWAY LANDSCAPE

BEAUTIFICATION PROJECT


Scale: AS NOTED

Date: OCTOBER 1998

SHEET No. E-22 OF 30 SHEETS

DATE	10/1/98
SURVEY PLOTTED BY	...
DRAWN BY	...
DESIGNED BY	...
QUANTITIES BY	...
CHECKED BY	...
ORIGINAL PLAN	...
NOTE BOOK	...

LAST DATE: 10/1/98
Z:\KAWAII\PROJECTS\LIHUE\220000\

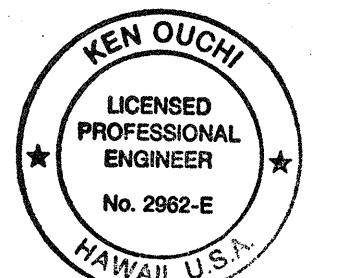

K. Ouchi
THIS WORK WAS PREPARED BY
ME OR UNDER MY SUPERVISION.