





FED. ROAD DIST. NO.	STATE	FED. AID PROJ. NO.	FISCAL YEAR	SHEET NO.	TOTAL SHEETS
HAWAII	HAW.	STP-0700 (43)	1998	132	141

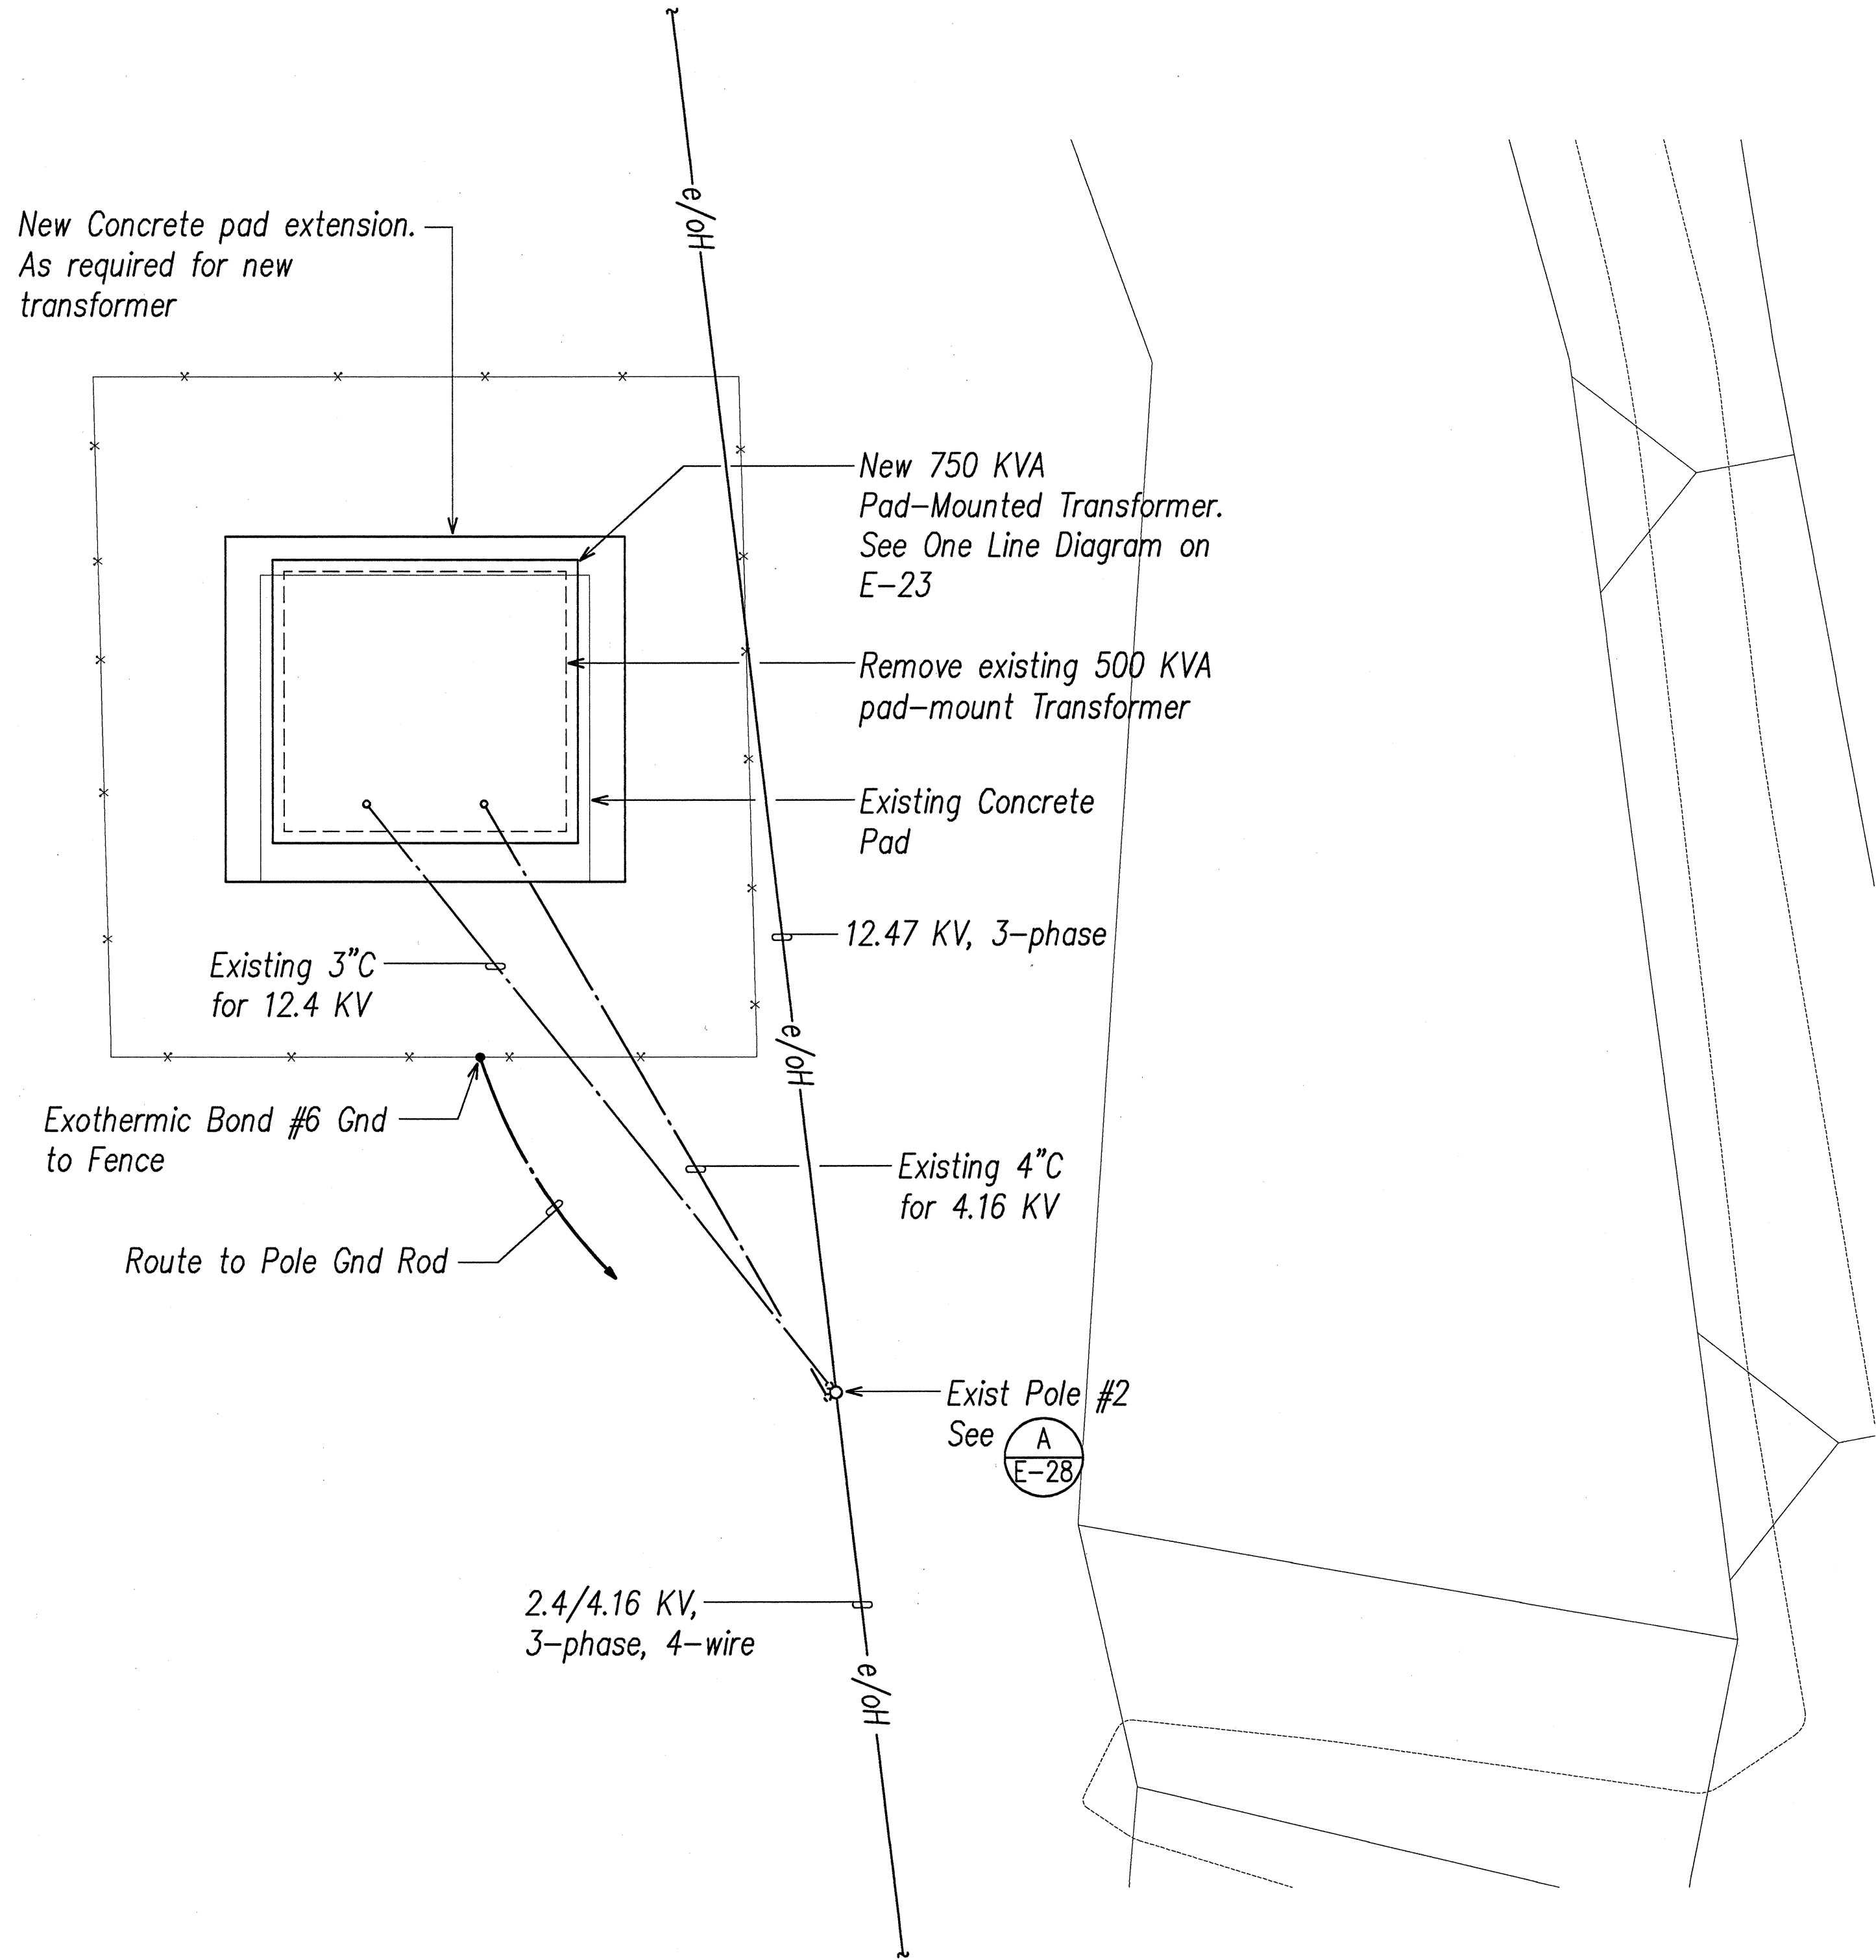

(A) TRANSFORMER FACILITY ELECTRICAL PLAN
 E-21 SCALE: 3/8"=1'-0"

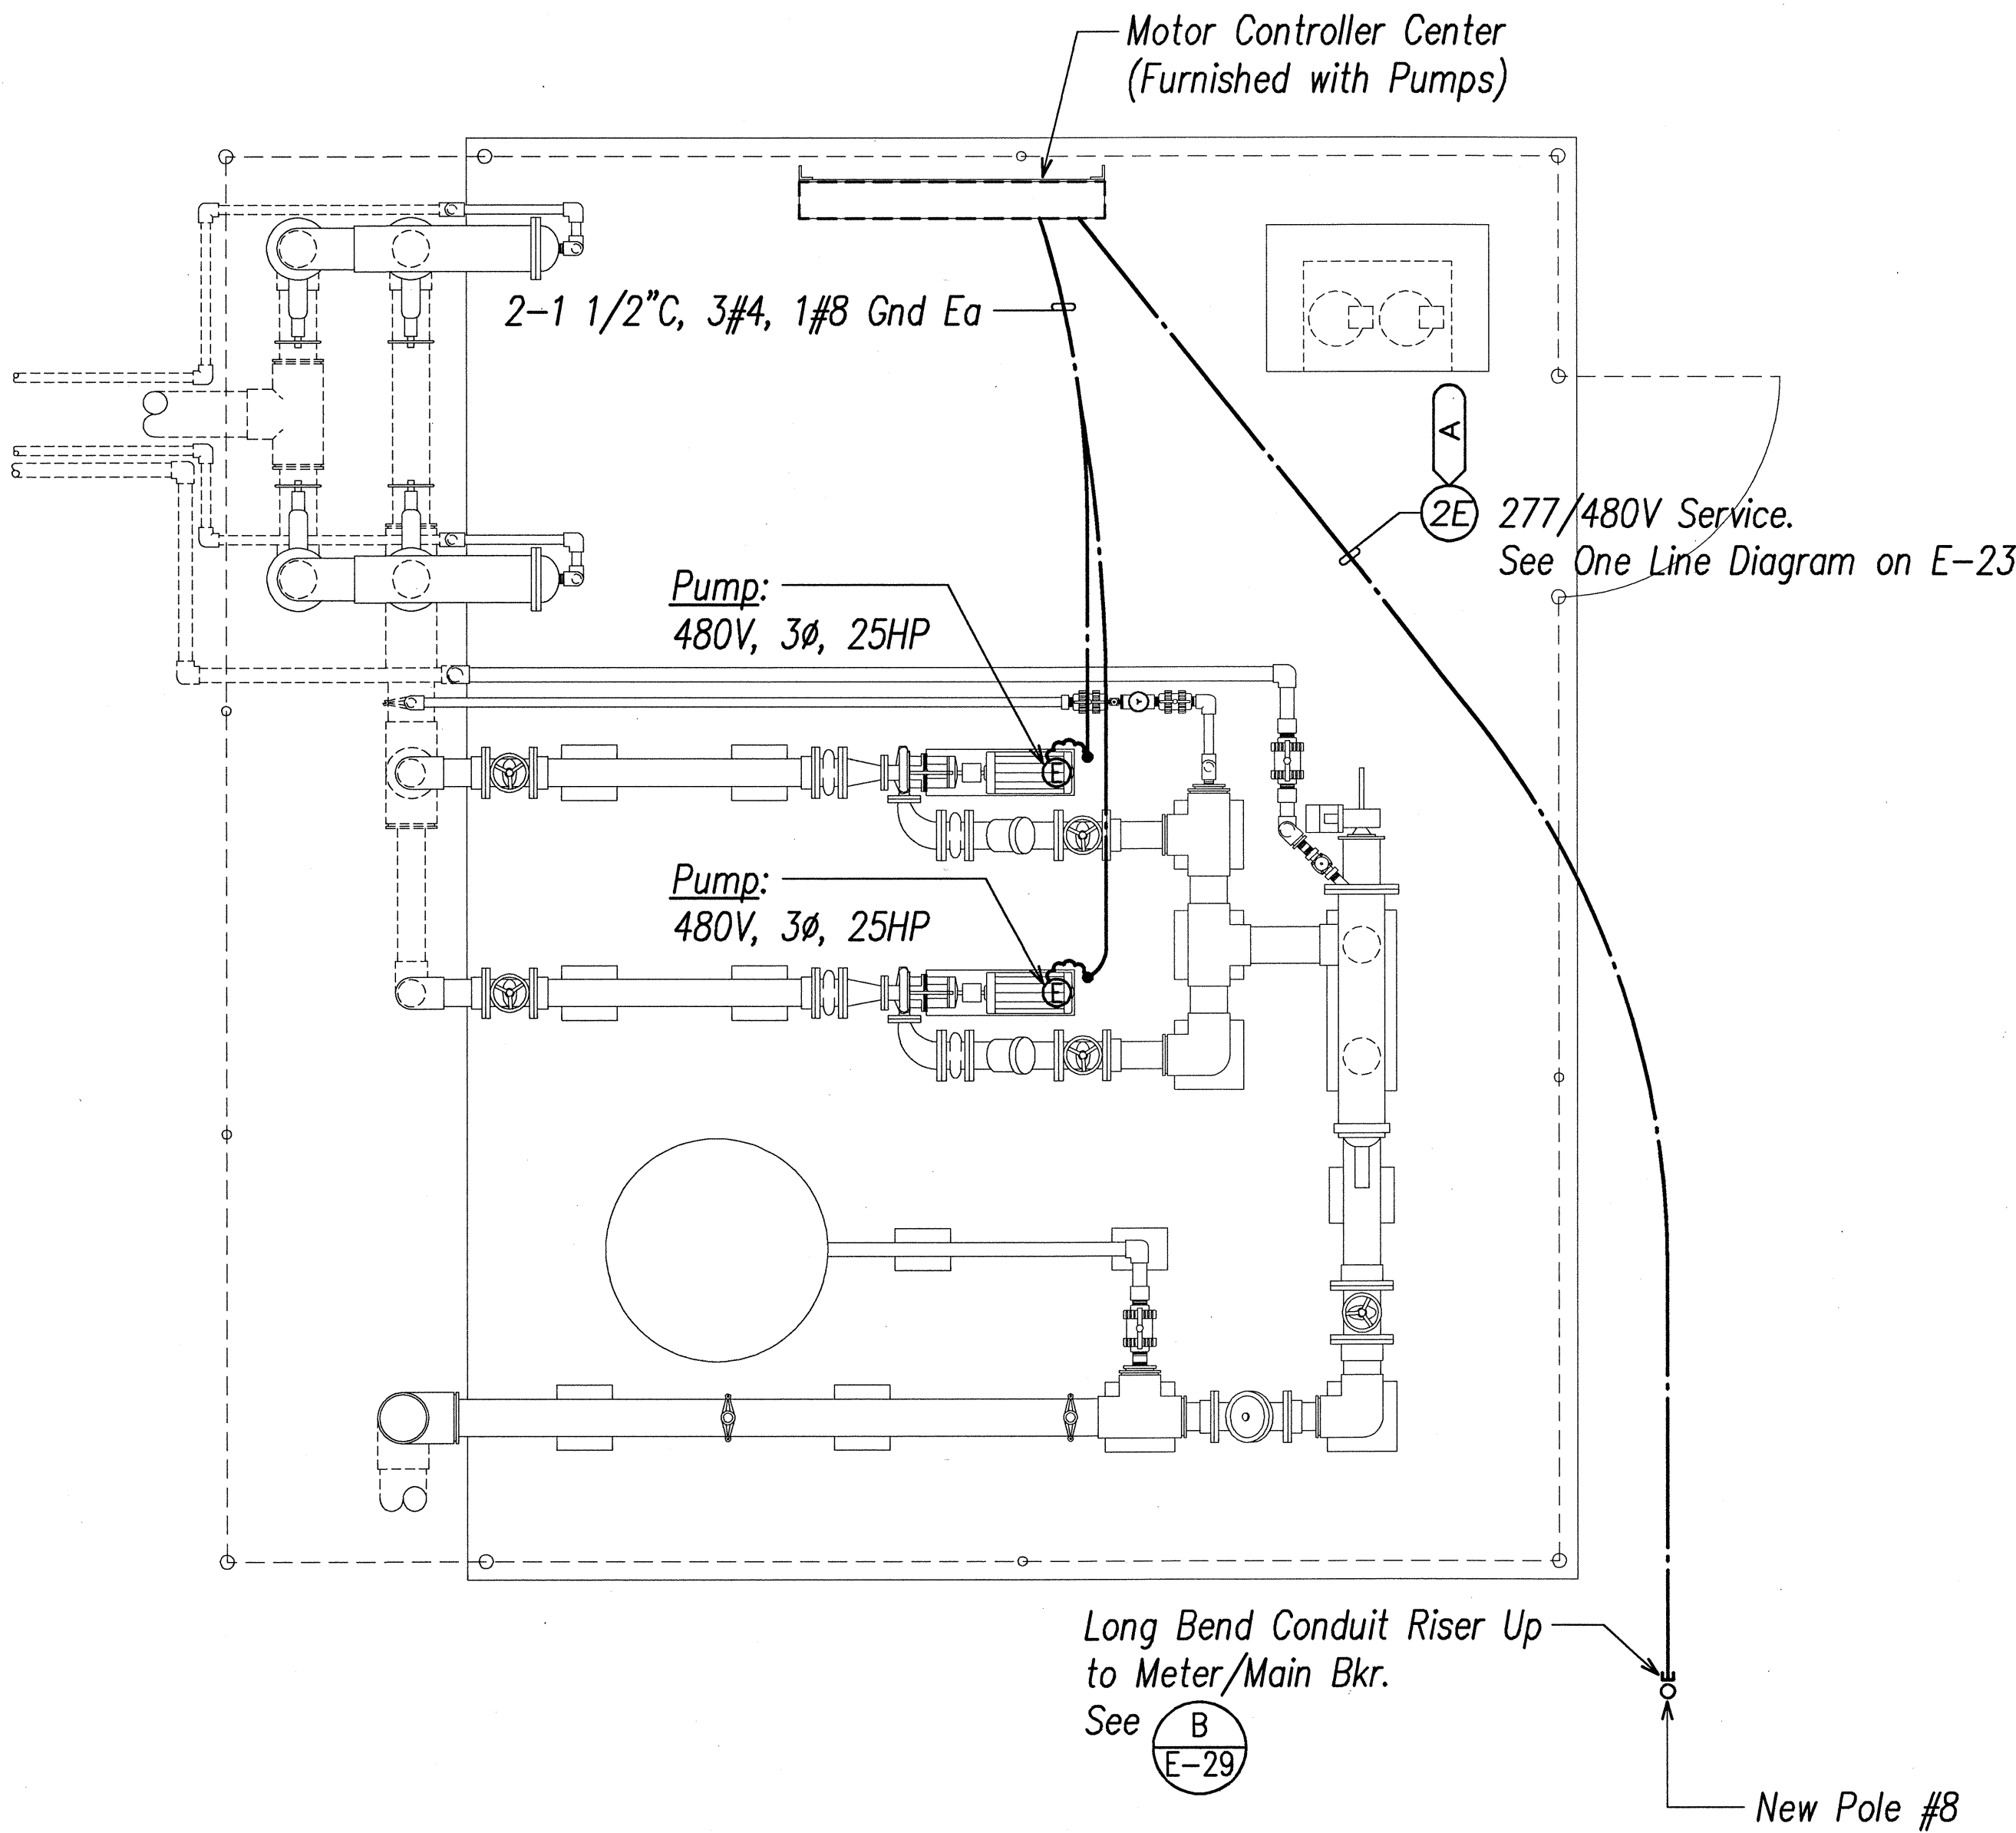

(B) PUMP FACILITY ELECTRICAL PLAN
 E-21 SCALE: 3/8"=1'-0"

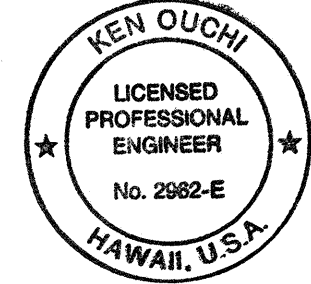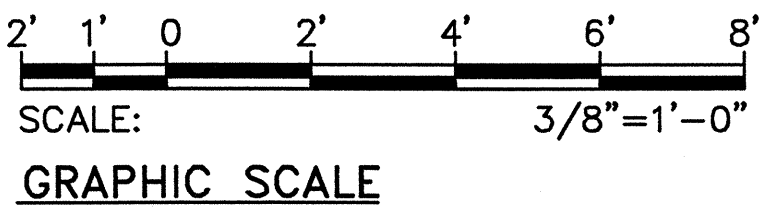

K. Ouchi
 THIS WORK WAS PREPARED BY
 ME OR UNDER MY SUPERVISION.

STATE OF HAWAII
DEPARTMENT OF TRANSPORTATION
HIGHWAYS DIVISION

ELECTRICAL PLANS
IRRIGATION PUMP FACILITY

LIHUE GATEWAY LANDSCAPE
BEAUTIFICATION PROJECT

Scale: AS NOTED
Date: OCTOBER 1998
SHEET No. E-21 OF 30 SHEETS

132