



FED. ROAD DIST. NO.	STATE	FED. AID PROJ. NO.	FISCAL YEAR	SHEET NO.	TOTAL SHEETS
HAWAII	HAW.	STP-0700 (43)	1998	113	141

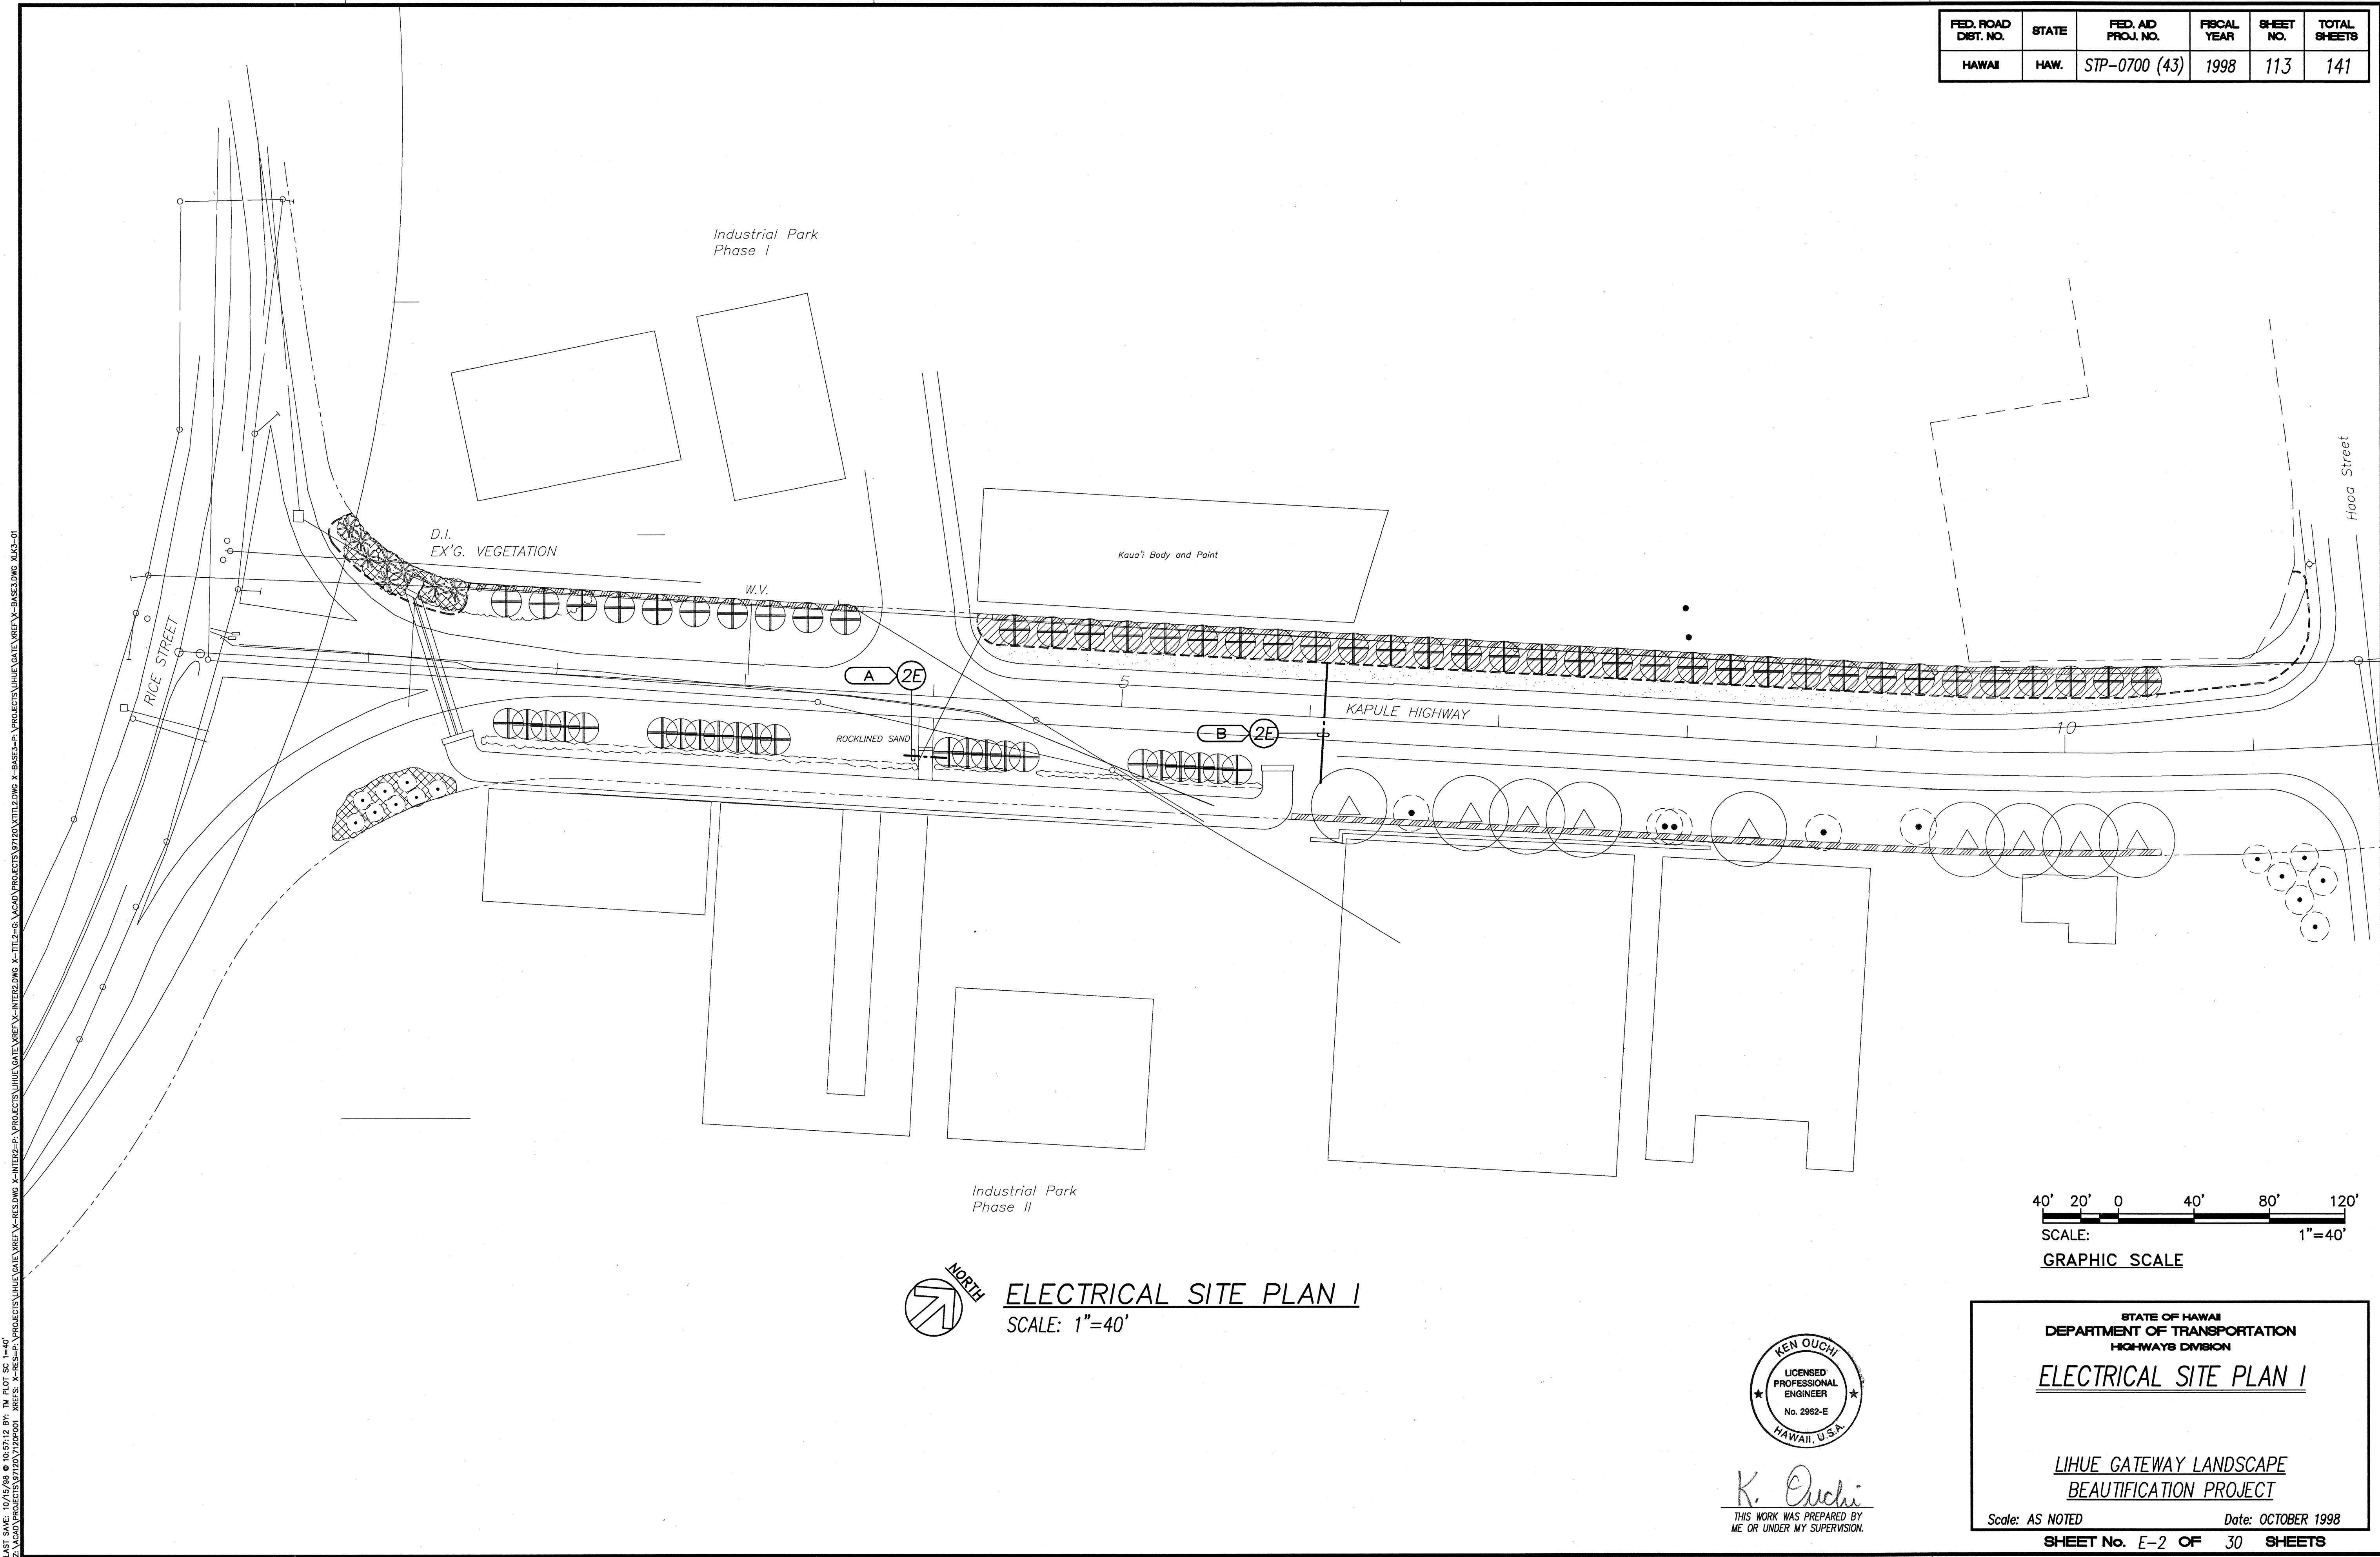

ORIGINAL PLAN	SURVEY PLOTTED BY	DATE
NOTE BOOK	DRAWN BY	
	DESIGNED BY	
	CHECKED BY	

LAST SAVE: 10/14/98 @ 10:57:18 BY: TM 3/07 SS 1/4/07
 Z:\ACAD\PROJECTS\97\20\7120\001 - REFS: X-RES-P\PROJECTS\LIHUE GATEWAY\REF X-INTER2.DWG X-RES-P\PROJECTS\LIHUE GATEWAY\REF X-BASE3.DWG X-K3-01

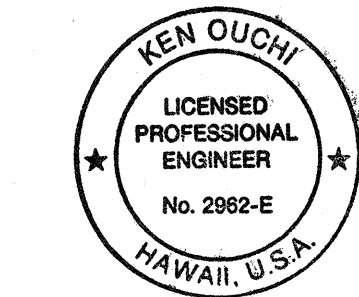

K. Ouchi
 THIS WORK WAS PREPARED BY
 ME OR UNDER MY SUPERVISION.

STATE OF HAWAII
DEPARTMENT OF TRANSPORTATION
HIGHWAYS DIVISION


ELECTRICAL SITE PLAN I

LIHUE GATEWAY LANDSCAPE
BEAUTIFICATION PROJECT

Scale: AS NOTED
Date: OCTOBER 1998
SHEET No. E-2 OF 30 SHEETS


113

FED. ROAD DIST. NO.	STATE	FED. AID PROJ. NO.	FISCAL YEAR	SHEET NO.	TOTAL SHEETS
HAWAII	HAW.	STP-0700 (43)	1998	114	141


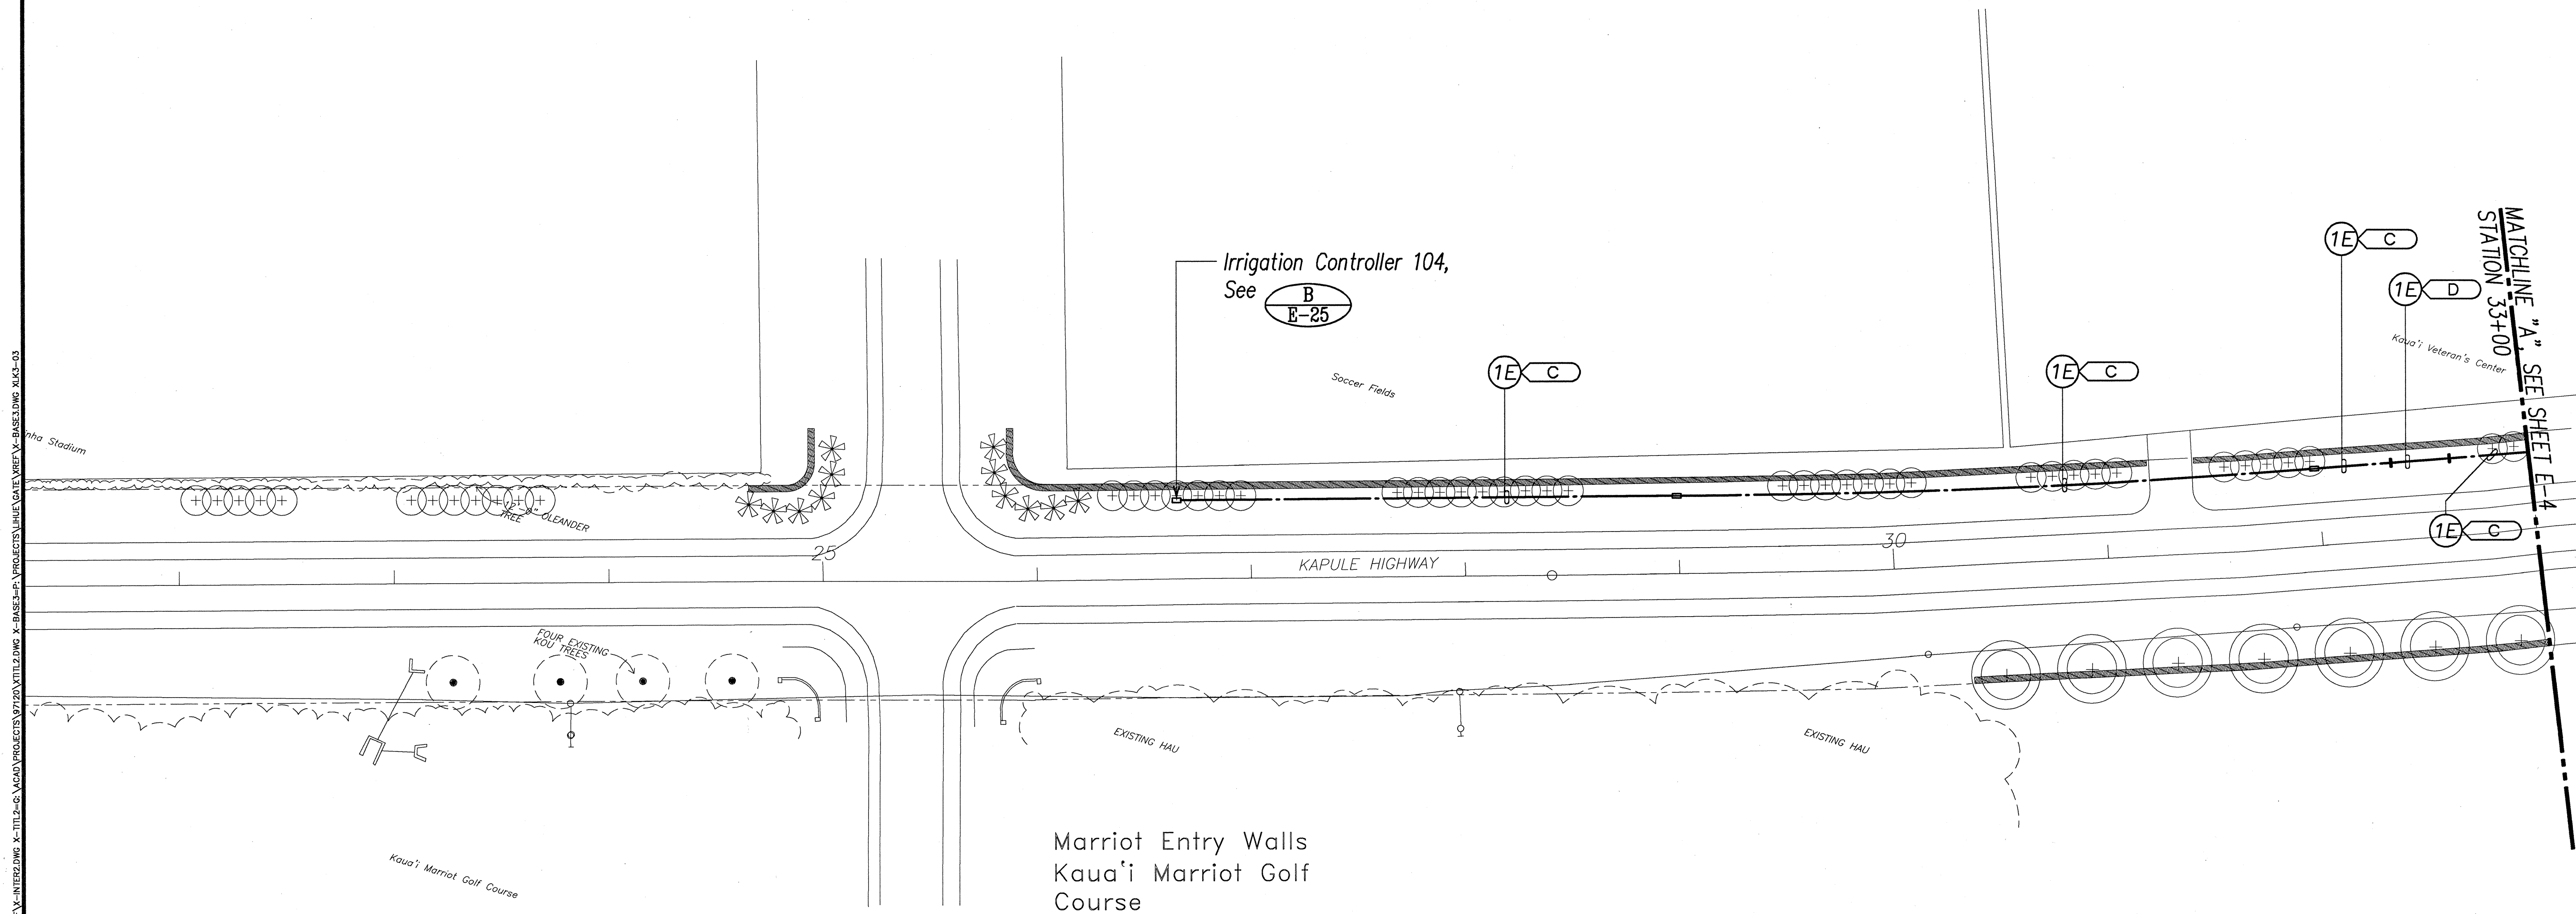


ORIGINAL PLAN	SURVEY PLOTTED BY	DATE
NOTE BOOK	DRAWN BY	
	DESIGNED BY	
	QUANTITIES BY	
	CHECKED BY	

LAST SAVE: 10/15/98 @ 10:59:34 BY: ME PLOT: SC: 1/4"=40' X 1/4"=40' PROJECTS\LIHUE GATEWAY\INTERZONES\X-TITLE-05.MXD PROJECTS\LIHUE GATEWAY\BASE\X-BASE.DWG X-43-03

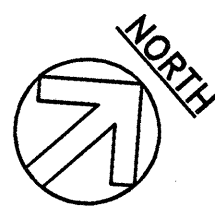

ELECTRICAL SITE PLAN II
SCALE: 1"=40'

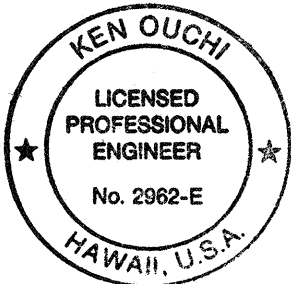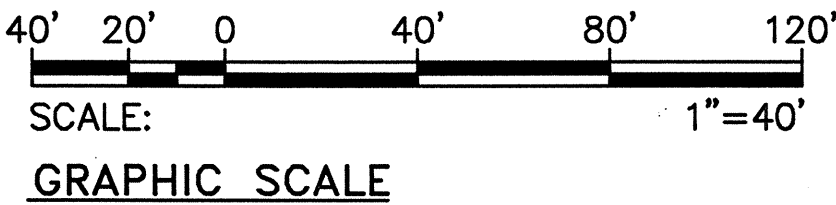



K. Ouchi
THIS WORK WAS PREPARED BY
ME OR UNDER MY SUPERVISION.

STATE OF HAWAII
DEPARTMENT OF TRANSPORTATION
HIGHWAYS DIVISION
ELECTRICAL SITE PLAN II

LIHUE GATEWAY LANDSCAPE
BEAUTIFICATION PROJECT
Scale: AS NOTED Date: OCTOBER 1998
SHEET No. E-3 OF 30 SHEETS


FED. ROAD DIST. NO.	STATE	FED. AID PROJ. NO.	FISCAL YEAR	SHEET NO.	TOTAL SHEETS
HAWAII	HAW.	STP-0700 (43)	1998	116	141

DATE: 10/15/98 BY: K. OUCHI
 PROJECT: LIHUE GATEWAY LANDSCAPE BEAUTIFICATION PROJECT
 SHEET: E-5 OF 30 SHEETS
 DRAWN BY: K. OUCHI
 DESIGNED BY: K. OUCHI
 CHECKED BY: K. OUCHI
 SURVEY PLOTTED BY: K. OUCHI

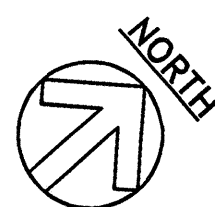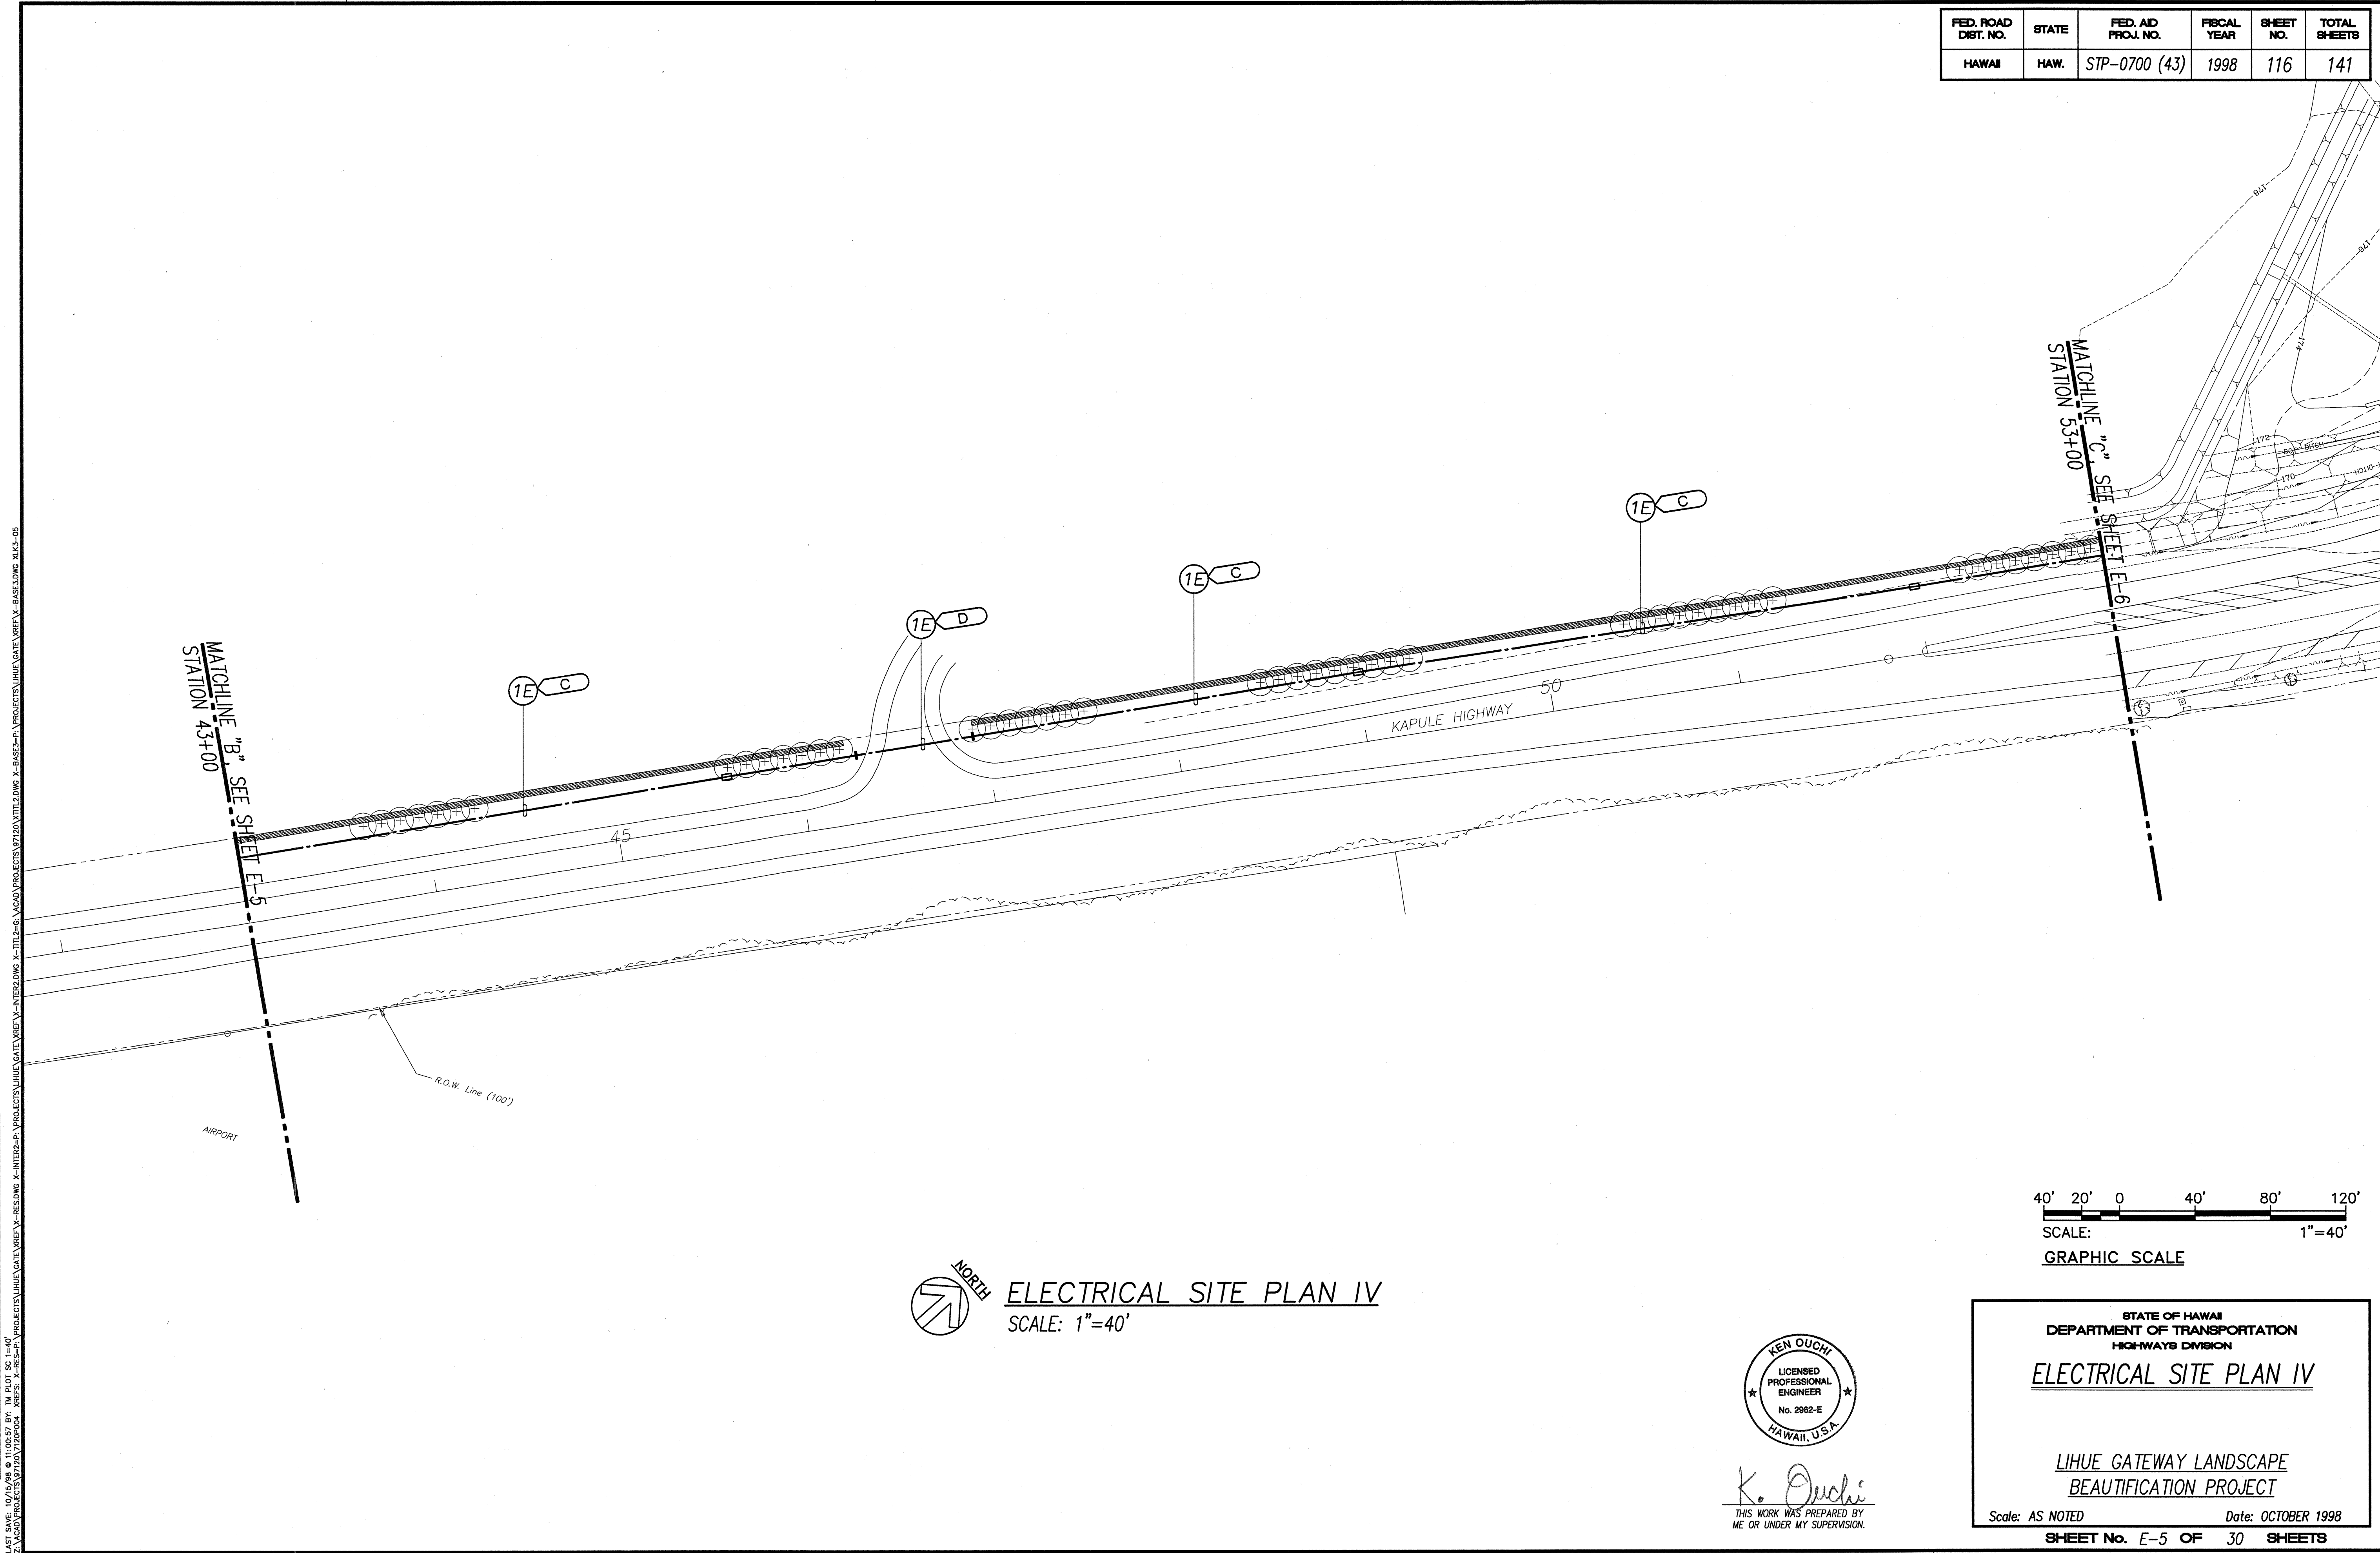

ELECTRICAL SITE PLAN IV
 SCALE: 1"=40'

40' 20' 0 40' 80' 120'
 SCALE: 1"=40'
 GRAPHIC SCALE

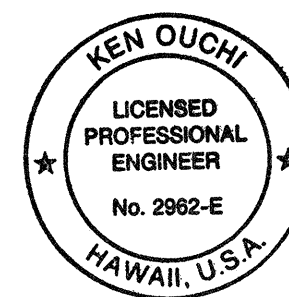

K. Ouchi
 THIS WORK WAS PREPARED BY
 ME OR UNDER MY SUPERVISION.

STATE OF HAWAII
 DEPARTMENT OF TRANSPORTATION
 HIGHWAYS DIVISION

ELECTRICAL SITE PLAN IV

LIHUE GATEWAY LANDSCAPE
 BEAUTIFICATION PROJECT

Scale: AS NOTED Date: OCTOBER 1998
 SHEET No. E-5 OF 30 SHEETS



FED. ROAD DIST. NO.	STATE	FED. AID PROJ. NO.	FISCAL YEAR	SHEET NO.	TOTAL SHEETS
HAWAII	HAW.	STP-0700 (43)	1998	117	141

Electrical Utility Line Notes

- 1 Primary and Secondary Lines to be Removed by Kauai Elec. (KE)
- 2 Pole and Guying to be Removed by KE.
- 3 Overhead Guy to be Removed by KE.
- 4 Pole to be Modified by KE for Deadending of Existing Lines.
- 5 Secondary Line for Streetlightings to be Removed by KE.
- 6 Pole, Transformer and Secondary Riser to be Removed by KE.
- 7 Secondary Line for Streetlights to be removed by KE.

LAST SAVE: 12/27/98 @ 09:35:03 BY: C:\PILOT\50-144\01\ACAD\PROJECTS\97120\1720205.XREFS: X-RESAP:PROJECTS\LINE\GATEWAY\X-RESLWDG.X1X3-068 X-INTERSECT:PROJECTS\LINE\GATEWAY\X-INTERSECT.DWG X-TITLE:ACAD\PROJECTS\97120\1720205.X1X3-068 X-PROJECT:LINE\GATEWAY\X-BASE-P:PROJECTS\LINE\GATEWAY\X-BASE.DWG X1X3-068

ORIGINAL PLAN	SURVEY PLOTTED BY	DATE
NOTE BOOK	DRAWN BY	
	TRACED BY	
	CHECKED BY	
	QUANTITIES BY	
	CHECKED BY	

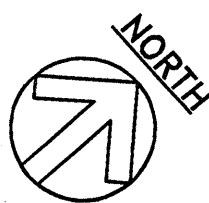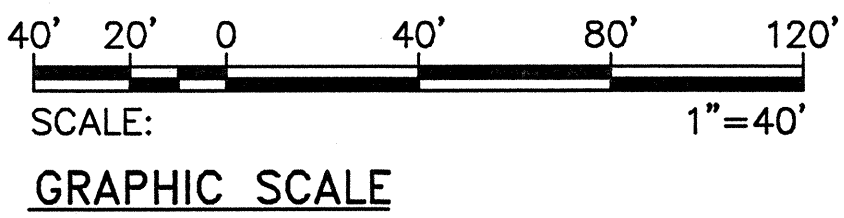

ELECTRICAL SITE PLAN V

SCALE: 1"=40'

APPROVED BY:

Debra A. Aantaa 2-18-99
KAUAI ELECTRIC DATE


STATE OF HAWAII
DEPARTMENT OF TRANSPORTATION
HIGHWAYS DIVISION

ELECTRICAL SITE PLAN V

LIHUE GATEWAY LANDSCAPE
BEAUTIFICATION PROJECT


Scale: AS NOTED Date: OCTOBER 1998

SHEET No. E-6 OF 30 SHEETS

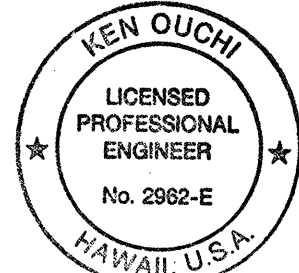


K. Ouchi
THIS WORK WAS PREPARED BY
ME OR UNDER MY SUPERVISION.

FED. ROAD DIST. NO.	STATE	FED. AID PROJ. NO.	FISCAL YEAR	SHEET NO.	TOTAL SHEETS
HAWAII	HAW.	STP-0700 (43)	1998	120	141

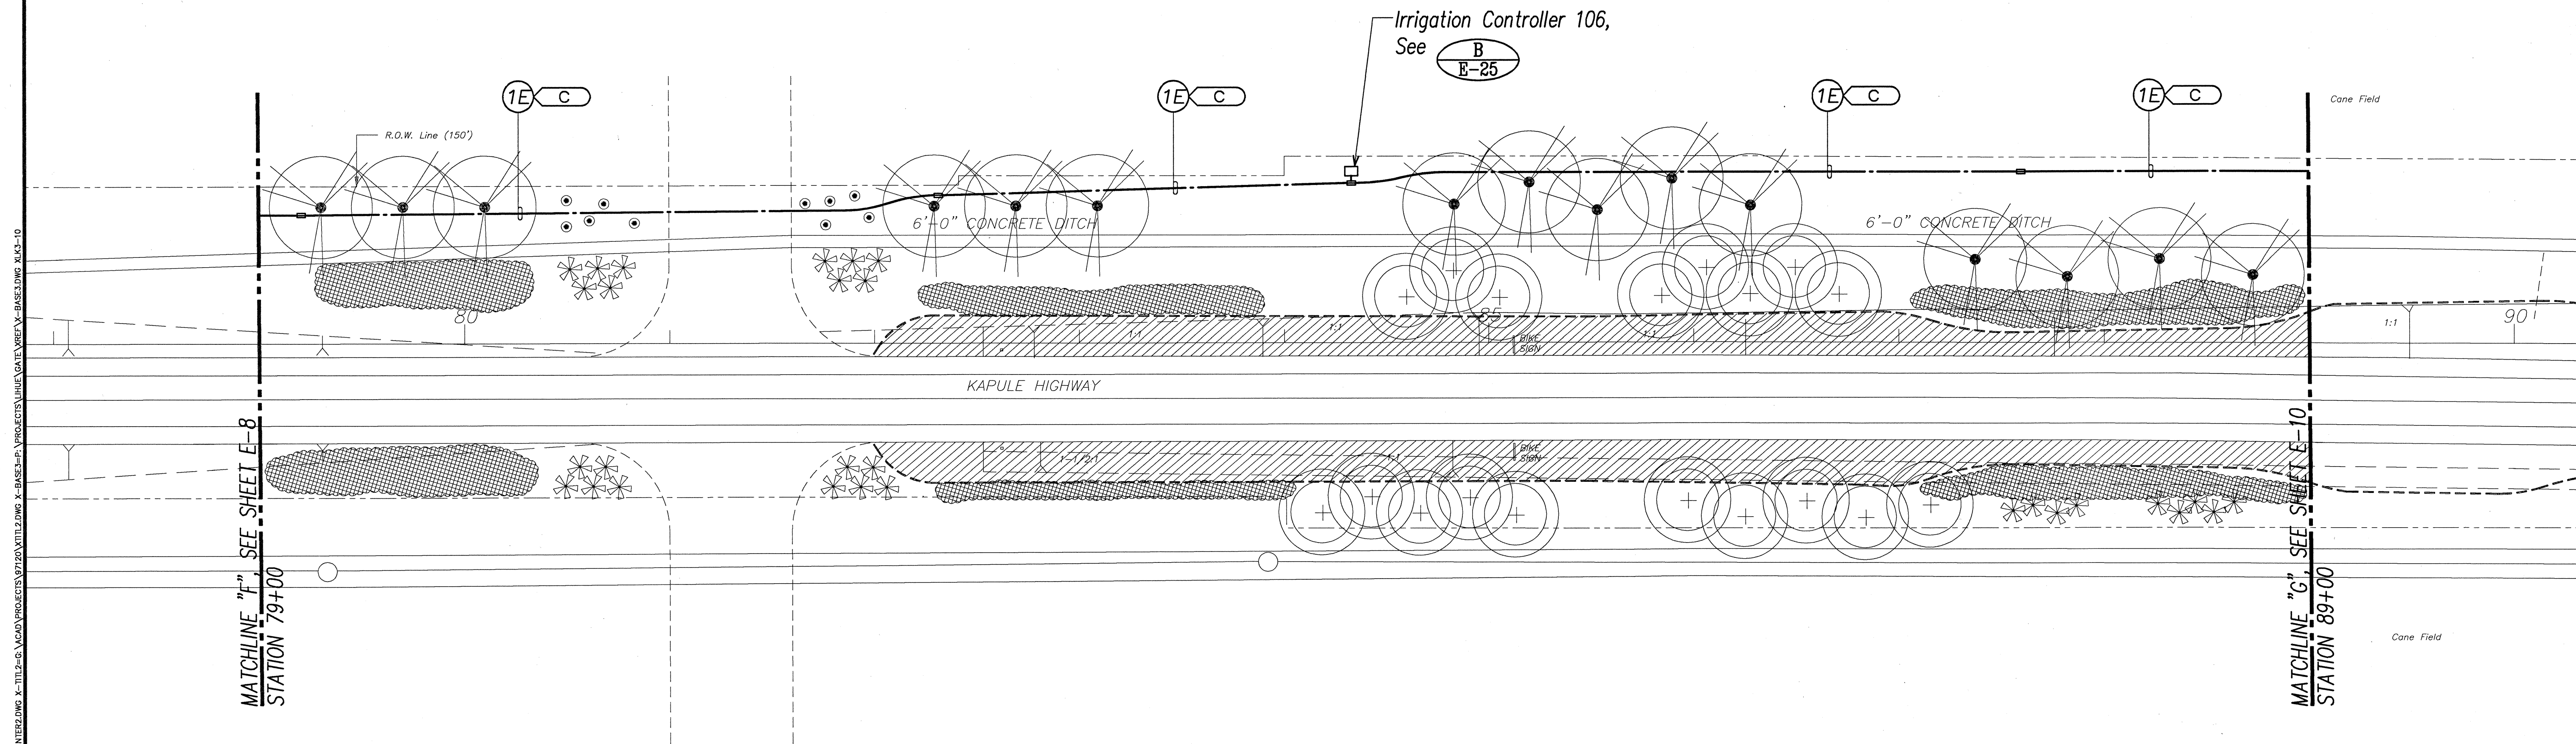


ORIGINAL PLAN	SURVEY PLOTTED BY	DATE
NOTE BOOK	DRAWN BY	
	DESIGNED BY	
	QUANTITIES BY	
	CHECKED BY	

LAST DATE: 10/17/98
 PROJECT: LIHUE GATEWAY LANDSCAPE BEAUTIFICATION PROJECT
 SHEET: E-9 OF 30 SHEETS
 SCALE: AS NOTED
 DATE: OCTOBER 1998

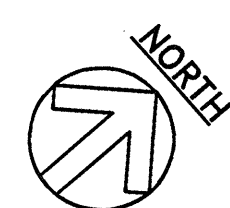


ELECTRICAL SITE PLAN VIII

SCALE: 1"=40'

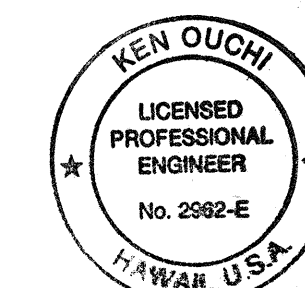

K. Ouchi
 THIS WORK WAS PREPARED BY
 ME OR UNDER MY SUPERVISION.

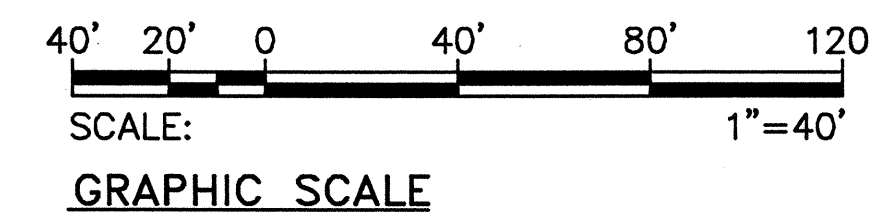

STATE OF HAWAII

DEPARTMENT OF TRANSPORTATION

HIGHWAYS DIVISION


ELECTRICAL SITE PLAN VIII

LIHUE GATEWAY LANDSCAPE
BEAUTIFICATION PROJECT

Scale: AS NOTED Date: OCTOBER 1998


SHEET No. E-9 OF 30 SHEETS

FED. ROAD DIST. NO.	STATE	FED. AID PROJ. NO.	FISCAL YEAR	SHEET NO.	TOTAL SHEETS
HAWAII	HAW.	STP-0700 (43)	1998	121	141


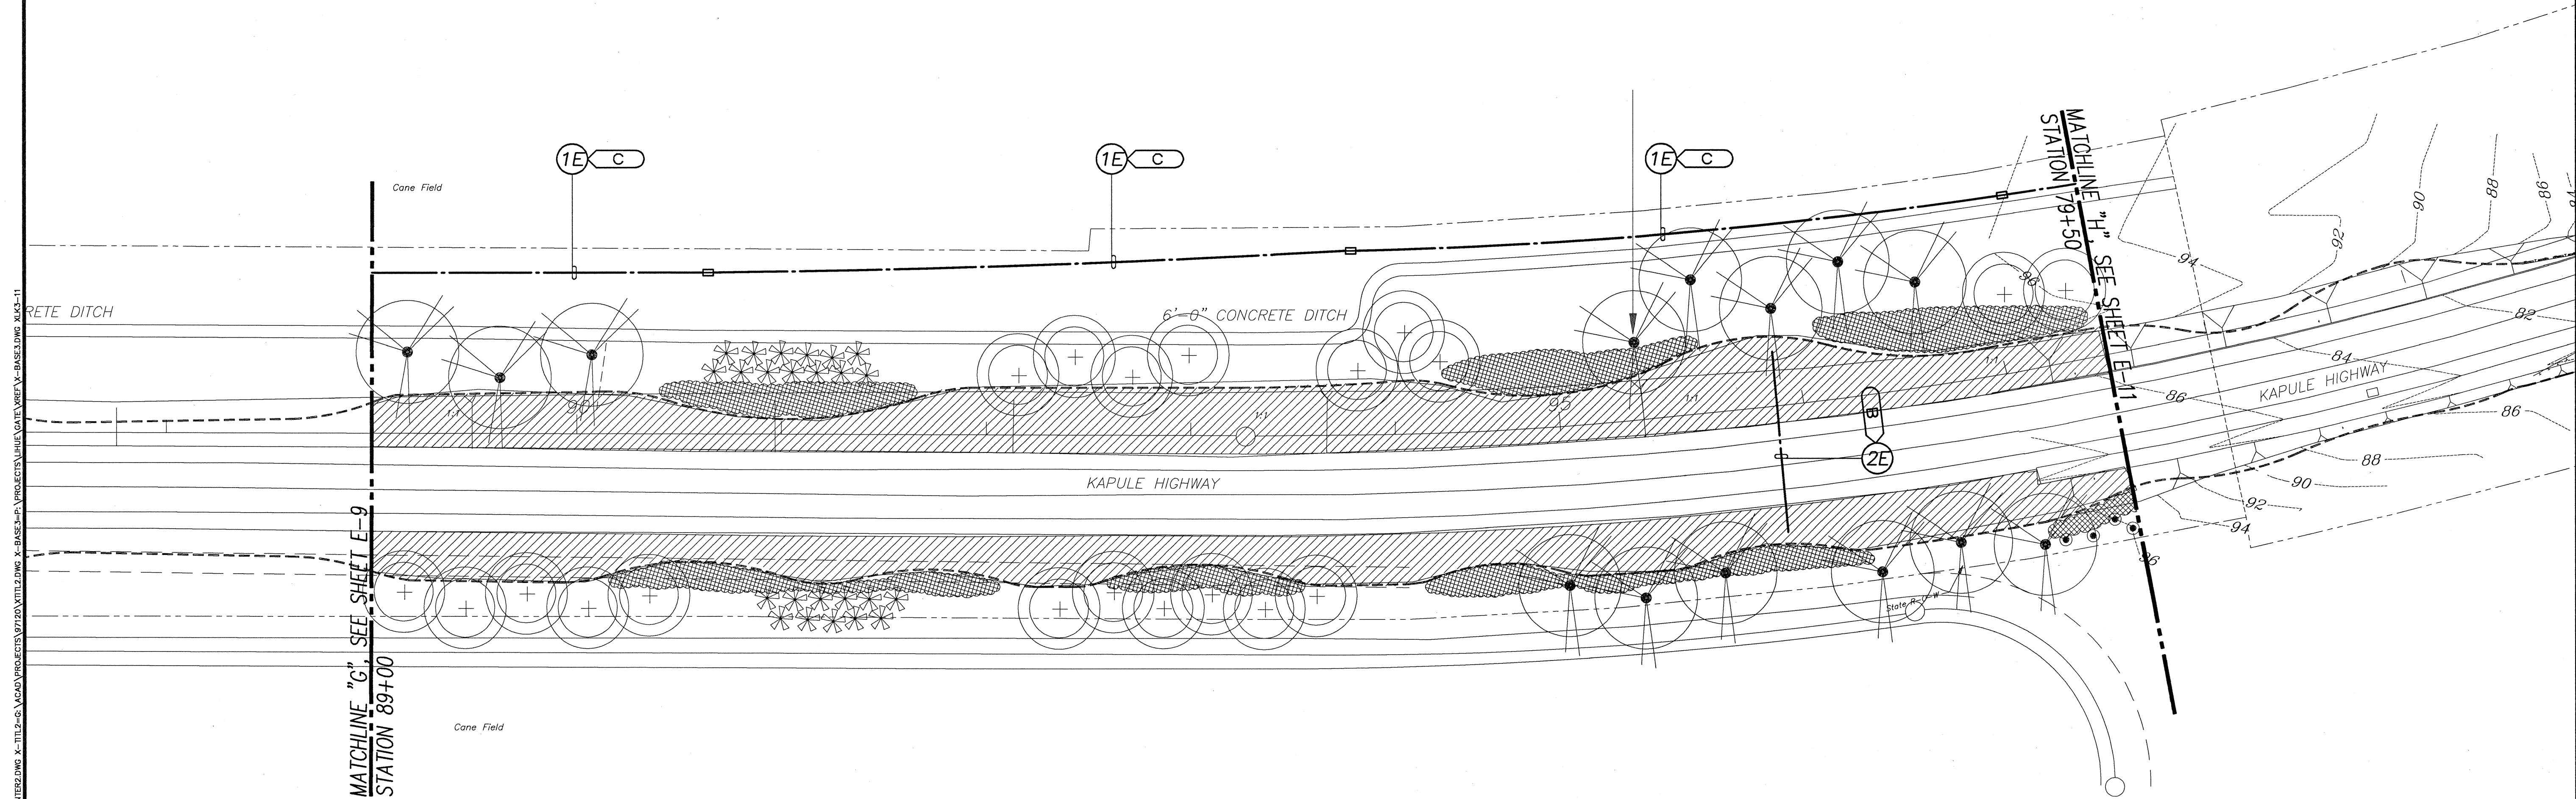


DATE: 10/1/98	SURVEY PLOTTED BY: [Signature]
ORIGINAL PLAN	DRAWN BY: [Signature]
NOTE BOOK	DESIGNED BY: [Signature]
	CHECKED BY: [Signature]
	APPROVED BY: [Signature]

SEE SHEET E-8 FOR MATCHLINE "C" AND SHEET E-11 FOR MATCHLINE "H".

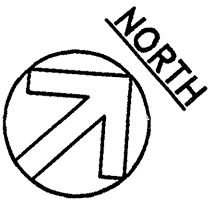

ELECTRICAL SITE PLAN IX SCALE: 1"=40'

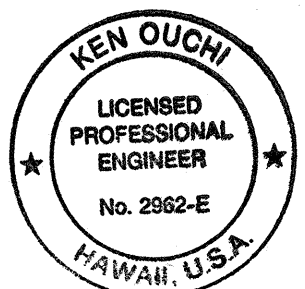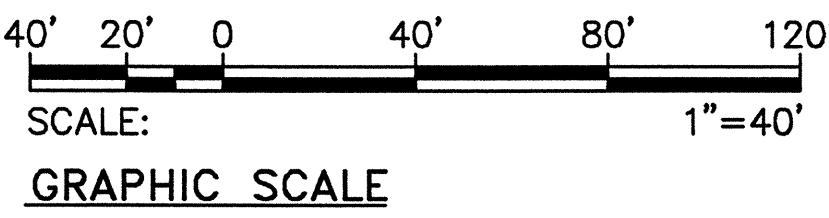

K. Ouchi
THIS WORK WAS PREPARED BY
ME OR UNDER MY SUPERVISION.

STATE OF HAWAII
DEPARTMENT OF TRANSPORTATION
HIGHWAYS DIVISION

ELECTRICAL SITE PLAN IX


LIHUE GATEWAY LANDSCAPE
BEAUTIFICATION PROJECT

Scale: AS NOTED Date: OCTOBER 1998

SHEET No. E-10 OF 30 SHEETS

121


FED. ROAD DIST. NO.	STATE	FED. AID PROJ. NO.	FISCAL YEAR	SHEET NO.	TOTAL SHEETS
HAWAII	HAW.	STP-0700 (43)	1998	122	141

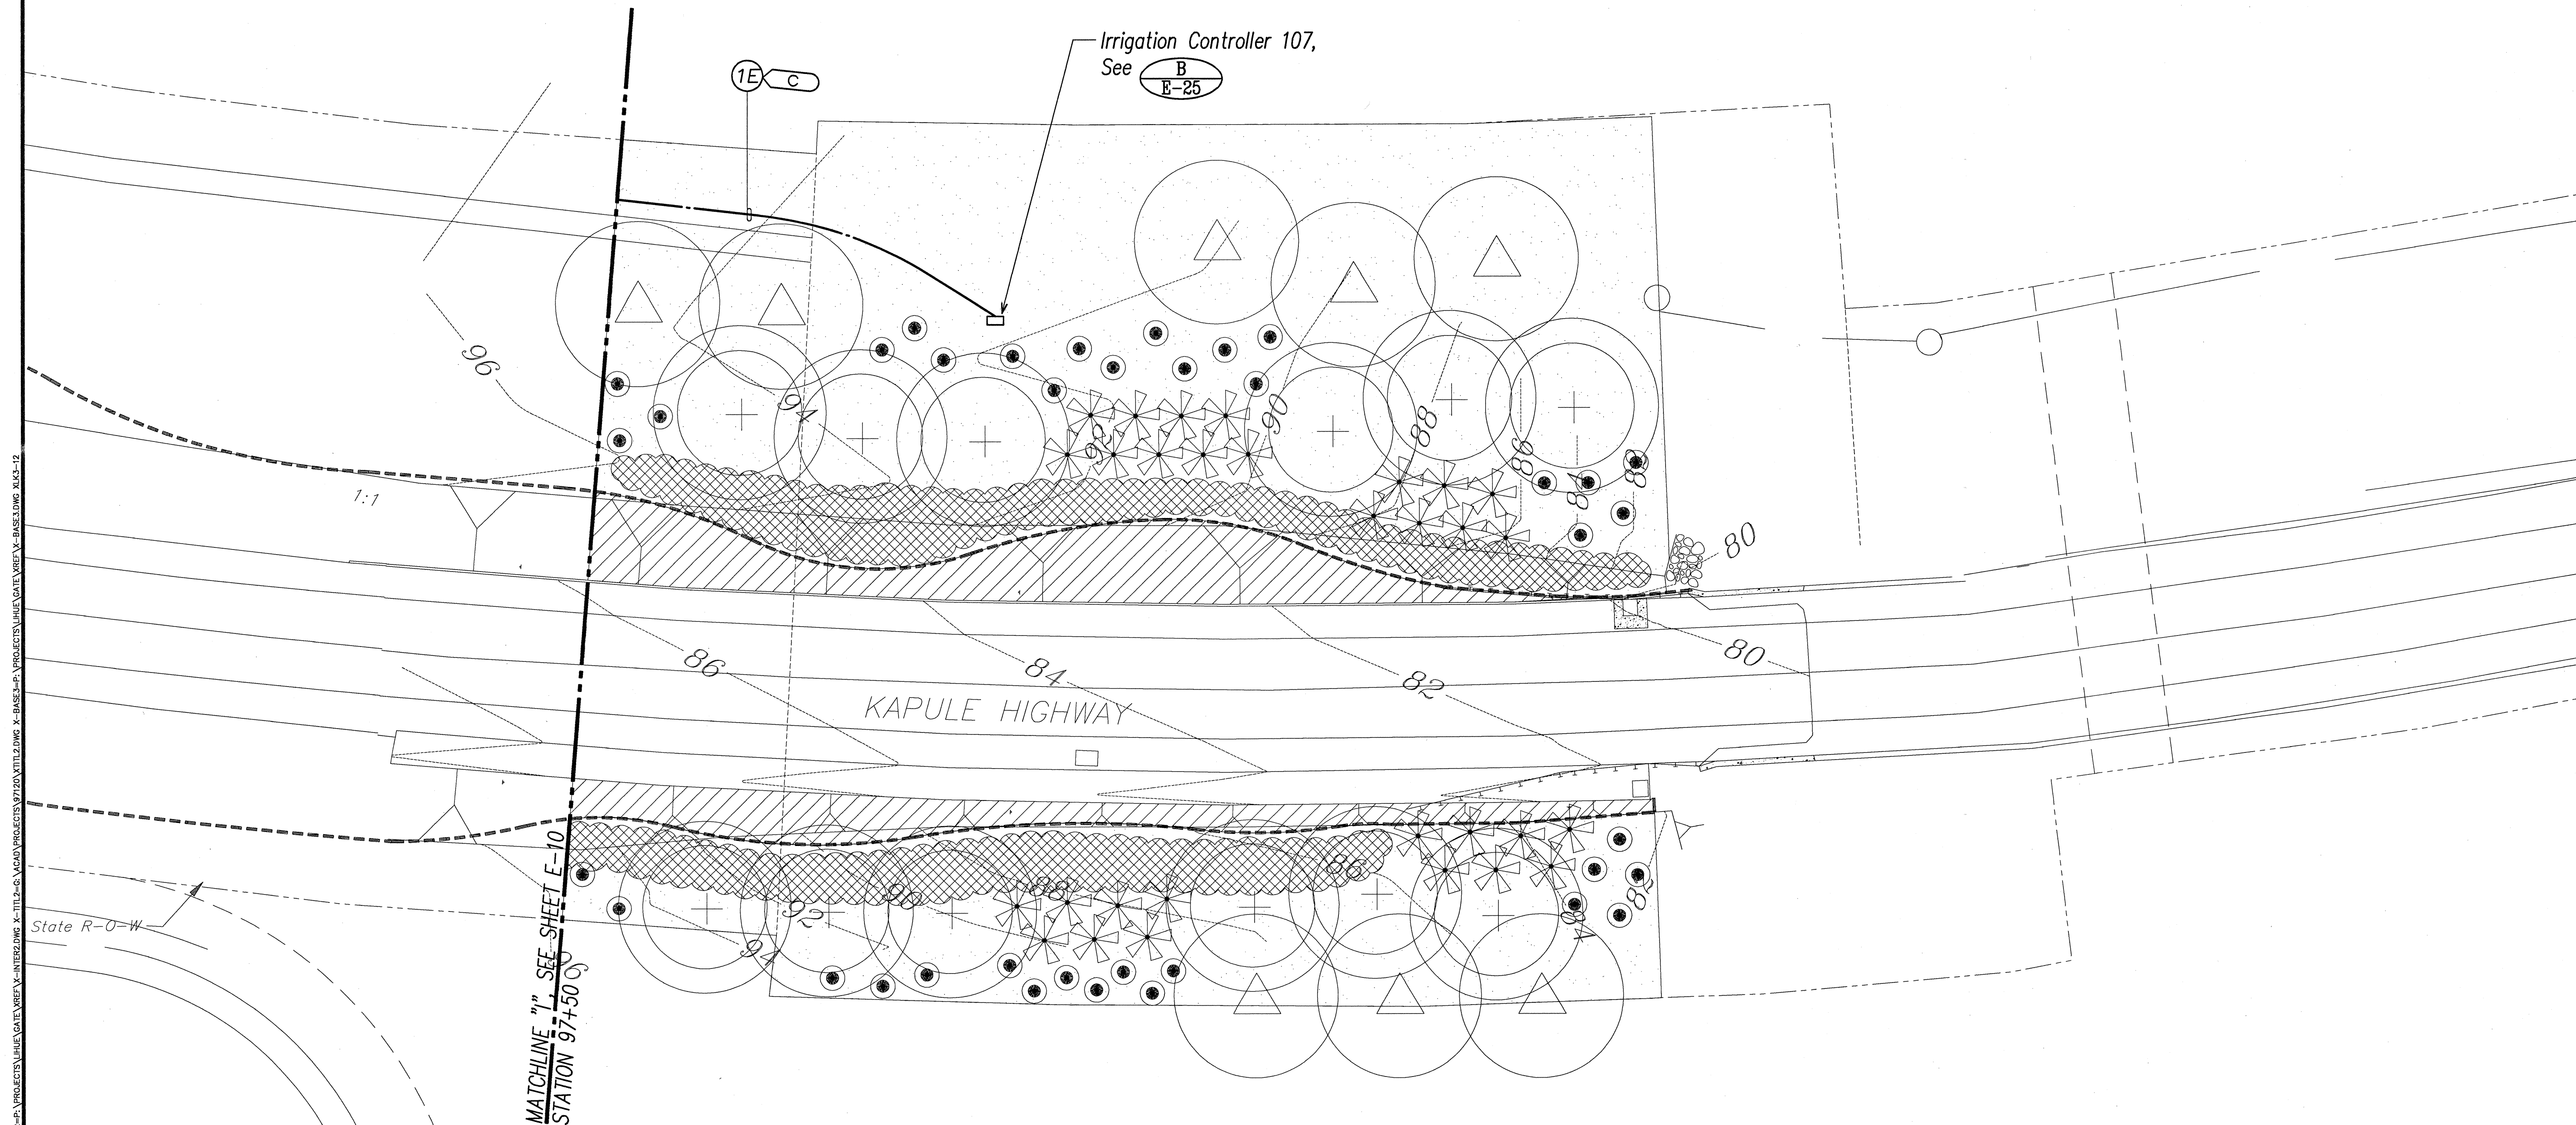

ORIGINAL PLAN	SURVEY PLOTTED BY	DATE
NOTE BOOK	DRAWN BY	
	DESIGNED BY	
	CHECKED BY	


LOT 16, 17, 18, 2152, 215

FED. ROAD DIST. NO.	STATE	FED. AID PROJ. NO.	FISCAL YEAR	SHEET NO.	TOTAL SHEETS
HAWAII	HAW.	STP-0700 (43)	1998	123	141

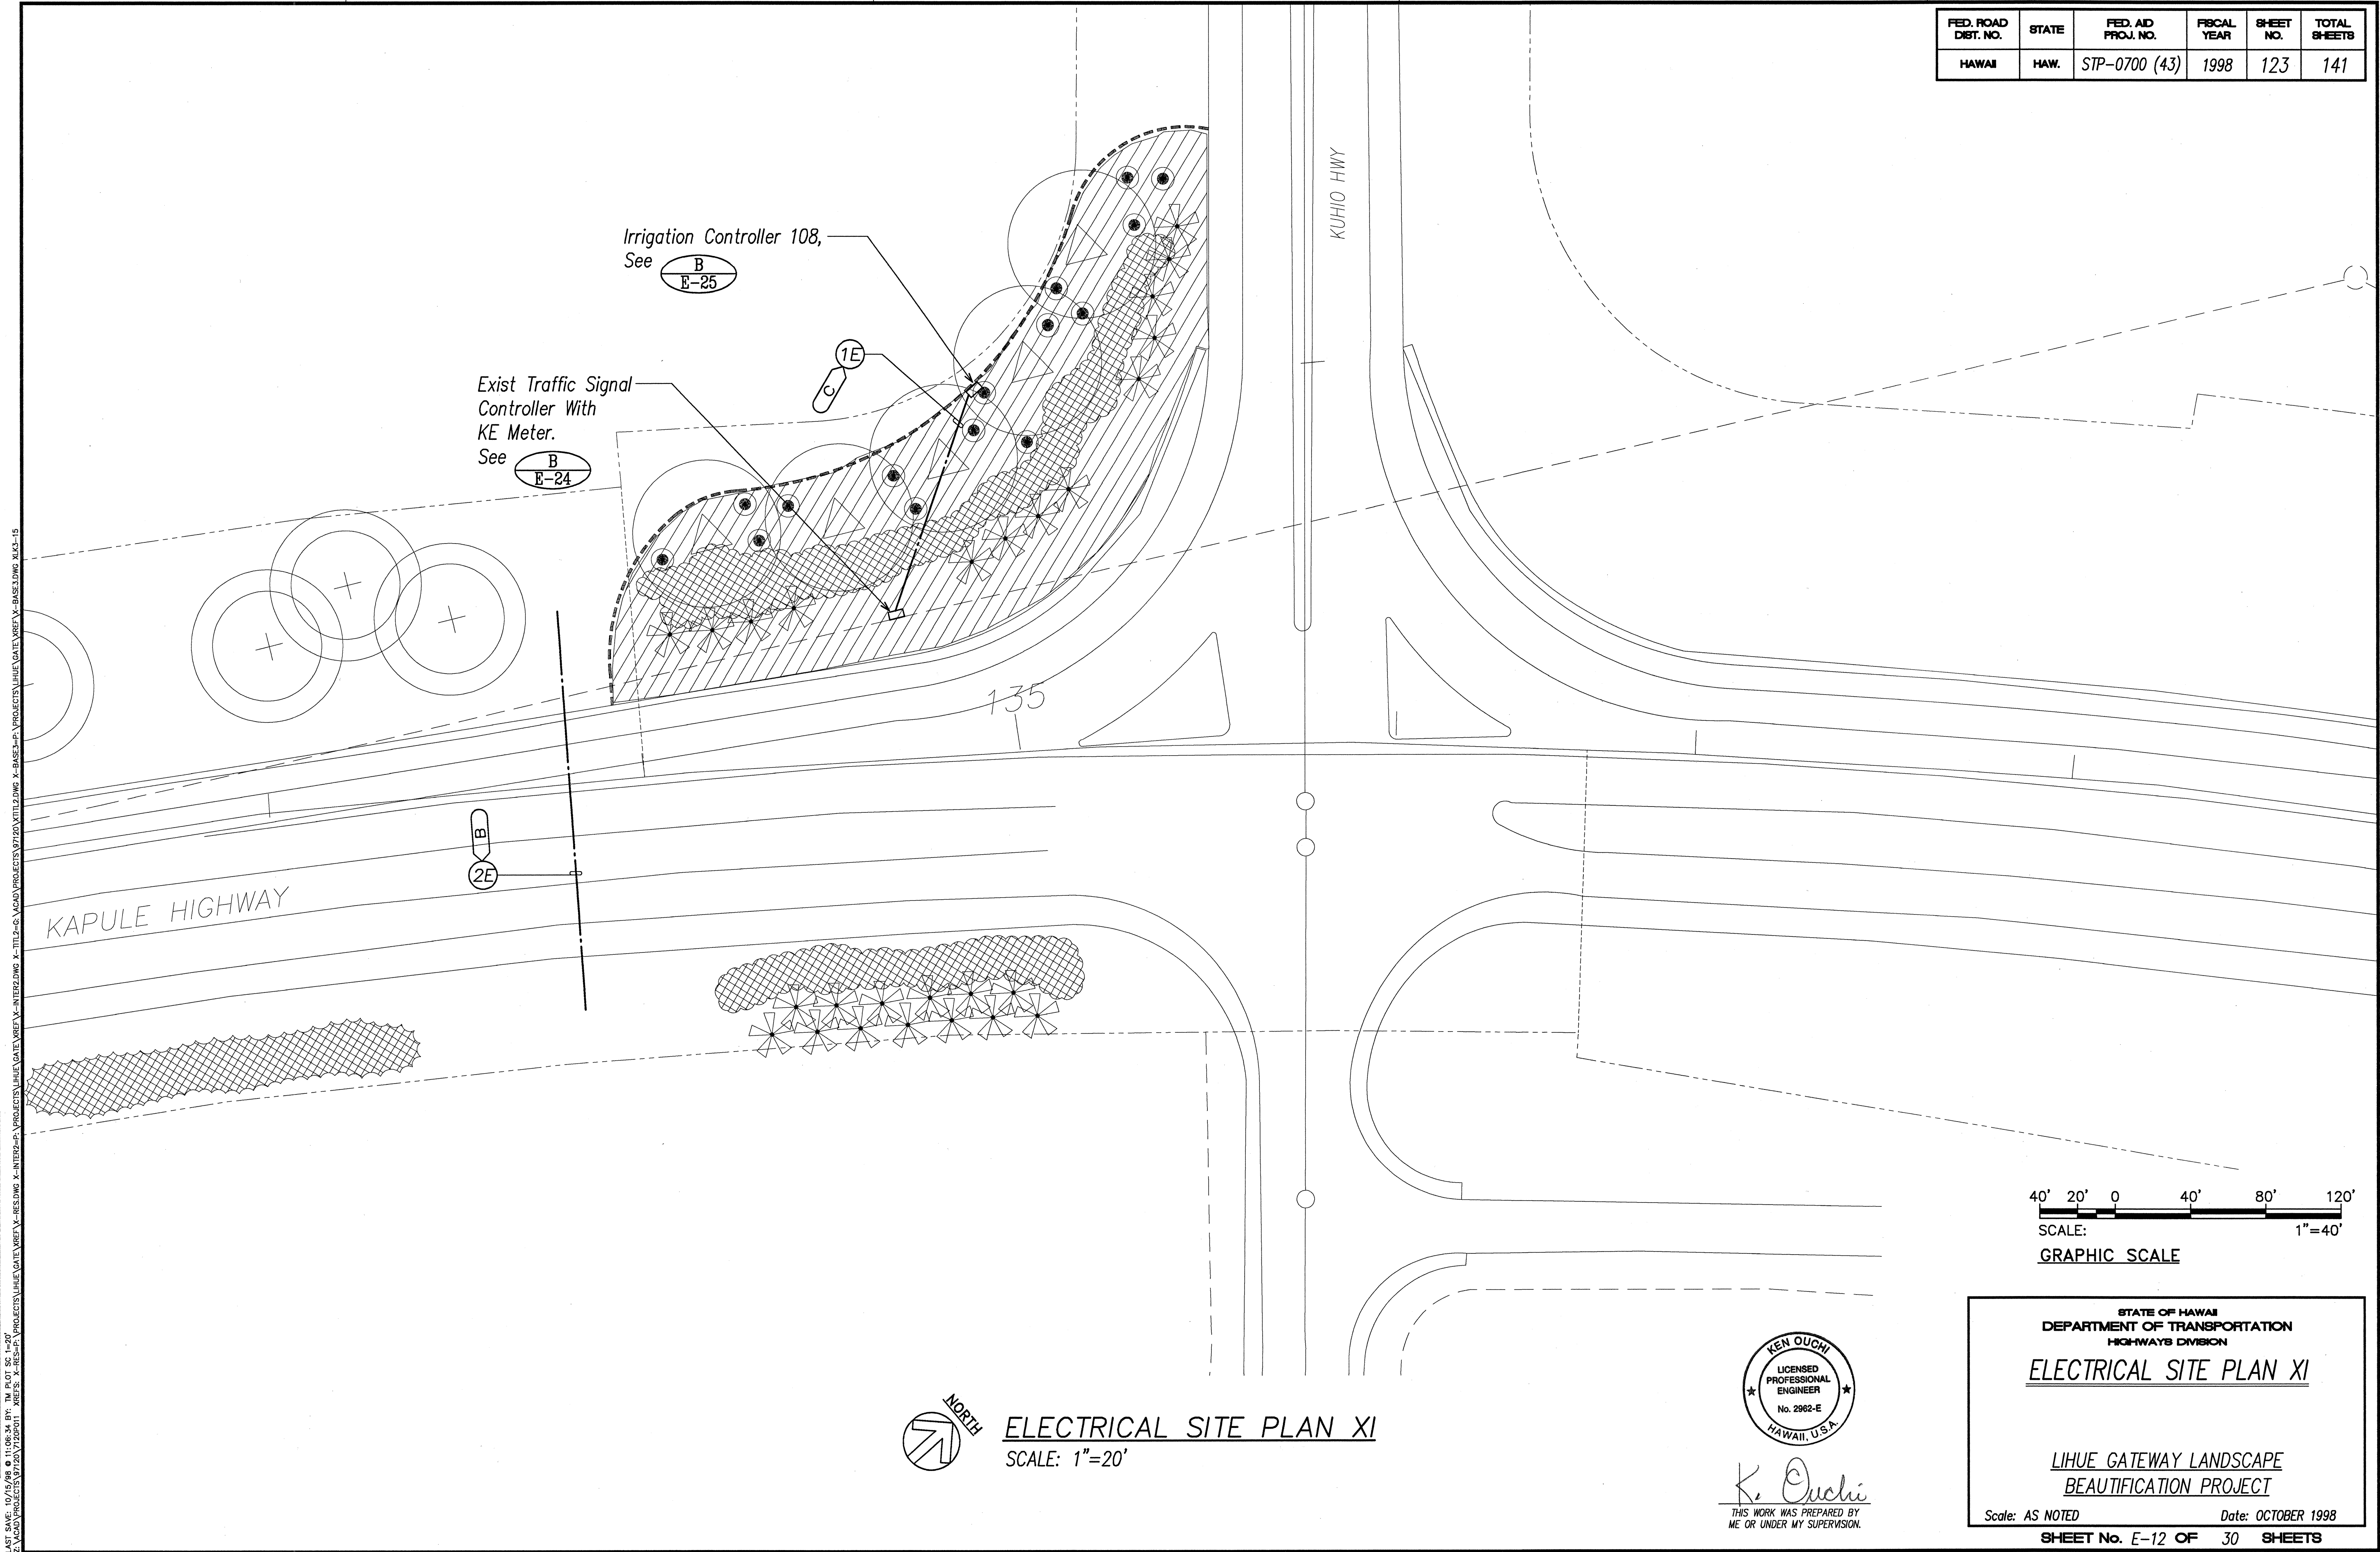


ORIGINAL PLAN	SURVEY PLOTTED BY	DATE
NOTE BOOK	DRAWN BY	
	DESIGNED BY	
	CHECKED BY	
	DATE	

LAST DATE: 10/19/98 BY: J. K. OUCHI
 Z:\MACRO\PROJECTS\0720\TITLE.DWG X-TITLE-00\PROJECTS\LIHUE GATEWAY\X-BASE-00\PROJECTS\LIHUE GATEWAY\X-BASE-00\X-13-15

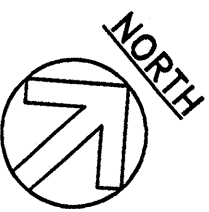

ELECTRICAL SITE PLAN XI

SCALE: 1"=20'

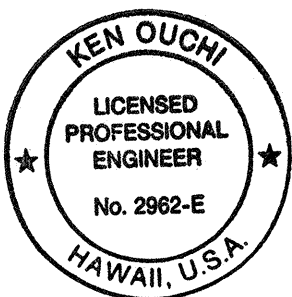

K. Ouchi
 THIS WORK WAS PREPARED BY
 ME OR UNDER MY SUPERVISION.

STATE OF HAWAII
 DEPARTMENT OF TRANSPORTATION
 HIGHWAYS DIVISION


ELECTRICAL SITE PLAN XI

LIHUE GATEWAY LANDSCAPE
 BEAUTIFICATION PROJECT

Scale: AS NOTED Date: OCTOBER 1998


SHEET No. E-12 OF 30 SHEETS

FED. ROAD DIST. NO.	STATE	FED. AID PROJ. NO.	FISCAL YEAR	SHEET NO.	TOTAL SHEETS
HAWAII	HAW.	STP-0700 (43)	1998	124	141

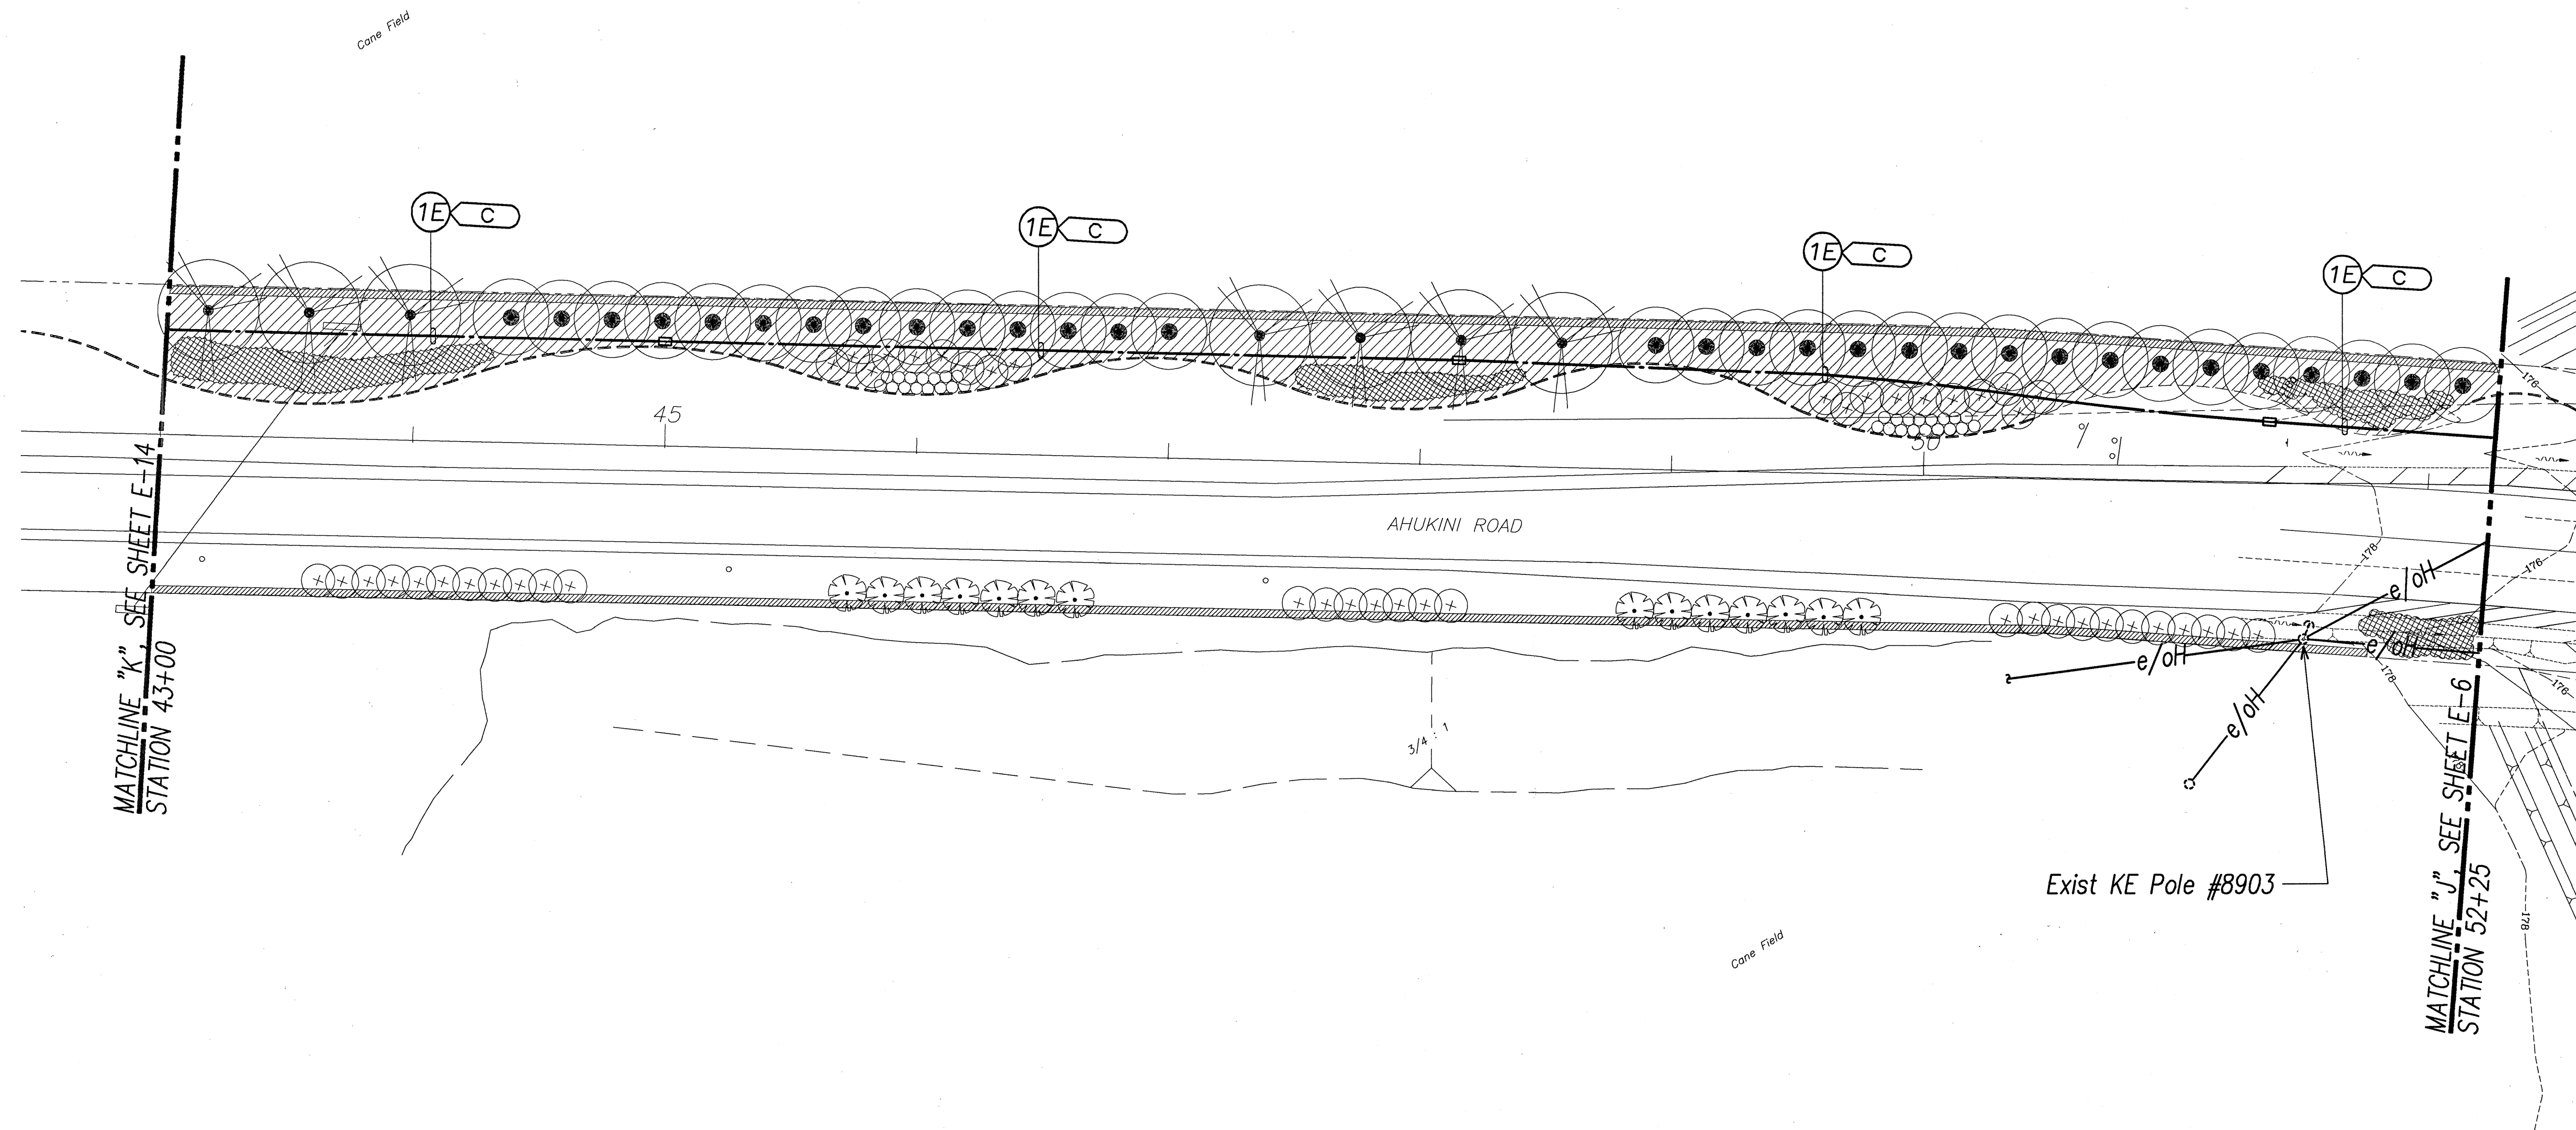


ORIGINAL PLAN	SURVEY PLOTTED BY	DATE
NOTE BOOK	DRAWN BY	
	DESIGNED BY	
	CHECKED BY	


LOT 546, 1/4 SEC. 16, T. 10 N., R. 10 E., S. 10, KAUAI COUNTY, HAWAII. PROJECT: LIHUE GATEWAY LANDSCAPE BEAUTIFICATION PROJECT. SHEET: E-13 OF 30. DATE: OCTOBER 1998.

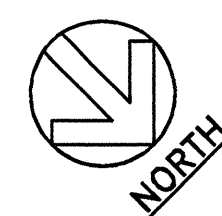

ELECTRICAL SITE PLAN XII
SCALE: 1"=40'

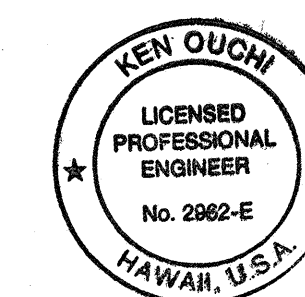

K. Ouchi
THIS WORK WAS PREPARED BY
ME OR UNDER MY SUPERVISION.

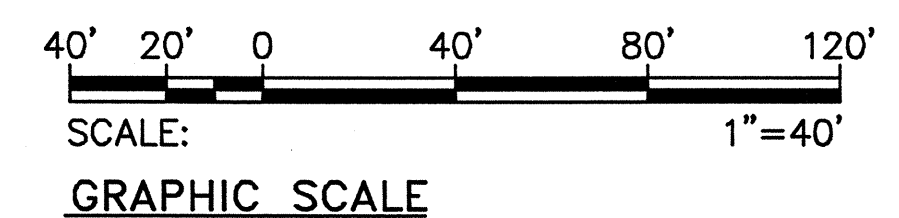


STATE OF HAWAII
DEPARTMENT OF TRANSPORTATION
HIGHWAYS DIVISION

ELECTRICAL SITE PLAN XII

LIHUE GATEWAY LANDSCAPE
BEAUTIFICATION PROJECT

Scale: AS NOTED Date: OCTOBER 1998
SHEET No. E-13 OF 30 SHEETS

FED. ROAD DIST. NO.	STATE	FED. AID PROJ. NO.	FISCAL YEAR	SHEET NO.	TOTAL SHEETS
HAWAII	HAW.	STP-0700 (43)	1998	126	141

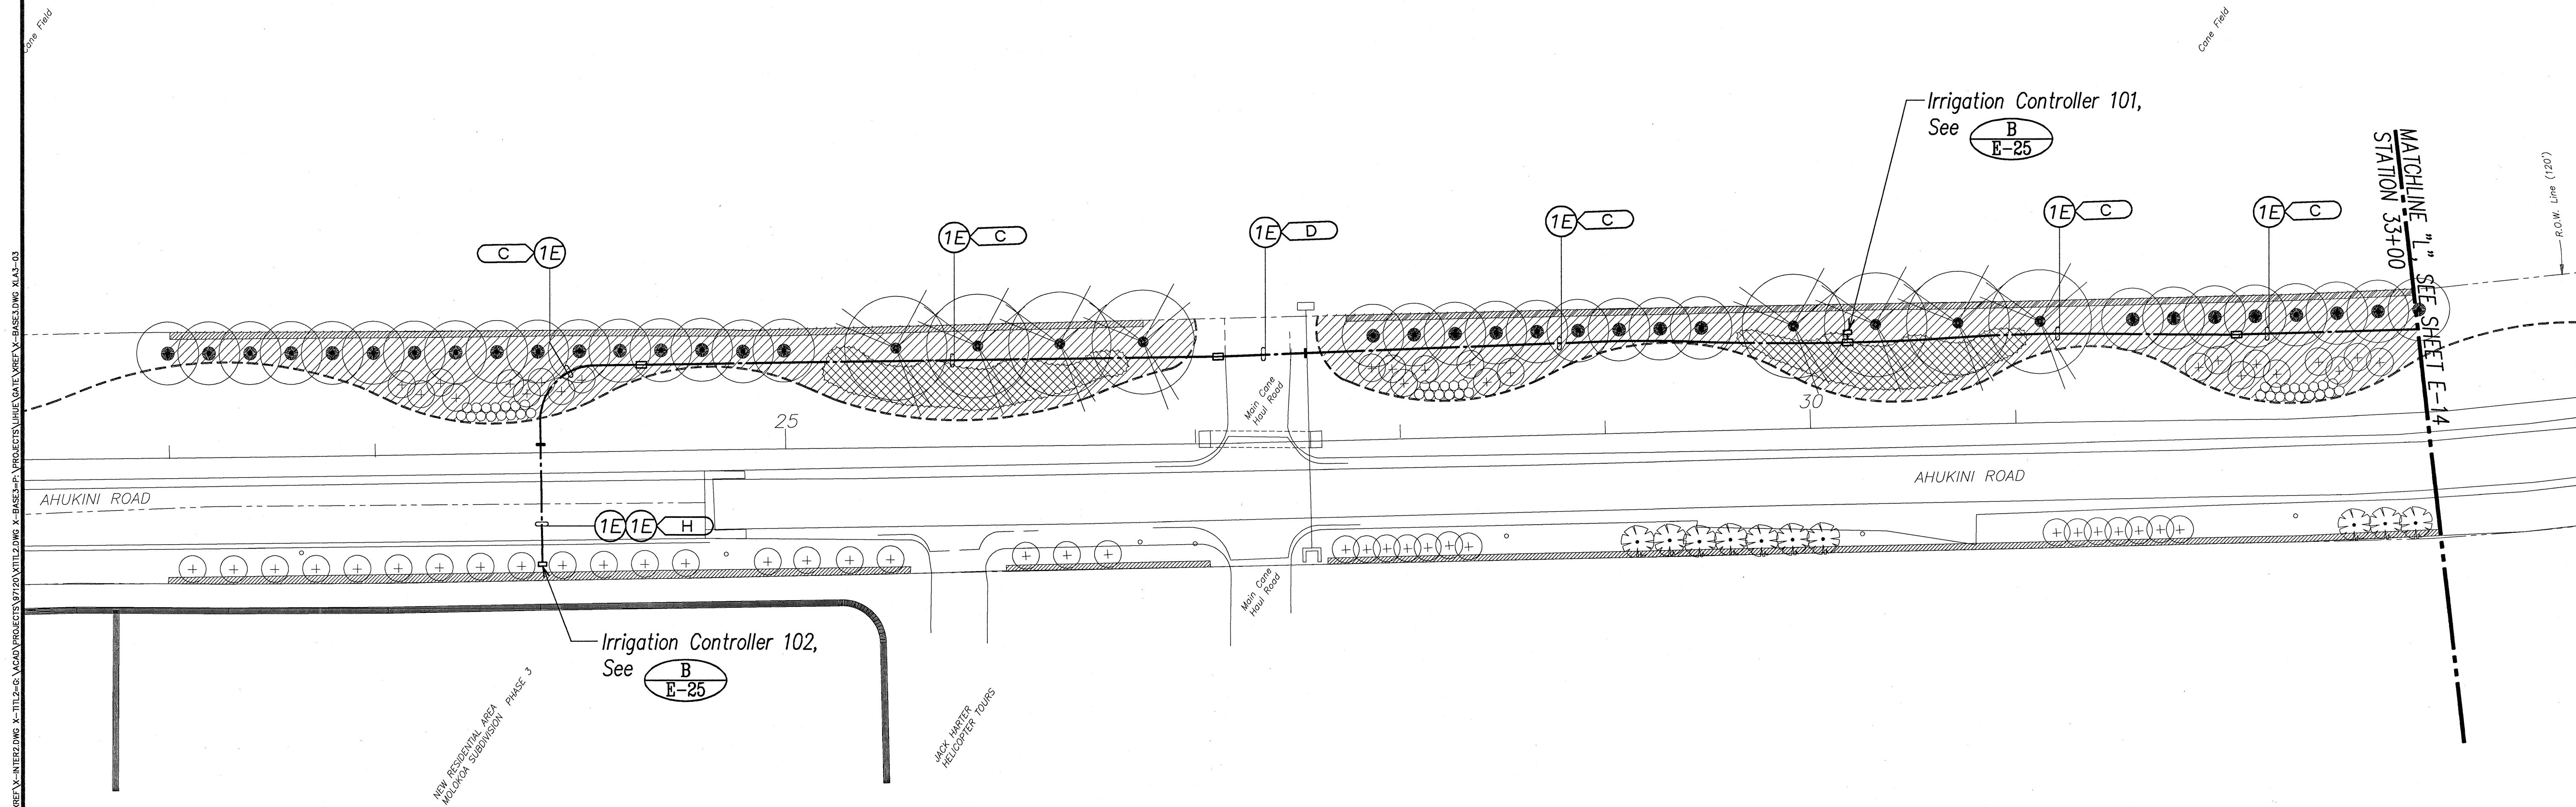


ORIGINAL PLAN	SURVEY PLOTTED BY	DATE
NOTE BOOK	DRAWN BY	
	DESIGNED BY	
	CHECKED BY	


LAST DATE: 10/1/98 BY: K. Ouchi, EIT, 2002-E, No. 2002-E, HAWAII, U.S.A. THIS WORK WAS PREPARED BY ME OR UNDER MY SUPERVISION.



ELECTRICAL SITE PLAN XIV SCALE: 1"=40'

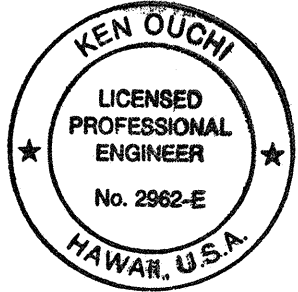

K. Ouchi
THIS WORK WAS PREPARED BY
ME OR UNDER MY SUPERVISION.

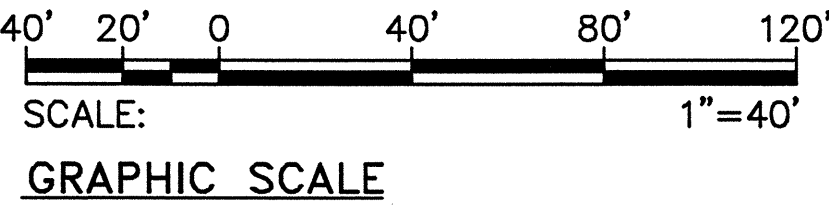

STATE OF HAWAII
DEPARTMENT OF TRANSPORTATION
HIGHWAYS DIVISION
ELECTRICAL SITE PLAN XIV

LIHUE GATEWAY LANDSCAPE
BEAUTIFICATION PROJECT
Scale: AS NOTED Date: OCTOBER 1998
SHEET No. E-15 OF 30 SHEETS

126