


FED. ROAD DIST. NO.	STATE	FED. AID PROJ. NO.	FISCAL YEAR	SHEET NO.	TOTAL SHEETS
HAWAII	HAW.	STP-0700 (43)	1998	130	141




DATE	_____
SURVEY PLOTTED BY	_____
DRAWN BY	_____
DESIGNED BY	_____
QUANTITIES BY	_____
CHECKED BY	_____
APPROVED BY	_____
NO.	_____


LAST DATE OF ANY REVISIONS: 10/27/98
 BY: K. OUCHI
 REVISIONS: 1-40

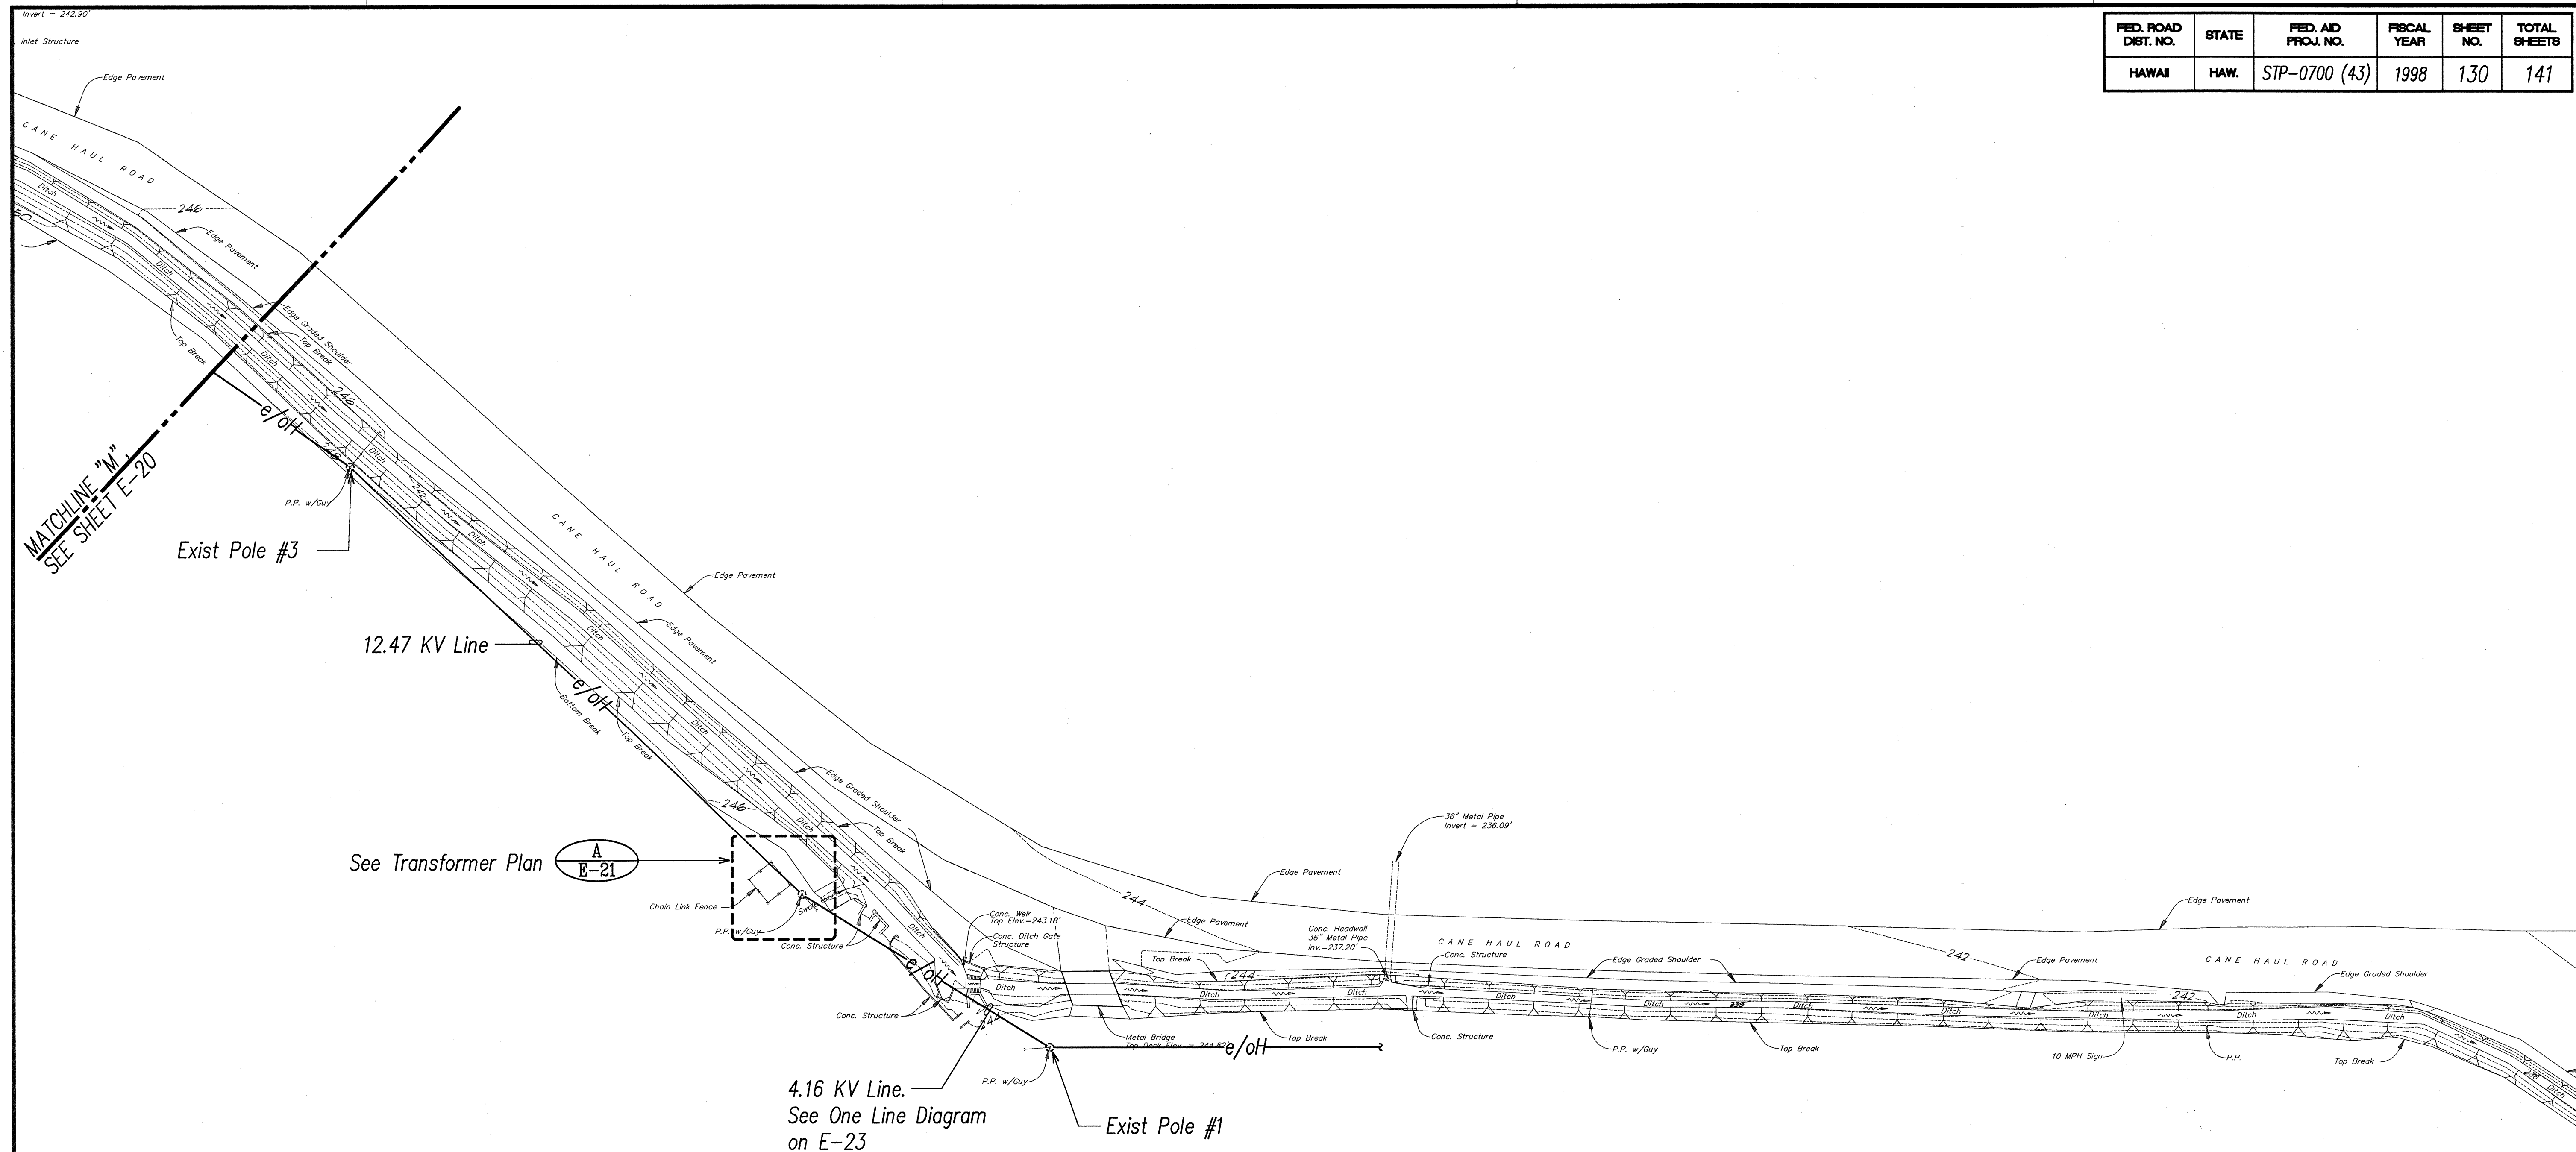

ELECTRICAL SITE PLAN – IRRIGATION PUMP FACILITY SCALE: 1"=40'

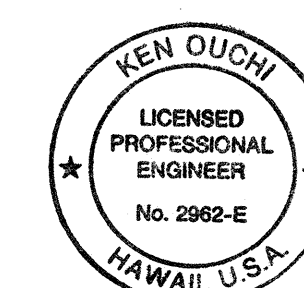

K. Ouchi
 THIS WORK WAS PREPARED BY
 ME OR UNDER MY SUPERVISION.

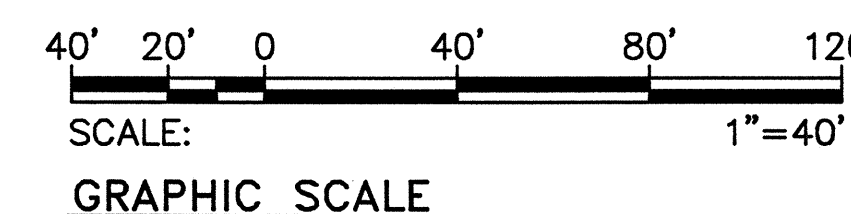

STATE OF HAWAII

DEPARTMENT OF TRANSPORTATION

HIGHWAYS DIVISION

ELECTRICAL SITE PLAN

IRRIGATION PUMP FACILITY

LIHUE GATEWAY LANDSCAPE


BEAUTIFICATION PROJECT

Scale: AS NOTED

Date: OCTOBER 1998

SHEET No. E-19 OF 30 SHEETS

FED. ROAD DIST. NO.	STATE	FED. AID PROJ. NO.	FISCAL YEAR	SHEET NO.	TOTAL SHEETS
HAWAII	HAW.	STP-0700 (43)	1998	31	141

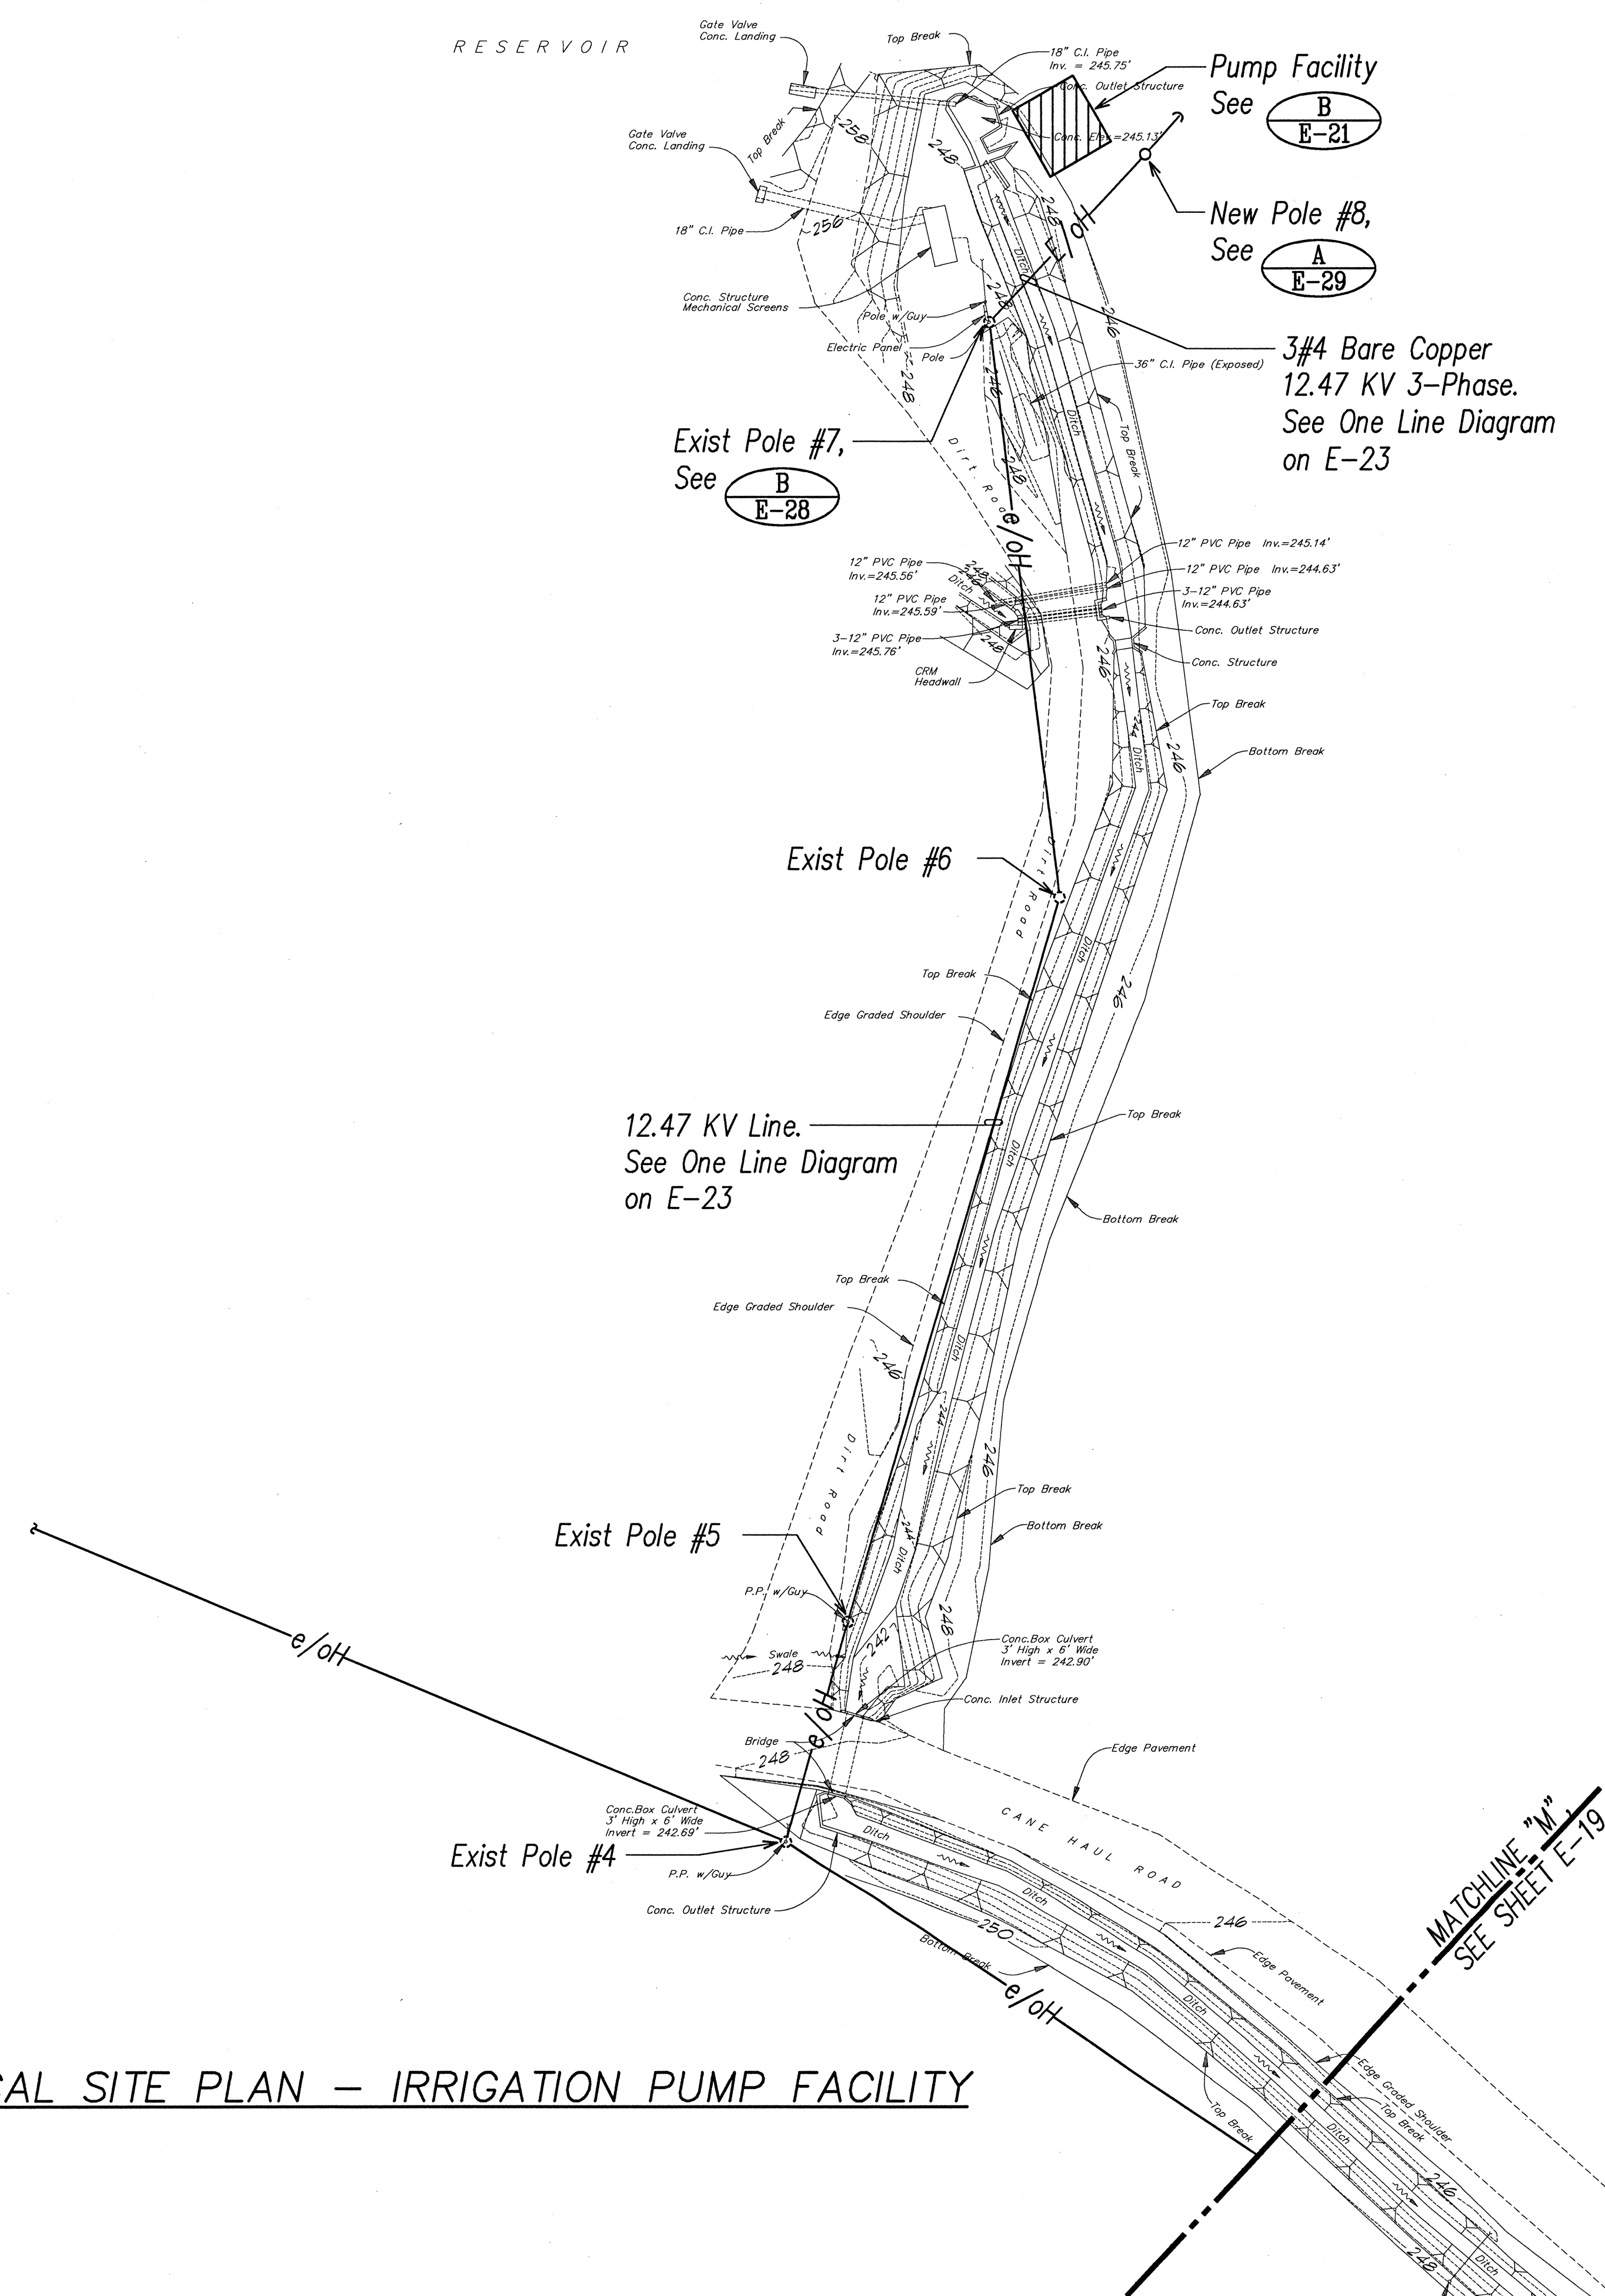


SURVEY PLOTTED BY	DATE
DRAWN BY	
DESIGNED BY	
CHECKED BY	
NOTED BY	
NO.	


LAST DATE 10/15/98 BY: K. OUCHI
 2. AMENDMENTS TO SHEETS: NONE



ELECTRICAL SITE PLAN – IRRIGATION PUMP FACILITY
 SCALE: 1"=40'

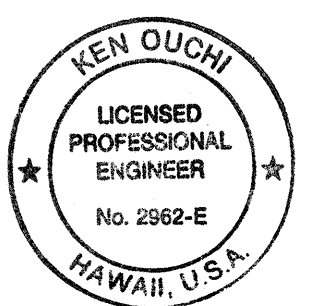

K. Ouchi
 THIS WORK WAS PREPARED BY
 ME OR UNDER MY SUPERVISION.

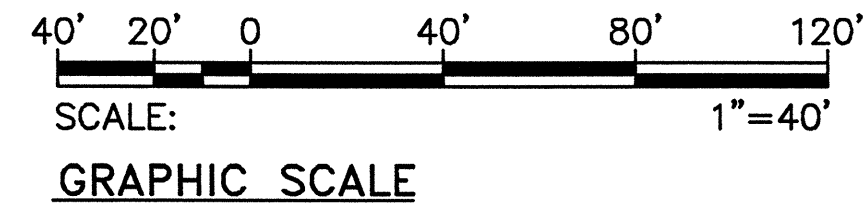

STATE OF HAWAII
DEPARTMENT OF TRANSPORTATION
HIGHWAYS DIVISION

ELECTRICAL SITE PLAN
IRRIGATION PUMP FACILITY

LIHUE GATEWAY LANDSCAPE
BEAUTIFICATION PROJECT

Scale: AS NOTED
Date: OCTOBER 1998

SHEET No. E-20 OF 30 SHEETS