
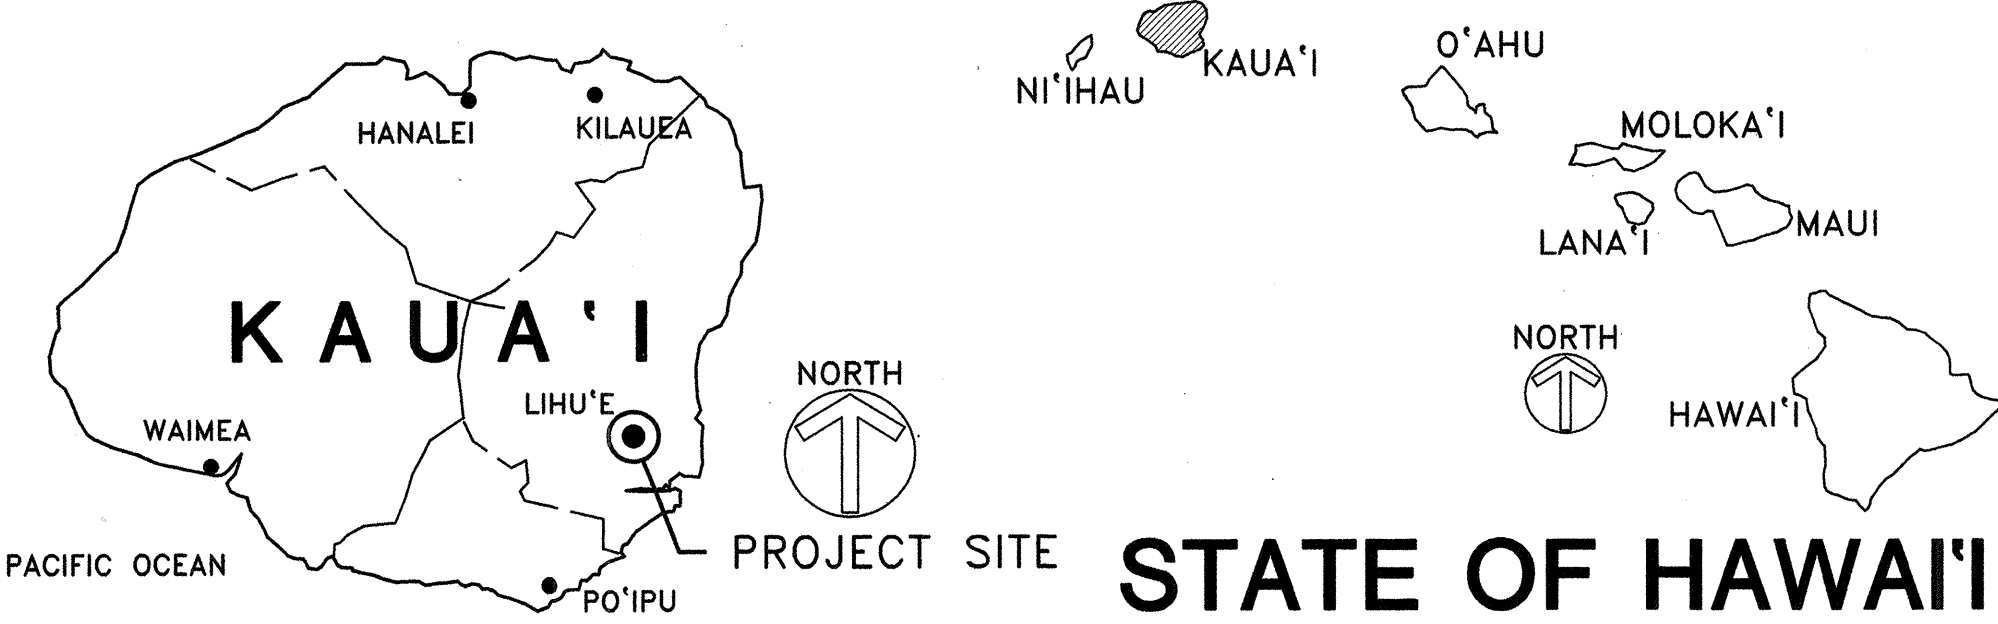


INDEX TO DRAWINGS					
SHEET NO.	DESCRIPTION	DRAWING NO.	SHEET NO.	DESCRIPTION	DRAWING NO.
1	TITLE SHEET	T-1	132	ELECTRICAL PLAN	E-21
2	STANDARD PLANS SUMMARY	C-1		IRRIGATION PUMP FACILITY	
3	GENERAL NOTES	C-2	133	ELECTRICAL DIAGRAMS	E-22
4	LEGEND	C-3	134	ELECTRICAL DIAGRAM- IRRIGATION PUMP FACILITY	E-23
5 TO 6	MASS GRADING PLAN	C-4 TO C-5			
7 TO 8	DETAILS	C-6 TO C-7	135	ELECTRICAL SERVICE DETAILS, PANEL SCHEDULE	E-24
9	TRAFFIC SIGNING PLAN	C-8			
10 TO 11	TRAFFIC SIGN SUMMARY	C-9 TO C-10	136	WIRING AND PULLBOX DETAILS	E-25
12 TO 14	ENTRY WALL LAYOUT PLAN	LH-1 TO LH-3	137	LANDSCAPE LIGHTS	E-26
15 TO 16	SIGN WALL SECTIONS	LH-4 TO LH-5	138	DUCT SECTIONS	E-27
17 TO 29	IRRIGATION SUPPLY LINE PLAN	S1 TO S13	139 TO 141	POLE DETAILS	E-28 TO E-30
30 TO 39	IRRIGATION SUPPLY LINE DETAILS	S14 TO S23			
40	RESERVOIR CONNECTION DETAILS	R1			
41	IRRIGATION PUMP, FILTER AND DISTRIBUTION FACILITY PLAN	P1			
42 TO 46	IRRIGATION PUMP, FILTER AND DISTRIBUTION FACILITY PLAN	P2 TO P6			
47 TO 51	LANDSCAPE LAYOUT PLAN	LA1-01 TO LA1-05			
52 TO 53	LANDSCAPE LAYOUT PLAN	LK1-01 TO LK1-02			
54 TO 56	LANDSCAPE LAYOUT PLAN	LK1-06A TO LK1-07			
57 TO 60	LANDSCAPE LAYOUT PLAN	LK1-10 TO LK1-14			
61	LANDSCAPE LAYOUT PLAN	LK1-15			
62 TO 66	LANDSCAPE IRRIGATION PLAN	LA2-01 TO LA2-05			
67 TO 82	LANDSCAPE IRRIGATION PLAN	LK2-01 TO LK2-15			
83 TO 86	LANDSCAPE IRRIGATION DETAILS	LI2-01 TO LI2-04			
87	LANDSCAPE IRRIGATION LEGEND, NOTES AND DETAILS	LI2-05			
88 TO 92	LANDSCAPE PLANTING PLAN	LA3-01 TO LA3-05			
93 TO 108	LANDSCAPE PLANTING PLAN	LK3-01 TO LK3-15			
109	LANDSCAPE PLANT LIST AND NOTES	LP-1			
110	LANDSCAPE PLANTING DETAILS	LP-2			
111	LANDSCAPE SECTIONS	LP-3			
112	ELECTRICAL SITE LOCATION PLAN	E-1			
113 TO 126	ELECTRICAL SITE PLAN I THROUGH XIV	E-2 TO E-15			
127 TO 129	LANDSCAPE LIGHTING PLAN I THROUGH III	E-16 TO E-18			
130 TO 131	ELECTRICAL SITE PLAN IRRIGATION PUMP FACILITY	E-19 TO E-20			

FED. ROAD DIST. NO.	STATE	FED. AID PROJ. NO.	FISCAL YEAR	SHEET NO.	TOTAL SHEETS
HAWAII	HAW.	STP-0700(43)	1998	1	141

STATE OF HAWAII
DEPARTMENT OF TRANSPORTATION
HIGHWAYS DIVISION
HONOLULU, HAWAII
PLANS FOR
LIHU'E GATEWAY BEAUTIFICATION
FEDERAL AID PROJECT
NO. STP-0700 (43)
DISTRICT OF LIHU'E
ISLAND OF KAUAI

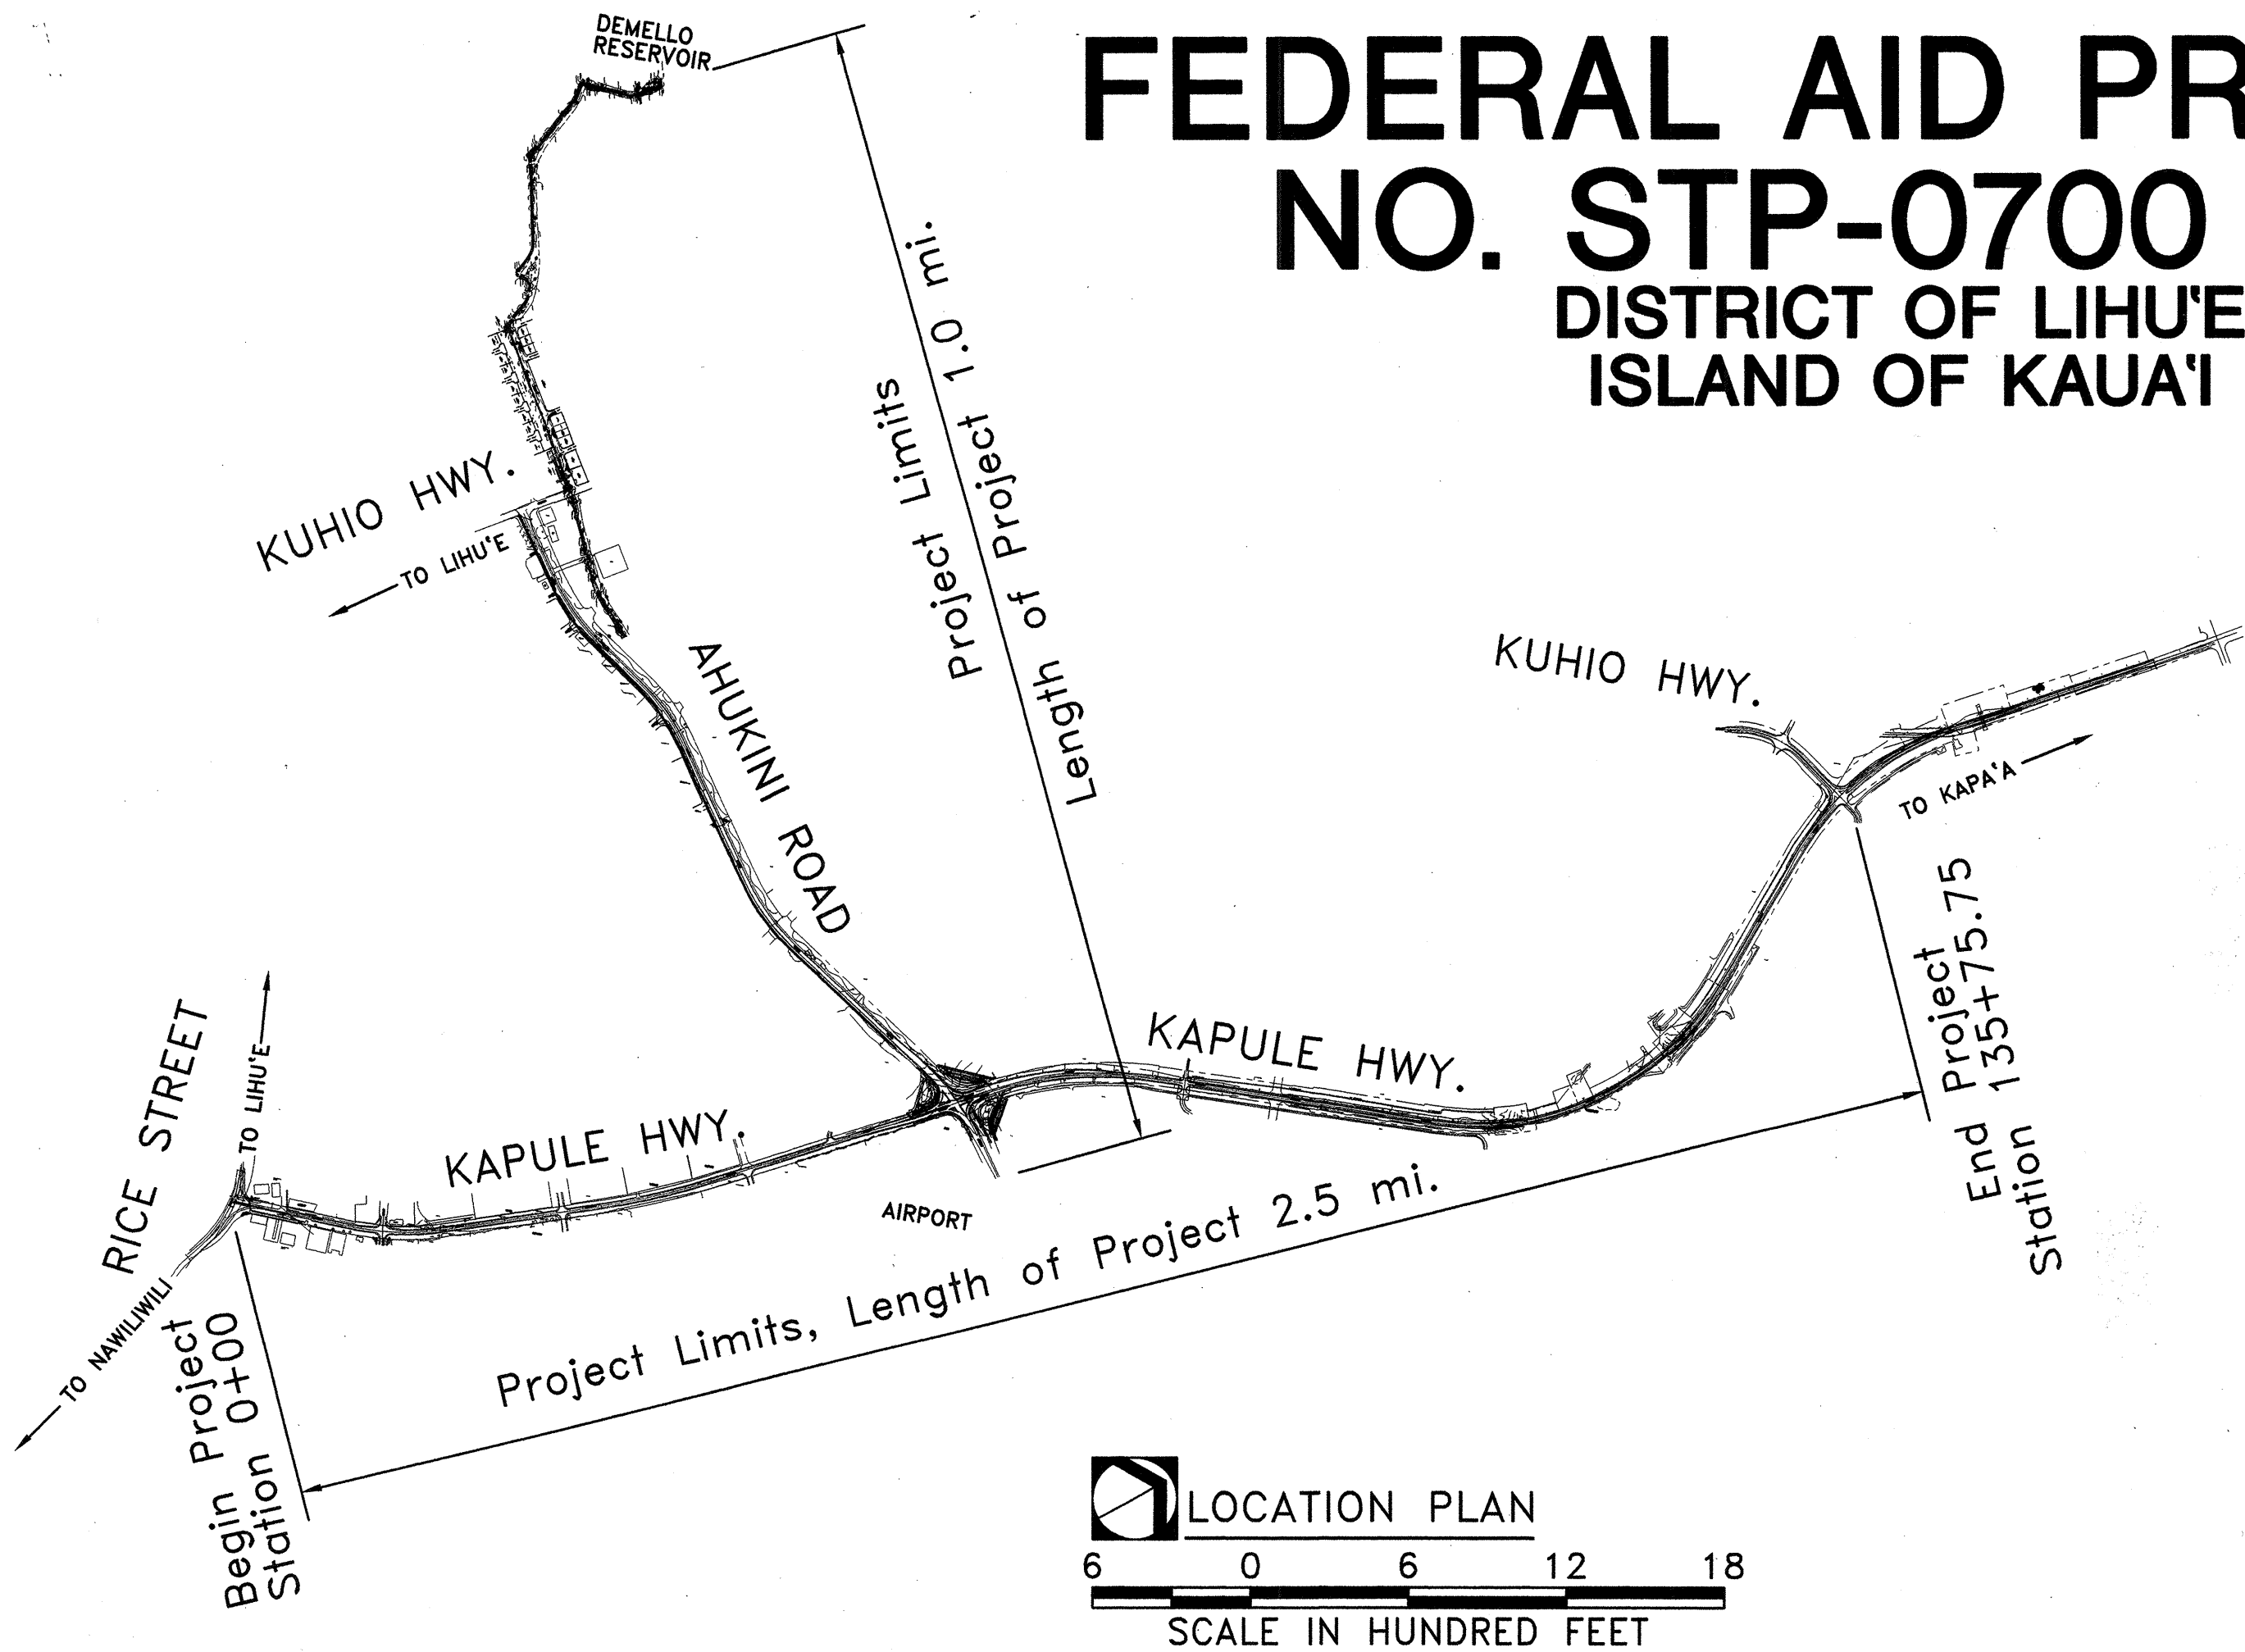

DEPARTMENT OF TRANSPORTATION
STATE OF HAWAII
APPROVED:
Kay Hayschick
DIR. OF TRANSPORTATION
DATE: 12/23/98

JULY 31, 1998
SHEET No. T-1 OF 1 SHEETS

PHILLIPS BRANDT REDDICK
& ASSOCIATES (HAWAII), INC.
DESIGNED BY
FRED REYES
P.S. & E. BY
274-3111
PHONE
JANUARY 1999
DATE