

INDEX TO DRAWINGS	
SHEET NO.	DESCRIPTION
1	TITLE SHEET
2	TYPICAL SECTION
3-5	PLAN & PROFILE
6-7	STANDARD DETAILS
8	DRAINAGE LAYOUT
9	DETAIL OF STAIRS
10-16	CROSS SECTIONS

TERRITORY OF HAWAII
DEPARTMENT OF PUBLIC WORKS
DIVISION OF HIGHWAYS
HONOLULU T. H.



PLANS OF
KAUAI BELT ROAD
WAIMEA - KEKAHA SECTION
FEDERAL AID PROJECT NO. F. A. P. 29-D(1)

DISTRICT OF WAIMEA
ISLAND OF KAUAI

CONVENTIONAL SIGNS	
PRESENT DIRT ROAD	---
EXISTING FENCE	=====
EXISTING STONE FENCE	-----
BOUNDARY LINE	-----
CENTER LINE	-----
CULVERTS	-----
BRIDGES	-----

SCALE

PLAN 1 IN. = 100 FT.
PROFILE 1 IN. = 100 "
CROSS SECTION { Vert. : 1 IN. = 10 "
 Hor. : 1 IN. = 10 "

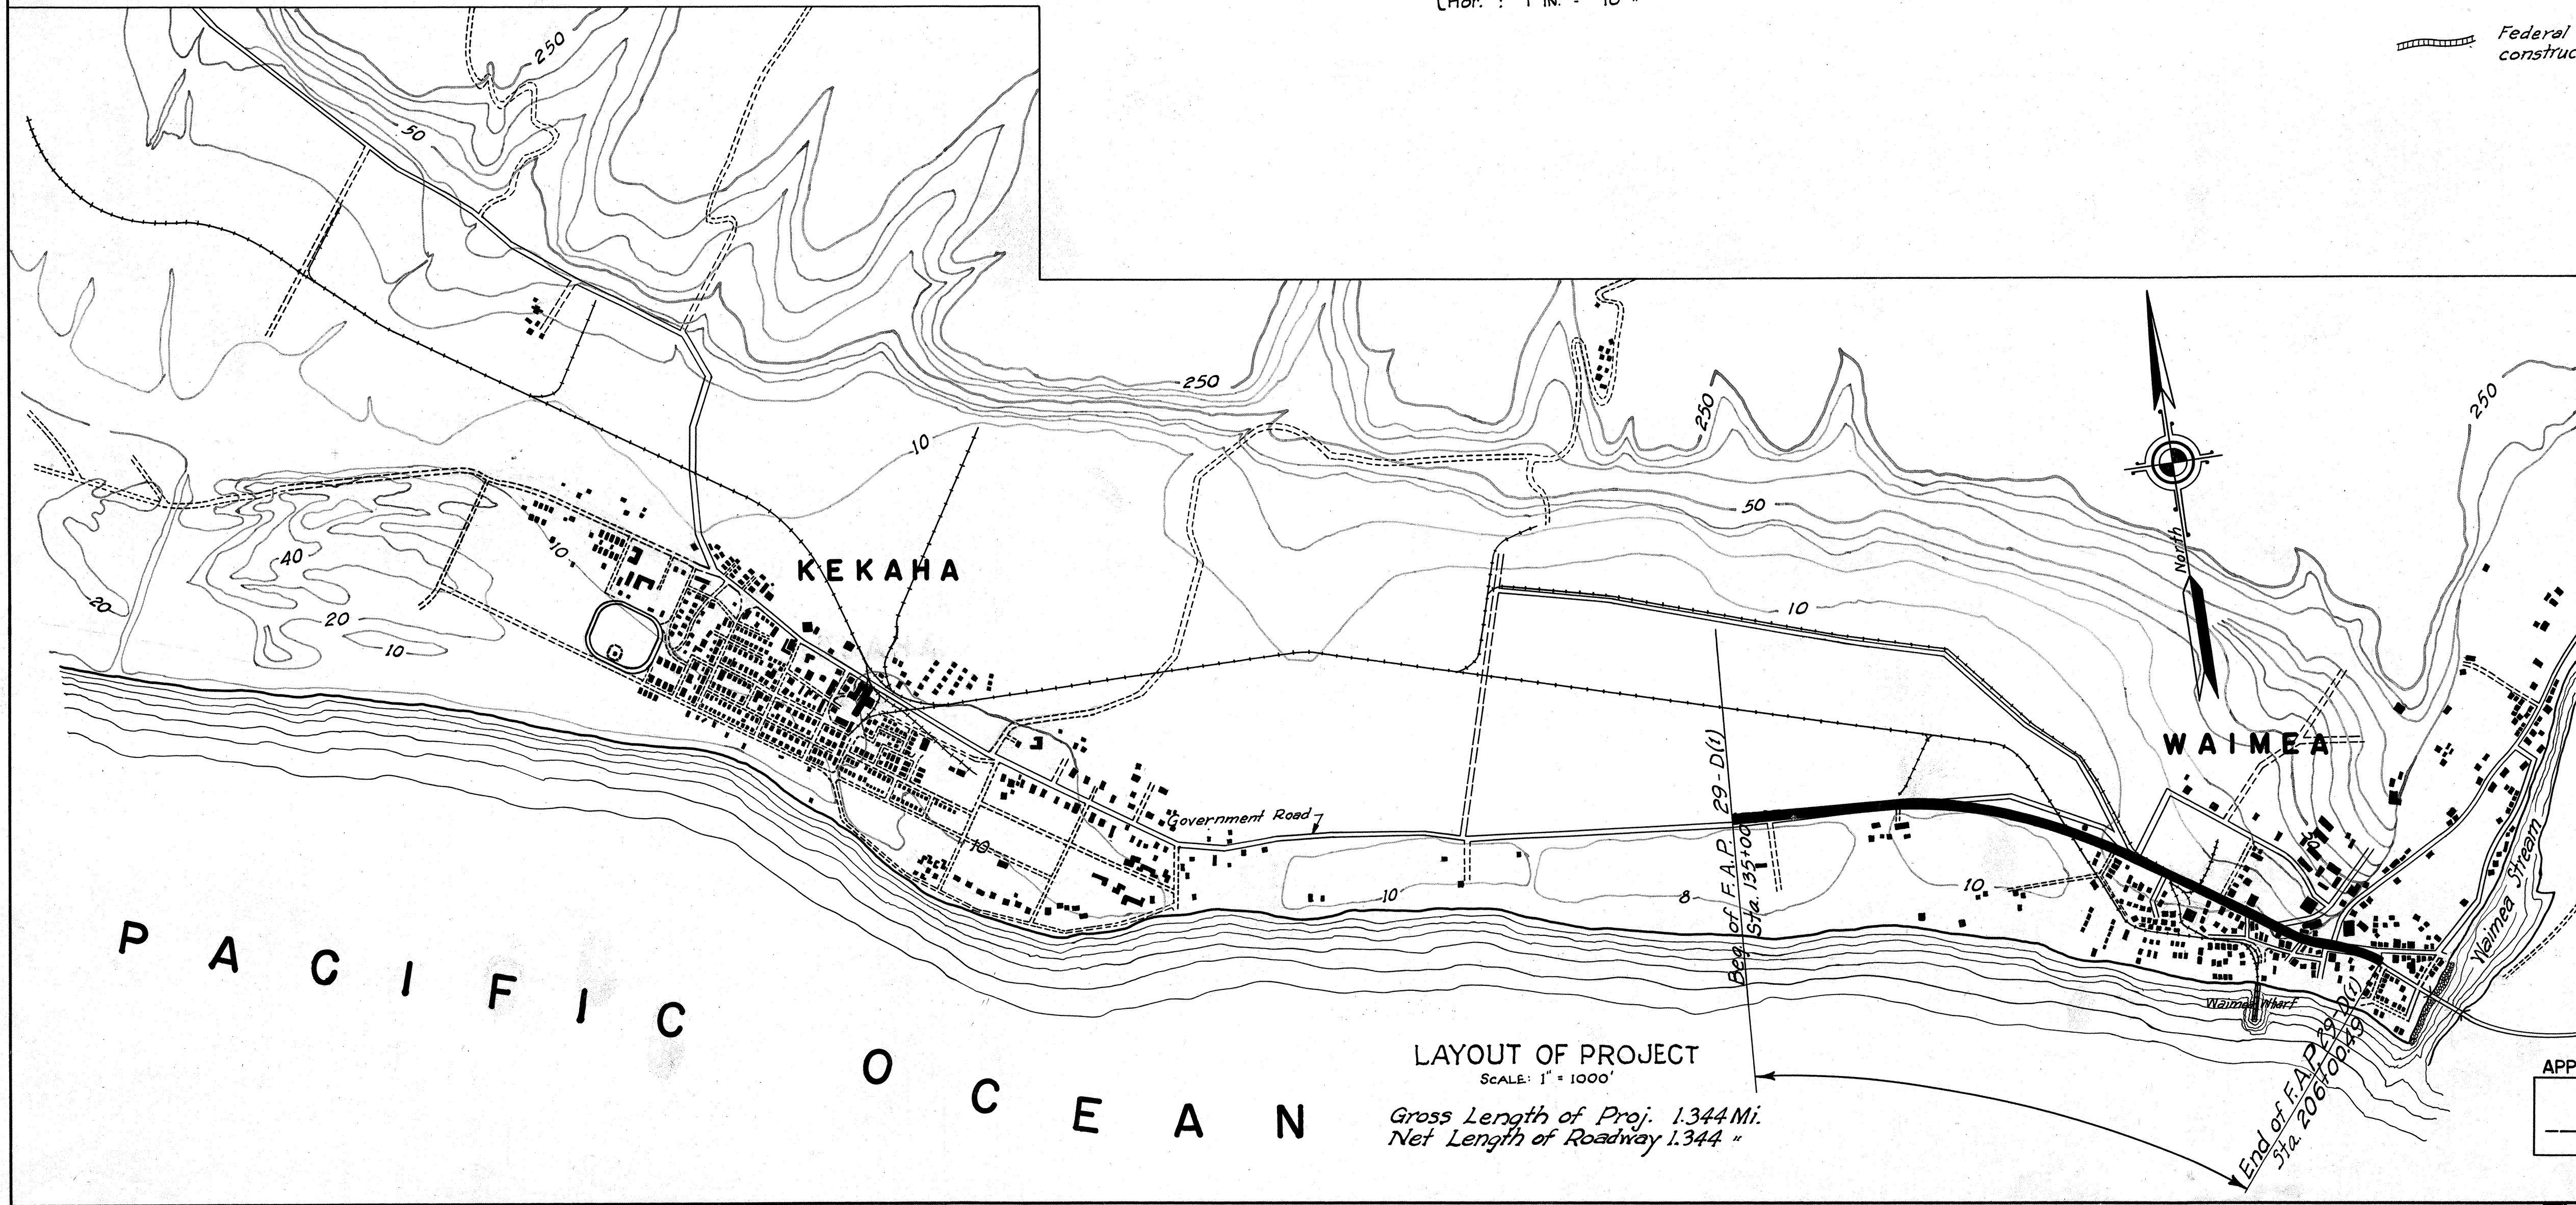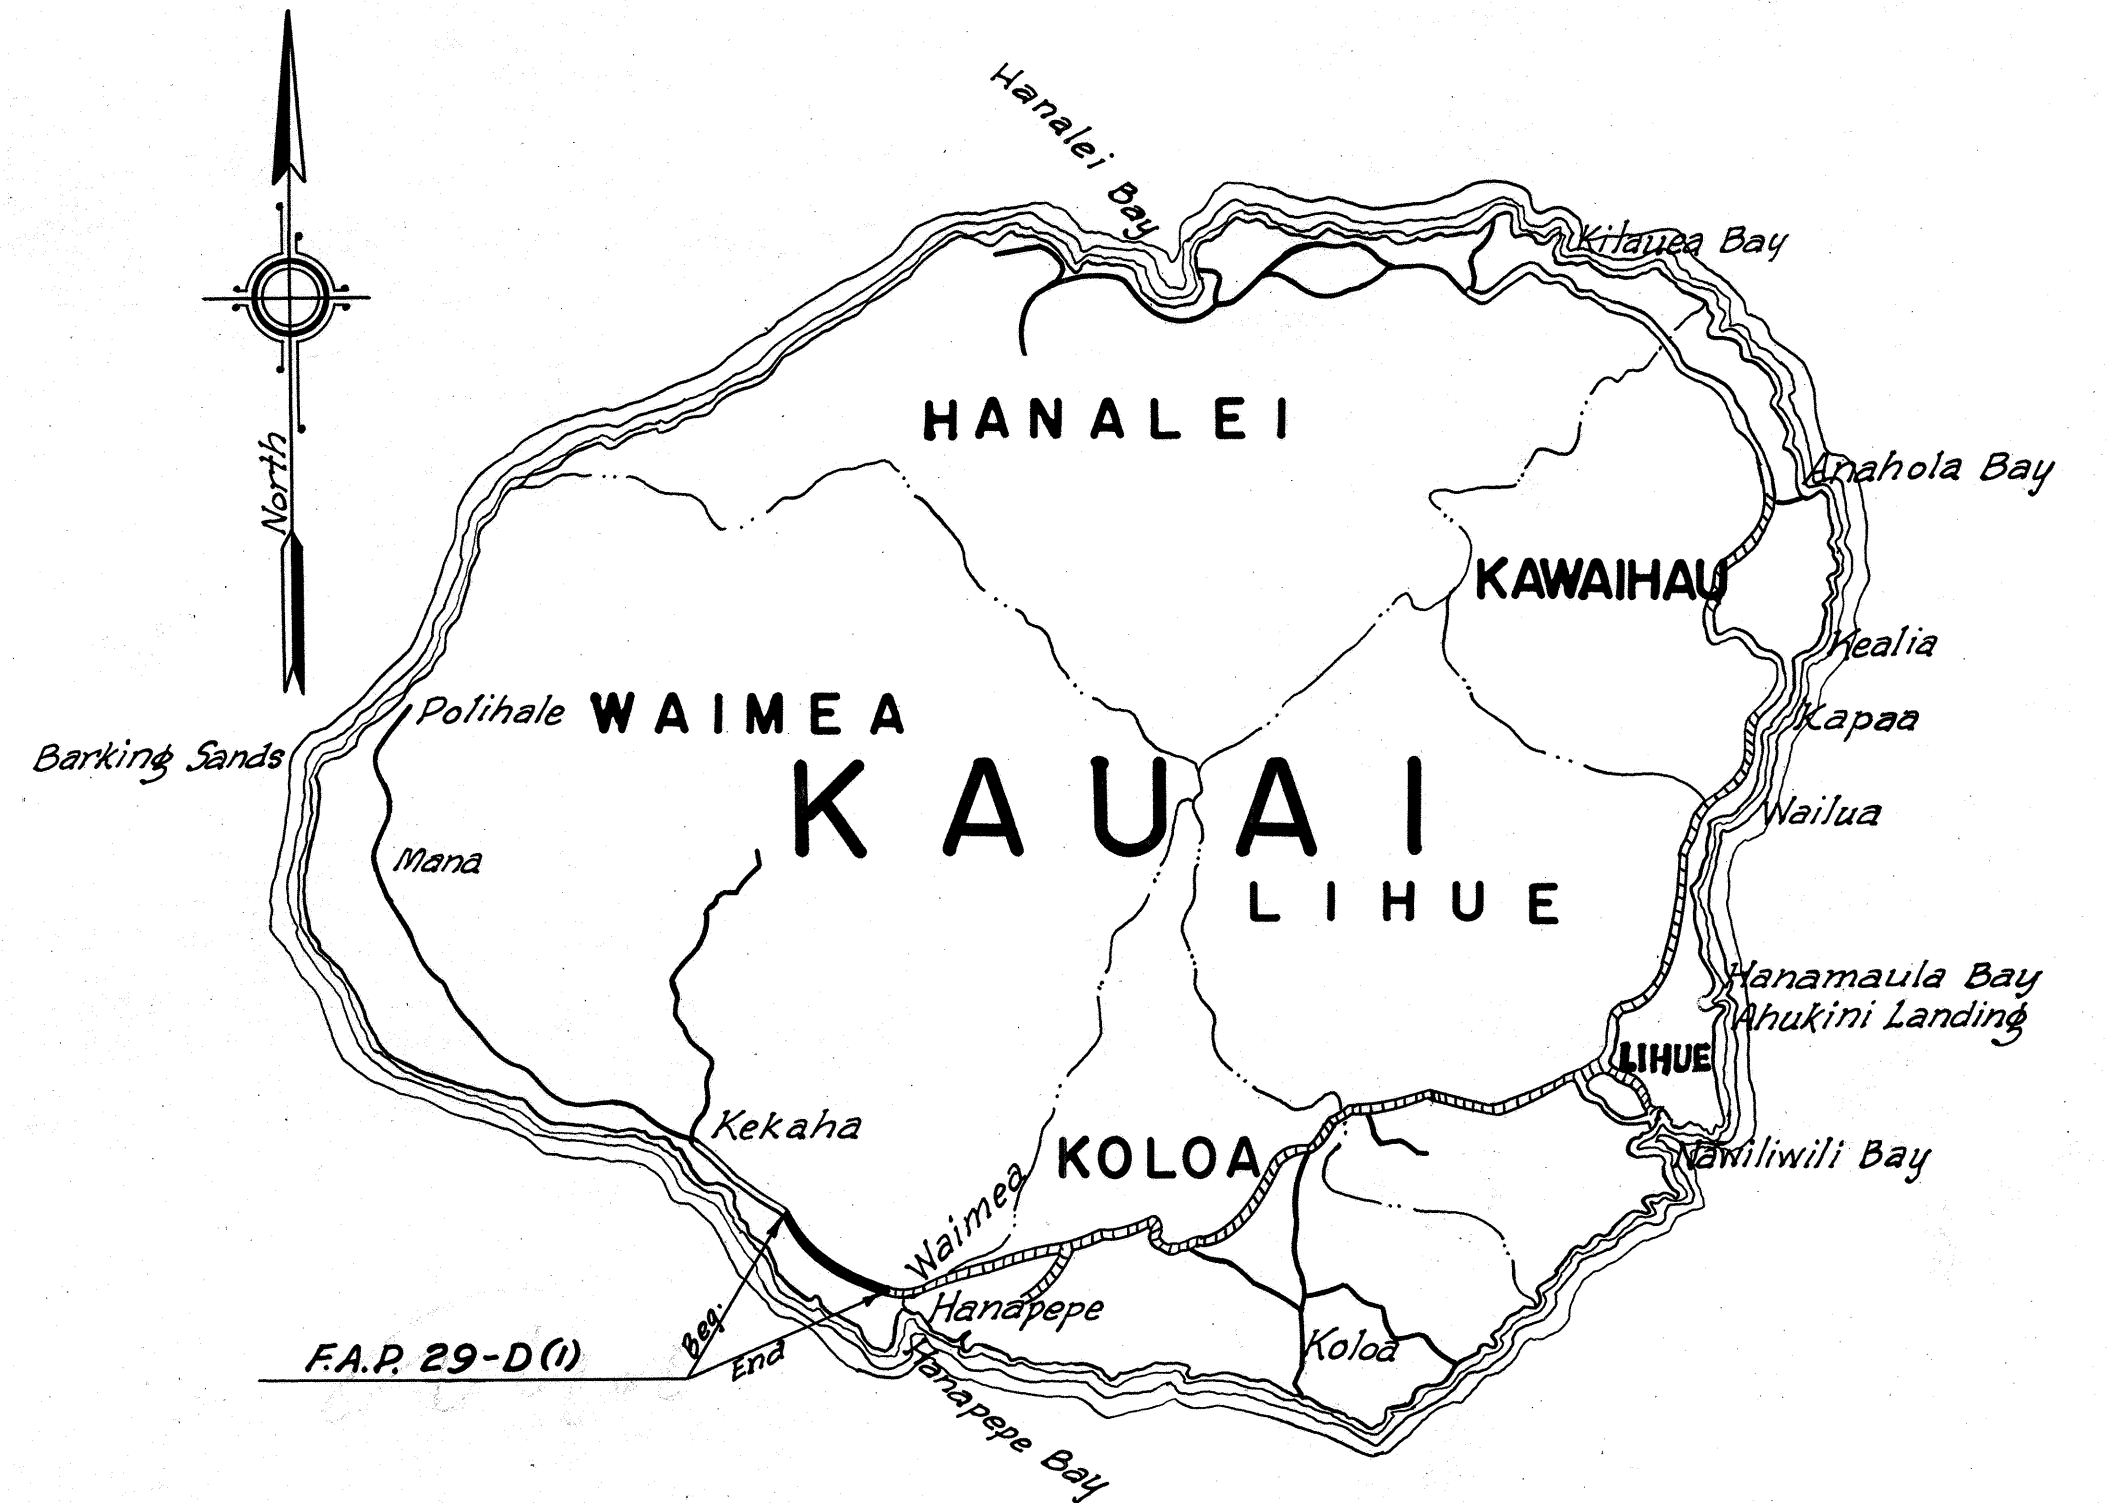

RECOMMENDED FOR APPROVAL

DISTRICT ENGINEER
PUBLIC ROADS ADMINISTRATION
FEDERAL WORKS AGENCY

RECOMMENDED FOR APPROVAL

CHIEF WESTERN REGION
PUBLIC ROADS ADMINISTRATION
FEDERAL WORKS AGENCY

APPROVED

COMMISSIONER
PUBLIC ROADS ADMINISTRATION
FEDERAL WORKS AGENCY

APPROVED

Louis B. Cain
DATE: May 23, 1940
TERRITORIAL HIGHWAY ENGINEER

5029.1