



DIST. NO.	STATE	PROJ. NO.	FISCAL YEAR	SHEET NO.	TOTAL SHEETS
KAUAI	HAW.	50B-01-14	2020	38	44

NOTES:

- Light Lines Denote Existing Condition
Bold Lines Denote New Work
- Provide New Anchor and Guy Wires (By HTCom).
- See Detail $\frac{1}{E-10}$ for Street Light Pole Detail.
- See Detail $\frac{2}{E-6}$ for Concrete Collar Around Pullboxes.
- See Detail $\frac{2}{E-9}$ for Meter Pedestal Detail.

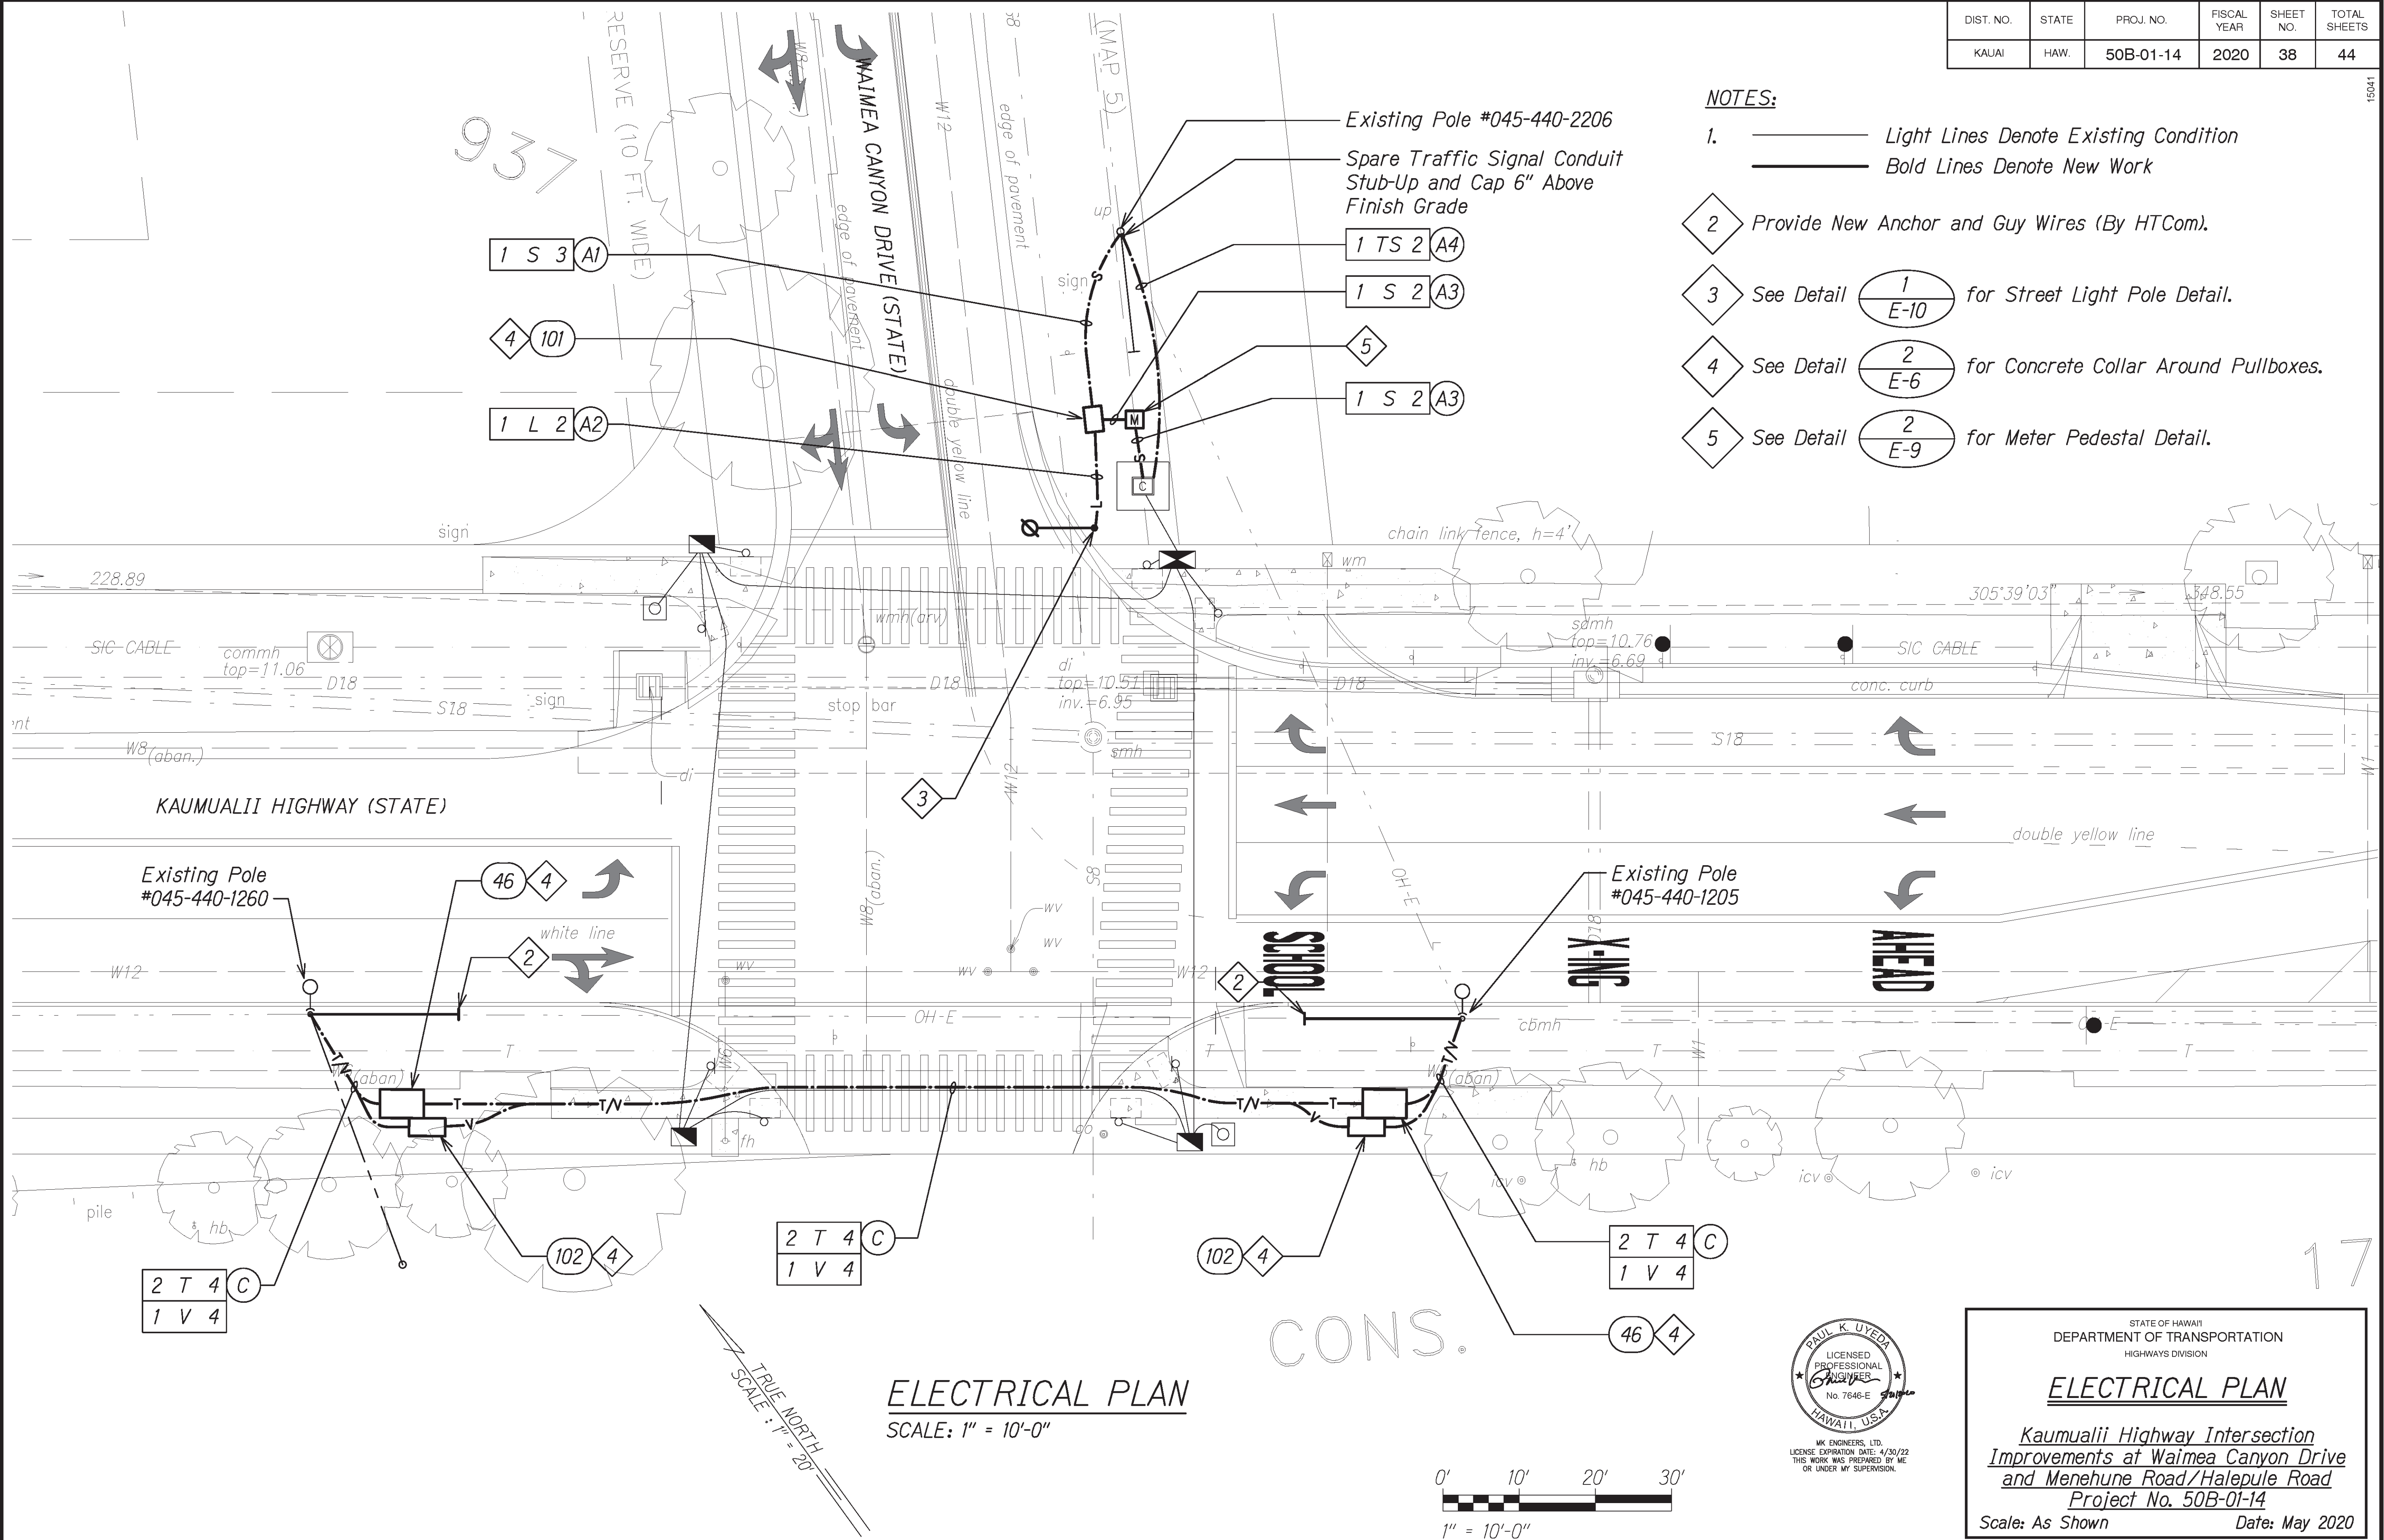

DATE: _____	DESIGNED BY: _____
ORIGINAL PLAN: _____	CHECKED BY: _____
NOTED BY: _____	
NO. _____	

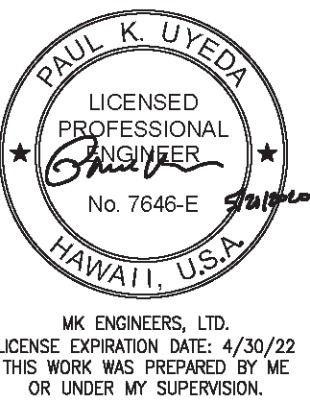

STATE OF HAWAII
DEPARTMENT OF TRANSPORTATION
HIGHWAYS DIVISION

ELECTRICAL PLAN

*Kaumualii Highway Intersection
Improvements at Waimea Canyon Drive
and Menhune Road/Halepule Road
Project No. 50B-01-14*

Scale: As Shown Date: May 2020

SHEET No. E-5 OF 11 SHEETS