

INDEX TO DRAWINGS	
SHEET NO.	DESCRIPTION
1	TITLE SHEET
2	STANDARD PLANS SUMMARY
3	GENERAL NOTES
4	NOTES AND LEGEND
5	TYPICAL SECTION AND DETAILS
6	ROADWAY PLAN Kaumualii Highway ½ Sta. 3+50 to Sta. 6+00
7-10	MISCELLANEOUS DETAILS
11	PAVEMENT MARKING NOTES AND LEGEND
12	PAVEMENT MARKING PLAN Kaumualii Highway ½ Sta. 2+30 to Sta. 8+10
13	STREET NAME SIGN AND CROSSWALK DETAILS
14	MAST ARM SIGN MOUNTING DETAIL
15	DESTINATION SIGN DETAILS
16	TRAFFIC SIGNAL NOTES AND LEGEND
17-18	TRAFFIC SIGNAL PLAN Kaumualii Highway ½ Sta. 2+30 to 8+10
19-20	TRAFFIC SIGNAL PLAN Kaumualii Highway ½ Sta. 94+00 to Sta. 99+00
21-27	TRAFFIC SIGNAL DETAILS
28	ELECTRICAL SITE PLAN

STATE OF HAWAII

DEPARTMENT OF TRANSPORTATION
HIGHWAYS DIVISION
HONOLULU, HAWAII

PLANS FOR

KAUMUALII HIGHWAY





TRAFFIC SIGNAL MODERNIZATION

AT VARIOUS LOCATIONS

FEDERAL-AID PROJECT NO. STP-050-1(20)

DISTRICTS OF KOLOA AND LIHUE
ISLAND OF KAUAI

FED. ROAD DIST. NO.	STATE	FED. AID PROJ. NO.	FISCAL YEAR	SHEET NO.	TOTAL SHEETS
HAWAII	HAW.	STP-050-1(20)	2000	1	28

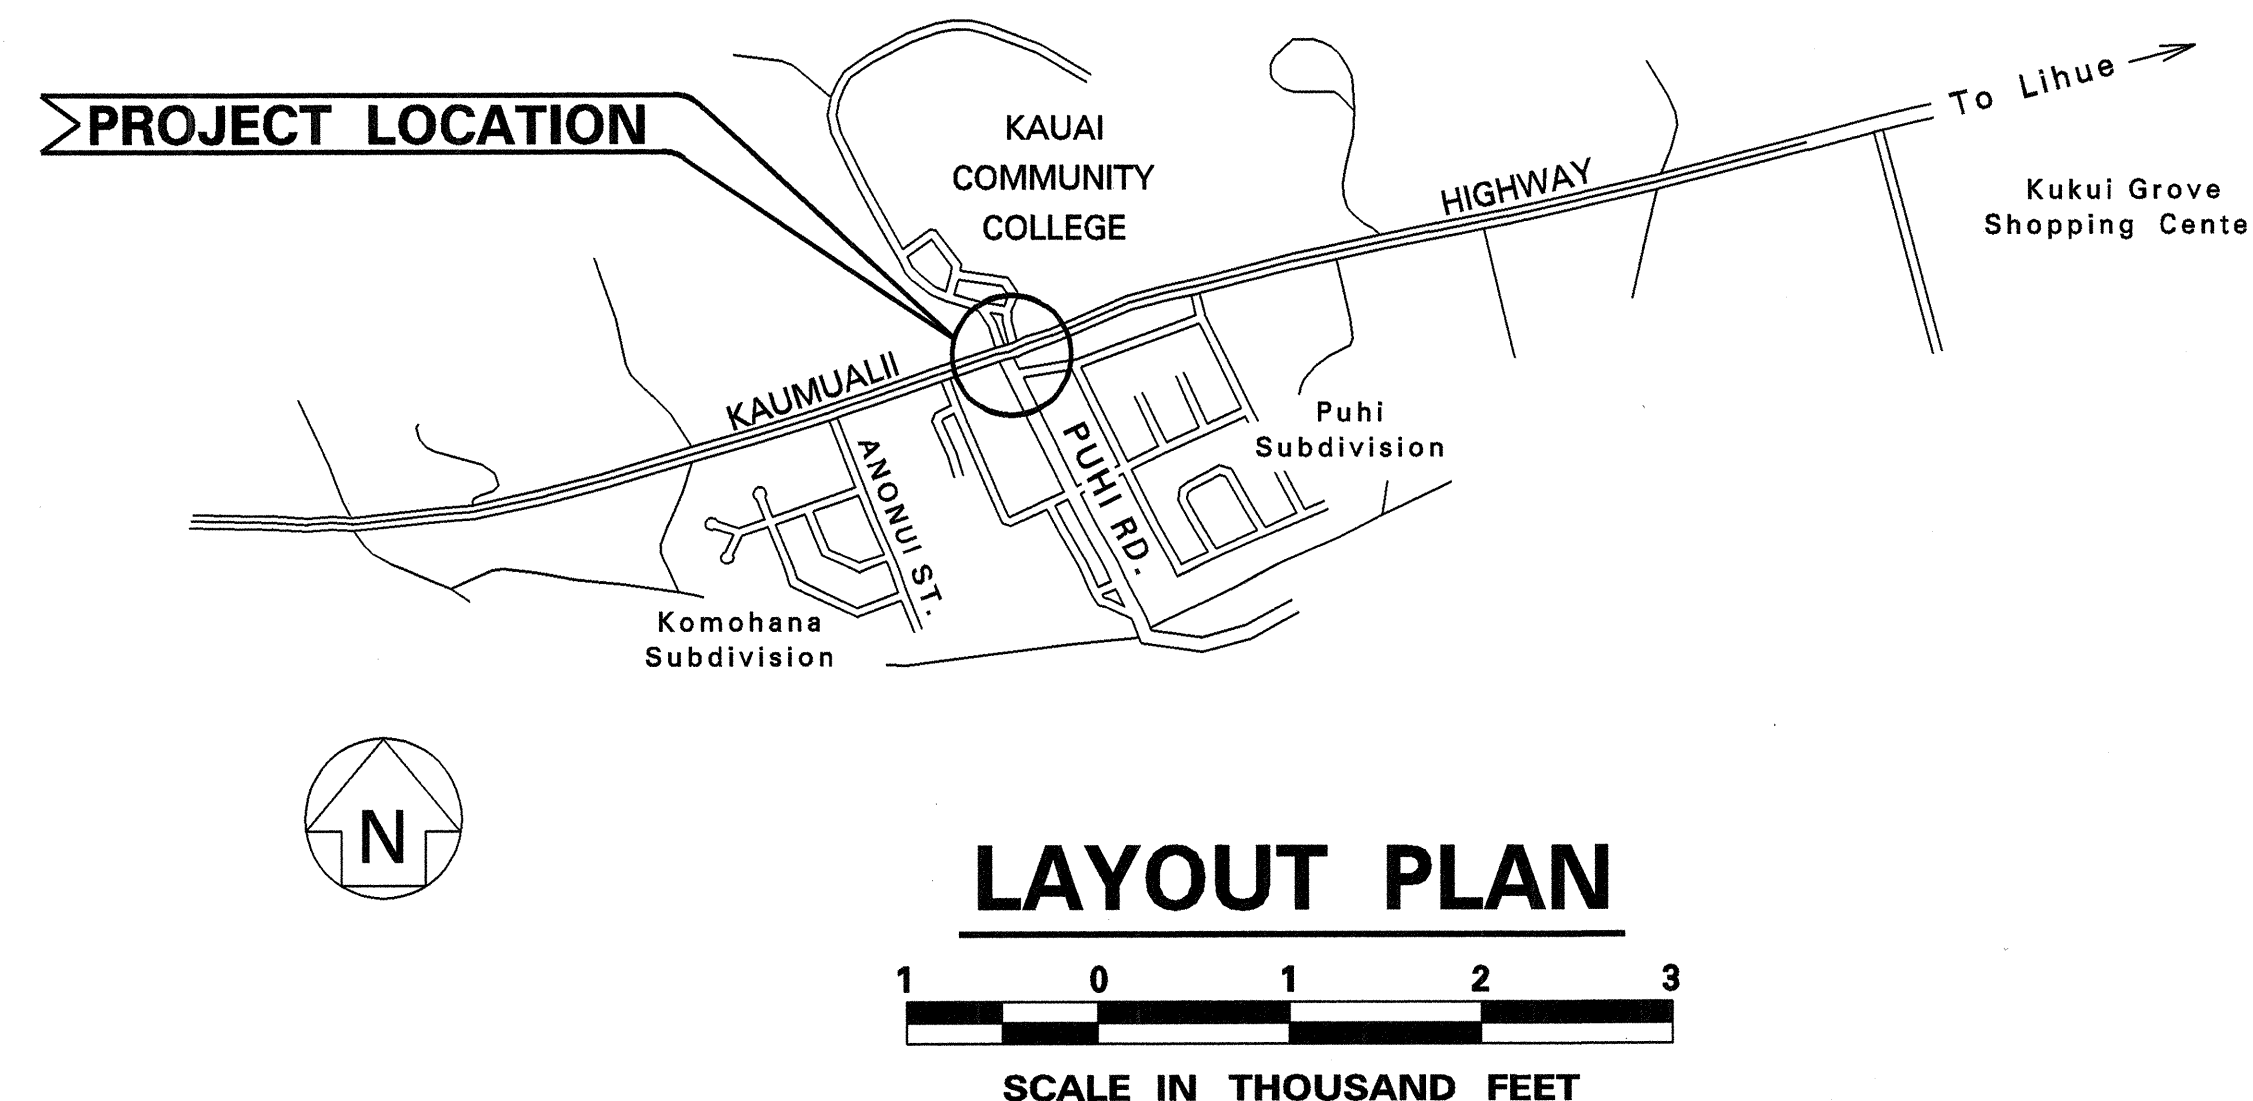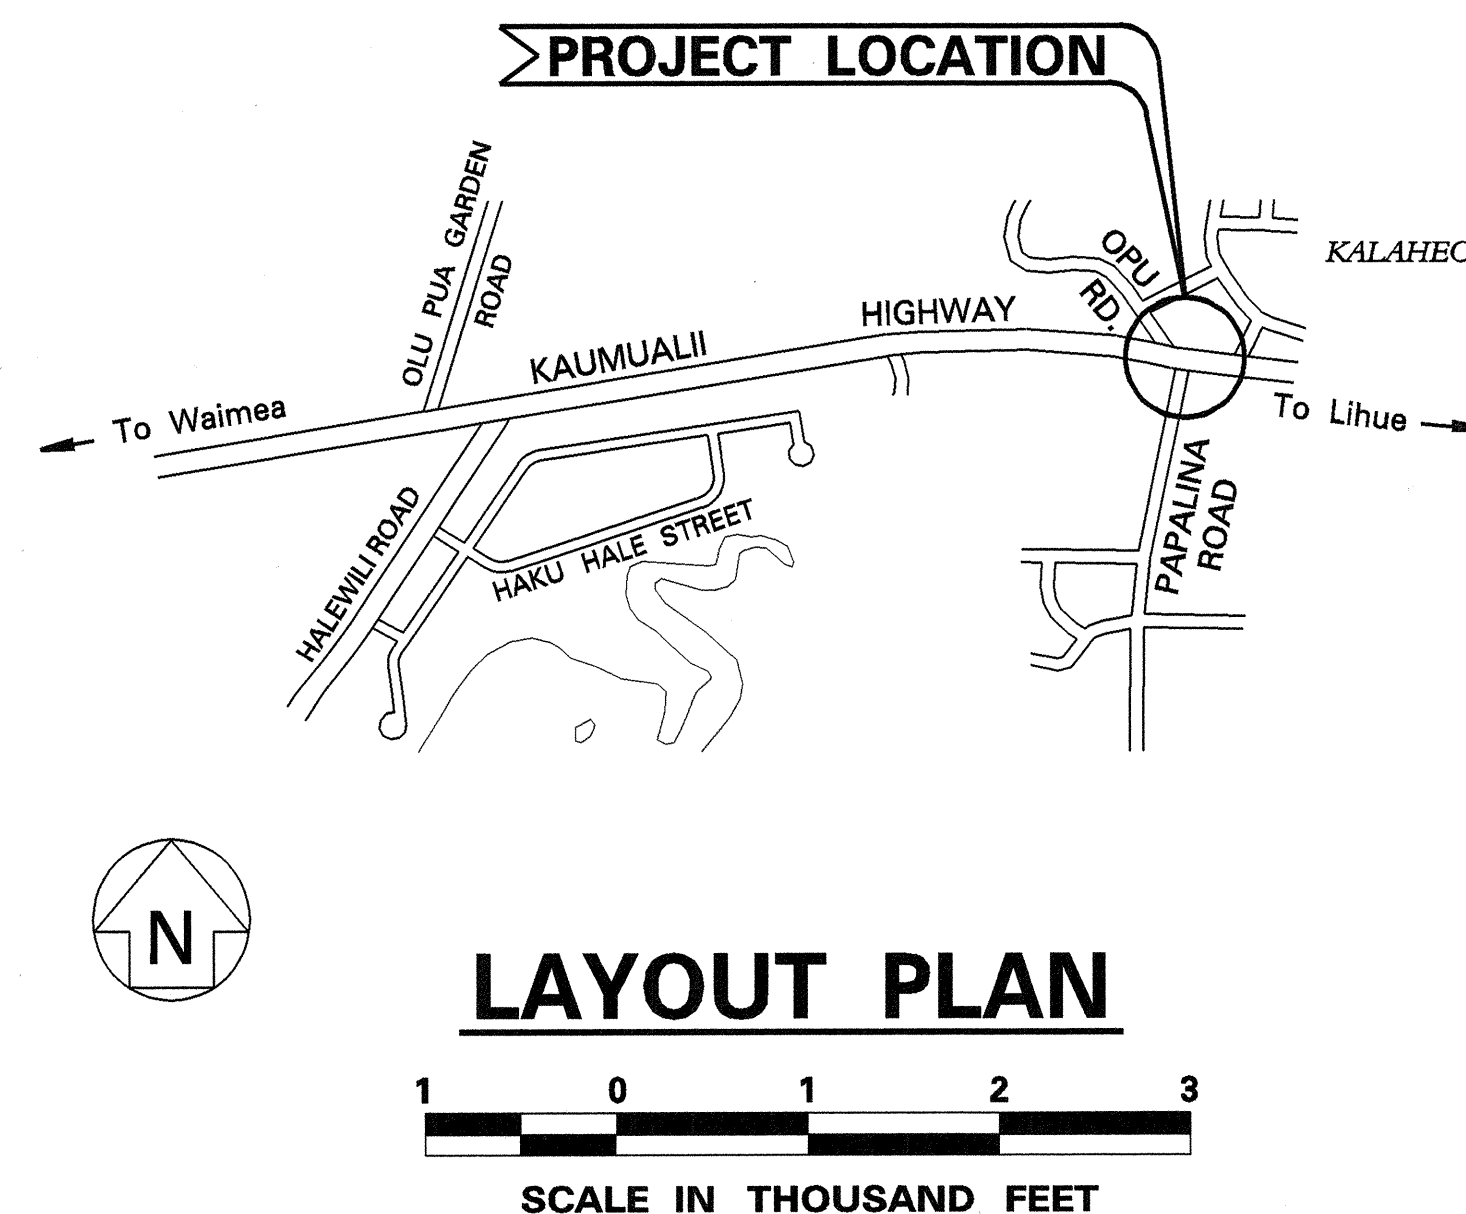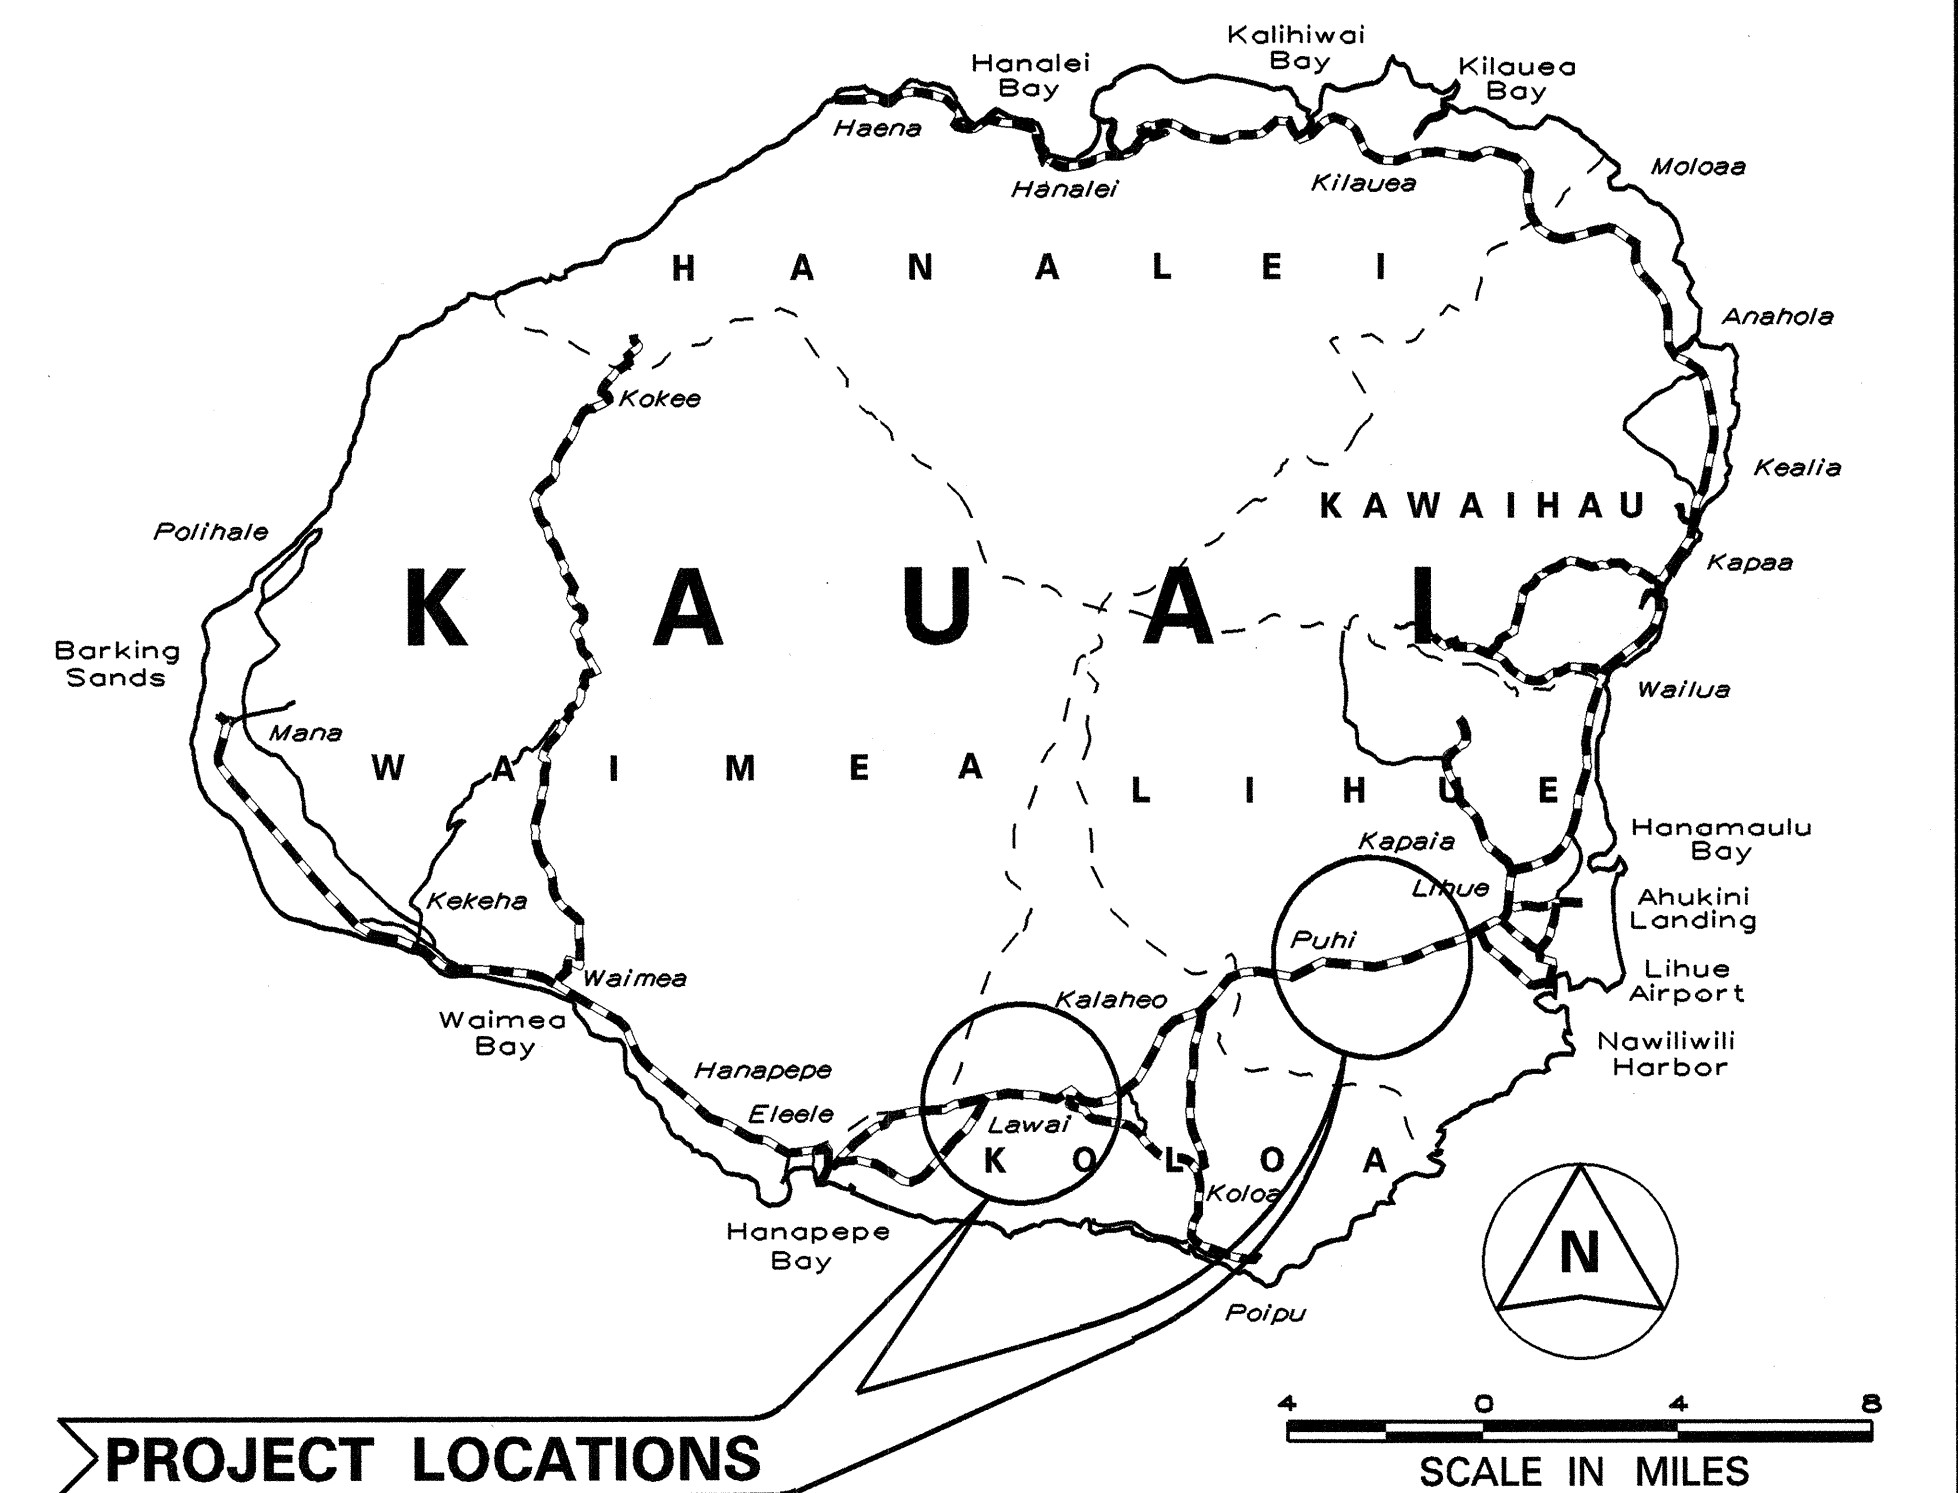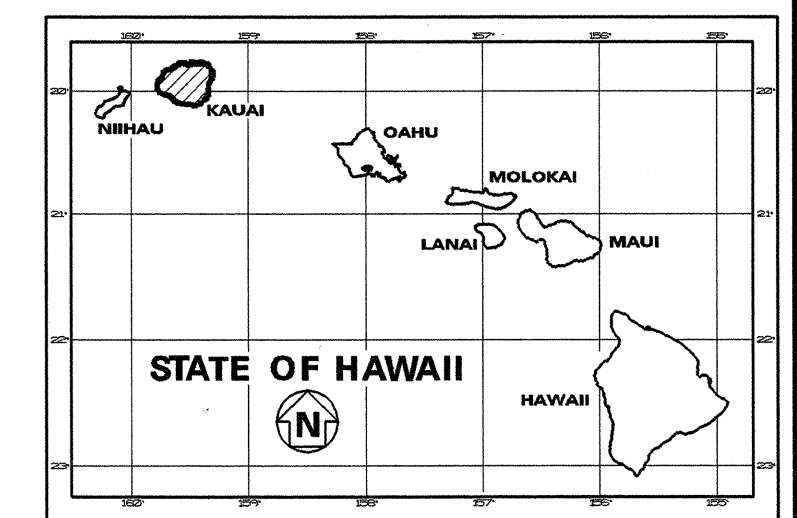

----- FEDERAL AID PROJECTS PREVIOUSLY CONSTRUCTED OR UNDER CONSTRUCTION

KAUMUALII HWY/PAPALINA/OPU RD.
MILE POST 11.73 TO MILE POST 11.83

KAUMUALII HWY/PUHI RD./KAUAI COMMUNITY COLLEGE
MILE POST 1.75 TO MILE POST 1.80

DEPARTMENT OF TRANSPORTATION STATE OF HAWAII	
APPROVED: <i>Kay L. Laysan</i>	5/8/00
DIR. OF TRANSPORTATION	DATE

DESIGNED BY
Shimabukuro, Endo
& Yoshizaki, Inc.

KARL KUNISHIGE
P. S. & E. BY

692-7679
PHONE

APRIL 2000
DATE