



DIST. NO.	STATE	PROJ. NO.	FISCAL YEAR	SHEET NO.	TOTAL SHEETS
KAUAI	HAW.	50B-01-14R	2021	38	44

NOTES:

- Light Lines Denote Existing Condition
Bold Lines Denote New Work
- Provide New Anchor and Guy Wires (By HTCom).
- See Detail $\frac{1}{E-10}$ for Street Light Pole Detail.
- See Detail $\frac{2}{E-6}$ for Concrete Collar Around Pullboxes.
- See Detail $\frac{2}{E-9}$ for Meter Pedestal Detail.

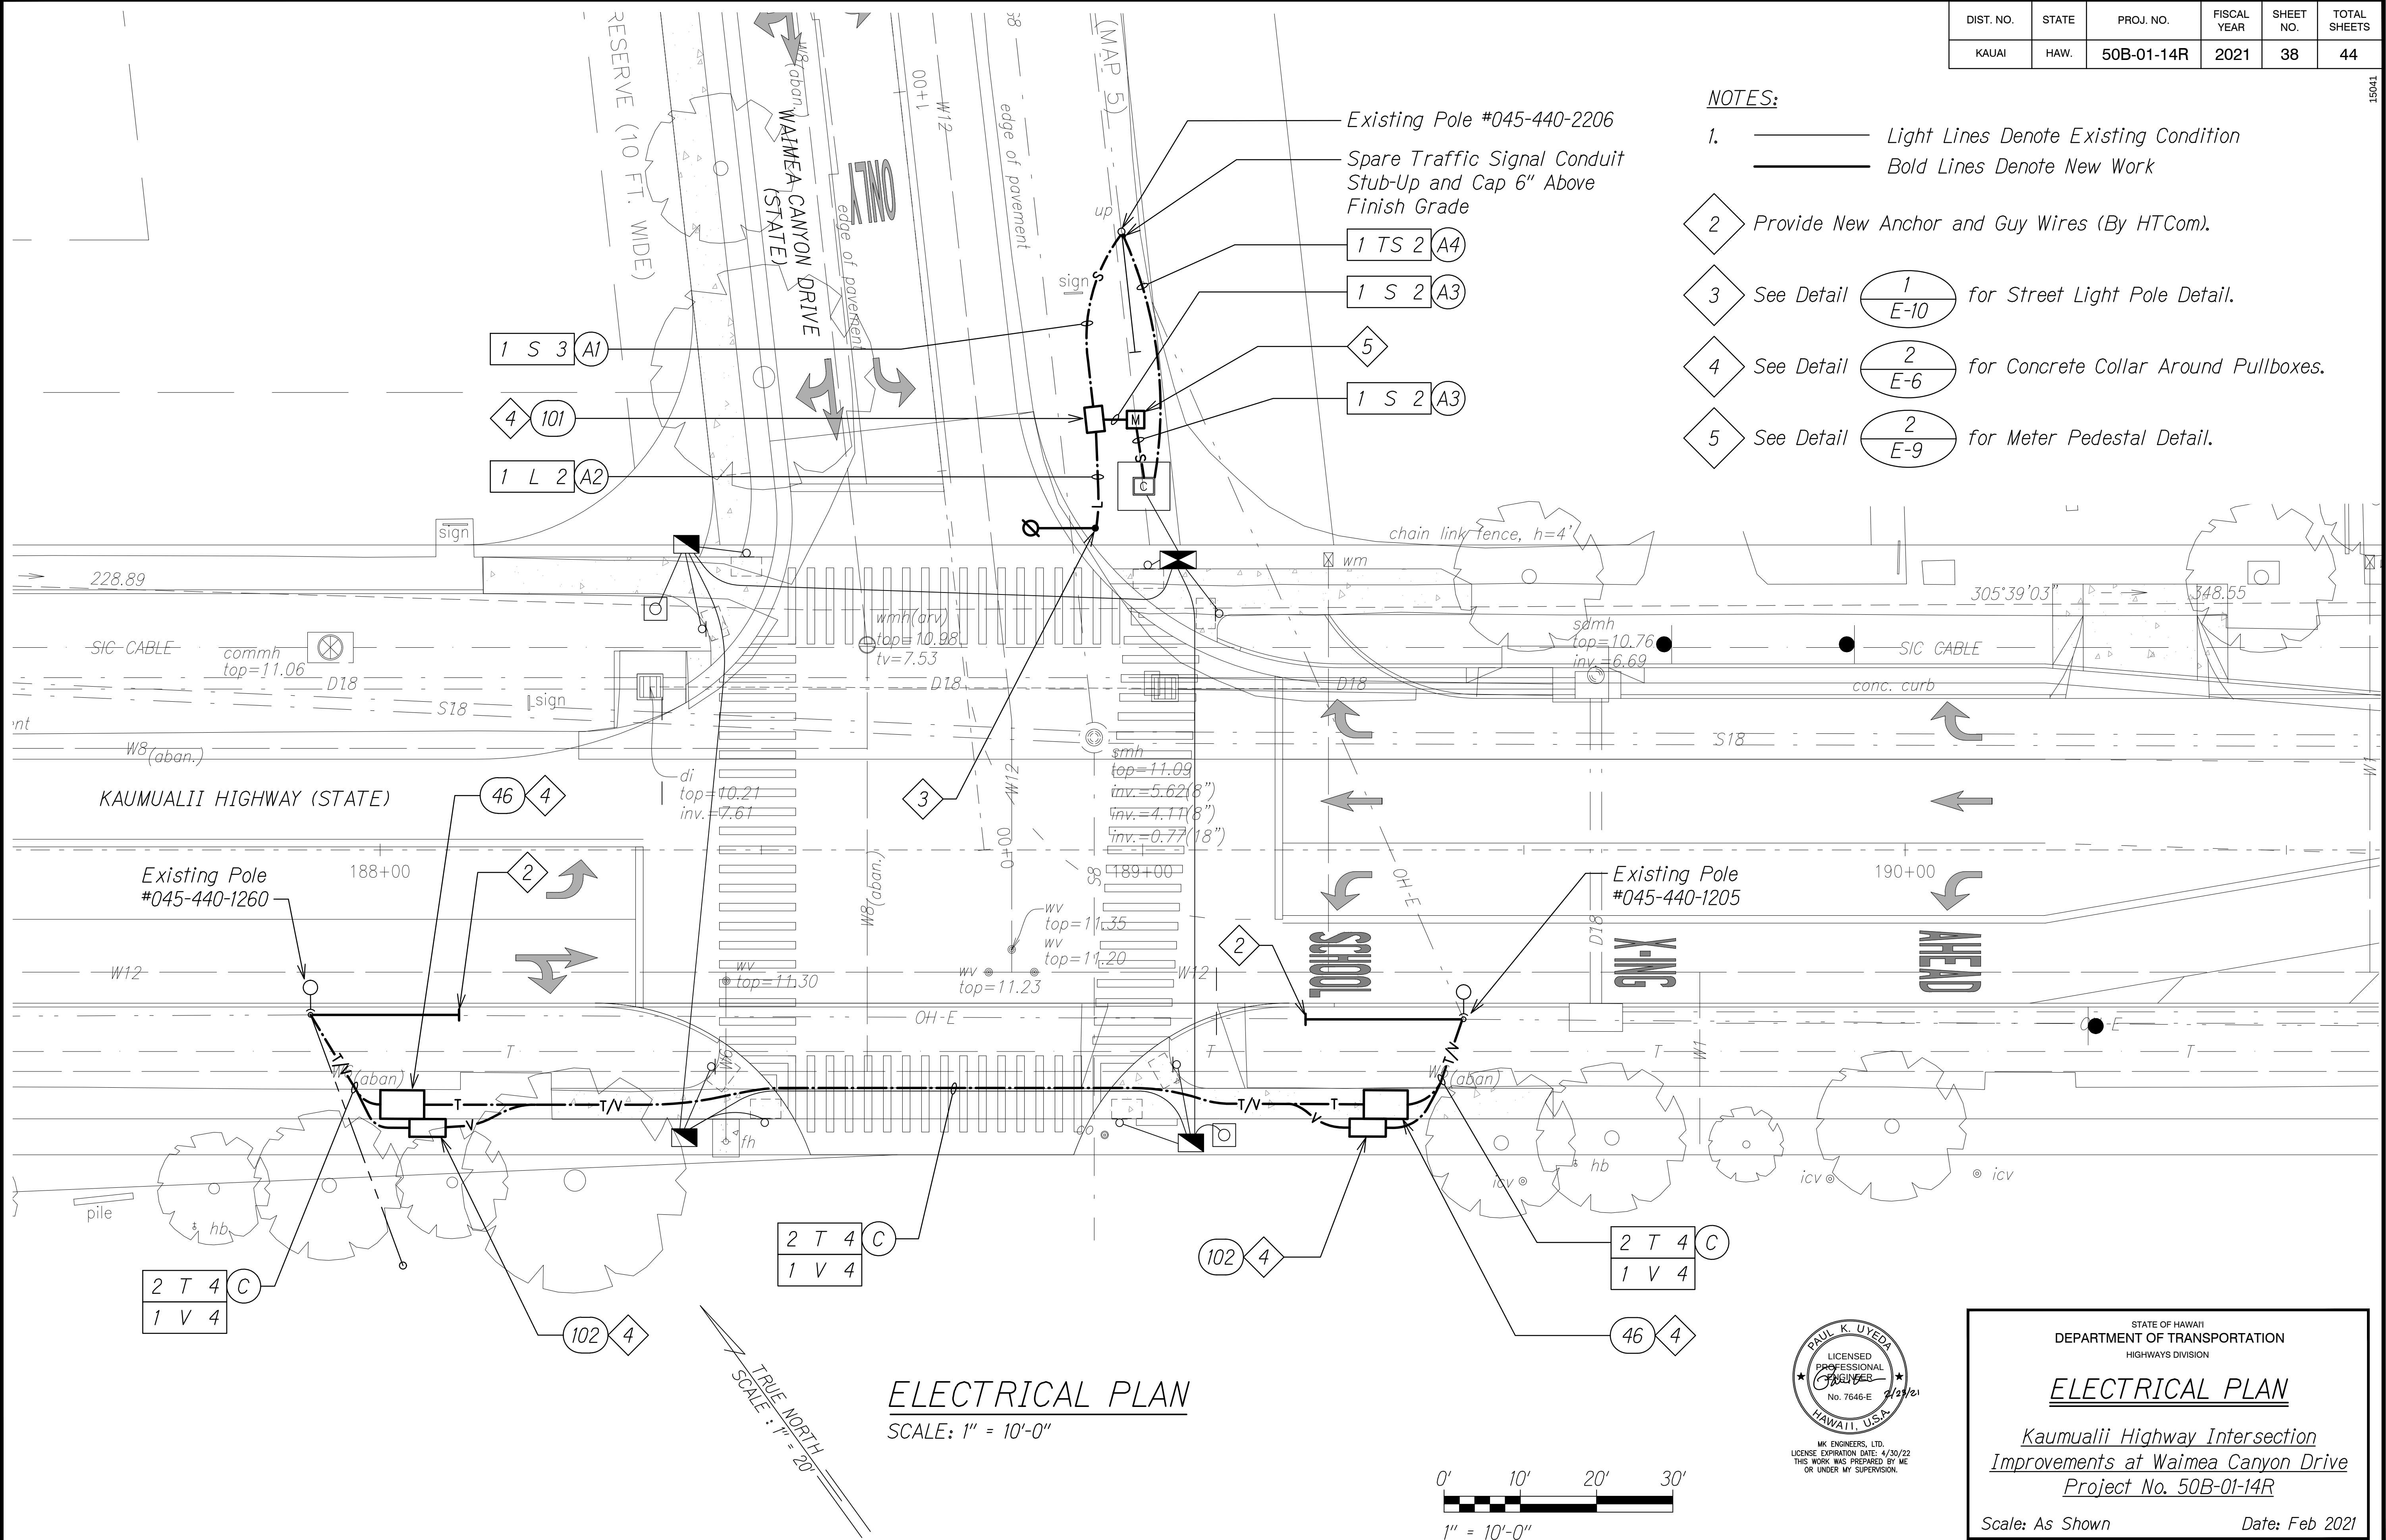

DATE	_____
SURVEY PLOTTED BY	_____
DESIGNED BY	_____
QUANTITIES BY	_____
CHECKED BY	_____
ORIGINAL PLAN	_____
NOTE BOOK	_____
No.	_____

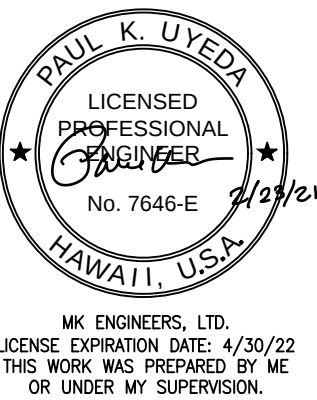

STATE OF HAWAII
DEPARTMENT OF TRANSPORTATION
HIGHWAYS DIVISION

ELECTRICAL PLAN

*Kaumualii Highway Intersection
Improvements at Waimea Canyon Drive
Project No. 50B-01-14R*

Scale: As Shown Date: Feb 2021

SHEET No. E-5 OF 11 SHEETS