



FED. ROAD DIST. NO.	STATE	FED. AID PROJ. NO.	FISCAL YEAR	SHEET NO.	TOTAL SHEETS
HAWAII	HAW.	F-051-1(4)	1984	40	65

NORTH →

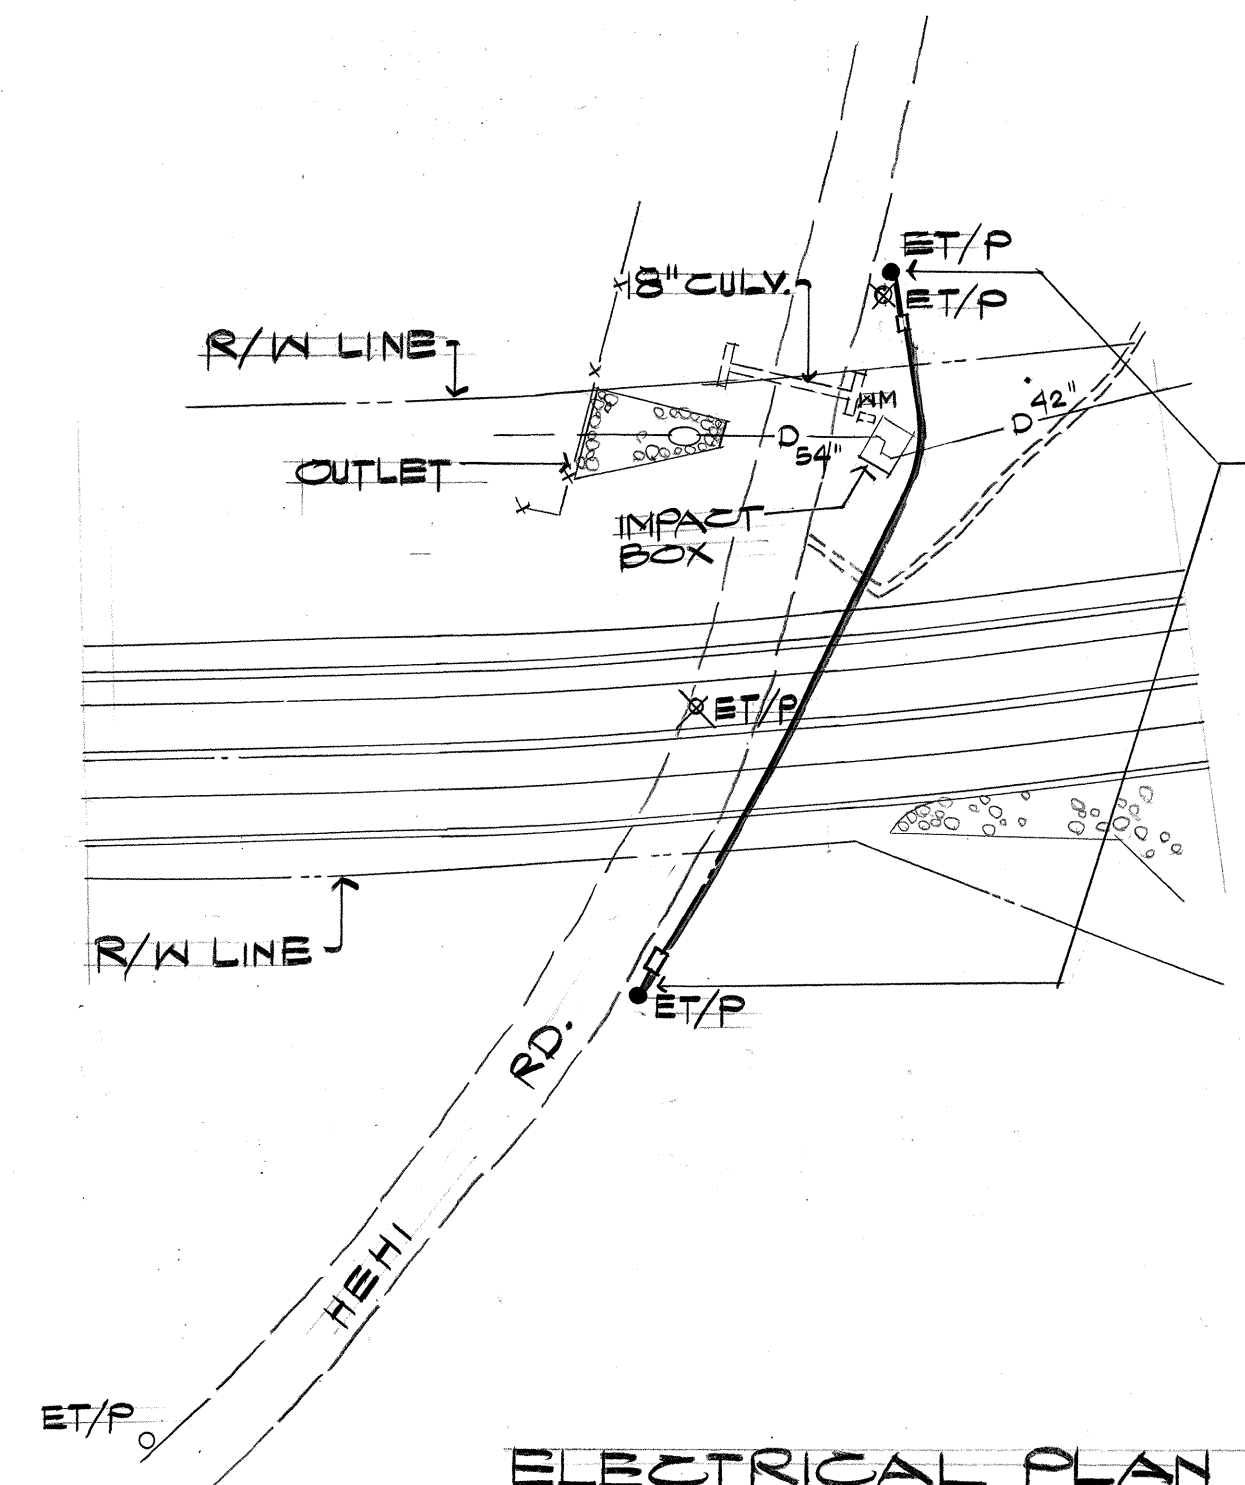


ELECTRICAL PLAN
SCALE: 1" = 50'

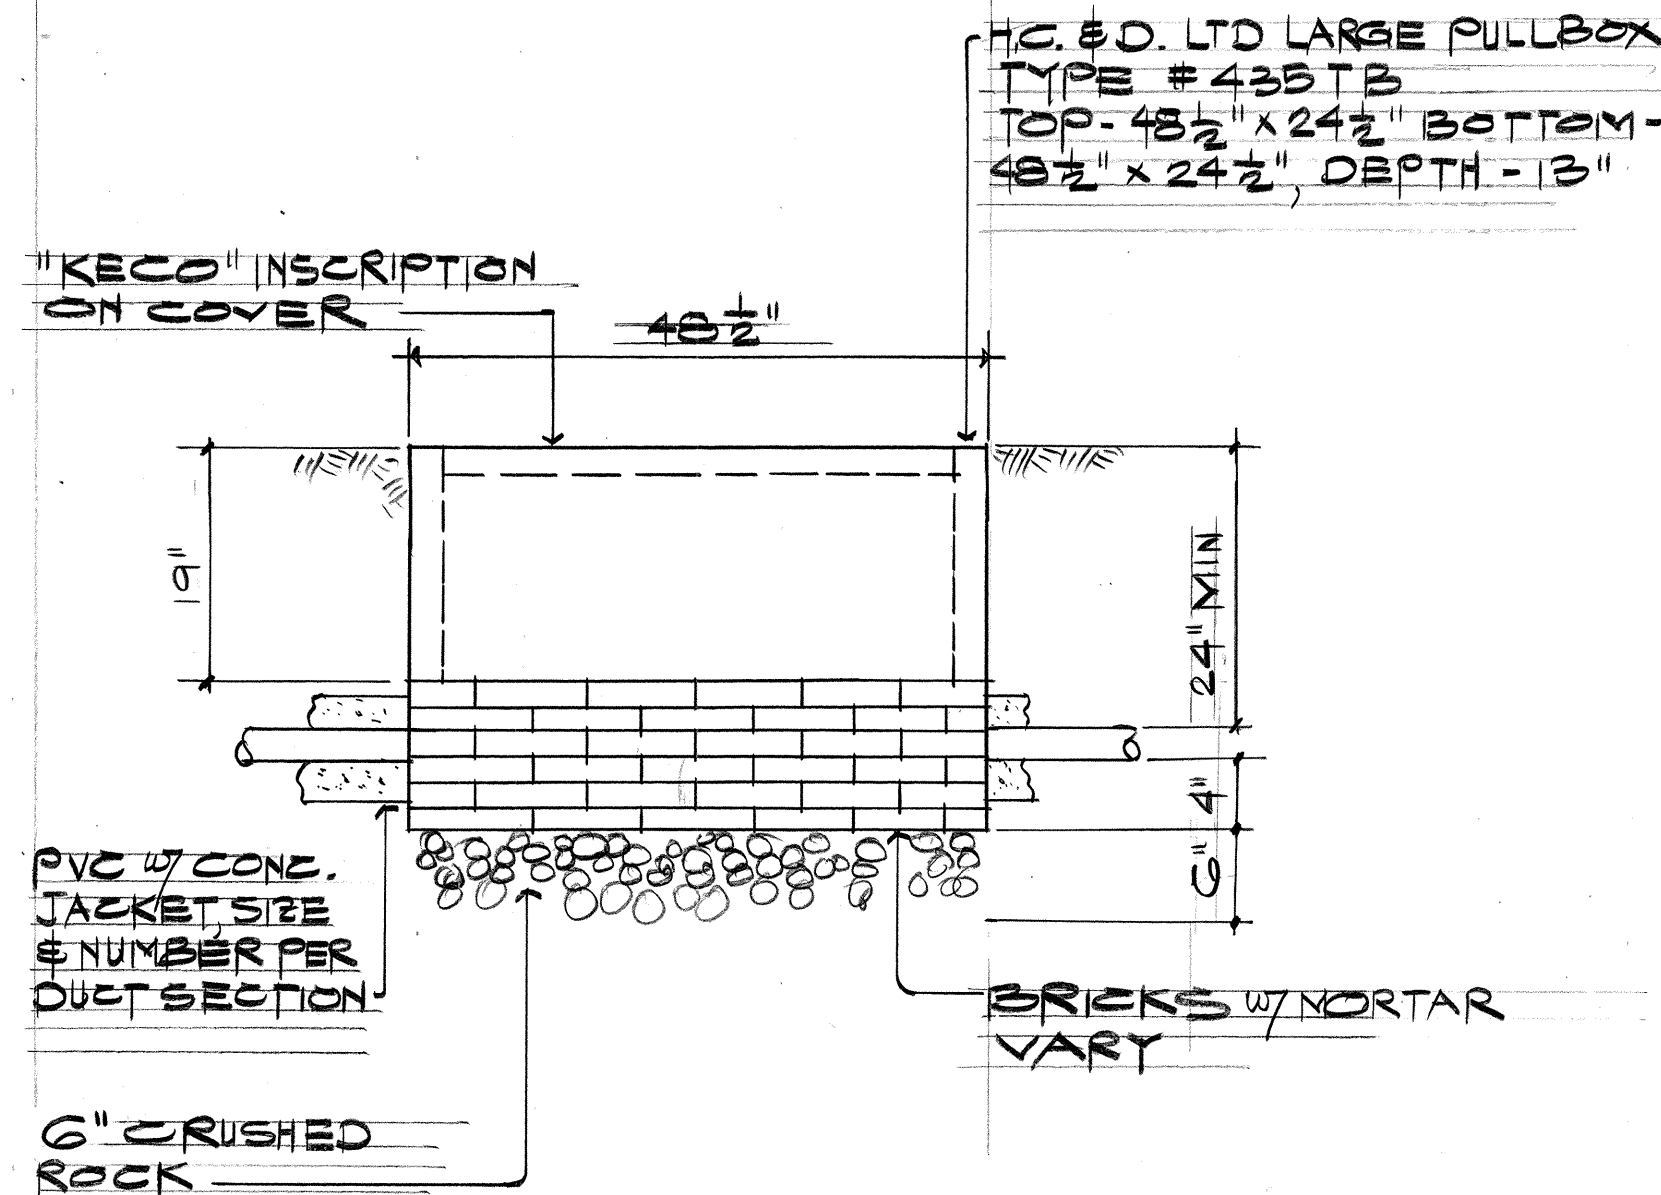

PULL BOX DETAIL
NTS

ELECTRICAL SYMBOLS


- ✗ ET/P EXISTING JOINT POLE TO BE REMOVED BY KAUAI ELECTRIC.
- ET/P EXISTING JOINT POLE TO REMAIN
- ET/P NEW JOINT POLE BY KAUAI ELECTRIC.
- ELECTRIC PULL BOX, 2'x4'
- UNDERGROUND CONDUIT PER DUCT SECTION.
- NM WATER METER

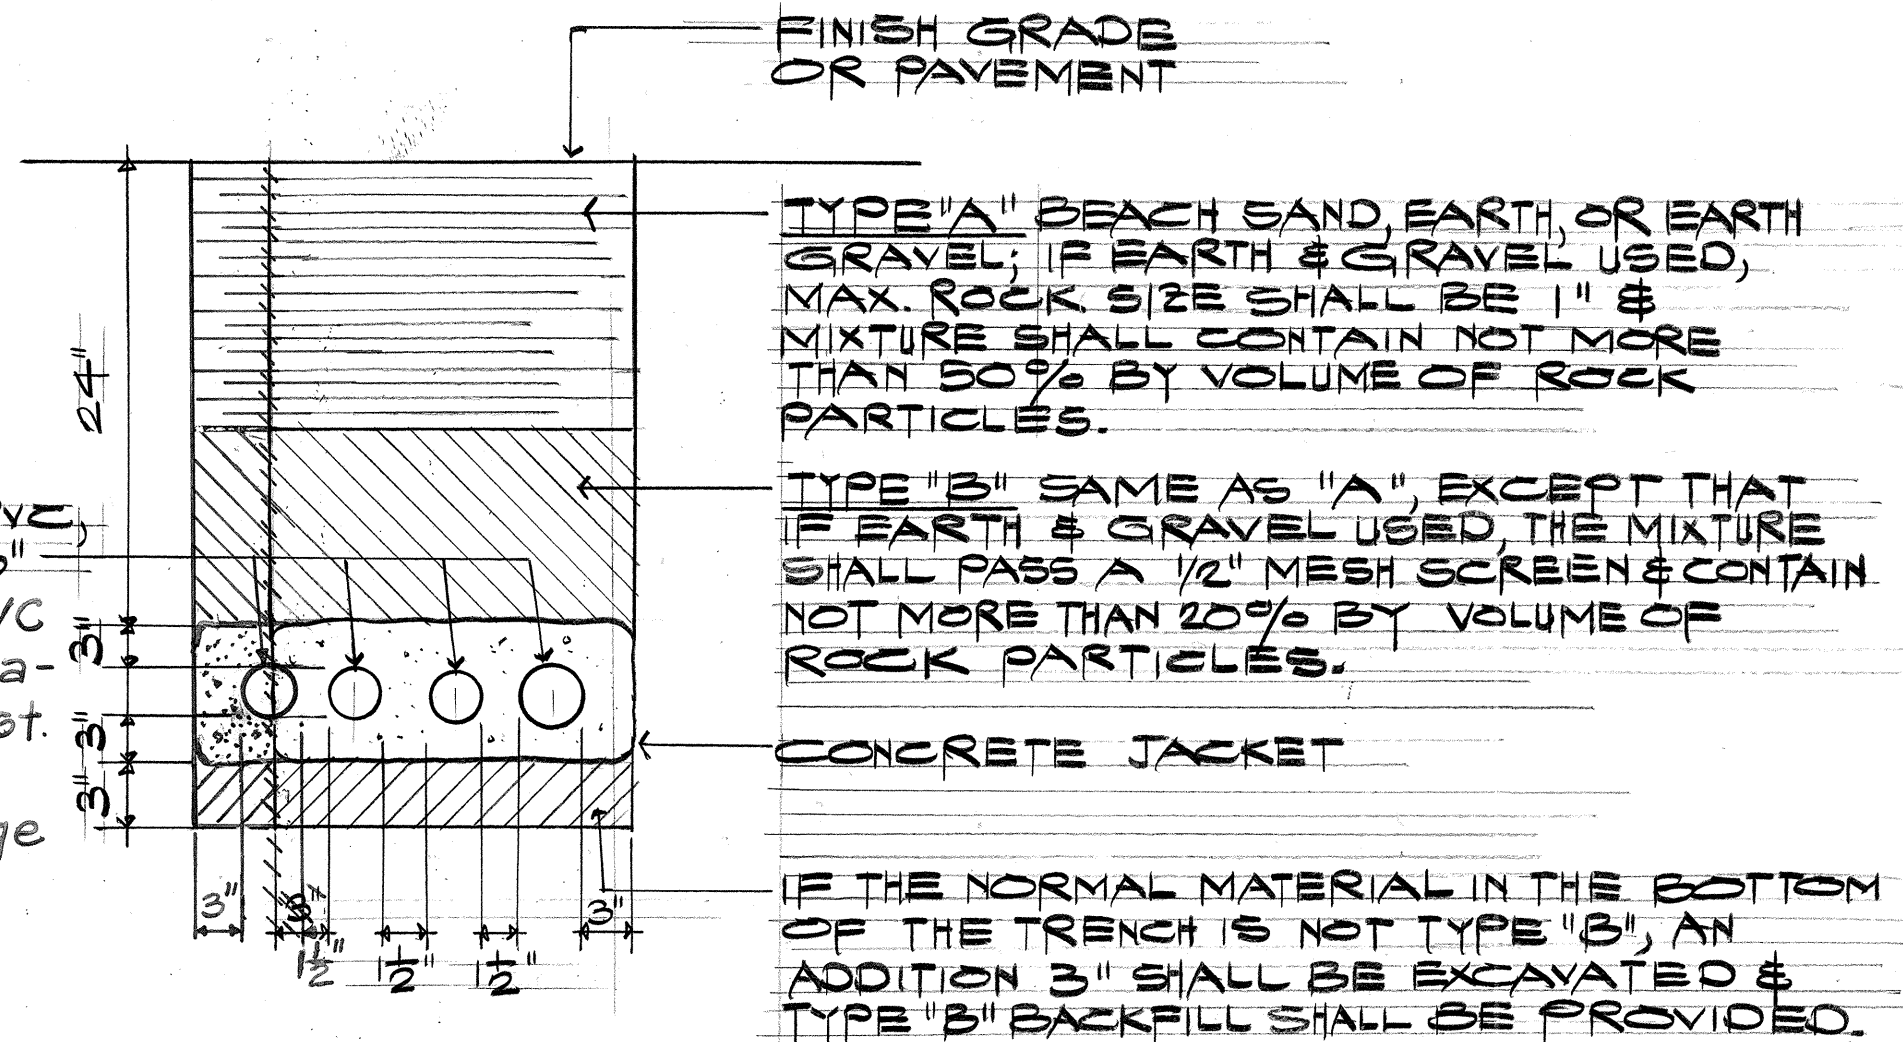

TYP. DUCT SECTION
NTS

ORIGINAL PLAN	DATE
DESIGNED BY	
TRACED BY	
NOTE BOOK	
QUANTITIES BY	
CHECKED BY	

NAKAMURA, KAWABATA & ASSOC., INC.
One Kapiolani Bldg., Suite 403
800 Kapiolani Boulevard
Honolulu, Hawaii 96813

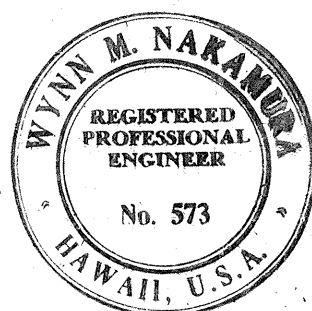

THIS WORK WAS PREPARED BY
AS OR UNDER MY SUPERVISION
Wynn M. Nakamura 5/5/83

STATE OF HAWAII
DEPARTMENT OF TRANSPORTATION
HIGHWAYS DIVISION

ELECTRICAL PLAN, SYMBOLS,
TYP DUCT SECTION & HANDHOLE DET.
HANAMAULU VIADUCT
HANAMAULU-AHUKINI CUTOFF ROAD
(AHUKINI ROAD TO KAUAI HARDWOODS)
FEDERAL AID PROJ. NO. F-051-1(4)
SCALE: AS SHOWN DATE: MAY, 1983