




FED. ROAD DIST. NO.	STATE	FED. AID PROJ. NO.	FISCAL YEAR	SHEET NO.	TOTAL SHEETS
HAWAII	HAW.				

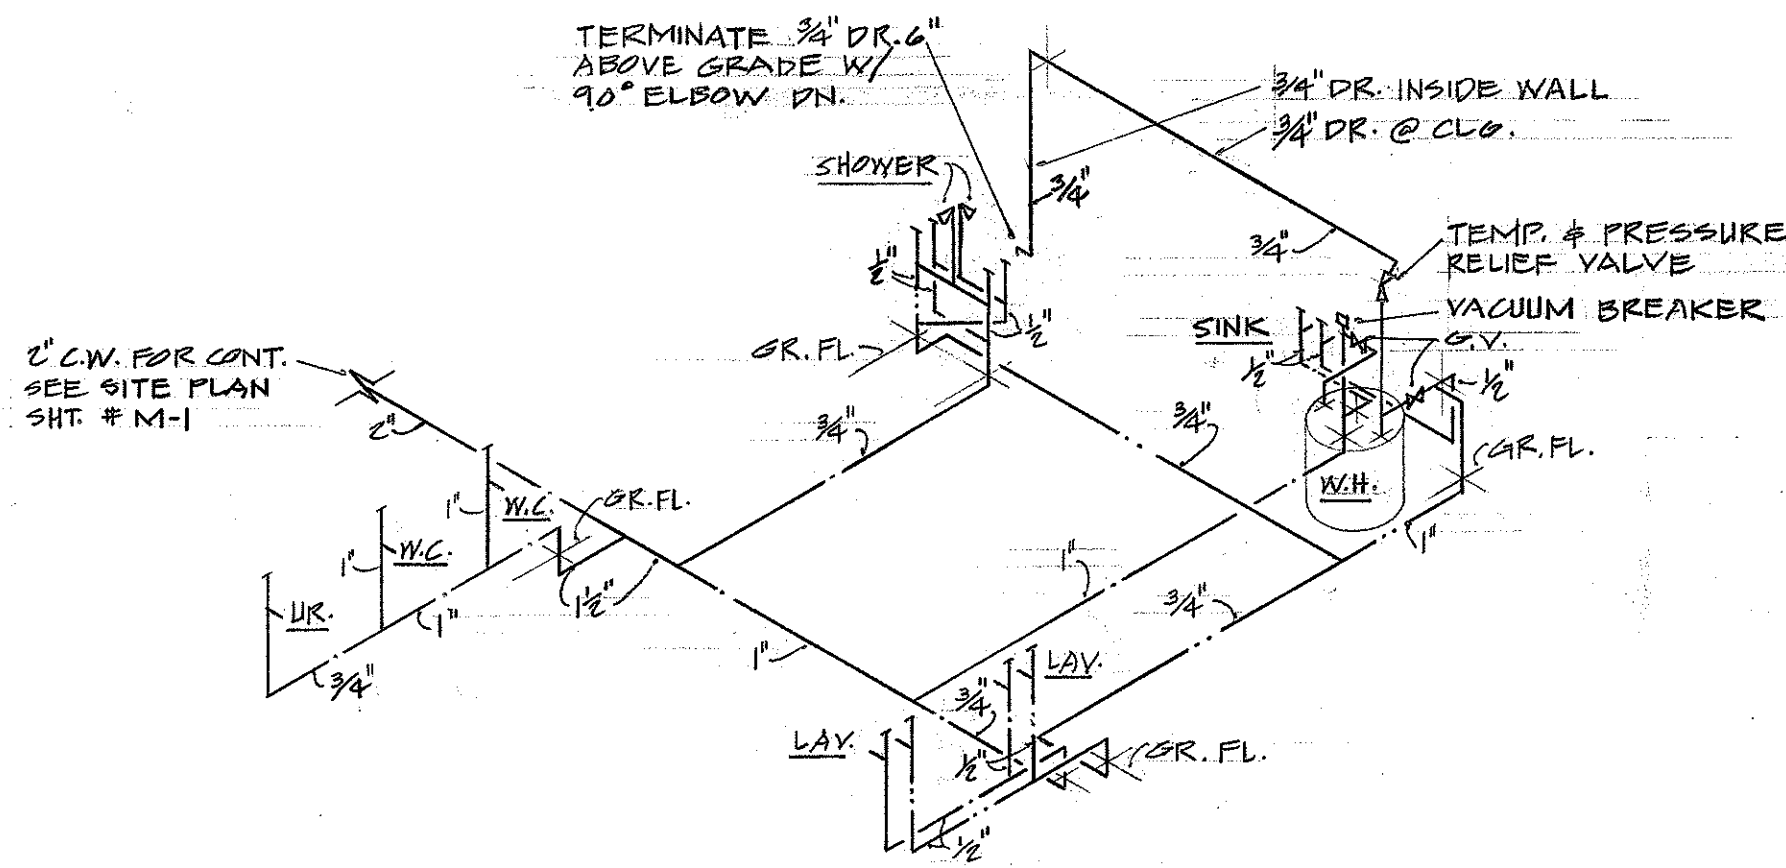


HOT & COLD WATER DIAGRAM (N.I.C.)
(BUILDING "A") NOT TO SCALE

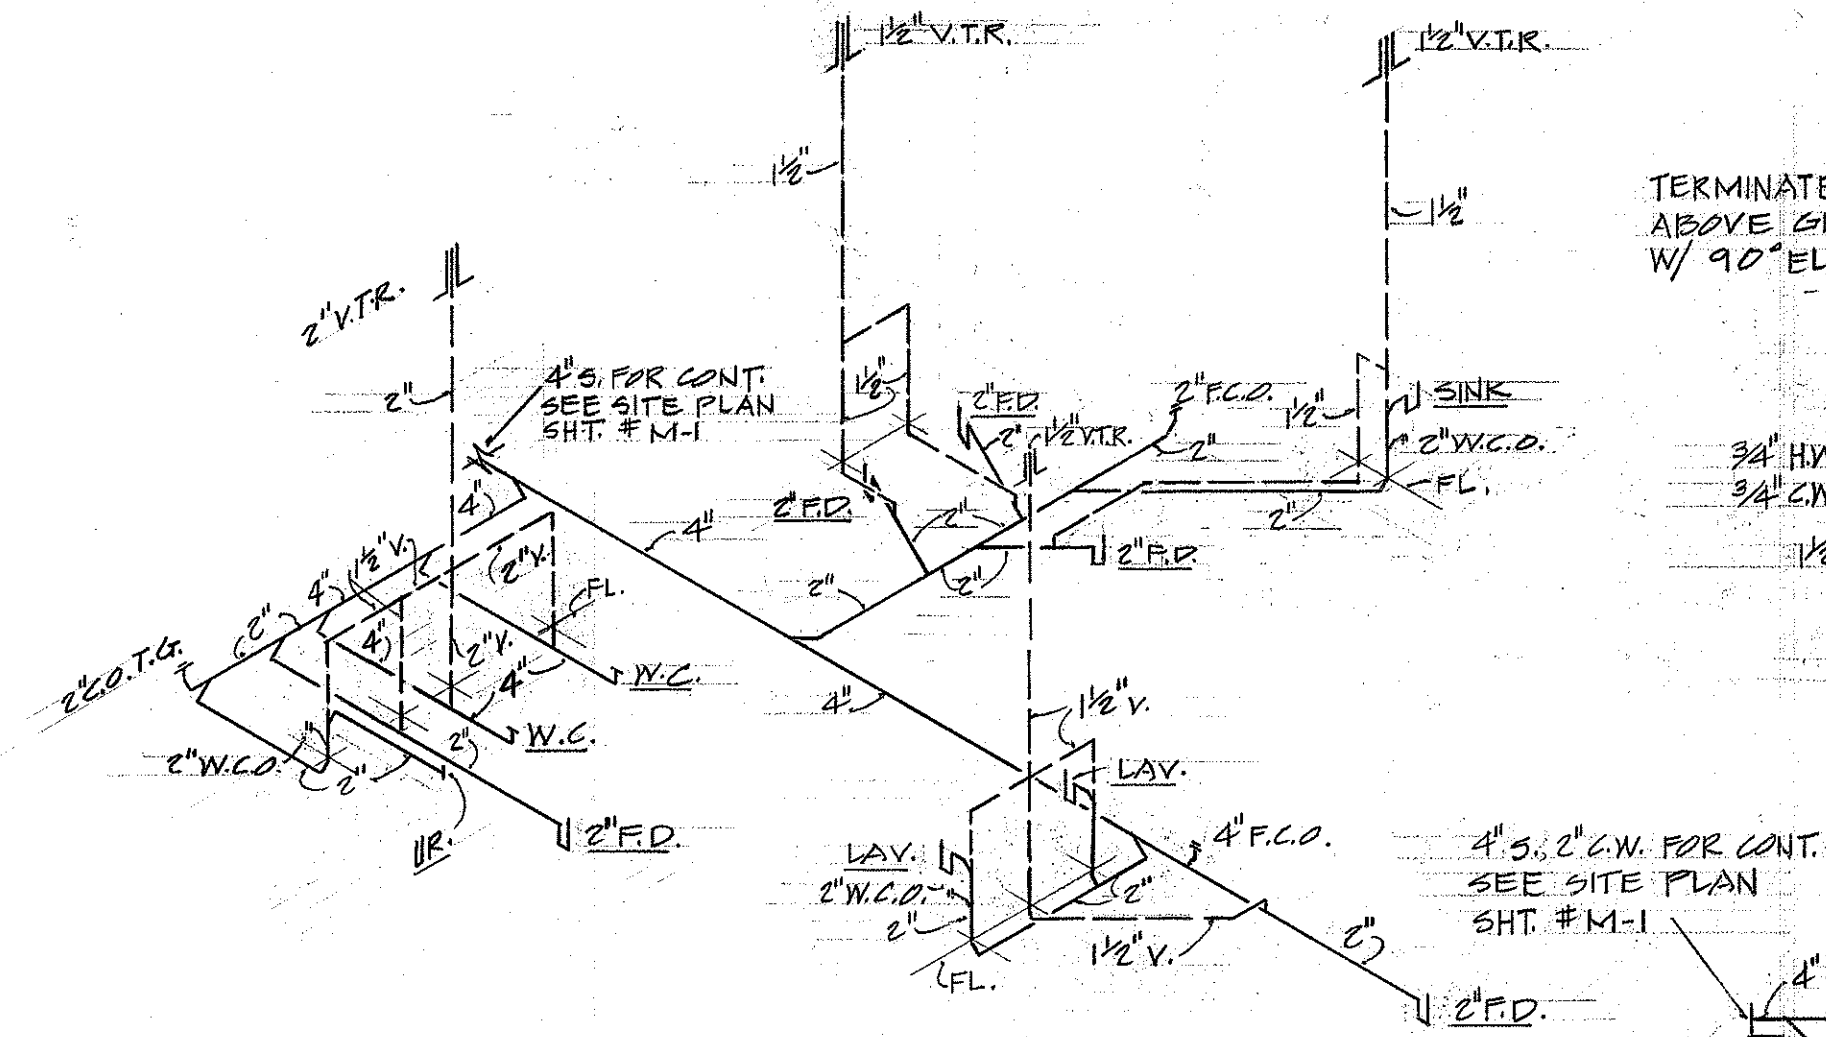

SANITARY DIAGRAM (N.I.C.)
(BUILDING "A") NOT TO SCALE

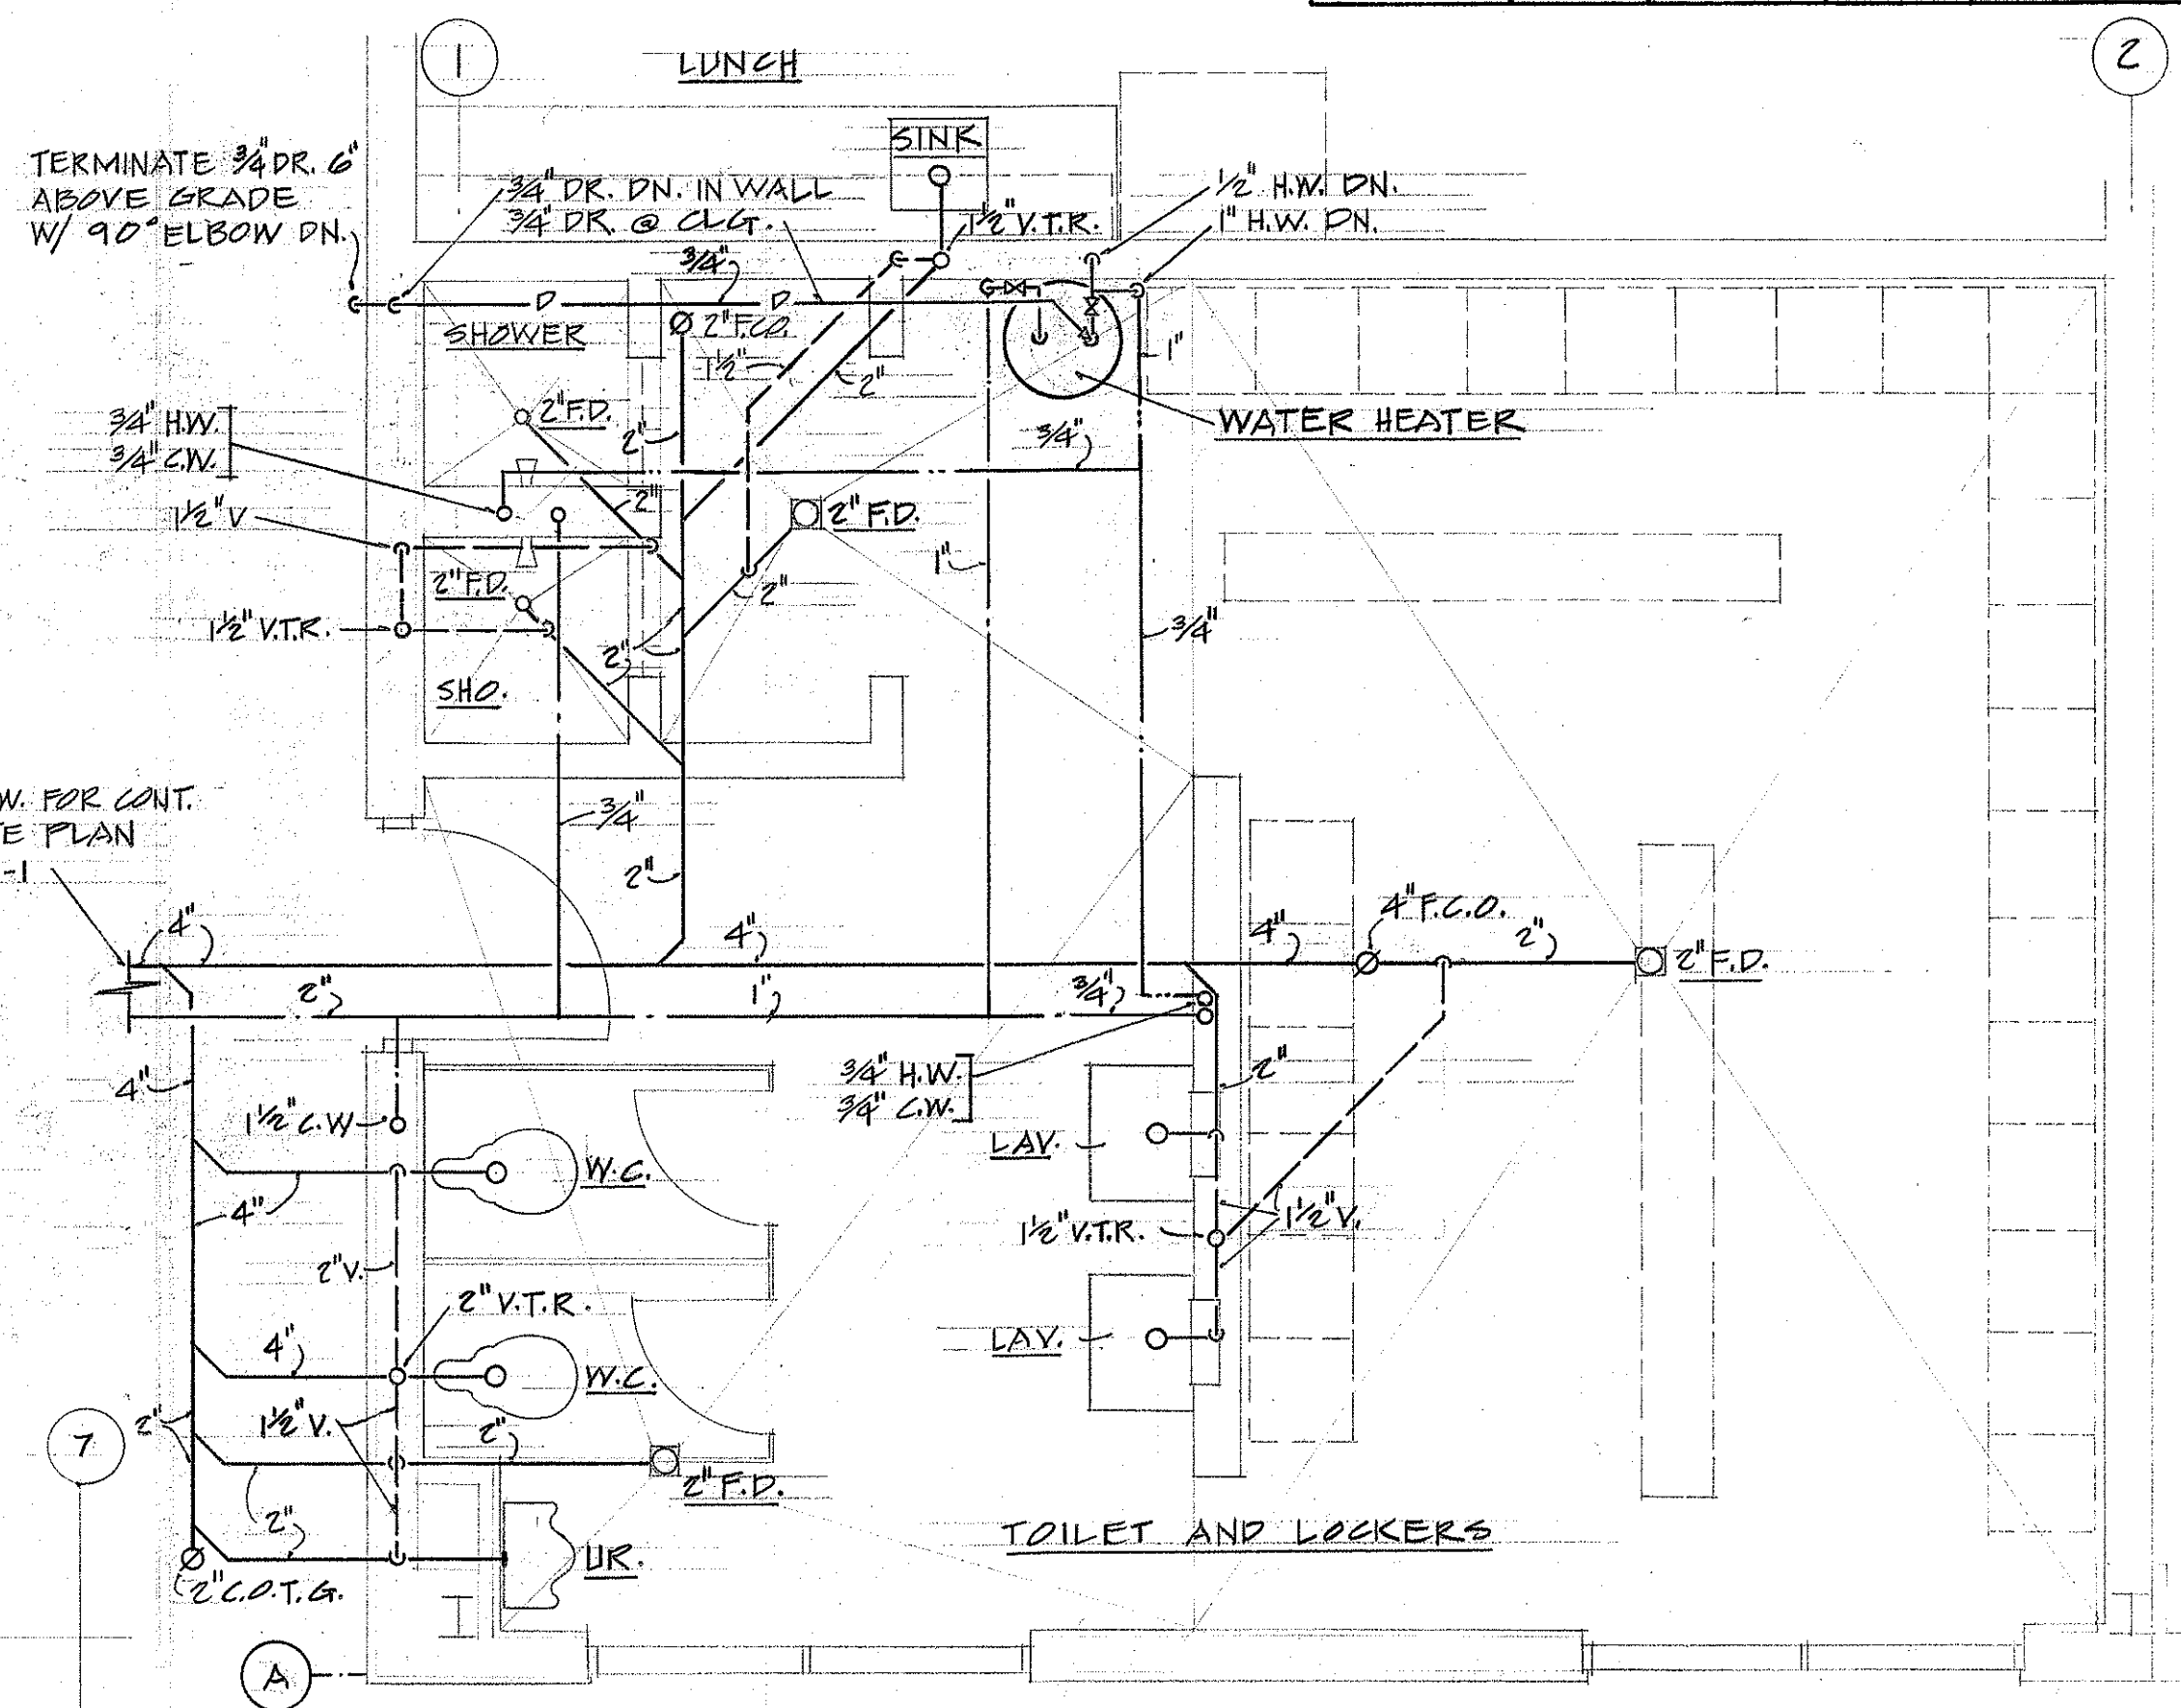

TOILET & LOCKER ROOM FLOOR PLAN (BUILDING "A") N.I.C. SCALE: 3/8"=1'-0" M-2

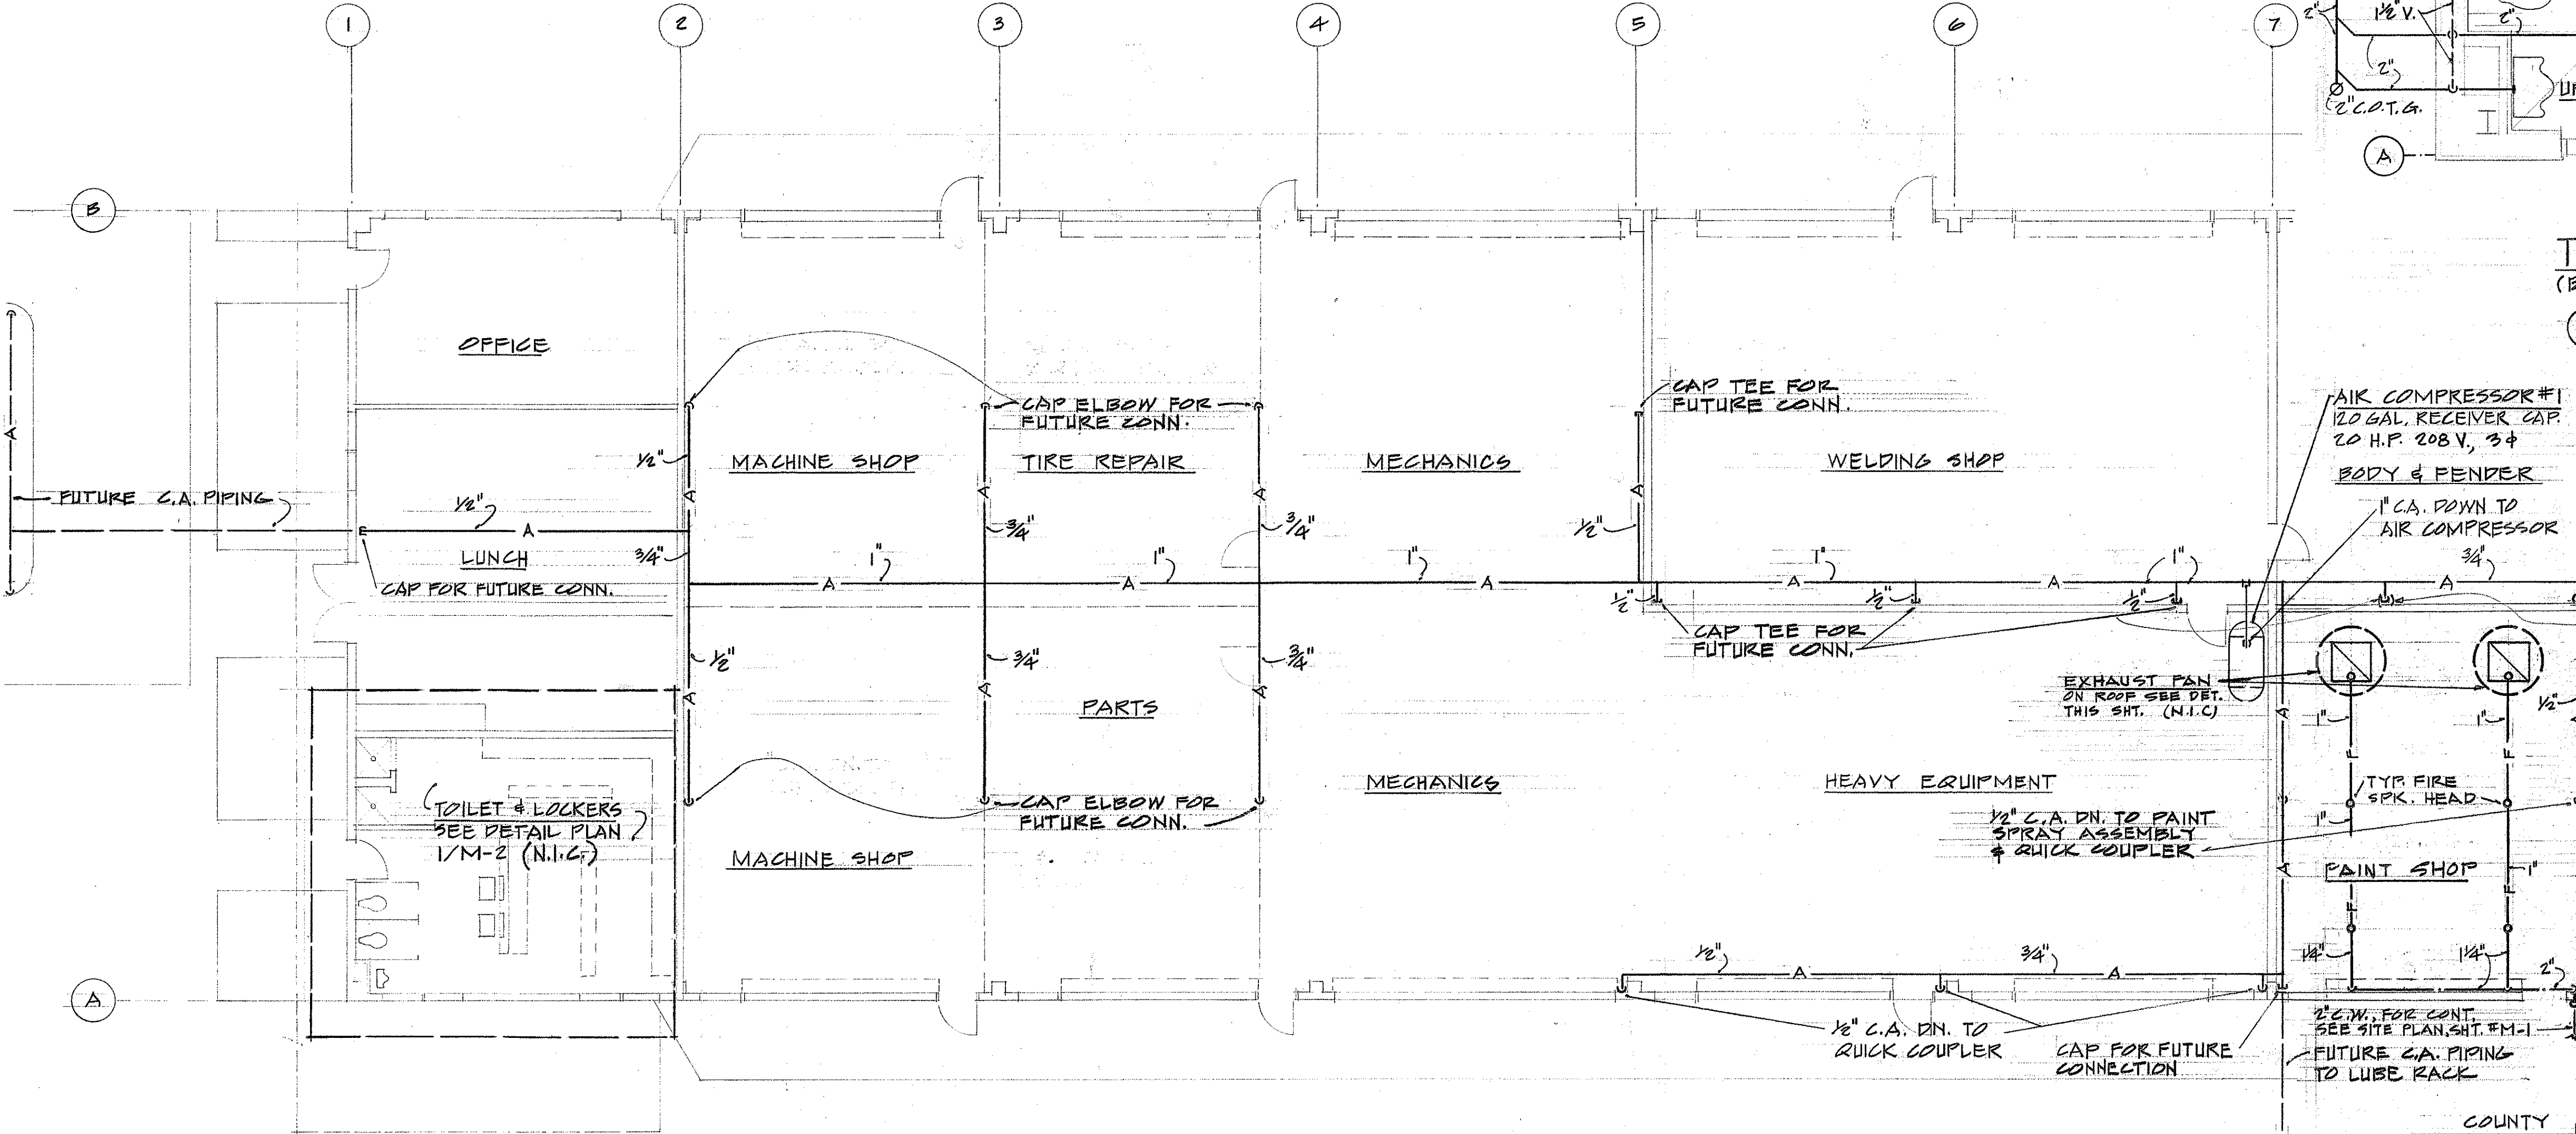

PARTIAL BLDG. "A" FLOOR PLAN (COUNTY)
SCALE: 1/8"=1'-0"

AIR COMPRESSOR #1
100 GAL. RECEIVER CAP.
20 H.P. 208 V., 3 ϕ
BODY & FENDER
1" C.A. DOWN TO
AIR COMPRESSOR

EXHAUST FAN
ON ROOF SEE DET.
THIS SHT. (N.I.C.)


1/2" C.A. DN. TO PAINT
SHOP ASSEMBLY
& QUICK COUPLER

PAINT SHOP


2" C.W. FOR CONT.
SEE SITE PLAN, SHT. #M-1
FUTURE C.A. PIPING
TO LUBE RACK

MATCH LINE
FOR CONT. SEE
SHT. #M-3

CONTINUE TO
LUBRICATION (N.I.C.)

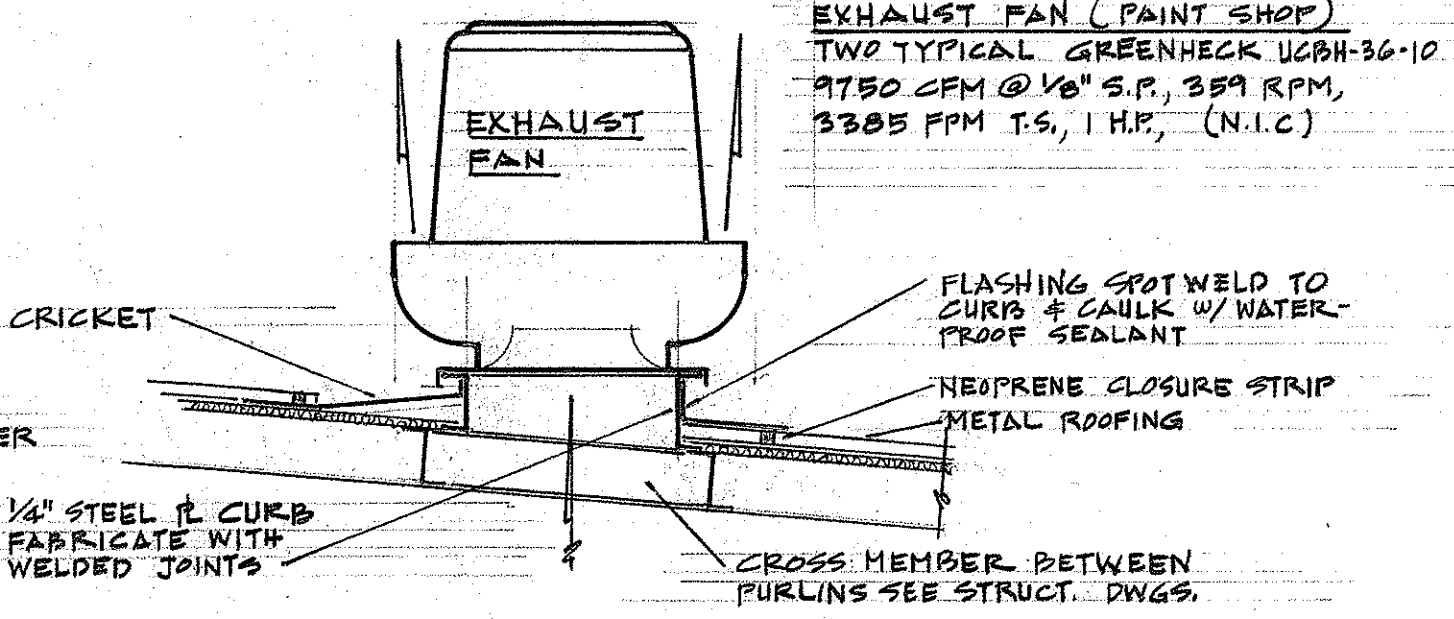

EXH. FAN SUPPORT DETAIL (N.I.C.)
SCALE: 3/8"=1'-0"

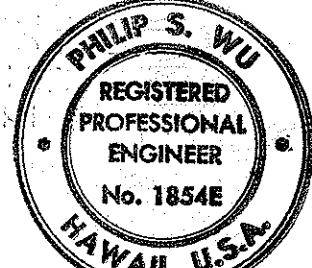








THIS WORK WAS PREPARED BY
ME OR UNDER MY SUPERVISION.
Philip S. Wu

STATE OF HAWAII DEPARTMENT OF TRANSPORTATION HIGHWAYS DIVISION	
KAUAI STATE HIGHWAY - COUNTY BASE YARD KAPAA KAUAI	
PARTIAL FLOOR PLAN - BLDG. A PIPING DIAGRAMS	
SCALE AS NOTED DATE JULY 1972	BD65-363
SHEET No. 34 OF 41 SHEETS	

M 2

DATE	
SURVEY PLOTTED BY	
DRAWN BY	
CHECKED BY	
NOTE BOOK	
NO.	

FED. ROAD DIST. NO.	STATE	FED. AID PROJ. NO.	FISCAL YEAR	SHEET NO.	TOTAL SHEETS
HAWAII	HAW.				

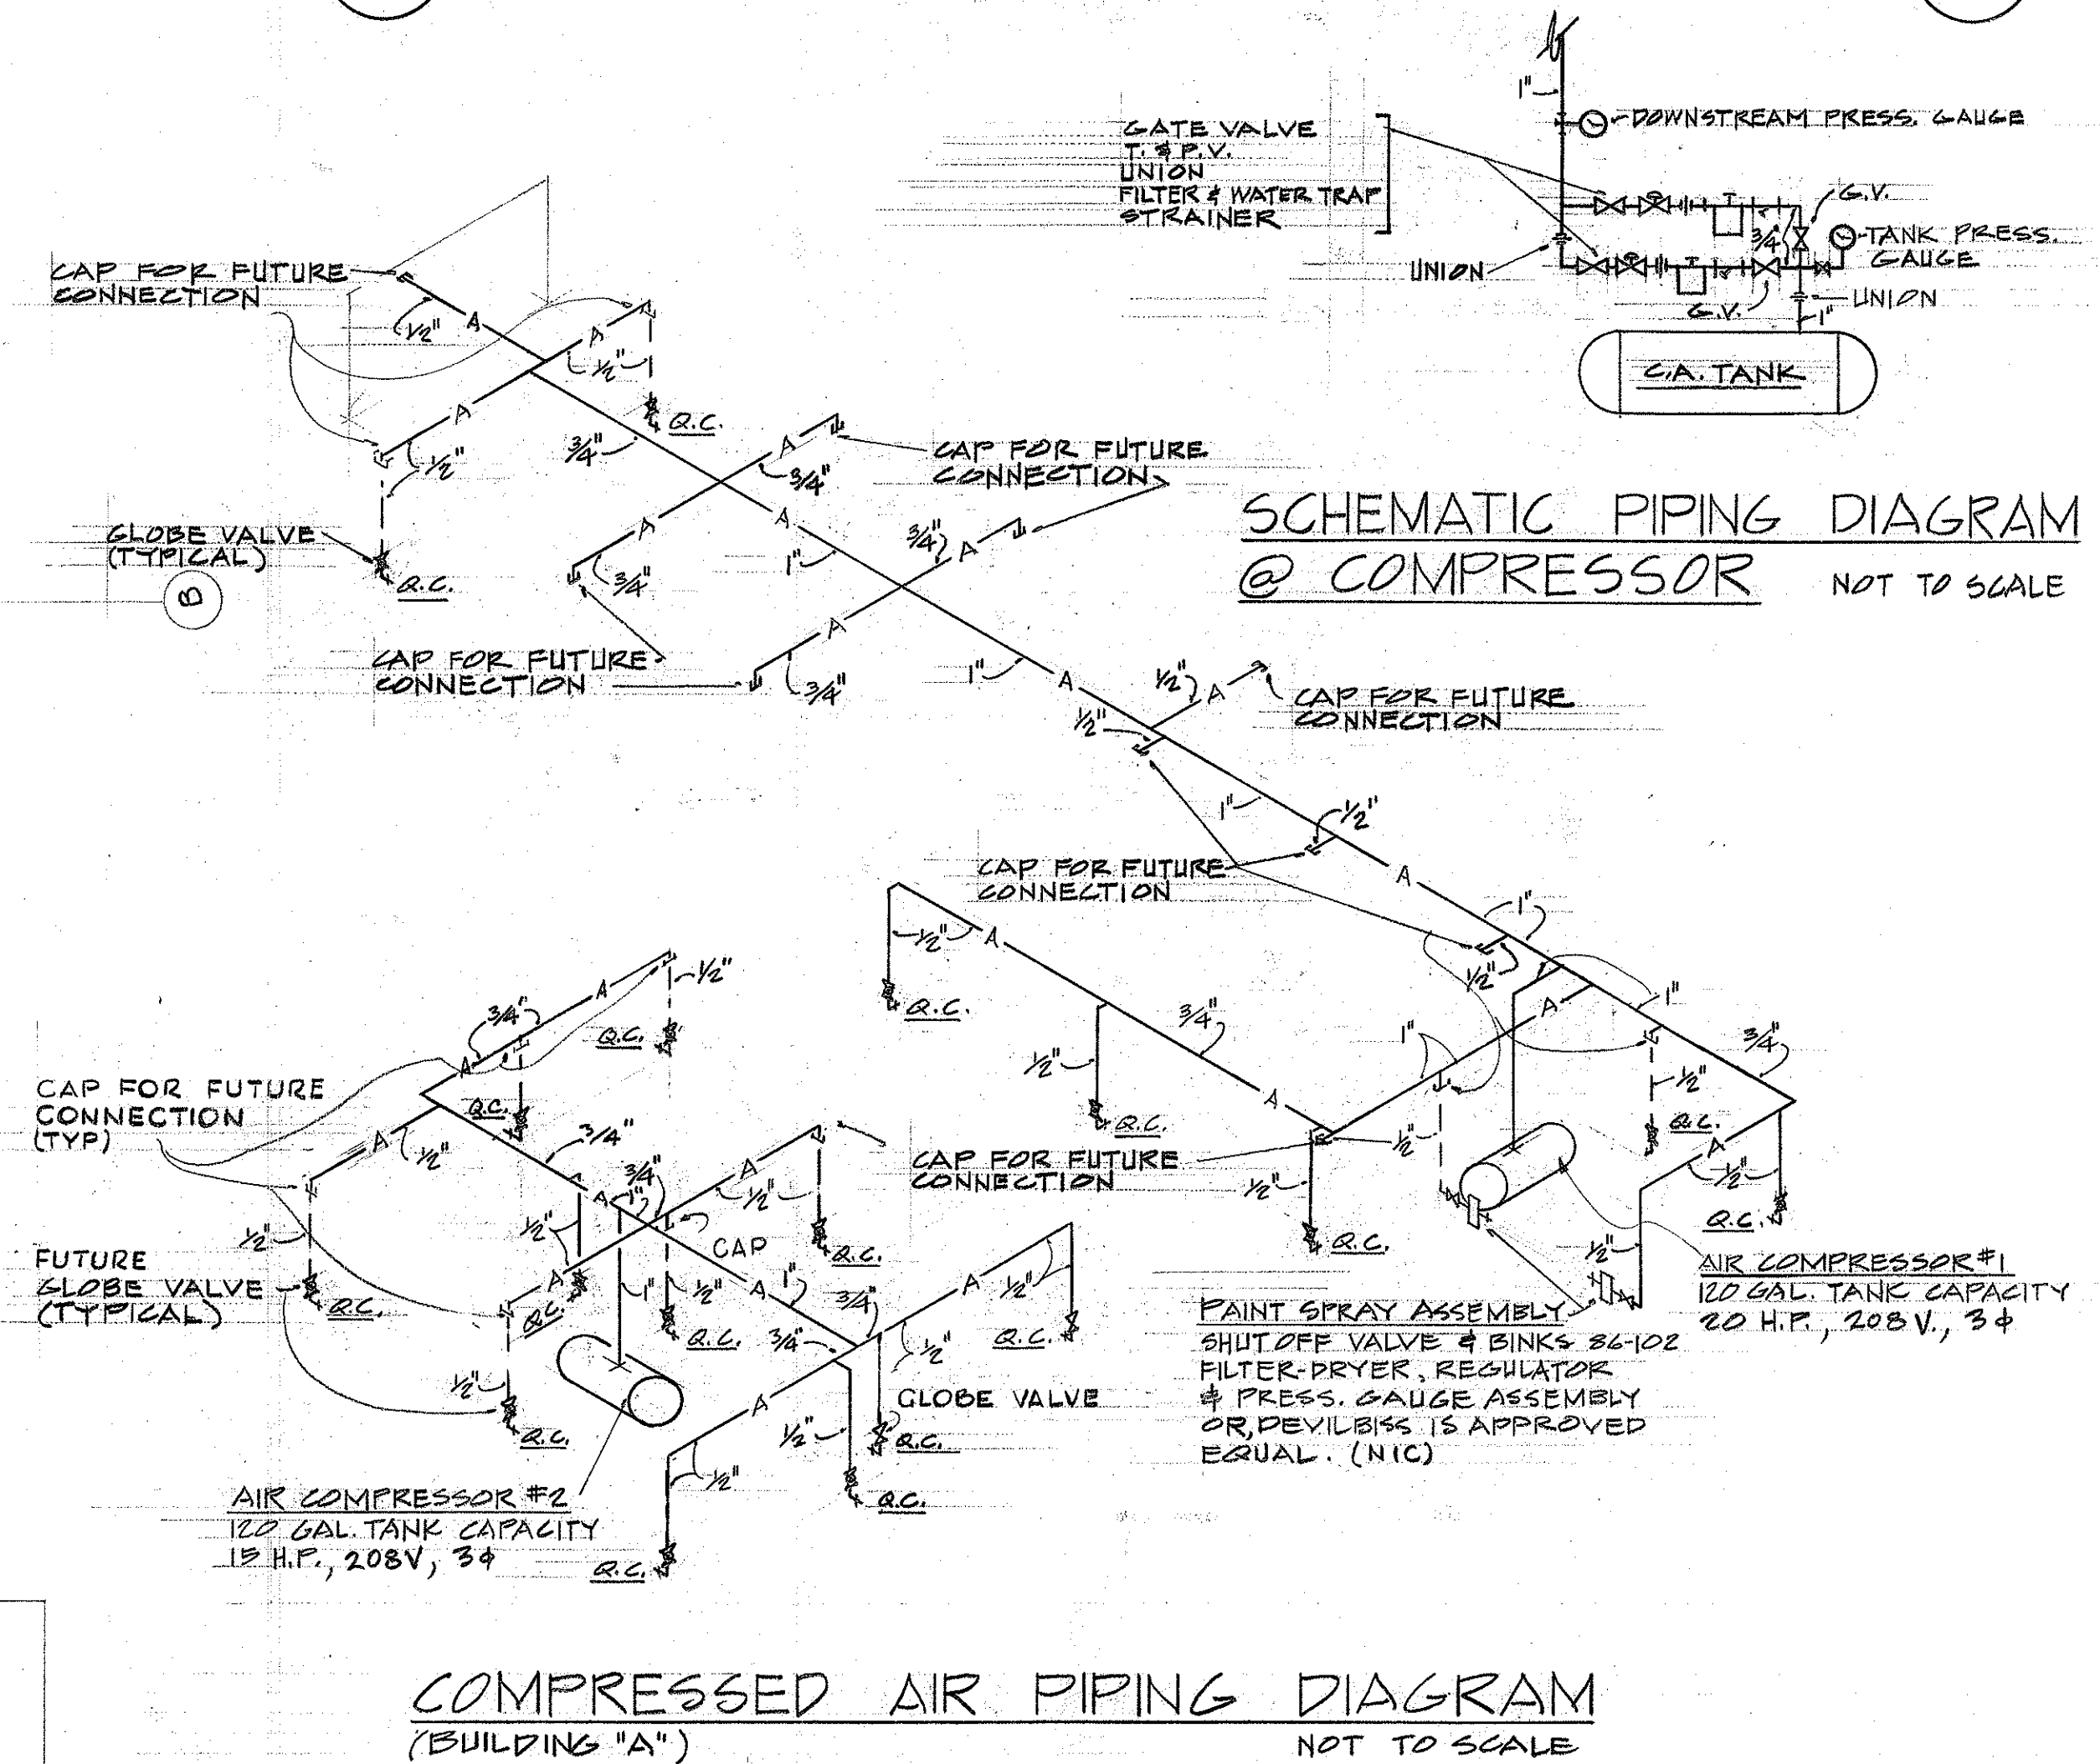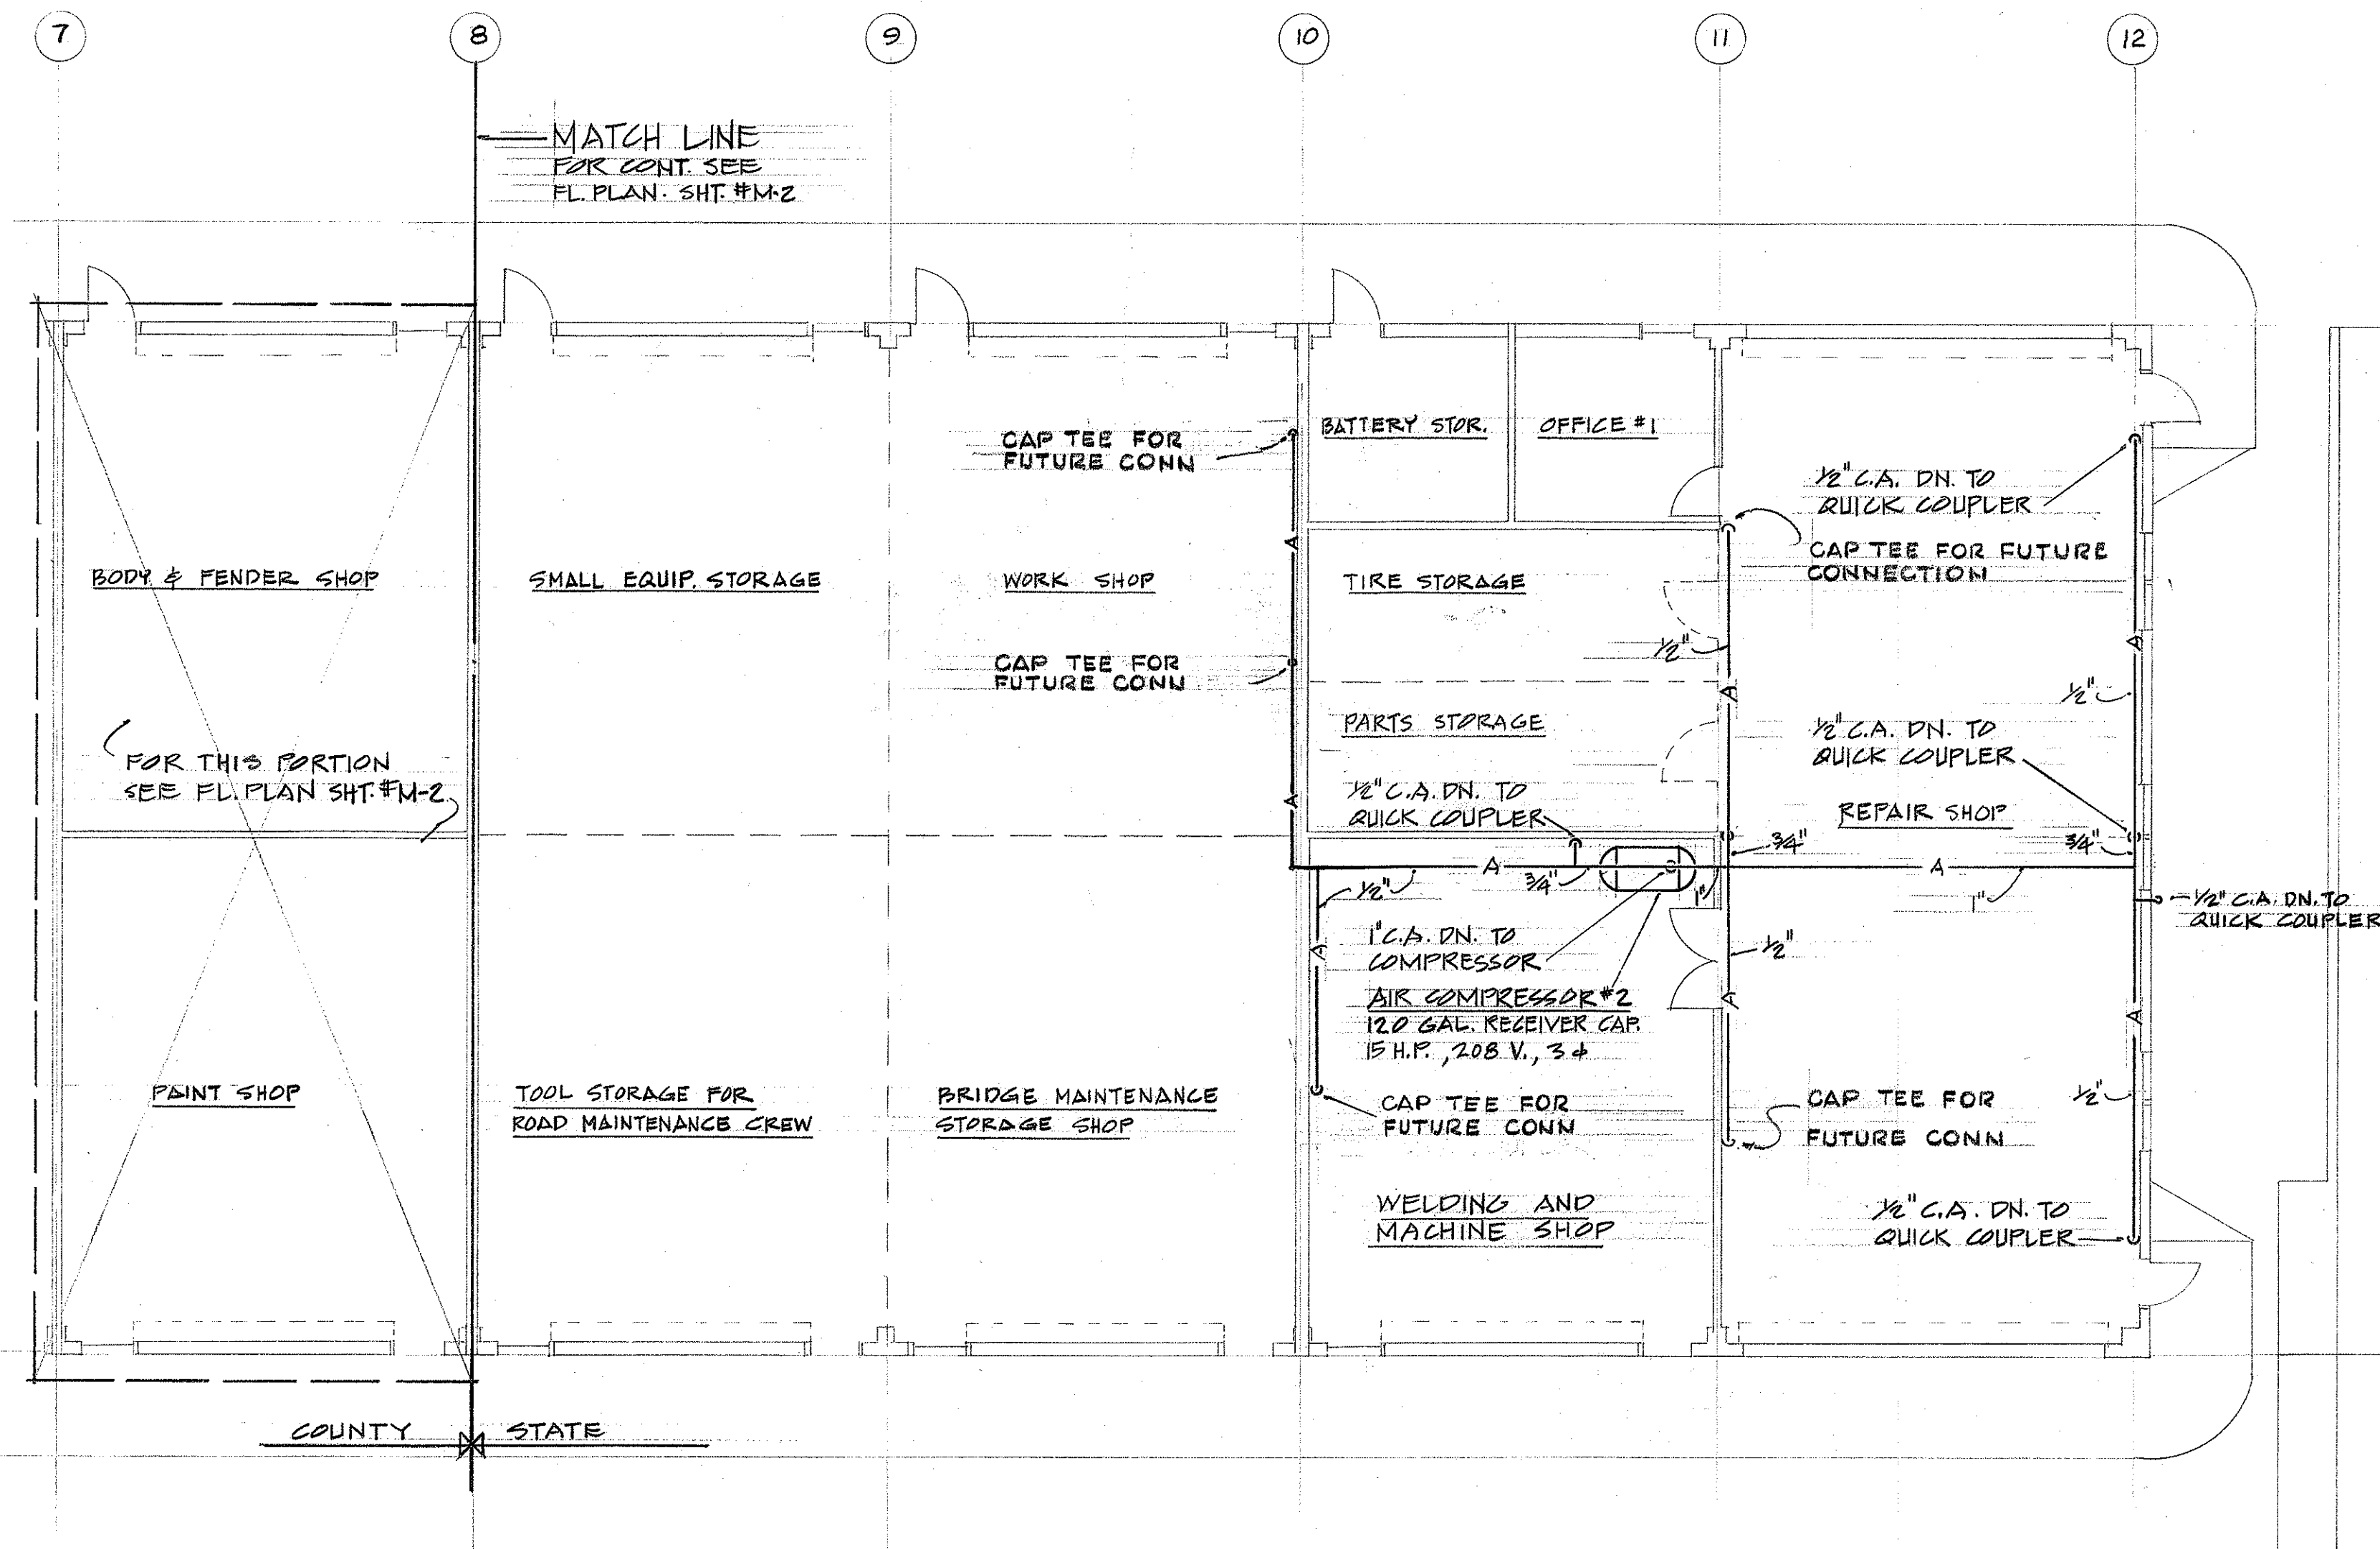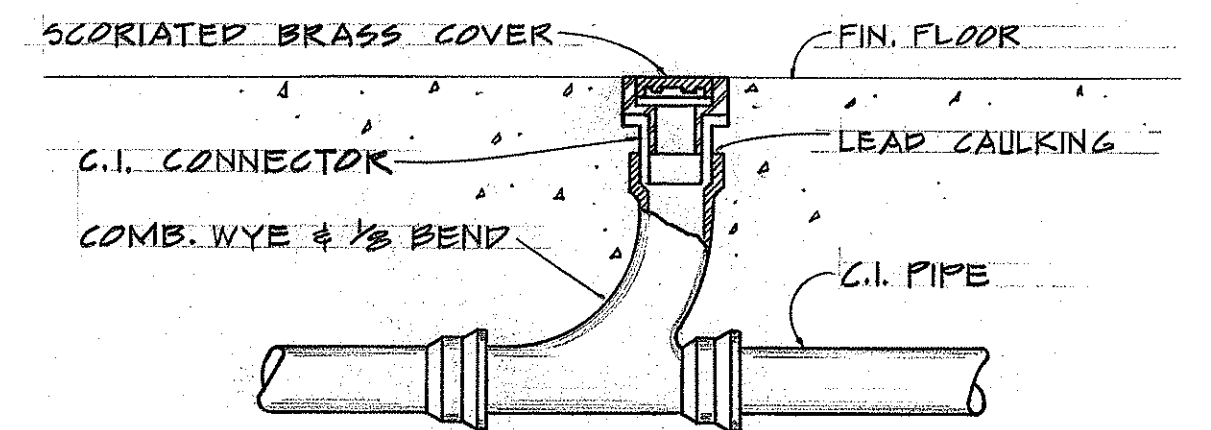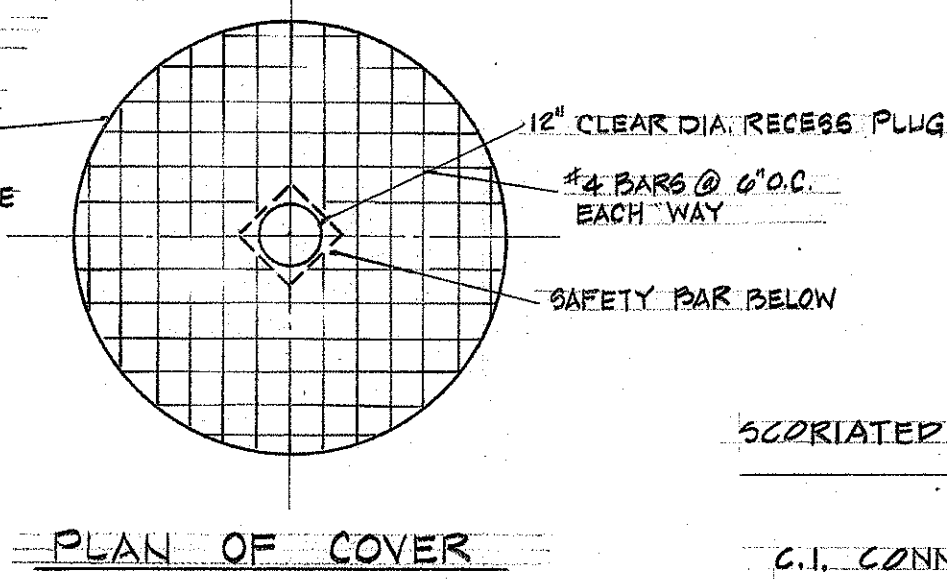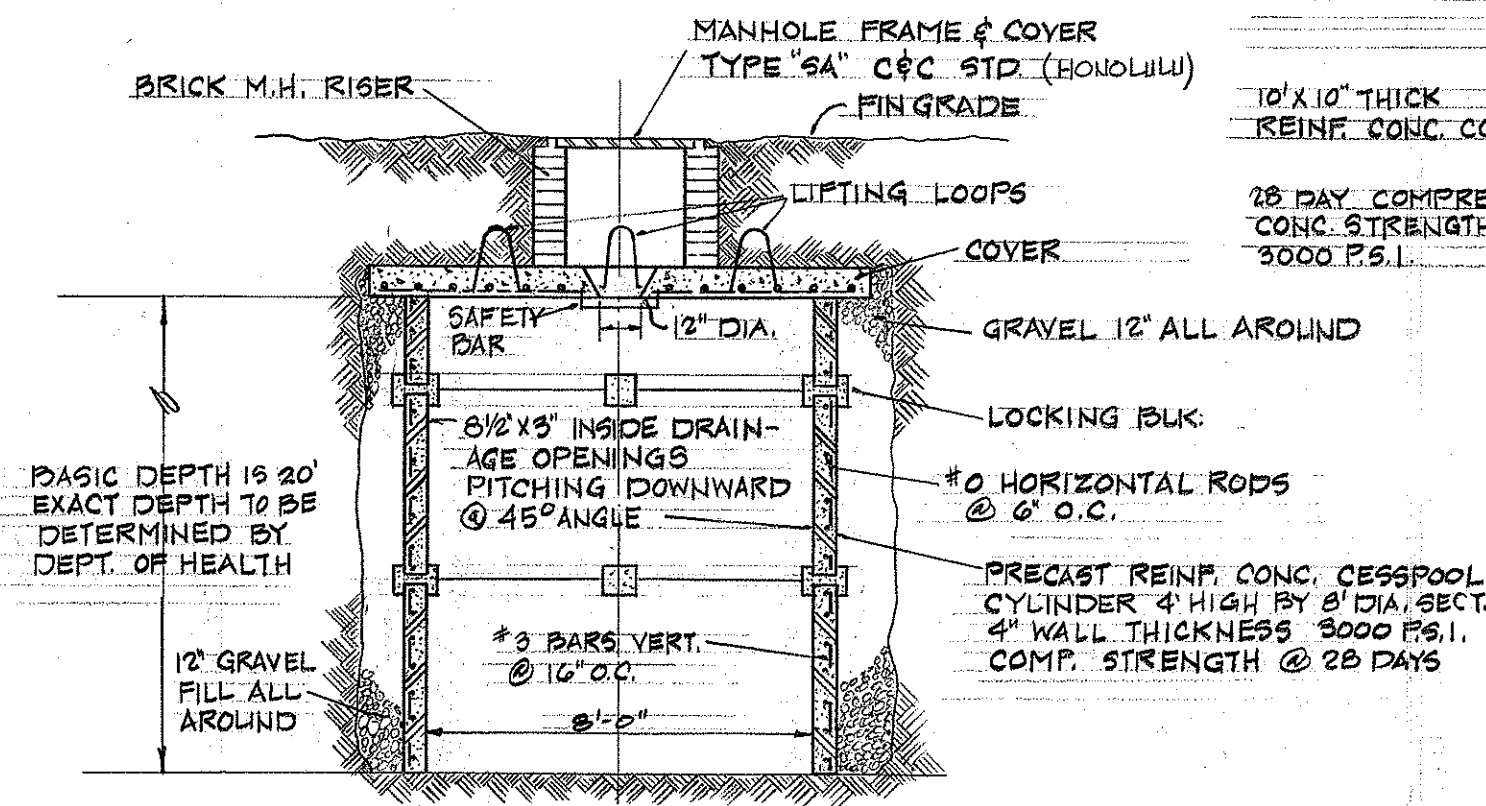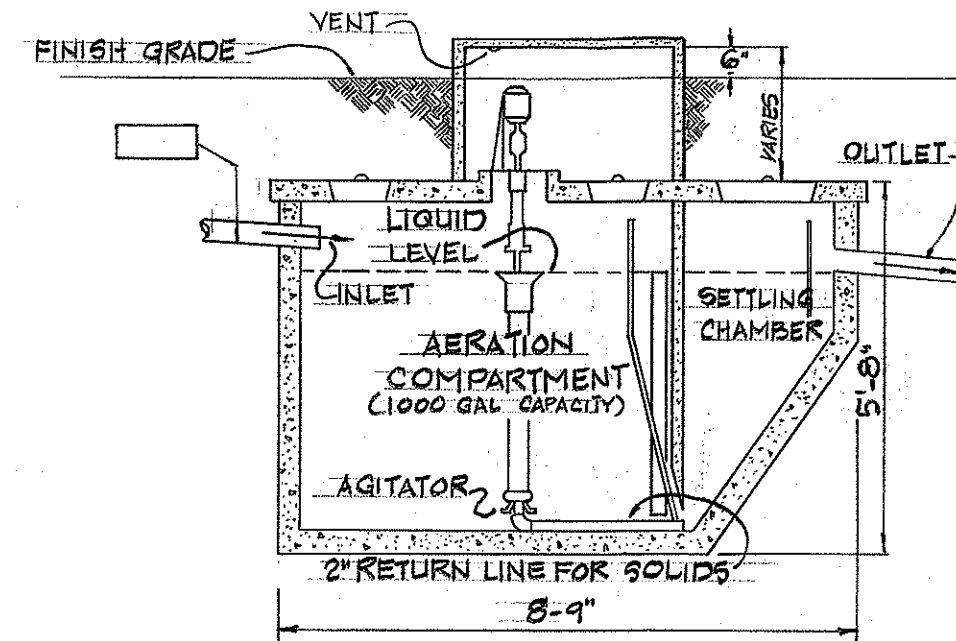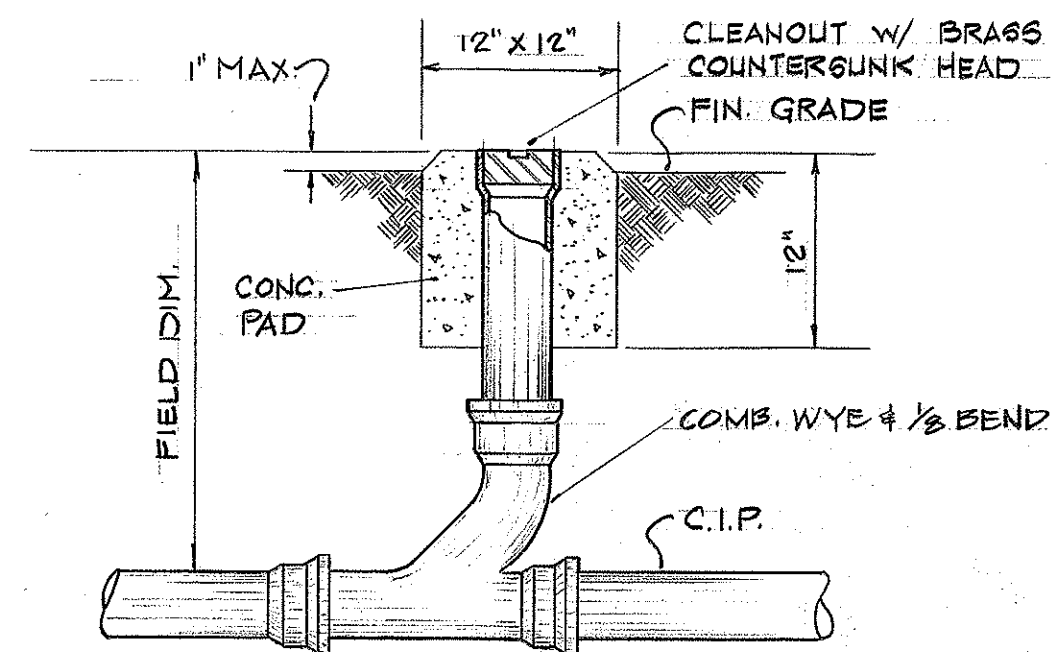



THIS WORK WAS PREPARED BY
A/E OR UNDER MY SUPERVISION.

STATE OF HAWAII DEPARTMENT OF TRANSPORTATION HIGHWAYS DIVISION	
KAUAI - STATE HIGHWAY - COUNTY BASE YARD KAPAA KAUAI	
PARTIAL FLOOR PLAN - BLDG. A COMPRESSED AIR PIPING DIAGRAM	M3
SCALE AS NOTED DATE JULY 1972	BD65-363

SHEET No. 35 OF 41 SHEETS




SURVEY PLOTTED BY	DATE
DRAWN BY	
CHECKED BY	
NOTE BOOK	
QUANTITIES BY	
CHECKED BY	

FED. ROAD DIST. NO.	STATE	FED. AID PROJ. NO.	FISCAL YEAR	SHEET NO.	TOTAL SHEETS
HAWAII	HAW.				

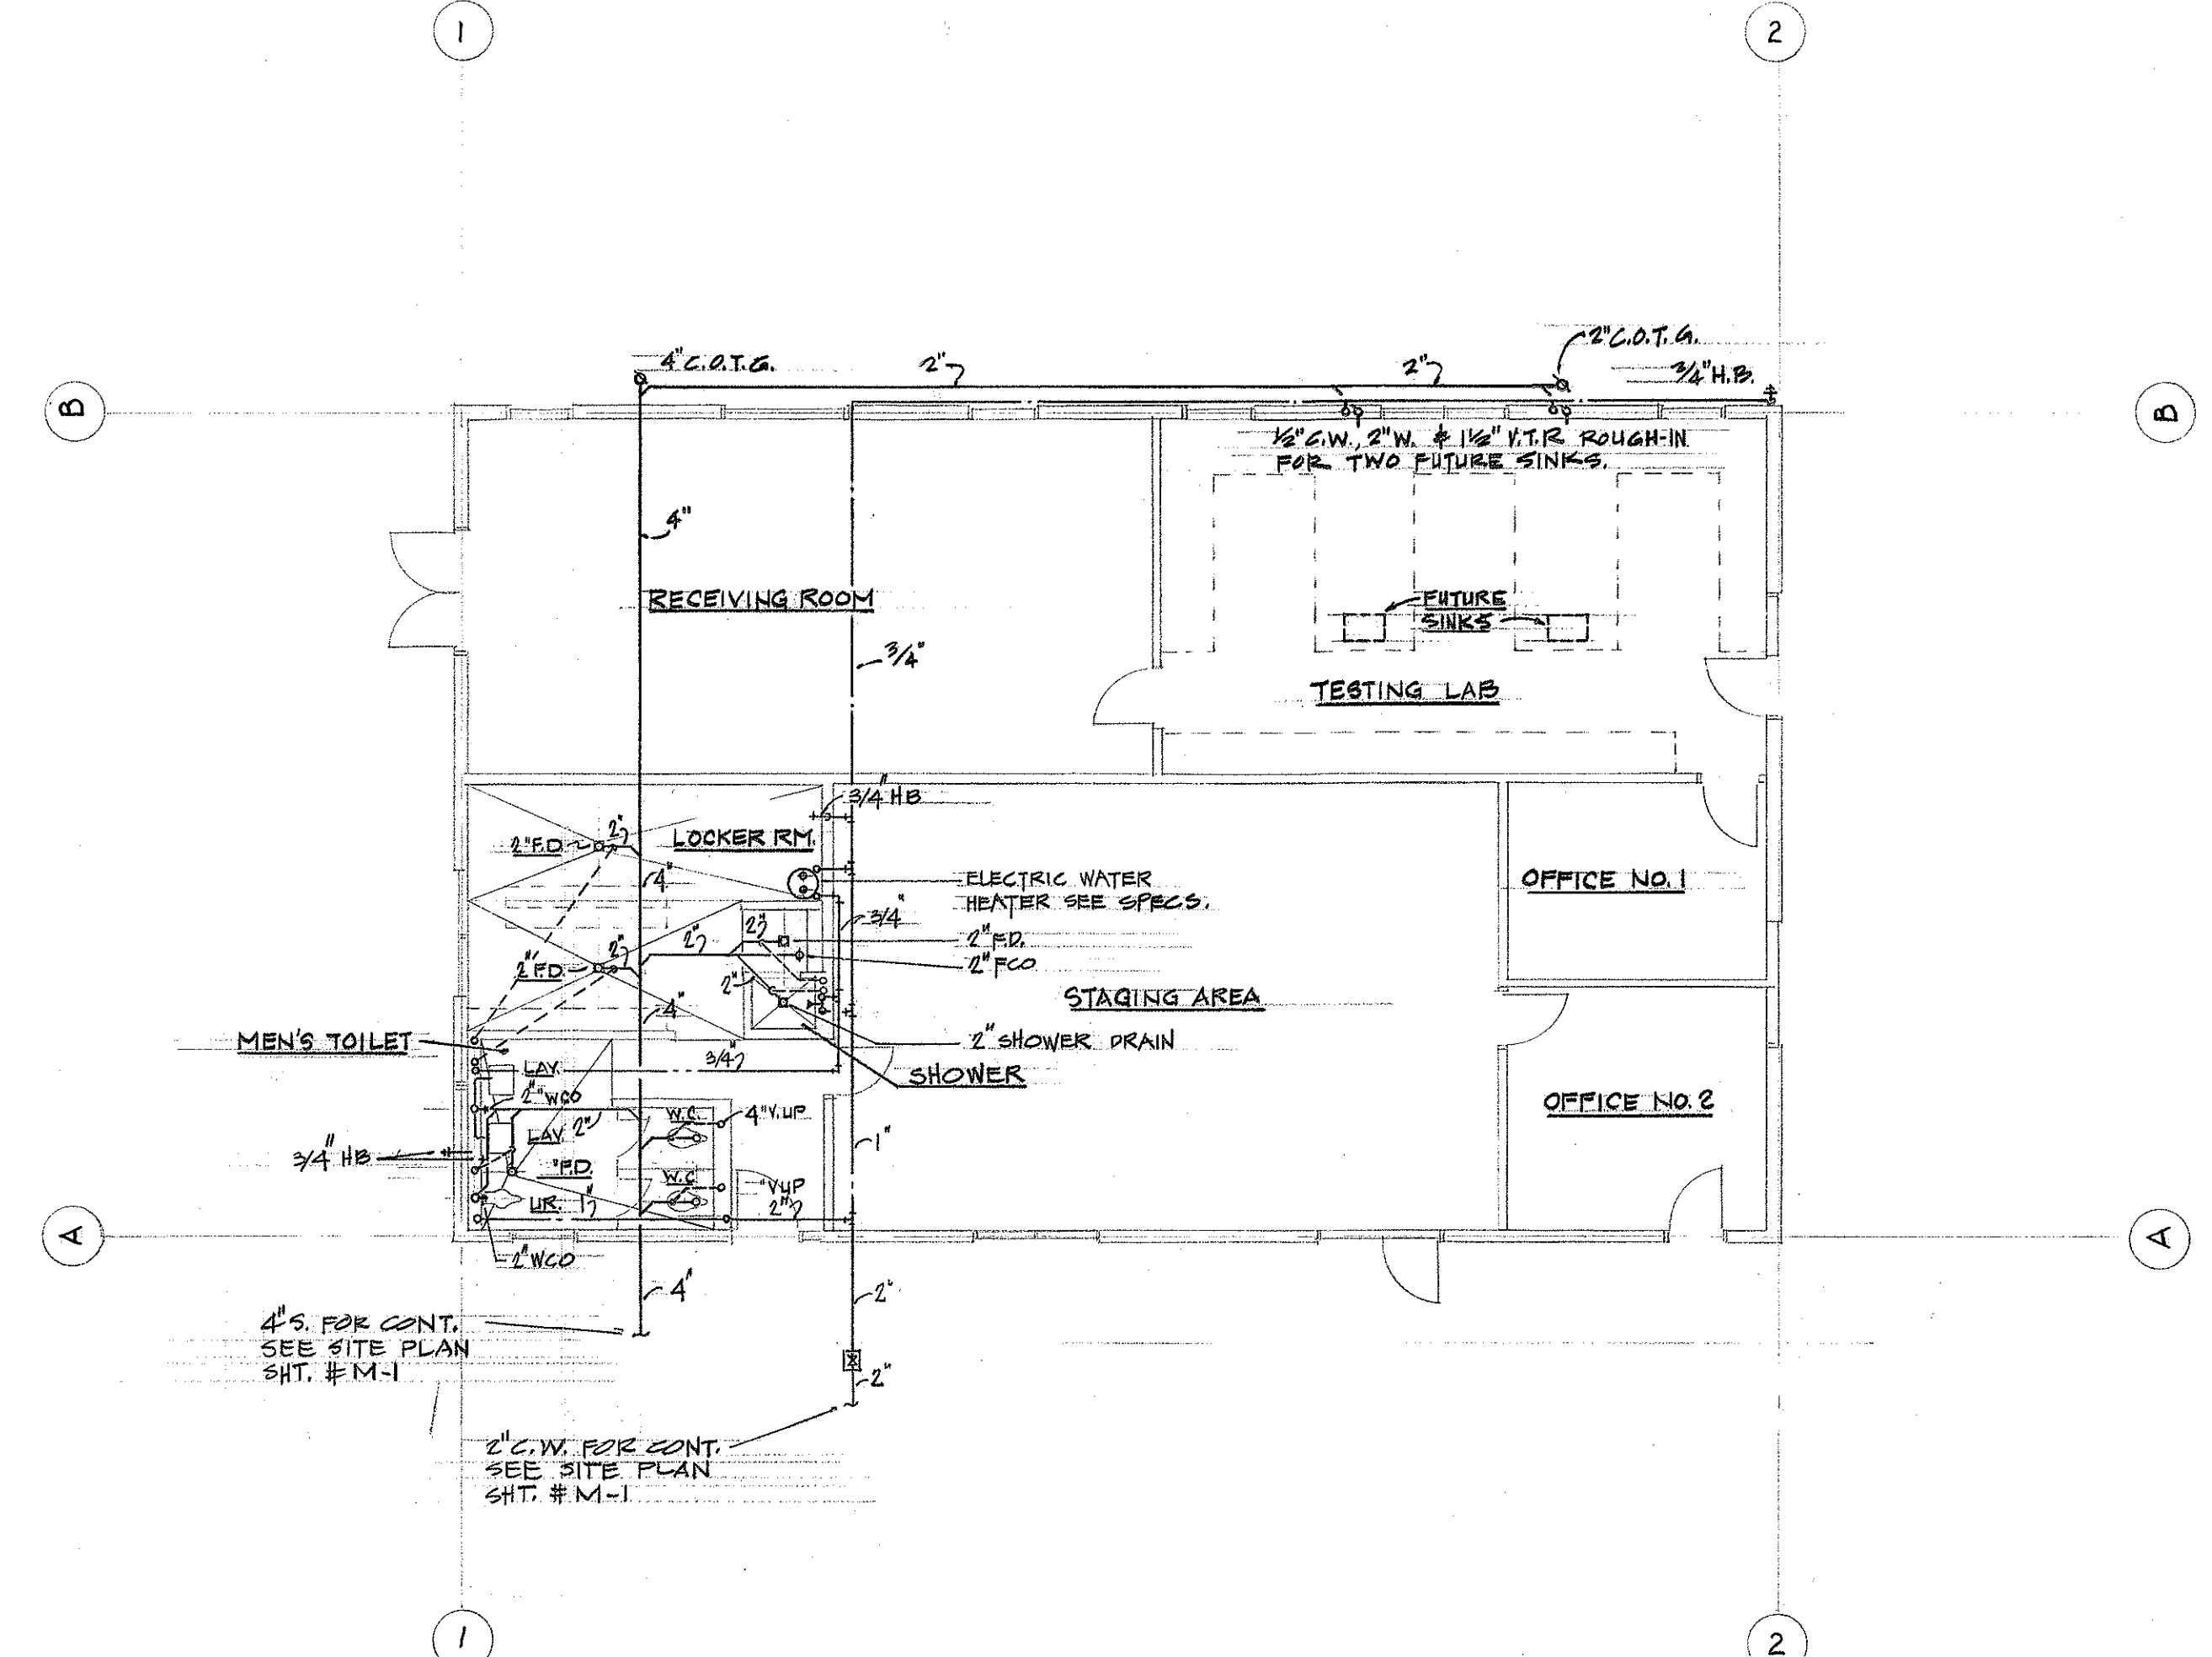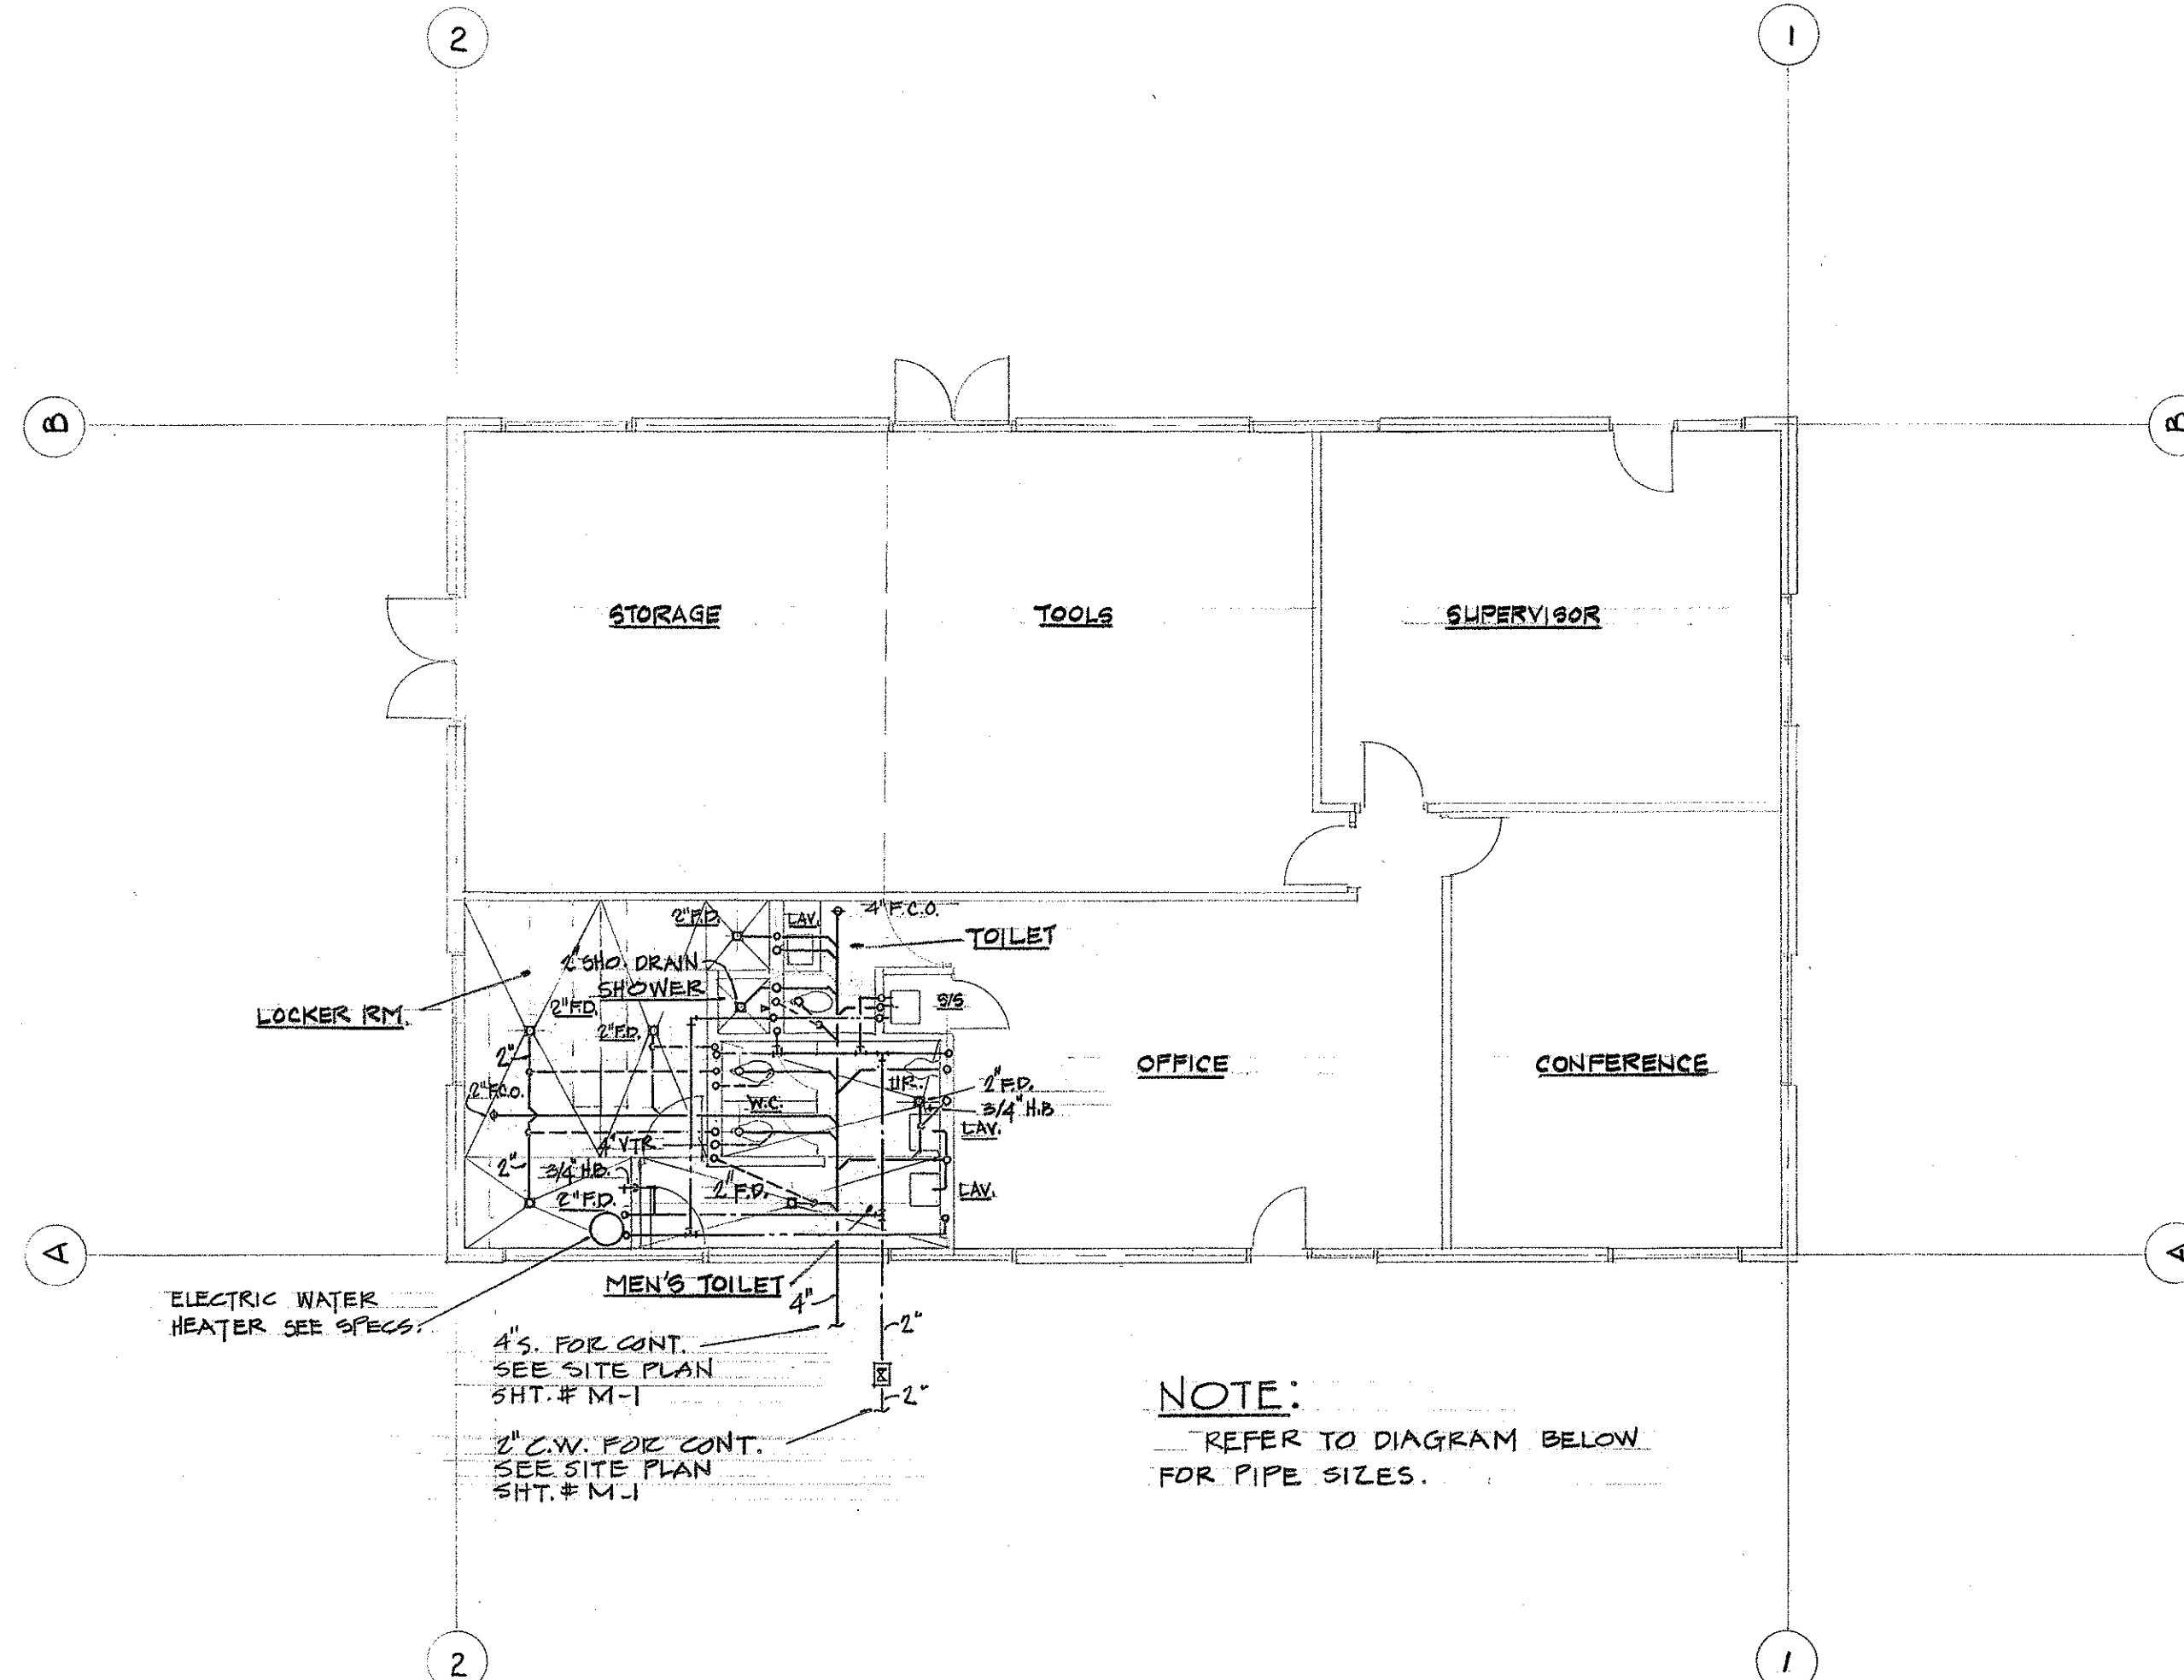

ALTERNATE #1
FLOOR PLAN-BUILDING "B" (COUNTY)
SCALE: 1/8"=1'-0"

ALTERNATE #4
FLOOR PLAN-BUILDING "C" (STATE)
SCALE: 1/8"=1'-0"

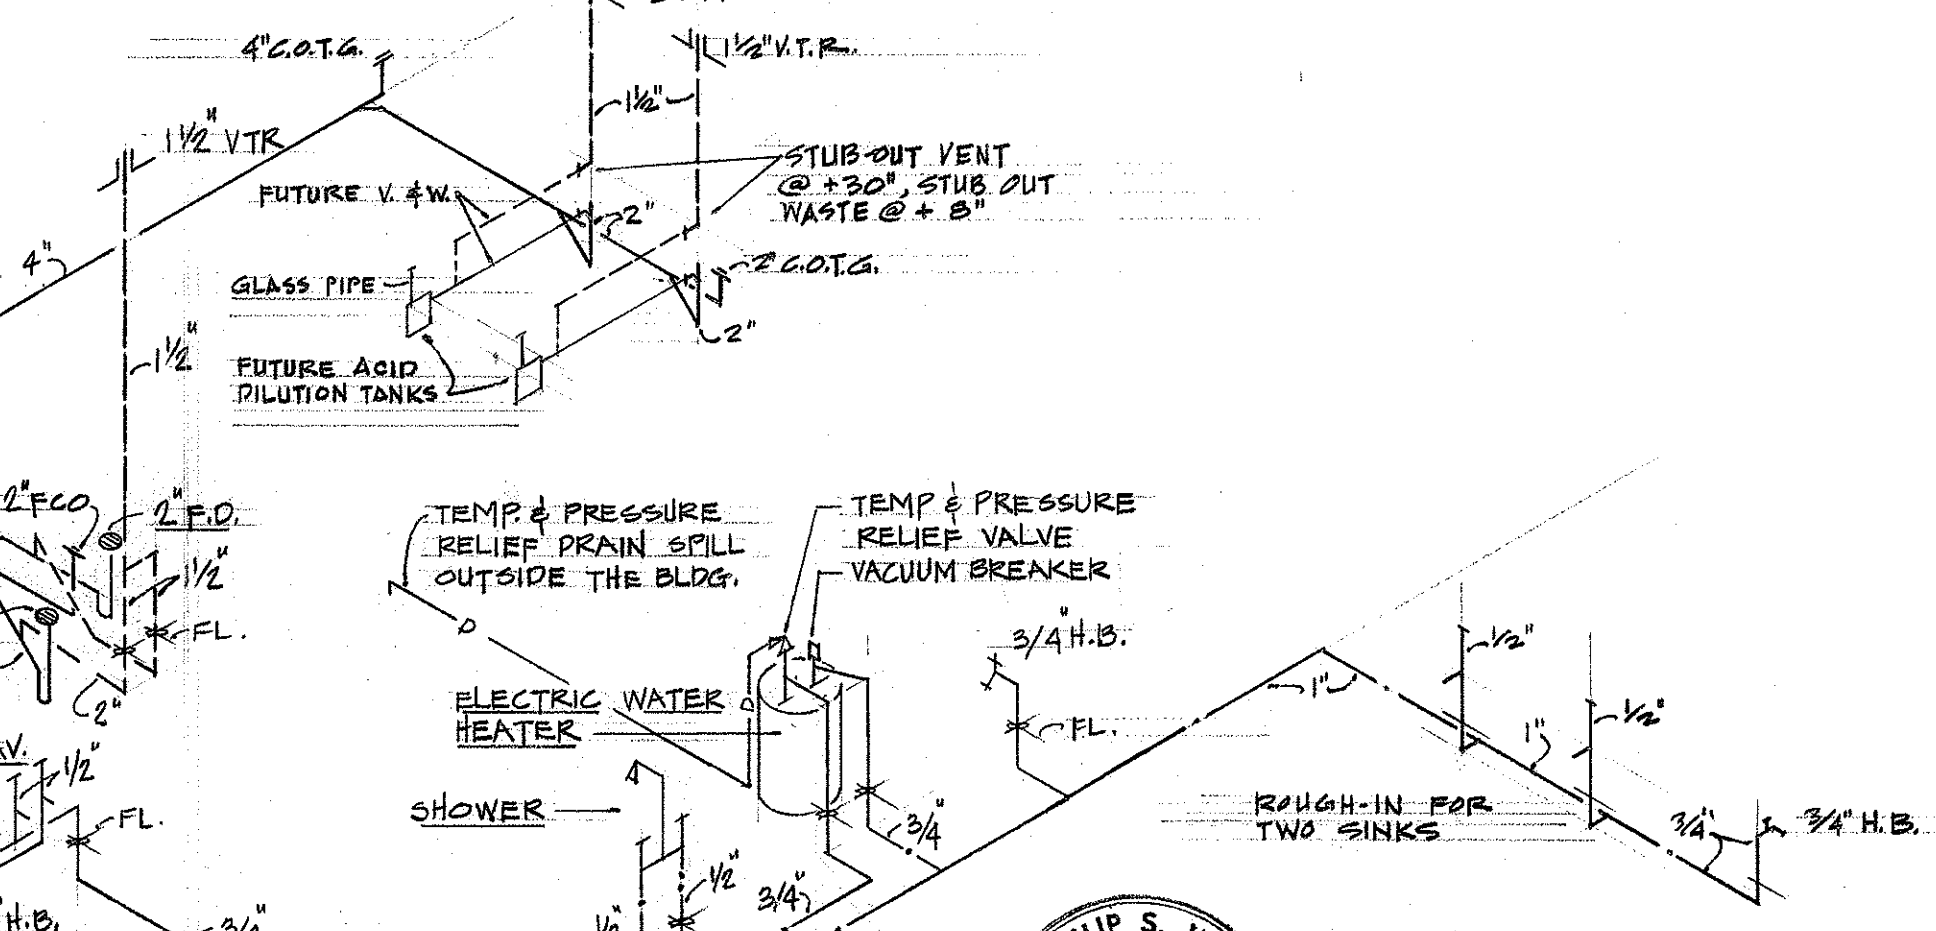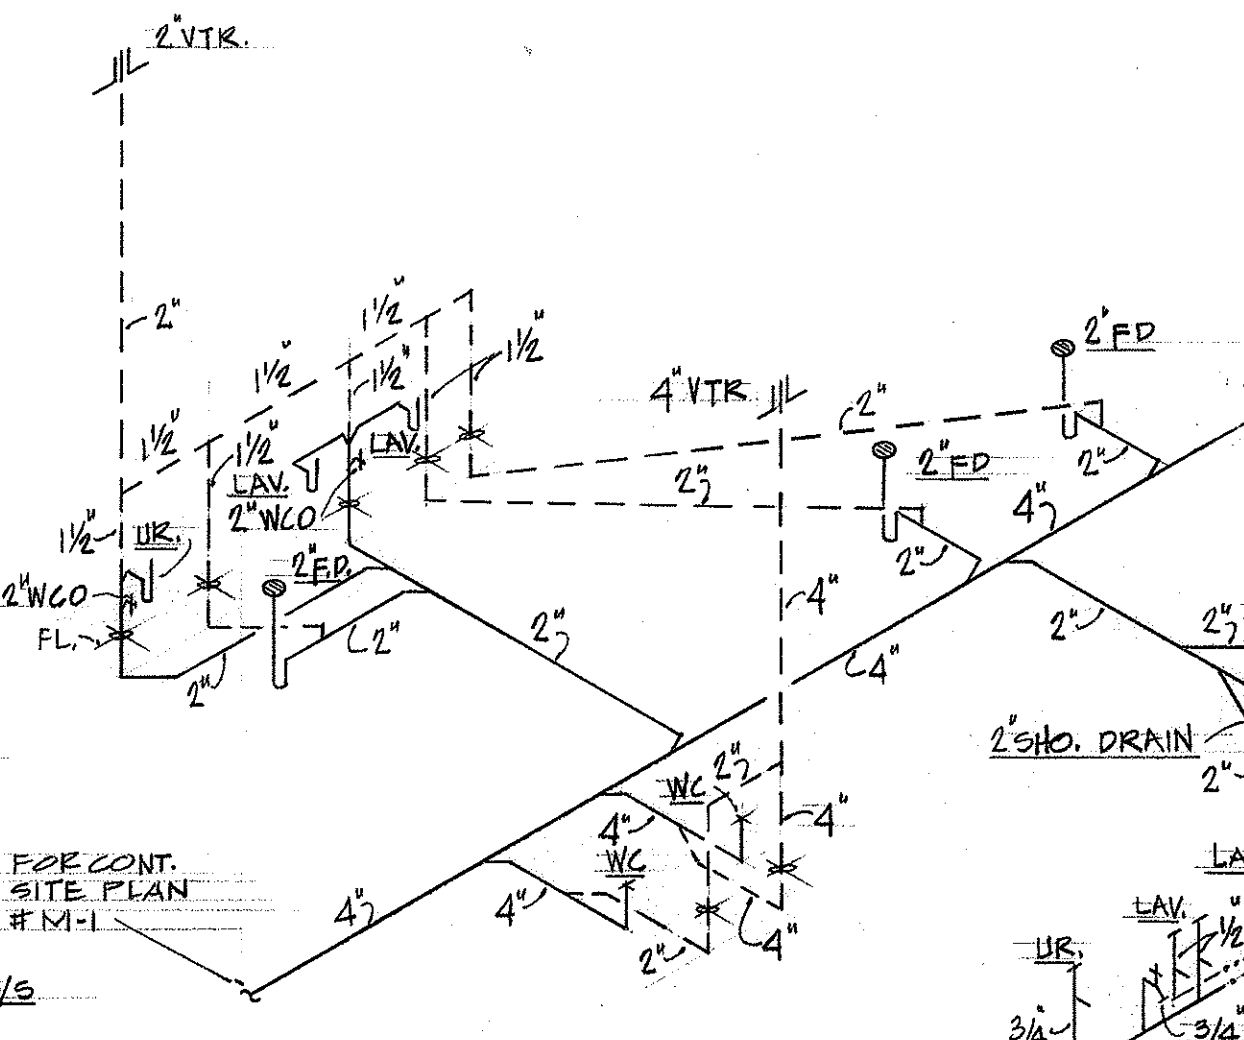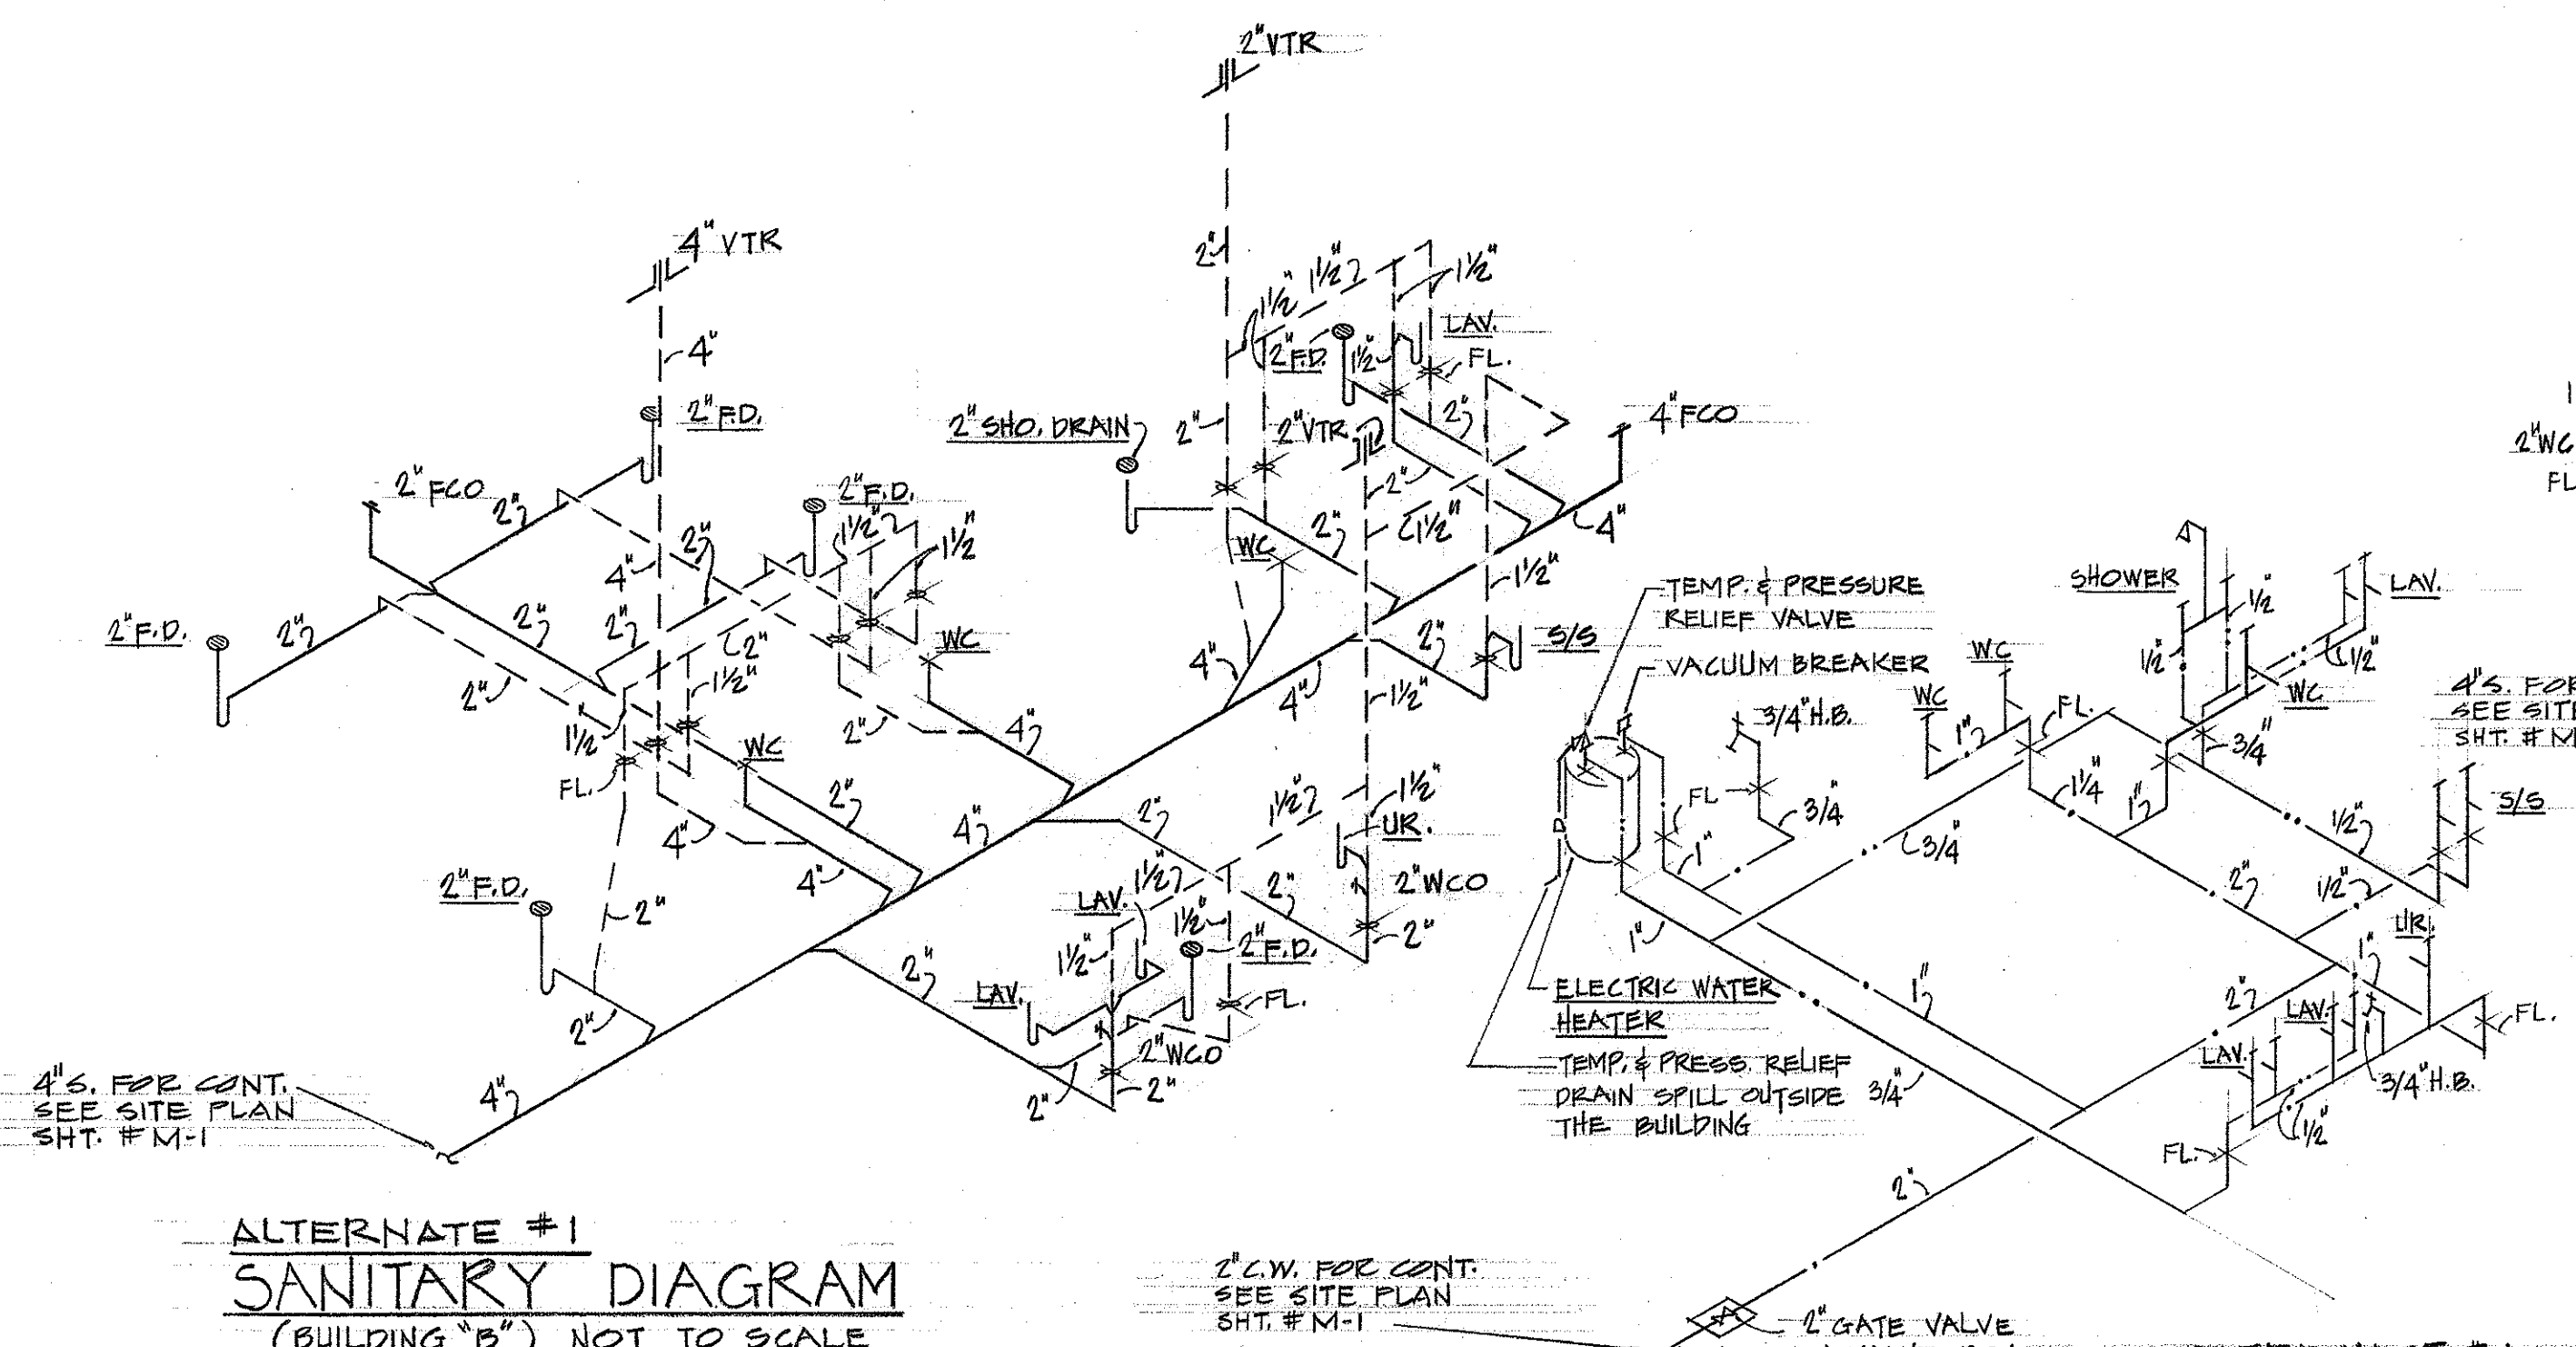


ALTERNATE #1
SANITARY DIAGRAM
(BUILDING "B") NOT TO SCALE

ALTERNATE #4
SANITARY DIAGRAM
(BUILDING "C") NOT TO SCALE

ALTERNATE #1
HOT & COLD WATER DIAGRAM (BUILDING "B") NOT TO SCALE

ALTERNATE #4
HOT & COLD WATER DIAGRAM
(BUILDING "C") NOT TO SCALE

DATE	
SURVEY PLOTTED BY	
DRAWN BY	
CHECKED BY	
NOTE BOOK	
NO.	

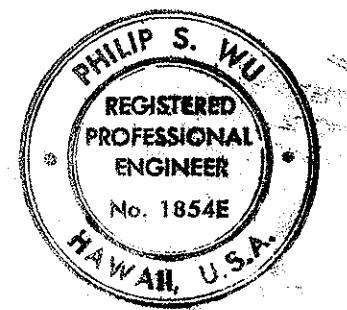

THIS WORK WAS PREPARED BY
ME OR UNDER MY SUPERVISION.
Philip S. Wu

STATE OF HAWAII DEPARTMENT OF TRANSPORTATION HIGHWAYS DIVISION	
KAUAI STATE HIGHWAY - COUNTY BASE YARD KAPAA KAUAI	
FLOOR PLANS - BLDGS. B & C DETAILS AND PIPING DIAGRAMS	
SCALE AS NOTED	BD65-363
DATE JULY 1972	
SHEET No. 36 OF 41 SHEETS	

M4