


FED. ROAD DIST. NO.	STATE	PROJ. NO.	FISCAL YEAR	SHEET NO.	TOTAL SHEETS
HAWAII	HAW.	LT-K-05-78		13	22


PHASE III

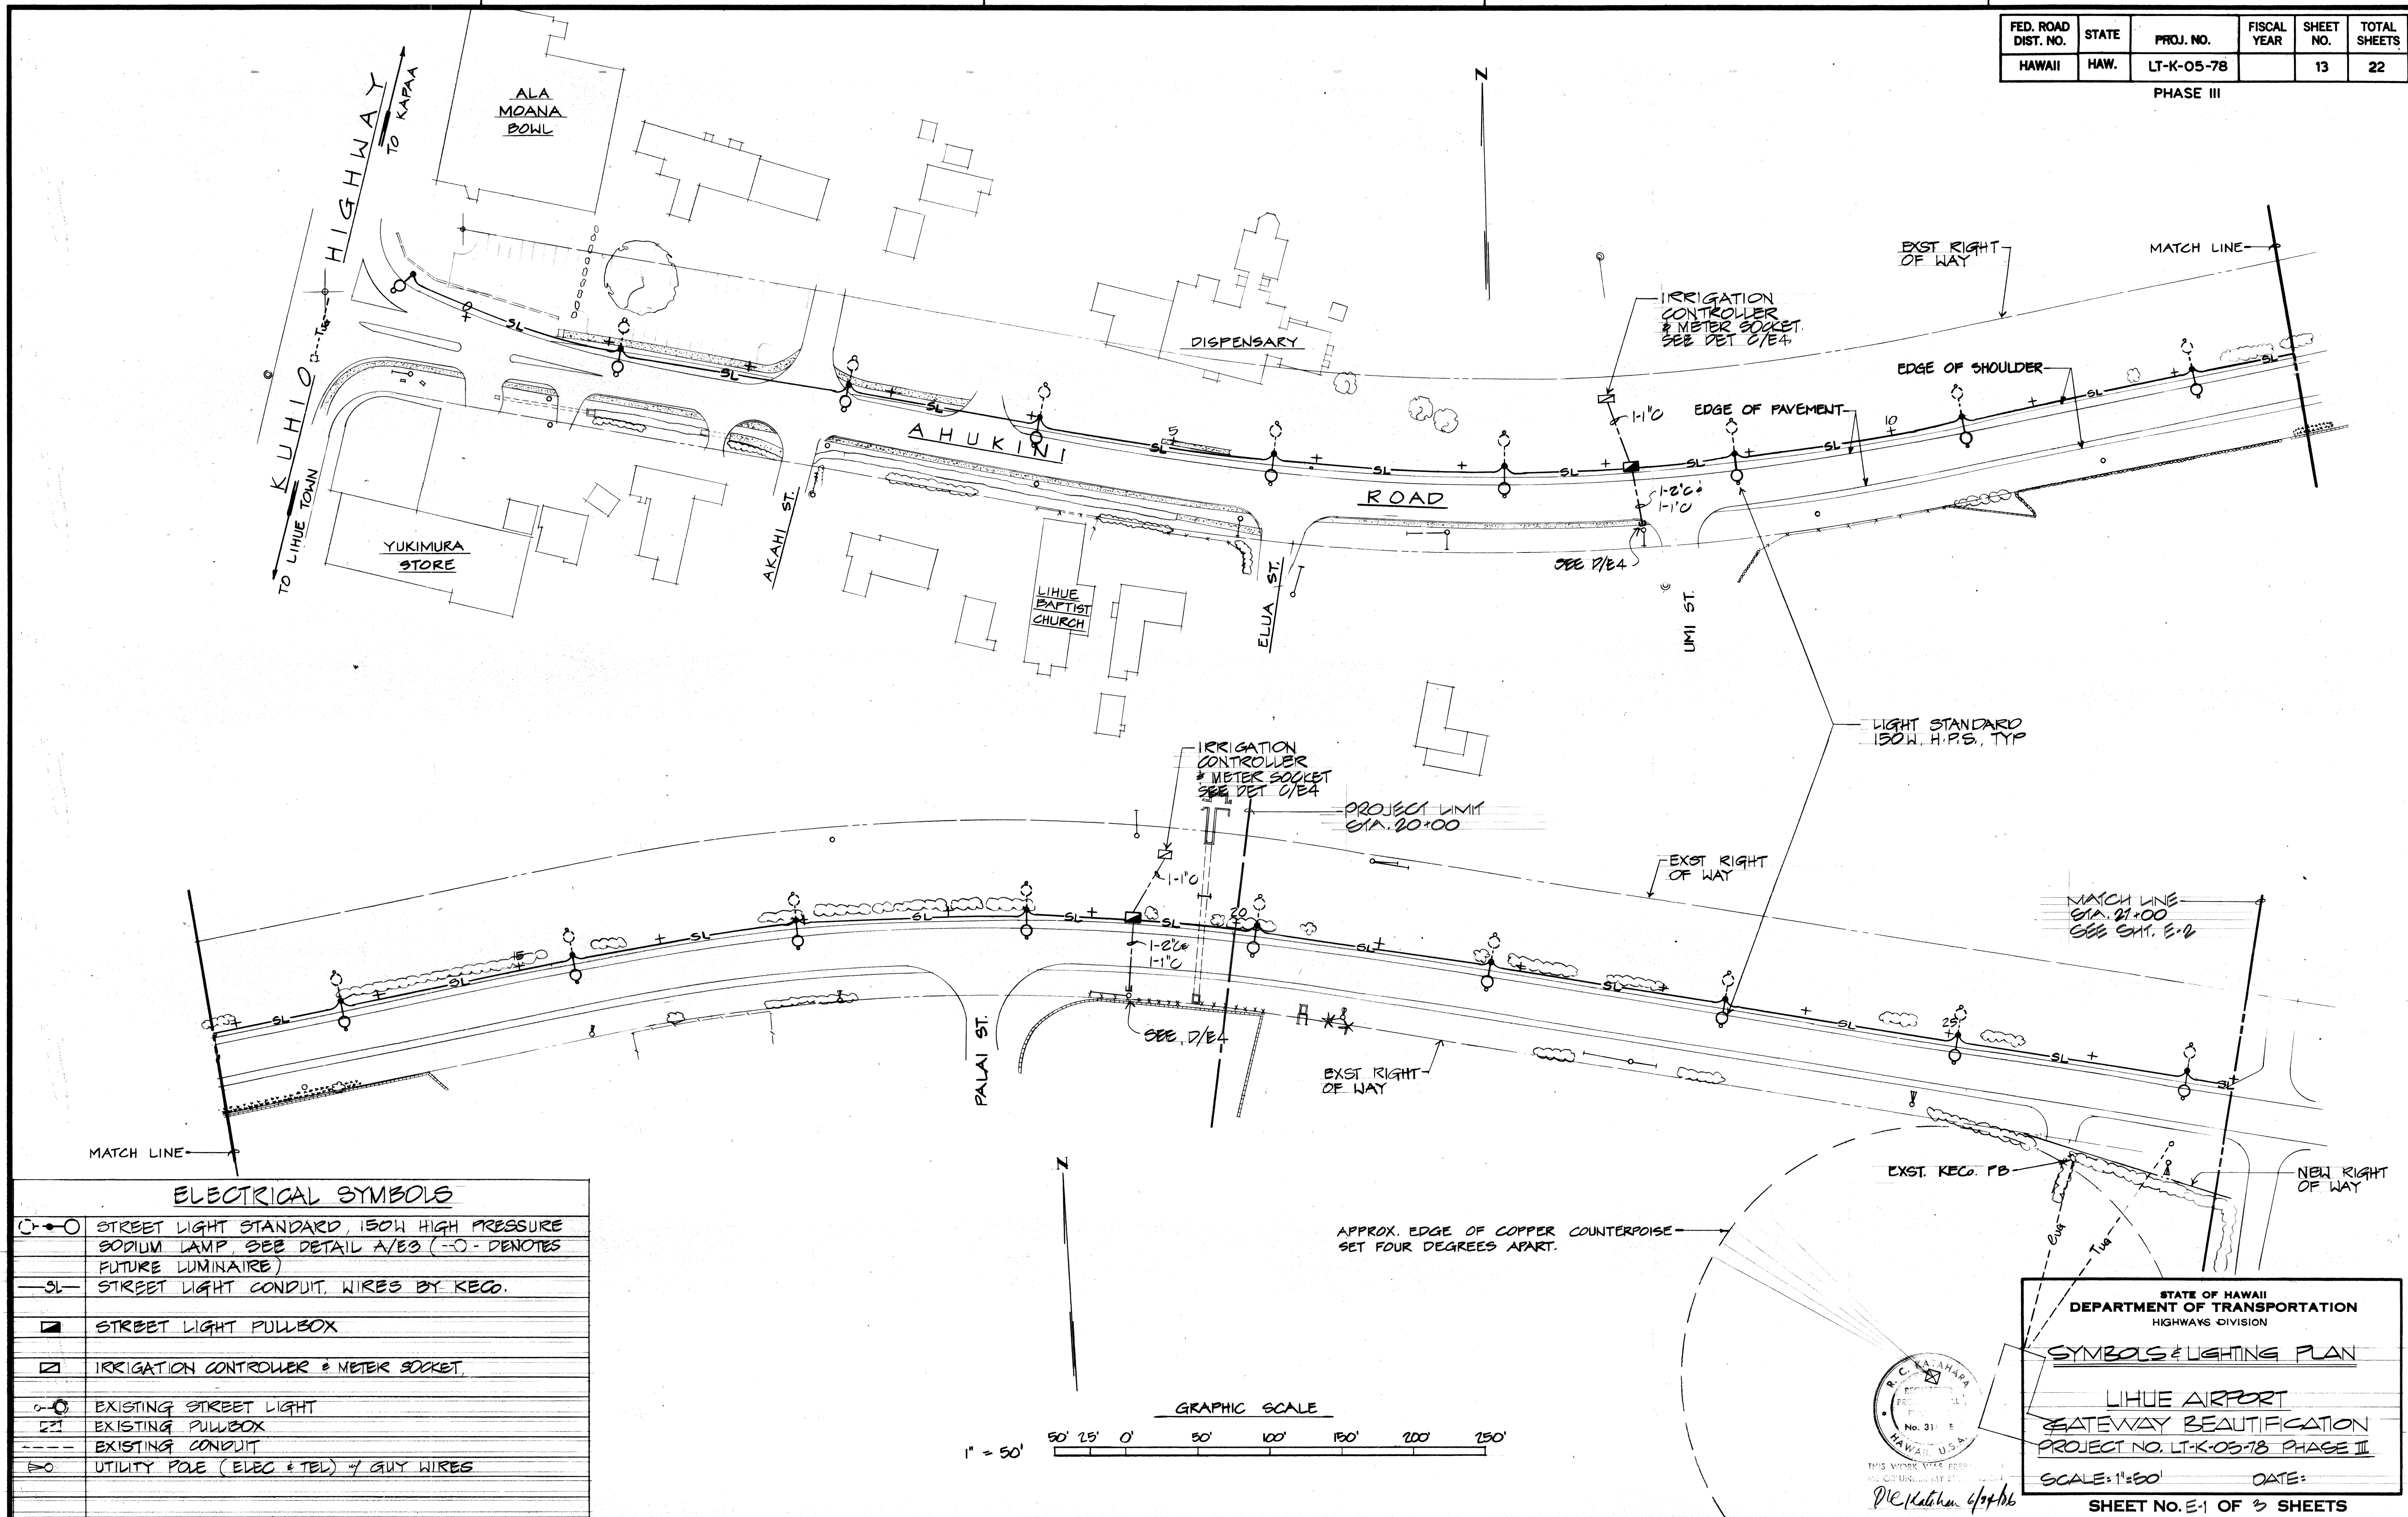

ELECTRICAL SYMBOLS

	STREET LIGHT STANDARD, 150W HIGH PRESSURE SODIUM LAMP, SEE DETAIL A/E3 (-O- DENOTES FUTURE LUMINAIRE)
	STREET LIGHT CONDUIT, WIRES BY KECO.
	STREET LIGHT PULLBOX
	IRRIGATION CONTROLLER & METER SOCKET
	EXISTING STREET LIGHT
	EXISTING PULLBOX
	EXISTING CONDUIT
	UTILITY POLE (ELEC & TEL) & GUY WIRES

 GRAPHIC SCALE



STATE OF HAWAII
DEPARTMENT OF TRANSPORTATION
HIGHWAYS DIVISION

SYMBOLS & LIGHTING PLAN


LIHUE AIRPORT
GATEWAY BEAUTIFICATION
PROJECT NO. LT-K-05-78 PHASE III

SCALE: 1"=50' DATE:


SHEET NO. E-1 OF 3 SHEETS

FED. ROAD DIST. NO.	STATE	PROJ. NO.	FISCAL YEAR	SHEET NO.	TOTAL SHEETS
HAWAII	HAW.	LT-K-05-78		14	22

PHASE III

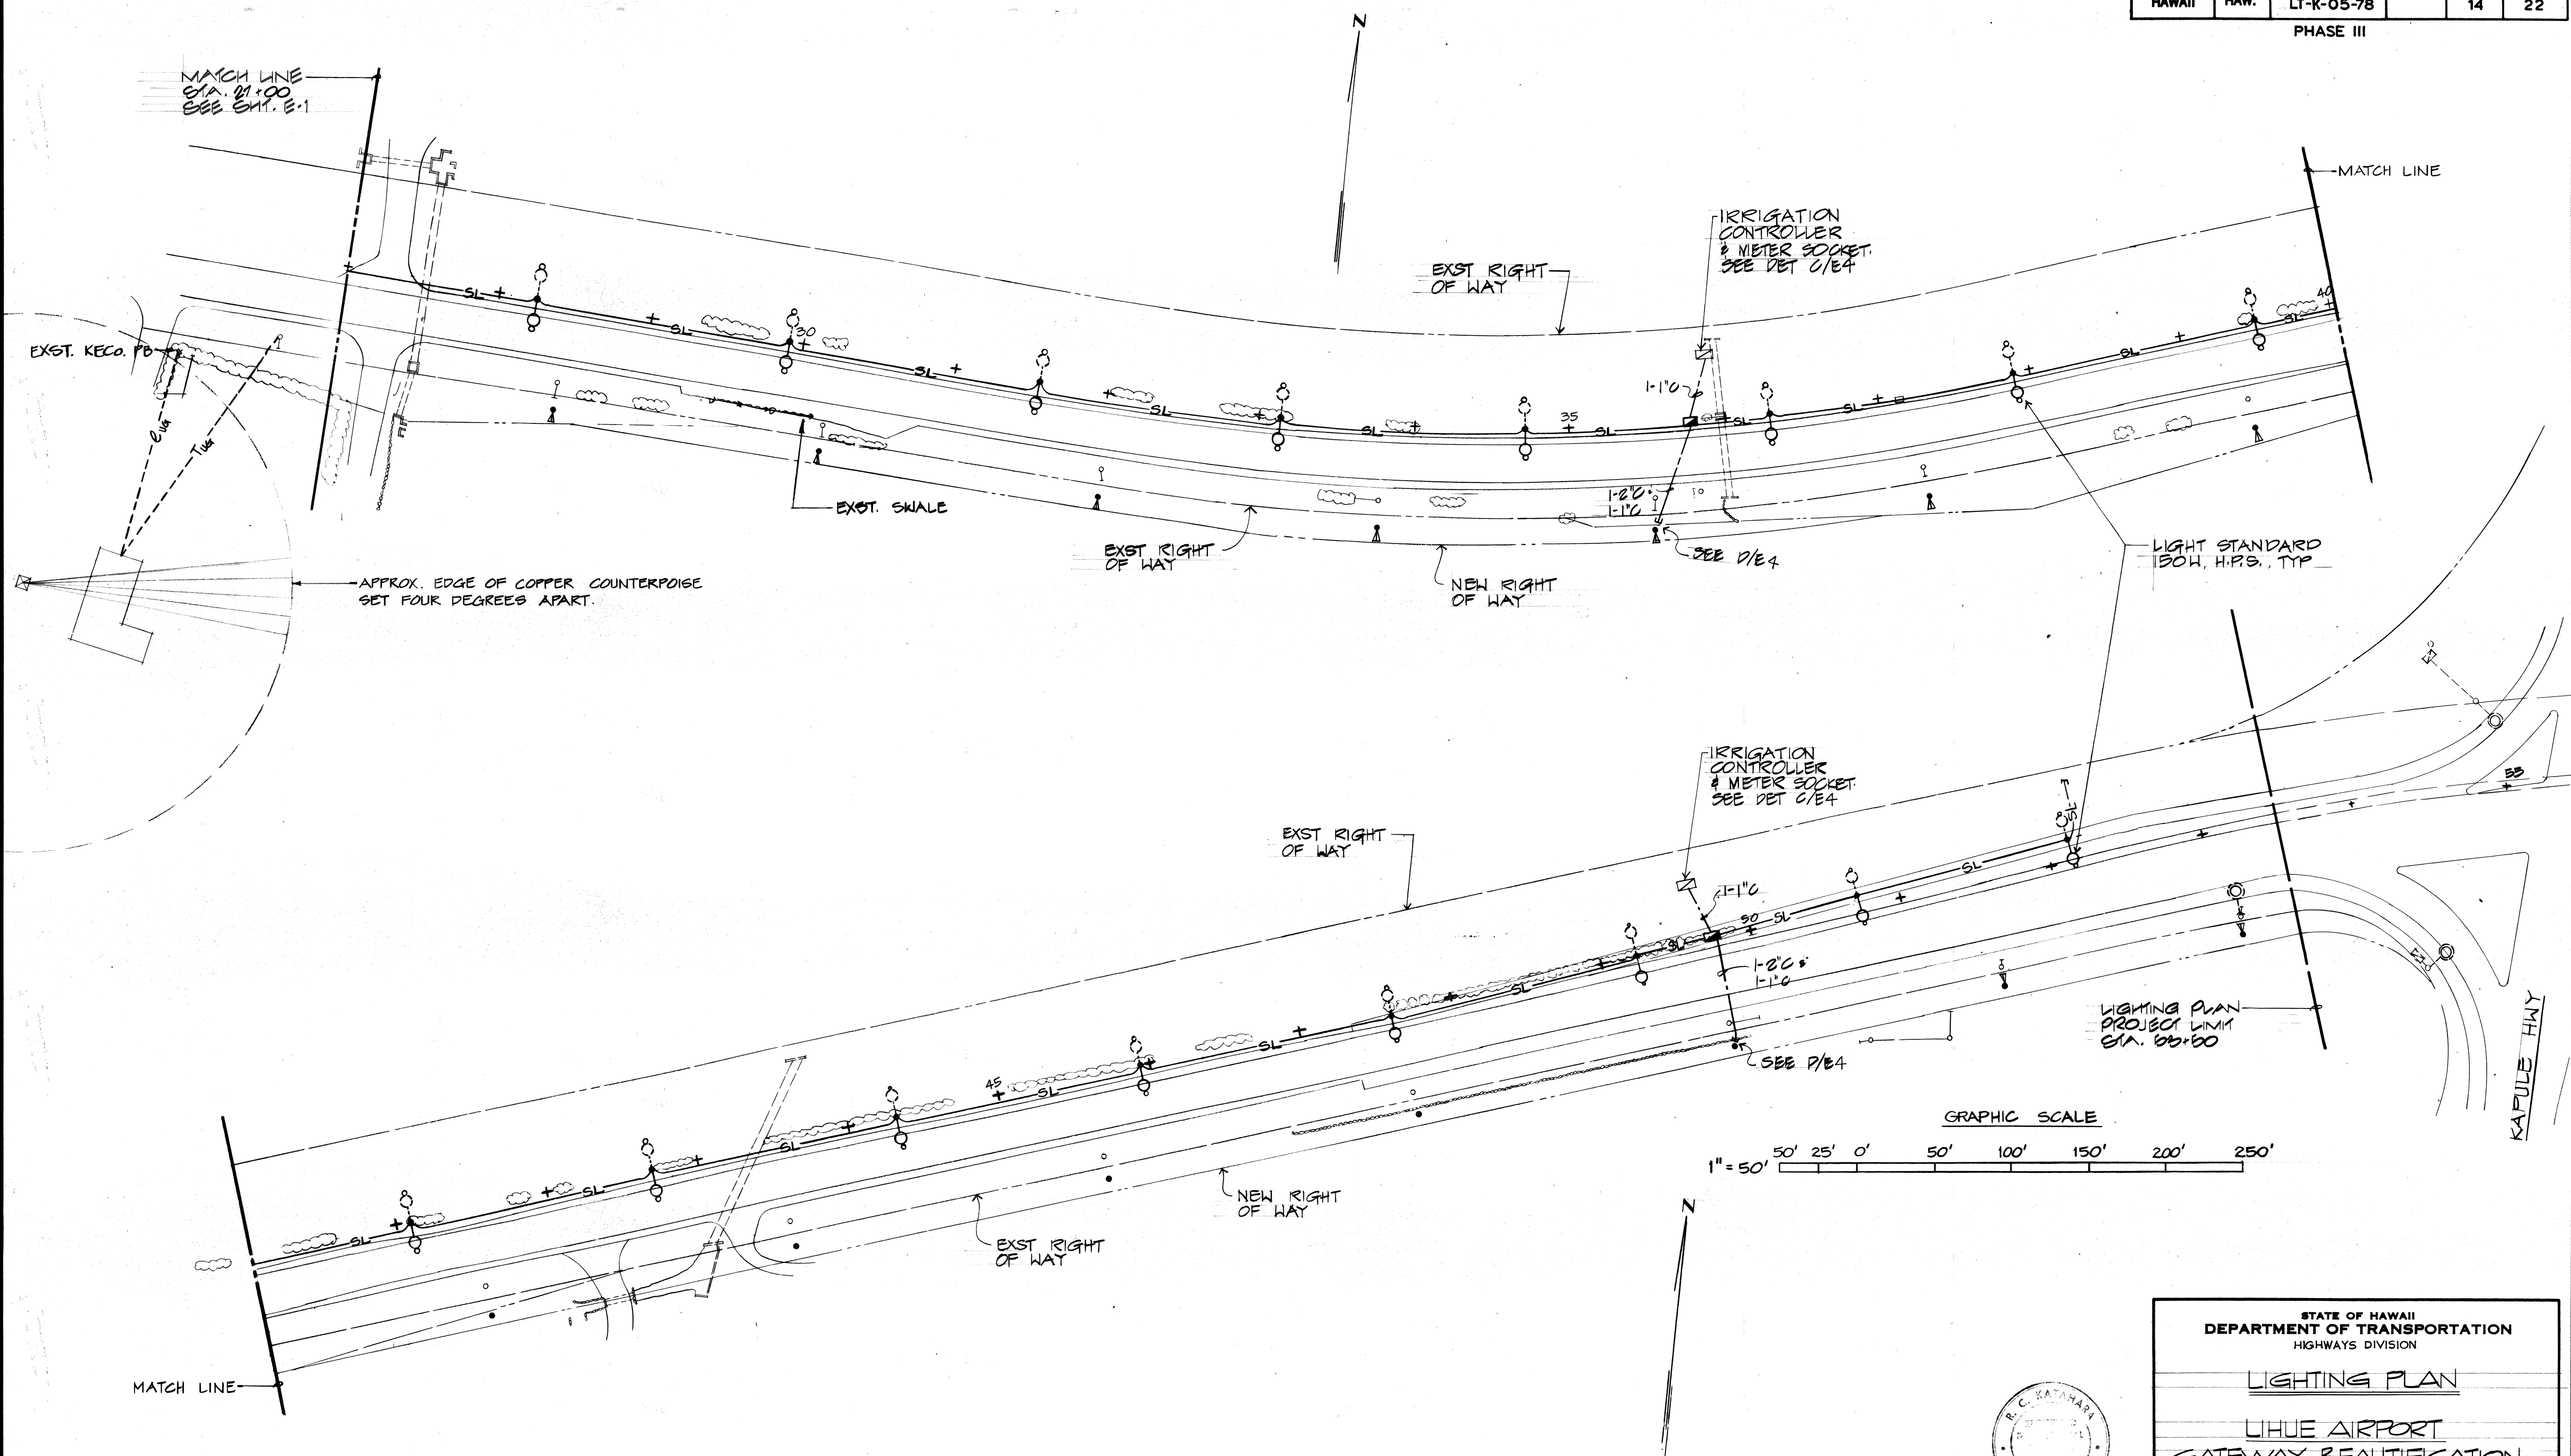

DATE	_____
SURVEY PLOTTED BY	_____
DESIGNED BY	_____
QUANTITIES BY	_____
CHECKED BY	_____
NOTE BOOK	_____
NO.	_____

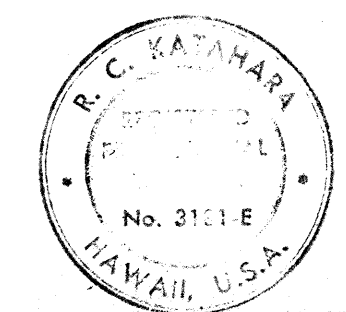

THIS WORK WAS PREPARED BY
ME OR UNDER MY SUPERVISION
R.C. Kahane 4/17/86

STATE OF HAWAII
DEPARTMENT OF TRANSPORTATION
HIGHWAYS DIVISION

LIGHTING PLAN

LIHUE AIRPORT

GATEWAY BEAUTIFICATION

PROJECT NO. LT-K-05-78 PHASE II

SCALE: 1"=50' DATE: _____

SHEET NO. E2 OF 3 SHEETS