

| INDEX TO DRAWINGS | |
|-------------------|--|
| SHEET NO. | DESCRIPTION |
| 1 | TITLE SHEET |
| 2-3 | PLAN AND PROFILE |
| 4 | TYPICAL SECTIONS |
| 5-8 | CULVERT EXTENSION DETAILS |
| 9 | WATER SYSTEM DETAILS |
| 10-12 | CROSS SECTIONS |
| 13 | SYMBOLS AND LIGHTING PLAN |
| 14 | LIGHTING PLAN |
| 15 | MISCELLANEOUS DETAILS |
| 16-17 | PARTIAL IRRIGATION PLAN |
| 18 | DRIP IRRIGATION PLAN |
| 19 | IRRIGATION DETAILS |
| 20 | IRRIG. LEGEND, CONTROLLER SCH. & DETAILS |
| 21 | PLANTING PLAN |
| 22 | PLANT LIST AND DETAILS |

| FED. ROAD DIST. NO. | STATE | PROJ. NO. | FISCAL YEAR | SHEET NO. | TOTAL SHEETS |
|---------------------|-------|------------|-------------|-----------|--------------|
| HAWAII | HAW. | LT-K-05-78 | | 1 | 22 |

PHASE III

STATE OF HAWAII
DEPARTMENT OF TRANSPORTATION
HIGHWAYS DIVISION
HONOLULU, HAWAII



PLANS FOR

LIHUE AIRPORT GATEWAY BEAUTIFICATION

AHUKINI ROAD

PROJECT NO. LT-K-05-78
PHASE III
DISTRICT OF LIHUE

ISLAND OF KAUAI

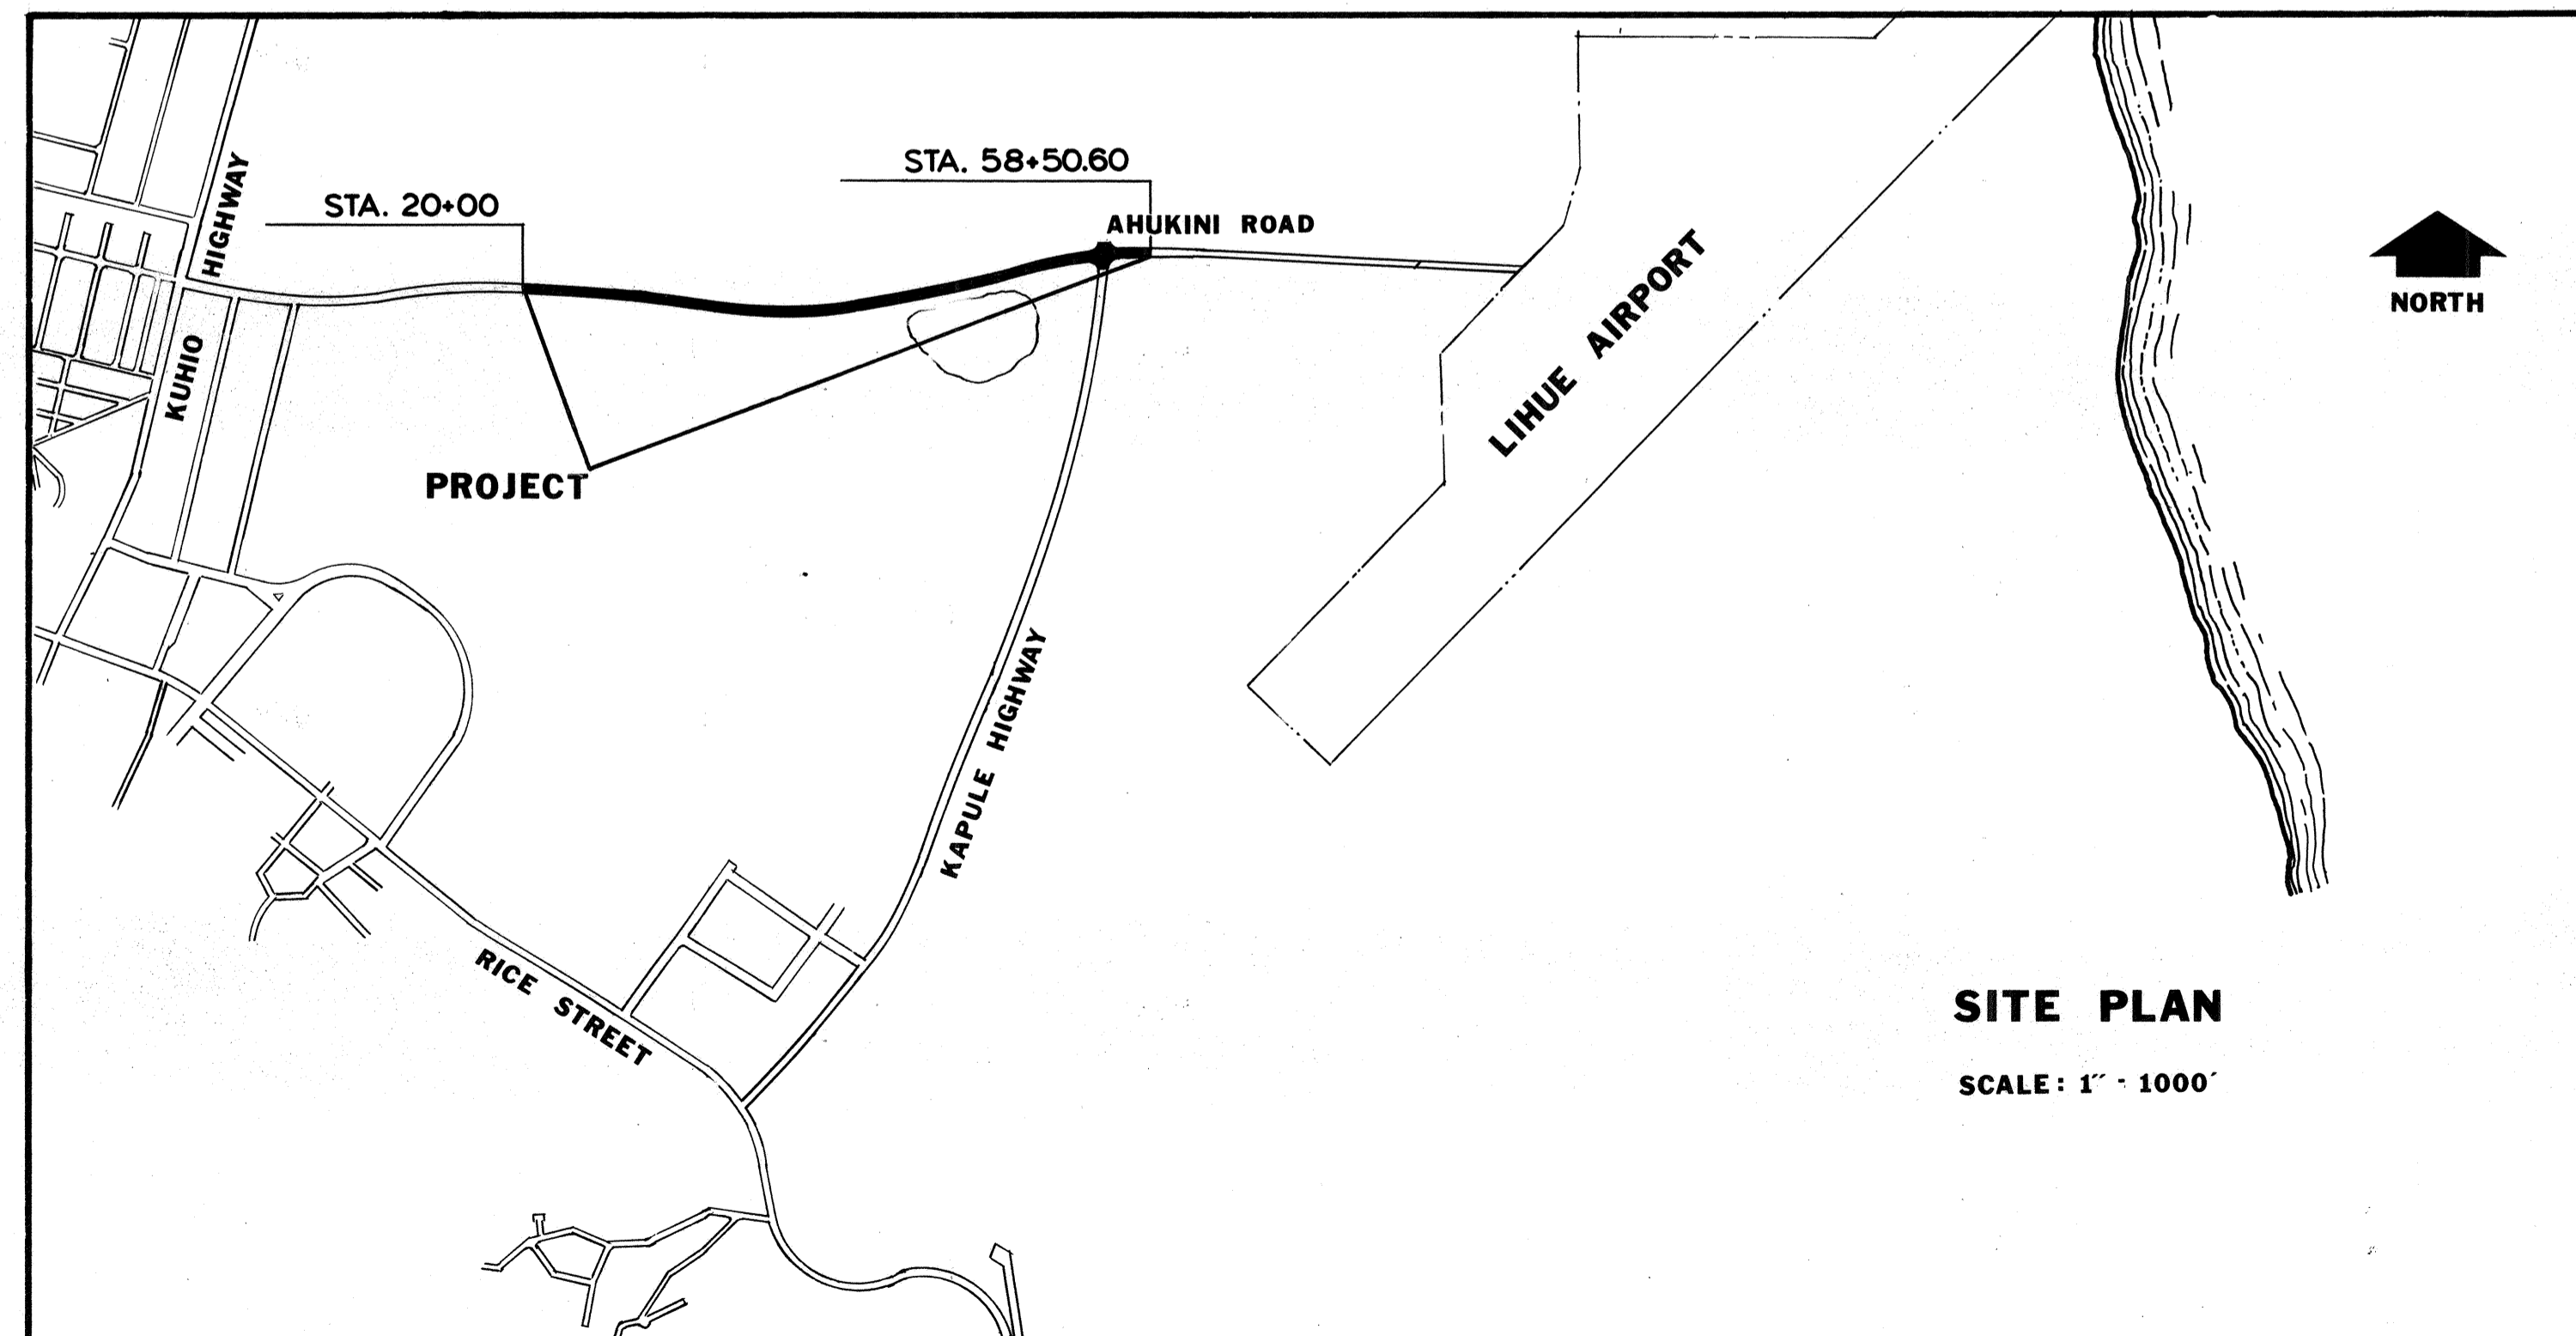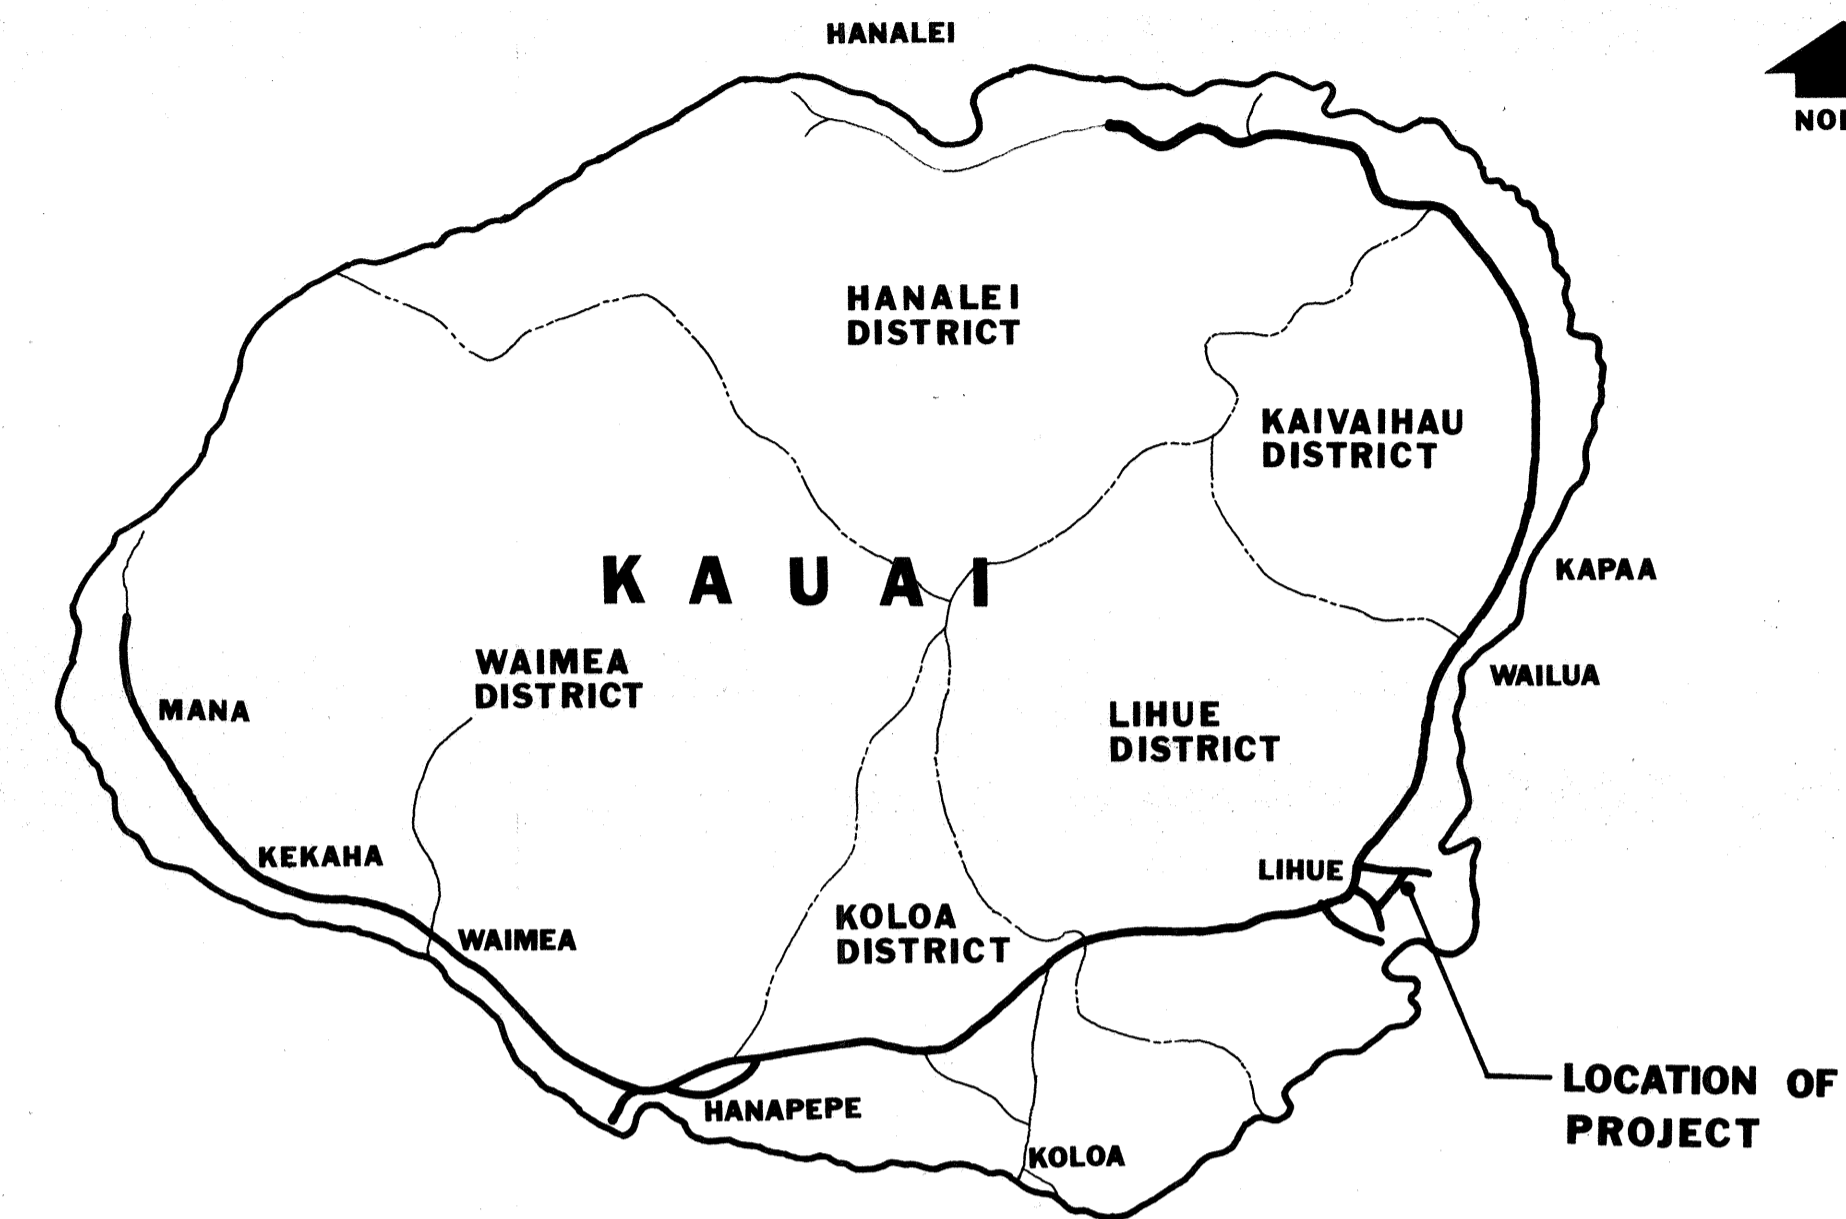

DEPARTMENT OF TRANSPORTATION
 STATE OF HAWAII
 APPROVED BY: _____
 DIRECTOR OF TRANSPORTATION DATE _____

SURVEY ELICITED BY _____ DATE _____
 DRAWN BY _____
 DESIGNED BY _____
 CHECKED BY _____
 ORIGINAL PLAN _____
 NOTE BOOK _____
 No. _____