



FED. ROAD DIST. NO.	STATE	PROJ. NO.	FISCAL YEAR	SHEET NO.	TOTAL SHEETS
HAWAII	HAW.	LT-K-05-78		11	18

PHASE II-A

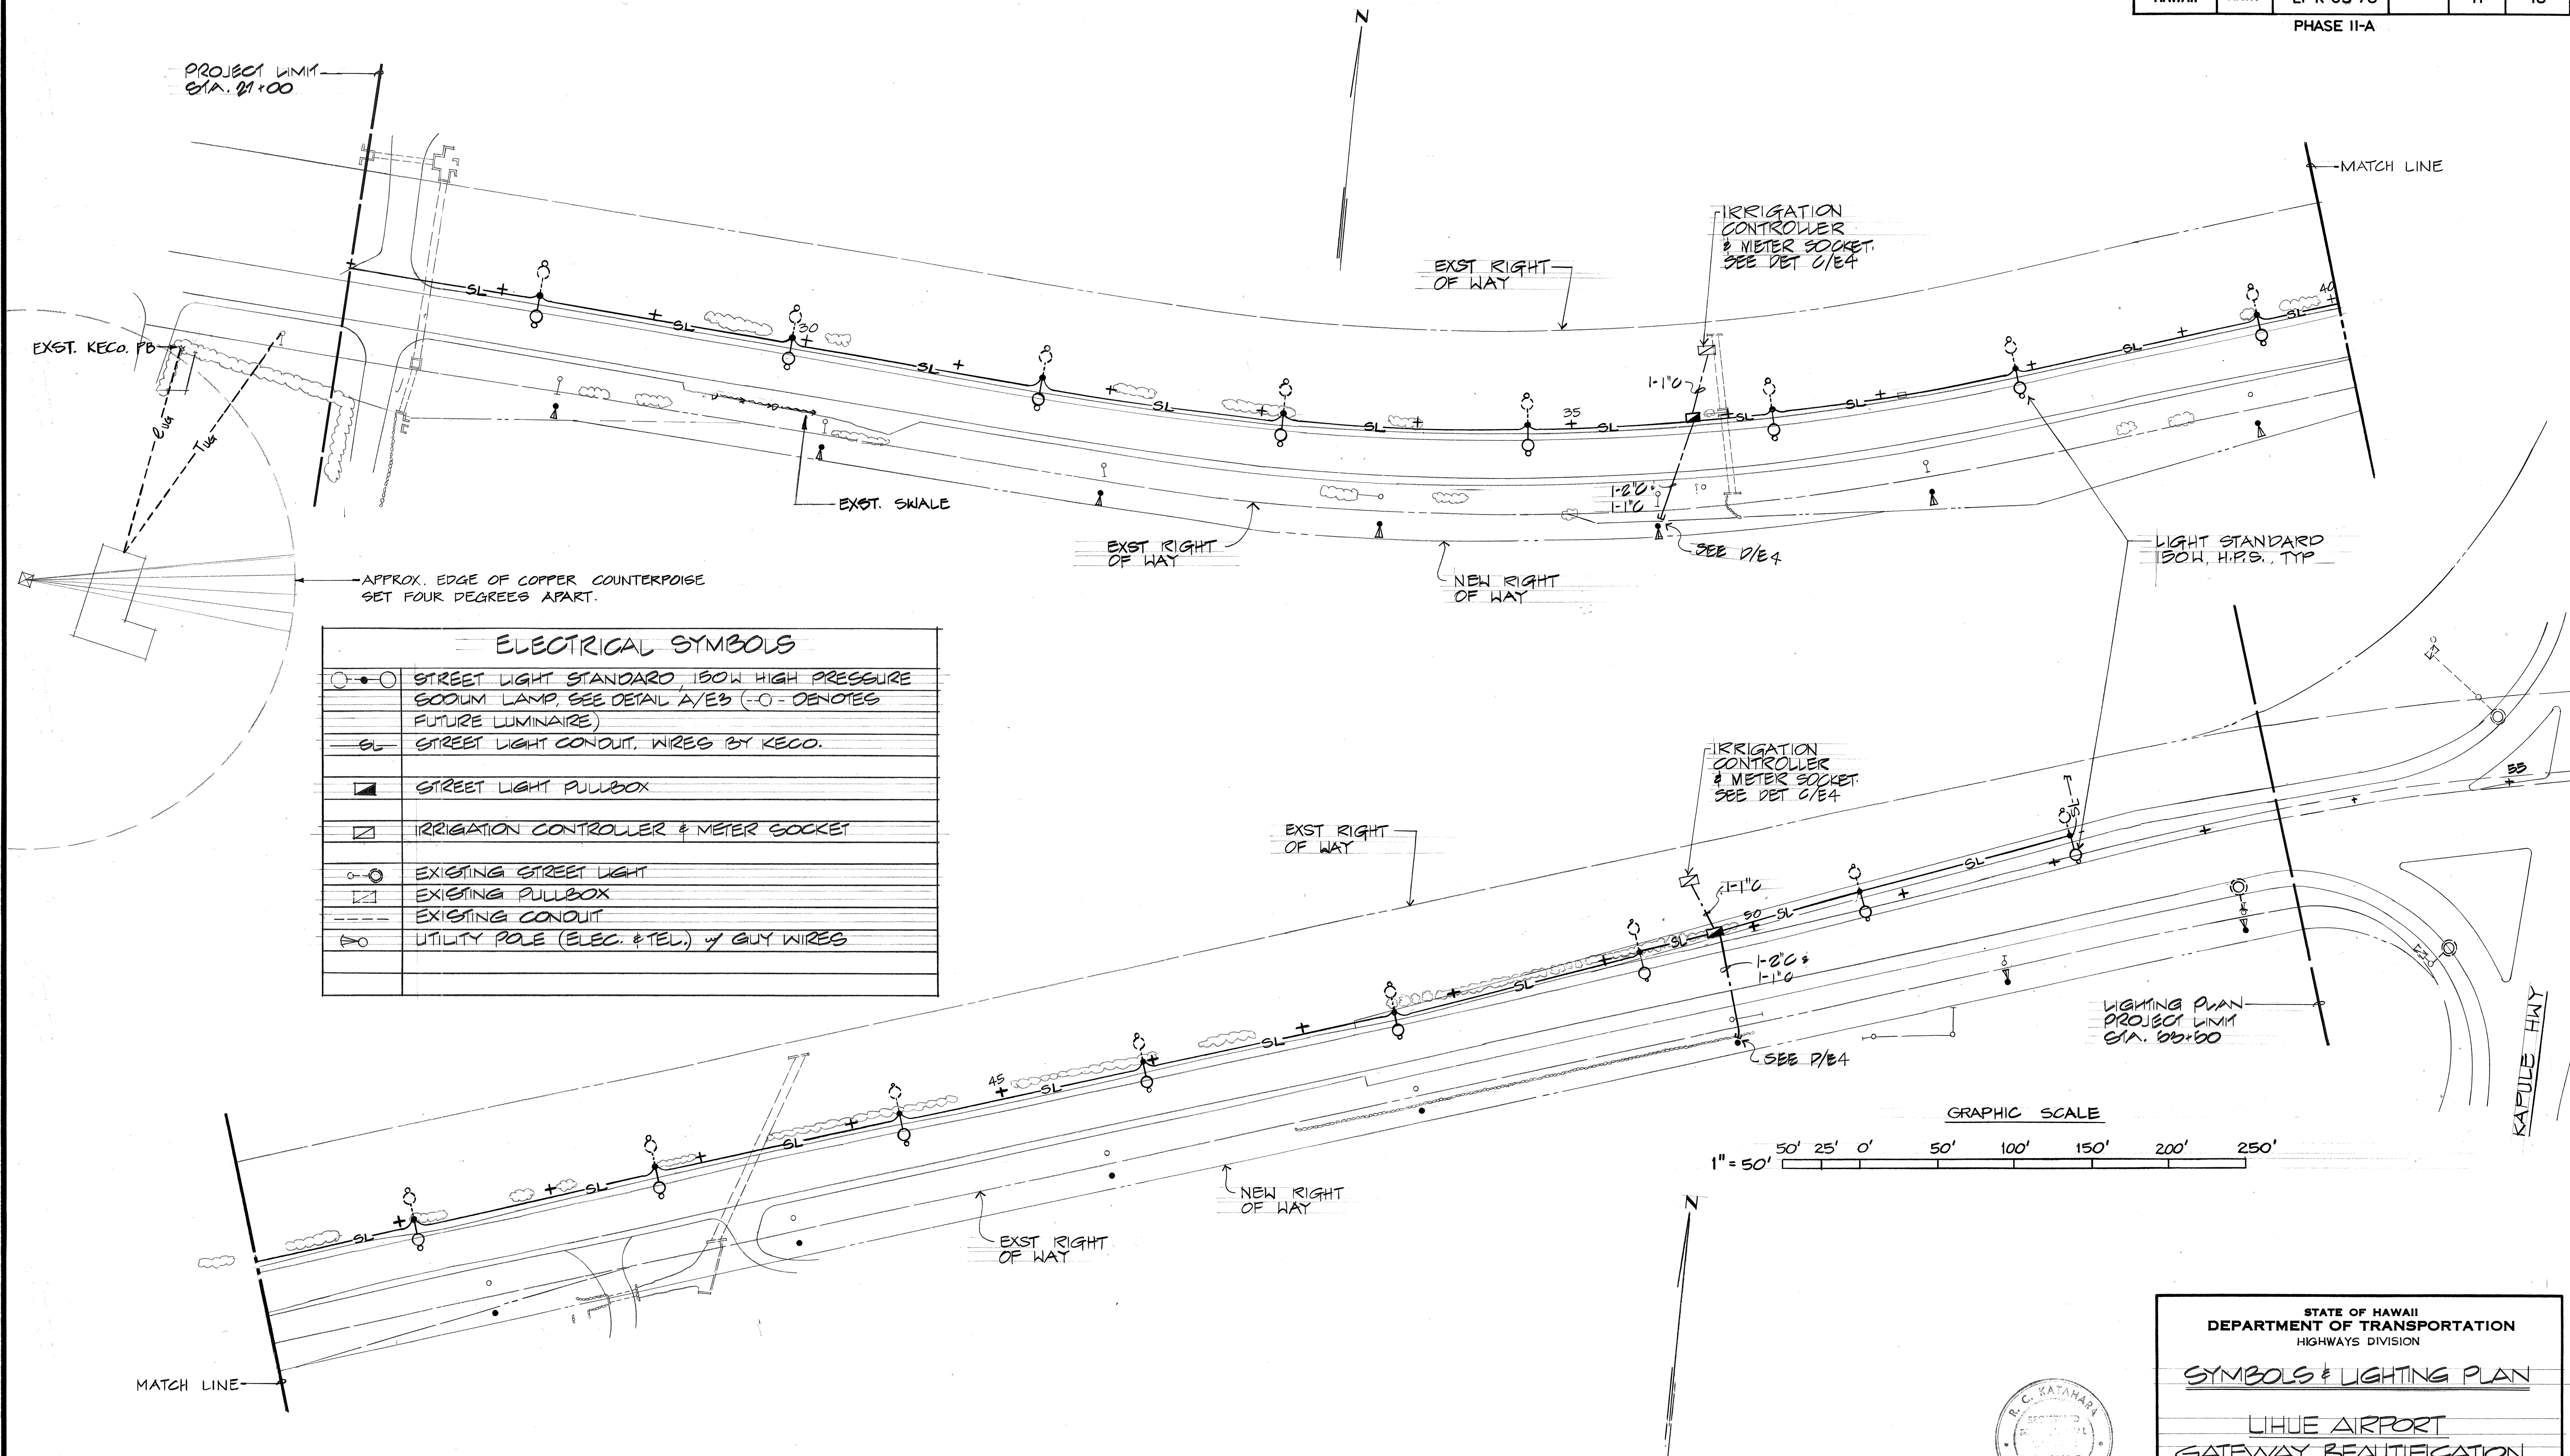

ELECTRICAL SYMBOLS	
	STREET LIGHT STANDARD, 50W HIGH PRESSURE SODIUM LAMP, SEE DETAIL A/E3 (-O- DENOTES FUTURE LUMINAIRE)
	STREET LIGHT CONDUIT, WIRES BY KECO.
	STREET LIGHT PULLBOX
	IRRIGATION CONTROLLER & METER SOCKET
	EXISTING STREET LIGHT
	EXISTING PULLBOX
	EXISTING CONDUIT
	UTILITY POLE (ELEC. & TEL.) & GUY WIRES

DATE	DATE
DESIGNED BY	DESIGNED BY
CHECKED BY	CHECKED BY
NOTED BY	NOTED BY
ORIGINAL PLAN	ORIGINAL PLAN

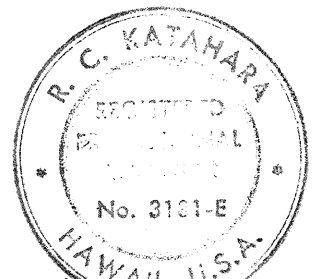

THIS WORK WAS PREPARED BY ME OR UNDER MY SUPERVISION
DATE: 4/24/78
D/C Katakara

STATE OF HAWAII DEPARTMENT OF TRANSPORTATION HIGHWAYS DIVISION
SYMBOLS & LIGHTING PLAN
LIHUE AIRPORT GATEWAY BEAUTIFICATION PROJECT NO. LT-K-05-78 PHASE II-A
SCALE: 1"=50' DATE:
SHEET NO. 11 OF 2 SHEETS