



INDEX TO DRAWINGS	
SHEET NO.	DESCRIPTION
1	TITLE SHEET
2-3	PLAN AND PROFILE
4	TYPICAL SECTIONS
5-8	CULVERT EXTENSION DETAILS
9-10	CROSS SECTIONS
11	SYMBOLS AND LIGHTING PLAN
12	MISCELLANEOUS DETAILS
13	IRRIGATION PLAN
14	DRIP IRRIGATION PLAN
15	IRRIGATION DETAILS
16	IRRIG. LEGEND, CONTROLLER SCH. & DETAILS
17	PLANTING PLAN
18	PLANT LIST AND DETAILS

FED. ROAD DIST. NO.	STATE	PROJ. NO.	FISCAL YEAR	SHEET NO.	TOTAL SHEETS
HAWAII	HAW.	LT-K-05-78		1	18

PHASE II-A

STATE OF HAWAII
DEPARTMENT OF TRANSPORTATION
HIGHWAYS DIVISION
HONOLULU, HAWAII

PLANS FOR
LIHUE AIRPORT GATEWAY BEAUTIFICATION
AHUKINI ROAD
PROJECT NO. LT-K-05-78
PHASE II-A
DISTRICT OF LIHUE
ISLAND OF KAUAI

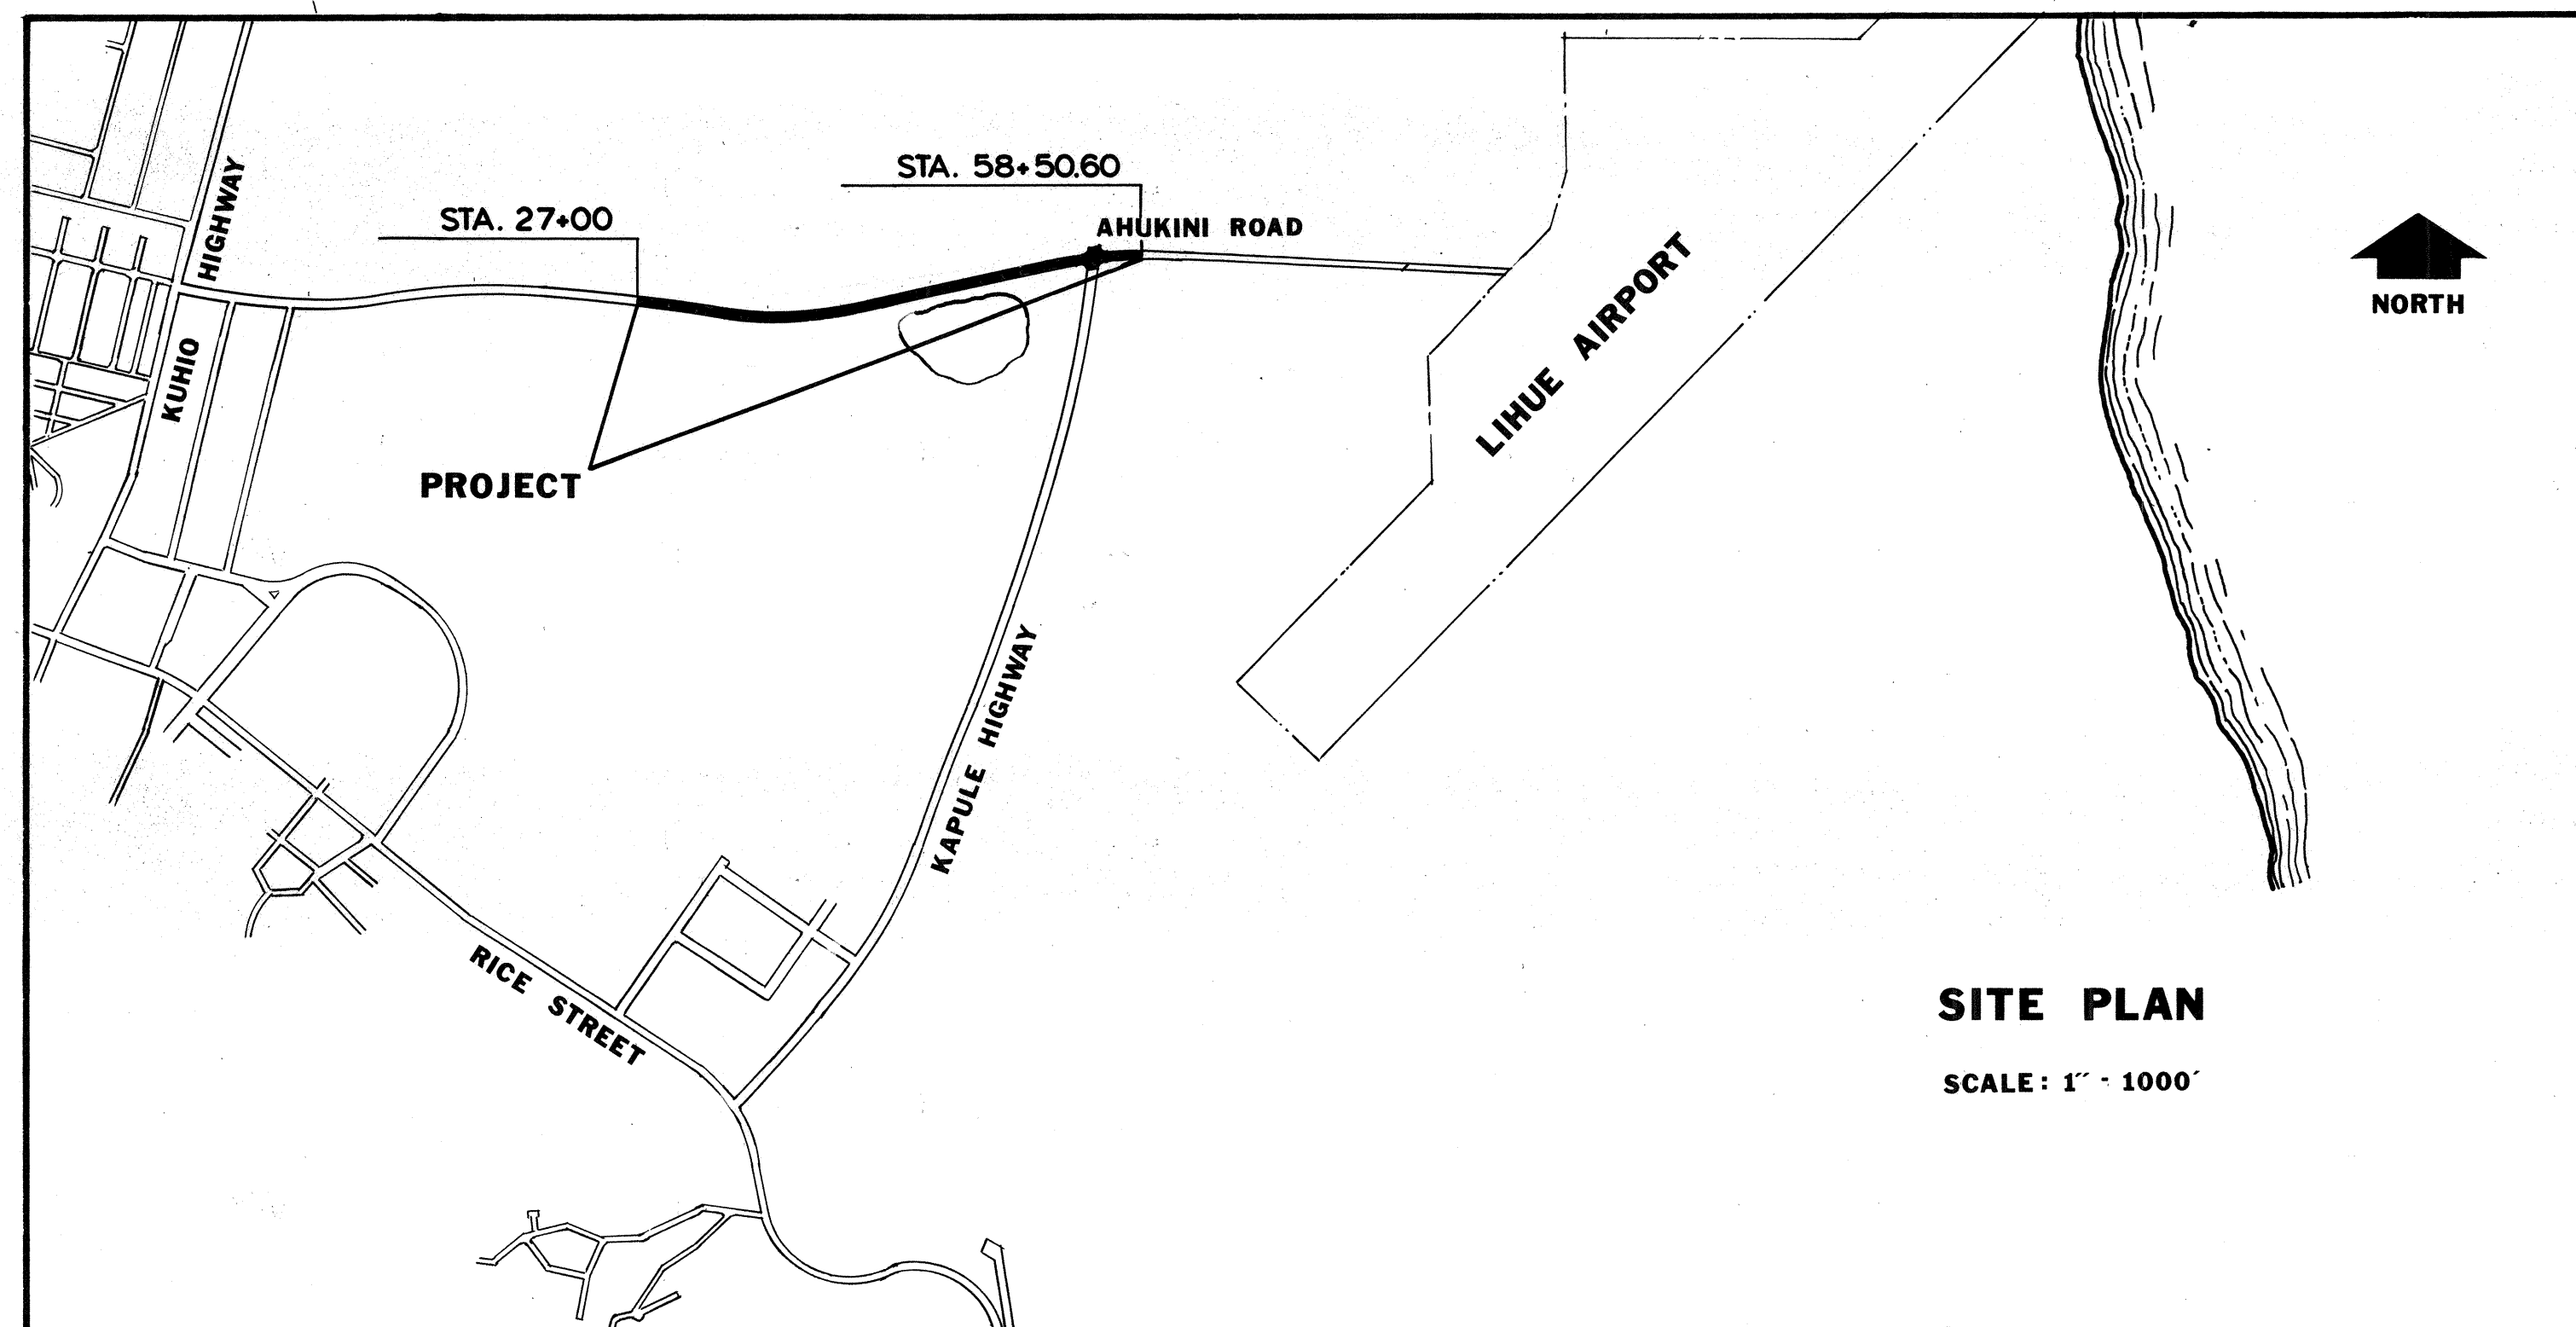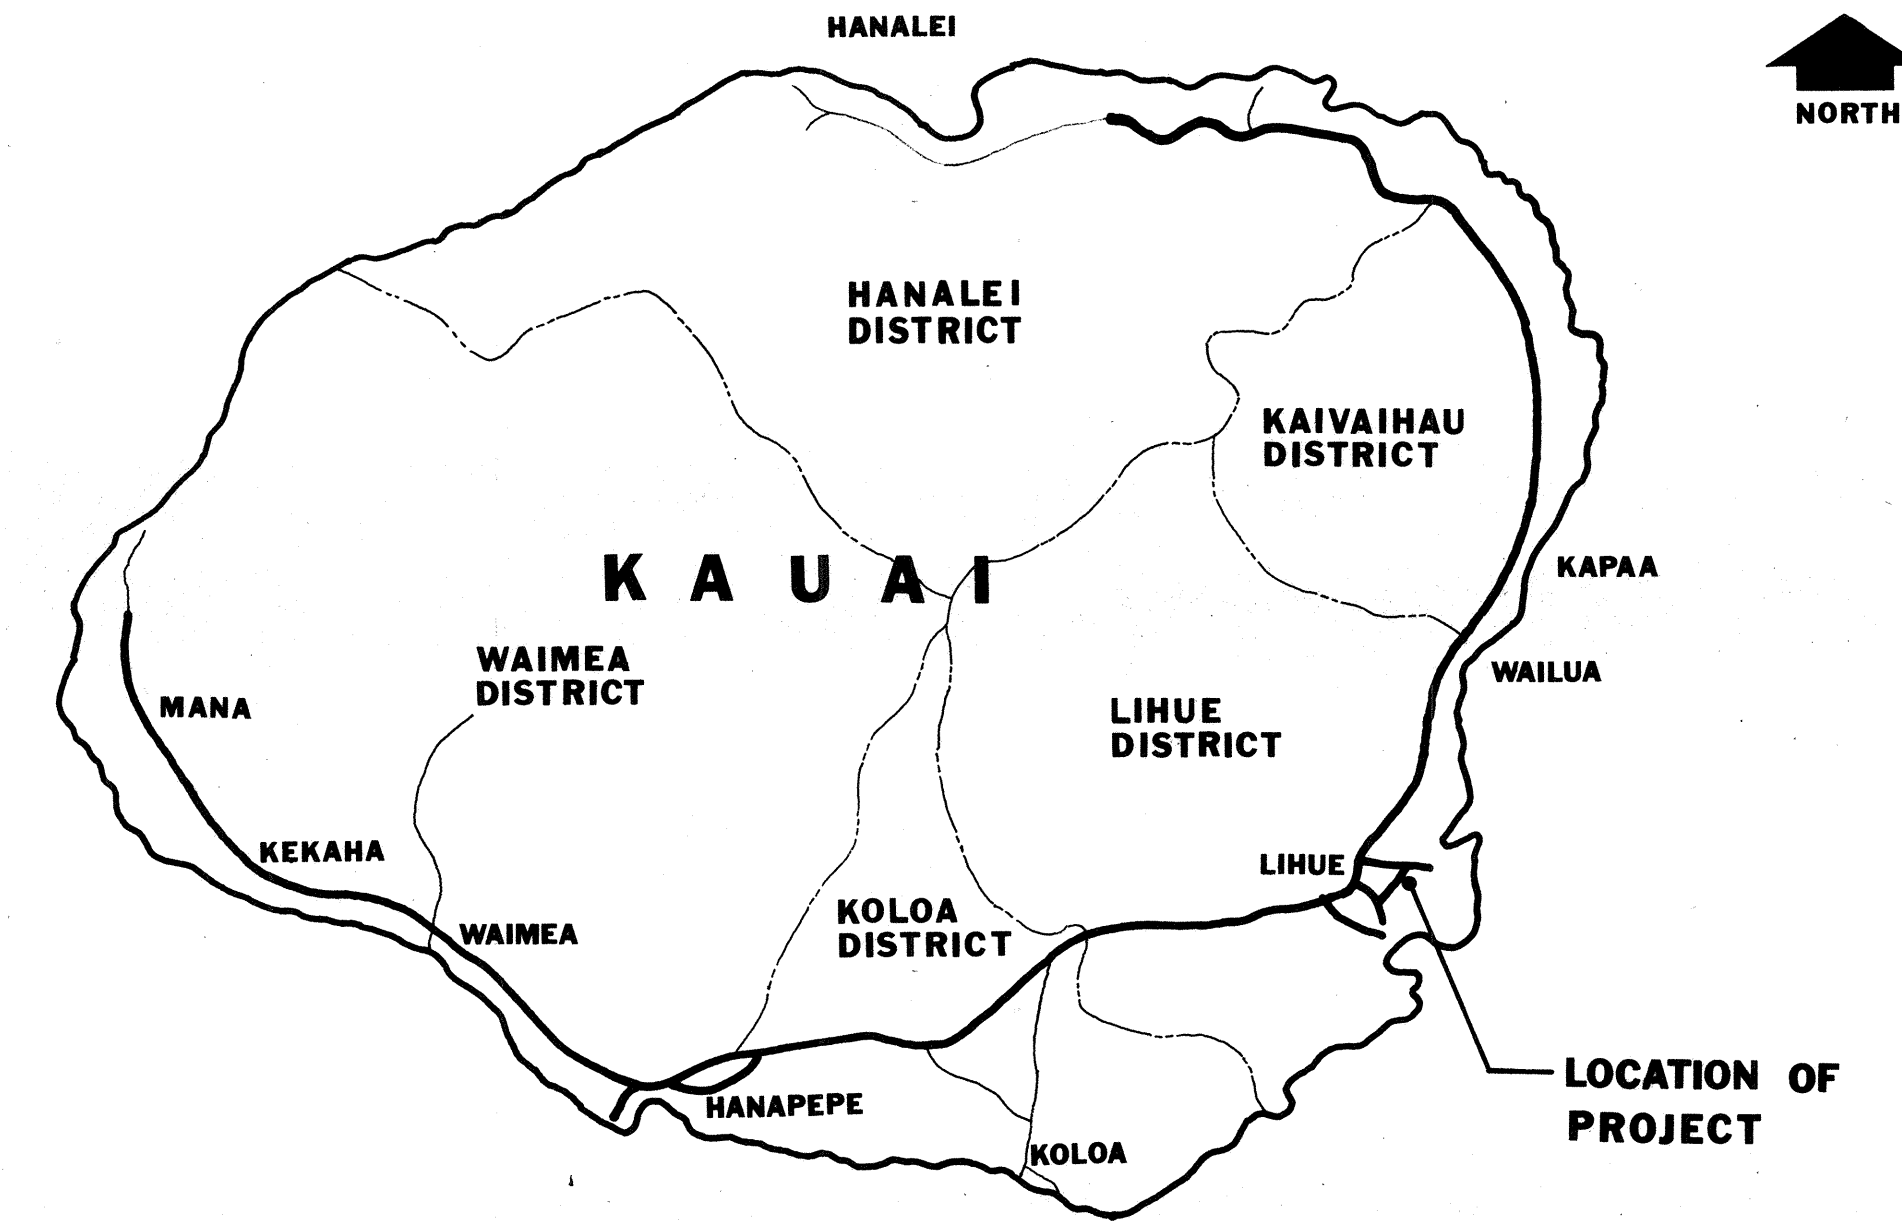

DEPARTMENT OF TRANSPORTATION
STATE OF HAWAII
APPROVED BY: _____
DIRECTOR OF TRANSPORTATION DATE _____

SURVEY PLOTTED BY: _____ DATE: _____
 ORIGINAL PLAN: _____
 DRAWN BY: _____
 NOTE BOOK DESIGNED BY: _____
 QUANTITIES BY: _____
 CHECKED BY: _____
 No. _____