

INDEX TO DRAWINGS	
SHEET NO.	DESCRIPTION
1	TITLE SHEET
2	PLAN AND PROFILE
3	PLAN OF NEW PARKING LOT
4	TYPICAL SECTIONS
5	WATER SYSTEM DETAILS
6	CROSS SECTIONS
7	SYMBOLS AND LIGHTING PLAN
8	MISCELLANEOUS DETAILS
9-10	PARTIAL IRRIGATION PLAN
11	DRIP IRRIGATION PLAN
12	IRRIGATION DETAILS
13	IRRIG. LEGEND, CONTROLLER SCH. & DETAILS
14-15	PARTIAL PLANTING PLAN
16	PLANT LIST AND DETAILS

STATE OF HAWAII

DEPARTMENT OF TRANSPORTATION

HIGHWAYS DIVISION

HONOLULU, HAWAII

PLANS FOR

LIHUE AIRPORT GATEWAY BEAUTIFICATION



AHUKINI ROAD

PROJECT NO. LT-K-05-78

PHASE II-B

DISTRICT OF LIHUE

ISLAND OF KAUAI

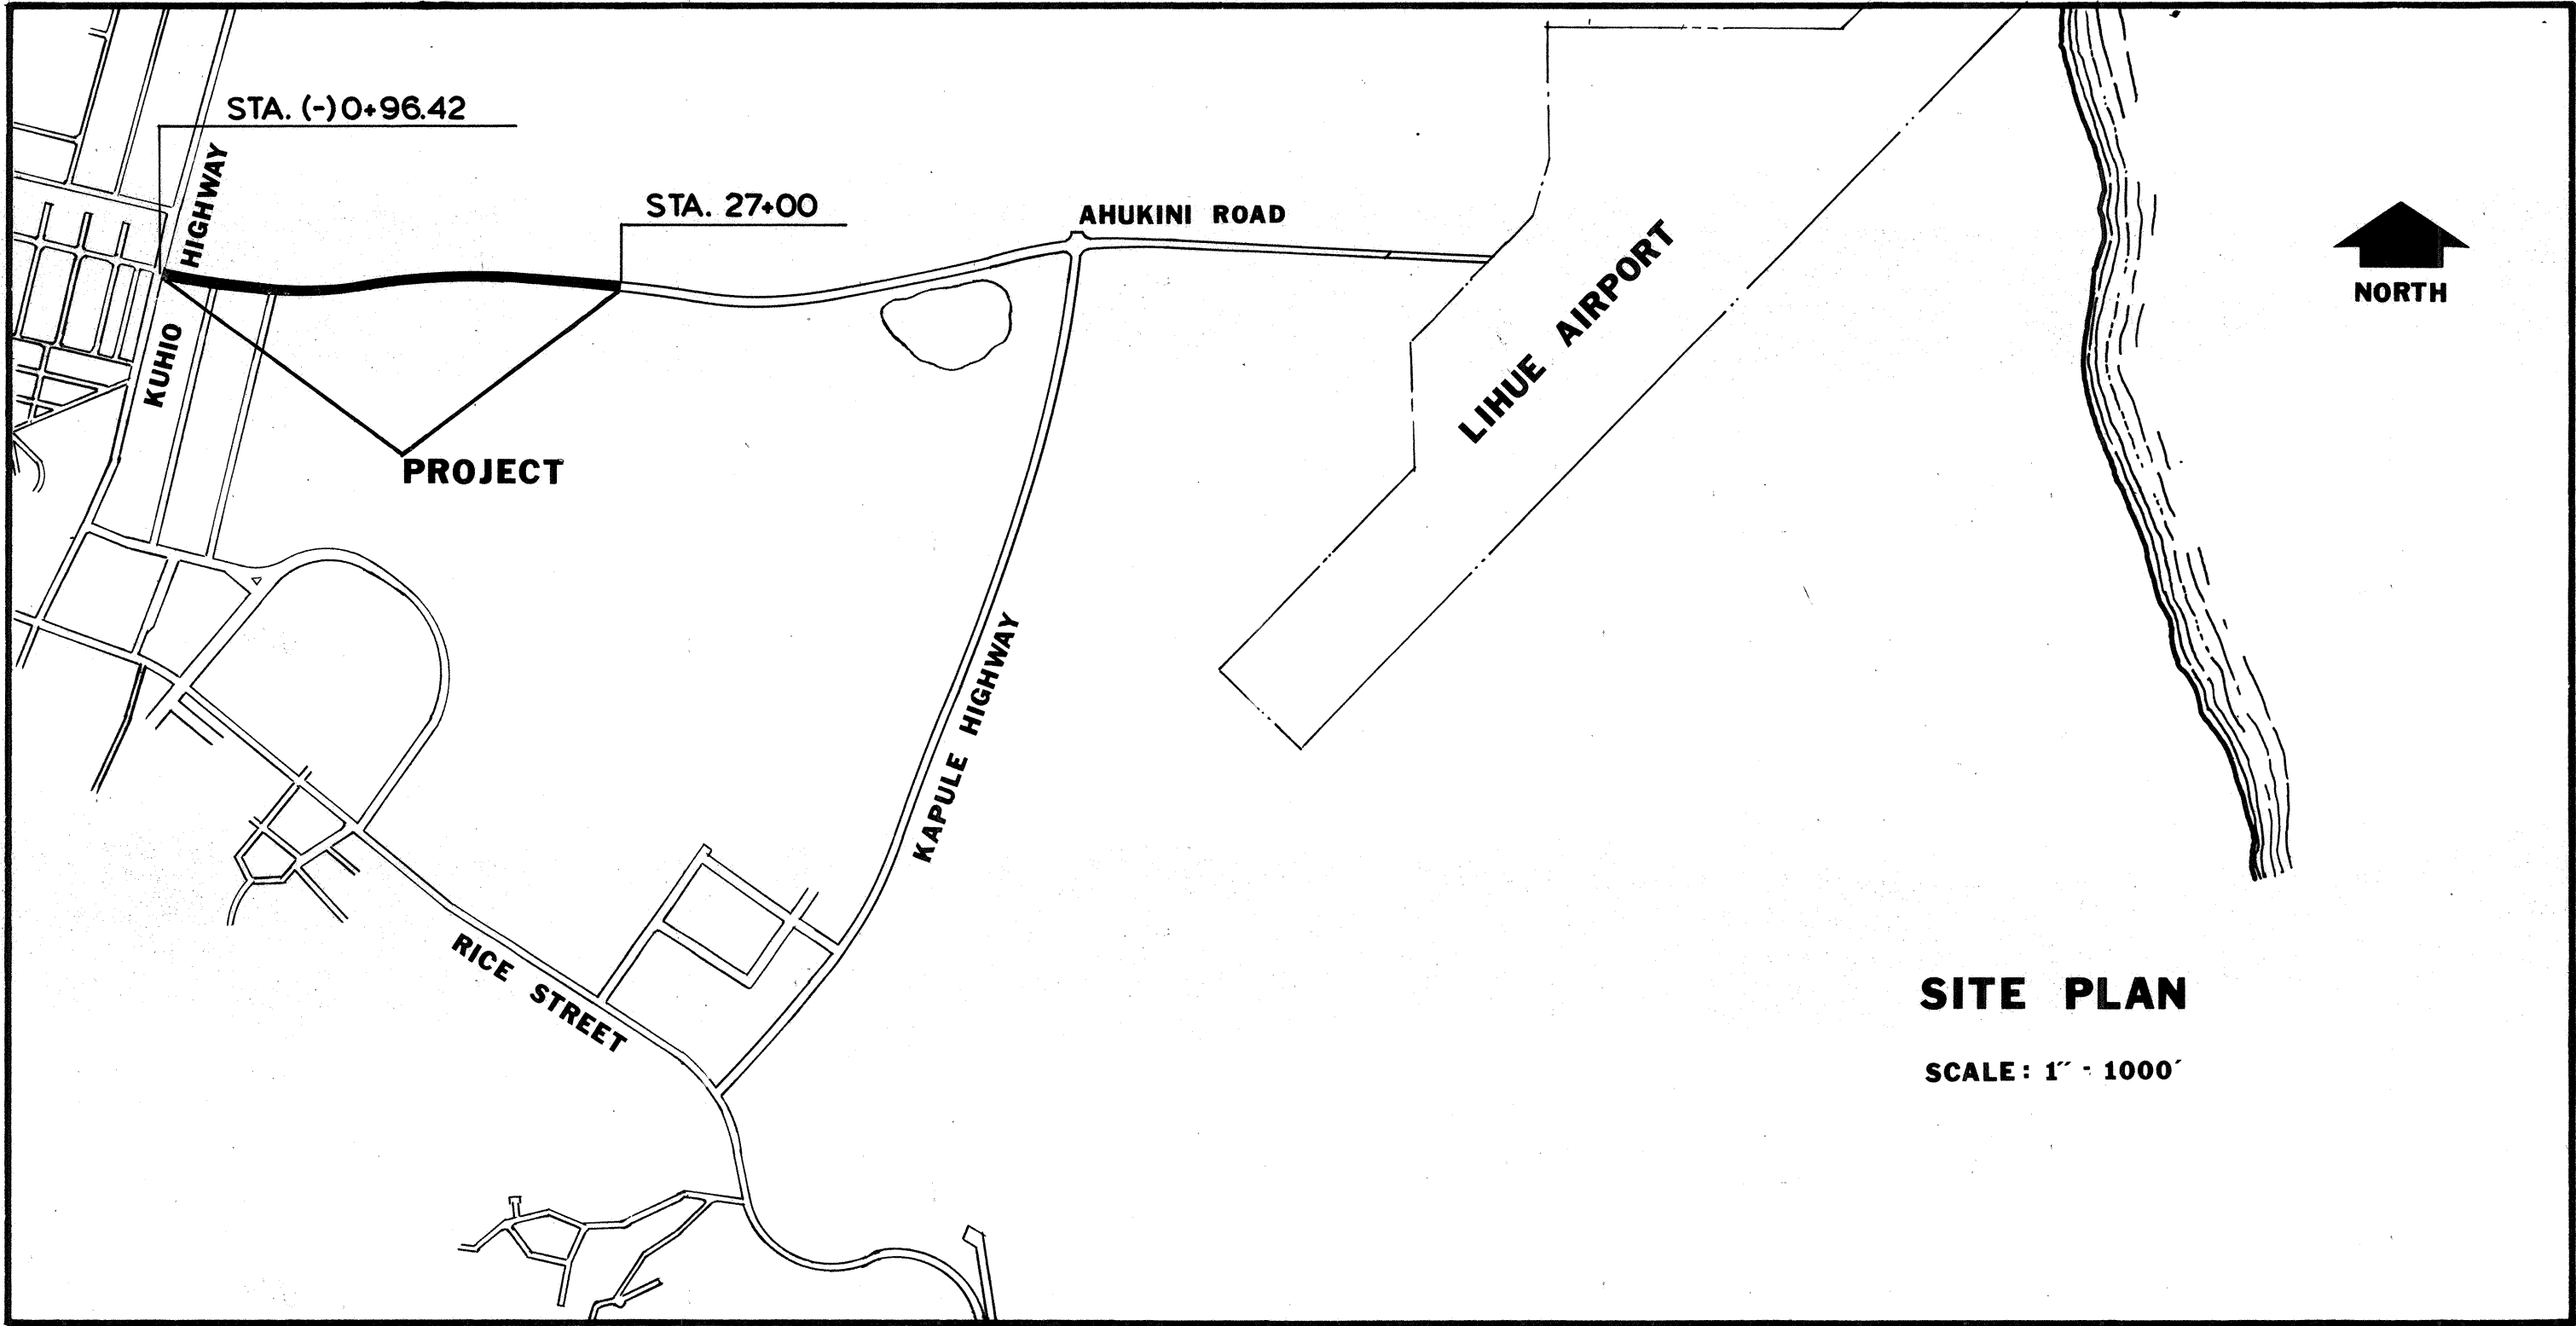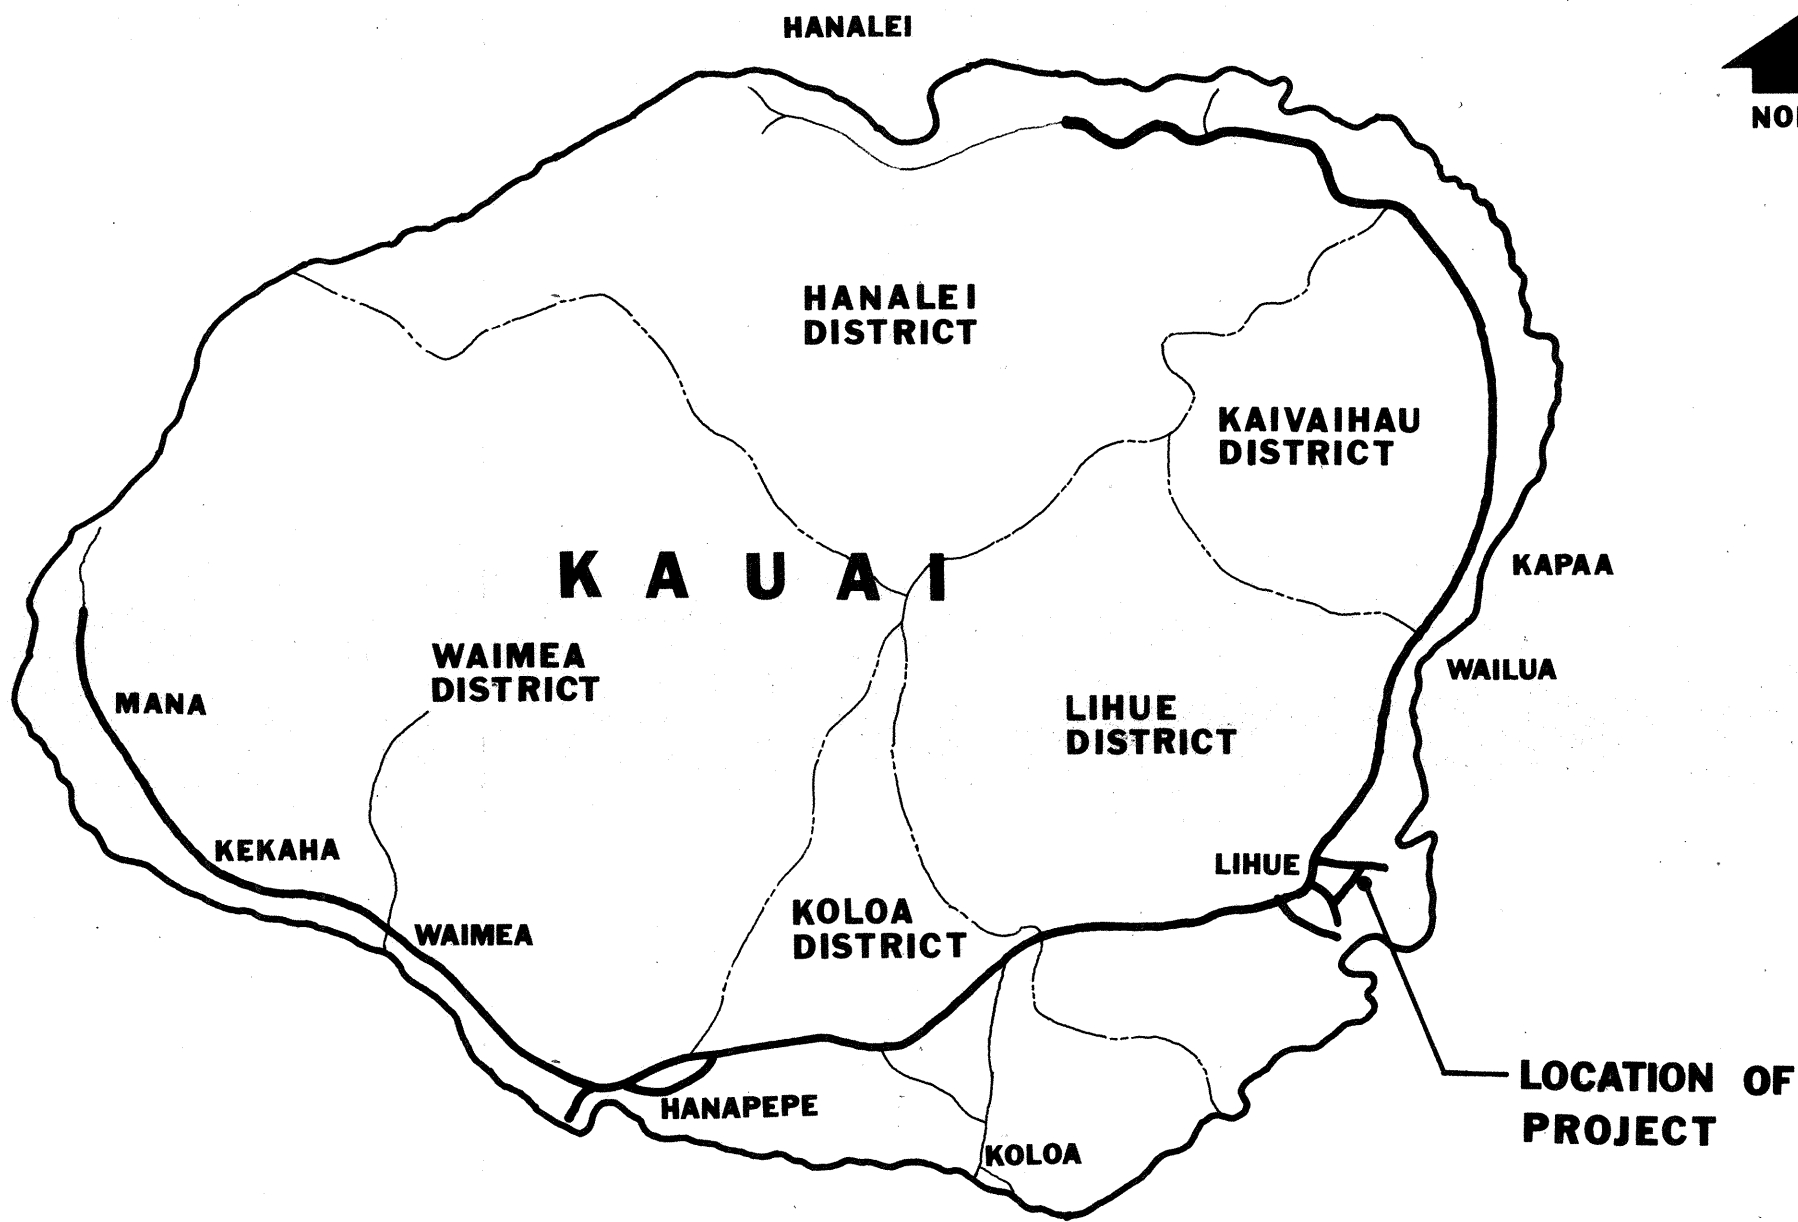

FED. ROAD DIST. NO.	STATE	PROJ. NO.	FISCAL YEAR	SHEET NO.	TOTAL SHEETS
HAWAII	HAW.	LT-K-05-78		1	16

PHASE II-B

DEPARTMENT OF TRANSPORTATION

STATE OF HAWAII

APPROVED BY: _____

DIRECTOR OF TRANSPORTATION

DATE _____

ORIGINAL PLAN	DATE
SURVEY PLOTTED BY	
DRAWN BY	
DESIGNED BY	
NOTE BOOK	
QUANTITIES BY	
CHECKED BY	
No.	