

FED. ROAD DIST. NO.	STATE	PROJ. NO.	FISCAL YEAR	SHEET NO.	TOTAL SHEETS
HAWAII	HAW.	HWY-M-ART18-01	2022	17	80

DEMOLITION KEY NOTES:

- (D1) REMOVE EXISTING WALL PARTITION WALL FINISHES, SUBSTRATE AND FRAMING, VERIFY.
- (D2) REMOVE EXISTING CERAMIC TILE FINISH AND EXISTING SUBSTRATE, WALL FRAMING TO REMAIN.
- (D3) REMOVE EXISTING DOOR, DOOR FRAME AND THRESHOLD.
- (D4) REMOVE EXISTING CERAMIC FLOOR TILE AND ASSOCIATED THIN SET TO EXPOSE EXISTING CONCRETE SUBSTRATE. SEE MECHANICAL SHEETS FOR PLUMBING SCOPE OF WORK AND RELATED CUTTING OF EXST CONCRETE SLAB OF GRADE.
- (D5) REMOVE EXISTING FLOOR DRAIN, SEE MECHANICAL SHEETS.
- (D6) REMOVE EXISTING PLUMBING FIXTURES AND ASSOCIATED PIPING, SEE PLUMBING SHEETS.
- (D7) REMOVE EXISTING TOILET PARTITIONS, PARTITION DOORS, GRAB BARS, AND BATHROOM ACCESSORIES IN ENTIRETY.
- (D8) REMOVE EXISTING COUNTERTOP AND FRAMING IN ENTIRETY.
- (D9) REMOVE EXISTING CERAMIC TILE BENCH, AND ASSOCIATED SUBSTRATE AND FRAMING.
- (D10) REMOVE EXISTING SURFACE MOUNTED MIRROR.
- (D11) REMOVE EXISTING COUNTERTOP, OVERHEAD CABINETS, AND ASSOCIATED FRAMING.
- (D12) REMOVE EXISTING PORTION OF ELECTRICAL SWITCH, SEE ELECTRICAL SHEETS.
- (D13) REMOVE EXISTING PANEL BREAKER. SEE ELECTRICAL SHEETS.
- (D14) REMOVE EXISTING CMU PLUMBING WALL, VERIFY.

CEILING DEMOLITION KEY NOTES:

- (CD1) REMOVE EXISTING CEILING MOUNTED FLORESCENT LIGHTING FIXTURE. REFER TO ELECTRICAL SHEETS.
- (CD2) REMOVE EXISTING SUPPLY GRILL. REFER TO MECHANICAL SHEETS.
- (CD3) REMOVE EXISTING ACCESS PANEL.
- (CD4) REMOVE EXISTING GYPSUM BOARD AND ASSOCIATED FRAMING/SUPPORTS IN ENTIRETY.


CEILING LEGEND:

	EXISTING LIGHTING FIXTURE. (NO WORK)		DEMO/REMOVAL WORK.
	EXISTING SUPPLY GRILL. (NO WORK)		EXISTING WALL/ WALL PARTITION REMOVAL.
	EXISTING WALL PARTITION.		EXISTING CMU REMOVAL.
			EXISTING CMU WALL.

GENERAL DEMOLITION NOTES:

- REFER TO MECHANICAL SHEETS FOR ALL HVAC, PLUMBING REMOVAL ITEMS BUT NOT LIMITED TO HVAC EQUIPMENT, PIPING, DRAIN, DUCTING, PIPING SUPPORTS, AND CONNECTIONS.
- REFER TO ELECTRICAL SHEETS FOR ALL POWER, ELECTRICAL SWITCH BOARD, PANEL BREAKER, FIRE DEVICES AND LIGHTING REMOVAL WORK.

KEY PLAN:

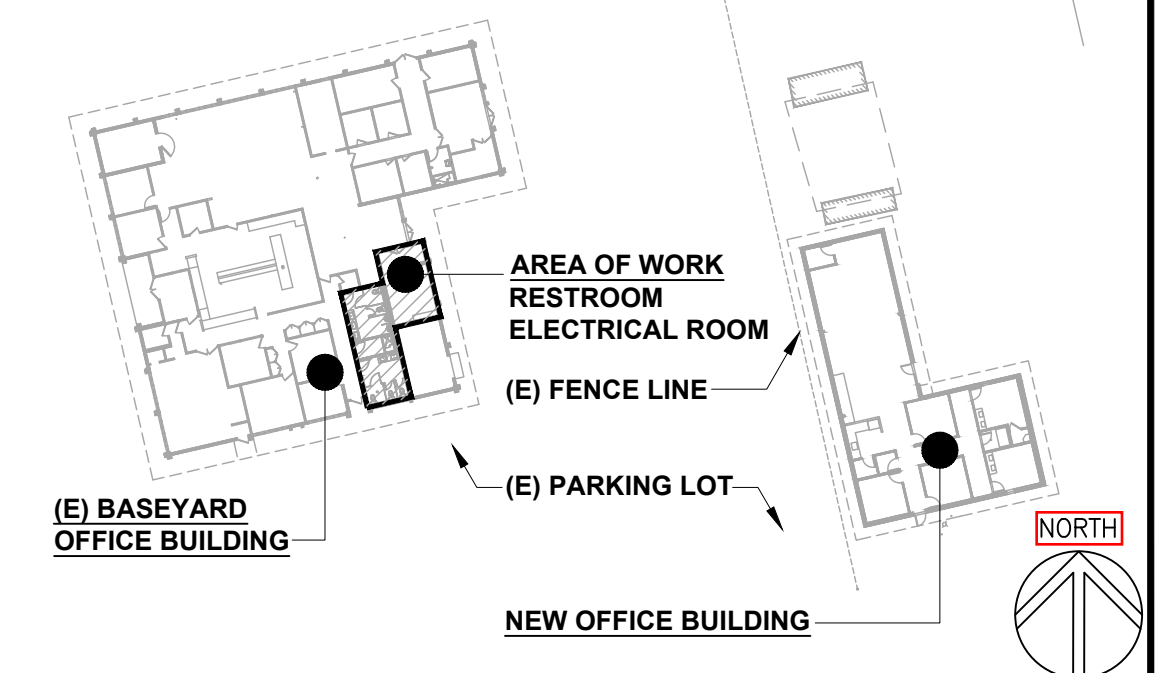

This work was prepared by me or under my supervision and construction of the project will be under my observation. Expiration date 04/30/24.

STATE OF HAWAII
DEPARTMENT OF TRANSPORTATION
HIGHWAYS DIVISION

DEMOLITION FLOOR PLAN,
DEMOLITION REFLECTED CEILING PLAN
EXISTING BASEYARD OFFICE BUILDING

MAUI DISTRICT BASEYARD
Project No. HWY-M-ART18.01

Scale: AS SHOWN Date: MAY 2022


SHEET No. A3 OF 80 SHEETS

DEMOLITION REFLECTED CEILING PLAN -
EXISTING BASEYARD OFFICE BUILDING

SCALE: 3/8" = 1'-0" 0 1 2 3 4 6 8 FT
SCALE: 3/8" = 1'-0"

DEMOLITION FLOOR PLAN -
EXISTING BASEYARD OFFICE BUILDING

SCALE: 3/8" = 1'-0" 0 1 2 3 4 6 8 FT
SCALE: 3/8" = 1'-0"

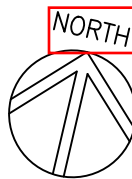

SURVEY PLOTTED BY: _____	DATE: _____
DRAWN BY: _____	
DESIGNED BY: _____	
CHECKED BY: _____	
NO.	