



FED. ROAD DIST. NO.	STATE	PROJ. NO.	FISCAL YEAR	SHEET NO.	TOTAL SHEETS
HAWAII	HAW.	HWY-M-ART18-01	2022	59	80


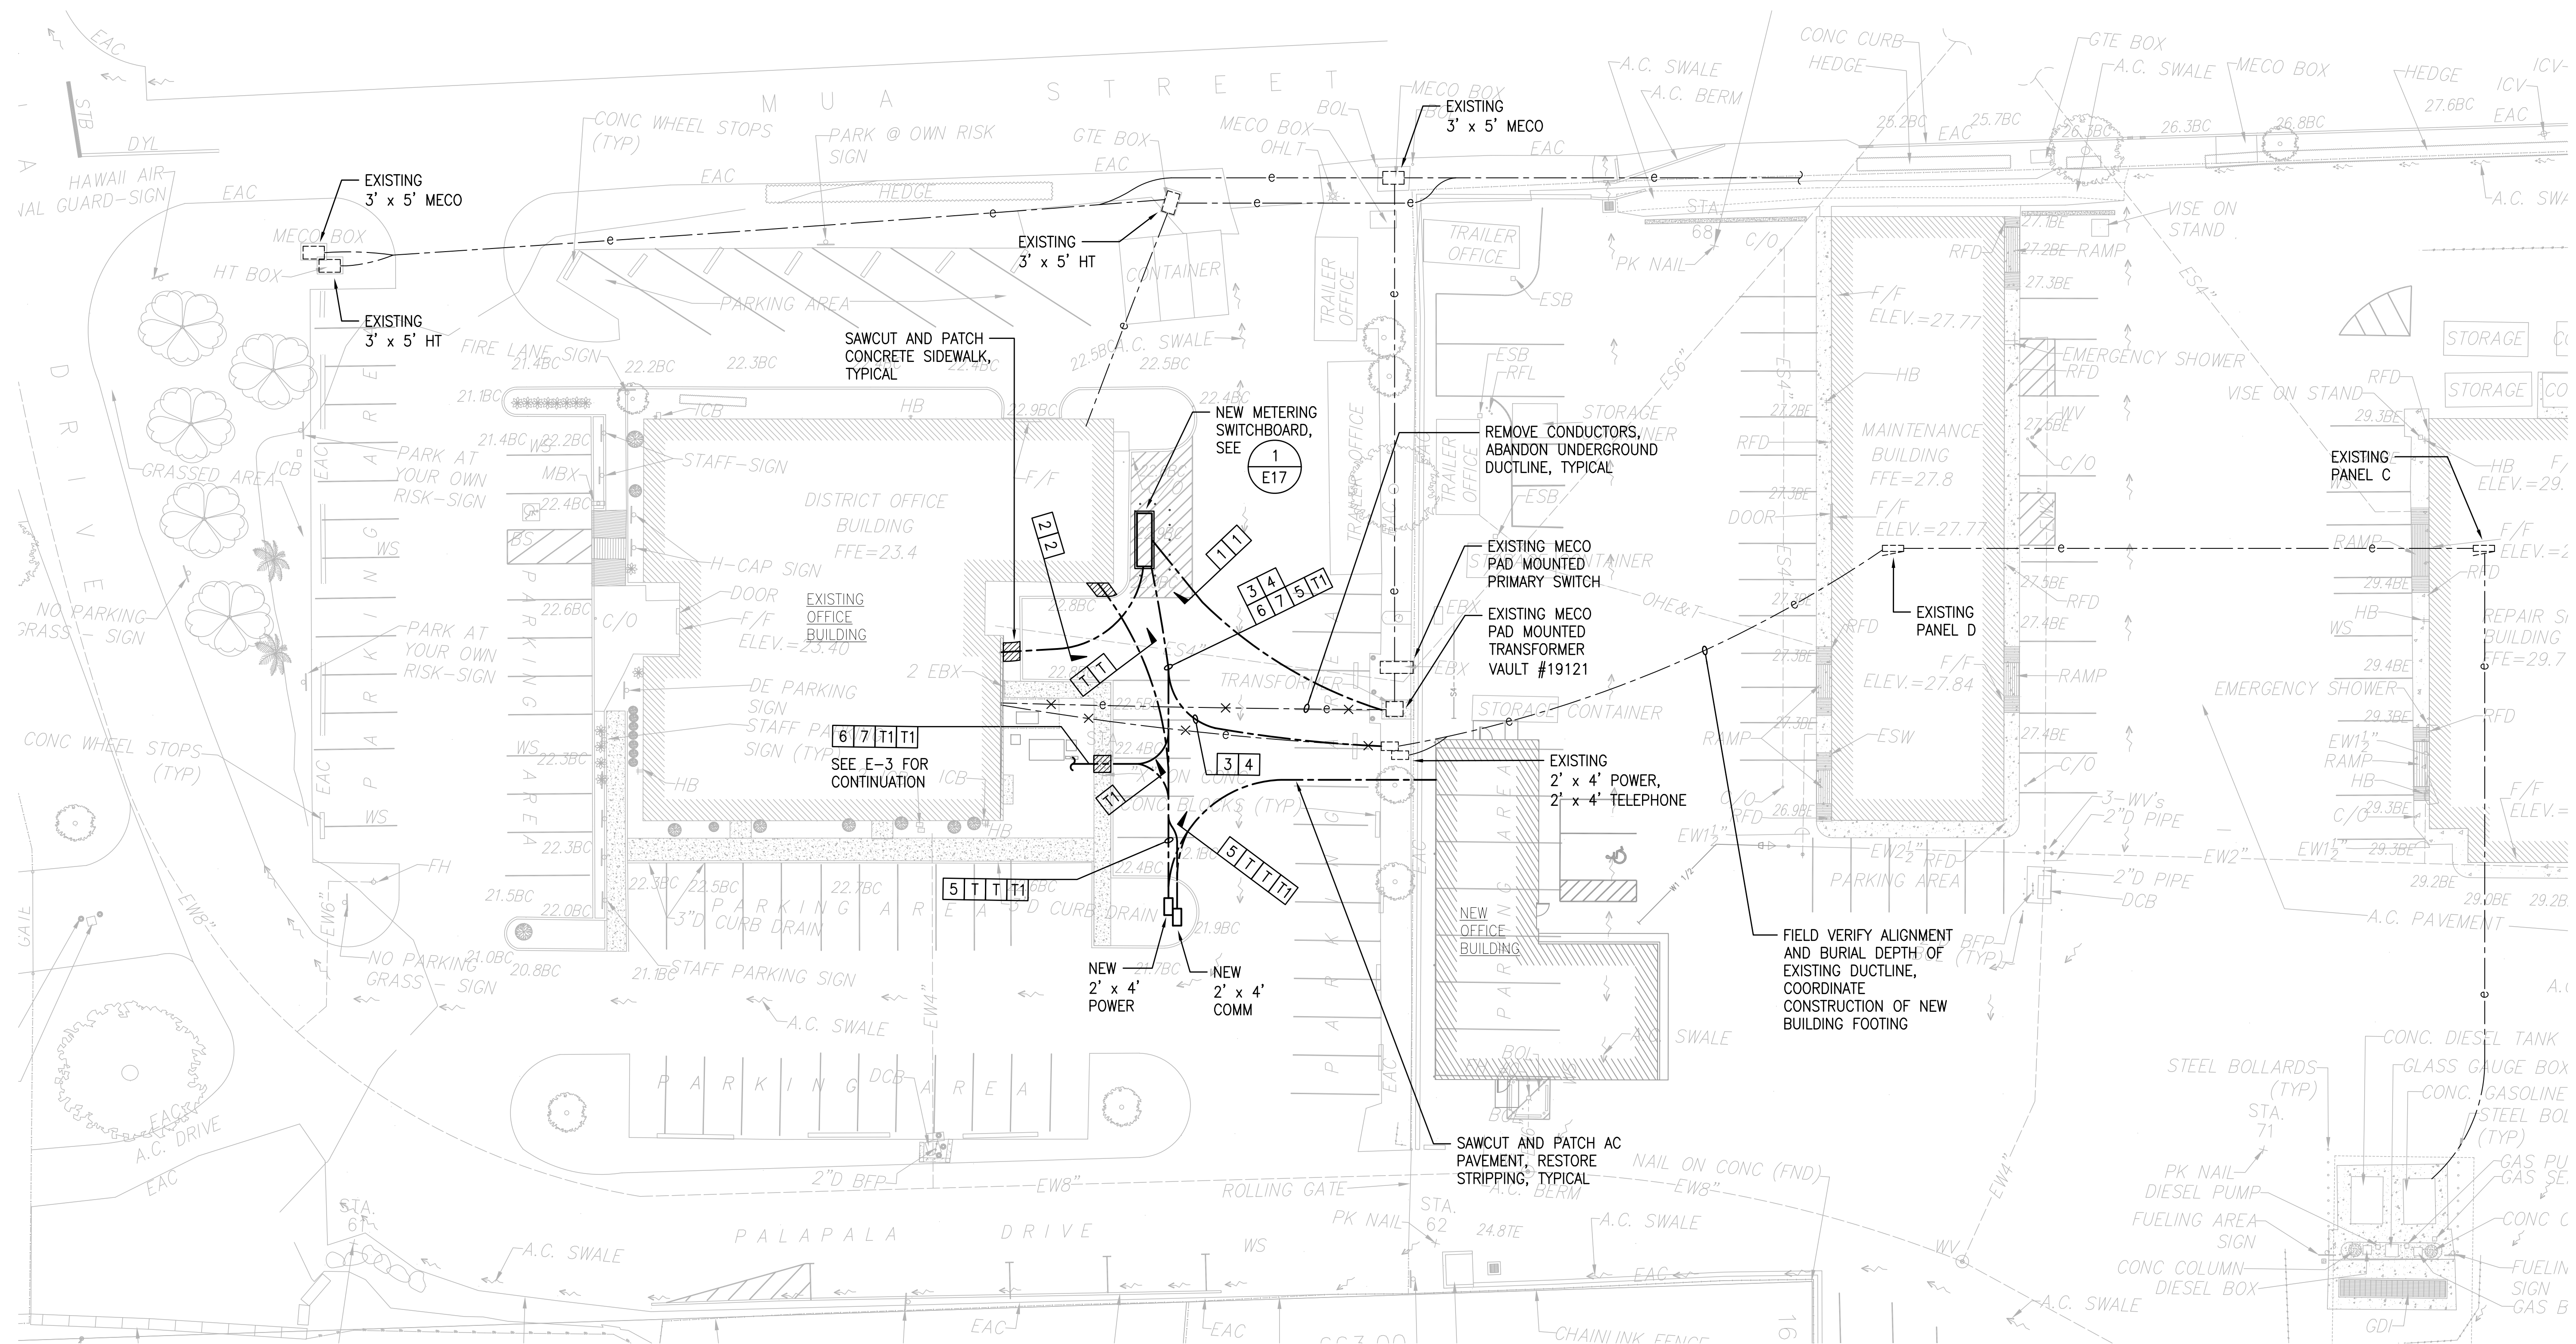


DESIGNED BY	DATE
DRAWN BY	DATE
CHECKED BY	DATE
APPROVED BY	DATE

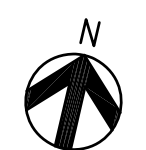

1
E2 **ELECTRICAL SITE PLAN**
SCALE: 1" = 20'-0"

GRAPHIC SCALE

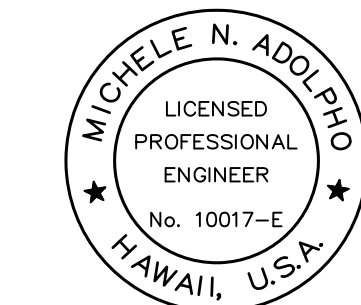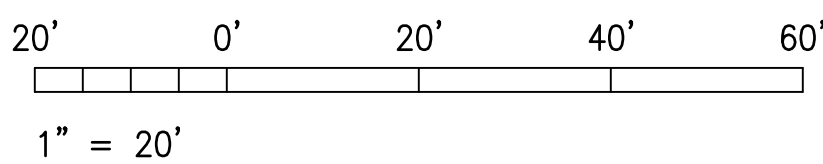

Michele N. Adolpho
PROJECT ENGINEER for ECS, Inc.
APRIL 30, 2024
EXPIRATION DATE OF THE LICENSE

STATE OF HAWAII
DEPARTMENT OF TRANSPORTATION
HIGHWAYS DIVISION

ELECTRICAL SITE PLAN

MAUI DISTRICT BASEYARD
Project No. HWY-M-ART18.01
Scale: AS SHOWN Date: MAY 2022

SHEET No. E2 OF 80 SHEETS