

FED. ROAD DIST. NO.	STATE	PROJ. NO.	FISCAL YEAR	SHEET NO.	TOTAL SHEETS
HAWAII	HAW.	HWY-M-ART18-01	2022	25	80


GENERAL NOTES:

- REFER TO STRUCTURAL SHEETS FOR ALL FOOTING AND FOUNDATION WORK.
- REFER TO MECHANICAL SHEETS FOR ALL HVAC, PLUMBING ITEMS BUT NOT LIMITED TO HVAC EQUIPMENT, PIPING, DUCTING, PIPING SUPPORTS AND CHILL WATER PIPING, AND CONNECTIONS.
- REFER TO ELECTRICAL SHEETS FOR ALL POWER PANELS, FIRE ALARM, IT, AND LIGHTING WORK.

LEGEND:

- EXISTING ELECTRICAL OUTLET, REFER TO ELECTRICAL SHEETS.
- EXISTING ELECTRICAL FLOOR OUTLET, REFER TO ELECTRICAL SHEETS.
- 2X2 RECESSED LED LIGHT FIXTURE, SEE ELECTRICAL SHEETS.
- 5" LED RECESSED LINEAR SLOT LIGHT FIXTURE, SEE ELECTRICAL SHEETS.
- EXTERIOR WALL MOUNTED LED LIGHT FIXTURE, SEE ELECTRICAL SHEETS.
- ILLUMINATED LED EXIT, SEE ELECTRICAL SHEETS.
- 2X2 FIRE RATED METAL, FLUSH, ACCESS PANEL W/ LOCK.
- HVAC SUPPLY REGISTER, SEE MECH SHEETS.
- HVAC RETURN REGISTER, SEE MECH SHEETS.
- LED PENDANT. SEE ELEC SHEETS.
- WINDOW CANOPY.
- 23"X11"X1" PRECAST CONC DIFFUSER SPLASH BLOCK.

KEY PLAN:

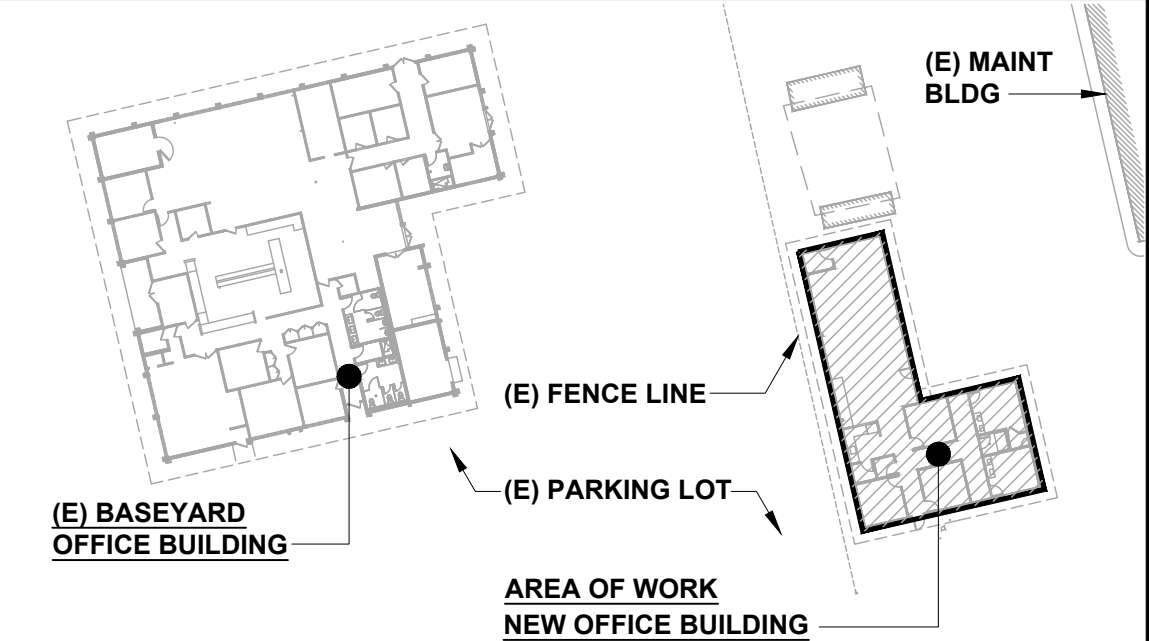

This work was prepared by me or under my supervision and construction of the project will be under my observation. Expiration date 04/30/24.


STATE OF HAWAII
DEPARTMENT OF TRANSPORTATION
HIGHWAYS DIVISION

FLOOR PLAN
NEW OFFICE BUILDING

MAUI DISTRICT BASEYARD
Project No. HWY-M-ART18.01



Scale: AS SHOWN Date: MAY 2022

SHEET No. A11 OF 80 SHEETS

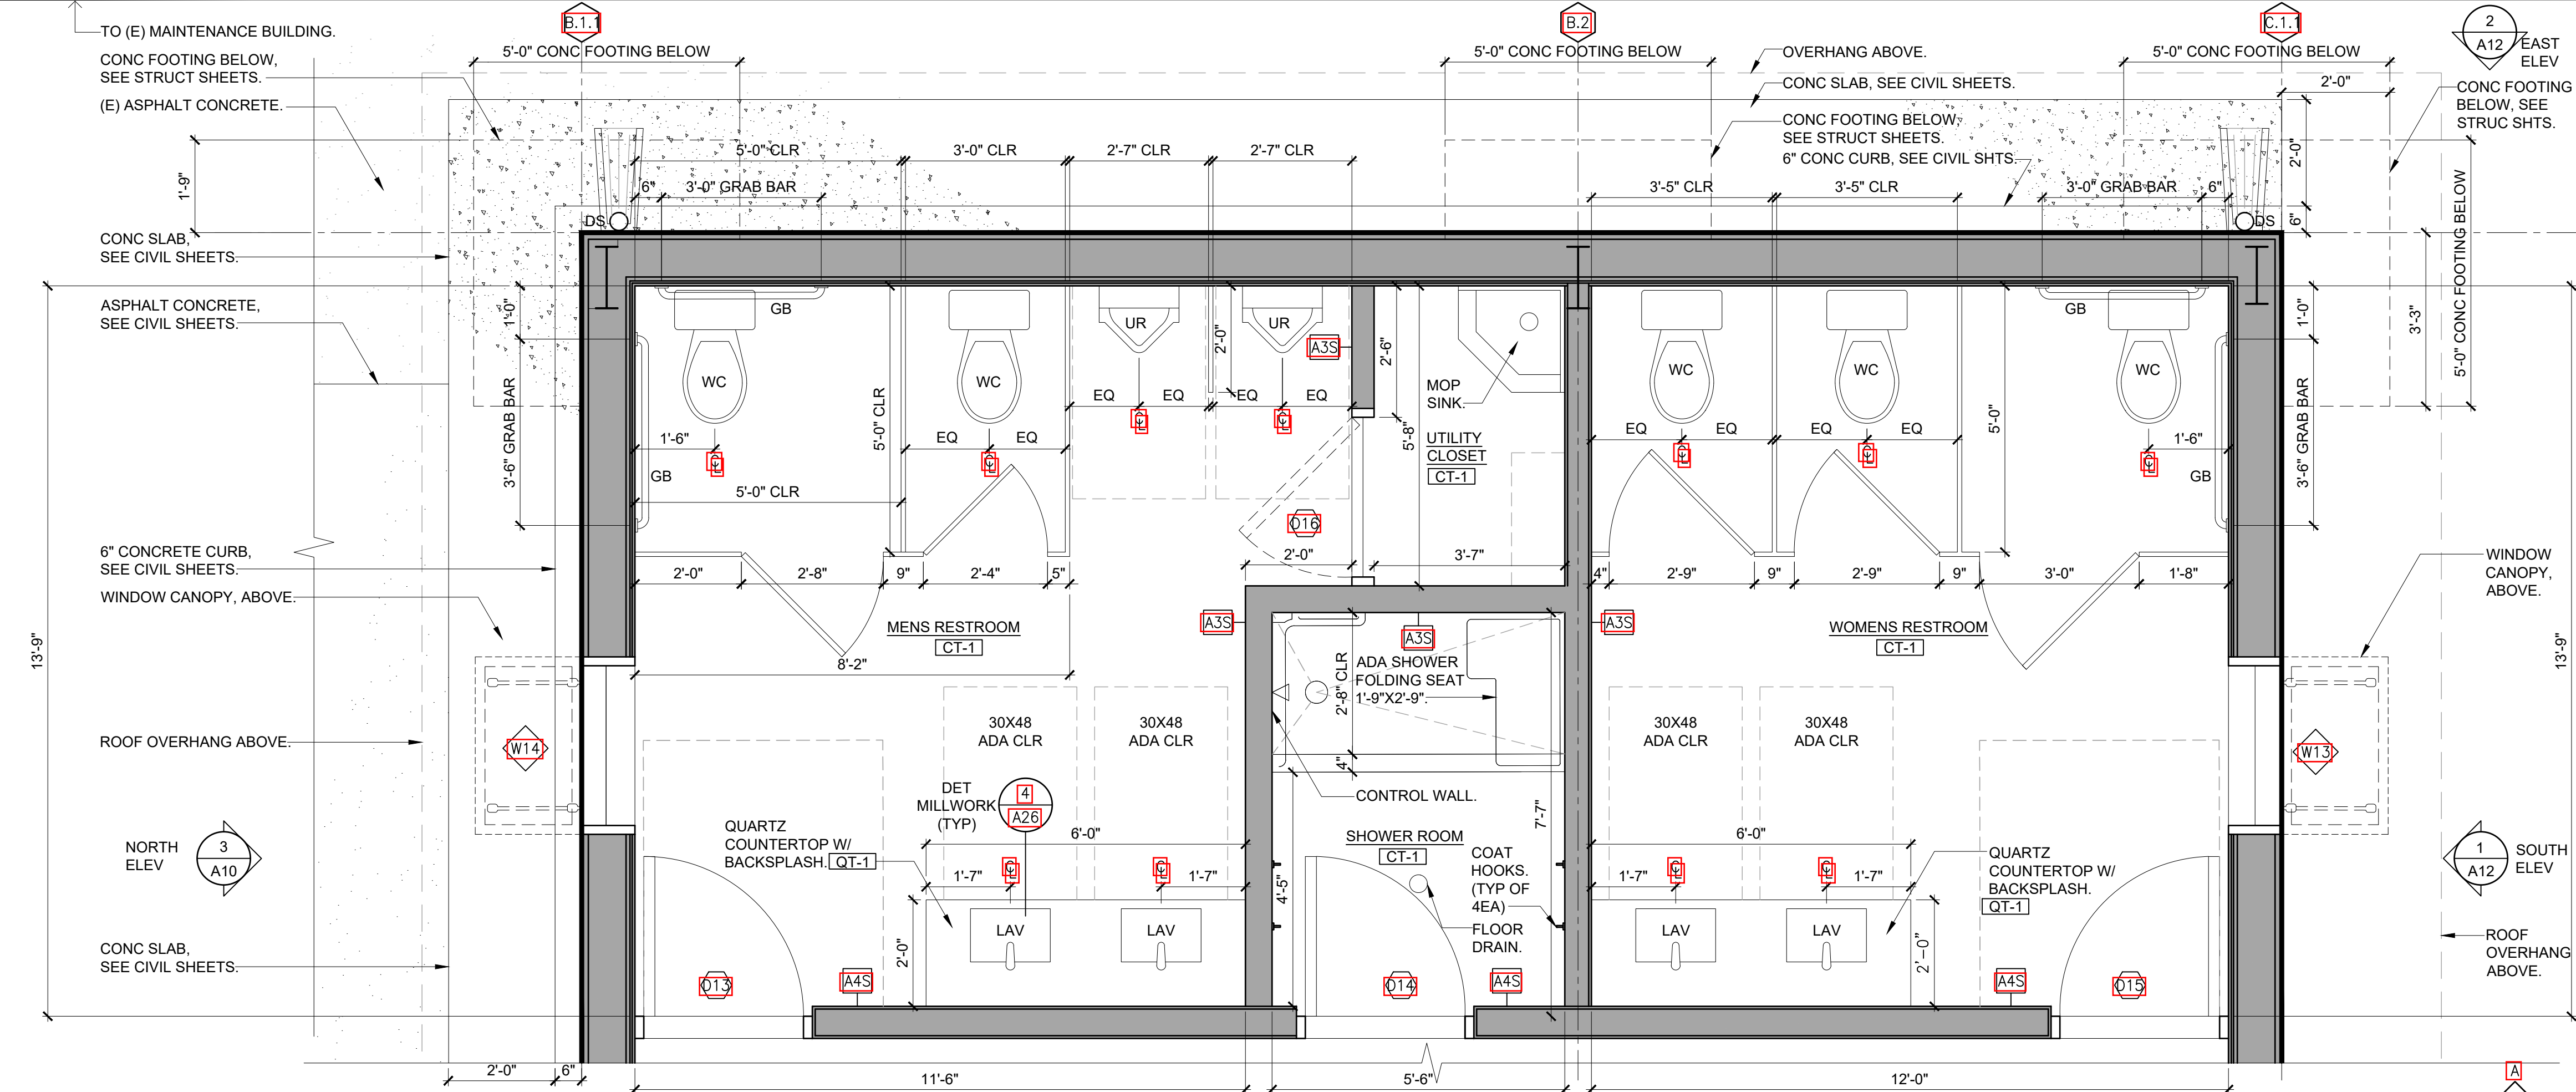


1 ENLARGED FLOOR PLAN - RESTROOMS

 SCALE: 1/2" = 1'-0"

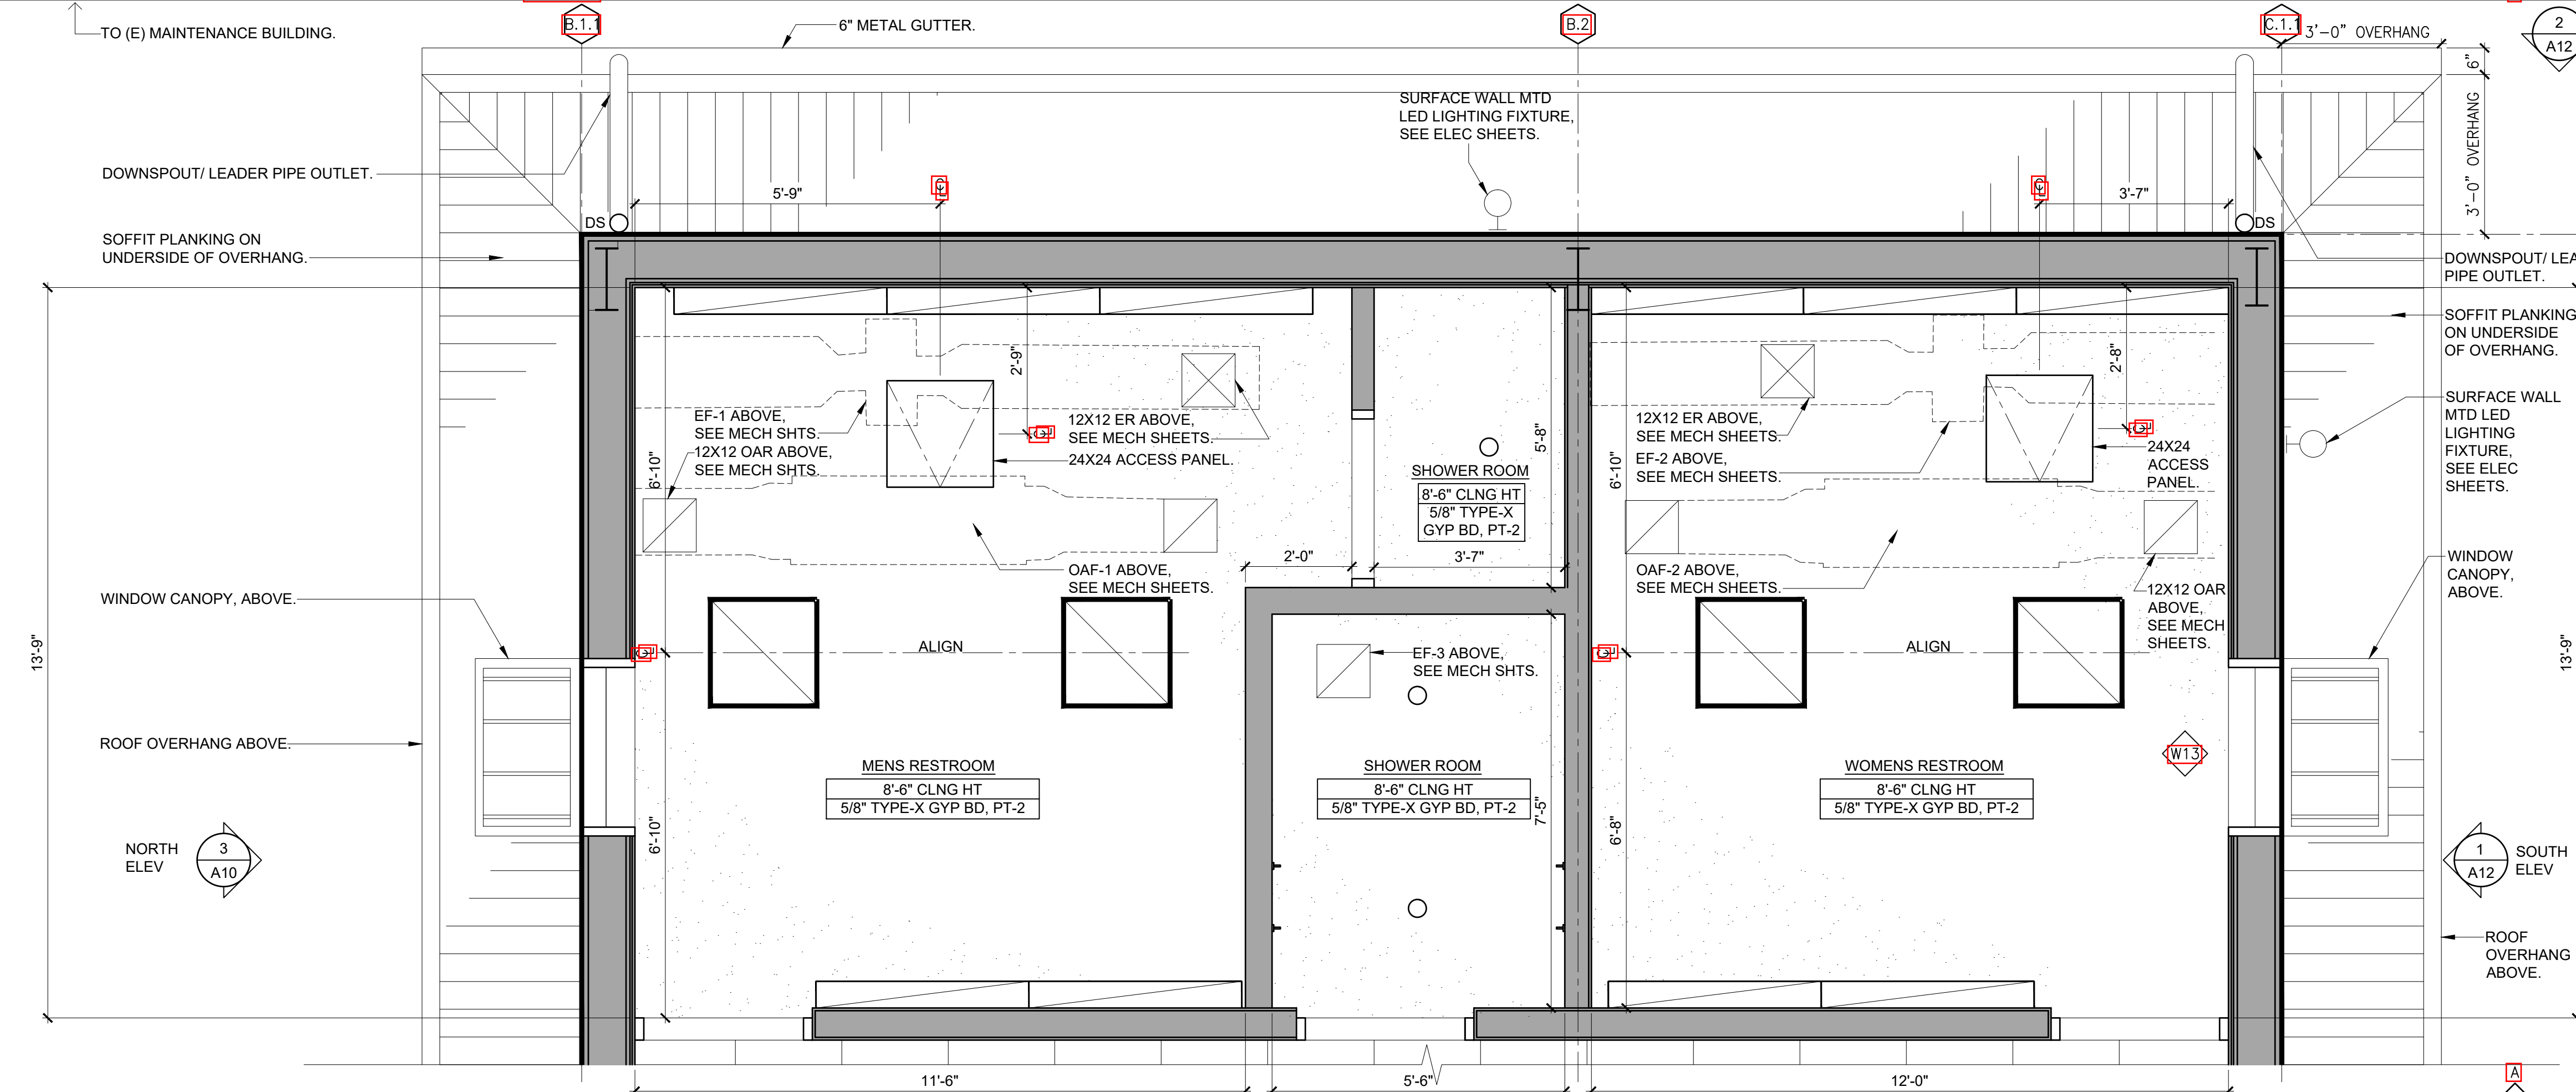

2 ENLARGED REFLECTED CEILING PLAN - RESTROOMS

 SCALE: 1/2" = 1'-0"



DATE	05/05/22
SURVEY PLOTTED BY	REID T. MIZUE
DRAWN BY	REID T. MIZUE
DESIGNED BY	REID T. MIZUE
CHECKED BY	REID T. MIZUE
NOTED BY	REID T. MIZUE
NO.	1