

FED. ROAD DIST. NO.	STATE	PROJ. NO.	FISCAL YEAR	SHEET NO.	TOTAL SHEETS
HAWAII	HAW.	HWY-M-ART18-01	2022	20	80


GENERAL NOTES:

- REFER TO MECHANICAL SHEETS FOR ALL HVAC, PLUMBING ITEMS BUT NOT LIMITED TO HVAC EQUIPMENT, PIPING, DUCTING, PIPING SUPPORTS AND CHILL WATER PIPING, DRAINS, AND CONNECTIONS.
- REFER TO ELECTRICAL SHEETS FOR ALL POWER, FIRE ALARM, IT, AND LIGHTING WORK.
- PROVIDE BACKING AND BLOCKING FOR ALL INDICATED BATH ACCESSORIES.
- REFER TO INTERIOR ELEVATIONS FOR ALL BATH ACCESSORIES.

LEGEND:

- EXISTING ELECTRICAL OUTLET, REFER TO ELECTRICAL SHEETS.
- 5" LED RECESSED LINEAR SLOT LIGHT FIXTURE, SEE ELECTRICAL SHTS.
- 4" RECESSED LED LIGHT FIXTURE, SEE ELECTRICAL SHEETS.
- NEW PARTITION WALLS
- SUPPLY GRILL, SEE MECH SHEETS.

KEY PLAN:

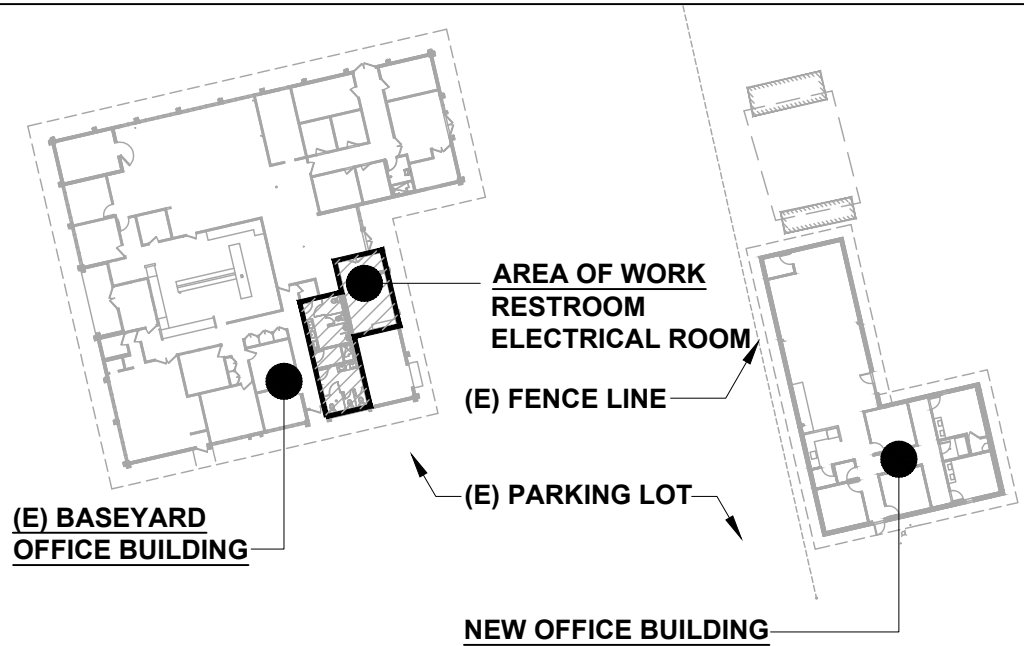

This work was prepared by me or under my supervision and construction of the project will be under my observation. Expiration date 04/30/24.

STATE OF HAWAII
DEPARTMENT OF TRANSPORTATION
HIGHWAYS DIVISION

FLOOR PLAN AND REFLECTED CEILING PLAN
EXISTING BASEYARD OFFICE BUILDING

MAUI DISTRICT BASEYARD
Project No. HWY-M-ART18.01

Scale: AS SHOWN Date: MAY 2022


SHEET No. A6 OF 80 SHEETS

DATE	3/15/24
SURVEY PLOTTED BY	REID T. MIZUE
DRAWN BY	REID T. MIZUE
DESIGNED BY	REID T. MIZUE
CHECKED BY	REID T. MIZUE
NOTED BY	REID T. MIZUE
NS	

REFLECTED CEILING PLAN -
EXISTING BASEYARD OFFICE BUILDING

SCALE: 3/8" = 1'-0"

1 2 3 4 5 6 8 FT
SCALE: 3/8" = 1'-0"

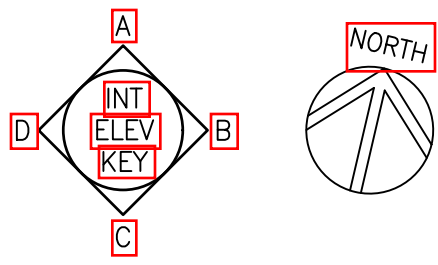FLOOR PLAN -
EXISTING BASEYARD OFFICE BUILDING

SCALE: 3/8" = 1'-0"

1 2 3 4 5 6 8 FT
SCALE: 3/8" = 1'-0"

