



FED. ROAD DIST. NO.	STATE	PROJ. NO.	FISCAL YEAR	SHEET NO.	TOTAL SHEETS
HAWAII	HAW.	HWY-M-ART18-01	2022	31	80

- GENERAL NOTES:
- REFER TO MECHANICAL SHEETS FOR ALL HVAC, PLUMBING ITEMS BUT NOT LIMITED TO HVAC EQUIPMENT, PIPING, DUCTING, PIPING SUPPORTS AND CHILL WATER PIPING, AND CONNECTIONS.
 - REFER TO ELECTRICAL SHEETS FOR ALL POWER, FIRE ALARM, IT, AND LIGHTING WORK.

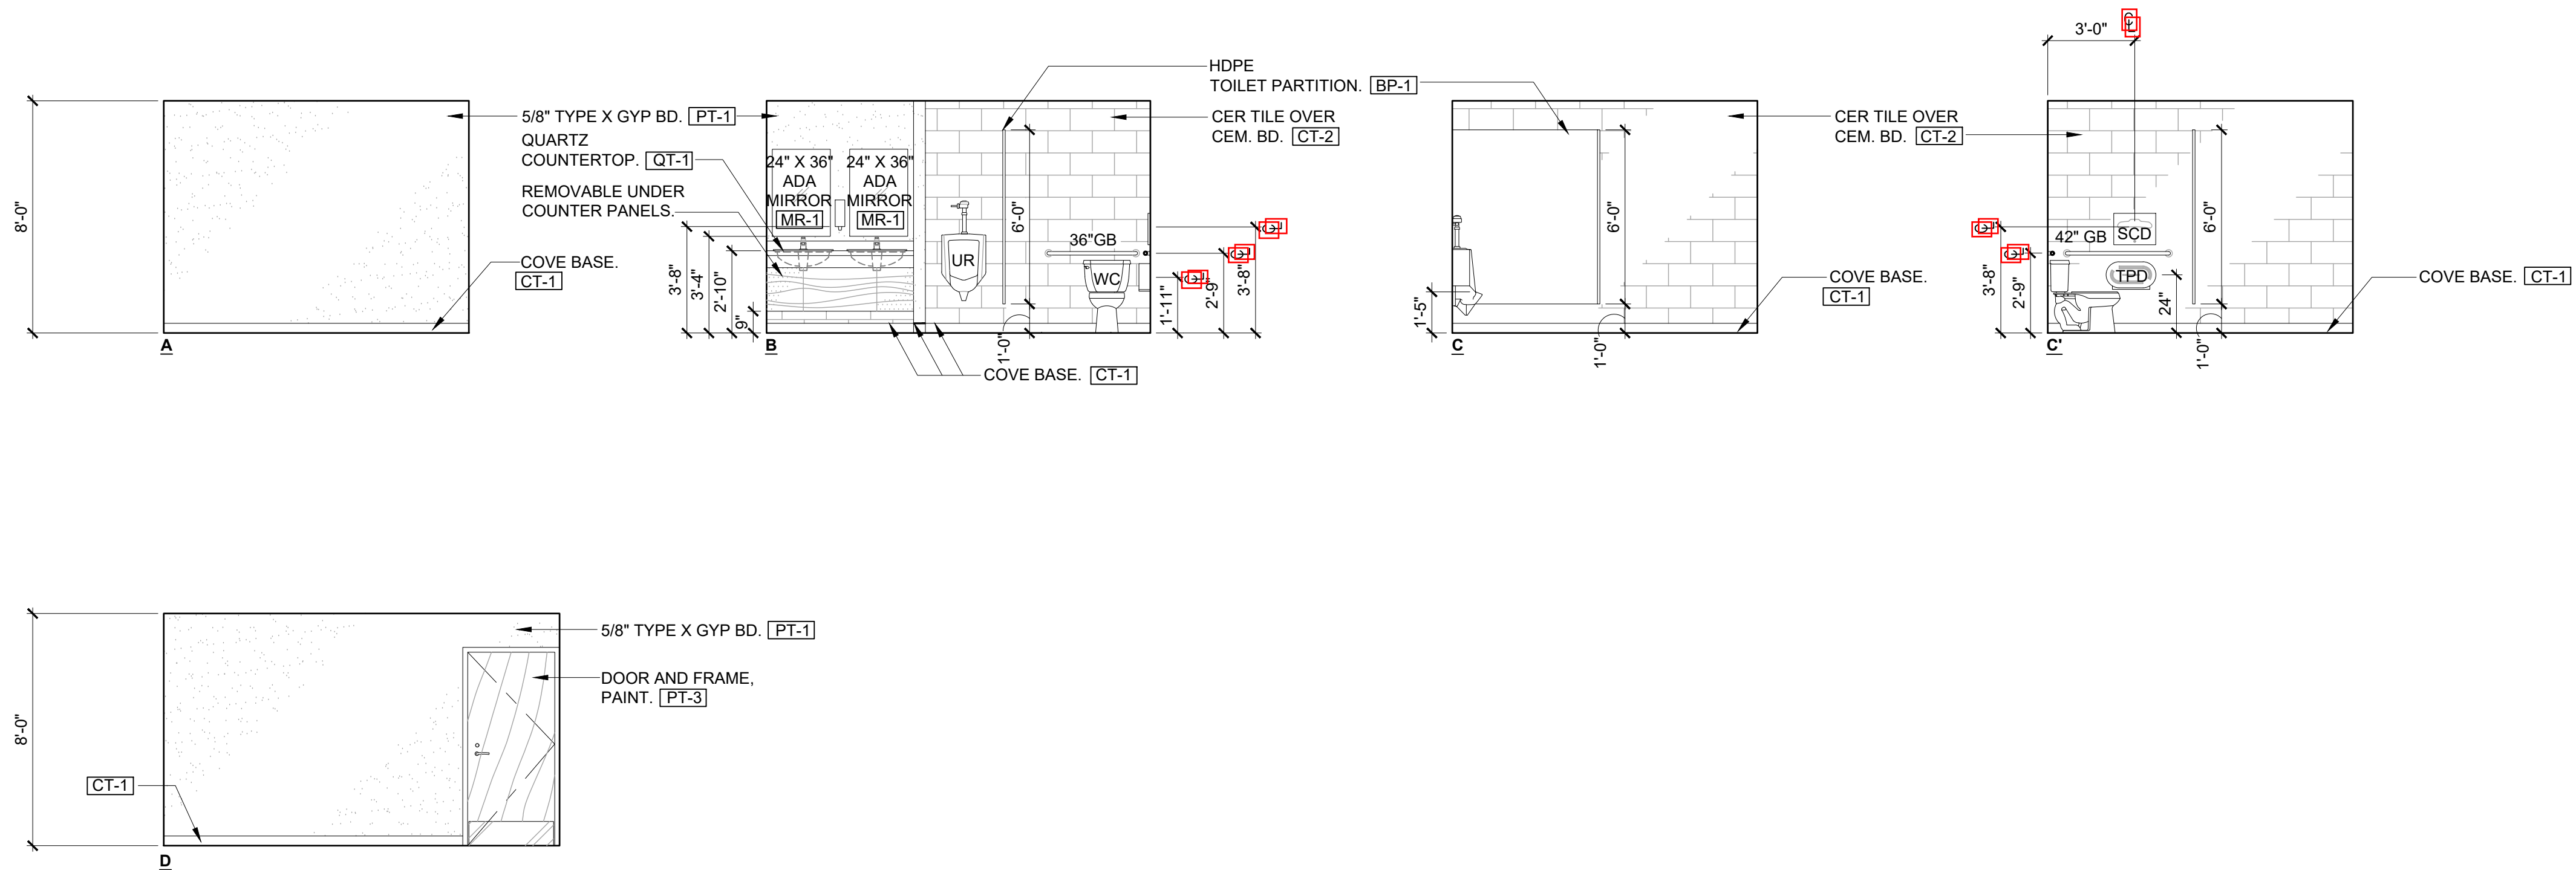


1 INTERIOR ELEVATION - EXISTING OFFICE MEN'S RESTROOM

 SCALE: 1/4" = 1'-0"





NOTE: 1. SEE MECHANICAL FOR ALL PLUMBING FIXTURES, PIPING, HVAC, AND DRAINS.

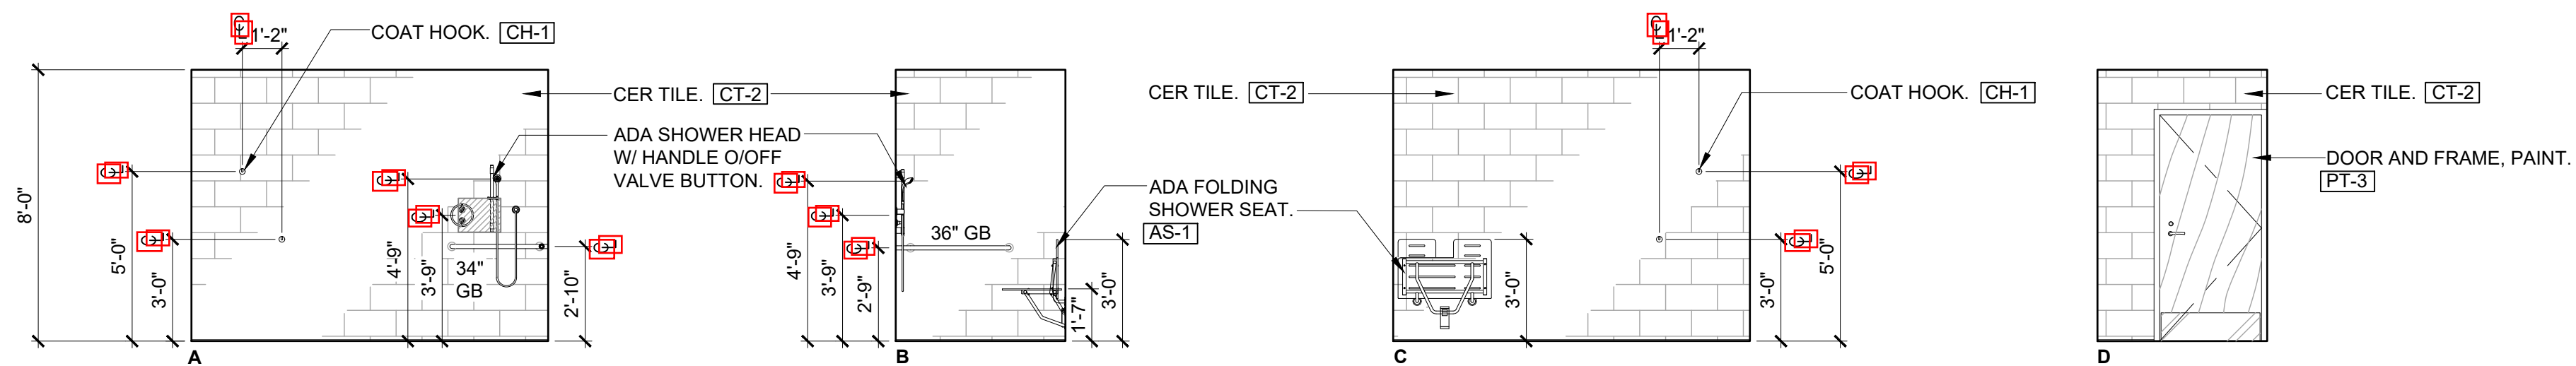



2 INTERIOR ELEVATION - EXISTING OFFICE SHOWER ROOM

 SCALE: 1/4" = 1'-0"

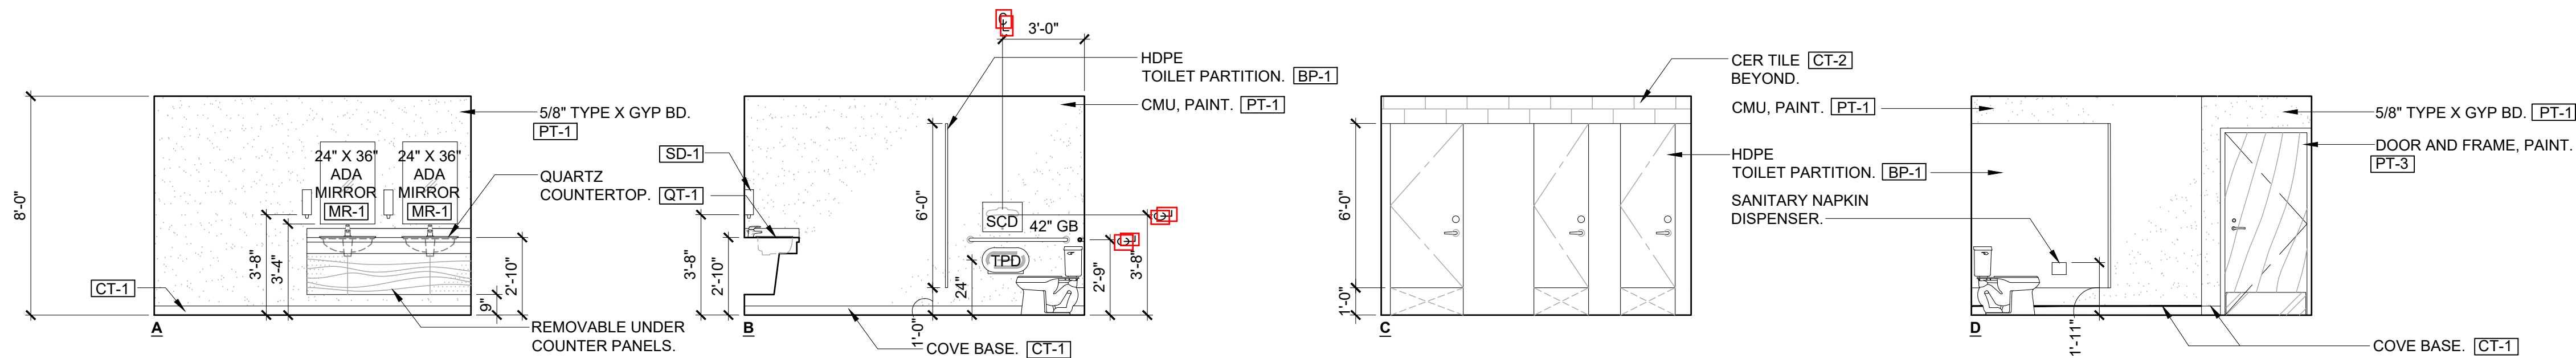


3 INTERIOR ELEVATION - EXISTING OFFICE WOMEN'S RESTROOM

 SCALE: 1/4" = 1'-0"

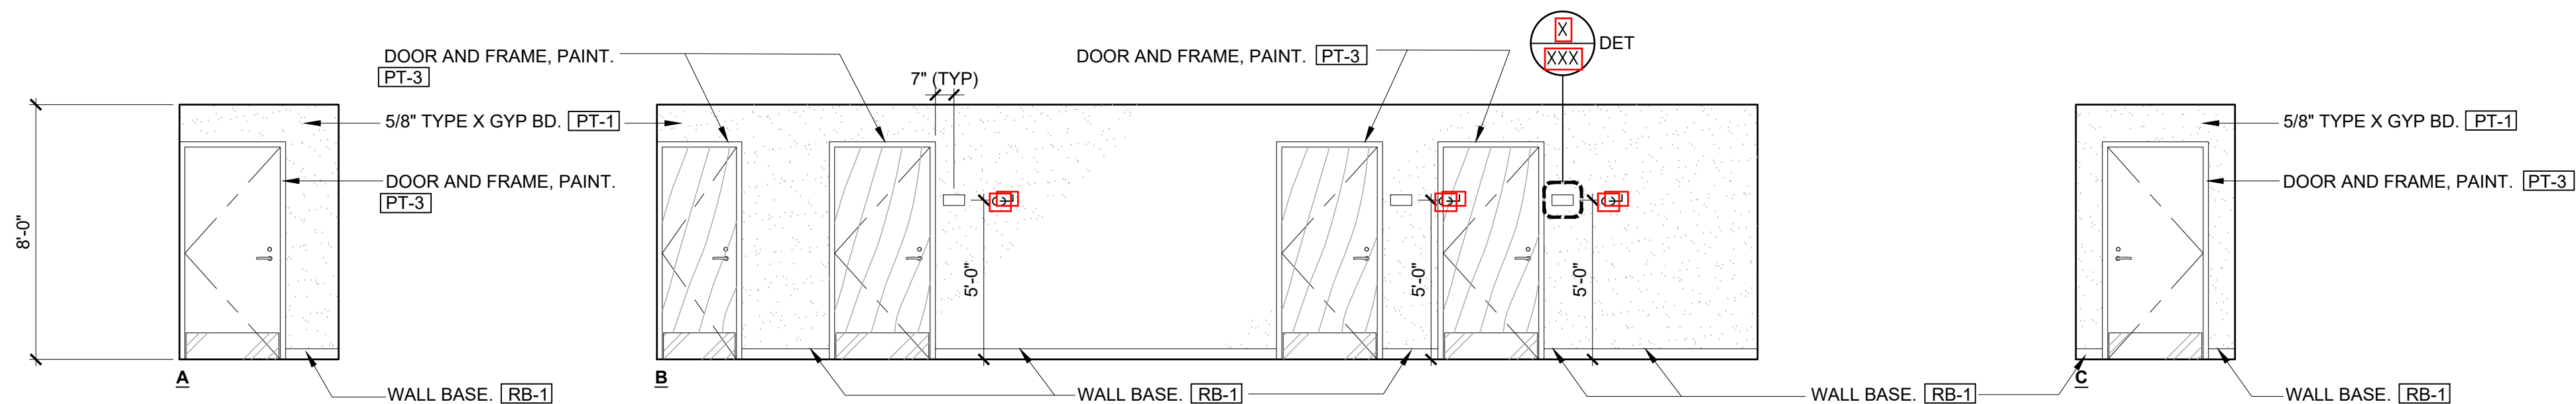

KEY PLAN:

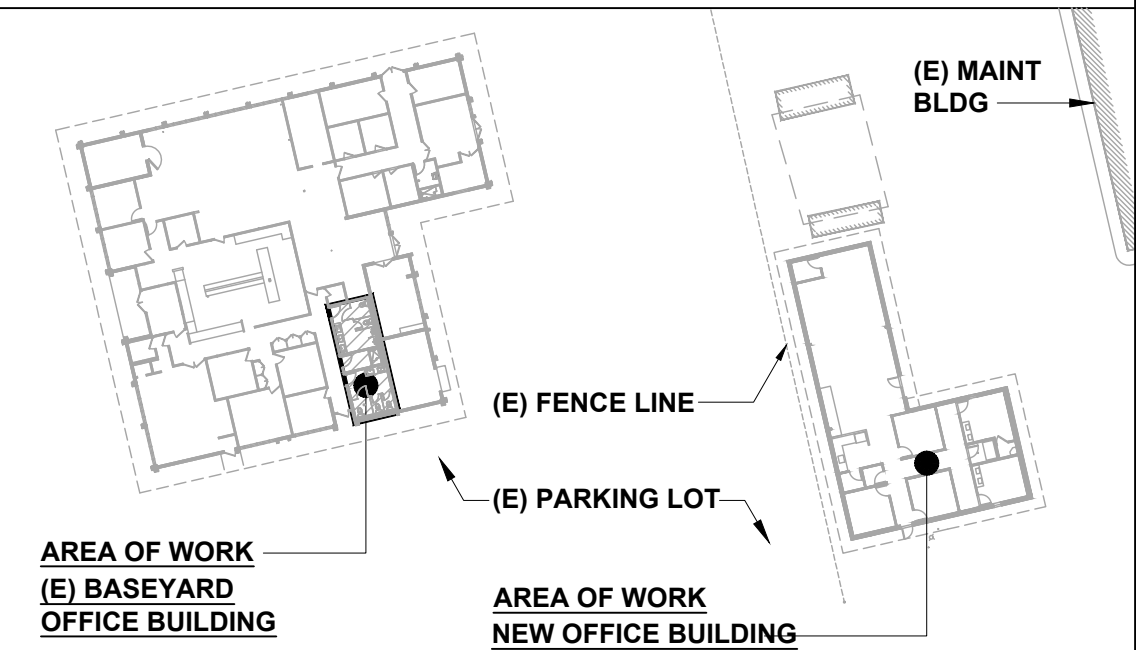

This work was prepared by me or under my supervision and construction of the project will be under my observation. Expiration date 04/30/24.

STATE OF HAWAII
DEPARTMENT OF TRANSPORTATION
HIGHWAYS DIVISION

INTERIOR ELEVATION
EXISTING OFFICE BUILDING

MAUI DISTRICT BASEYARD
Project No. HWY-M-ART18.01

Scale: AS SHOWN Date: MAY 2022

SHEET No. A17 OF 80 SHEETS