




FED. ROAD DIST. NO.	STATE	PROJ. NO.	FISCAL YEAR	SHEET NO.	TOTAL SHEETS
HAWAII	HAW.	HWY-M-ART18-01	2022	77	80

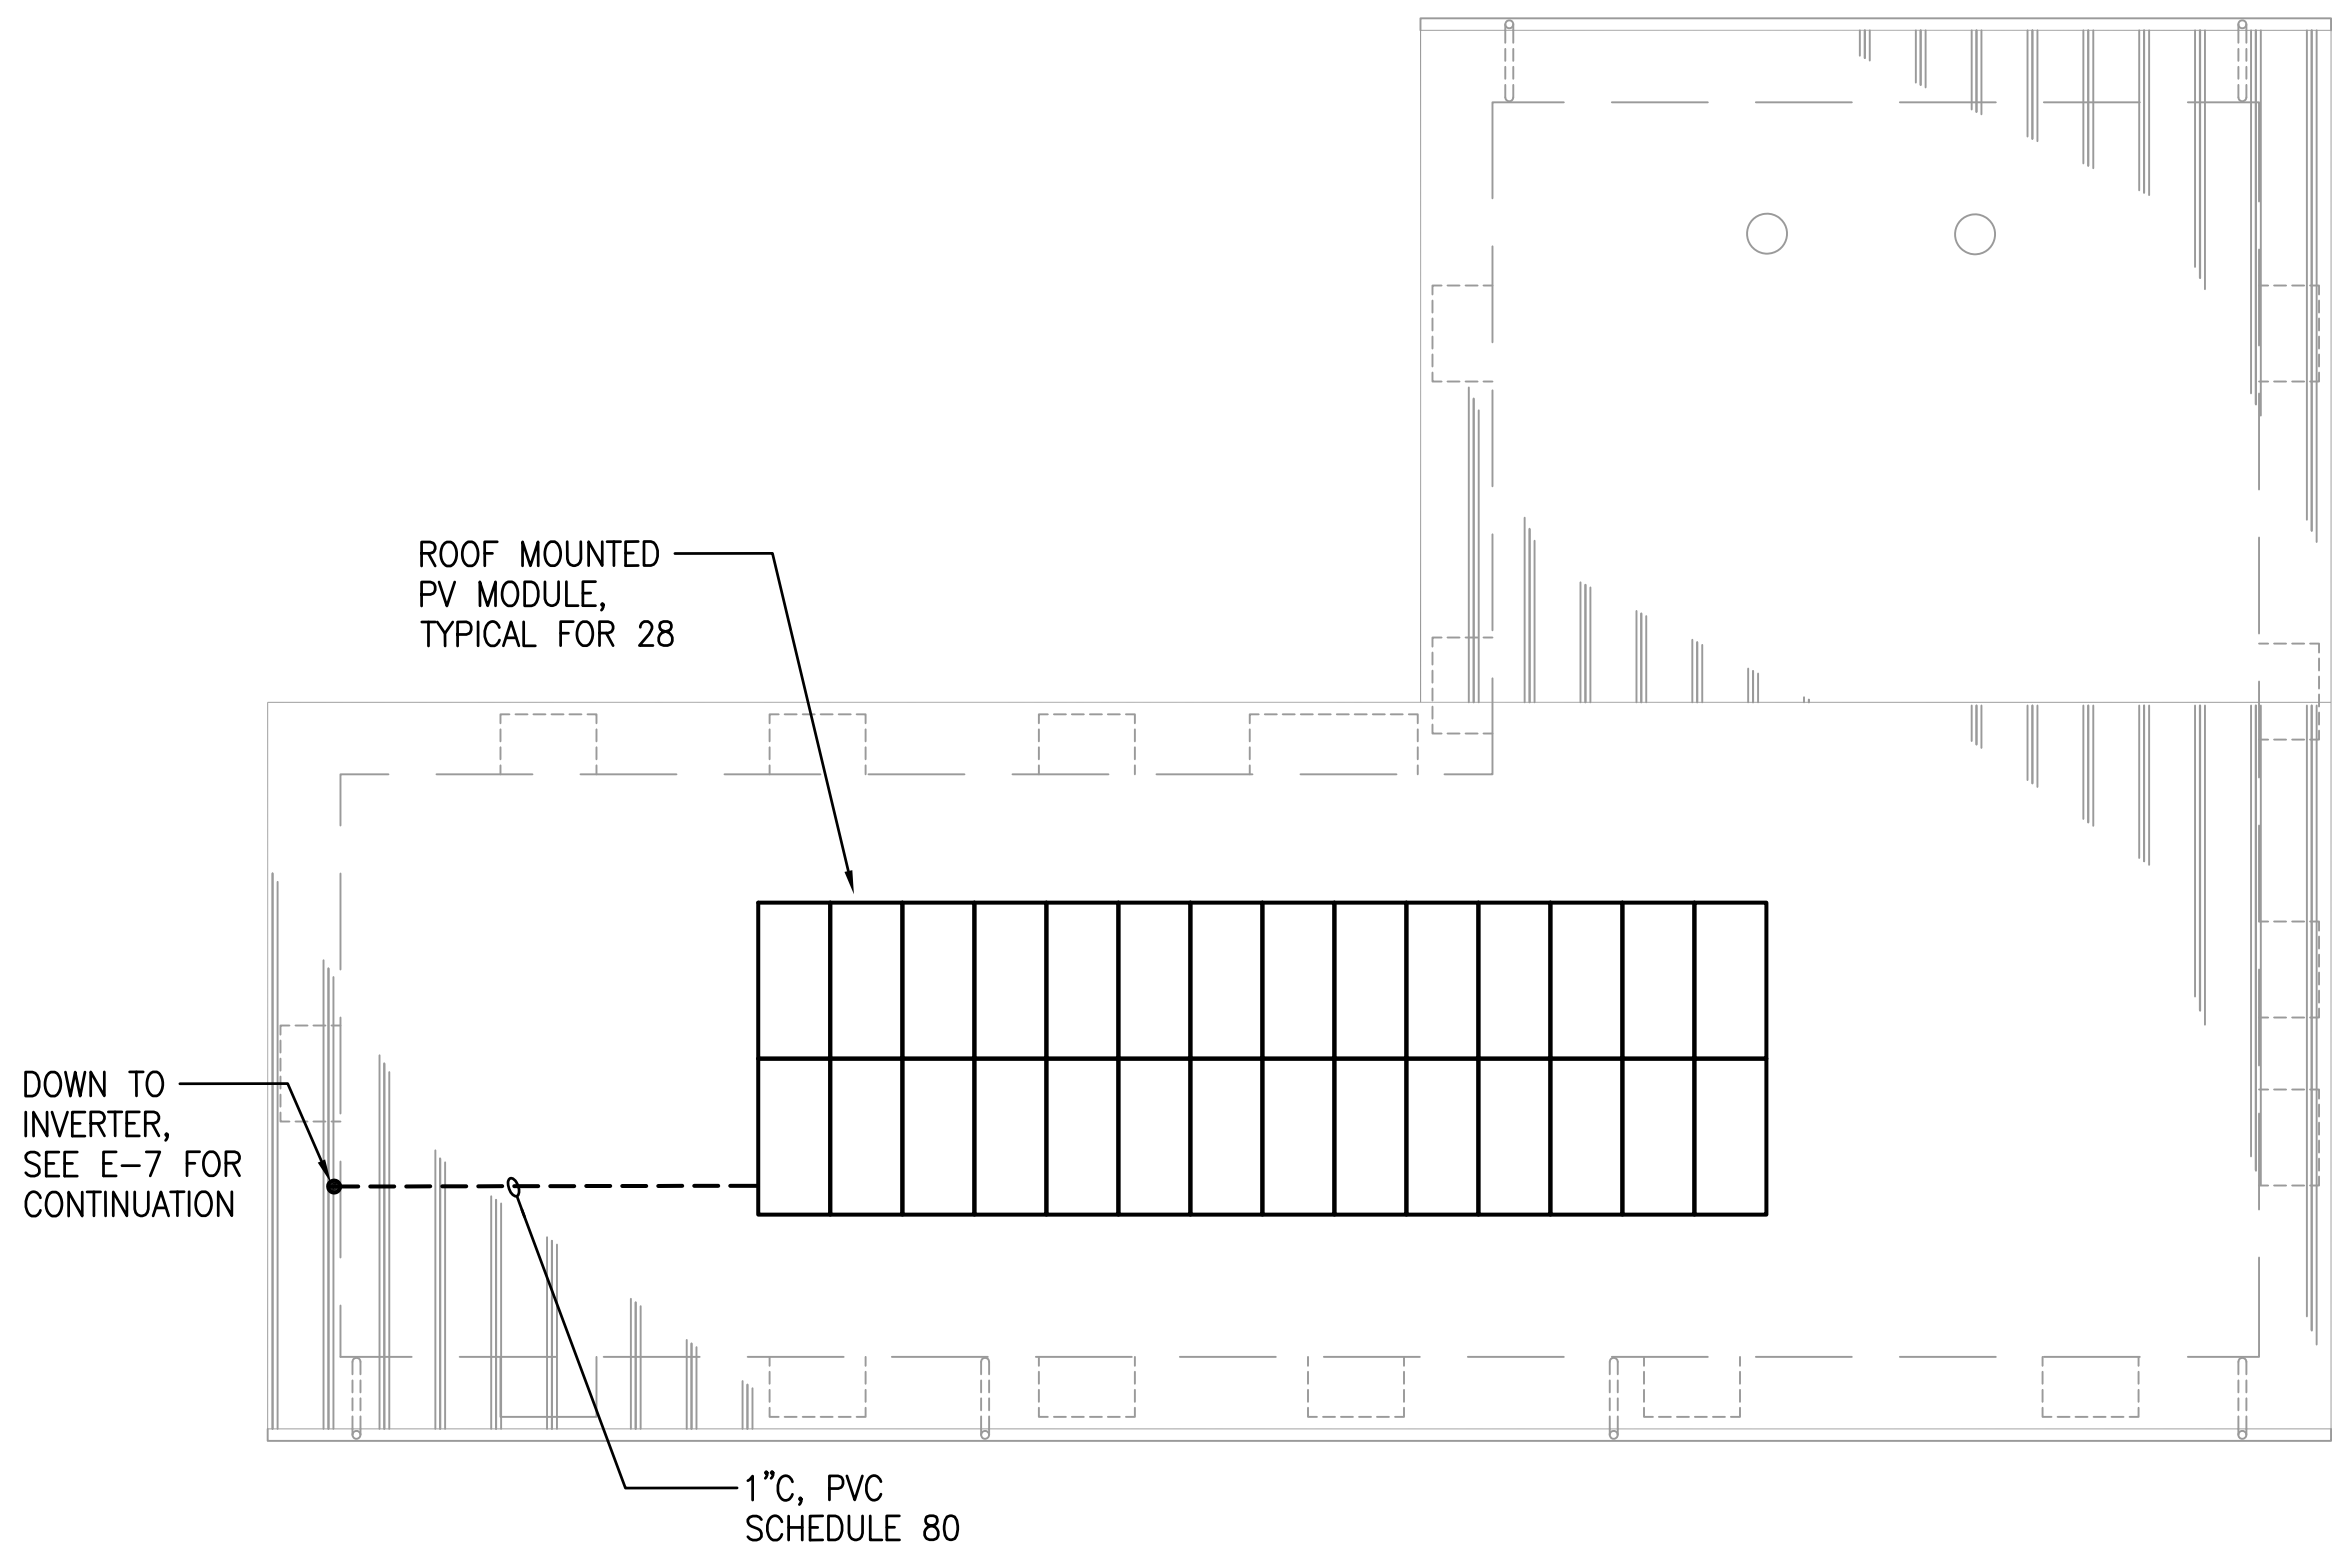

1 ROOF ELECTRICAL PLAN - NEW OFFICE BUILDING
E20 SCALE: 1/8" = 1'-0"


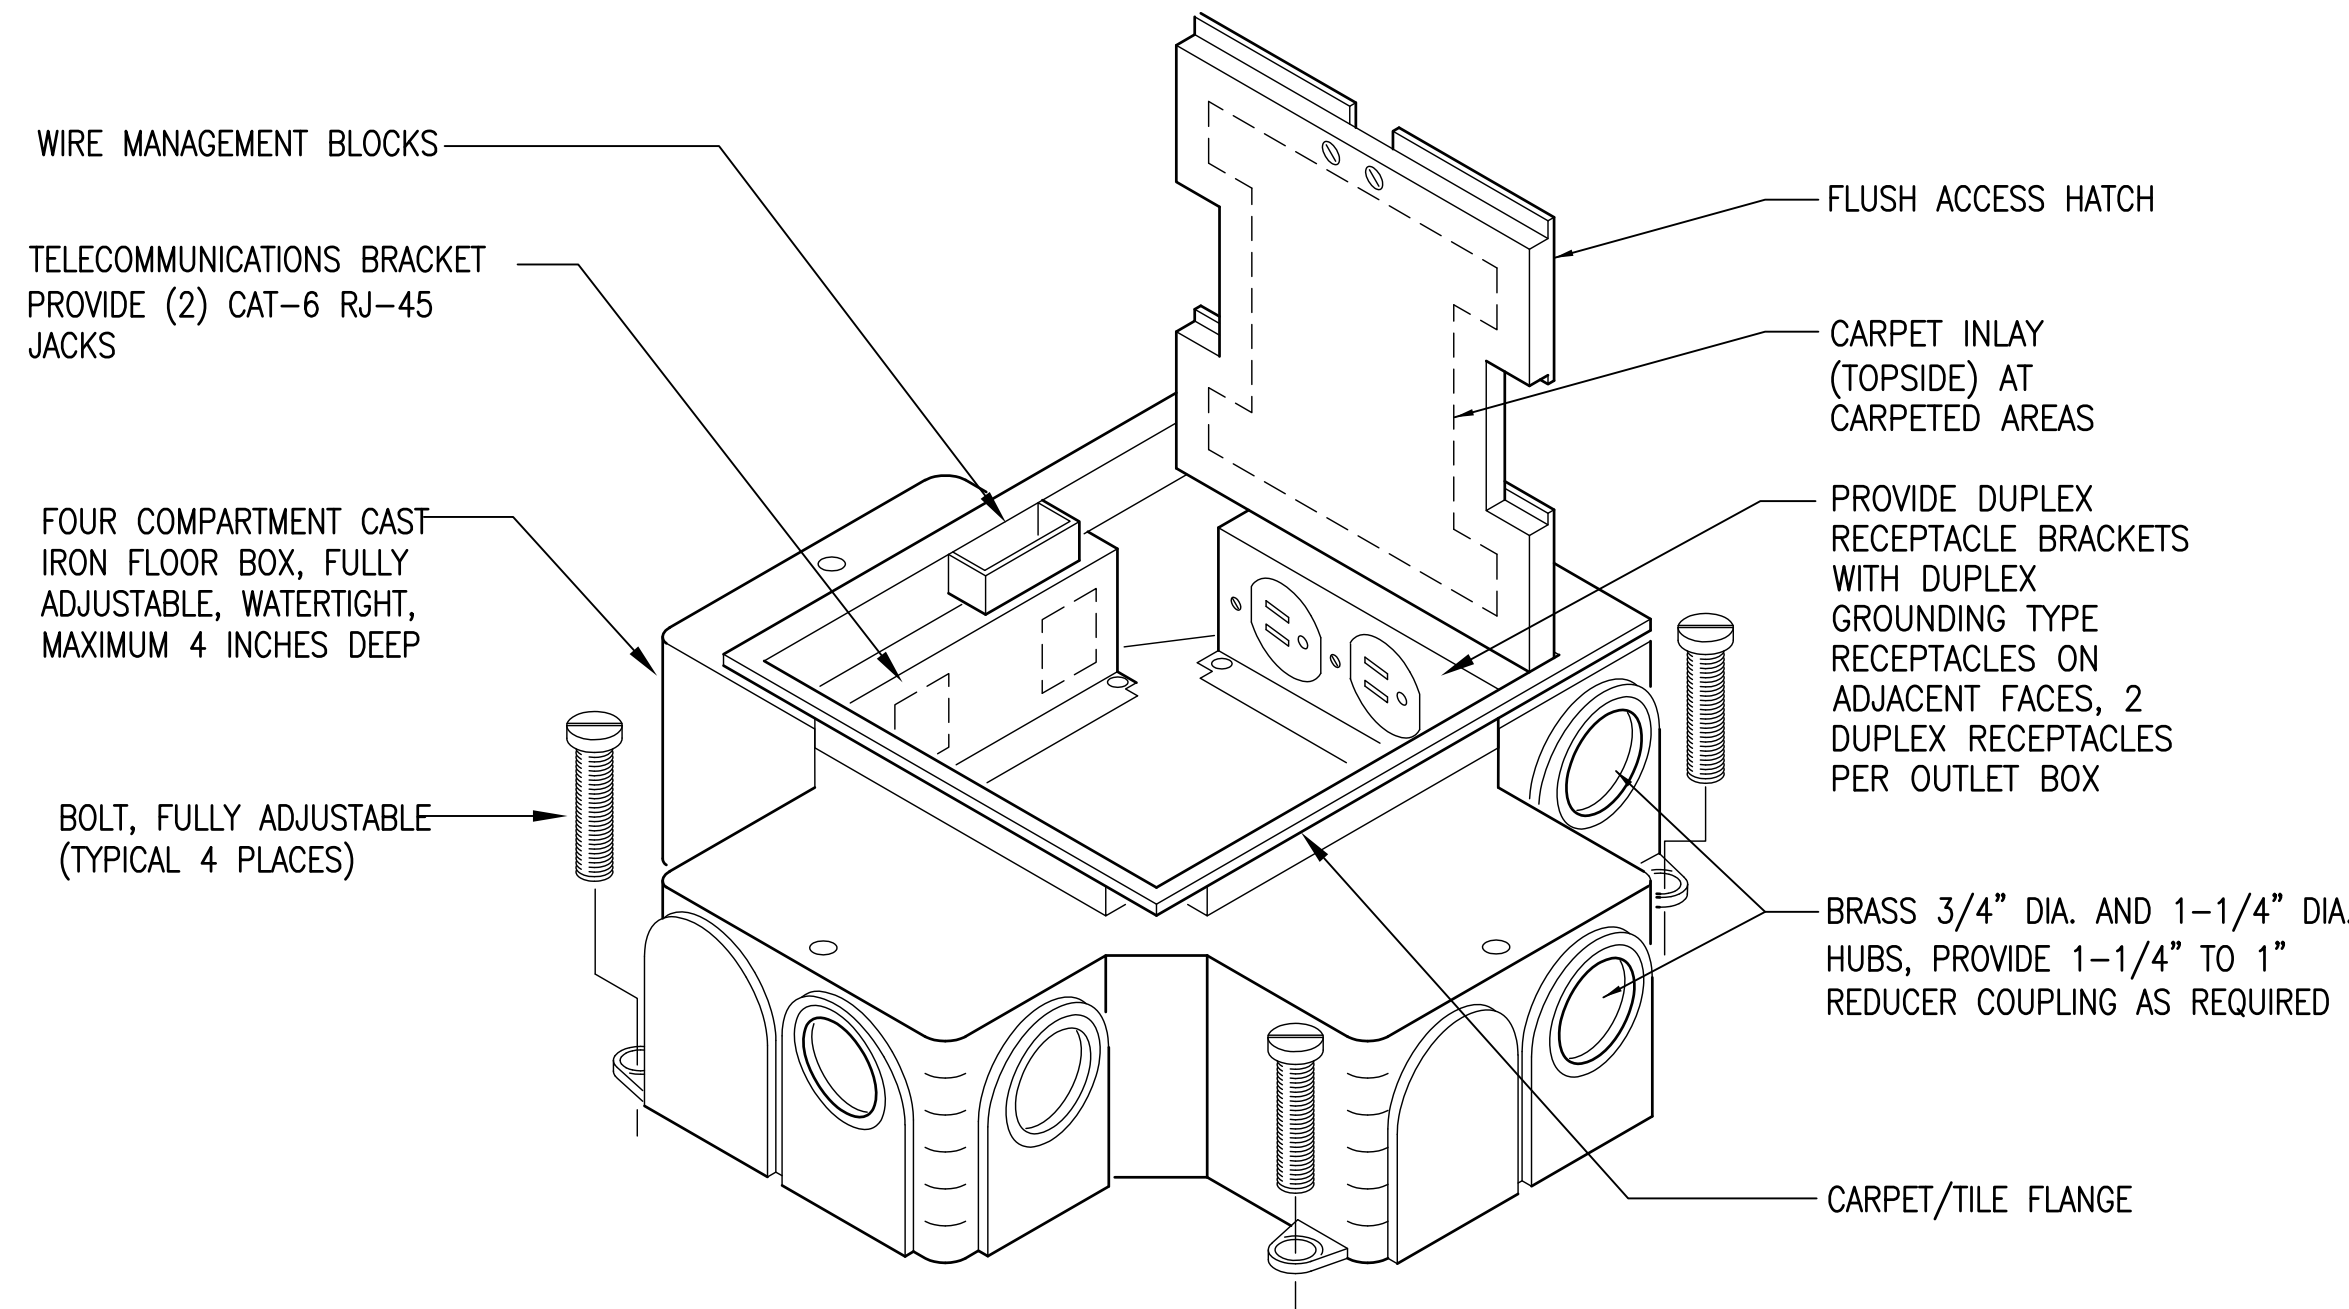


2 FLOOR OUTLET
E20 NO SCALE

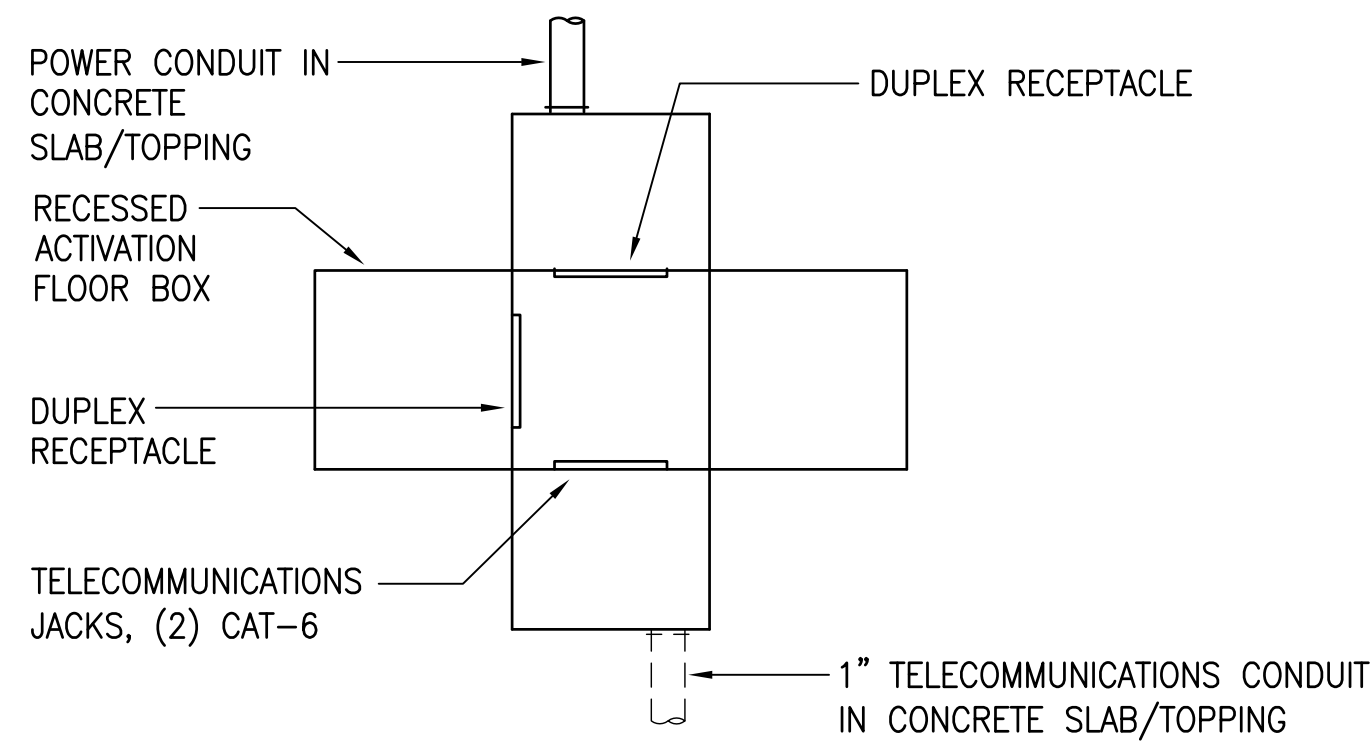

3 FLOOR OUTLET CONDUIT ROUTING
E20 NO SCALE

GRAPHIC SCALE

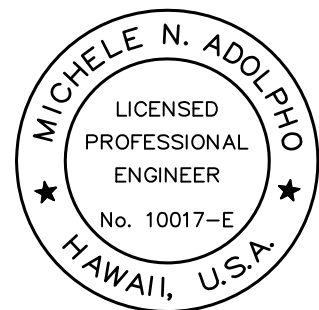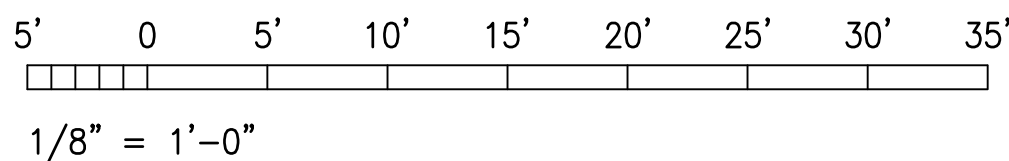

Michele N. Adolpho
PROJECT ENGINEER for ECS, Inc.
APRIL 30, 2024
EXPIRATION DATE OF THE LICENSE

STATE OF HAWAII
DEPARTMENT OF TRANSPORTATION
HIGHWAYS DIVISION

MISCELLANEOUS ELECTRICAL DETAILS

MAUI DISTRICT BASEYARD
Project No. HWY-M-ART18.01
Scale: AS SHOWN Date: MAY 2022
SHEET No. E20 OF 80 SHEETS