


FED. ROAD DIST. NO.	STATE	PROJ. NO.	FISCAL YEAR	SHEET NO.	TOTAL SHEETS
HAWAII	HAW.	HWY-M-ART18-01	2022	62	80

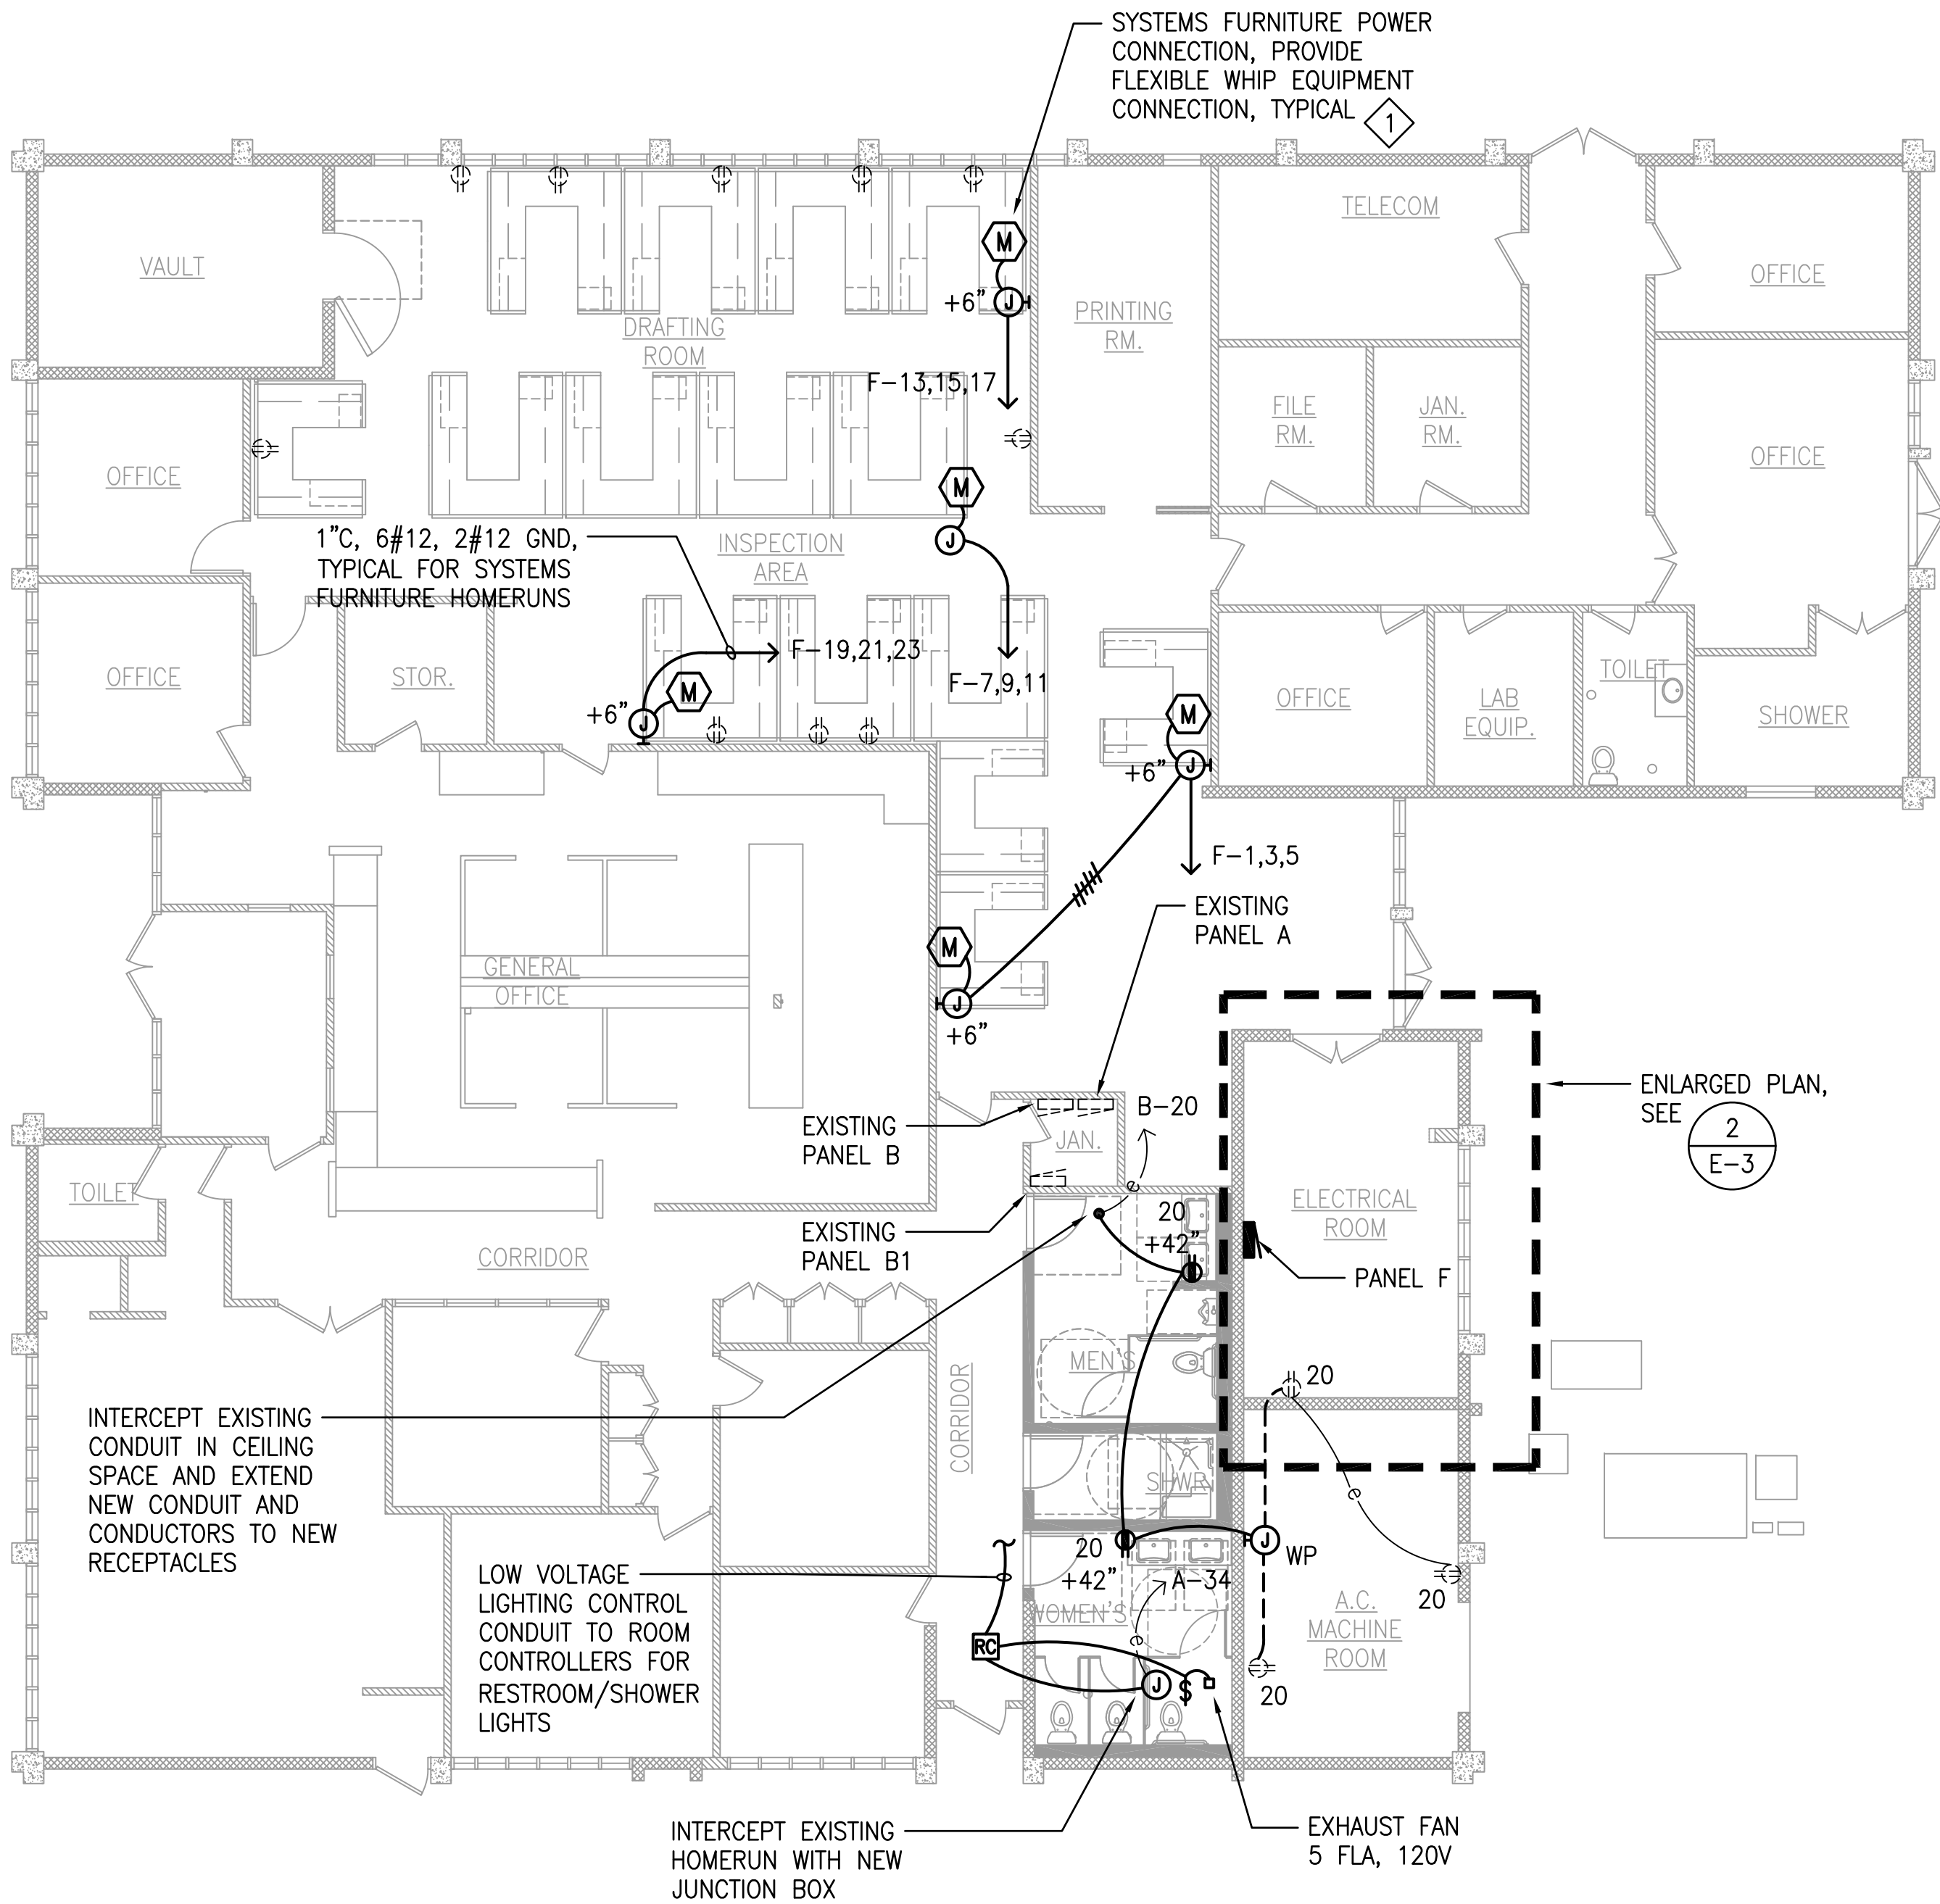


1
E5

POWER AND OUTLETS PLAN - EXISTING OFFICE BUILDING

SCALE: 1/8" = 1'-0"

NOTES:

- 1 A 3-CIRCUIT, 8 WIRE SYSTEM (3 HOT, 3 NEUTRAL, 2 GROUND CONDUCTORS) FURNITURE POWER DISTRIBUTION SYSTEM IS ASSUMED. COORDINATE SPECIFIC WIRING REQUIREMENTS, LOCATIONS OF SERVICE JUNCTION BOXES, AND RECEPTACLE CIRCUIT ASSIGNMENTS WITH THE SYSTEMS FURNITURE SYSTEM PROVIDER.
- 2 SYSTEM FURNITURE TELECOMMUNICATIONS SERVICE JUNCTION BOX. PROVIDE FLEXIBLE WHIP CONNECTION TO TRANSITION FROM JUNCTION BOX TO SYSTEMS FURNITURE. COORDINATE AND VERIFY EXACT LOCATION OF SERVICE JUNCTION BOX WITH THE SYSTEMS FURNITURE PROVIDER PRIOR TO ROUGH IN.
- 3 18" SQUARE x 8" DEEP TELECOMMUNICATIONS DISTRIBUTION JUNCTION BOX IN ACCESSIBLE CEILING SPACE.


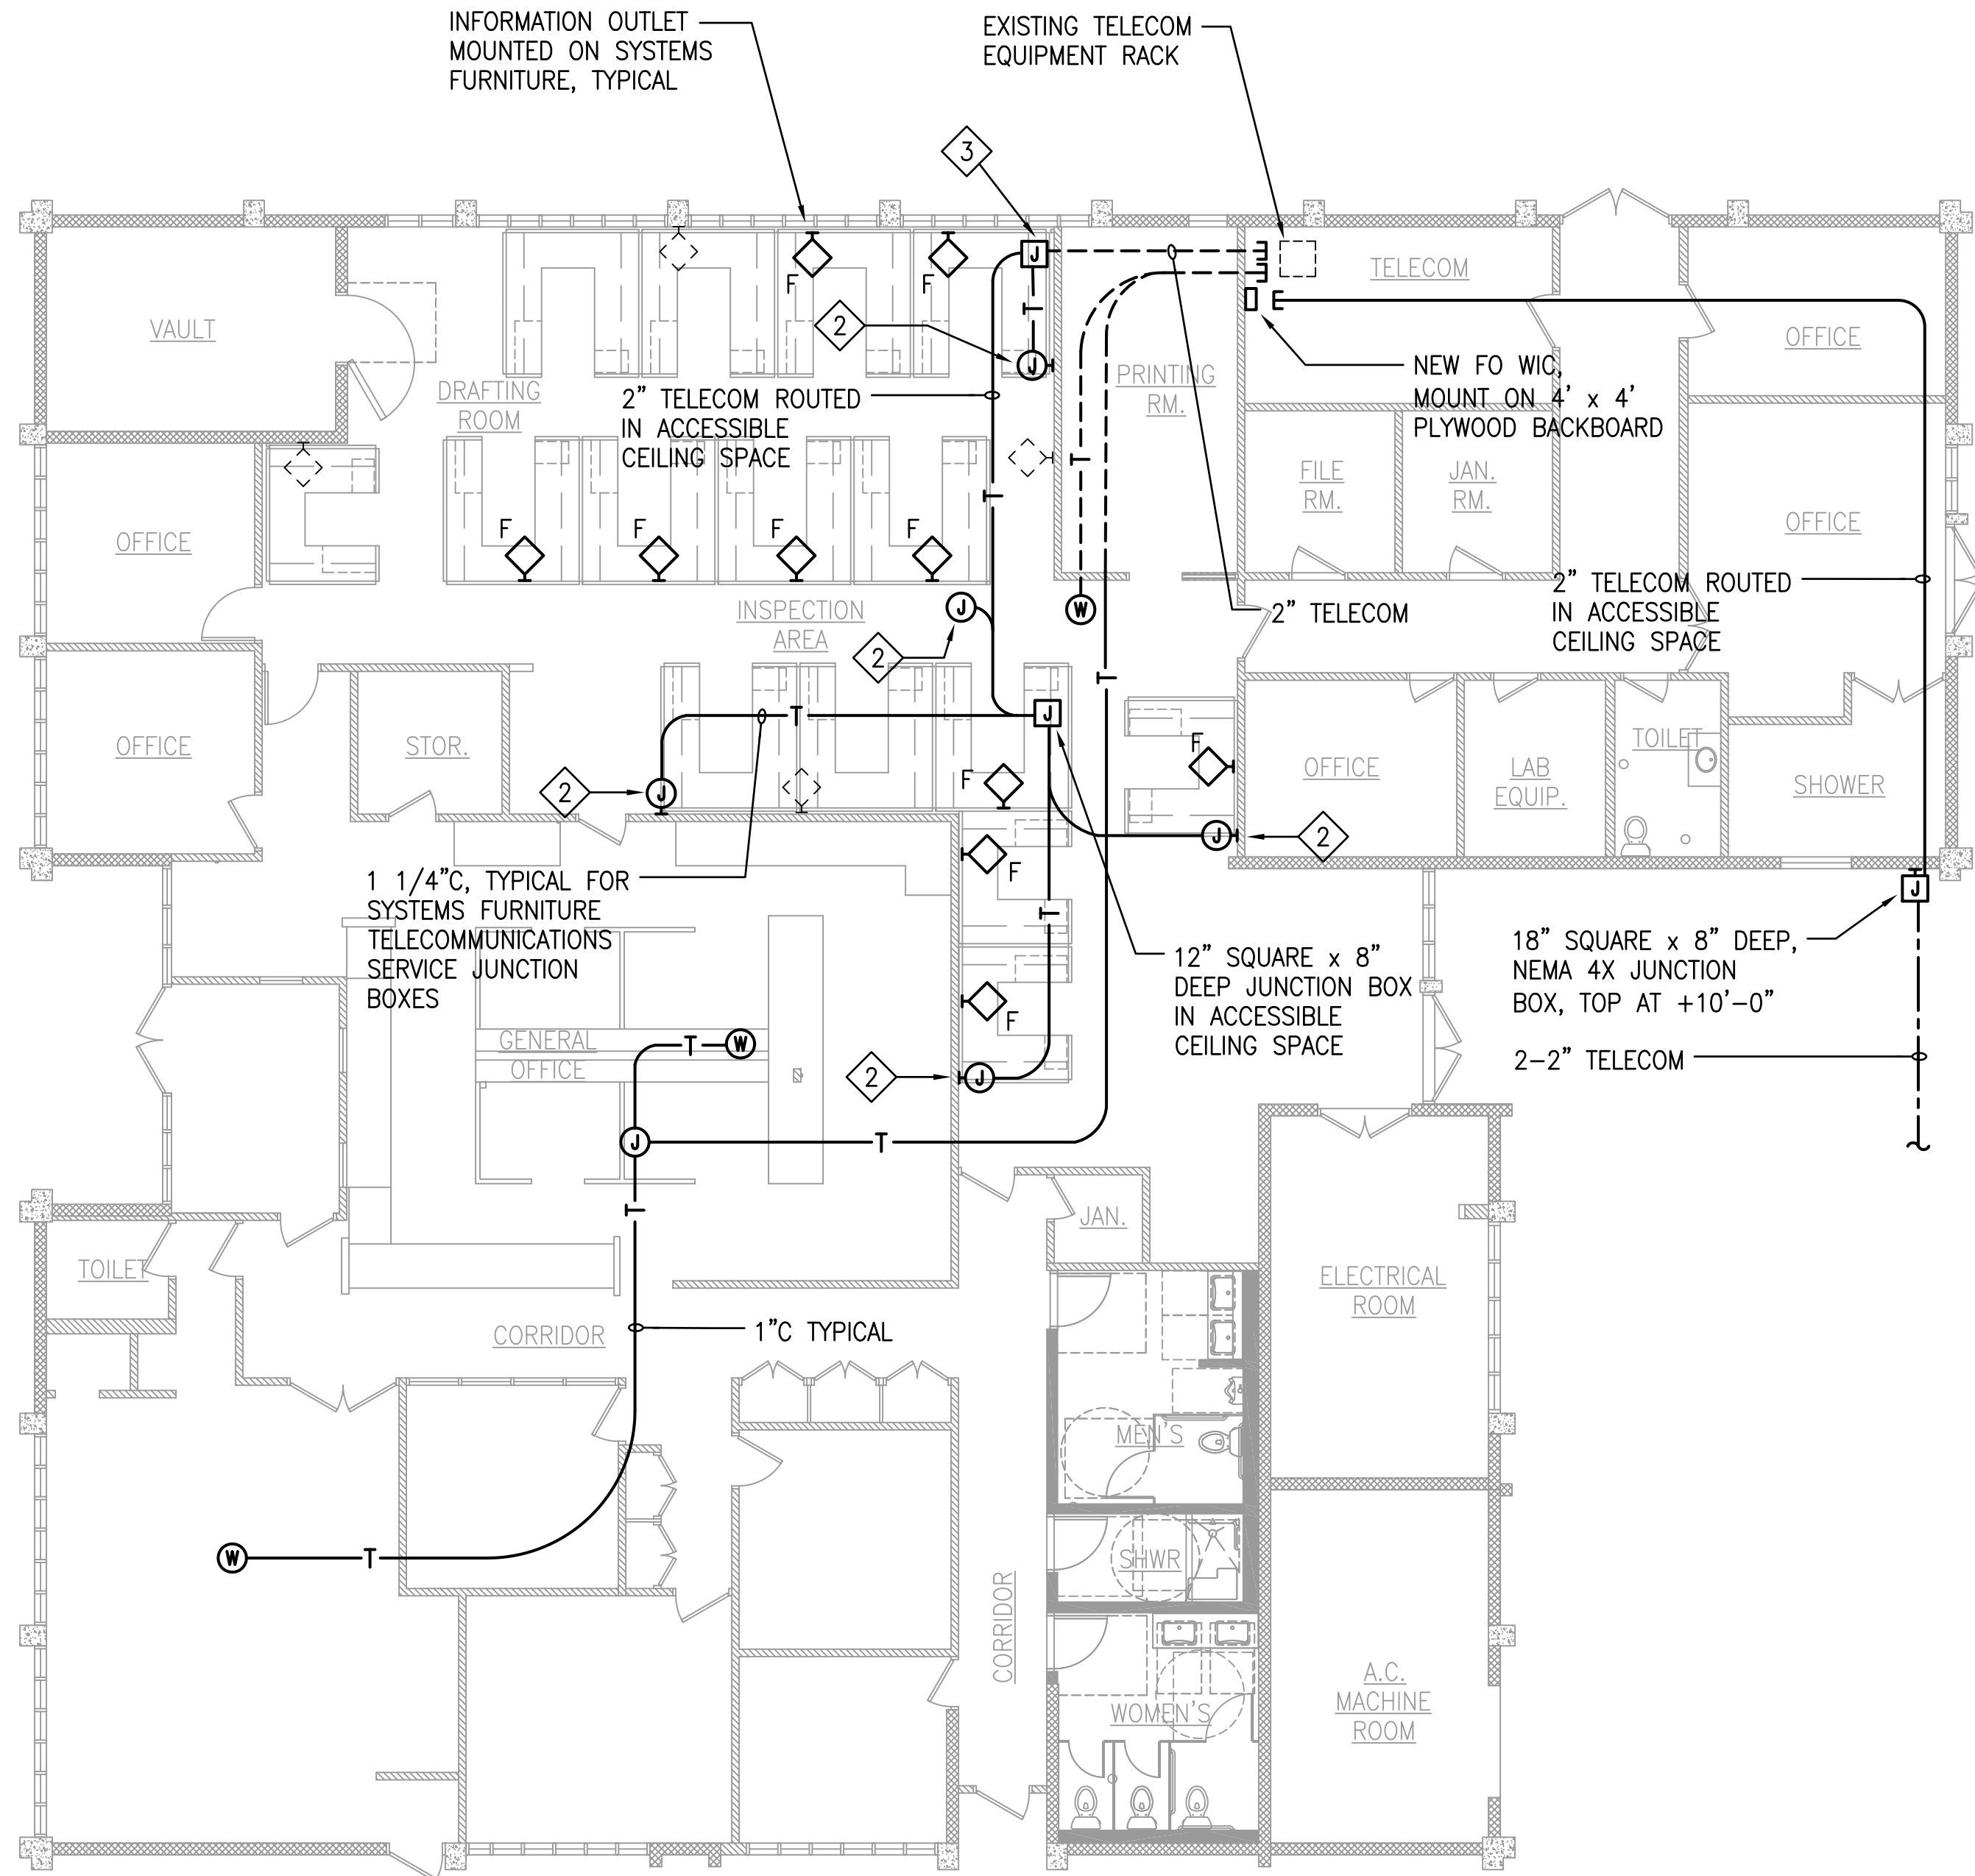


2
E5

TELECOMMUNICATIONS PLAN - EXISTING OFFICE BUILDING

SCALE: 1/8" = 1'-0"

GRAPHIC SCALE:

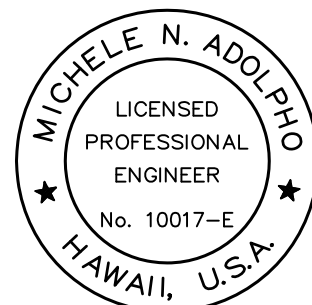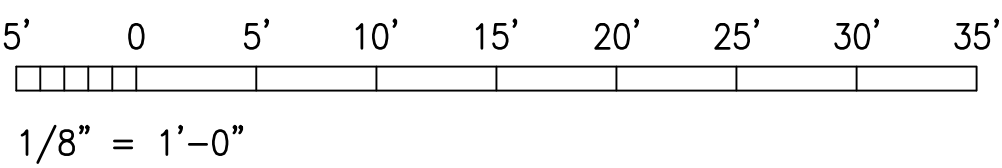

Michele N. Adolpho
PROJECT ENGINEER for ECS, Inc.
APRIL 30, 2024
EXPIRATION DATE OF THE LICENSE

STATE OF HAWAII
DEPARTMENT OF TRANSPORTATION
HIGHWAYS DIVISION

POWER AND OUTLETS PLAN - EXISTING OFFICE BUILDING

MAUI DISTRICT BASEYARD
Project No. HWY-M-ART18.01

Scale: AS SHOWN Date: MAY 2022

SHEET No. E5 OF 80 SHEETS

DESIGNED BY	_____
CHECKED BY	_____
DRAWN BY	_____
DATE	_____
SCALE	_____
PROJECT NO.	_____
SHEET NO.	_____
TOTAL SHEETS	_____