


FED. ROAD DIST. NO.	STATE	PROJ. NO.	FISCAL YEAR	SHEET NO.	TOTAL SHEETS
HAWAII	HAW.	HWY-M-ART18-01	2022	64	80


NOTES:

- 1 1"=, 6#12, 2#12 GND.
- 2 A 3-CIRCUIT, 8 WIRE SYSTEM (3 HOT, 3 NEUTRAL, 2 GROUND CONDUCTORS) FURNITURE POWER DISTRIBUTION SYSTEM IS ASSUMED. COORDINATE SPECIFIC WIRING REQUIREMENTS, LOCATIONS OF SERVICE JUNCTION BOXES, AND RECEPTACLE CIRCUIT ASSIGNMENTS WITH THE SYSTEMS FURNITURE SYSTEM PROVIDER.

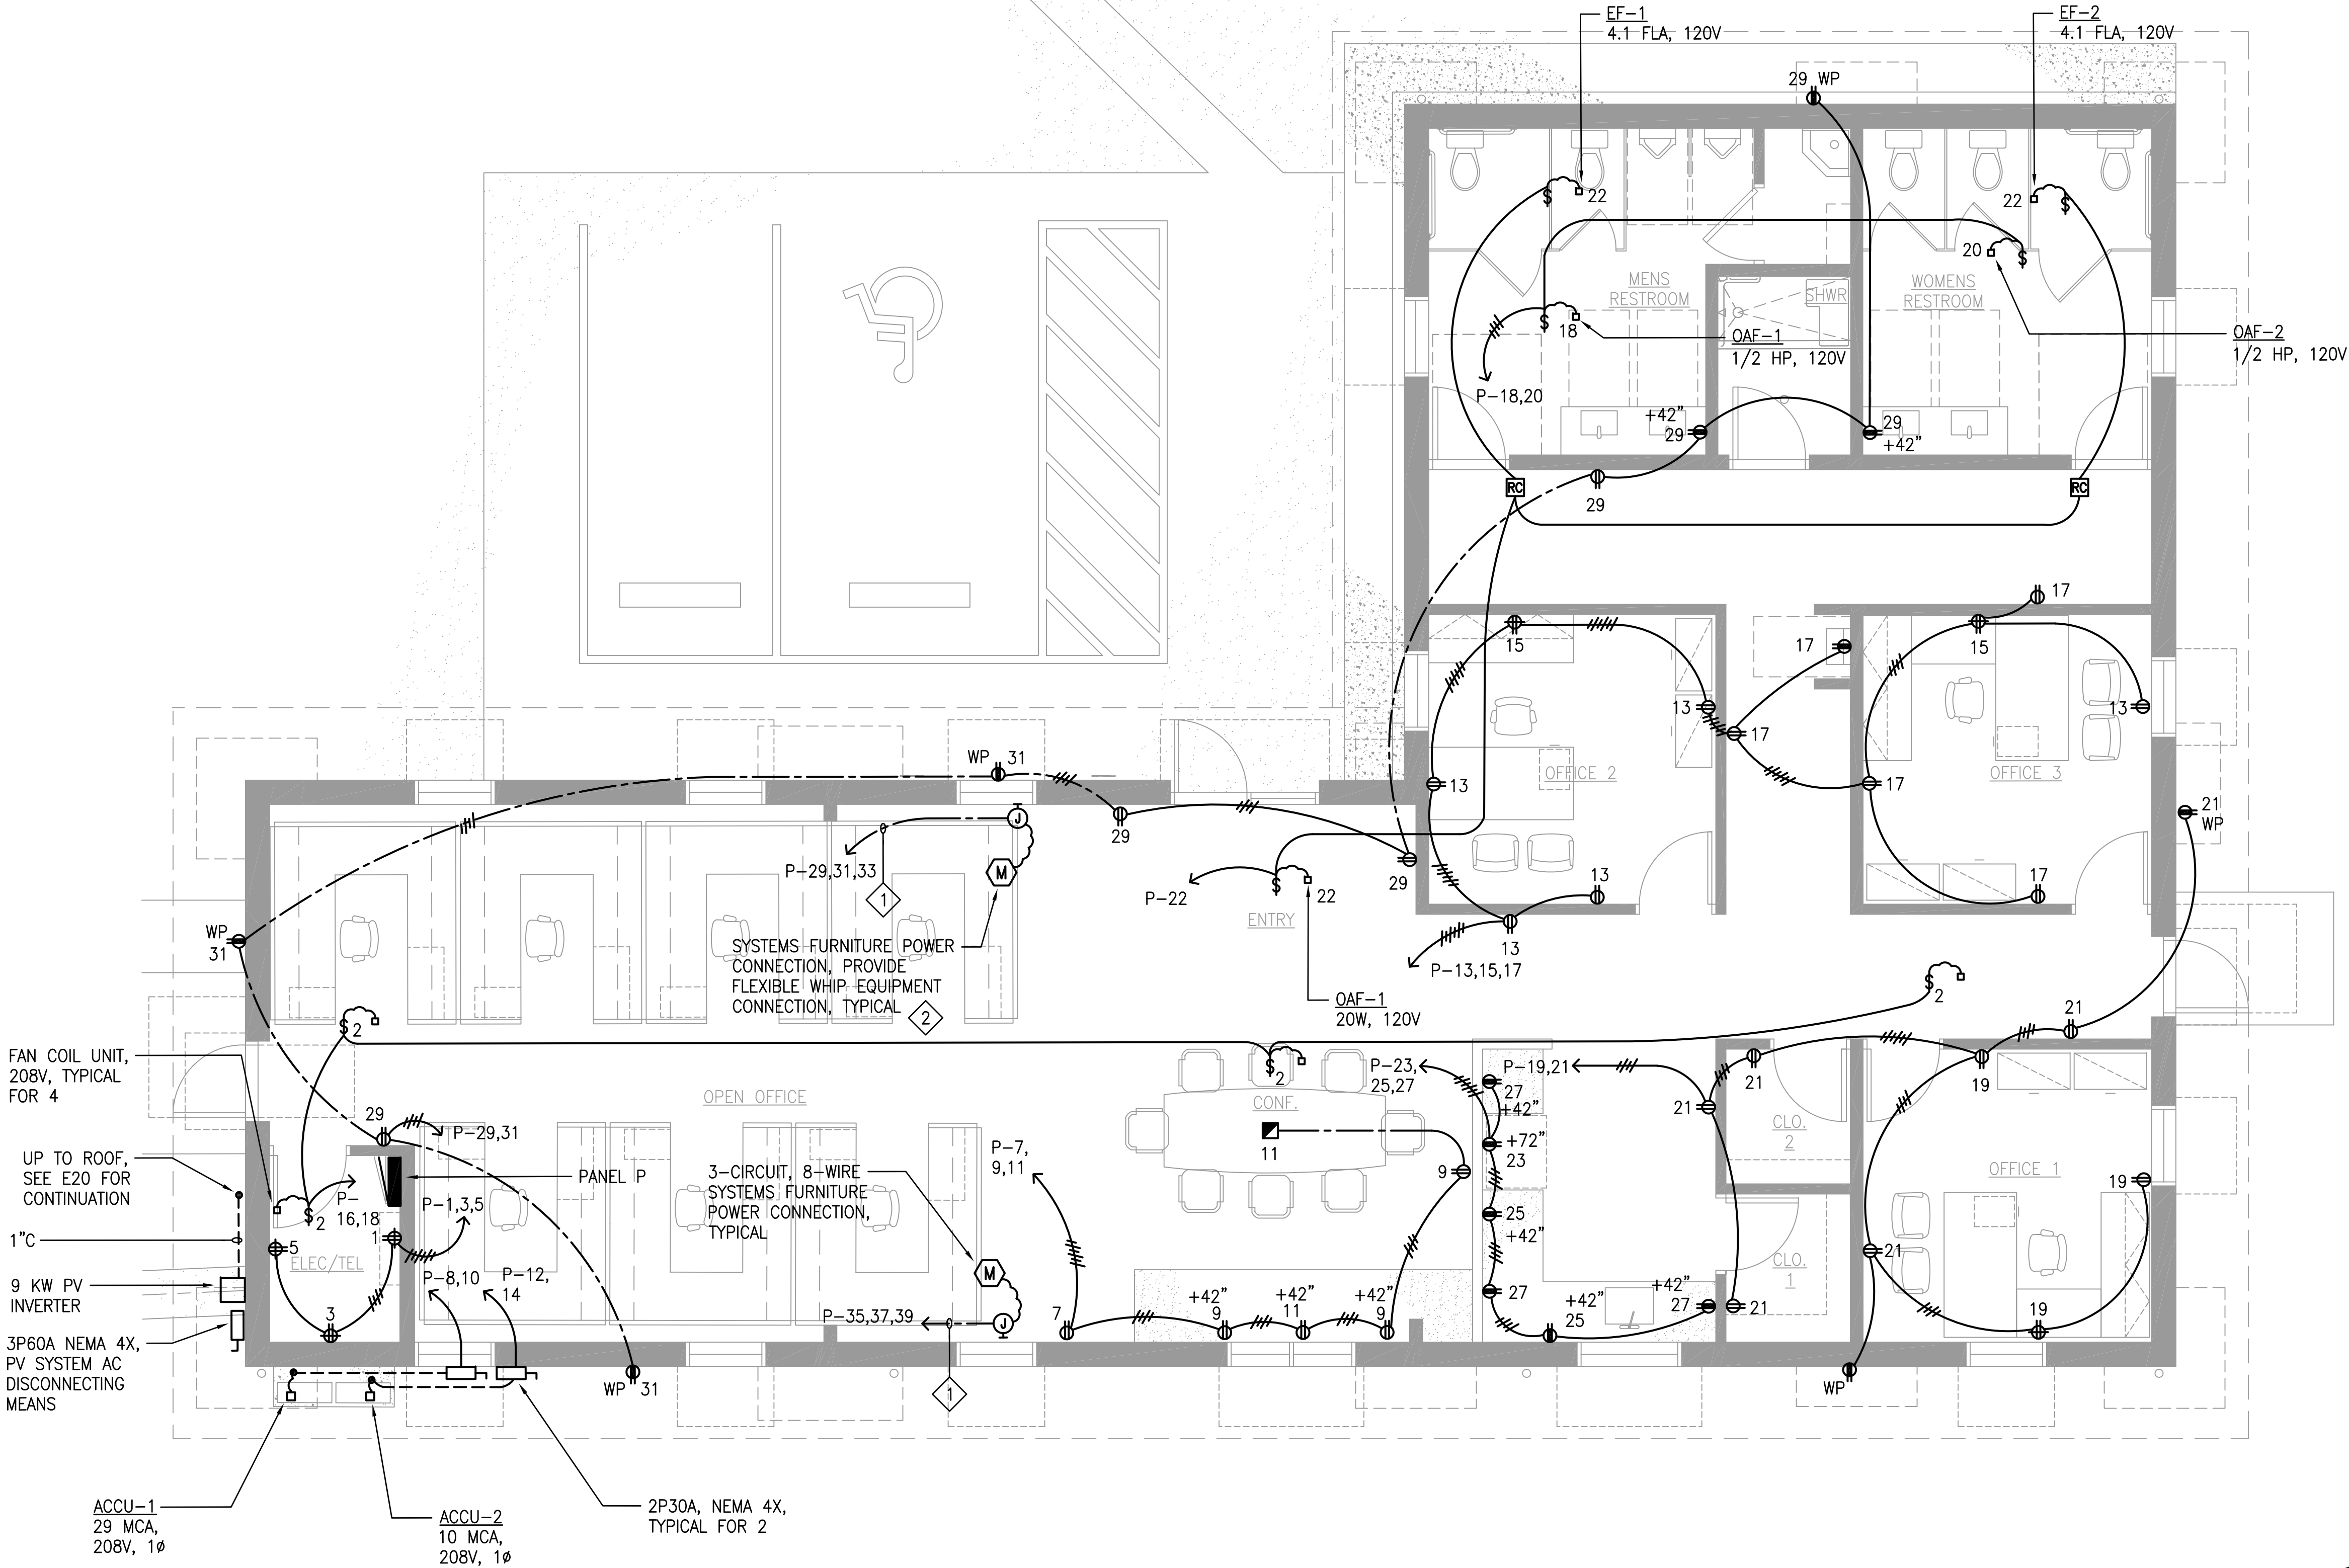

1 POWER PLAN - NEW OFFICE BUILDING
E7 SCALE: 1/4" = 1'-0"

GRAPHIC SCALE

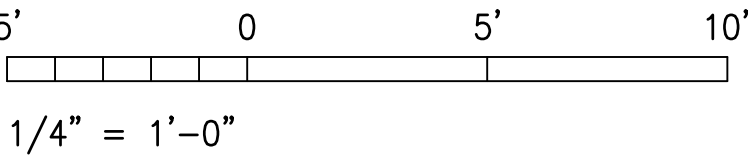

PROJECT ENGINEER for ECS, Inc.
APRIL 30, 2024
EXPIRATION DATE OF THE LICENSE

STATE OF HAWAII
DEPARTMENT OF TRANSPORTATION
HIGHWAYS DIVISION

POWER PLAN - NEW OFFICE BUILDING

MAUI DISTRICT BASEYARD
Project No. HWY-M-ART18.01

Scale: AS SHOWN Date: MAY 2022

SHEET No. E7 OF 80 SHEETS