

FED. ROAD DIST. NO.	STATE	PROJ. NO.	FISCAL YEAR	SHEET NO.	TOTAL SHEETS
HAWAII	HAW.	HWY-M-ART18-01	2022	23	80


GENERAL NOTES:

- REFER TO MECHANICAL SHEETS FOR ALL HVAC, PLUMBING ITEMS BUT NOT LIMITED TO HVAC EQUIPMENT, PIPING, DUCTING, PIPING SUPPORTS AND CHILL WATER PIPING, AND CONNECTIONS.
- REFER TO ELECTRICAL SHEETS FOR ALL POWER, FIRE ALARM, IT, AND LIGHTING WORK.

LEGEND:

- 2X2 RECESSED LED LIGHT FIXTURE, SEE ELECTRICAL SHEETS.
- 5" LED RECESSED LINEAR SLOT LIGHT FIXTURE, SEE ELECTRICAL SHEETS.
- 4" RECESSED LED LIGHT FIXTURE, SEE ELECTRICAL SHEETS.
- EXTERIOR WALL MOUNTED LED LIGHT FIXTURE, SEE ELECTRICAL SHEETS.
- ILLUMINATED LED EXIT, SEE ELECTRICAL SHEETS.
- 2X2 FIRE RATED METAL, FLUSH, ACCESS PANEL W/ LOCK.
- HVAC SUPPLY REGISTER, SEE MECH SHEETS.
- HVAC RETURN REGISTER, SEE MECH SHEETS.
- WINDOW CANOPY.

KEY PLAN:

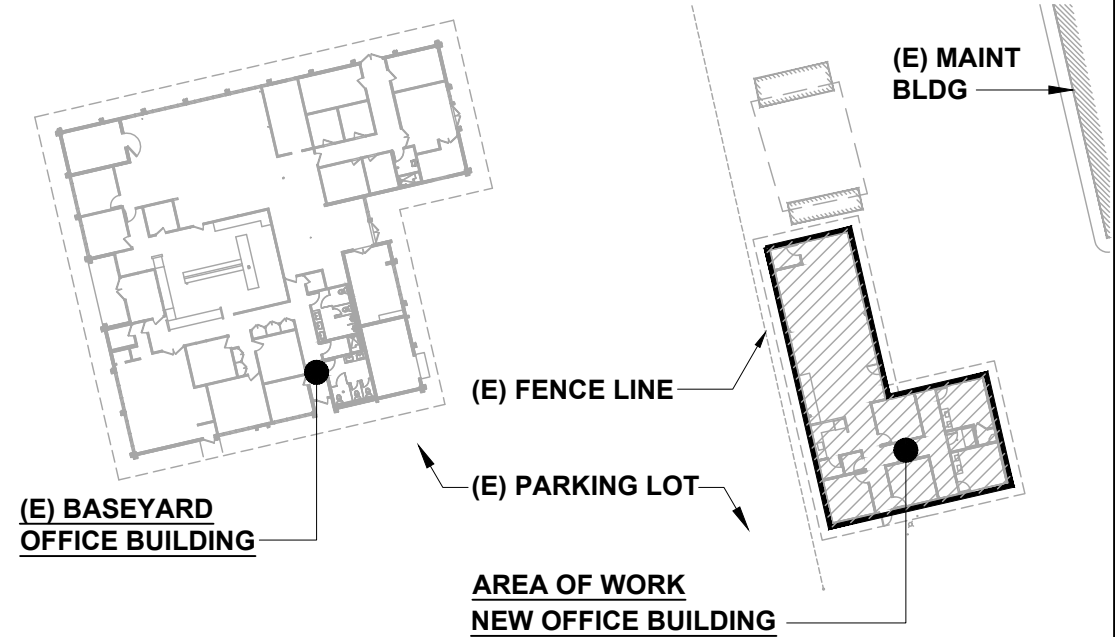

This work was prepared by me or under my supervision and construction of the project will be under my observation. Expiration date 04/30/24.

STATE OF HAWAII
DEPARTMENT OF TRANSPORTATION
HIGHWAYS DIVISION

REFLECTED CEILING PLAN
NEW OFFICE BUILDING

MAUI DISTRICT BASEYARD
Project No. HWY-M-ART18.01

Scale: AS SHOWN Date: MAY 2022

SHEET No. A9 OF 80 SHEETS

DATE	000000
SURVEY PLOTTED BY	
DRAWN BY	
DESIGNED BY	
CHECKED BY	
NOTED BY	
NS	

1 REFLECTED CEILING PLAN - NEW BASEYARD OFFICE BUILDING

SCALE: 1/4" = 1'-0"

