



FED. ROAD DIST. NO.	STATE	PROJ. NO.	FISCAL YEAR	SHEET NO.	TOTAL SHEETS
HAWAII	HAW.	HWY-M-ART18-01	2022	71	80

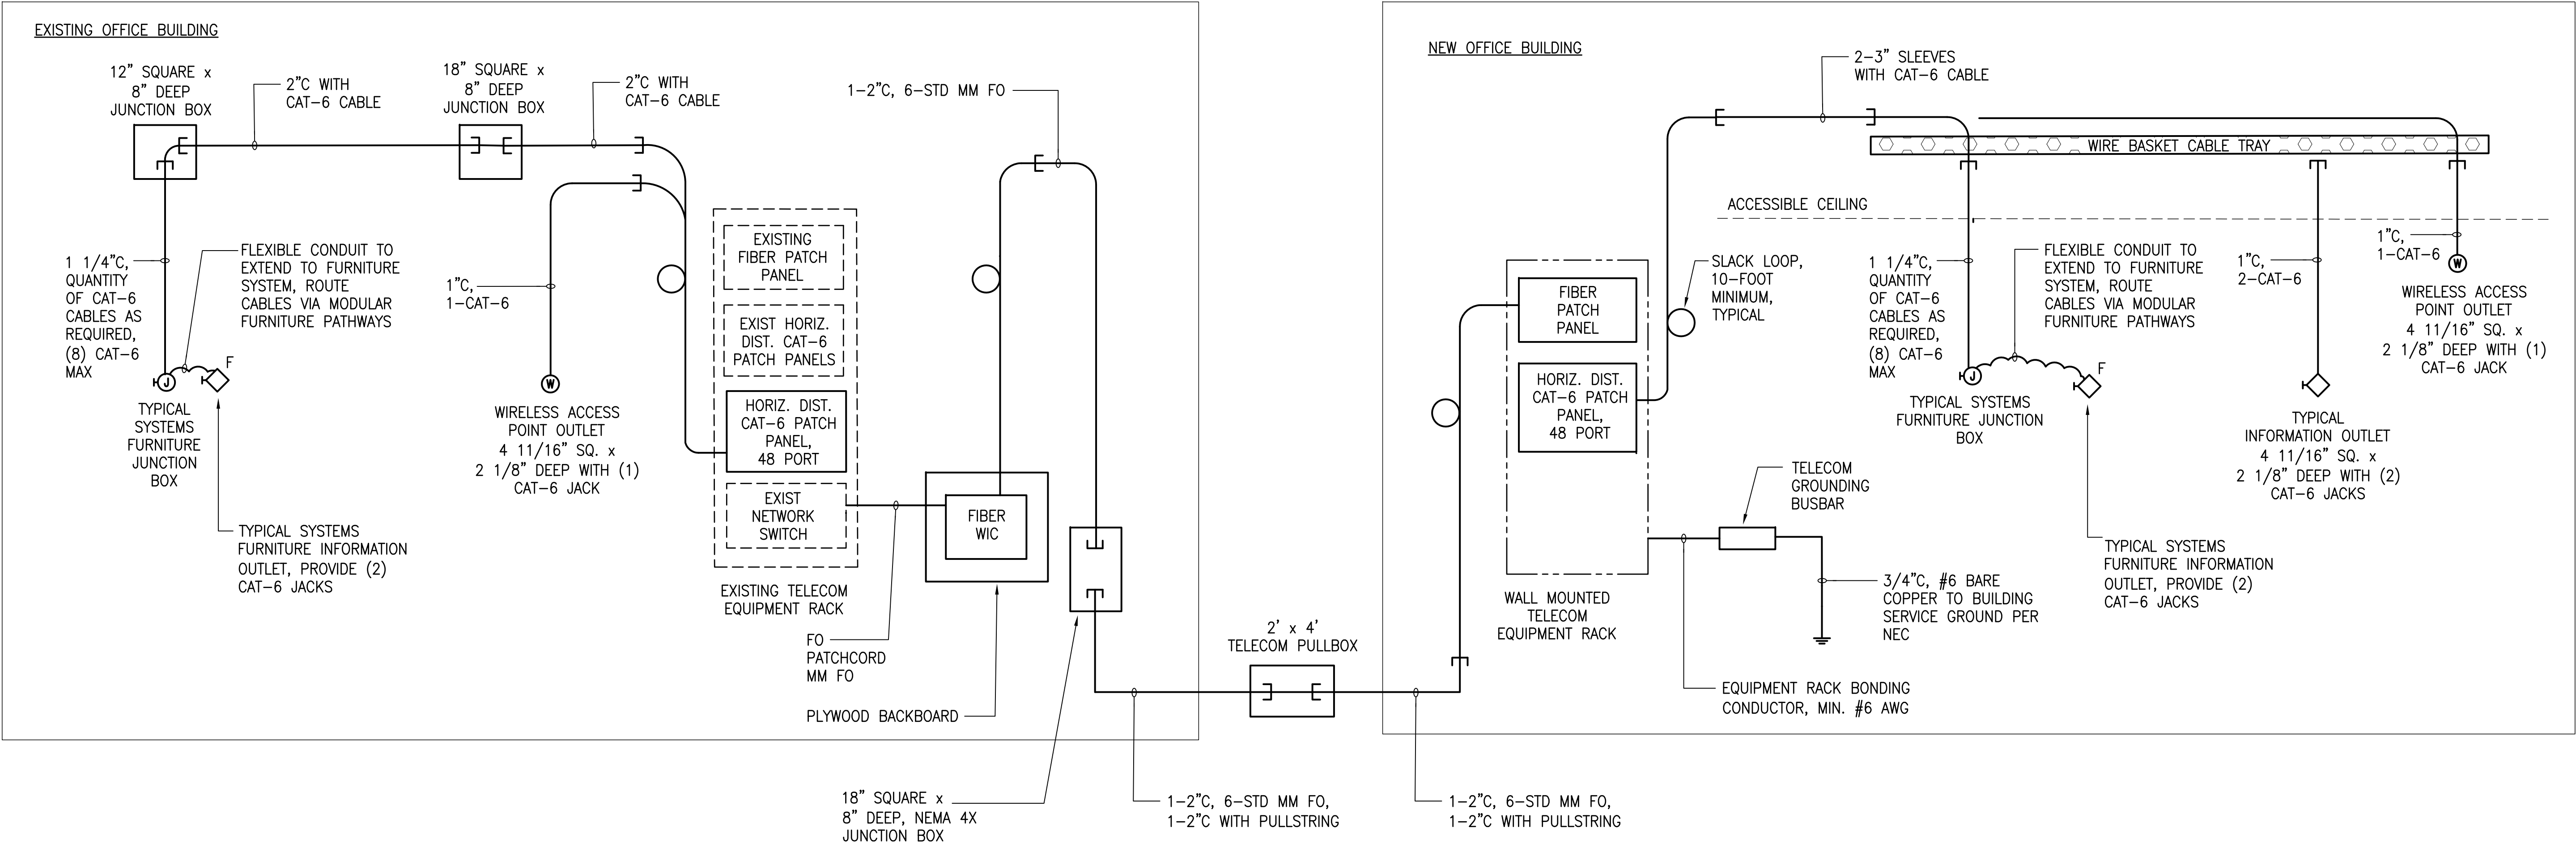


1 TELECOMMUNICATIONS RISER DIAGRAM
E14 NO SCALE

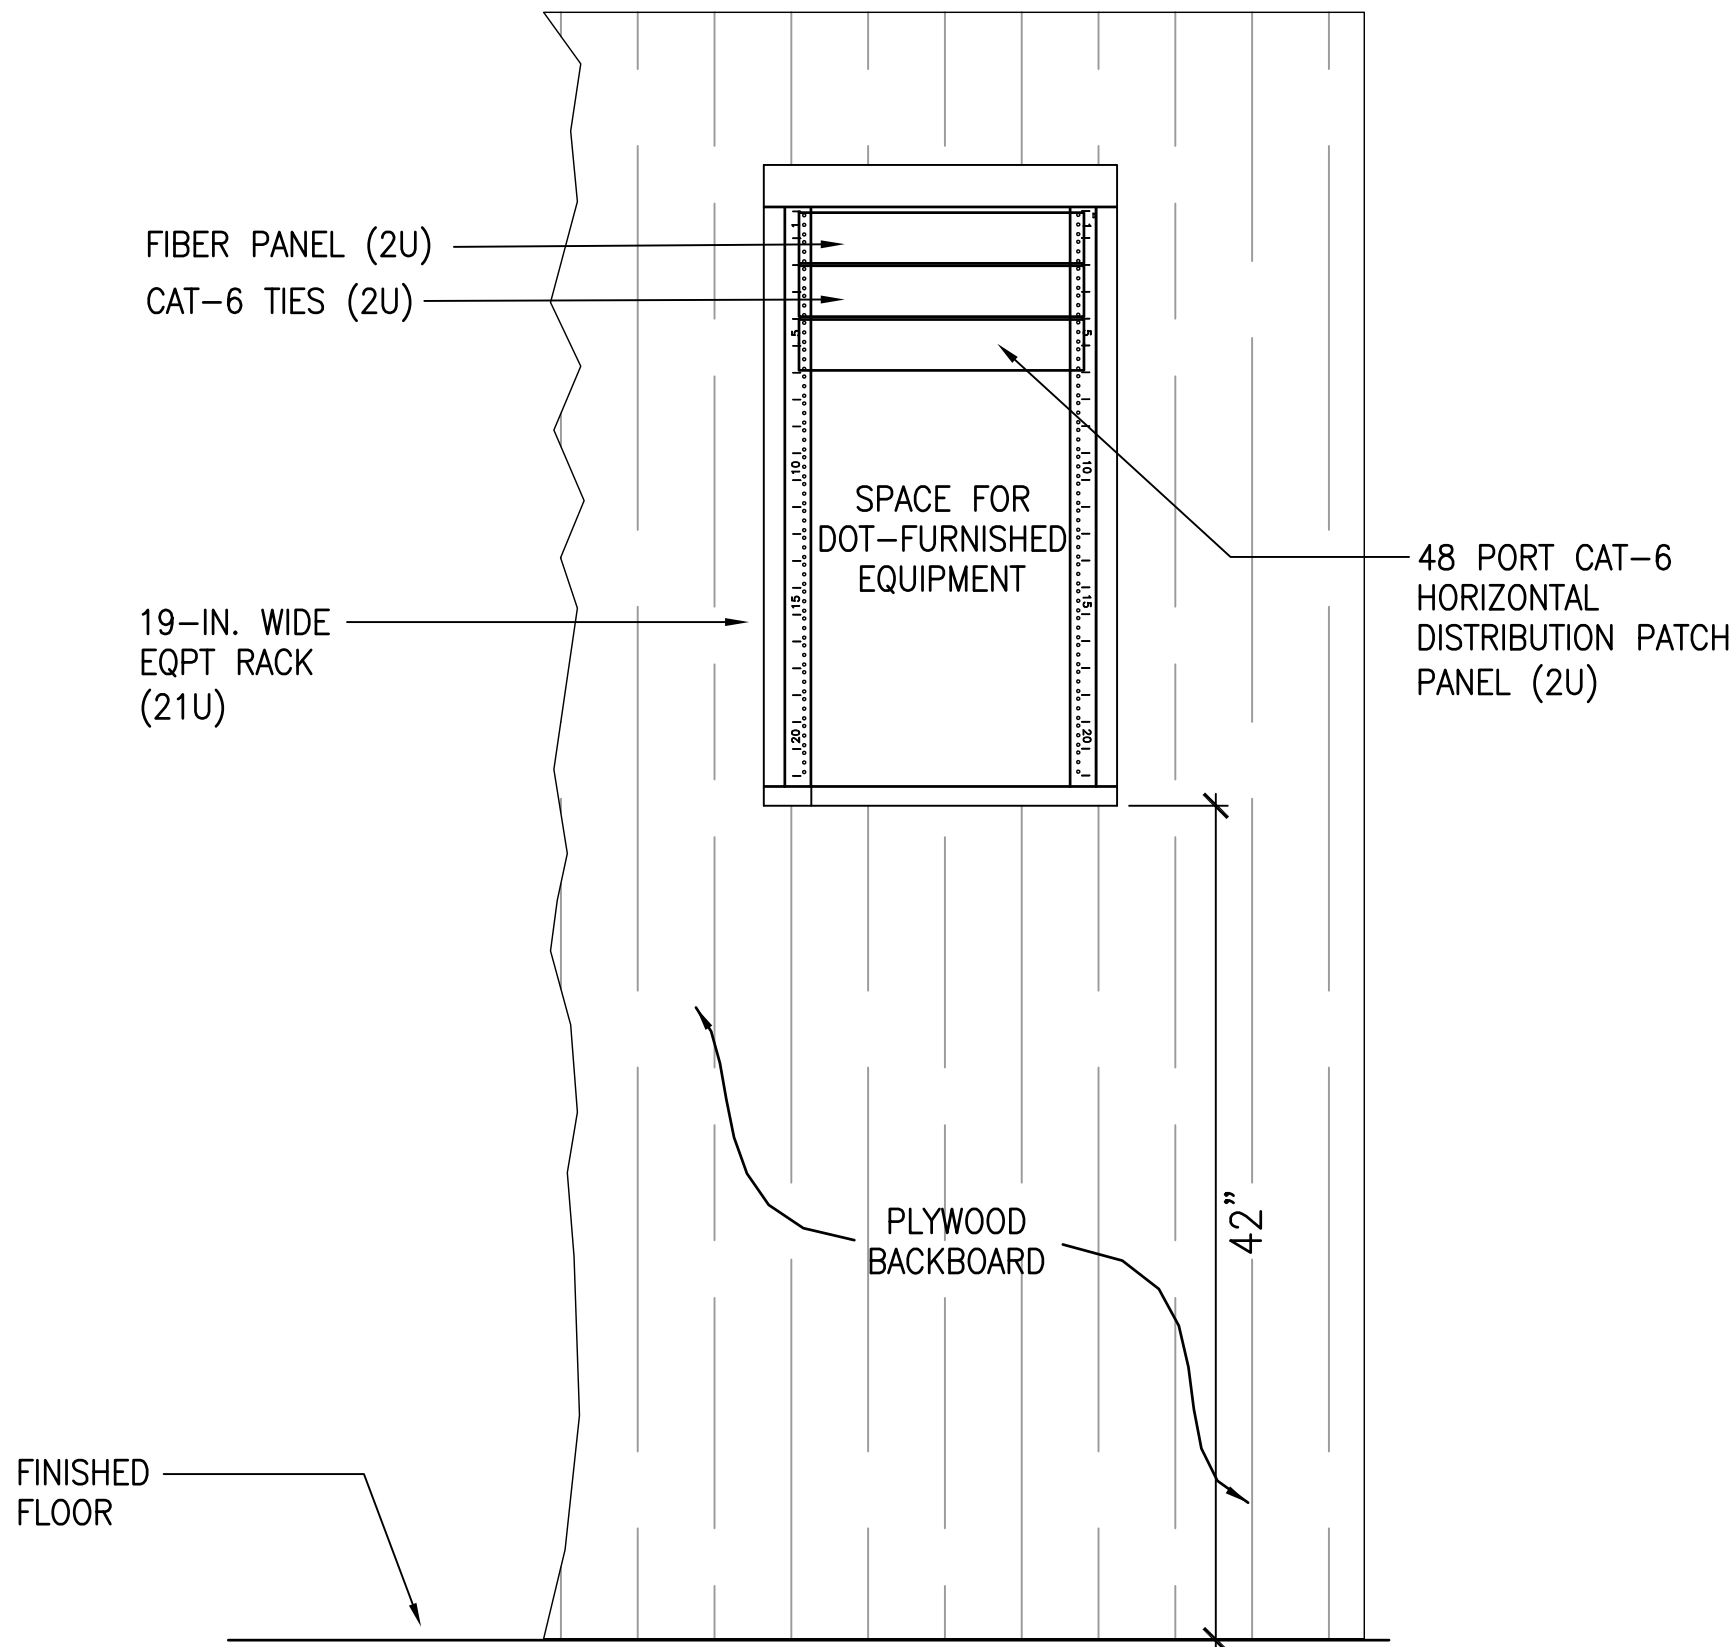

2 WALL MOUNTED TELECOM EQUIPMENT RACK ELEVATION - NEW BUILDING
E14 NOT TO SCALE

DESIGNED BY	DATE
DRAWN BY	
CHECKED BY	
IN CHARGE BY	
DATE	

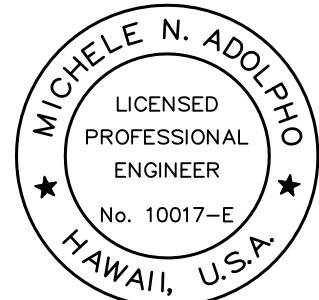

Michele N. Adolpho
PROJECT ENGINEER for ECS, Inc.
APRIL 30, 2024
EXPIRATION DATE OF THE LICENSE

STATE OF HAWAII
DEPARTMENT OF TRANSPORTATION
HIGHWAYS DIVISION

TELECOMMUNICATIONS RISER DIAGRAM

MAUI DISTRICT BASEYARD
Project No. HWY-M-ART18.01
Scale: AS SHOWN Date: MAY 2022

SHEET No. E14 OF 80 SHEETS