
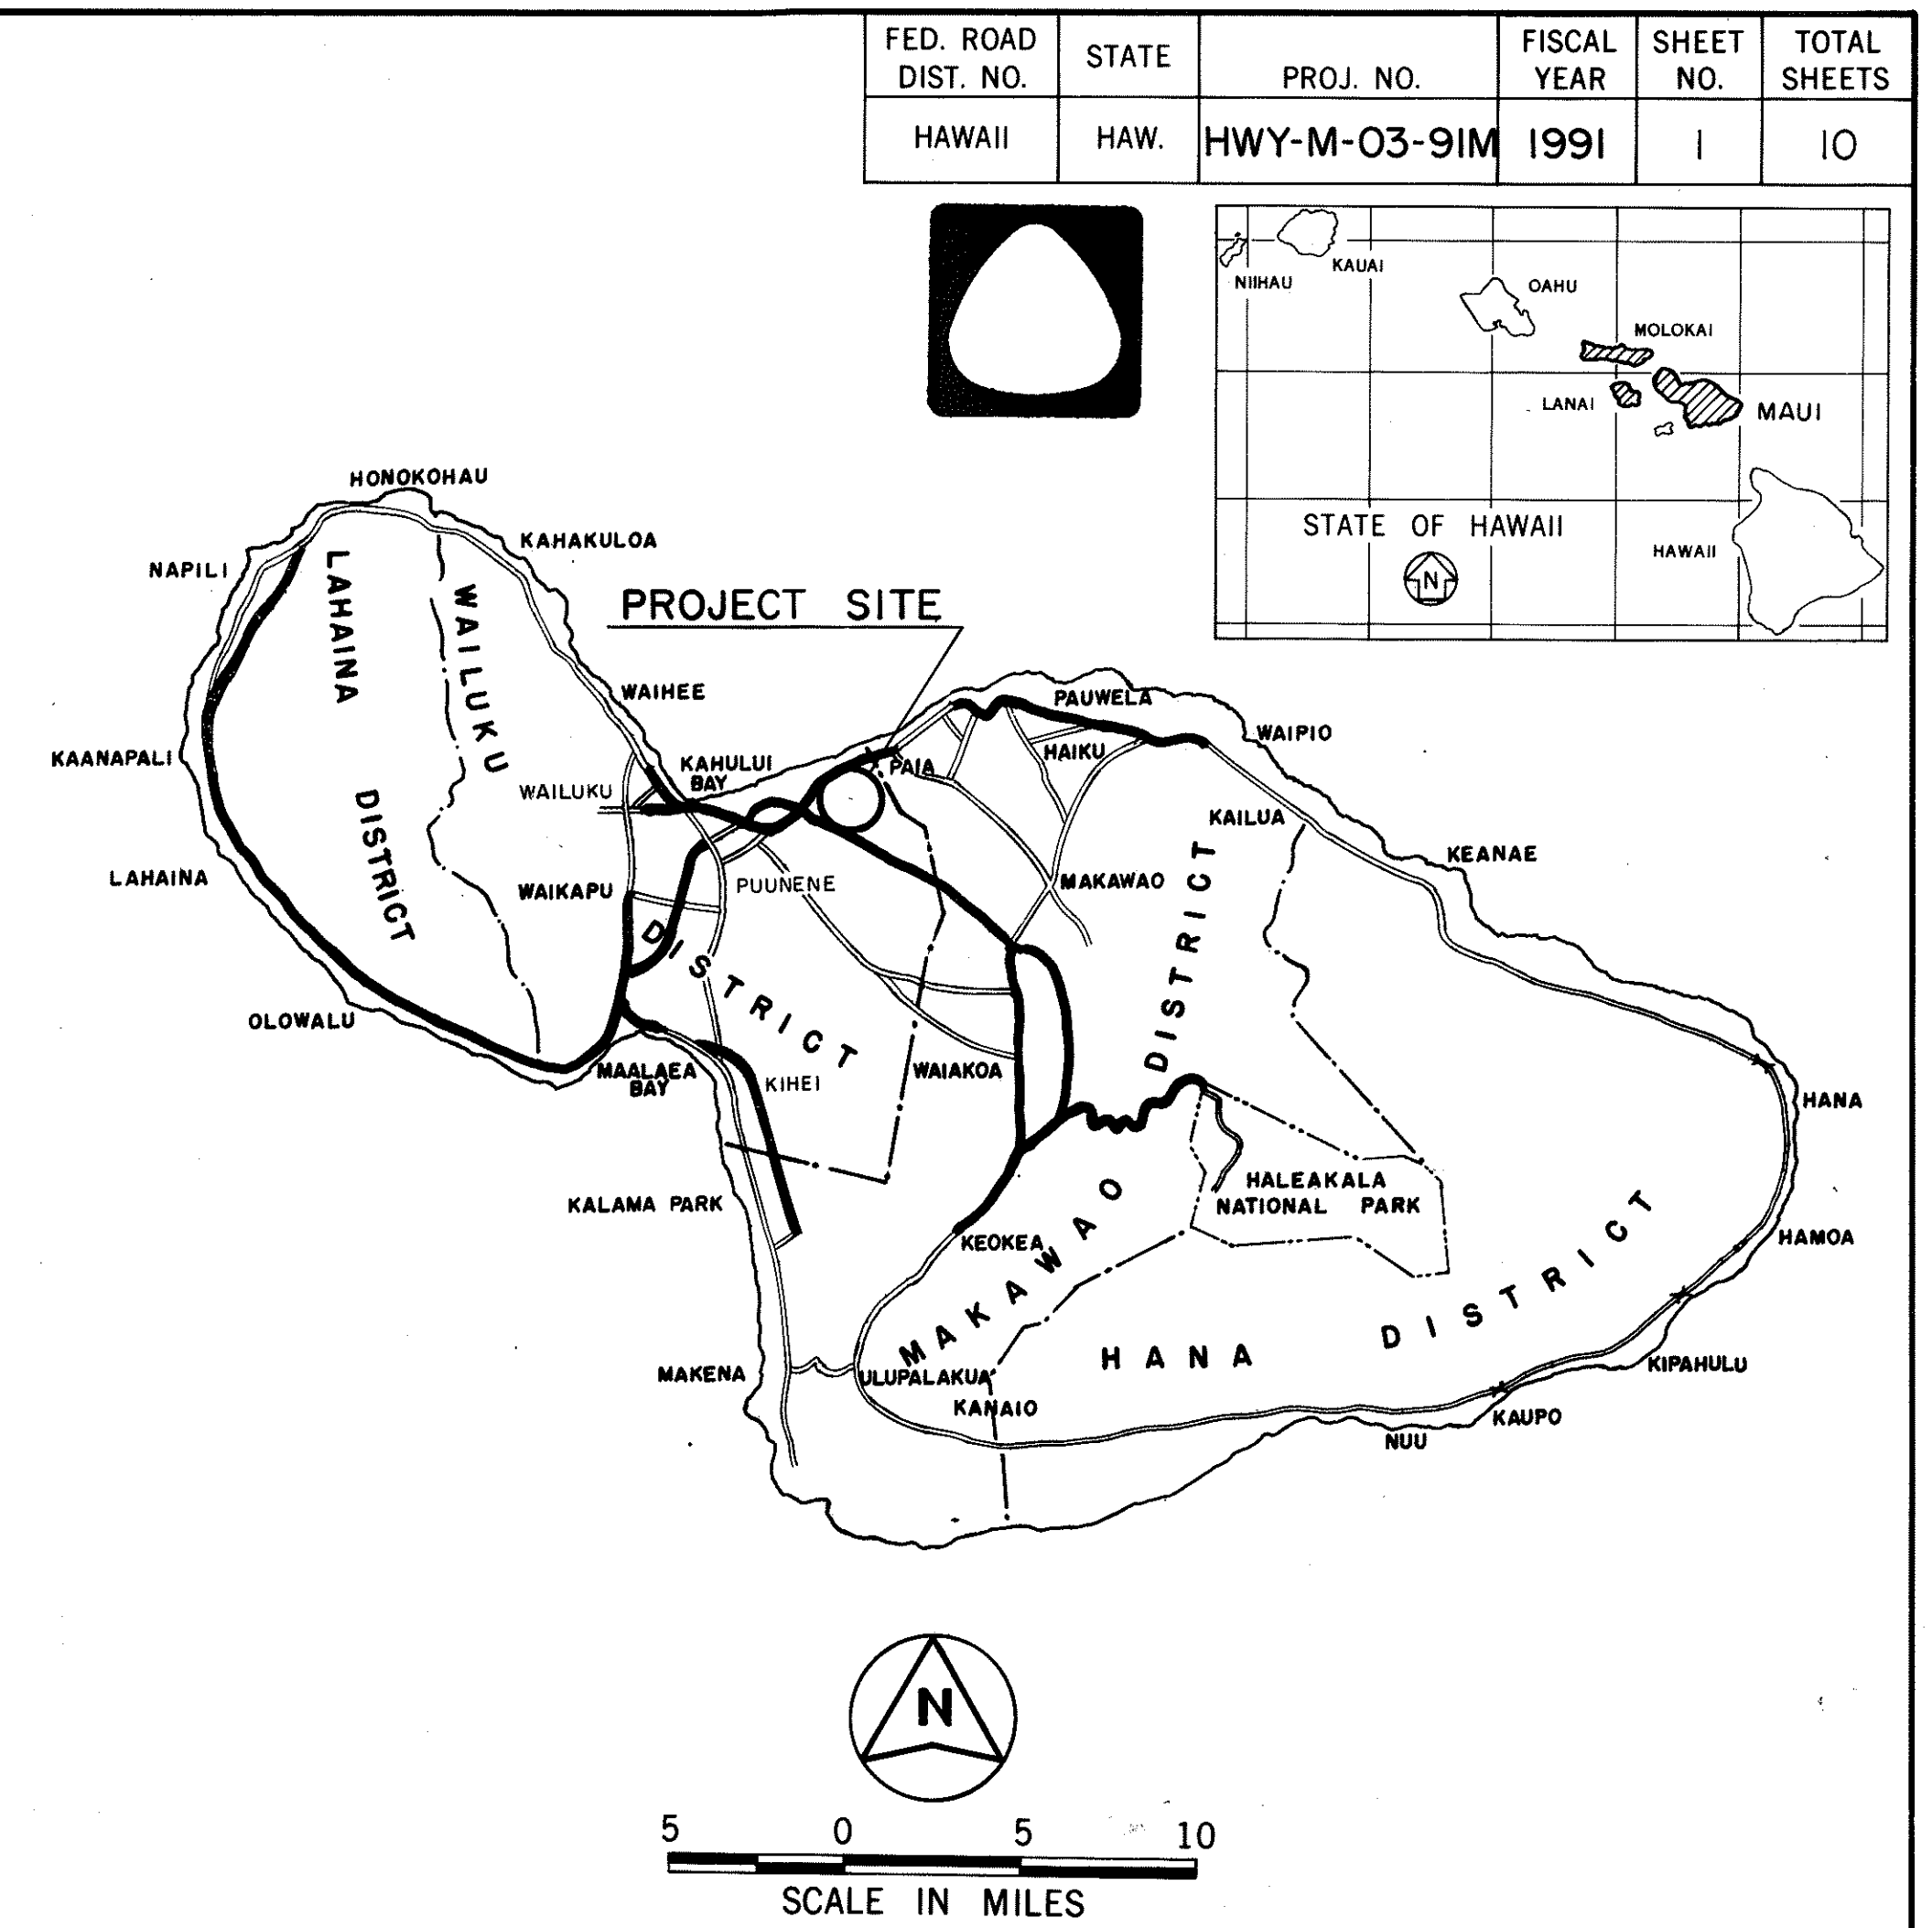


INDEX TO DRAWINGS	
SHEET NO.	DESCRIPTION
1	TITLE SHEET
2	AIR CONDITIONING AND VENTILATION PLAN
3-4	FLOOR PLAN
① 5	DETAILS AND DIAGRAMS
6	TYPICAL DETAILS, DIAGRAMS, AND EQUIPMENT SCHEDULES
	FOR INFORMATION ONLY
7	ELECTRICAL SITE PLAN, SYMBOLS AND DETAILS
8	LIGHTING FLOOR PLAN AND LUMINAIRE SCHEDULE
9	POWER AND SIGNAL PLAN
10	SINGLE LINE DIAGRAM, PANEL SCHEDULE

Plan Sht. No. ①5S-I is a supplementary sheet to this project.  
TOTAL SHEET COUNT after "AS BUILT" postings. 11 Sheets.

AIR - EM DESIGNED BY JULIUS B. FRONDA 548-4125 APR. 1991 P. S. & E. BY PHONE DATE

STATE OF HAWAII  
DEPARTMENT OF TRANSPORTATION  
HIGHWAYS DIVISION  
HONOLULU, HAWAII  
"AS BUILT"  
PLANS FOR  
MAUI DISTRICT BASEYARD  
ADMINISTRATION BUILDING AIR CONDITIONING  
PROJECT NO. HWY-M-03-91M  
DISTRICT OF WAILUKU  
ISLAND OF MAUI

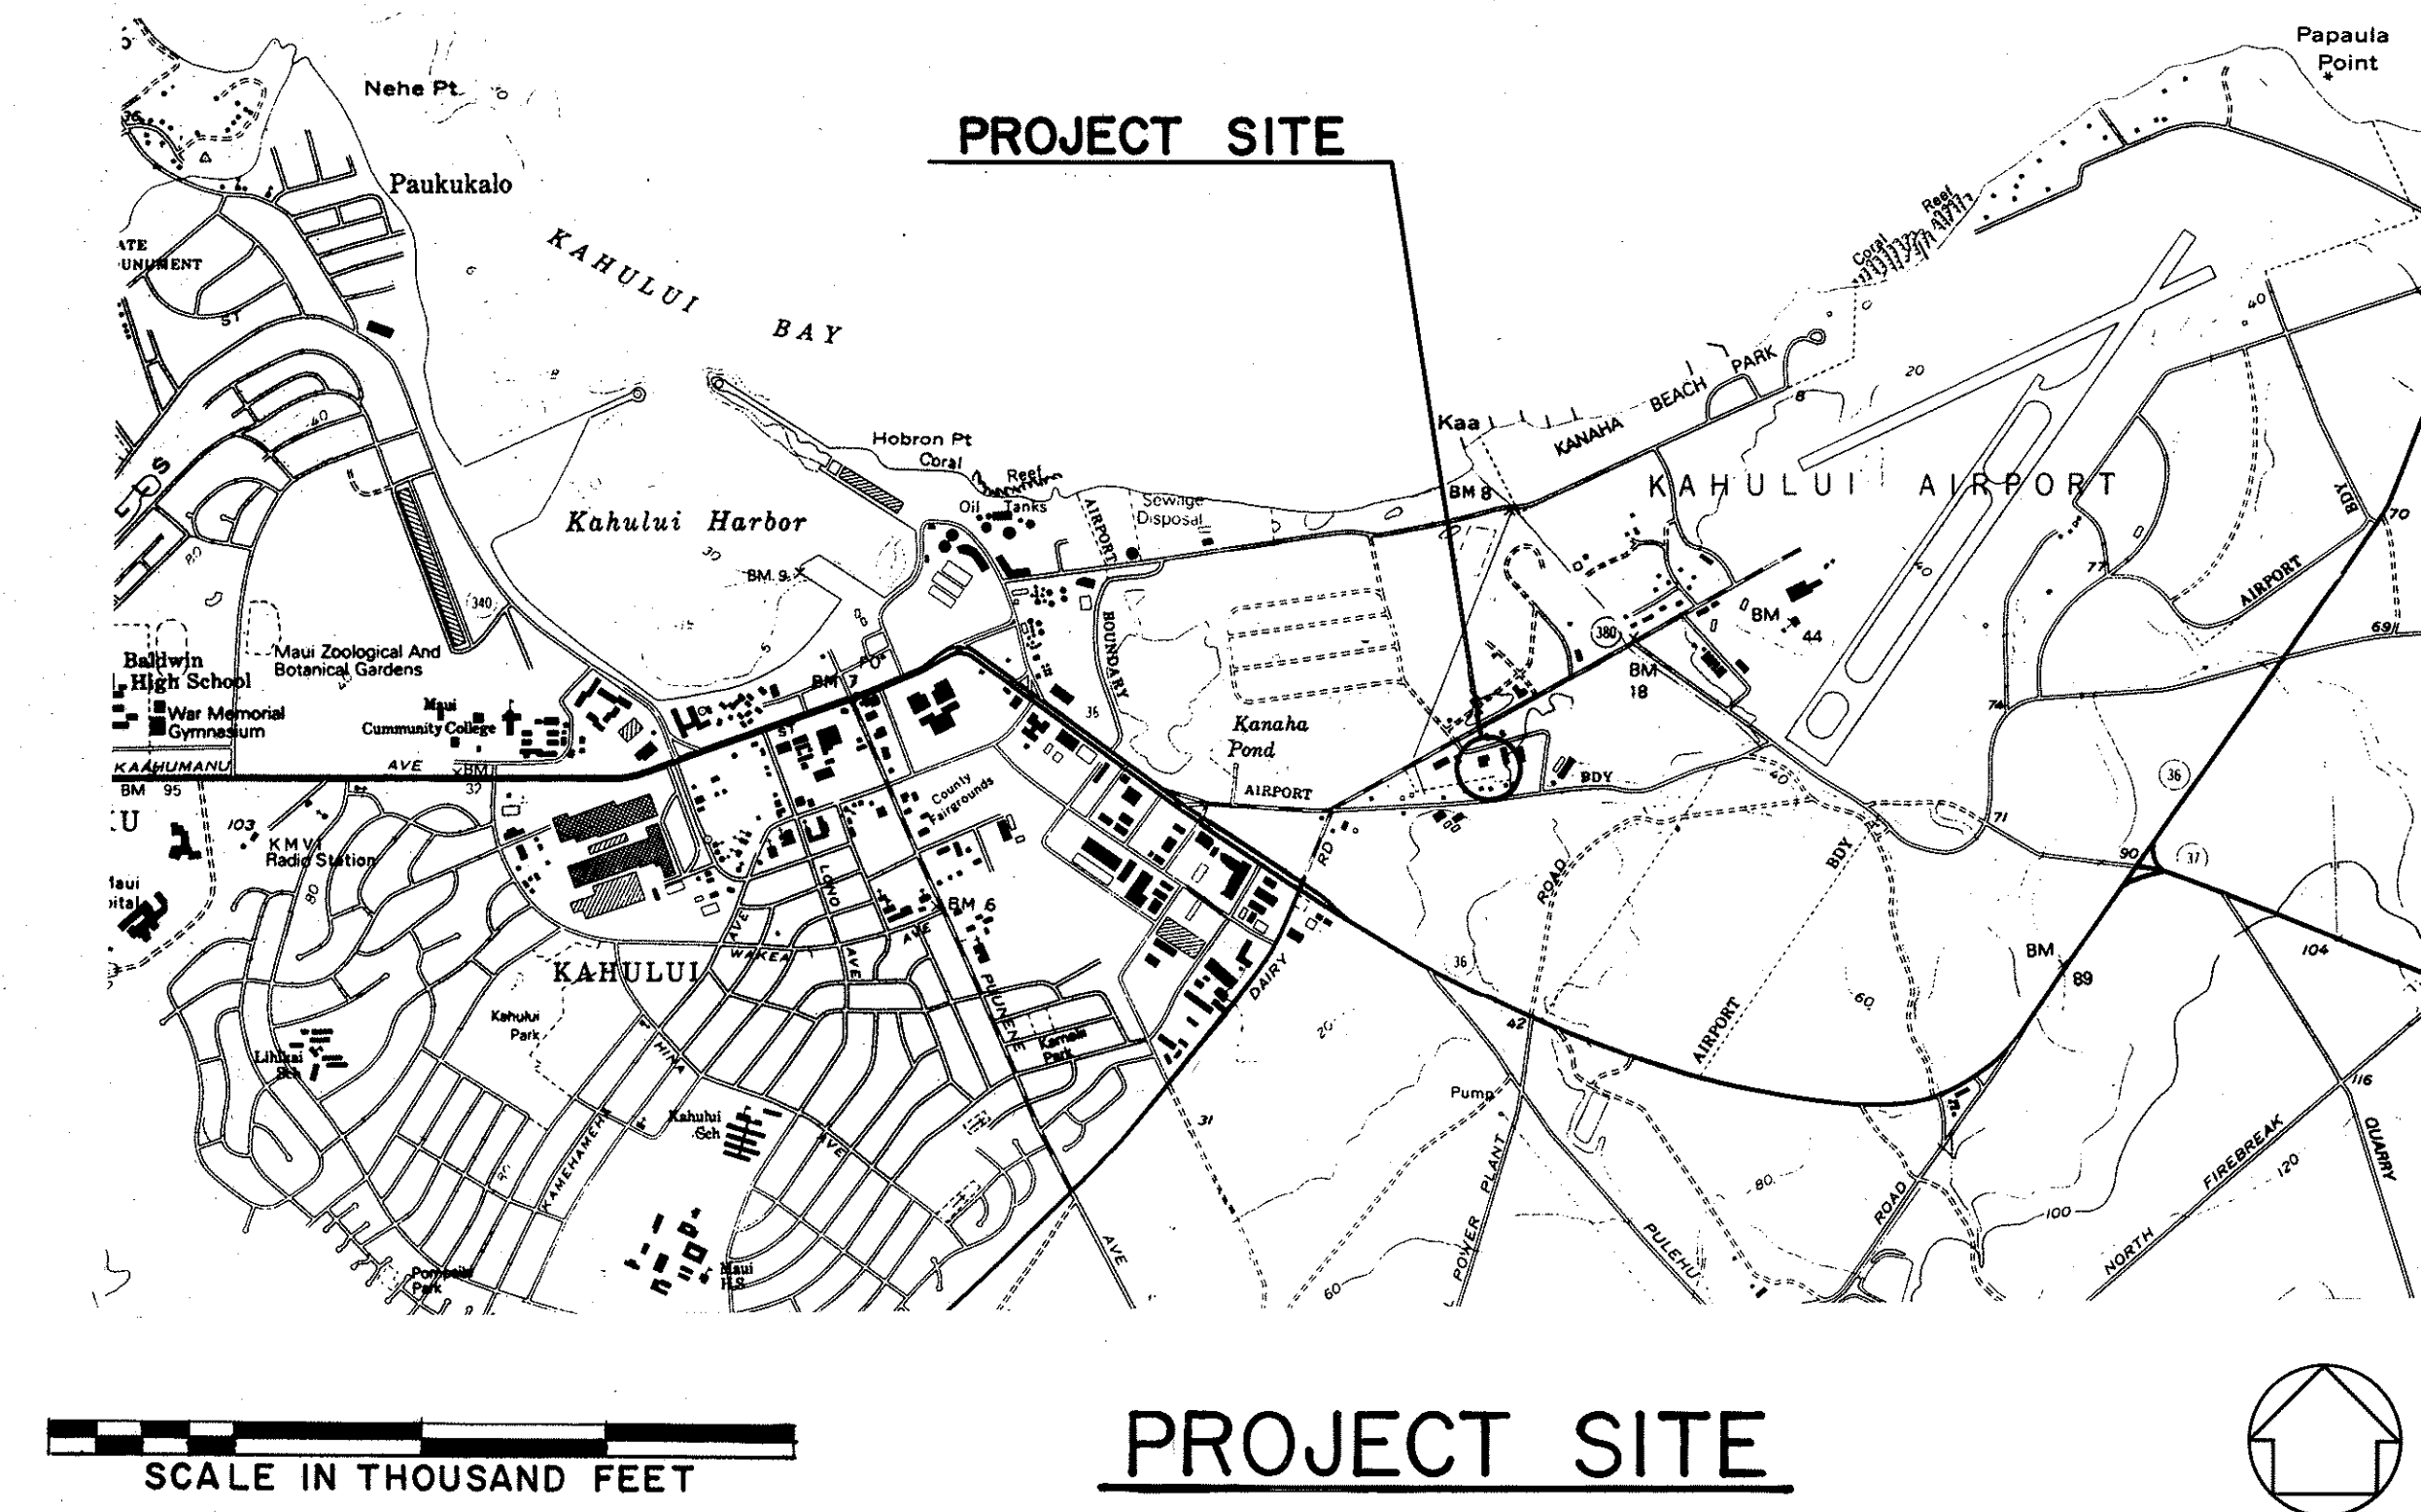

FEDERAL AID PROJECTS PREVIOUSLY CONSTRUCTED OR UNDER CONSTRUCTION  
MILE POST \_\_\_\_\_ TO MILE POST \_\_\_\_\_  
CHANGES MADE DURING CONSTRUCTION HAVE BEEN INCORPORATED ON THESE PLANS EXCEPT CHANGES IN THE ORIGINAL THEORETICAL QUANTITIES.  
RESIDENT ENGINEER DATE 2/7/96  
APPROVED: 5/1/91 DATE  
DIR. OF TRANSPORTATION