


FED. ROAD DIST. NO.	STATE	FED-AID PROJ. NO.	FISCAL YEAR	SHEET NO.	TOTAL SHEETS
HAWAII	HAW.	HWY-M-05-98	2002	78	99


PLUMBING FIXTURE SCHEDULE

- A-WC ACCESSIBLE WATER CLOSET, TANK TYPE, FLOOR MOUNTED
- A-UR ACCESSIBLE URINAL, FLUSH VALVE, WALL MOUNTED
- A-LAV ACCESSIBLE LAVATORY, WALL HUNG, HOT & COLD WATER
- A-SH ACCESSIBLE SHOWER SUPPLY FITTINGS & TRIM
- A-SK ACCESSIBLE SINK, SINGLE COMPARTMENT
- SS SERVICE SINK, COLD WATER ONLY
- A-EWC ACCESSIBLE ELECTRIC WATER COOLER
- EWC ELECTRIC WATER COOLER, DUAL HEIGHT
- HB-1 HOSE BIBB, EXTERIOR W/ VACUUM BREAKER
- HB-2 HOSE BIBB, INTERIOR W/ VACUUM BREAKER

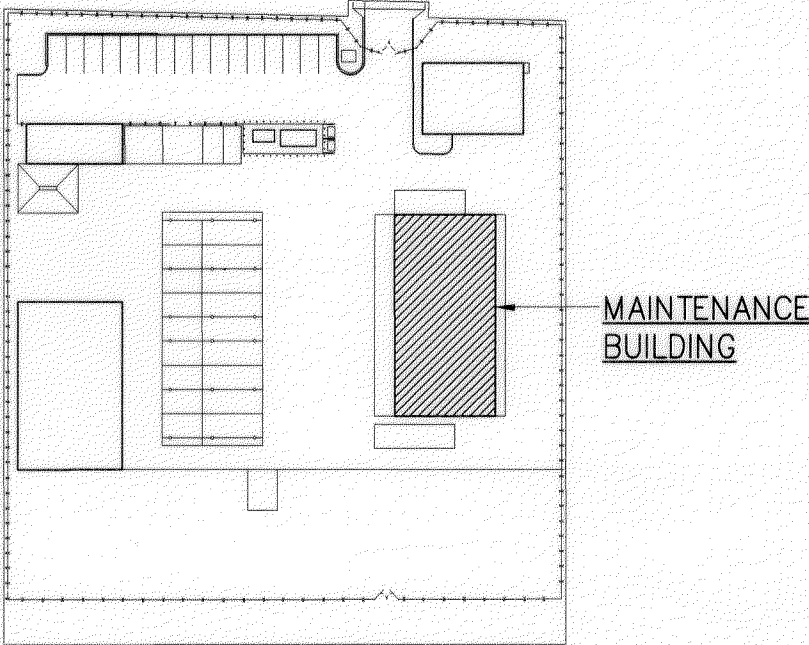


KEY PLAN
SCALE: NONE

GRAPHIC SCALES

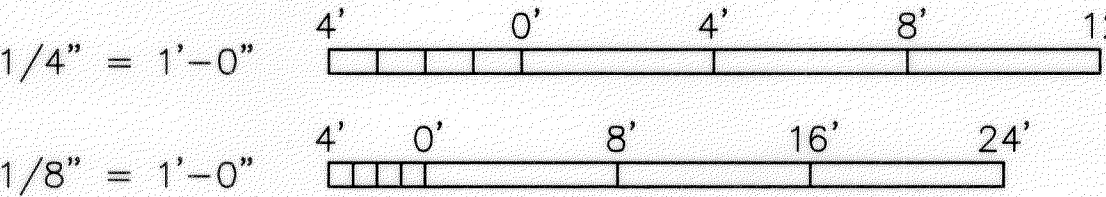


STATE OF HAWAII
DEPARTMENT OF TRANSPORTATION
HIGHWAYS DIVISION
MAINTENANCE BUILDING
PLBG, A/C & VENT FLR PLANS
MOLOKAI BASEYARD
MOLOKAI INDUSTRIAL PARK
Project No. HWY-M-05-98


Scale: As Noted Date: SEPT 13, 2001
SHEET No. M2.1 OF M2.3 SHEETS

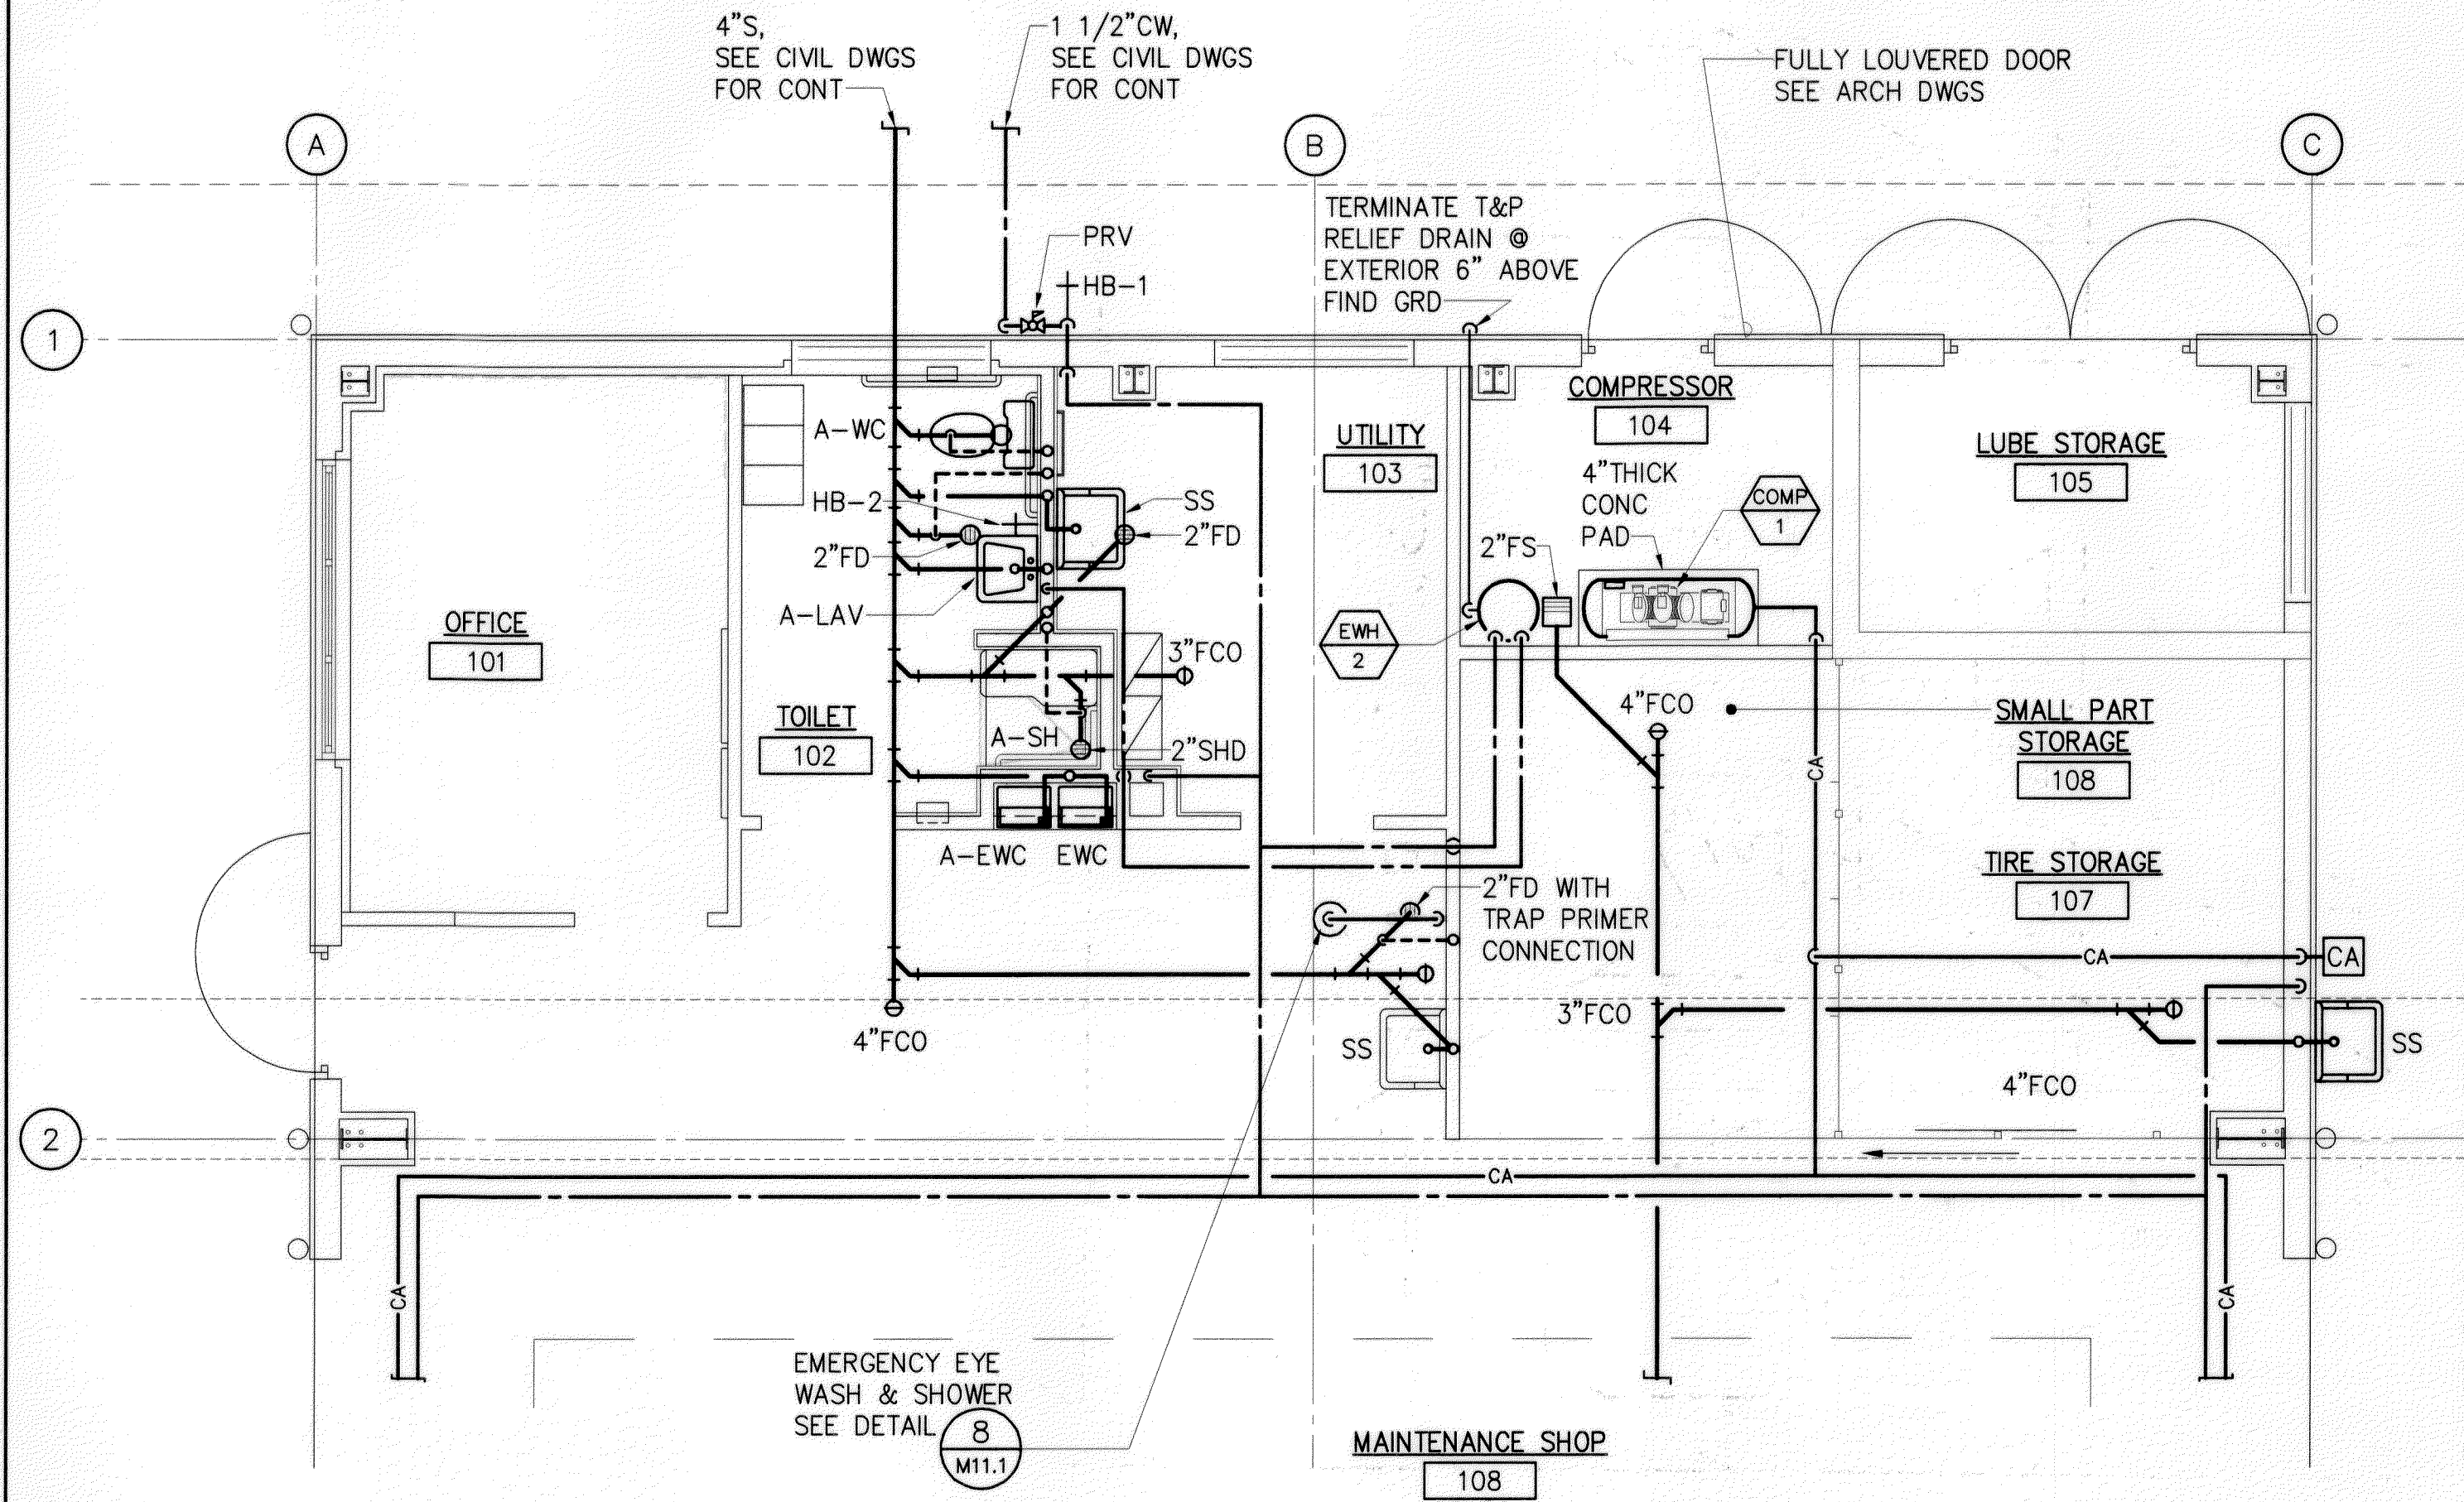

A DETAILED PLUMBING FLOOR PLAN
SCALE: 1/4" = 1'-0"

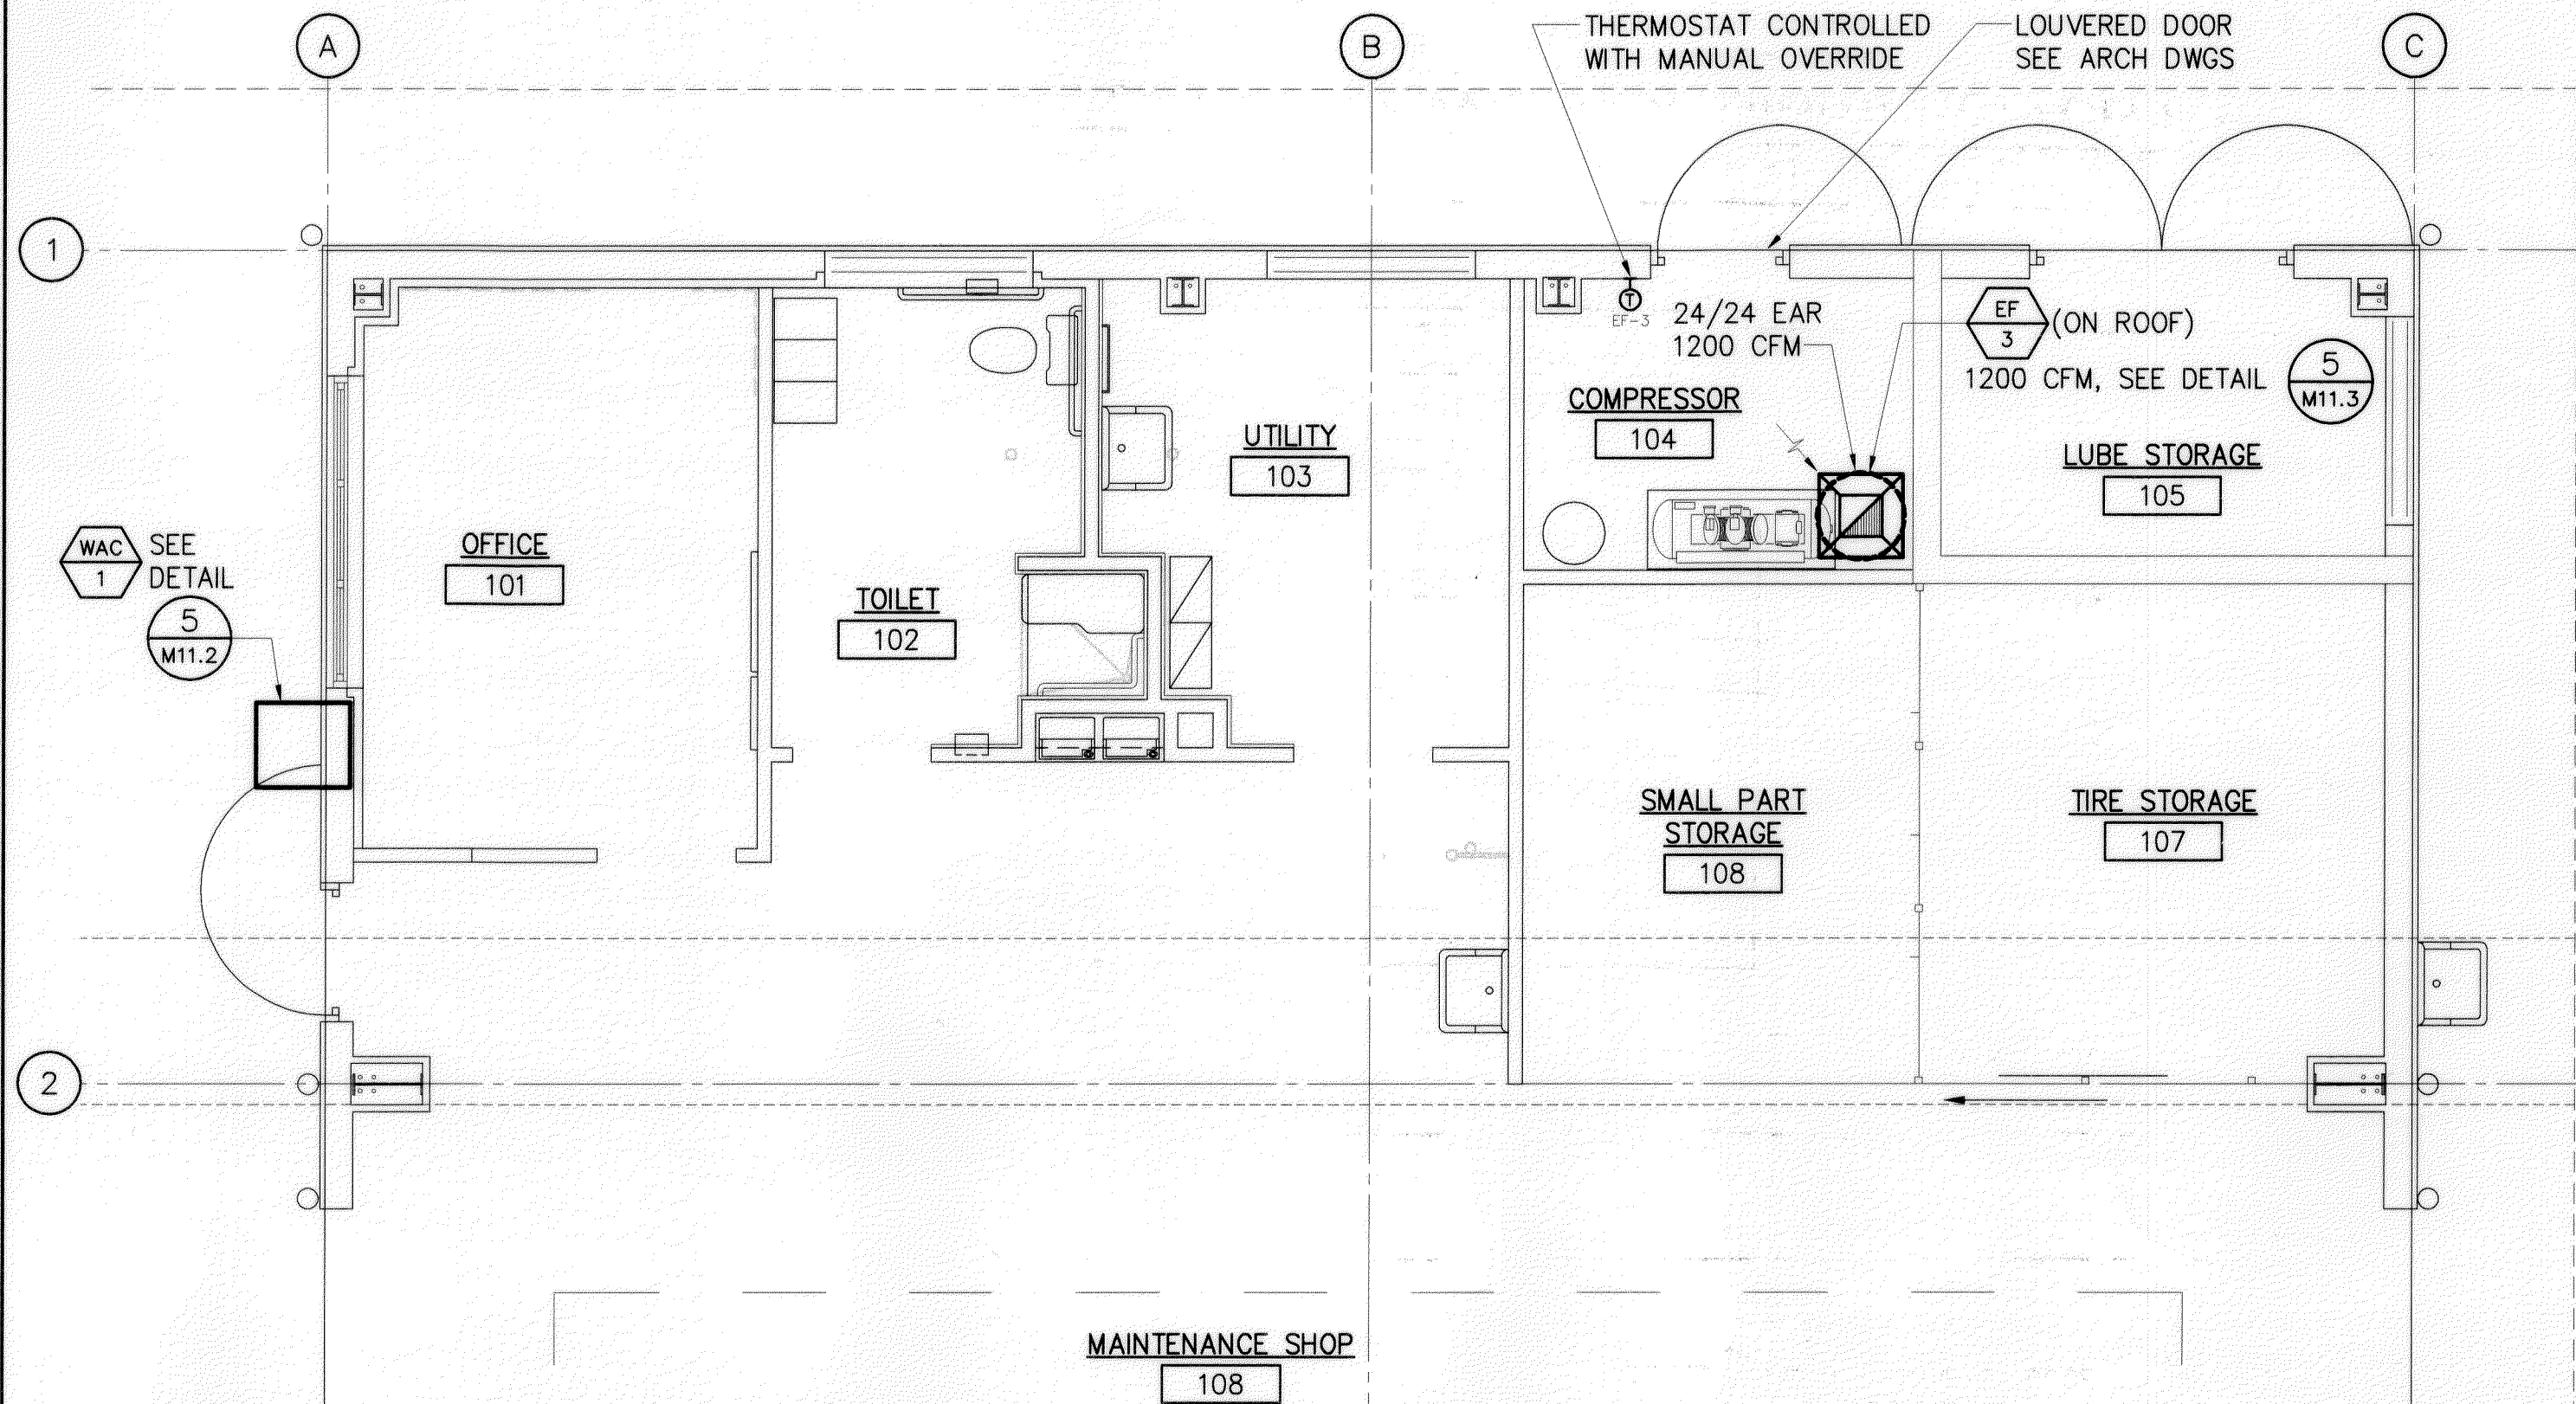

B DETAILED AIR CONDITIONING & VENTILATION FLOOR PLAN
SCALE: 1/4" = 1'-0"

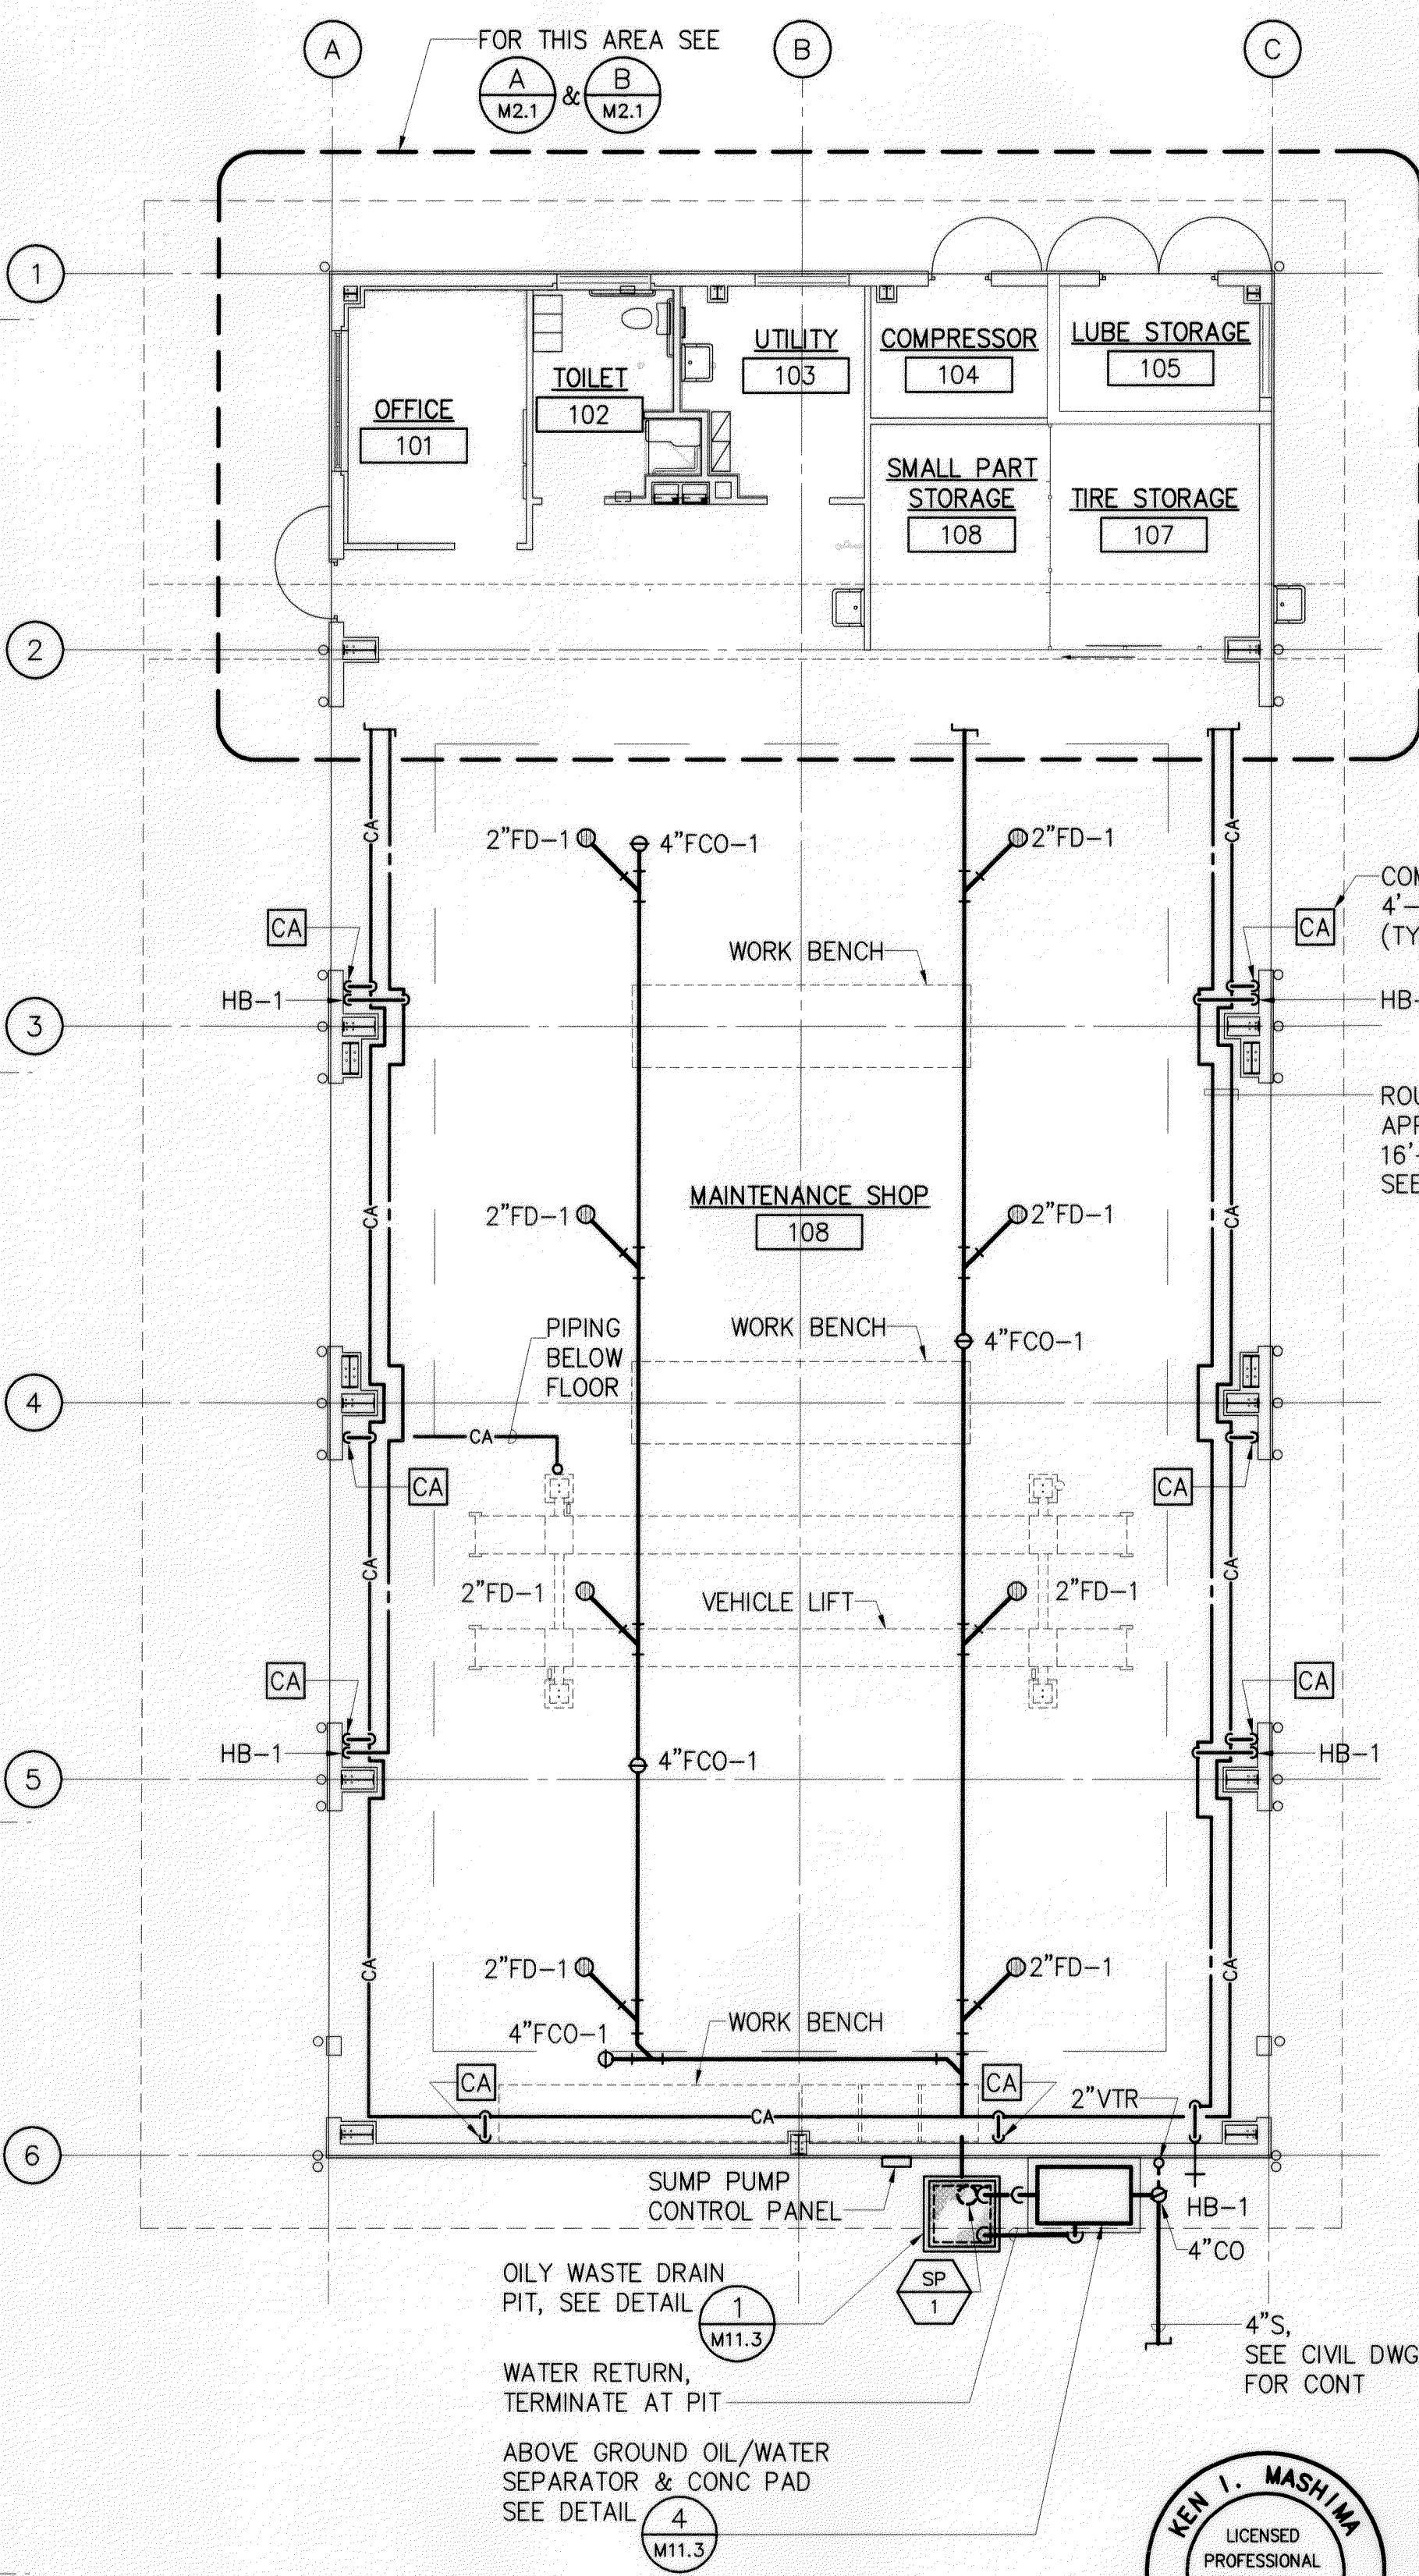



MAINTENANCE BUILDING
PLUMBING FLOOR PLAN
SCALE: 1/8" = 1'-0"




THIS WORK WAS PREPARED BY
ME OR UNDER MY SUPERVISION

MAINTENANCE BUILDING

FED. ROAD DIST. NO.	STATE	FED. AID PROJ. NO.	FISCAL YEAR	SHEET NO.	TOTAL SHEETS
HAWAII	HAW.	HWY-M-05-98	2002	79	99

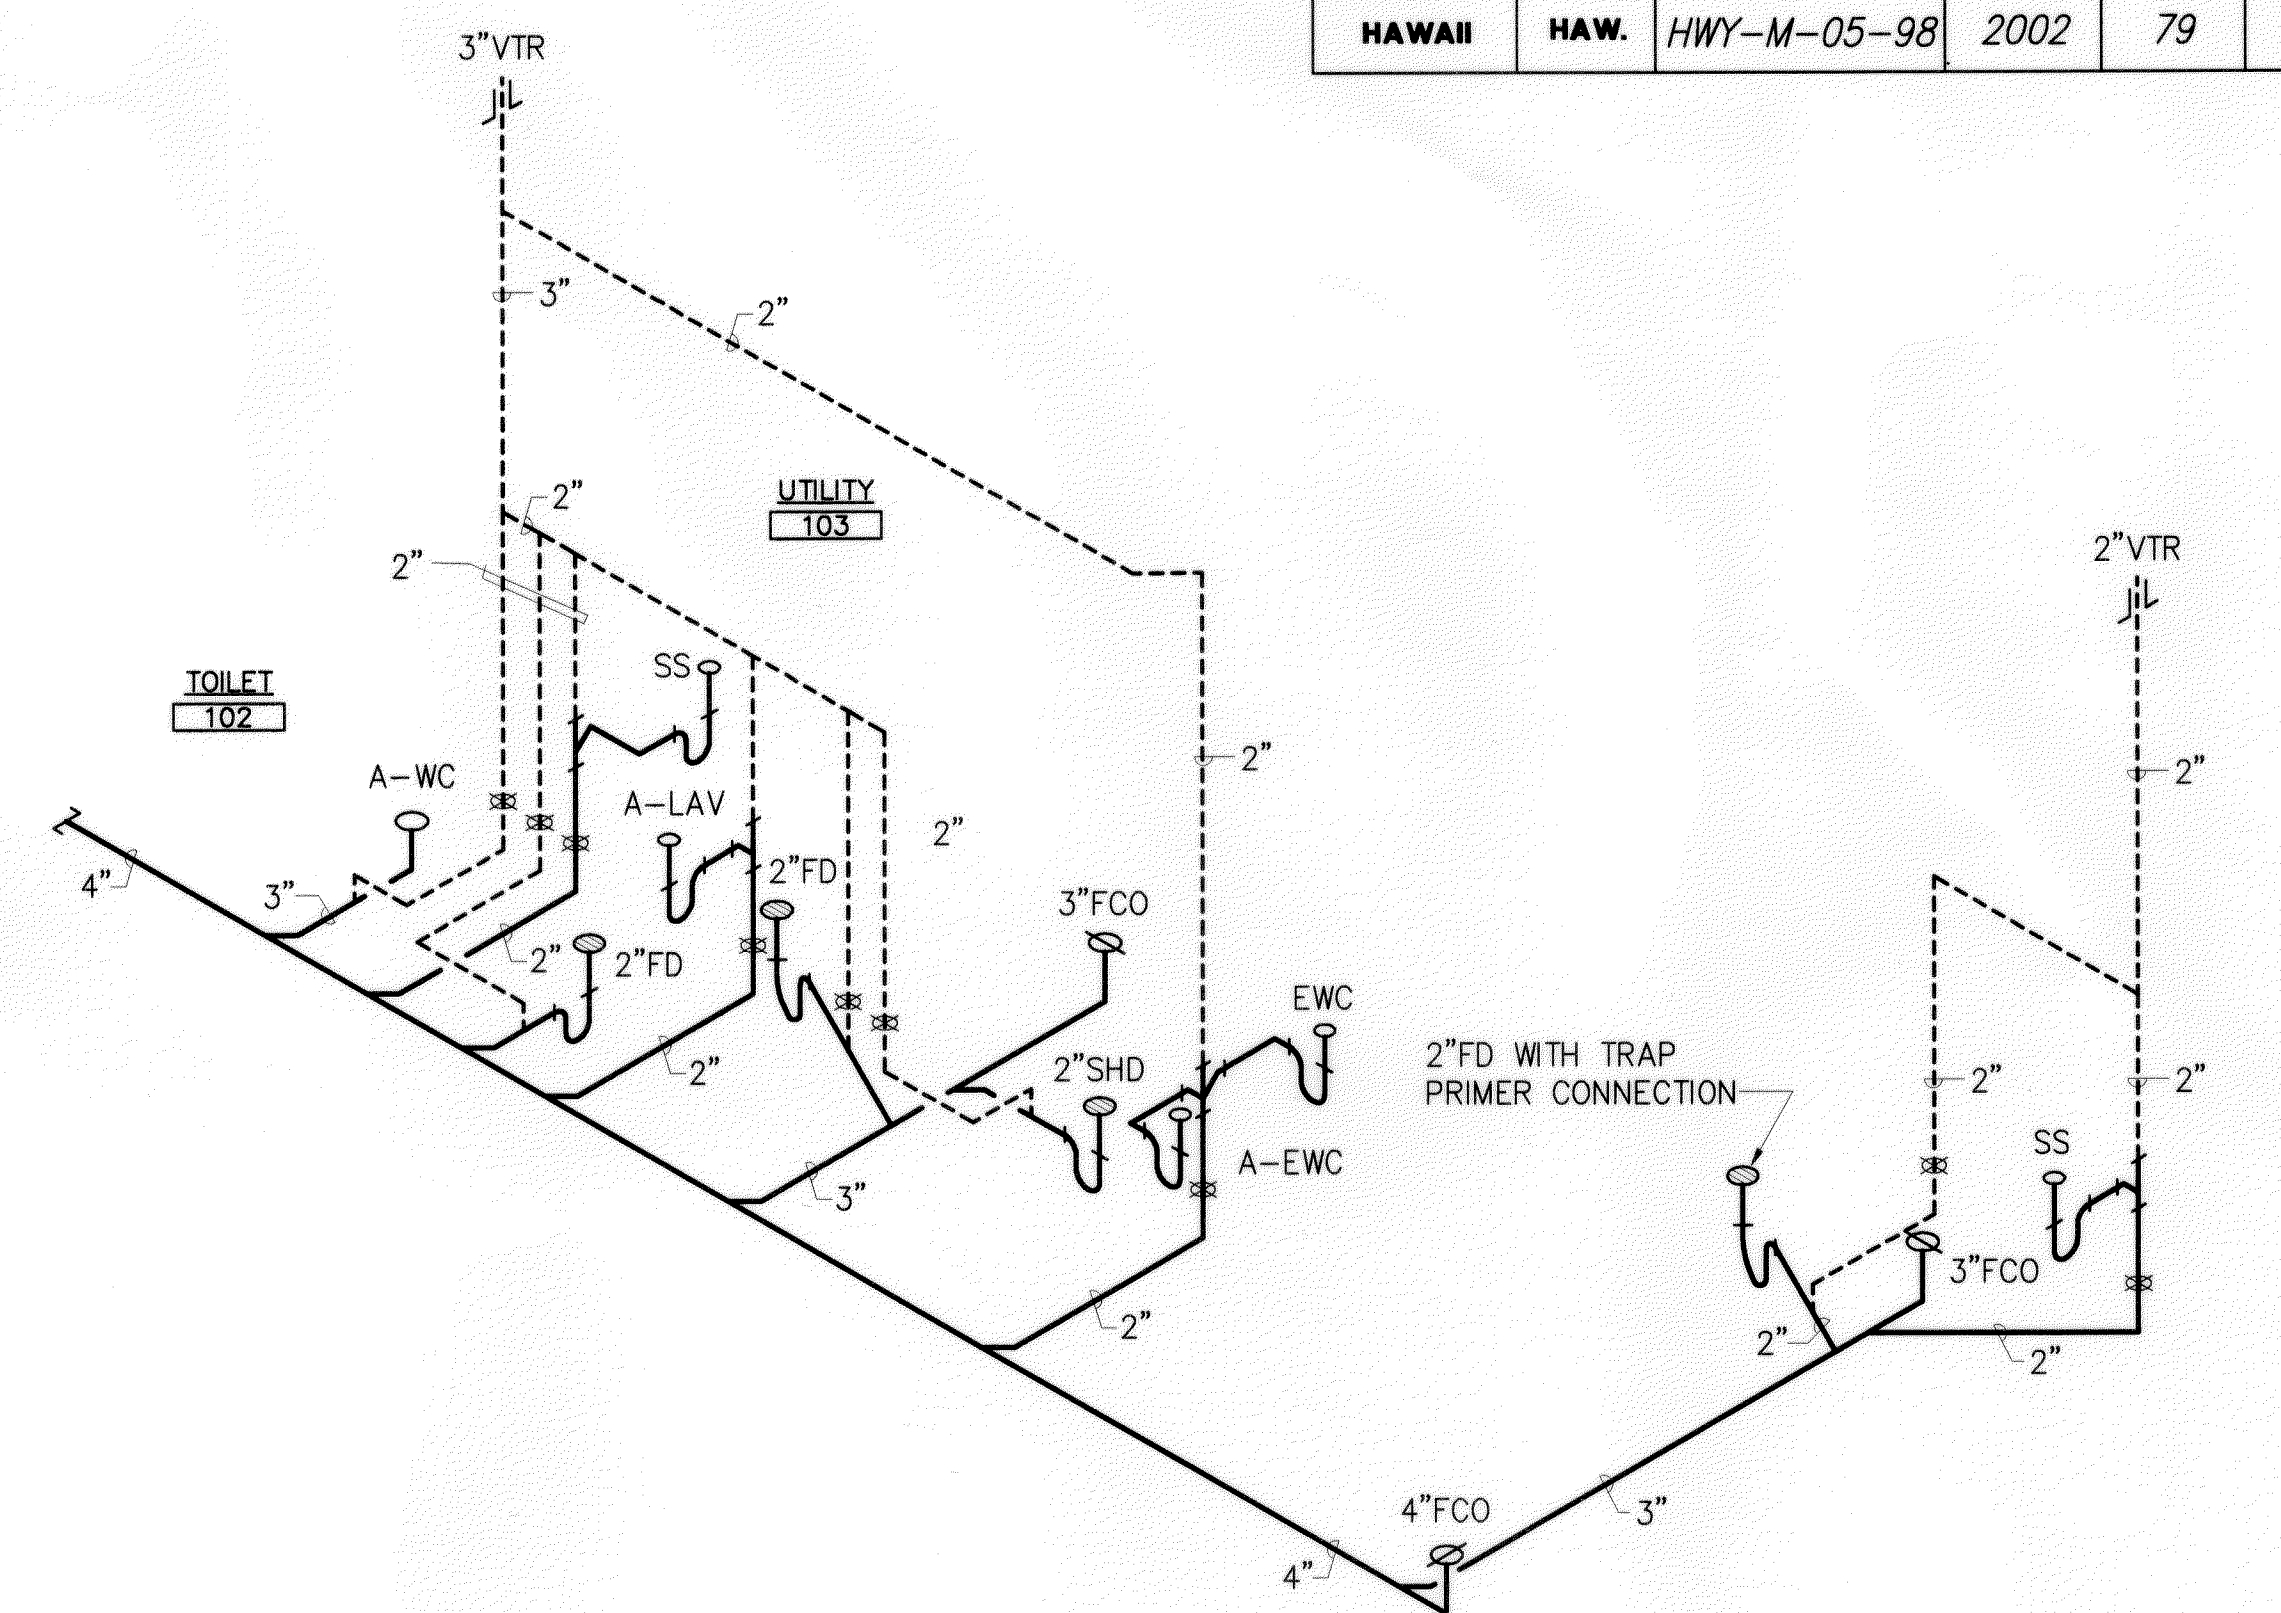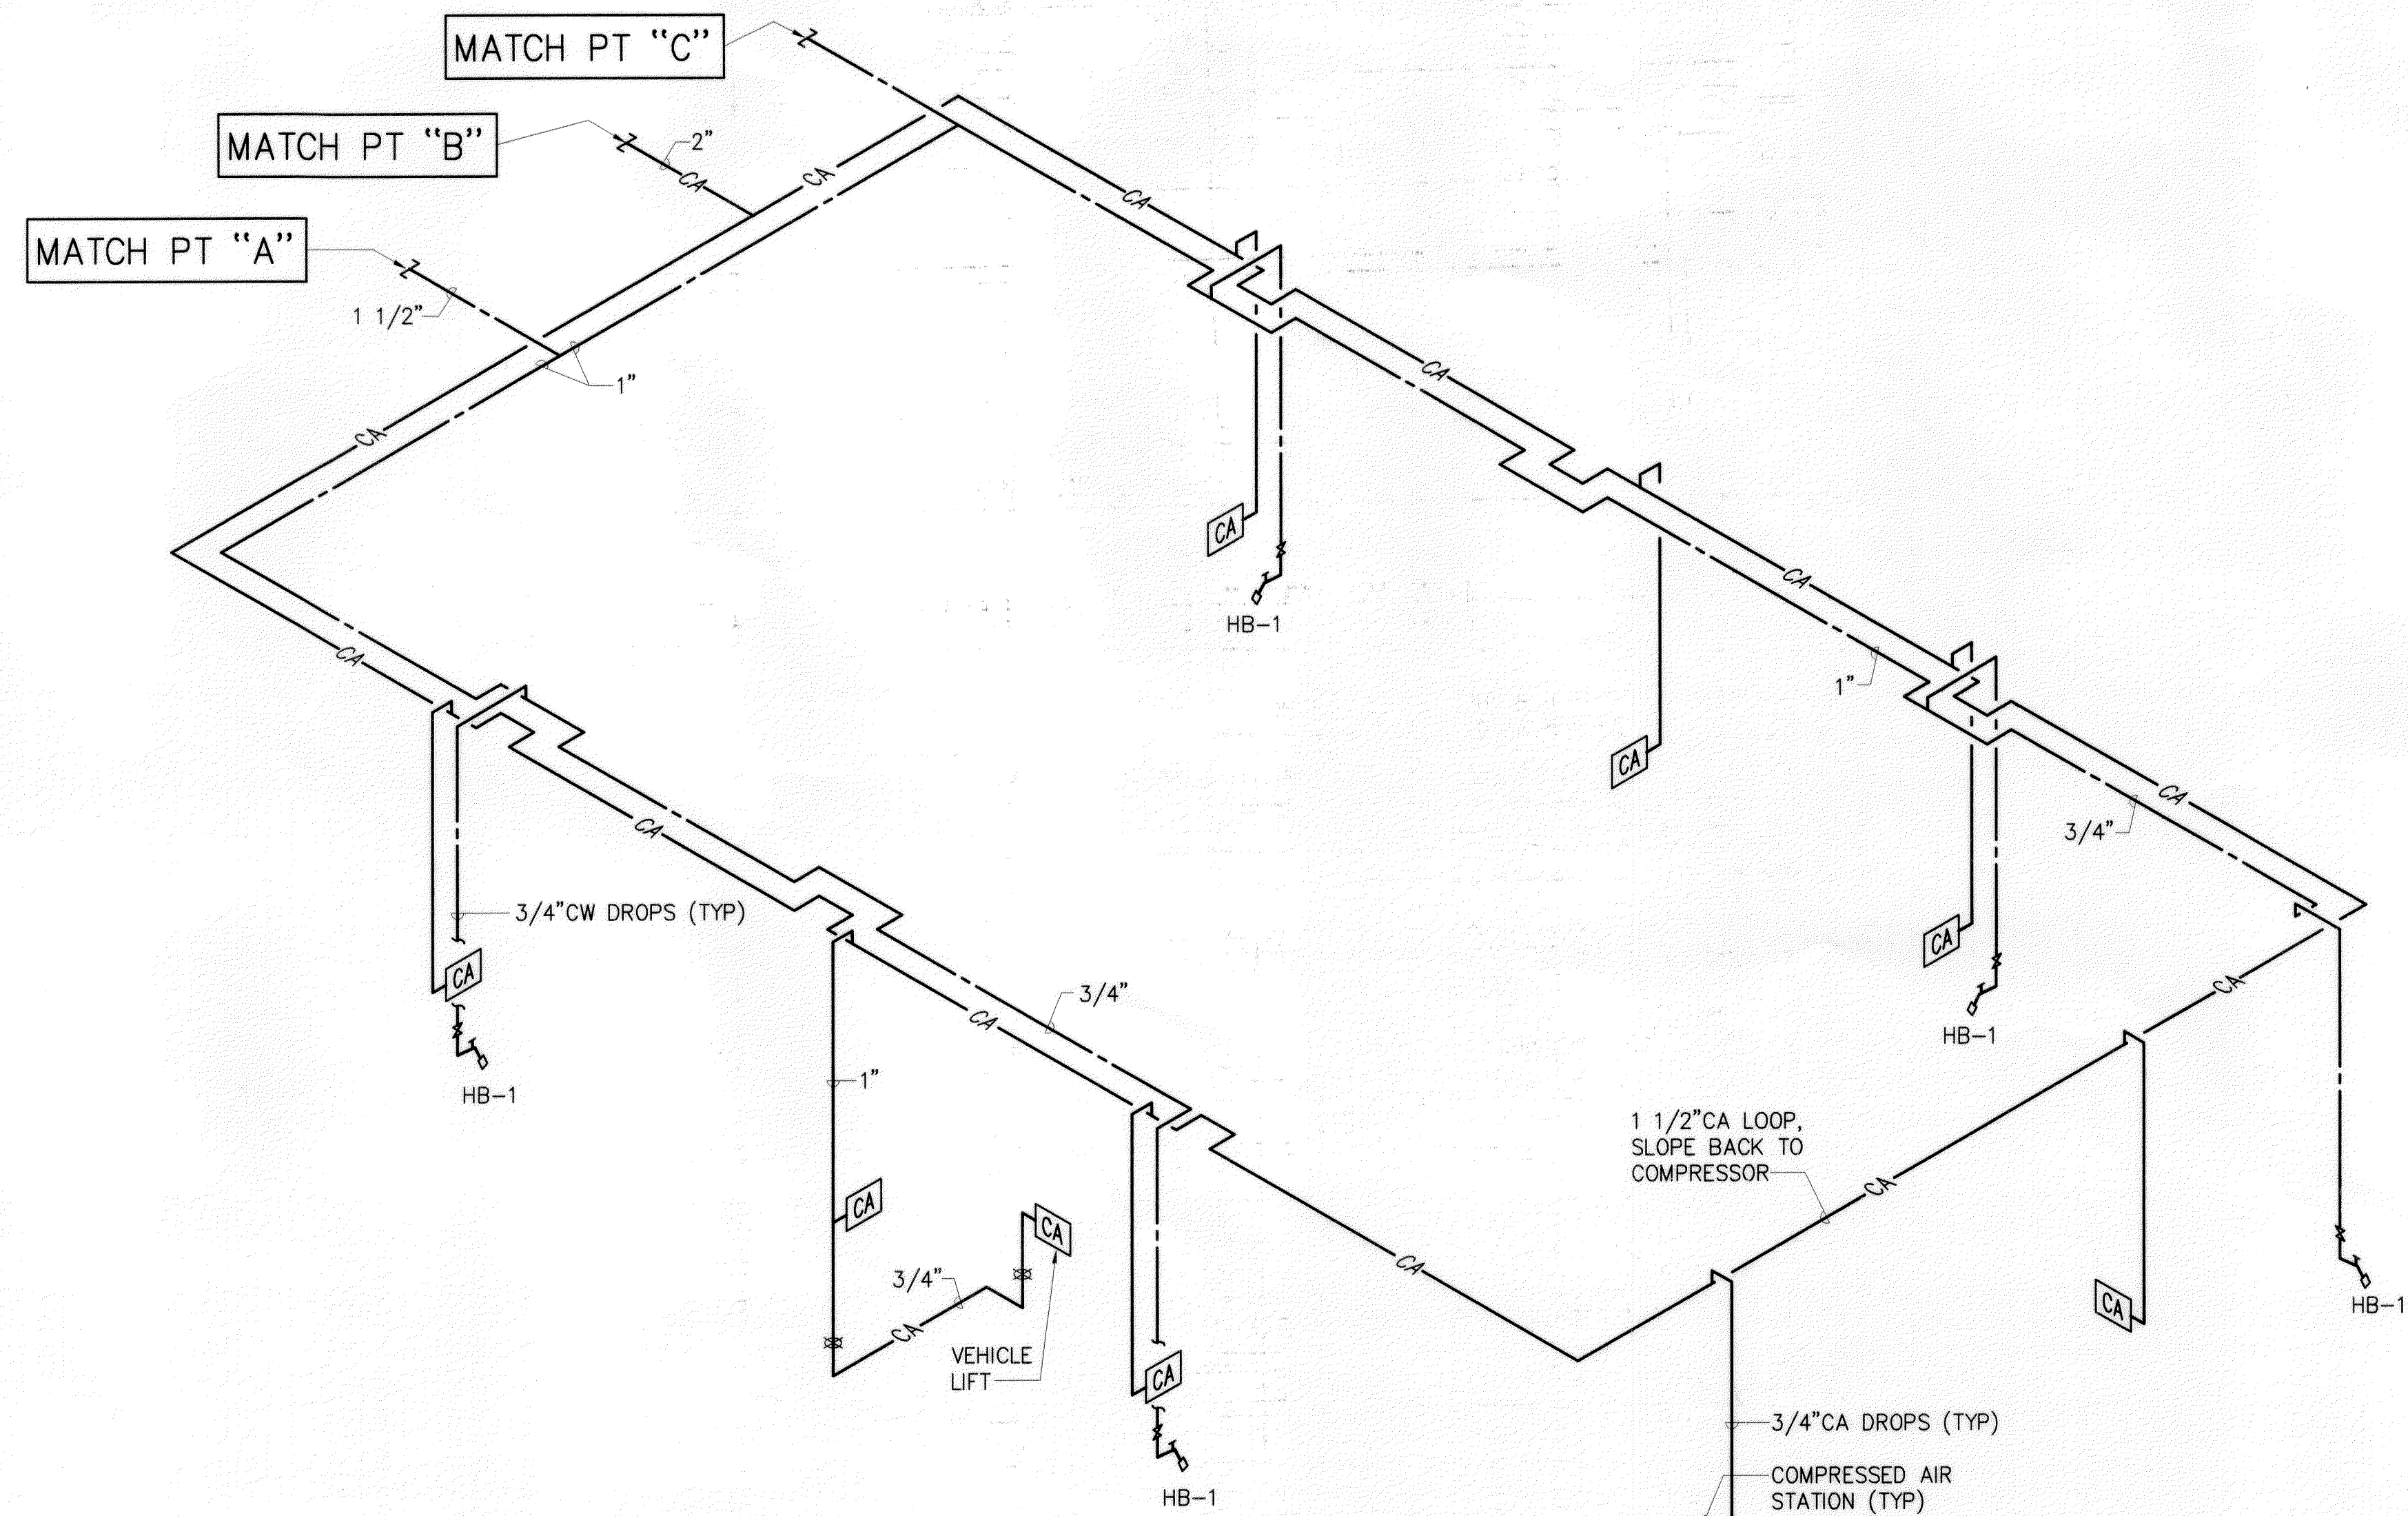


MAINTENANCE BUILDING – SANITARY PIPING DIAGRAM
SCALE: NONE

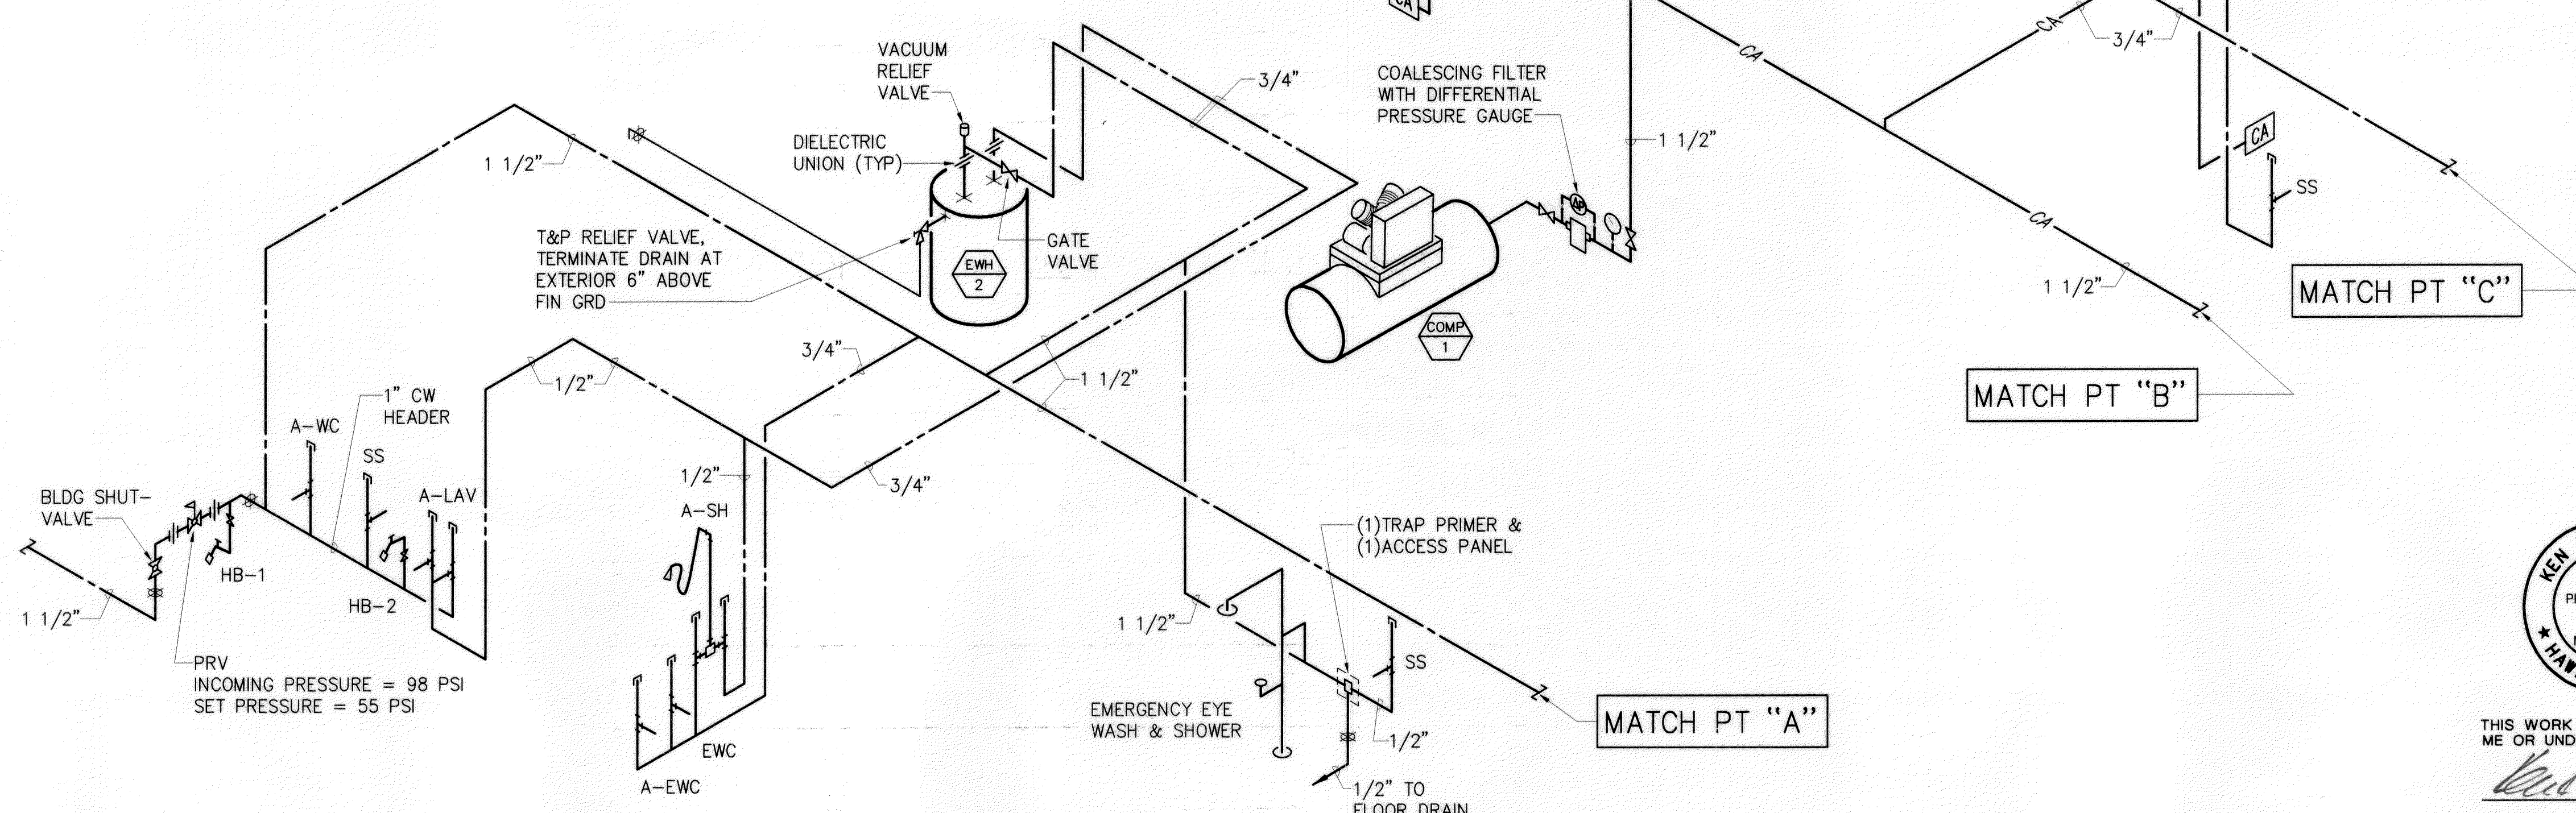

MAINTENANCE BUILDING – WATER & COMPRESSED AIR PIPING DIAGRAM
SCALE: NONE

PLUMBING FIXTURE PIPE SIZING SCHEDULE				
FIXTURE TYPE	WASTE	VENT	CW	HW
WATER CLOSET	3"	2"	1 1/2"	-
URINAL	2"	2"	3/4"	-
LAVATORY	2"	2"	1 1/2"	1 1/2"
SINK	2"	2"	1 1/2"	1 1/2"
SHOWER	2"	2"	1 1/2"	1 1/2"
WASHER	2"	2"	1 1/2"	1 1/2"
SERVICE SINK	2"	2"	1 1/2"	-
ELECTRIC WATER COOLER	2"	2"	1 1/2"	-

DESIGNED BY	DATE
DRAWN BY	
CHECKED BY	
NOTED BY	
ORIGINAL PLAN	
NO.	

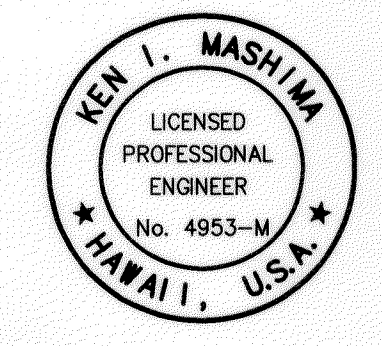

THIS WORK WAS PREPARED BY ME OR UNDER MY SUPERVISION

STATE OF HAWAII
DEPARTMENT OF TRANSPORTATION
HIGHWAYS DIVISION

MAINTENANCE BUILDING
PLBG, A/C & VENT. FLR PLANS

MOLOKAI BASEYARD
MOLOKAI INDUSTRIAL PARK
Project No. HWY-M-05-98

Scale: As Noted Date: SEPT 13, 2001

SHEET No. M2.2 OF M2.3 SHEETS

MAINTENANCE BUILDING