


FED. ROAD DIST. NO.	STATE	FED. AID PROJ. NO.	FISCAL YEAR	SHEET NO.	TOTAL SHEETS
HAWAII	HAW.	HWY-M-05-98	2002	77	99


PLUMBING FIXTURE PIPE SIZING SCHEDULE				
FIXTURE TYPE	WASTE	VENT	CW	HW
WATER CLOSET	3"	2"	1/2"	-
URINAL	2"	2"	3/4"	-
LAVATORY	2"	2"	1/2"	1/2"
SINK	2"	2"	1/2"	1/2"
SHOWER	2"	2"	1/2"	1/2"
WASHER	2"	2"	1/2"	1/2"
SERVICE SINK	2"	2"	1/2"	-
ELECTRIC WATER COOLER	2"	2"	1/2"	-

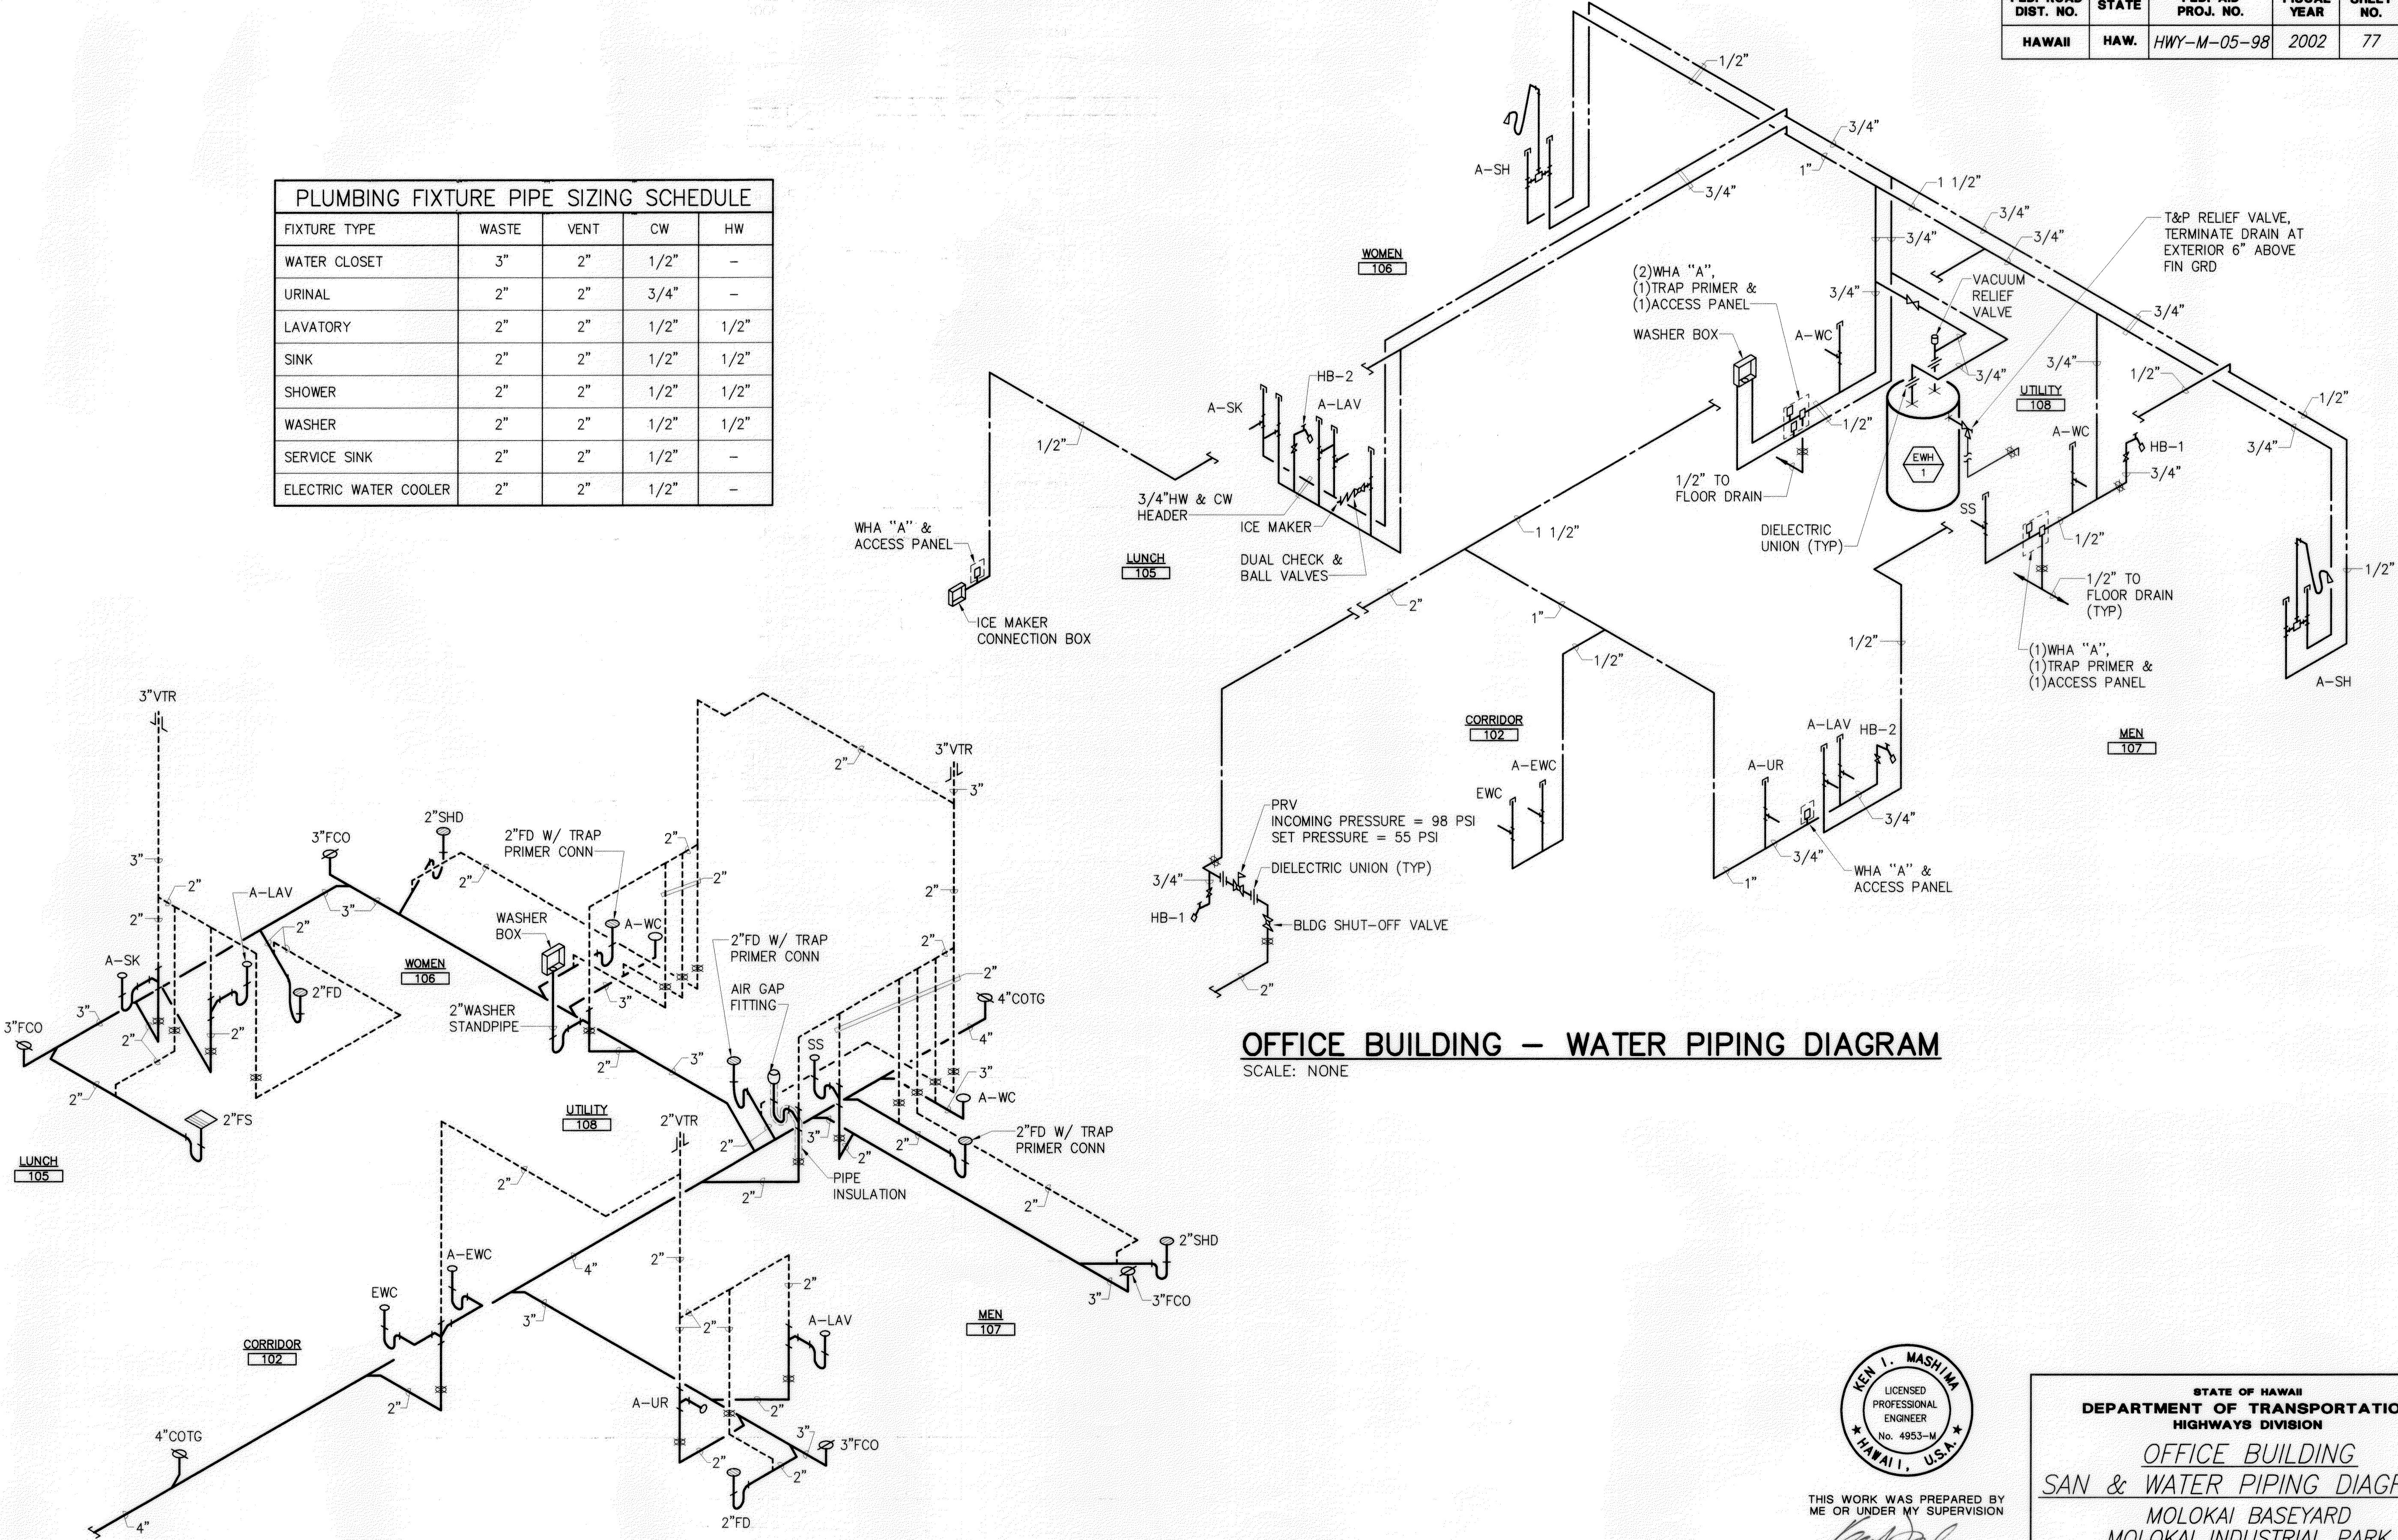

OFFICE BUILDING – WATER PIPING DIAGRAM
SCALE: NONE

OFFICE BUILDING – SANITARY PIPING DIAGRAM
SCALE: NONE

SURVEY PLOTTED BY	DATE
DRAWN BY	
TRACED BY	
DESIGNED BY	
CHECKED BY	
ORIGINAL PLAN	No.
NOTEBOOK	

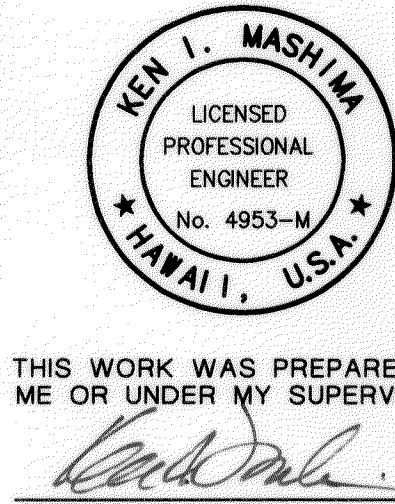

THIS WORK WAS PREPARED BY
ME OR UNDER MY SUPERVISION

STATE OF HAWAII
DEPARTMENT OF TRANSPORTATION
HIGHWAYS DIVISION
OFFICE BUILDING
SAN & WATER PIPING DIAGRAMS
MOLOKAI BASEYARD
MOLOKAI INDUSTRIAL PARK
Project No. HWY-M-05-98
Scale: As Noted
Date: SEPT 13, 2001
SHEET No. M1.4 OF M1.4 SHEETS

OFFICE BUILDING