



FED. ROAD DIST. NO.	STATE	PROJ. NO.	FISCAL YEAR	SHEET NO.	TOTAL SHEETS
HAWAII	HAW.	HWY-M-05-98	2002	91	99

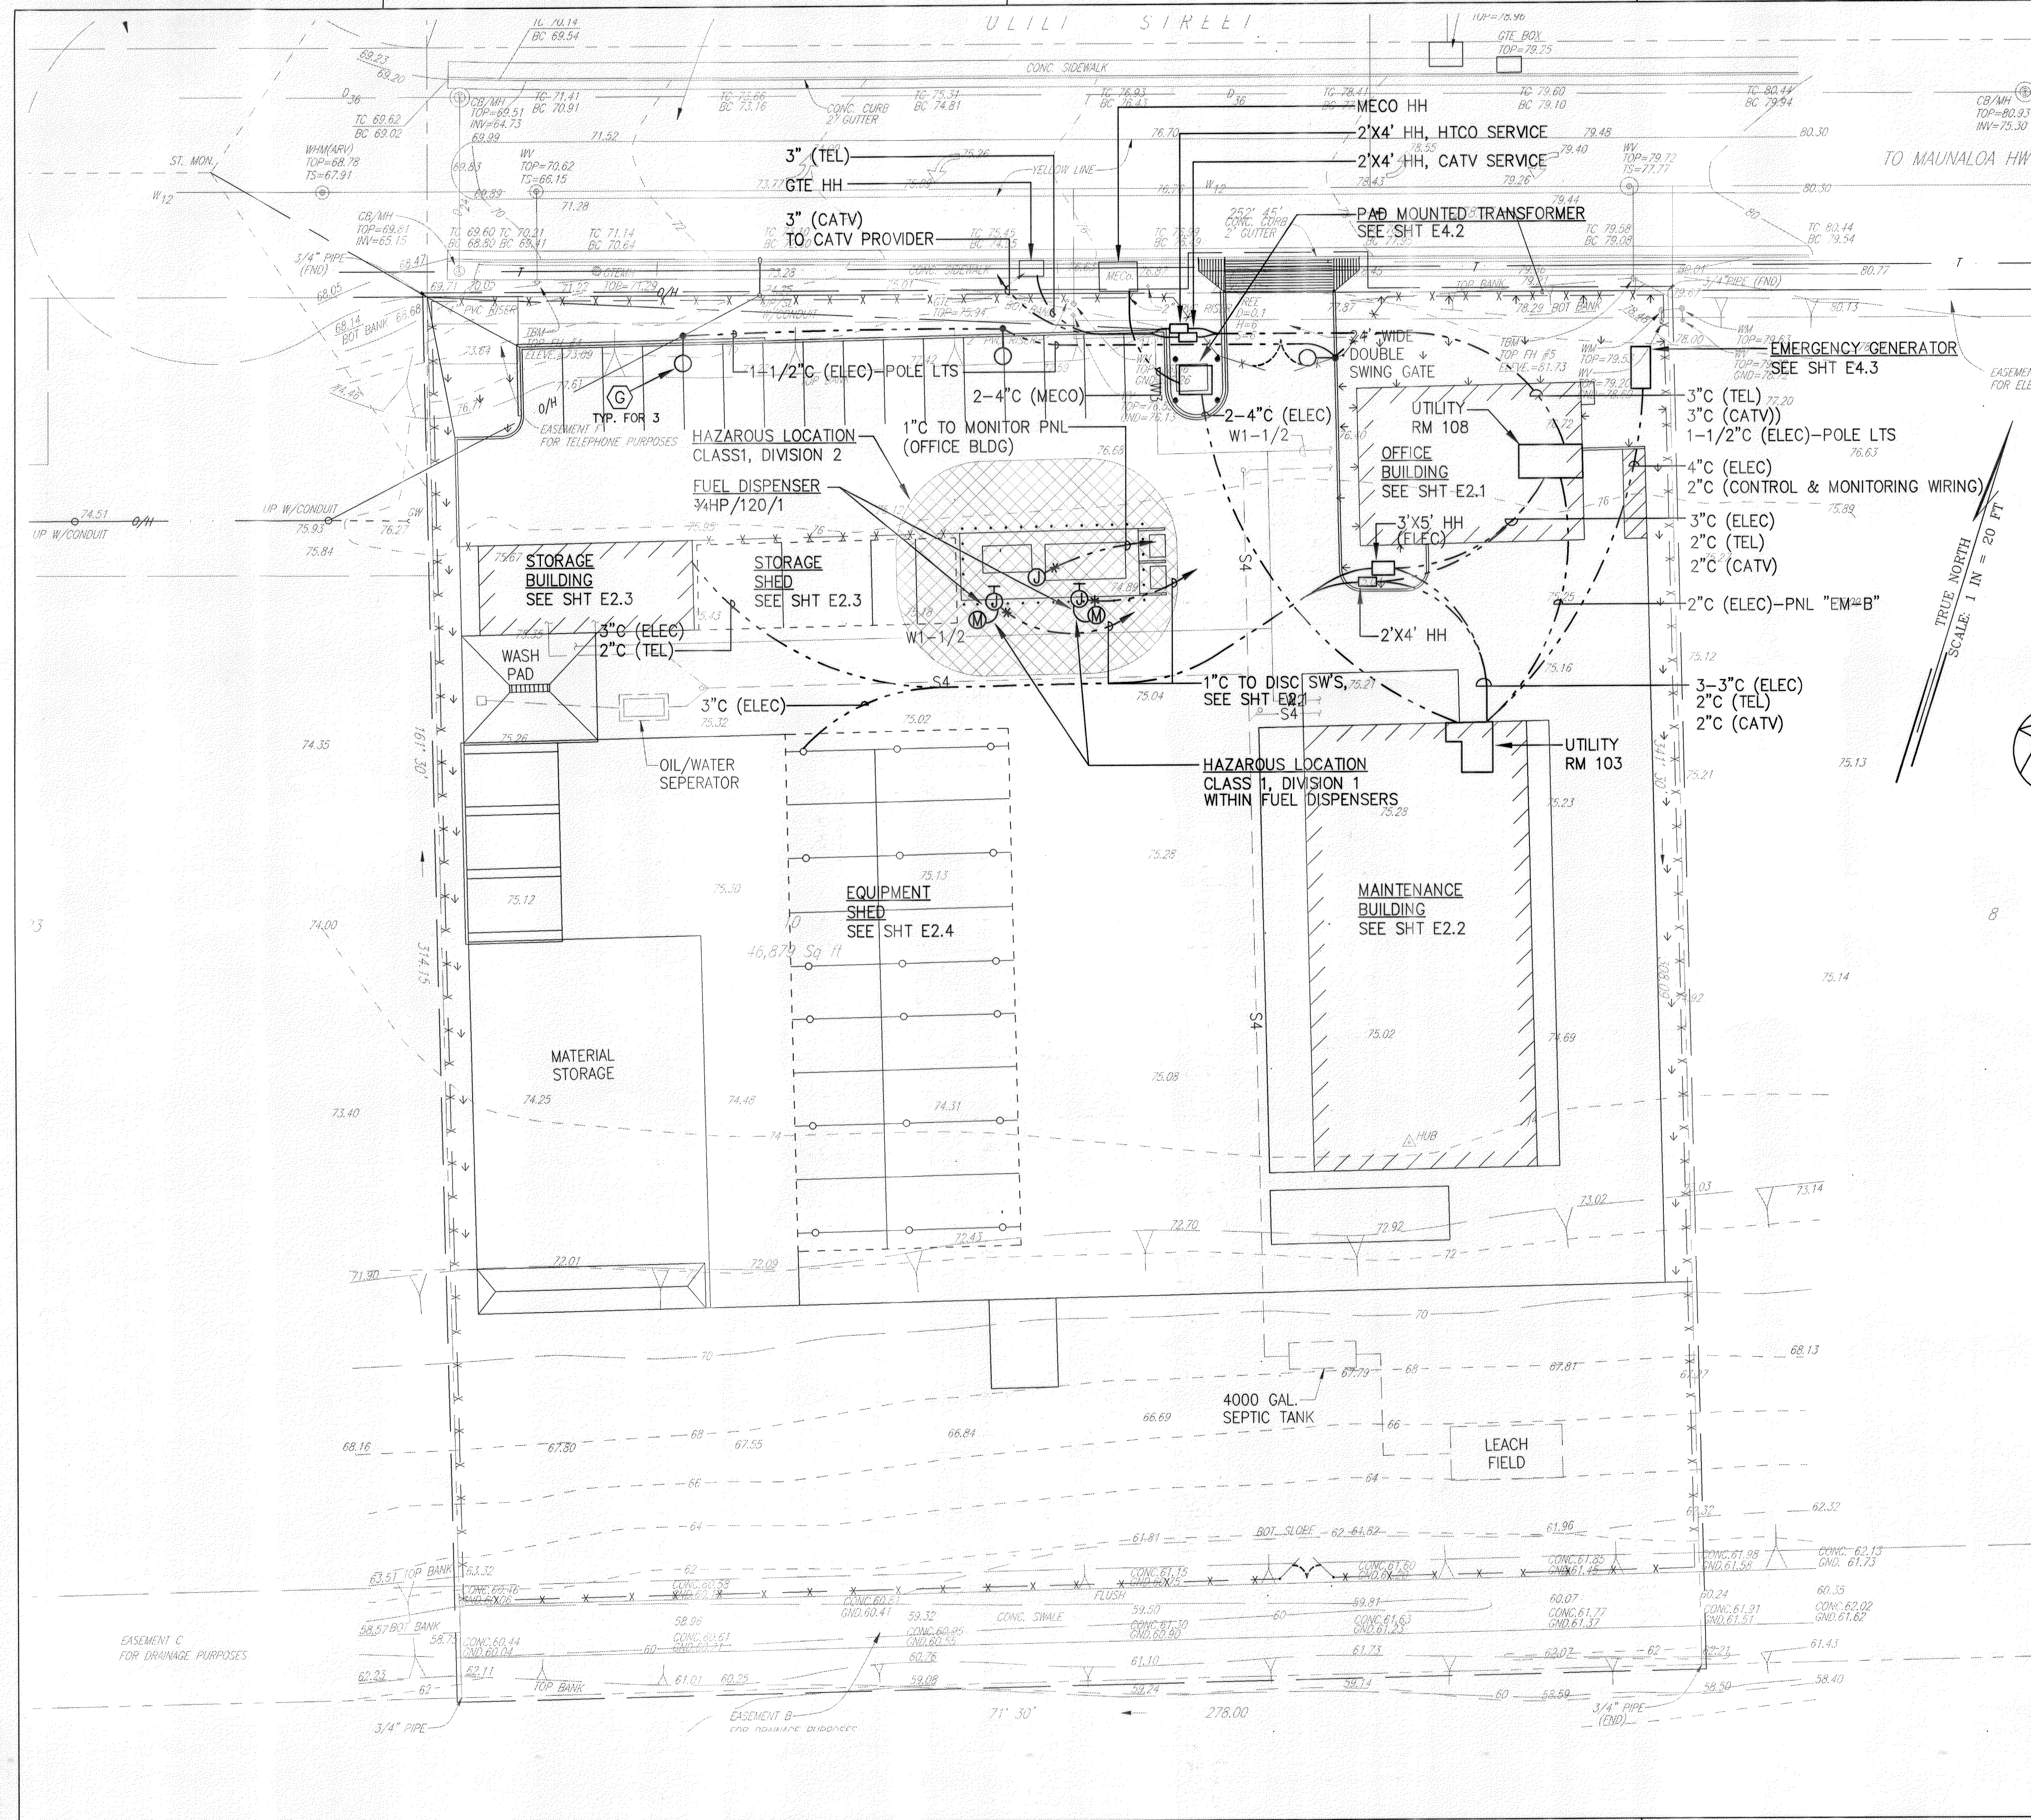

SITE ELECTRICAL PLAN SCALE: 1" = 20' - 0"

- NOTES:**
1. ALL RACEWAYS SHOWN IN OR PASSING THROUGH THE HAZARDOUS ZONE SHALL BE GALV. RIGID STEEL UNLESS NOTED OTHERWISE.
 2. ALL ELECTRICAL EQUIPMENT & WIRING AT & NEARBY FUEL DISPENSING & STORAGE AREAS SHALL COMPLY W/ NEC, ARTICLE 514. PROVIDE CONDUIT SEALS FOR RISERS AT BOTH ENDS OF MONITOR PNL CONDUIT & DISPENSER POWER CONDUITS. ALL JB'S SHALL BE EXPLOSION PROOF.

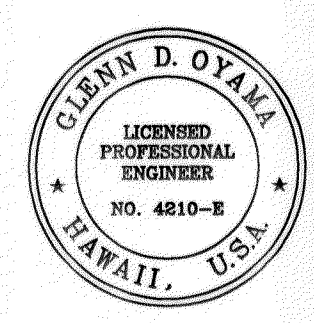

THIS WORK WAS PREPARED BY ME OR UNDER MY SUPERVISION
Glenn D. Oyama

STATE OF HAWAII
 DEPARTMENT OF TRANSPORTATION
 HIGHWAYS DIVISION

SITE ELECTRICAL PLAN

MOLOKAI BASEYARD
 MOLOKAI INDUSTRIAL PARK
 Project No. HWY-M-05-98

Scale: As Noted Date: SEPT. 13, 2001

SHEET No. E1.1 OF E1.1 SHEETS

ORIGINAL PLAN	SURVEY PLOTTED BY	DATE
DESIGNED BY	DRAWN BY	
CHECKED BY	NOTED BY	
	QUANTITIES BY	