



FED. ROAD DIST. NO.	STATE	FED. AID PROJ. NO.	FISCAL YEAR	SHEET NO.	TOTAL SHEETS
HAWAII	HAW.	HWY-M-05-98	2002	81	99

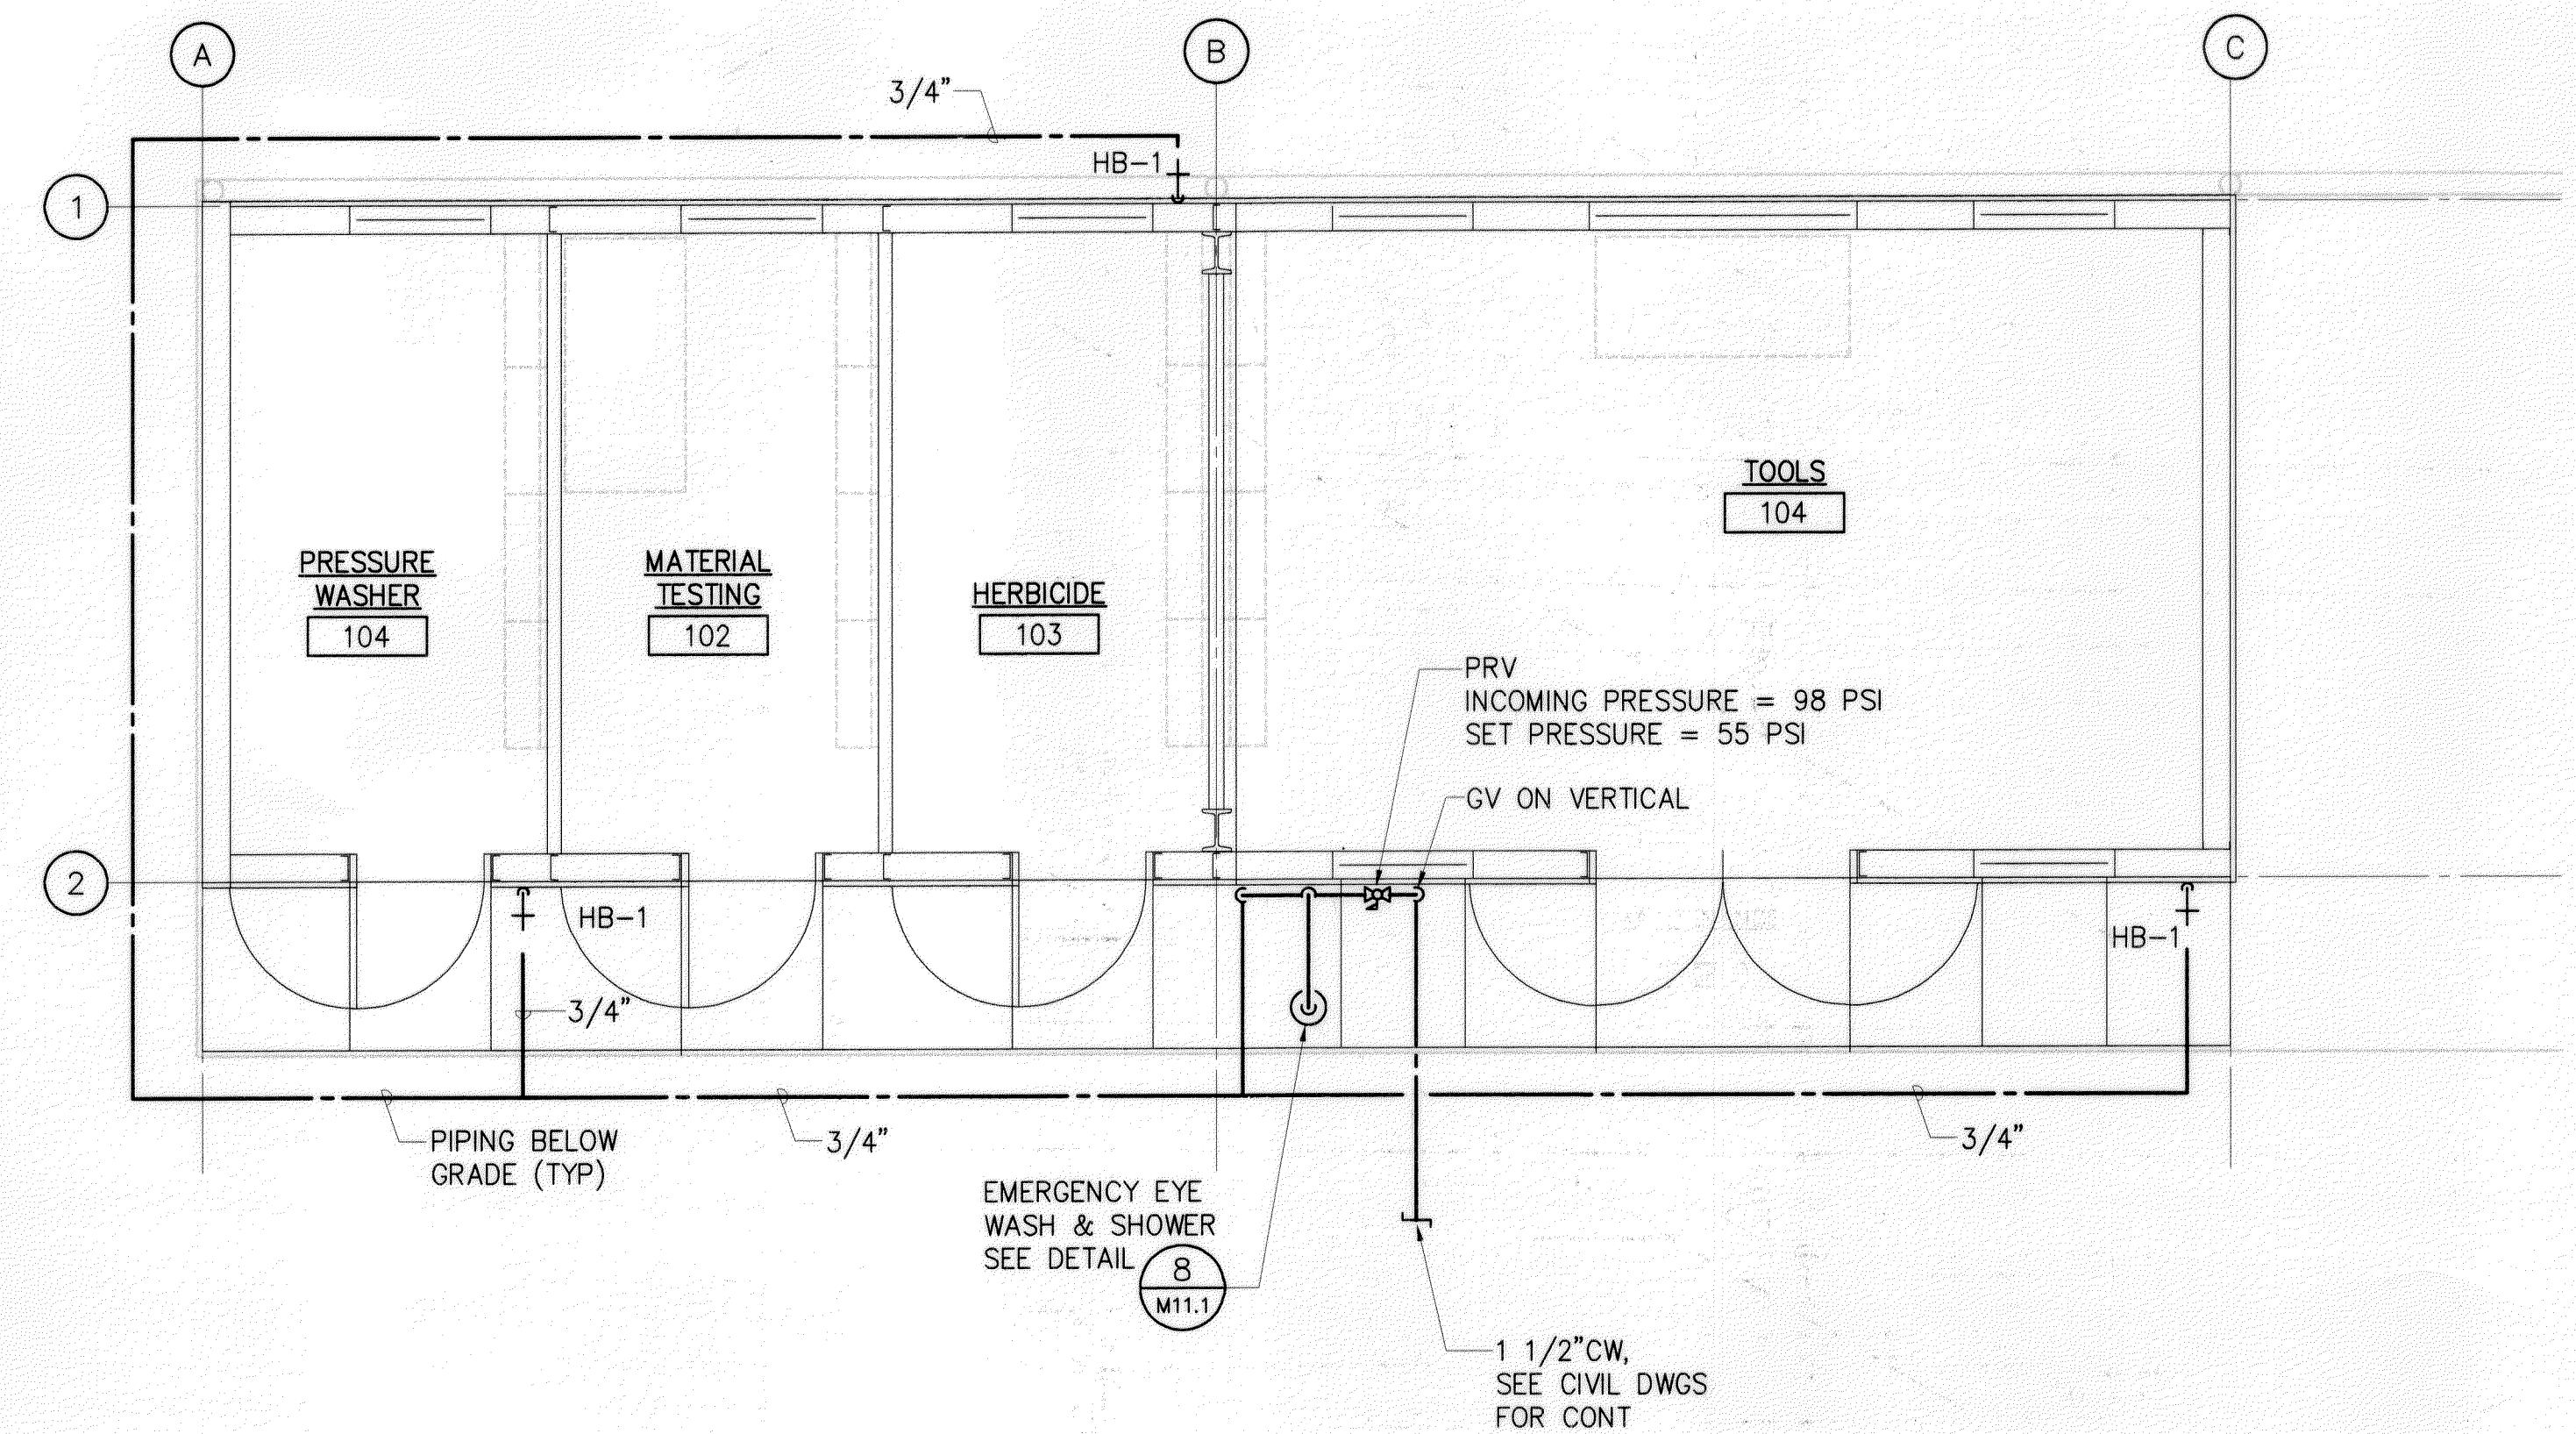


STORAGE BUILDING PLUMBING FLOOR PLAN (DEDUCTIVE NO. 1)
 SCALE: 1/4" = 1'-0"

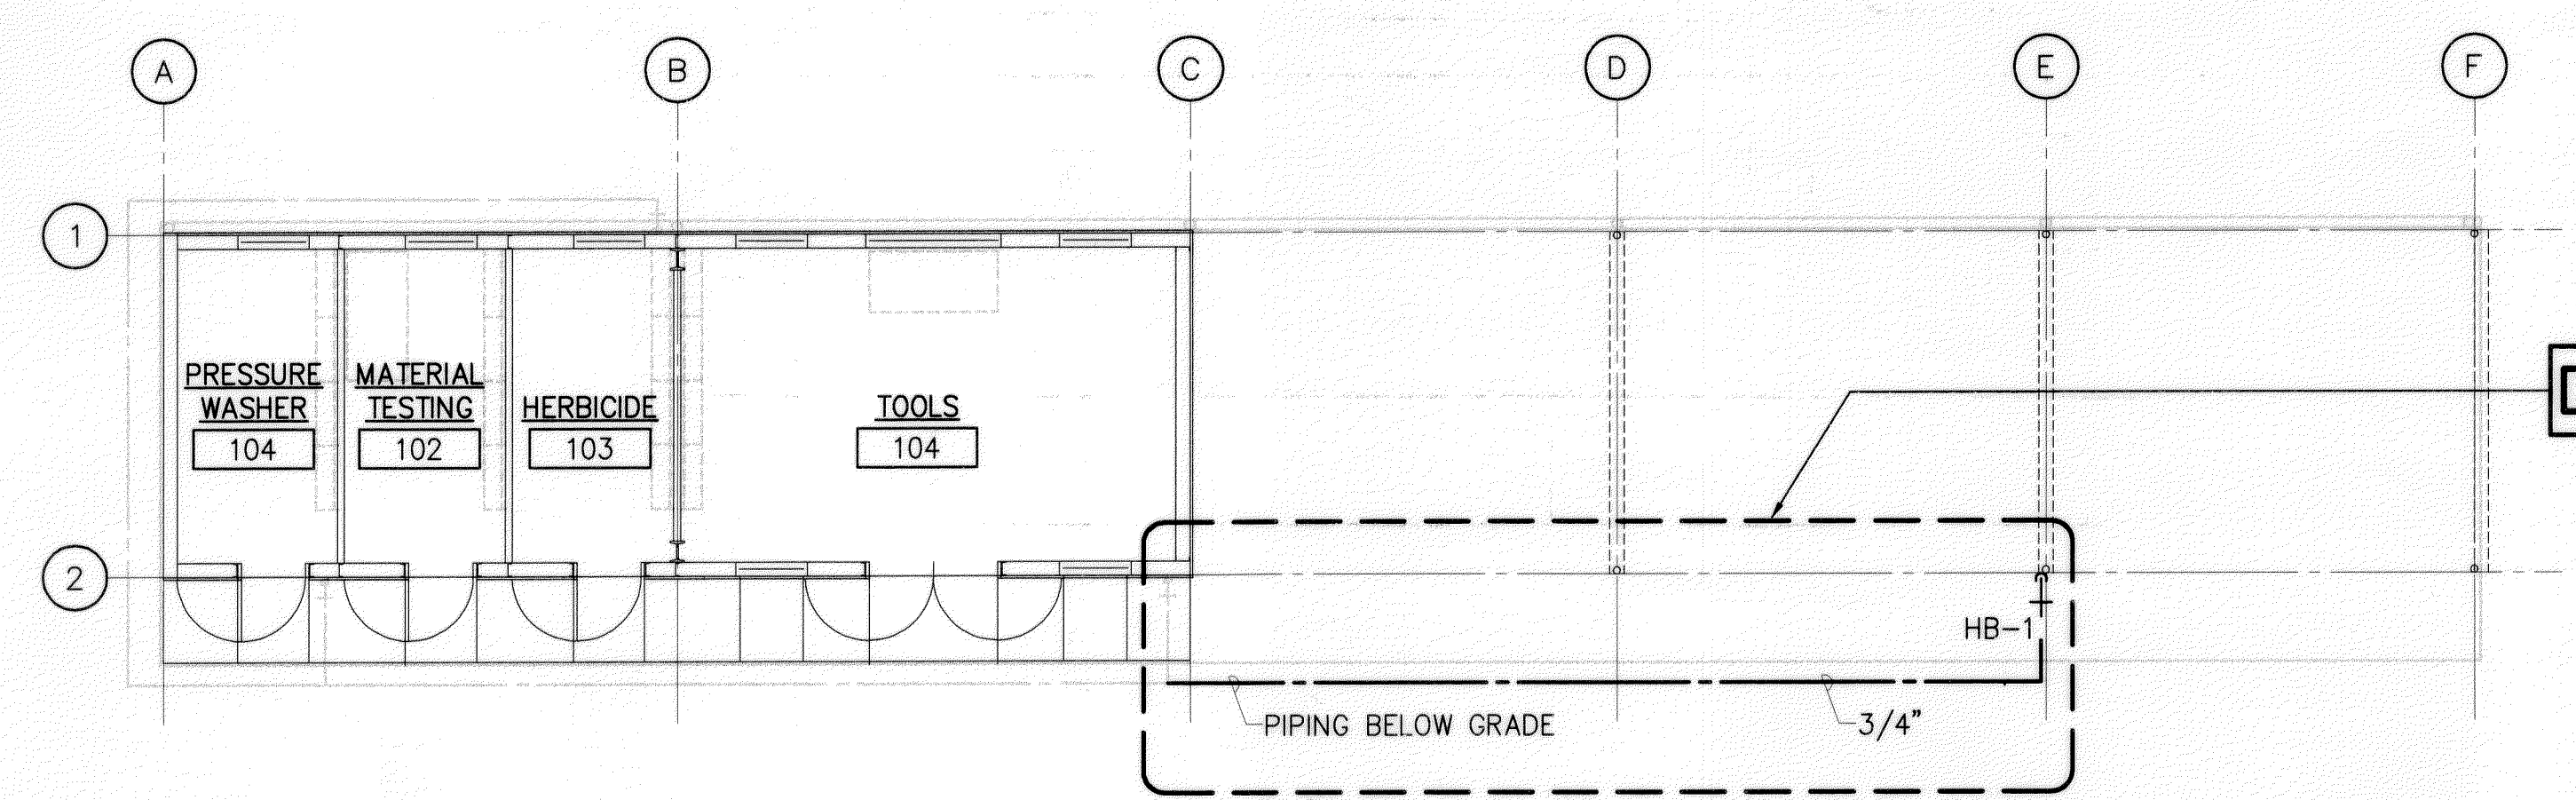

DEDUCTIVE NO. 2

STORAGE SHED PLUMBING FLOOR PLAN (DEDUCTIVE NO. 2)
 SCALE: 1/8" = 1'-0"

NOTE:
 MOUNT HOSE BIBBS AT APPROXIMATELY 2'-0" AFF.

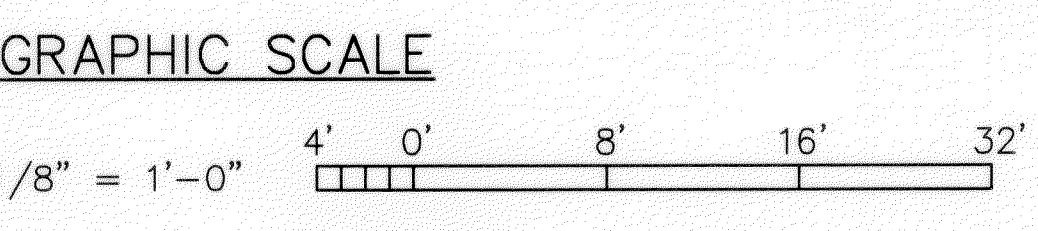

ORIGINAL PLAN	SURVEY PLOTTED BY	DATE
NOTED	DRAWN BY	
DESIGNED BY	TRACED BY	
QUANTITIES BY	CHECKED BY	
No.		

KEN I. MASHIMA
 LICENSED PROFESSIONAL ENGINEER
 No. 4953-M
 HAWAII, U.S.A.
 THIS WORK WAS PREPARED BY ME OR UNDER MY SUPERVISION

STATE OF HAWAII
 DEPARTMENT OF TRANSPORTATION
 HIGHWAYS DIVISION
 STORAGE BUILDING
 PLUMBING FLOOR PLAN
 MOLOKAI BASEYARD
 MOLOKAI INDUSTRIAL PARK
 Project No. HWY-M-05-98
 Scale: As Noted
 Date: SEPT 13, 2001

SHEET No. M3.1 OF M3.1 SHEETS

STORAGE BUILDING/STORAGE SHED