




FED. ROAD DIST. NO.	STATE	PROJ. NO.	FISCAL YEAR	SHEET NO.	TOTAL SHEETS
HAWAII	HAW.	HWY-M-05-98	2002	60	99

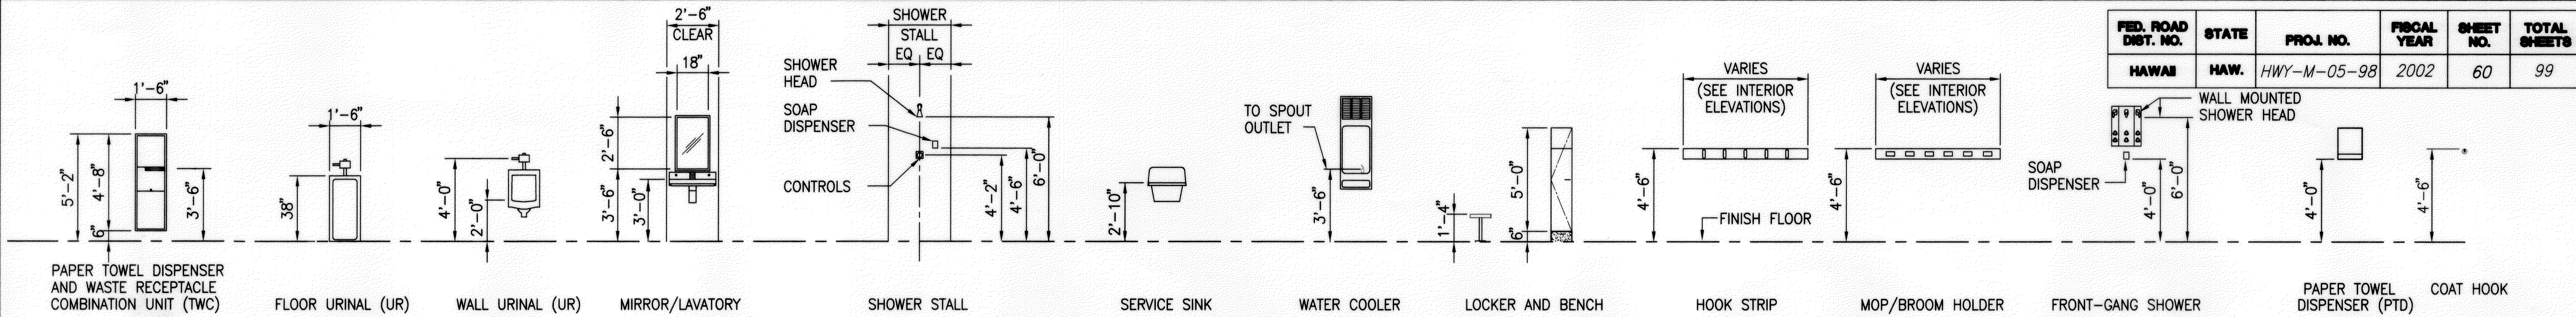


TYPICAL MOUNTING HEIGHT
SCALE: 1/4"=1'-0"

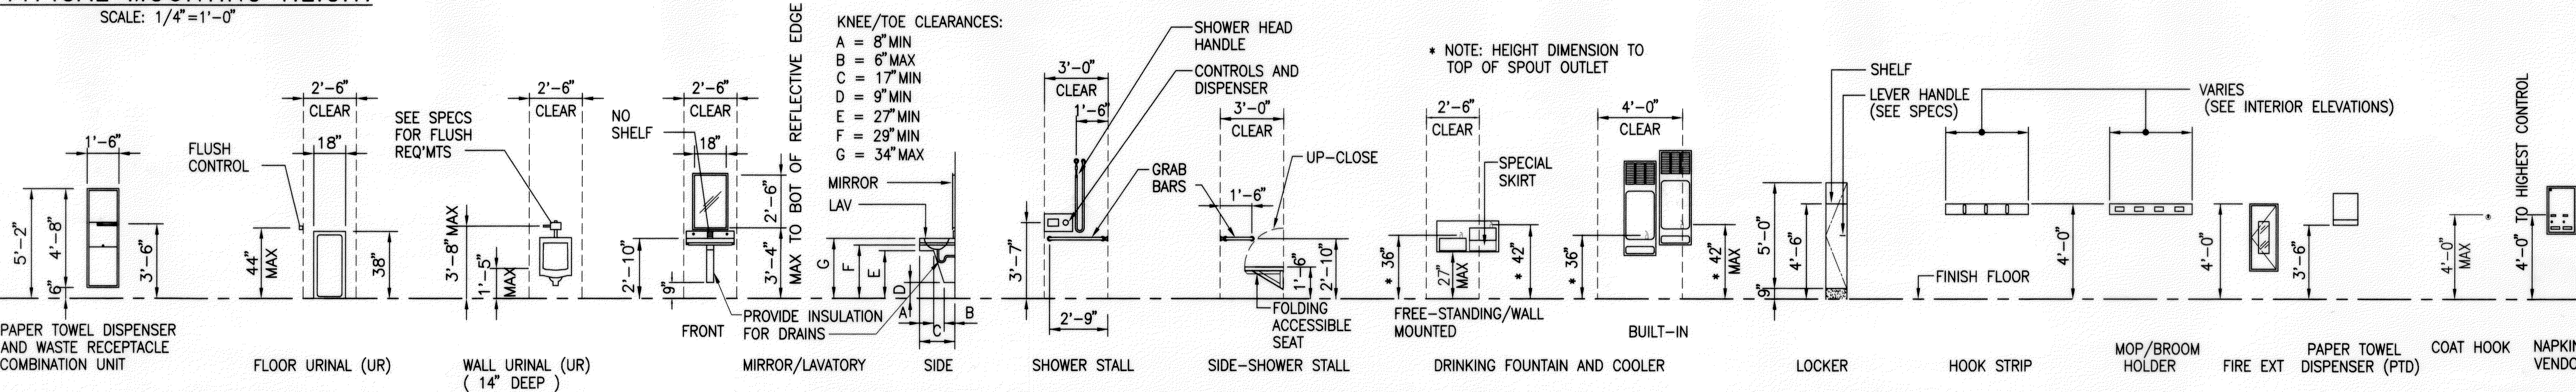


ADA FIXTURES AND EQUIPMENT MOUNTING HEIGHT
SCALE: 1/4"=1'-0"

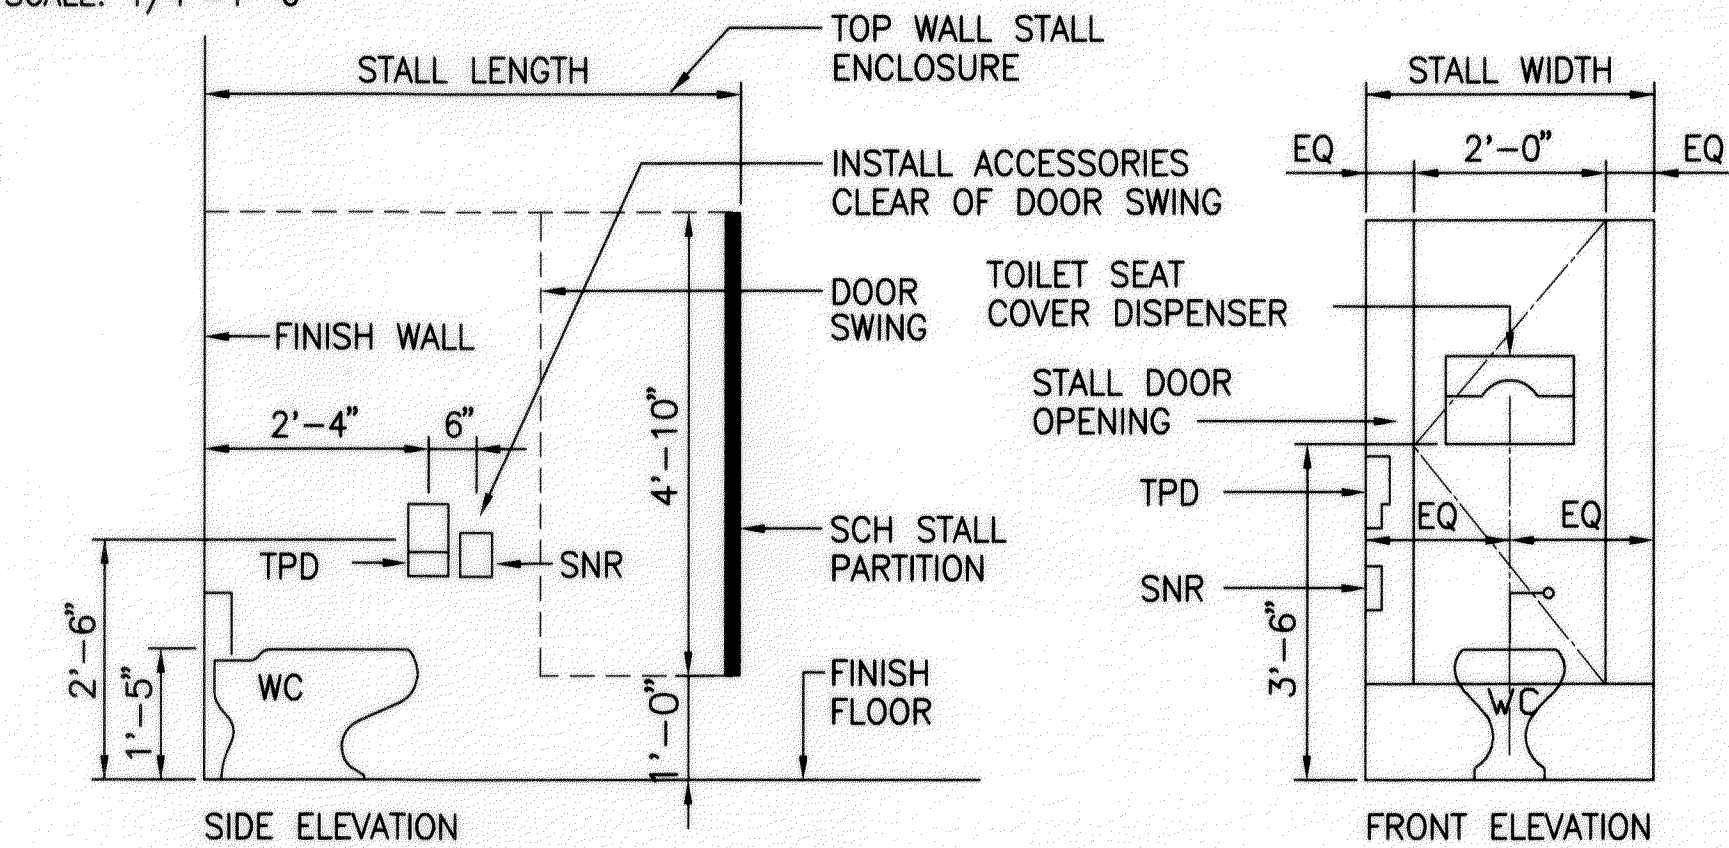


TYPICAL WATER CLOSET
SCALE: 1/2"=1'-0"

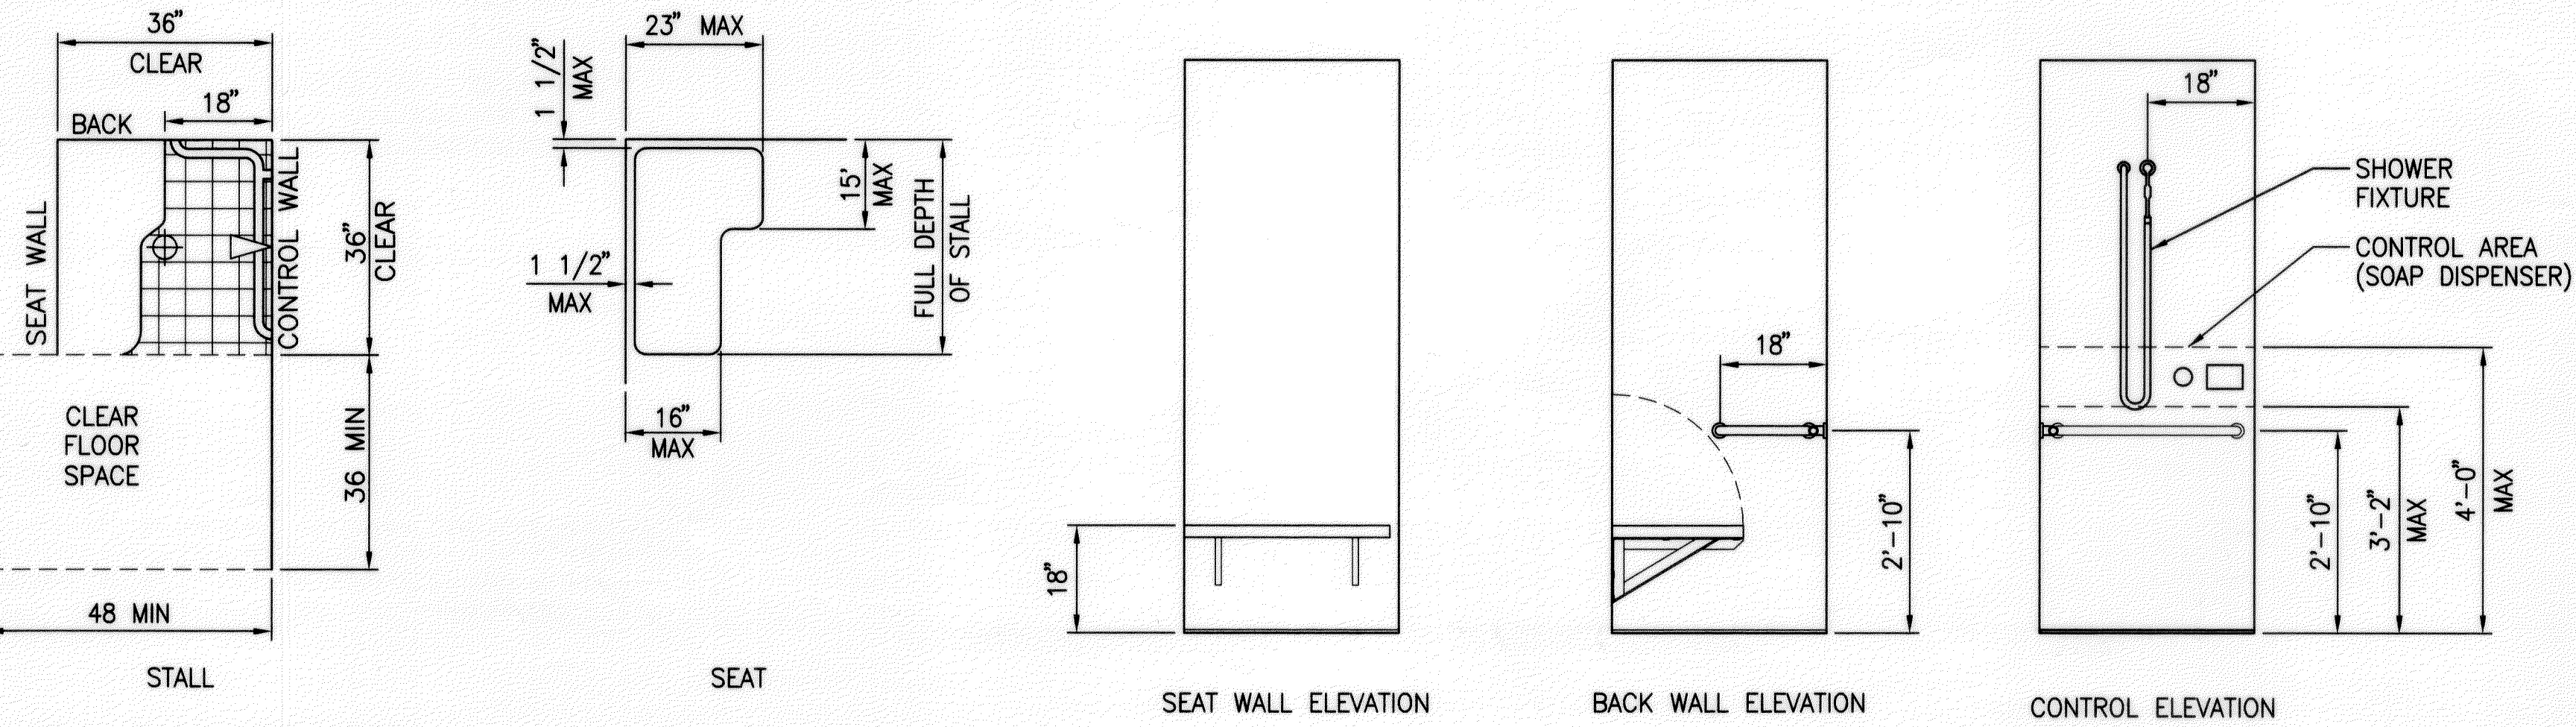

ADA SHOWER STALL
SCALE: 1/2"=1'-0"

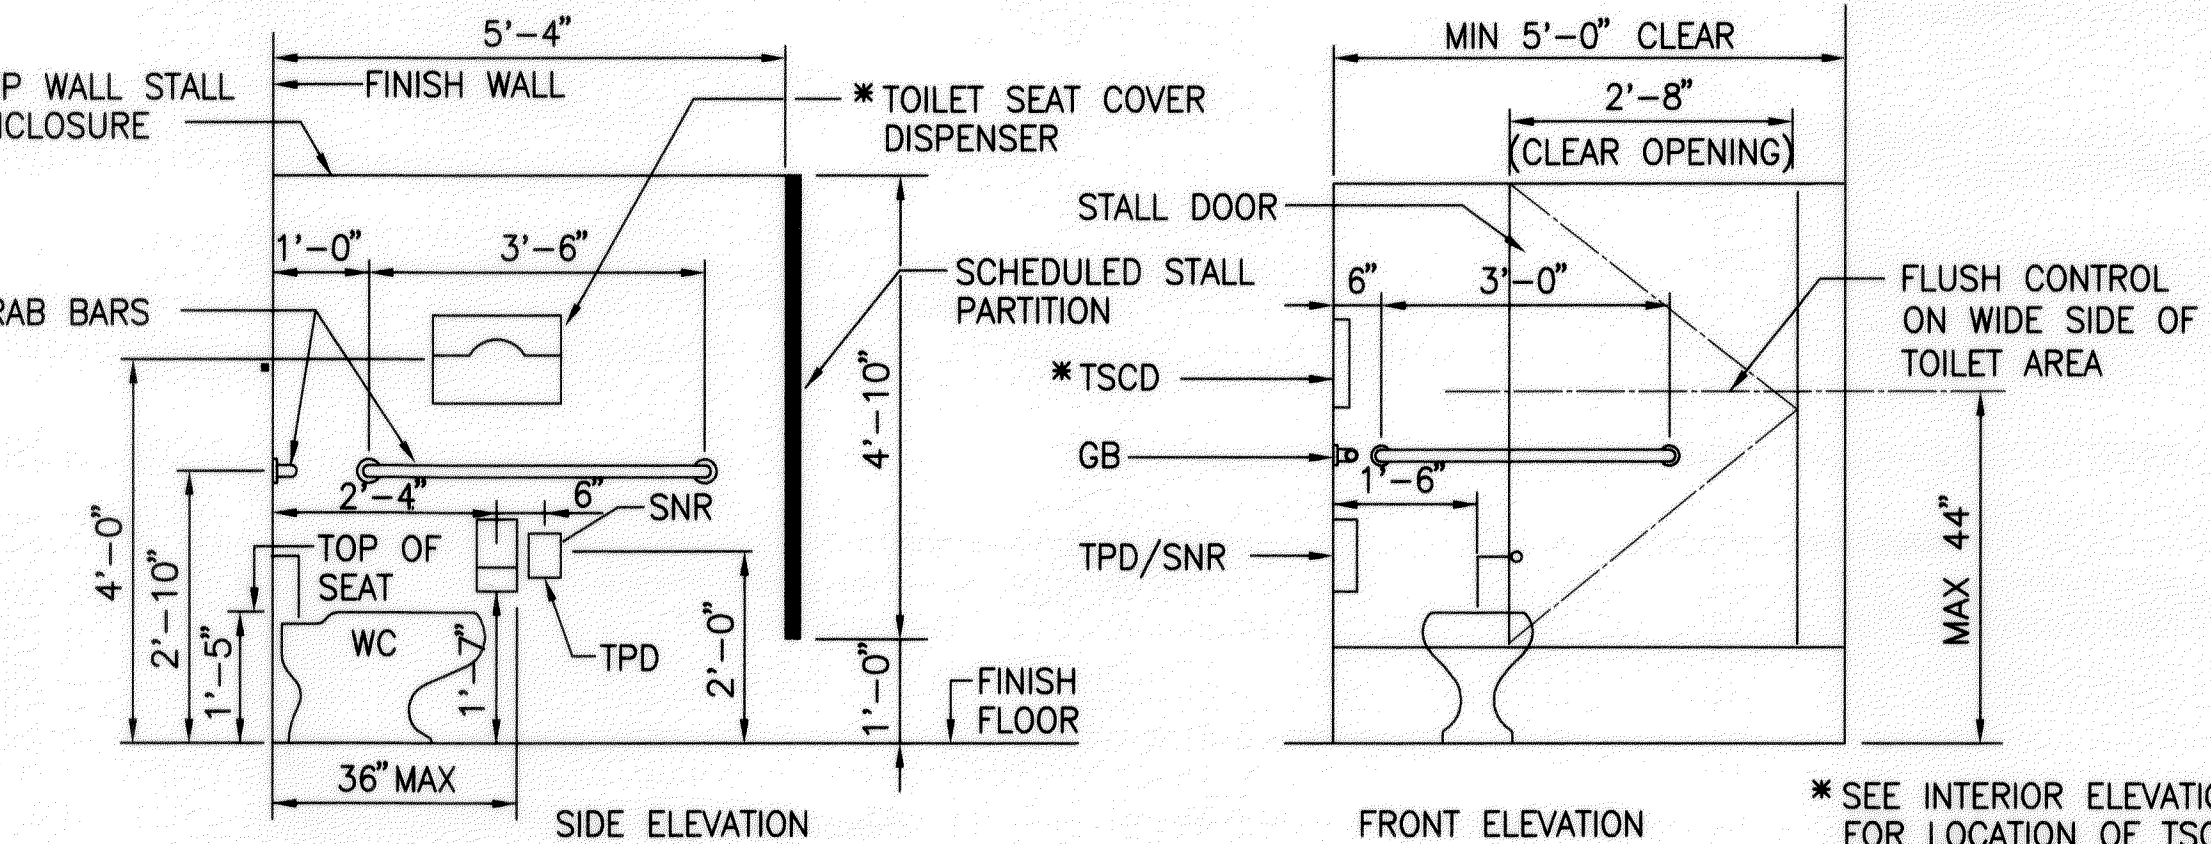

ADA WATER CLOSET
SCALE: 1/2"=1'-0"

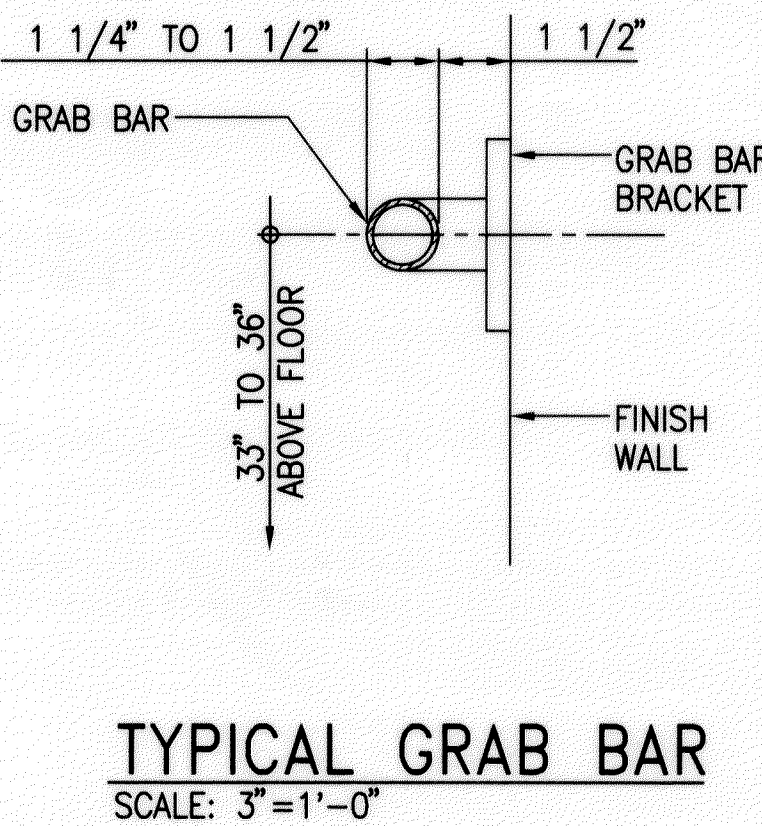

TYPICAL GRAB BAR
SCALE: 3"=1'-0"

- NOTE:**
(SPECIAL ABBREVIATIONS)
- TWC PAPER TOWEL DISPENSER AND WASTE RECEPTACLE COMBINATION UNIT
 - WC WATER CLOSET
 - UR URINAL
 - PTD PAPER TOWEL DISPENSER
 - SND SANITARY NAPKIN DISPOSAL
 - SNR SANITARY NAPKIN RECEPTACLE
 - TSCD TOILET SEAT COVER DISPENSER
 - TPD TOILET PAPER DISPENSER
 - GB GRAB BAR



THIS WORK WAS PREPARED BY
ME OR UNDER MY SUPERVISION

TYPICAL PLUMBING FIXTURES

STATE OF HAWAII
DEPARTMENT OF TRANSPORTATION
HIGHWAYS DIVISION

**TYPICAL PLUMBING FIXTURES
& ACCESSORIES INSTALLATION**

MOLOKAI BASEYARD
MOLOKAI INDUSTRIAL PARK
Project No. HWY-M-05-98

Scale: As Noted Date: SEPT. 13, 2001

SHEET No. A8.2 OF A8.3 SHEETS

DESIGNED BY	DATE
DRAWN BY	
CHECKED BY	
NOTED BY	
APPROVED BY	
ORIGINAL PLAN	
NO.	