


FED. ROAD DIST. NO.	STATE	FED-AID PROJ. NO.	FISCAL YEAR	SHEET NO.	TOTAL SHEETS
HAWAII	HAW.	HWY-M-05-98	2002	9	99

LEGEND

- PROJECT LIMIT
- PROPERTY LINE
- NEW BUILDING
- LEACHFIELD
- COVERED PARKING OR NEW BUILDING (DEDUCTIVE ALTERNATIVE)
- COTG
- SEWER LINE WITH PIPE SIZE
- WATER LINE WITH PIPE SIZE
- FIRE LINE WITH PIPE SIZE
- REDUCER
- GATE VALVE

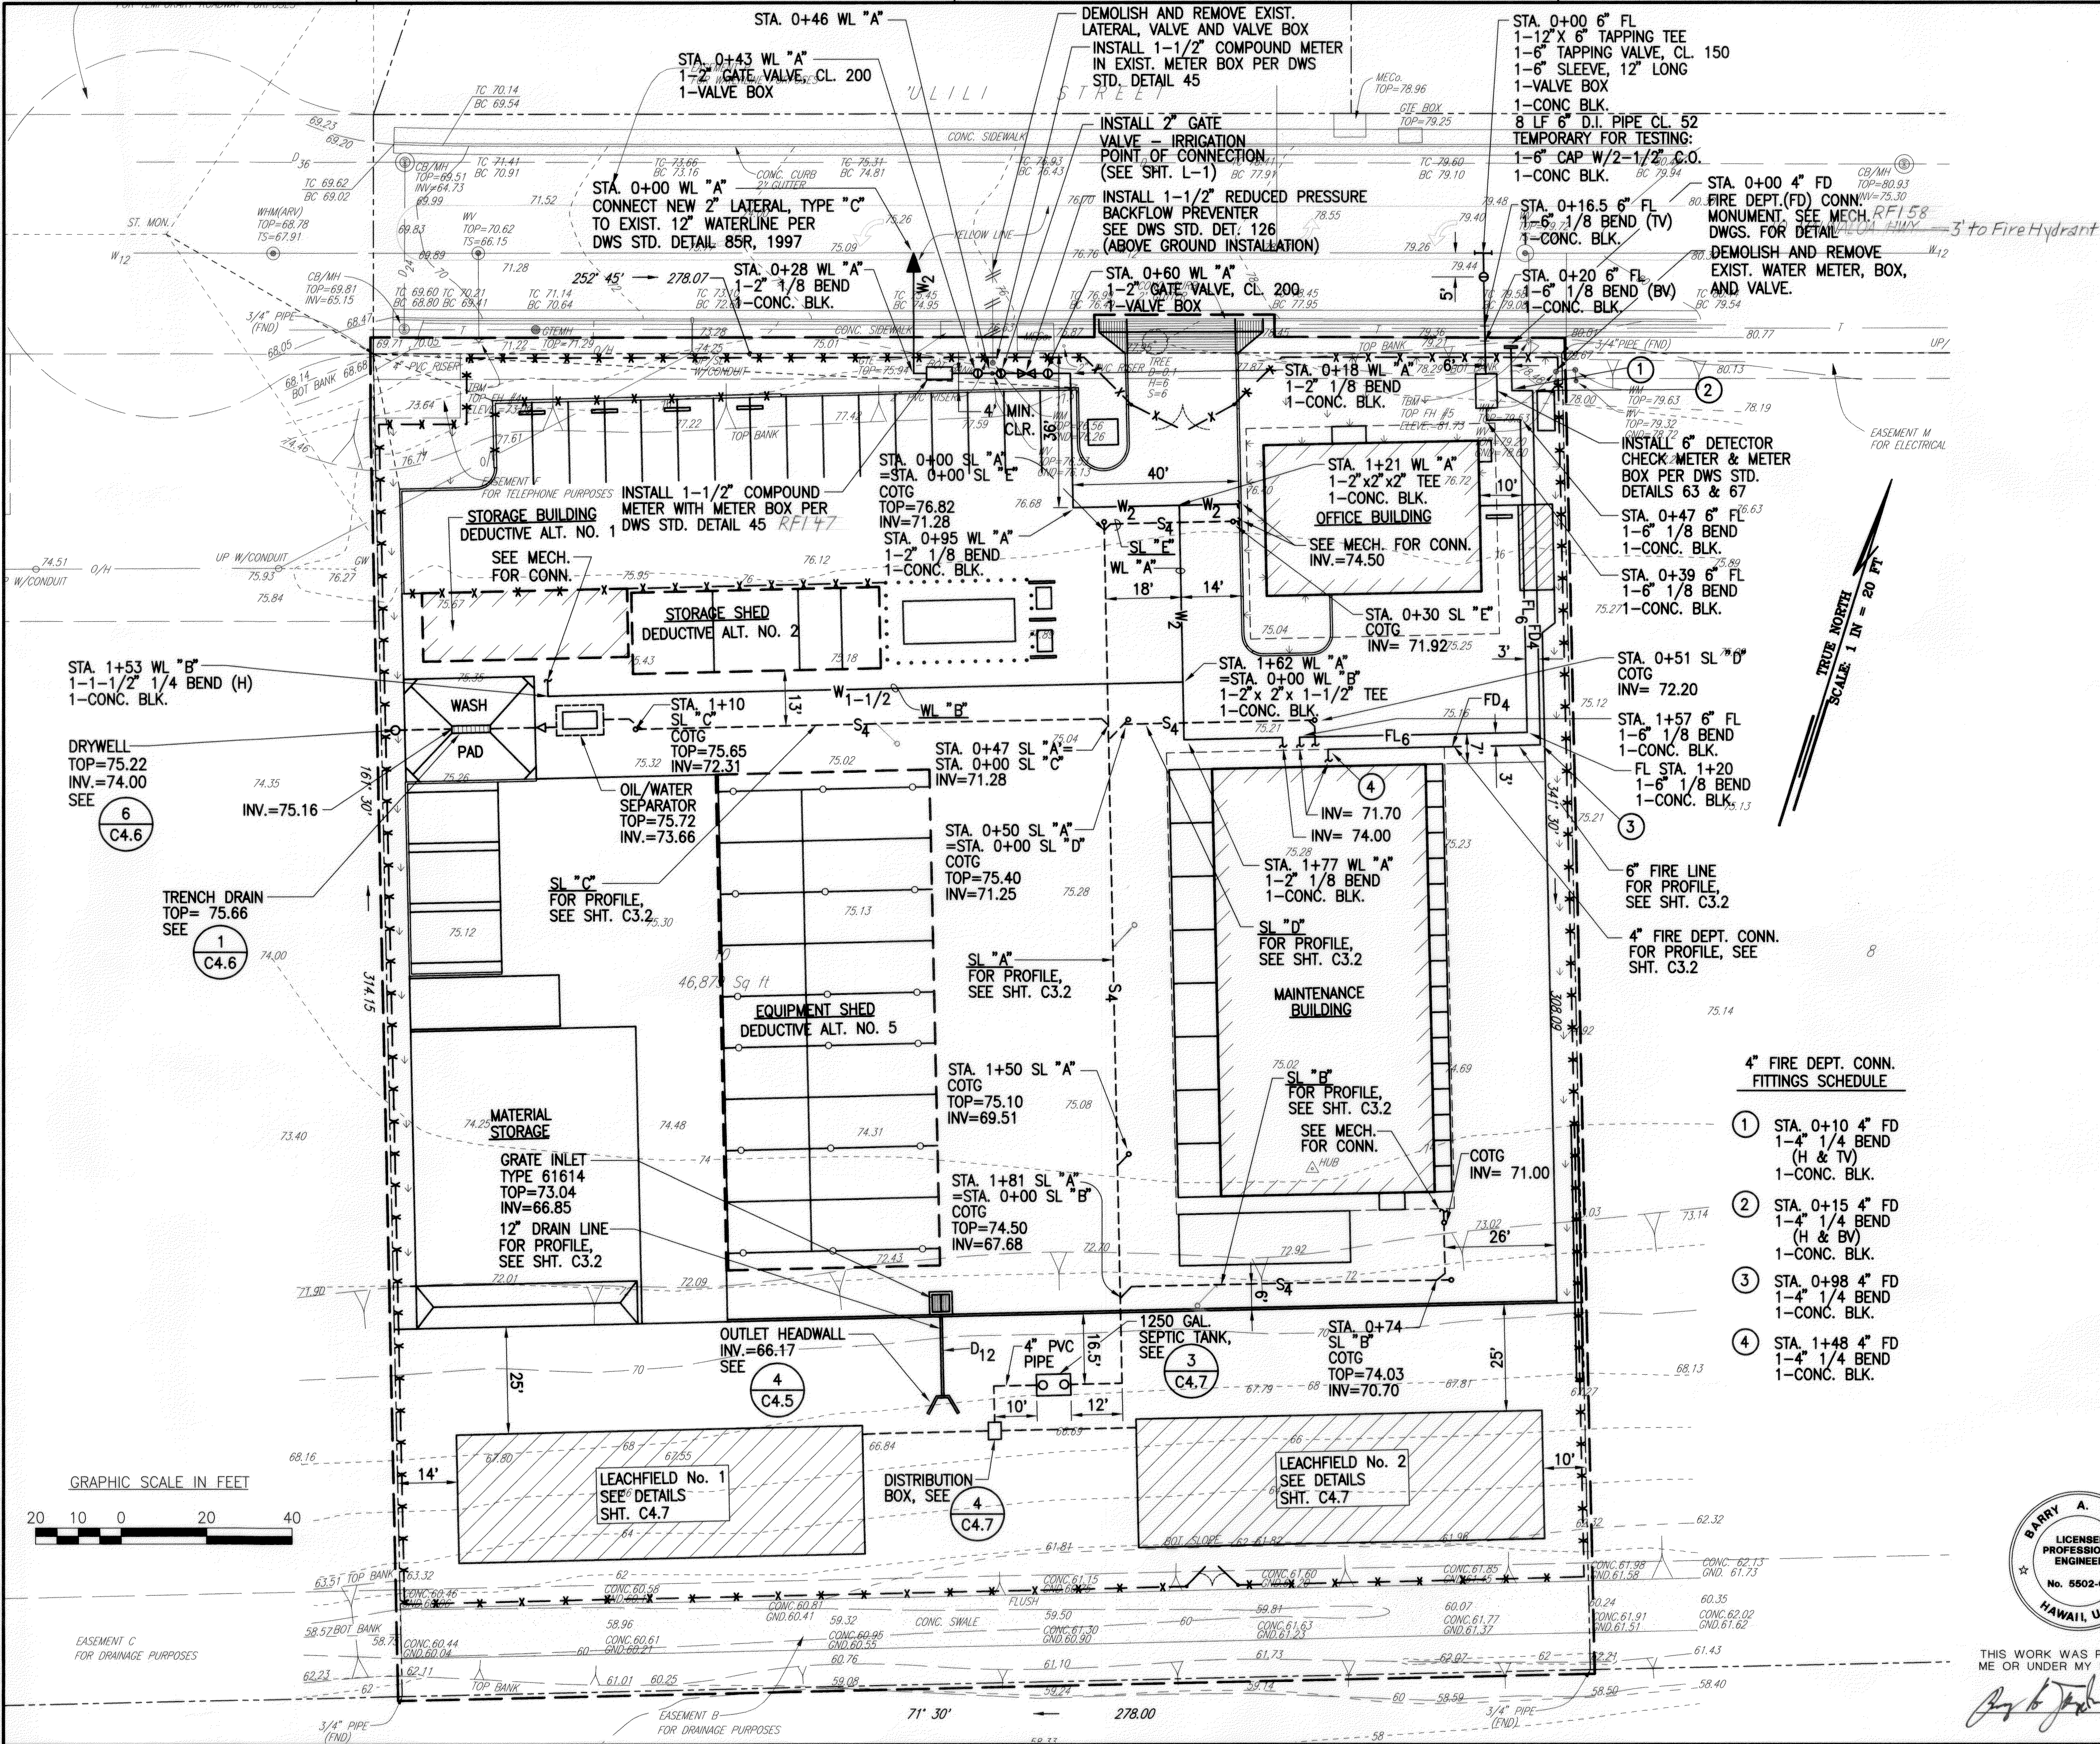

4" FIRE DEPT. CONN. FITTINGS SCHEDULE

- STA. 0+10 4" FD 1-4" 1/4 BEND (H & TV) 1-CONC. BLK.
- STA. 0+15 4" FD 1-4" 1/4 BEND (H & BV) 1-CONC. BLK.
- STA. 0+98 4" FD 1-4" 1/4 BEND 1-CONC. BLK.
- STA. 1+48 4" FD 1-4" 1/4 BEND 1-CONC. BLK.



THIS WORK WAS PREPARED BY ME OR UNDER MY SUPERVISION

DATE	REVISION
	STATE OF HAWAII DEPARTMENT OF TRANSPORTATION HIGHWAYS DIVISION UTILITY PLAN MOLOKAI BASEYARD MOLOKAI INDUSTRIAL PARK Project No. HWY-M-05-98 Scale: As Noted Date: Sept. 13, 2001 SHEET No. C2.2 OF C2.2 SHEETS