

INDEX TO DRAWINGS		
SHEET NO.		DESCRIPTION
1	T1.0	TITLE SHEET
ARCHITECTURAL DRAWINGS		
2	A1.1	SITE PLAN, GENERAL NOTES
3	A1.2	FLOOR PLAN, ELEVATIONS, & SECTION
4	A1.3	CEILING AND ROOF PLANS & SECTION
5	A1.4	CEILING & ROOF DETAILS
6	A2.1	DISTRICT OFFICE - PLAN & ELEVATION
STRUCTURAL DRAWINGS		
7	S1.0	GENERAL NOTES
8	S1.1	GENERAL NOTES
9	S1.2	TYPICAL DETAILS
10	S2.0	FOUNDATION & ROOF FRAMING PLANS
11	S2.1	SECTIONS AND DETAILS
MECHANICAL DRAWINGS		
12	M1.0	MECHANICAL DEMO & NEW WORK PLANS
13	M2.0	EQUIPMENT SCHEDULE & DETAILS
ELECTRICAL DRAWINGS		
14	E1.0	GAS STATION - ELECTRICAL PLAN
15	E2.0	DISTRICT OFFICE - ELECTRICAL PLAN

APR 2001 DATE
873-3535 PHONE
HWY-M P. S. + E. BY
PAUL S. OSUMI, JR., AIA, INC. DESIGNED BY

CONSULTANTS:

ARCHITECT:

PAUL S. OSUMI, JR. AIA, INC.
700 BISHOP ST., SUITE 700
HONOLULU, HAWAII 96813
PHONE: (808) 528-3500
FAX: (808) 532-0828

MECHANICAL ENGINEER:

CEDRIC D.O. CHONG & ASSOCIATES, INC.
828 FORT STREET MALL, SUITE 500
HONOLULU, HAWAII 96813
PHONE: (808) 521-3773
FAX: (808) 521-3993


STRUCTURAL ENGINEER:

KAI HAWAII, INC.
705 SOUTH KING ST., SUITE 106
HONOLULU, HAWAII 96813
PHONE: (808) 533-2210
FAX: (808) 533-2686

ELECTRICAL ENGINEER:




RS ENGINEERING, INC.
1376 KALANIKI ST.
HONOLULU, HAWAII 96821
PHONE: (808) 377-9210
FAX: (808) 377-9210

STATE OF HAWAII
DEPARTMENT OF TRANSPORTATION
HIGHWAYS DIVISION
HONOLULU, HAWAII
"AS-BUILT"
PLANS FOR
MAUI DISTRICT BASEYARD
REPAIR AND MAINTENANCE OF
BUILDINGS AND GROUNDS
DISTRICT OF WAILUKU
ISLAND OF MAUI
PROJECT NO. HWY-M-03-99M

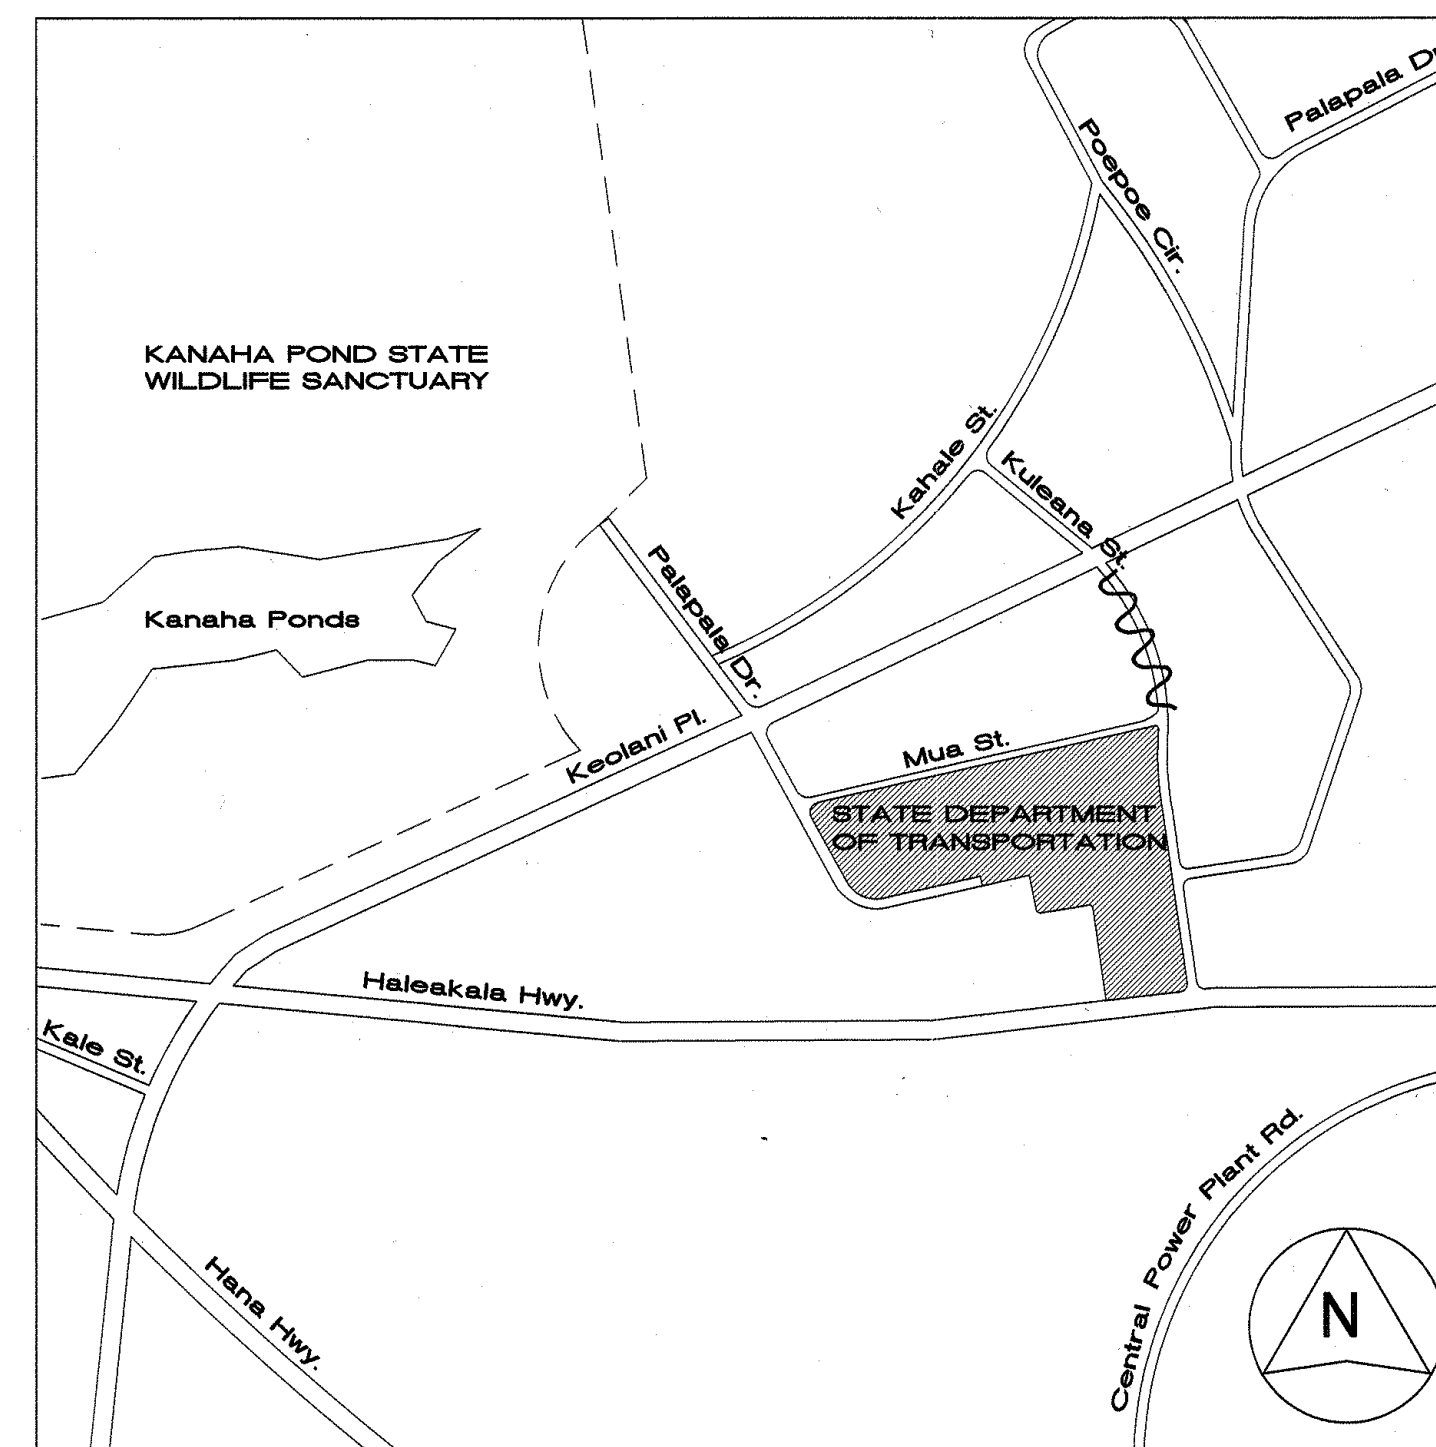

VICINITY MAP
NOT TO SCALE

FED. ROAD DIST. NO.	STATE	PROJ. NO.	FISCAL YEAR	SHEET NO.	TOTAL SHEETS
HAWAII	HAW.	HWY-M-03-99M	2001	1	15

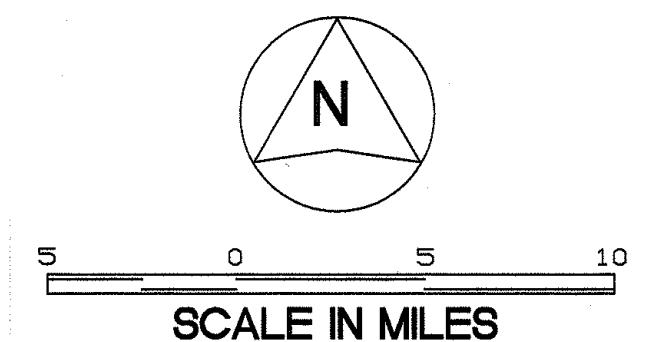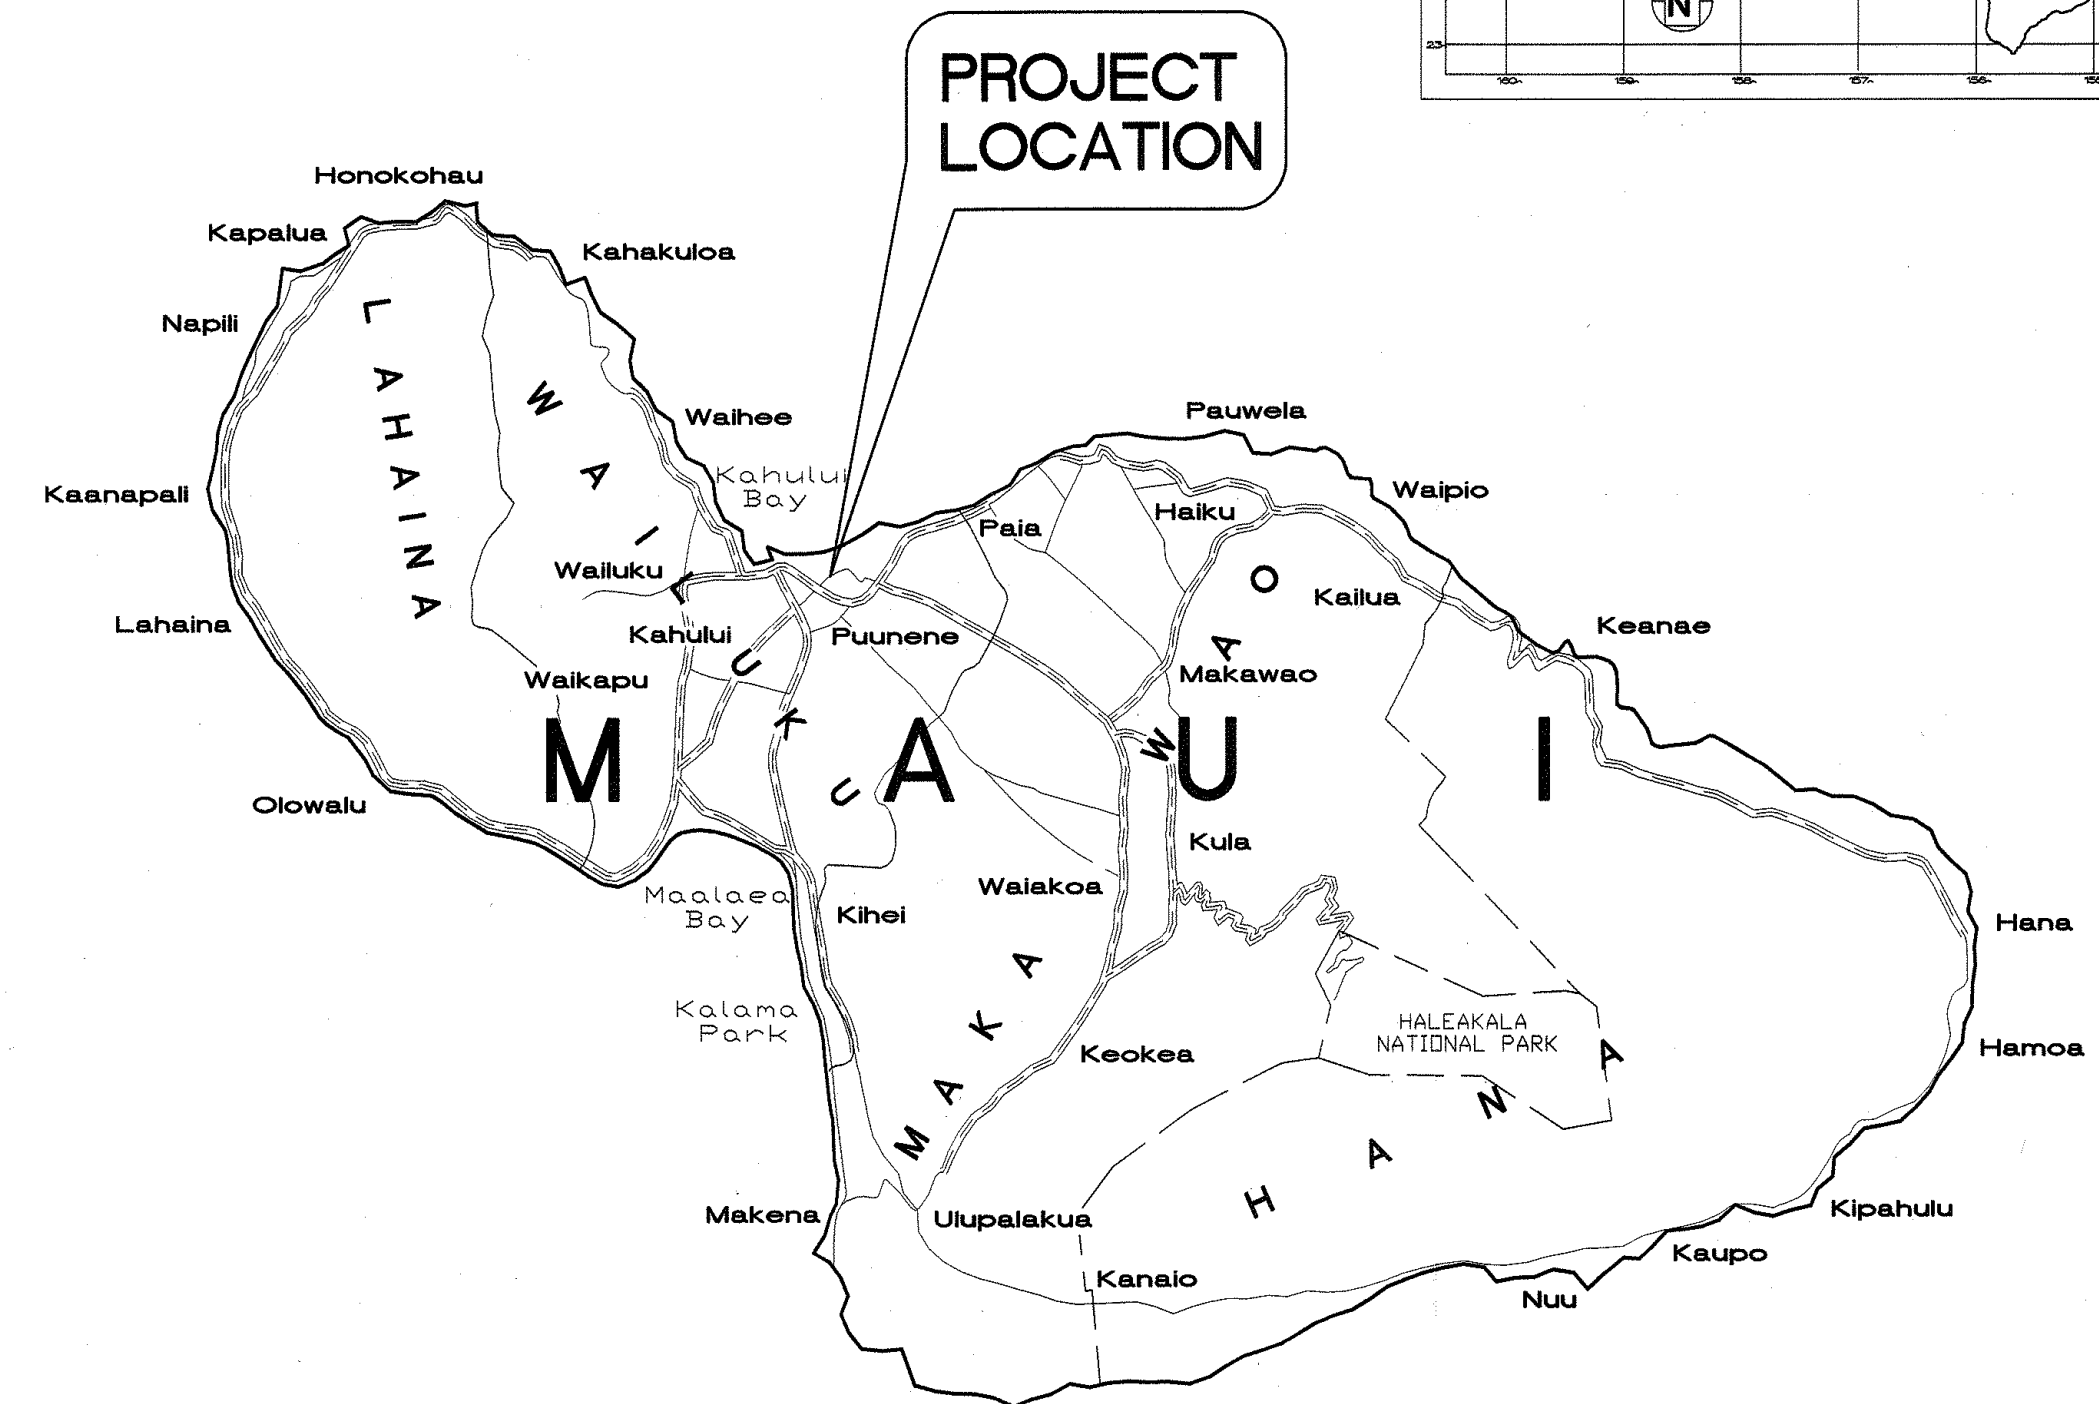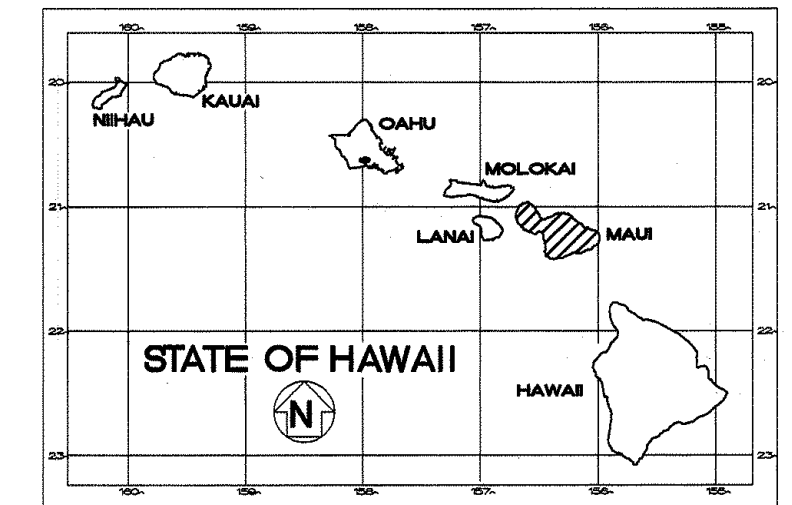

CHANGES MADE DURING CONSTRUCTION HAVE BEEN INCORPORATED ON THESE PLANS EXCEPT CHANGES IN THE ORIGINAL THEORETICAL QUANTITIES. FOR ACTUAL QUANTITIES, REFER TO PROJECT LEDGER AND/OR COMPUTATION BOOK.

RESIDENT ENGINEER DATE

DEPARTMENT OF TRANSPORTATION STATE OF HAWAII	
APPROVED:	
<i>Paul S. Osumi, Jr.</i> for DIR. OF TRANSPORTATION	S-24-01 DATE