


FED. ROAD DIST. NO.	STATE	PROJ. NO.	FISCAL YEAR	SHEET NO.	TOTAL SHEETS
HAWAII	HAW.	HWY-M-08-04M	2005	13	26

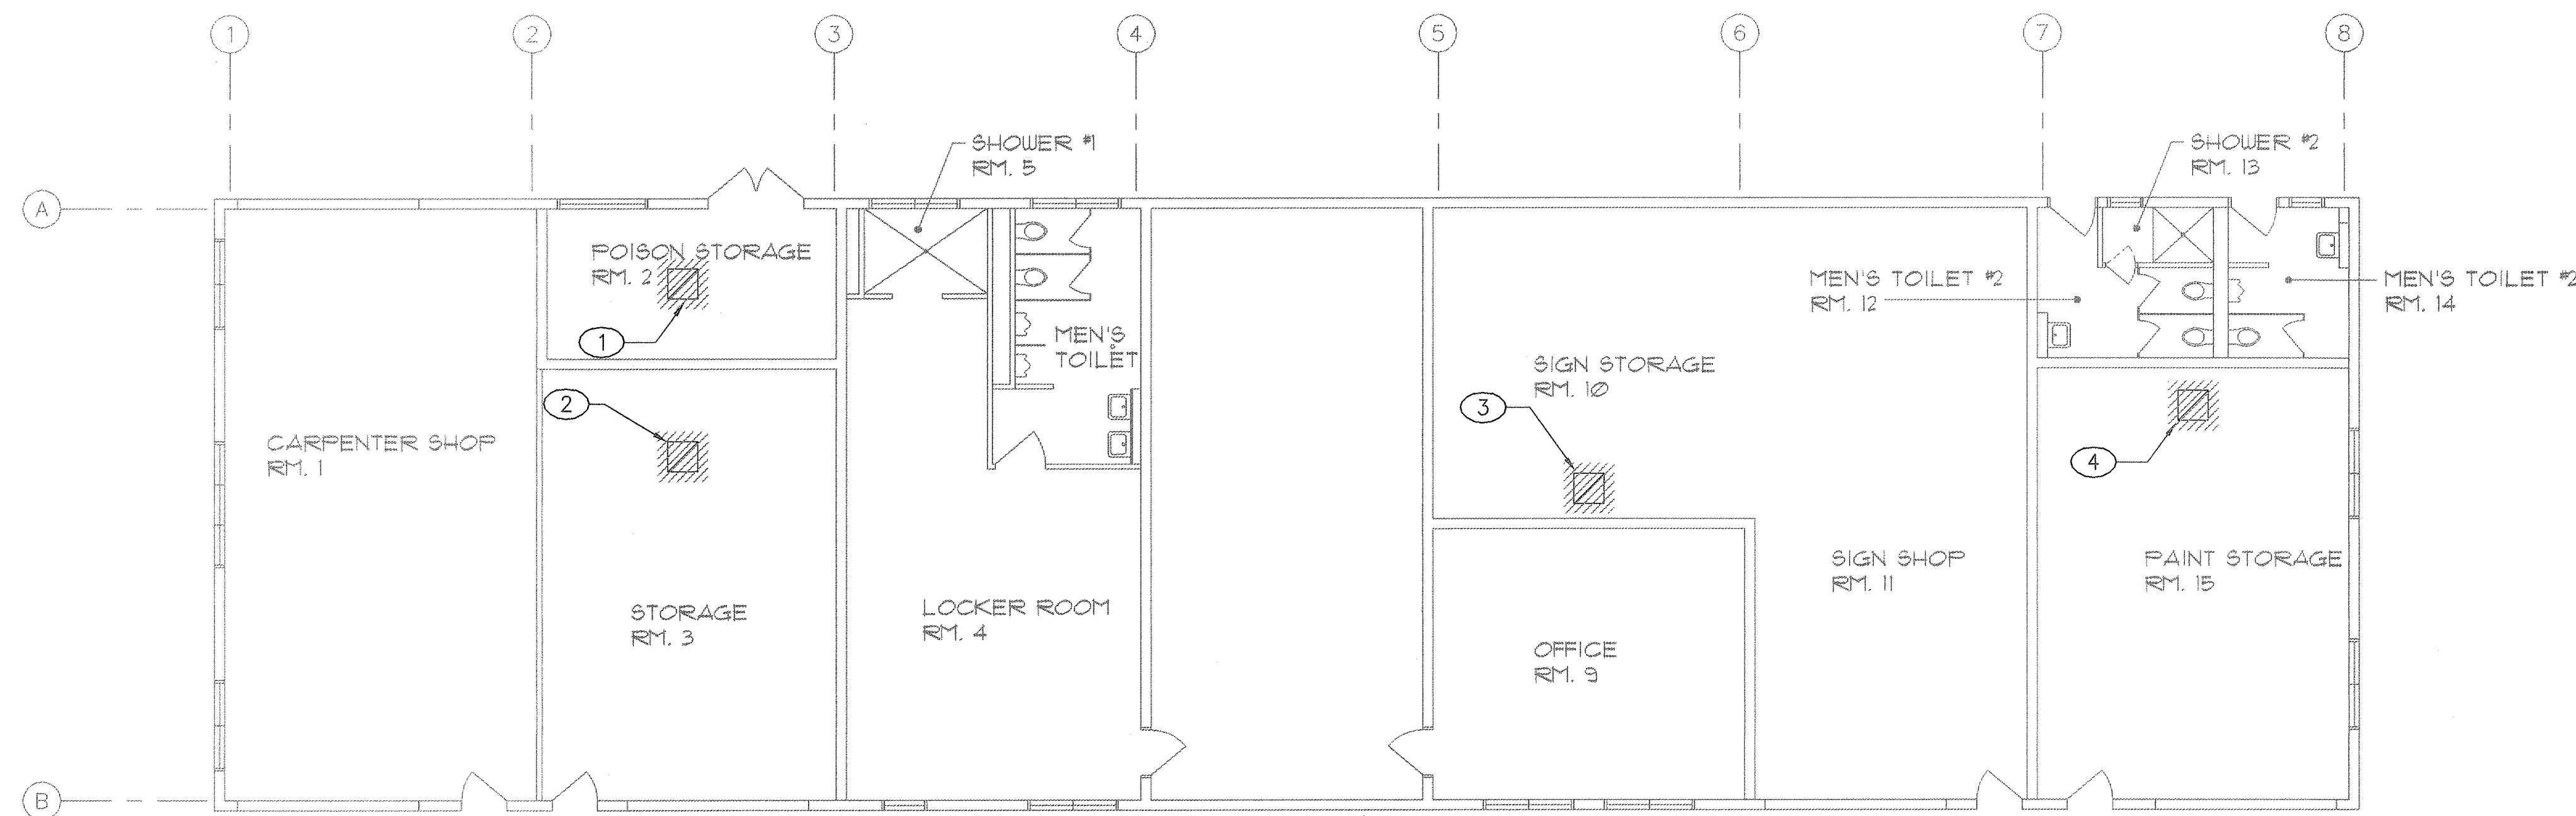


DEMOLITION KEY NOTES:

- ① REMOVE EXISTING EXHAUST FAN EF-1. INCLUDING BACKDRAFT DAMPER, 16x16 REGISTER AND ROOF CURB.
- ② REMOVE EXISTING EXHAUST FAN EF-2. INCLUDING BACKDRAFT DAMPER, 18x18 REGISTER AND ROOF CURB.
- ③ REMOVE EXISTING EXHAUST FAN EF-3. INCLUDING BACKDRAFT DAMPER, 18x18 REGISTER AND ROOF CURB.
- ④ REMOVE EXISTING EXHAUST FAN EF-4. INCLUDING BACKDRAFT DAMPER, 18x18 REGISTER AND ROOF CURB.


1 EXISTING MAINTENANCE OFFICE AND SHOP BLDG MECHANICAL DEMOLITION FLOOR PLAN

SCALE: 1/8"=1'-0"

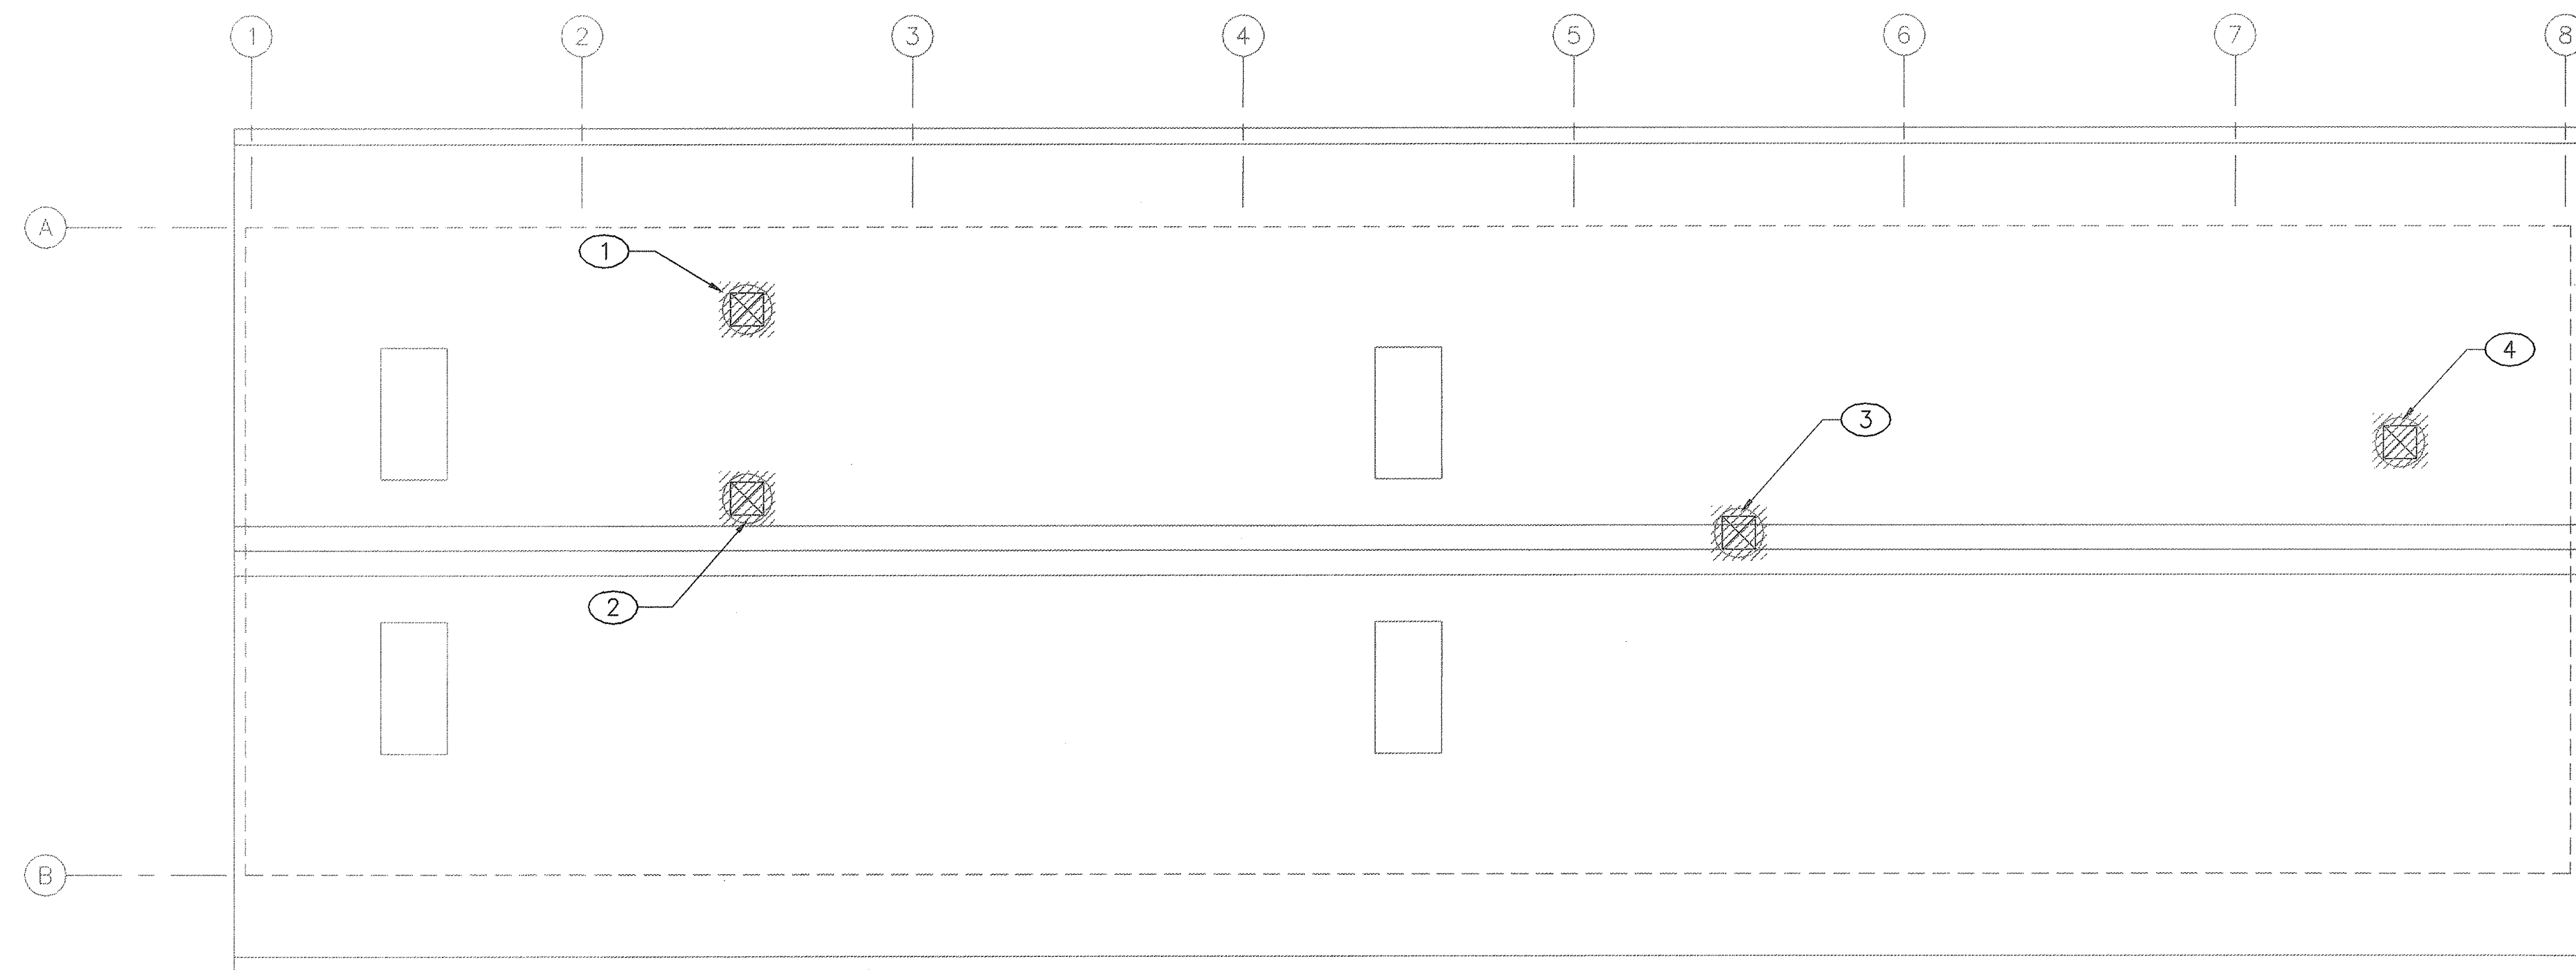

2 EXISTING MAINTENANCE OFFICE AND SHOP BLDG MECHANICAL DEMOLITION ROOF PLAN

SCALE: 1/8"=1'-0"

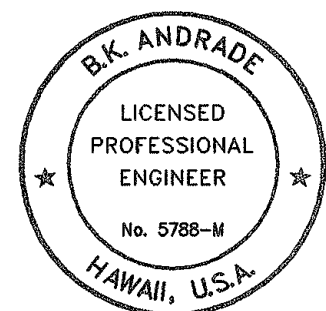


THIS WORK WAS PREPARED BY
ME OR UNDER MY SUPERVISION.
B.K. Andrade
Signature

STATE OF HAWAII
DEPARTMENT OF TRANSPORTATION
HIGHWAYS DIVISION
EXISTING MAINTENANCE OFFICE & SHOP BLDG
MECHANICAL DEMOLITION PLANS
MAUI DISTRICT BASEYARD
REPAIR AND MAINTENANCE OF
BUILDINGS AND GROUNDS, PHASE 3
PROJECT NO. HWY-M-08-04M

SCALE: AS SHOWN DATE: MAY 2005
SHEET No. M-2 OF 5 SHEETS

FED. ROAD DIST. NO.	STATE	PROJ. NO.	FISCAL YEAR	SHEET NO.	TOTAL SHEETS
HAWAII	HAW.	HWY-M-08-04M	2005	14	26

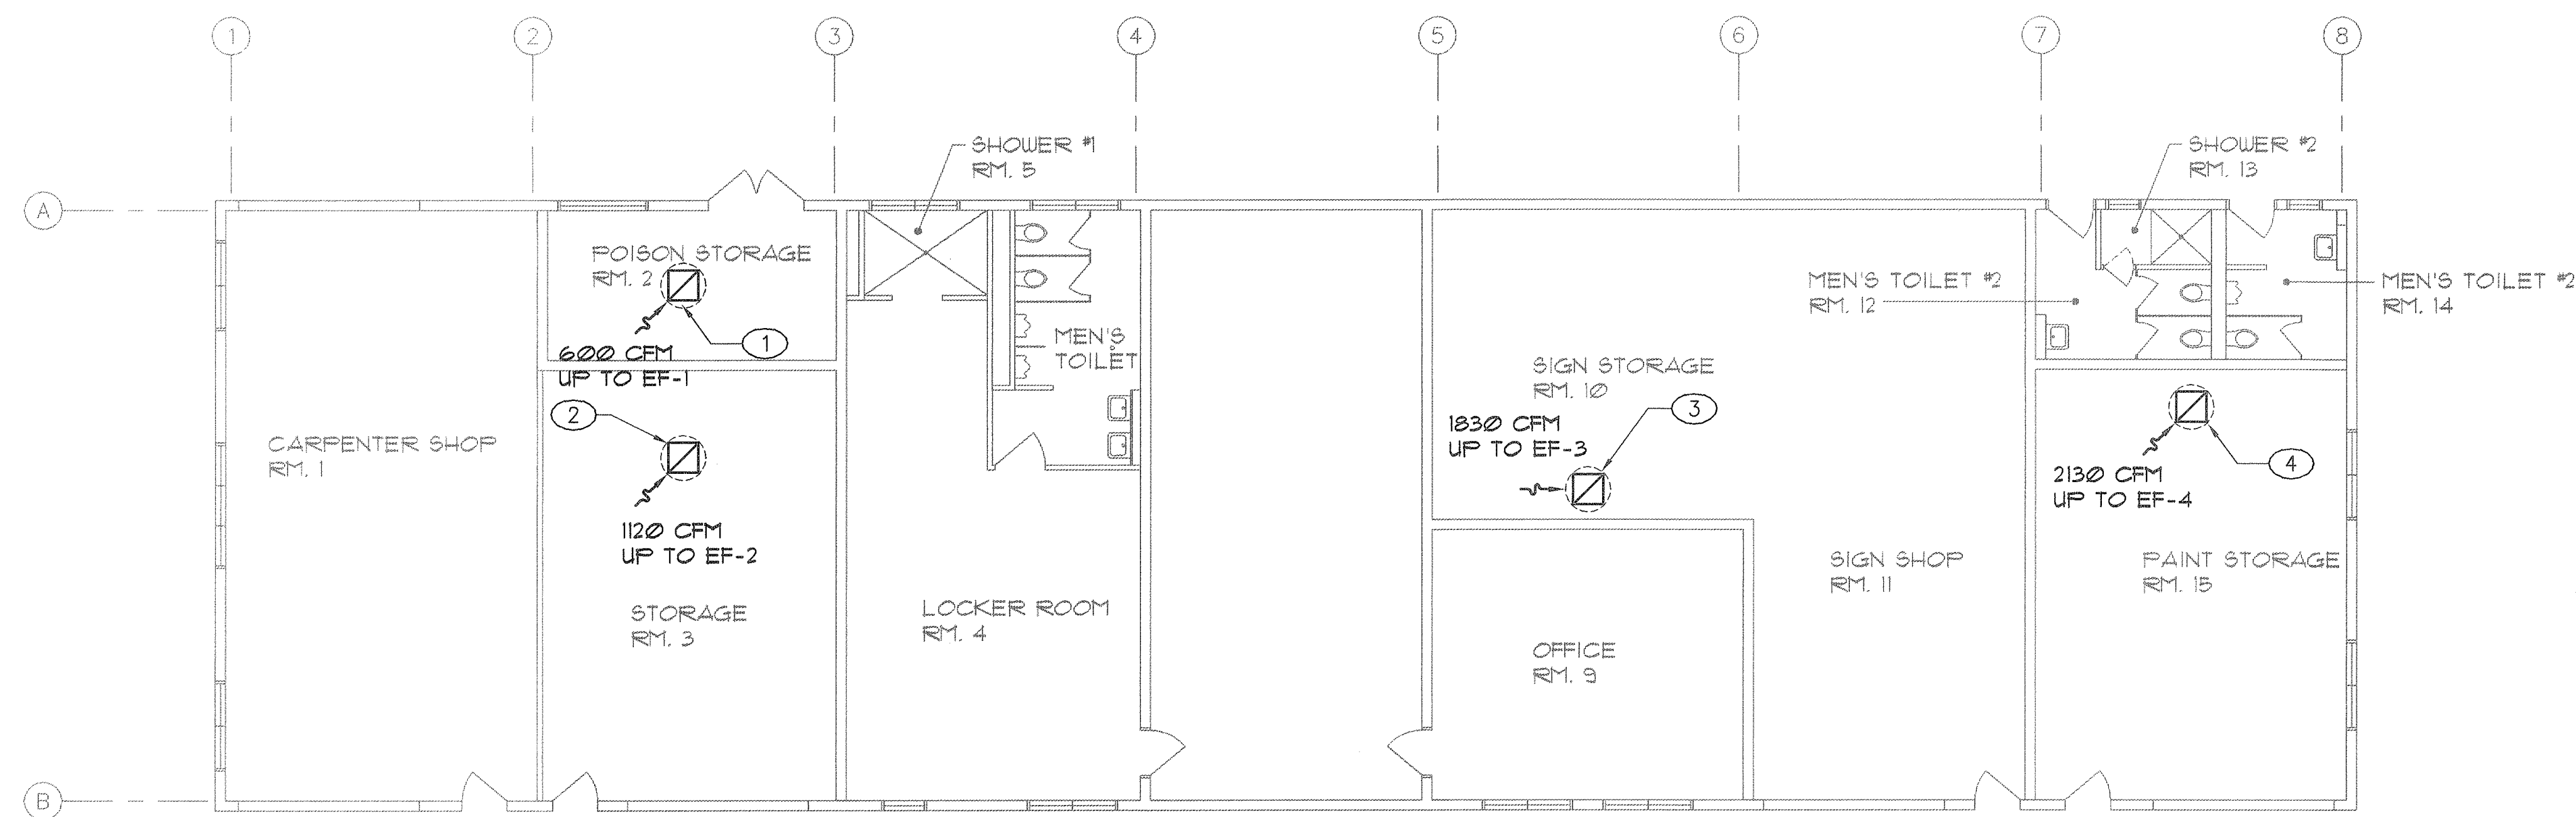


NEW WORK KEY NOTES:

- ① INSTALL NEW EXHAUST FAN EF-1. EXPLOSION PROOF. IN EXISTING LOCATION, PROVIDE NEW 16x16 REGISTER, BACKDRAFT DAMPER AND ROOF CURB.
- ② INSTALL NEW EXHAUST FAN EF-2. IN EXISTING LOCATION, PROVIDE NEW 18x18 REGISTER, BACKDRAFT DAMPER AND ROOF CURB.
- ③ INSTALL NEW EXHAUST FAN EF-3. IN EXISTING LOCATION, PROVIDE NEW 18x18 REGISTER, BACKDRAFT DAMPER AND ROOF CURB.
- ④ INSTALL NEW EXHAUST FAN EF-4. EXPLOSION PROOF. IN EXISTING LOCATION, PROVIDE NEW 18x18 REGISTER, BACKDRAFT DAMPER AND ROOF CURB.

1 EXISTING MAINTENANCE OFFICE AND SHOP BLDG MECHANICAL FLOOR PLAN

8' 4' 0' 4' 8' 16' 32'


SCALE: 1/8"=1'-0"

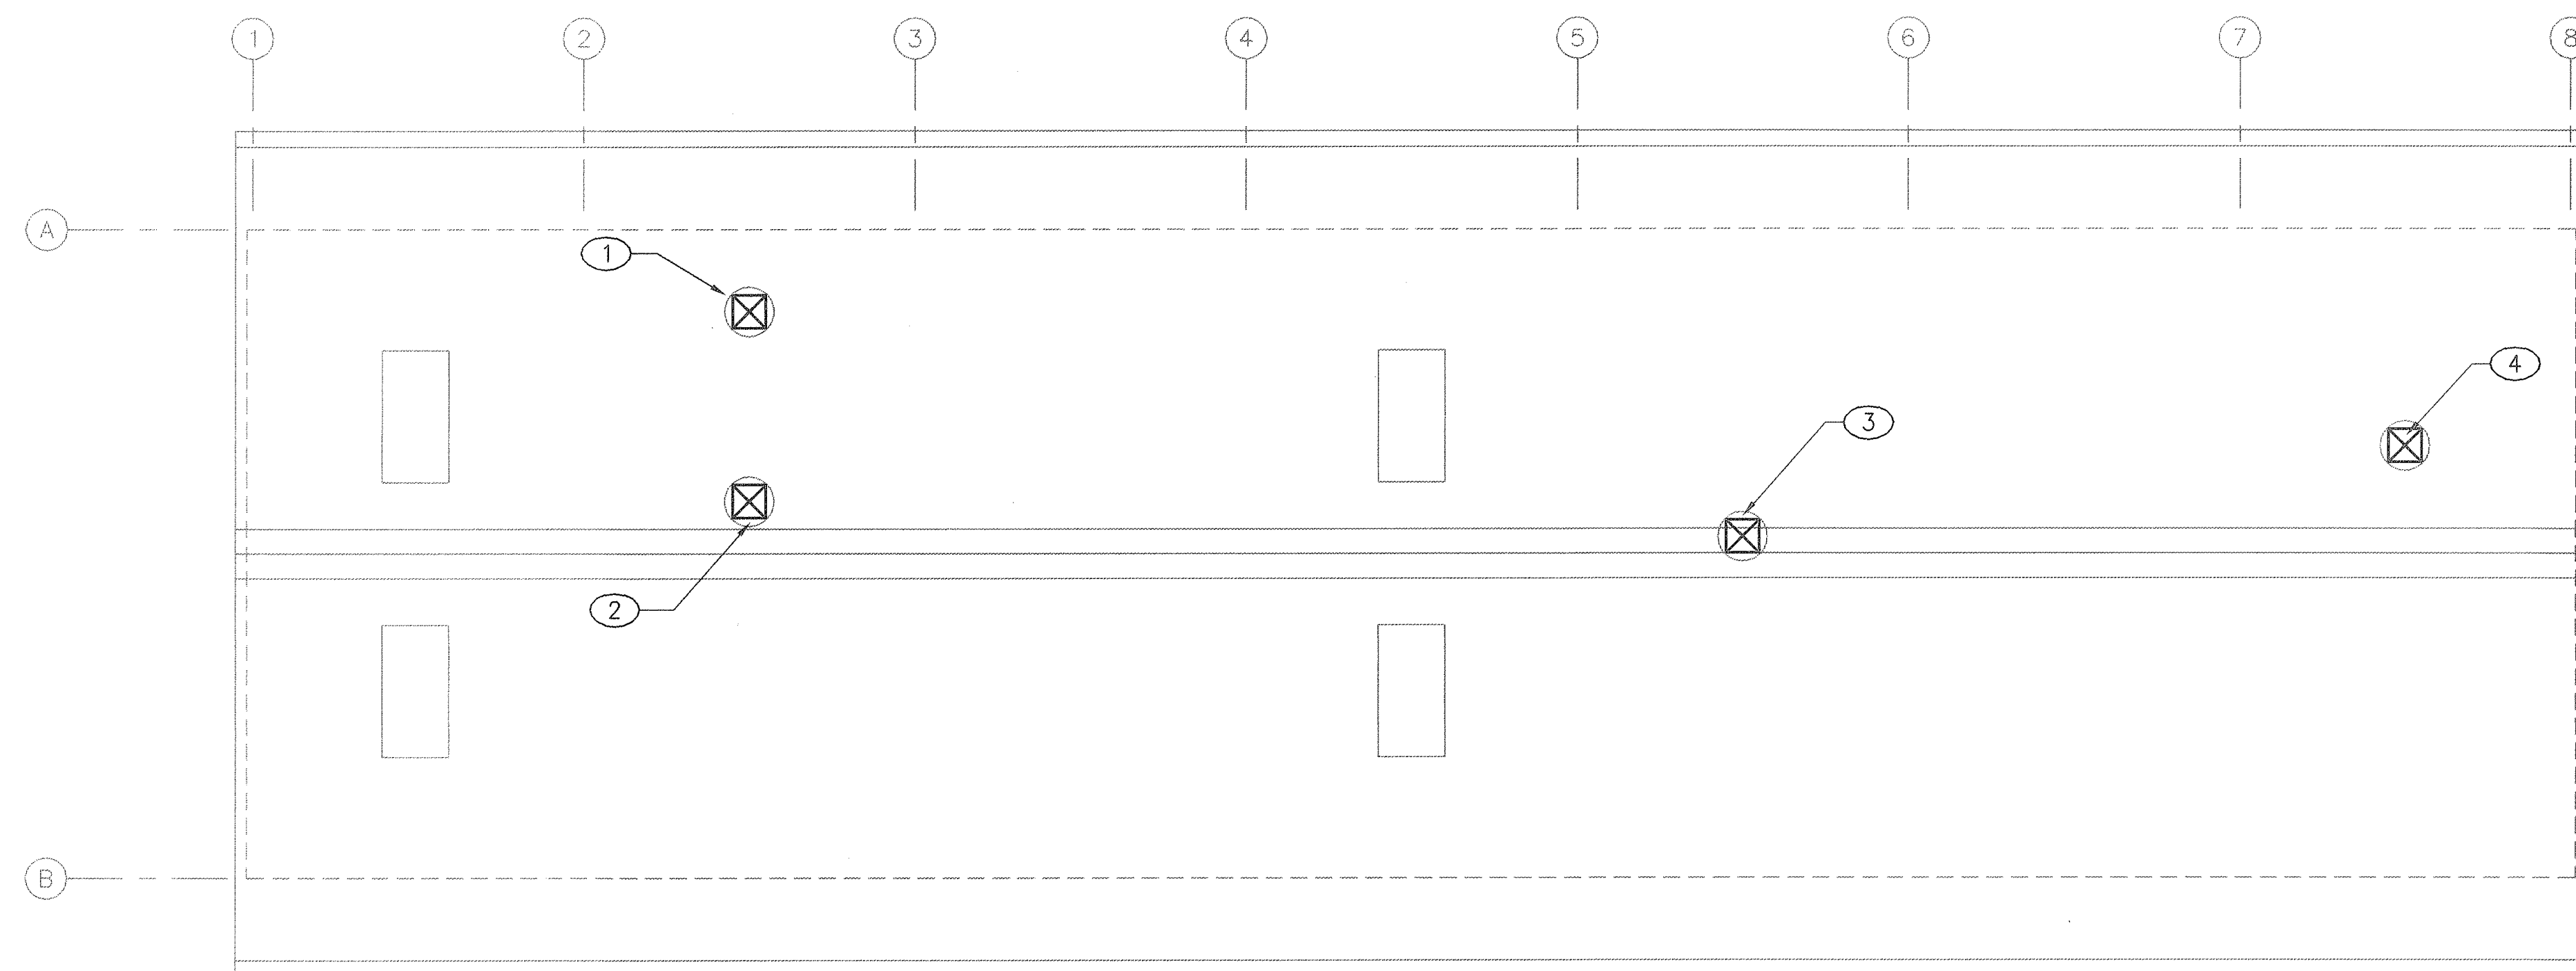

2 EXISTING MAINTENANCE OFFICE AND SHOP BLDG MECHANICAL ROOF PLAN

8' 4' 0' 4' 8' 16' 32'

SCALE: 1/8"=1'-0"

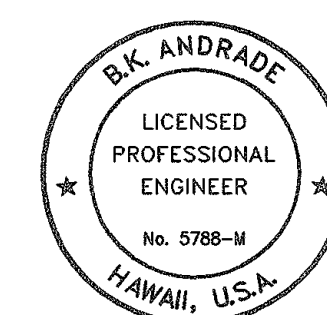

THIS WORK WAS PREPARED BY
ME OR UNDER MY SUPERVISION.
B.K. Andrade 5-5-05
Signature

STATE OF HAWAII
DEPARTMENT OF TRANSPORTATION
HIGHWAYS DIVISION
EXISTING MAINTENANCE OFFICE & SHOP BLDG
MECHANICAL FLOOR AND ROOF PLANS
MAUI DISTRICT BASEYARD
REPAIR AND MAINTENANCE OF
BUILDINGS AND GROUNDS, PHASE 3
PROJECT NO. HWY-M-08-04M

SCALE: AS SHOWN DATE: MAY 2005
SHEET No. M-3 OF 5 SHEETS