


FED. ROAD DIST. NO.	STATE	PROJ. NO.	FISCAL YEAR	SHEET NO.	TOTAL SHEETS
HAWAII	HAW.	HWY-M-08-04M	2005	22	26

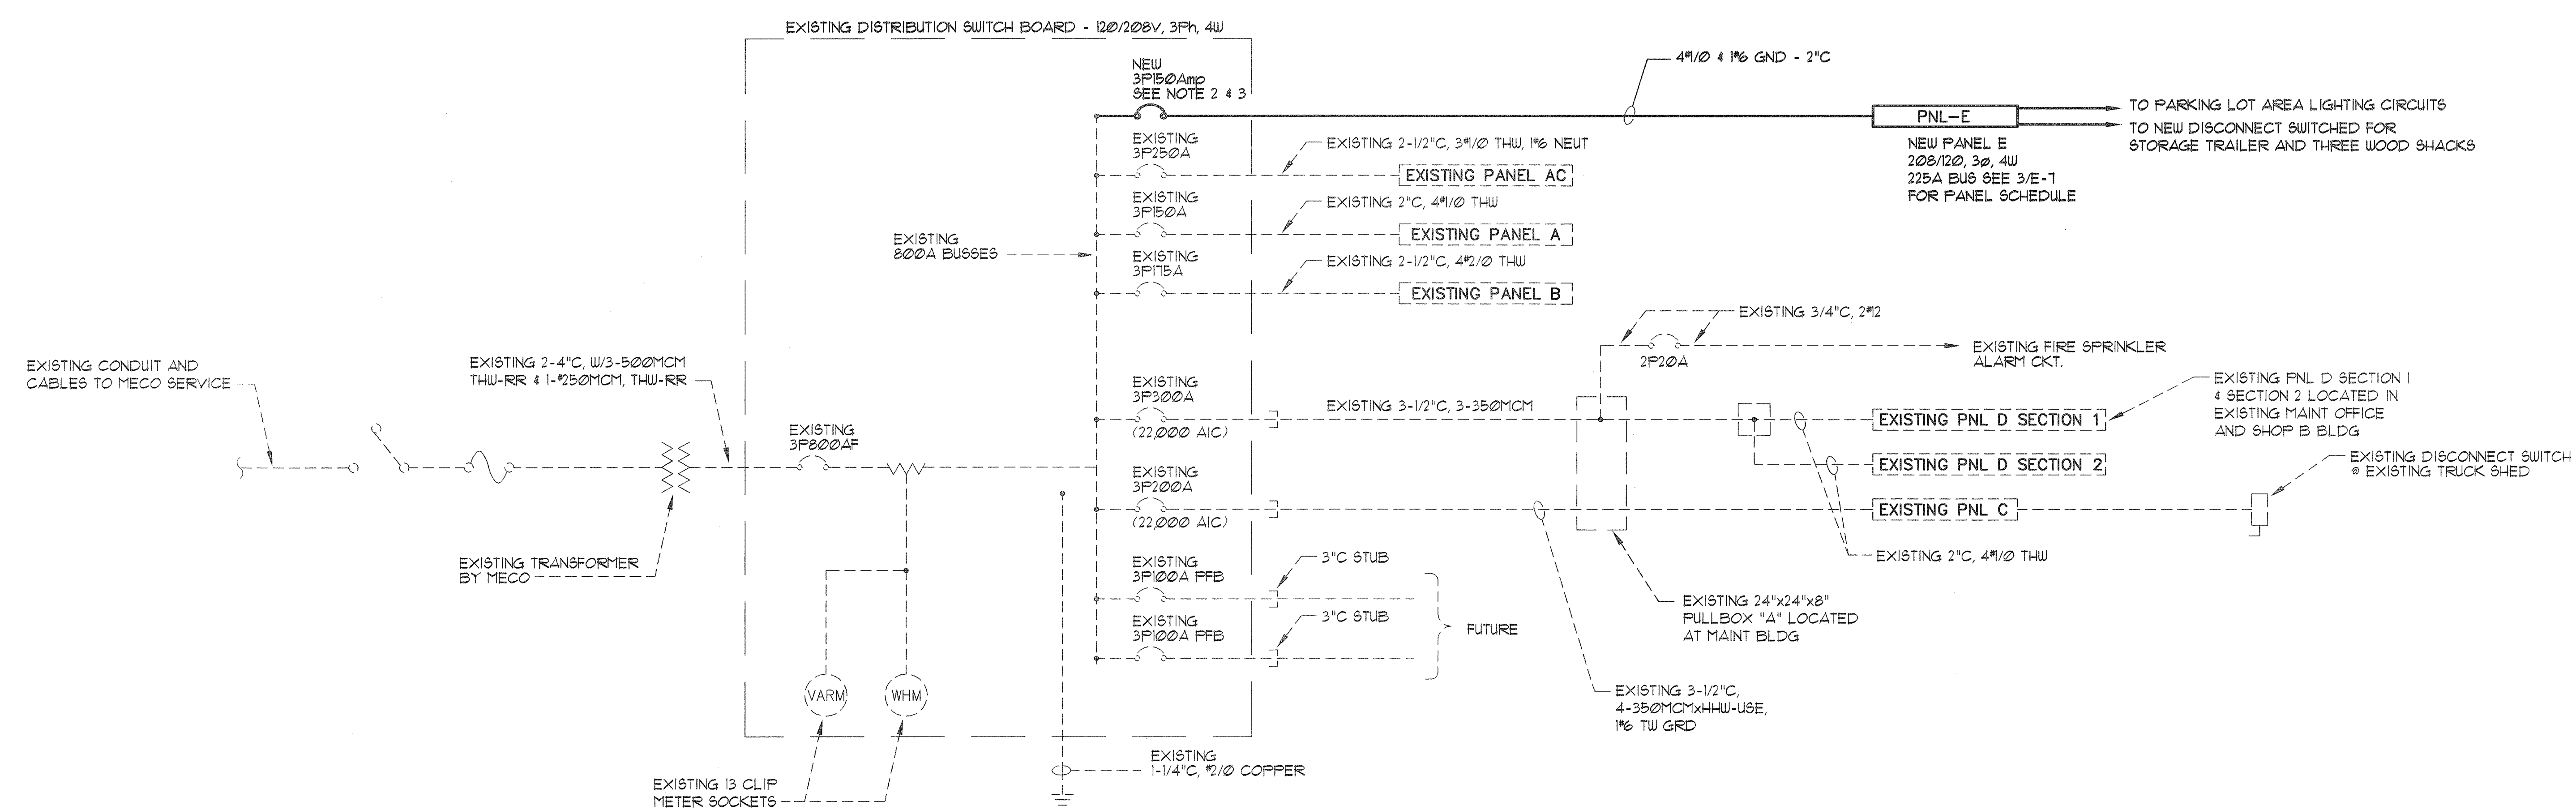

NOTES:

- EXISTING SINGLE LINE DIAGRAM WAS TAKEN FROM THE BEST AVAILABLE AS-BUILT DRAWINGS. CONTRACTOR TO VERIFY ACTUAL CONDITIONS AND TO NOTIFY CONTRACTING OFFICER OF ANY DISCREPANCIES.
- ELECTRICAL CONTRACTOR SHALL PROVIDE AND INSTALL NEW 3P-150 AMP CIRCUIT BREAKER IN THE EXISTING SPACE AT EXISTING DISTRIBUTION SWITCH BOARD
- NEW CIRCUIT BREAKER SHALL HAVE A SHORT CIRCUIT RATING NOT LESS THAN THE EXISTING.

1

MODIFICATION OF EXISTING SINGLE LINE DIAGRAM  
NOT TO SCALE  
E-6

MUNIR M. ARMANIOUS  
LICENSED PROFESSIONAL ENGINEER  
No. 11213  
HAWAII, U.S.A.

THIS WORK WAS PREPARED BY ME OR UNDER MY SUPERVISION.  
Signature

STATE OF HAWAII  
DEPARTMENT OF TRANSPORTATION  
HIGHWAYS DIVISION  
  
MODIFICATION OF EXISTING SINGLE LINE DIAGRAM  
  
MAUI DISTRICT BASEYARD  
REPAIR AND MAINTENANCE OF BUILDINGS AND GROUNDS, PHASE 3  
PROJECT NO. HWY-M-08-04M  
  
SCALE: AS SHOWN      DATE: MAY 2005  
SHEET No. E-6 OF 20 SHEETS

Job No. H610/01

Final Submittal

05/02/05 13:48

H610E231.DWG