

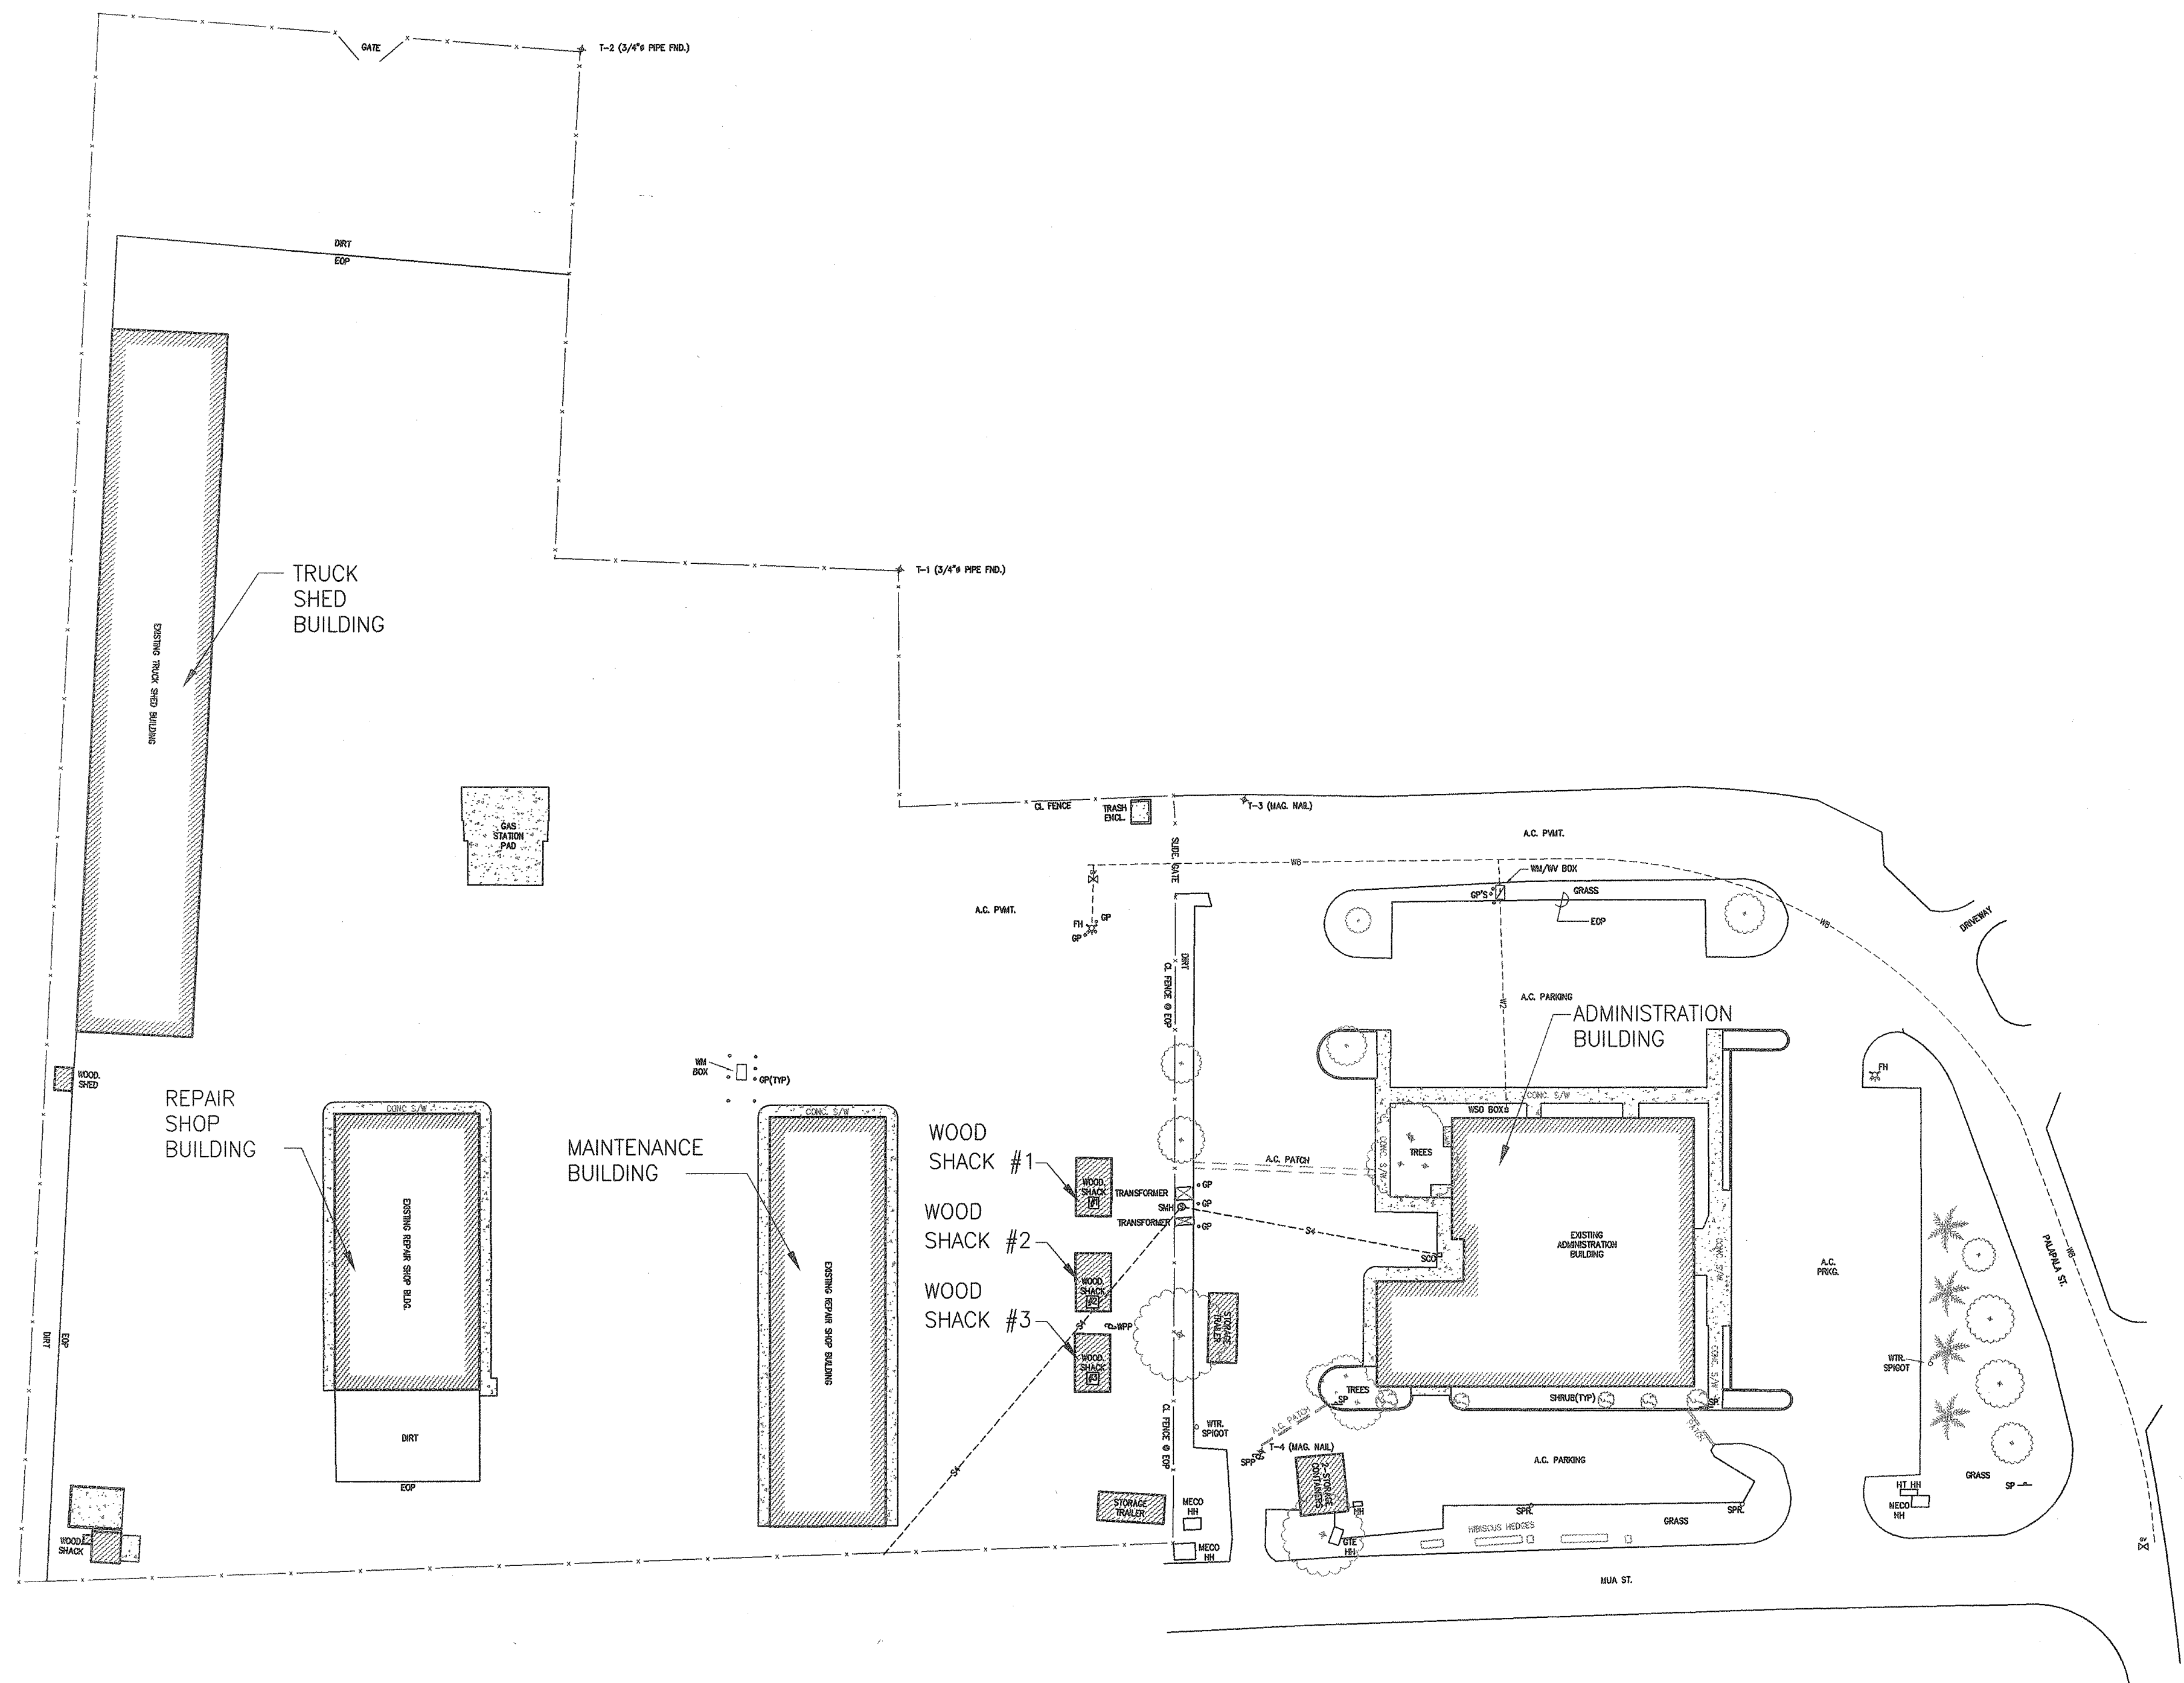


FED. ROAD DIST. NO.	STATE	PROJ. NO.	FISCAL YEAR	SHEET NO.	TOTAL SHEETS
HAWAII	HAW.	HWY-M-08-04M	2005	2	26

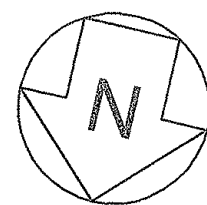

PROJECT ORIENTATION

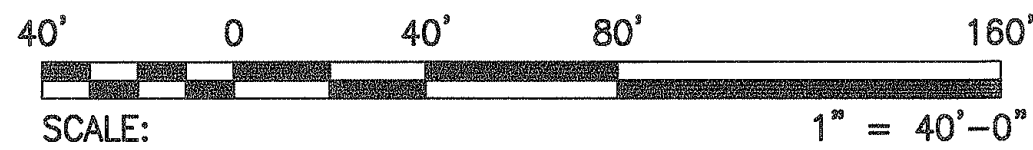

1. WORK AT EXISTING ADMINISTRATION BUILDING

- RE-TILE FLOOR AND WALLS OF THE MEN'S AND WOMEN'S RESTROOMS; REMOVE AND REPLACE PLUMBING FIXTURES, AND TOILET PARTITIONS; AND REPAINT.
- RE-TILE UNISEX RESTROOM.
- PROVIDE AND INSTALL EIGHT (8) CAD WORKSTATIONS, INCLUDING BUT NOT LIMITED TO PARTITIONS, WORK SURFACES, ACCESSORIES, AND ELECTRICAL FEEDERS FOR RECEPTACLES.
- REMOVE EXISTING CABINETS AND COUNTERS IN ROOM 116 AND REPAINT AS INDICATED.
- REPLACE EXISTING RECEPTACLES WITH GFI RECEPTACLES AS INDICATED.
- REMOVE AND REPLACE EXISTING ROOF PANELS, GUTTERS, FLASHING, AND ROOF INSULATION.
- PROVIDE EXTERIOR LIGHTING AS INDICATED.
- REMOVE AND REPLACE EXISTING ACOUSTIC CEILING TILES AND CEILING GRID.
- REMOVE AND REPLACE EXISTING LIGHTING FIXTURES.

2. WORK AT EXISTING TRUCK SHED BUILDING

- REMOVE AND REPLACE METAL SIDING PANELS AS INDICATED.
- INSPECT, REMOVE, AND REPLACE MISSING OR DAMAGED STRUCTURAL MEMBERS AS INDICATED AND REQUIRED.
- REMOVE AND REPLACE METAL ROOFING AS INDICATED.

3. WORK AT EXISTING MAINTENANCE BUILDING


- REMOVE EXISTING GUTTERS AND DOWNSPOUTS, AND INSTALL NEW GUTTERS AND DOWNSPOUTS PROVIDED BY THE STATE.
- REMOVE AND REPLACE EXISTING POWERED ROOF VENTILATORS AS INDICATED.

4. WORK AT EXISTING REPAIR SHOP BUILDING

- PROVIDE CONTINUOUS RIDGE VENTILATOR AS INDICATED.
- REMOVE AND REPLACE EXISTING POWERED ROOF VENTILATORS AS INDICATED.
- PROVIDE DOOR, LOUVERED WINDOW, AND POWERED ROOF VENTILATOR AT EXISTING OIL STORAGE ROOM.

5. OTHER WORK

- ELECTRICAL WORK TO REPLACE ELECTRIC POWER FEEDERS TO THREE (3) EXISTING WOOD SHACKS AND ONE (1) EXISTING STORAGE TRAILER.
- OTHER WORK AS INDICATED ON PLANS AND/OR SPECIFIED.

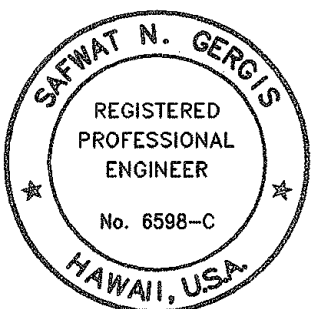

THIS WORK WAS PREPARED BY  
ME OR UNDER MY SUPERVISION.

*[Signature]*  
Signature

STATE OF HAWAII  
DEPARTMENT OF TRANSPORTATION  
HIGHWAYS DIVISION

PROJECT ORIENTATION PLAN

MAUI DISTRICT BASEYARD  
REPAIR AND MAINTENANCE OF  
BUILDINGS AND GROUNDS, PHASE 3  
PROJECT NO. HWY-M-08-04M

SCALE: AS SHOWN DATE: MAY 2005

SHEET No. G-2 OF 2 SHEETS