 










FED. ROAD DIST. NO.	STATE	PROJ. NO.	FISCAL YEAR	SHEET NO.	TOTAL SHEETS
HAWAII	HAW.	HWY-M-06-06M	2010	17	18

 
ELECTRICAL SYMBOLS

-  existing ceiling luminaire to be removed
-  New Ceiling Luminaire
-  New Switch, 4-0"
-  existing panelboard
-  existing junction box to be removed
-  existing junction box to remain
-  existing equipment connection
-  New Junction Box
- EP Explosionproof
- WP Weatherproof
- wiring in existing raceway to be removed
- *-x-* wiring in existing raceway to be removed
- New Wiring in Raceway Concealed in Floor or Below Grade
- New Wiring in Exposed Raceway
- EP— New Wiring in Explosion Proof Raceway


- Notes:**
- Any Circuit With No Further Designation Indicates A Two Wire Circuit. Circuits with Additional Wires are Indicated as Follows: \neq , 3 Wires: $\neq\neq$, 4 Wires, Etc.
 - Ground Wire Per National Electrical Code Indicated as Follows: \leftarrow
 - All Exposed Conduit and Boxes Shall Be Painted to Match Adjacent Wall or Ceiling Surrounding

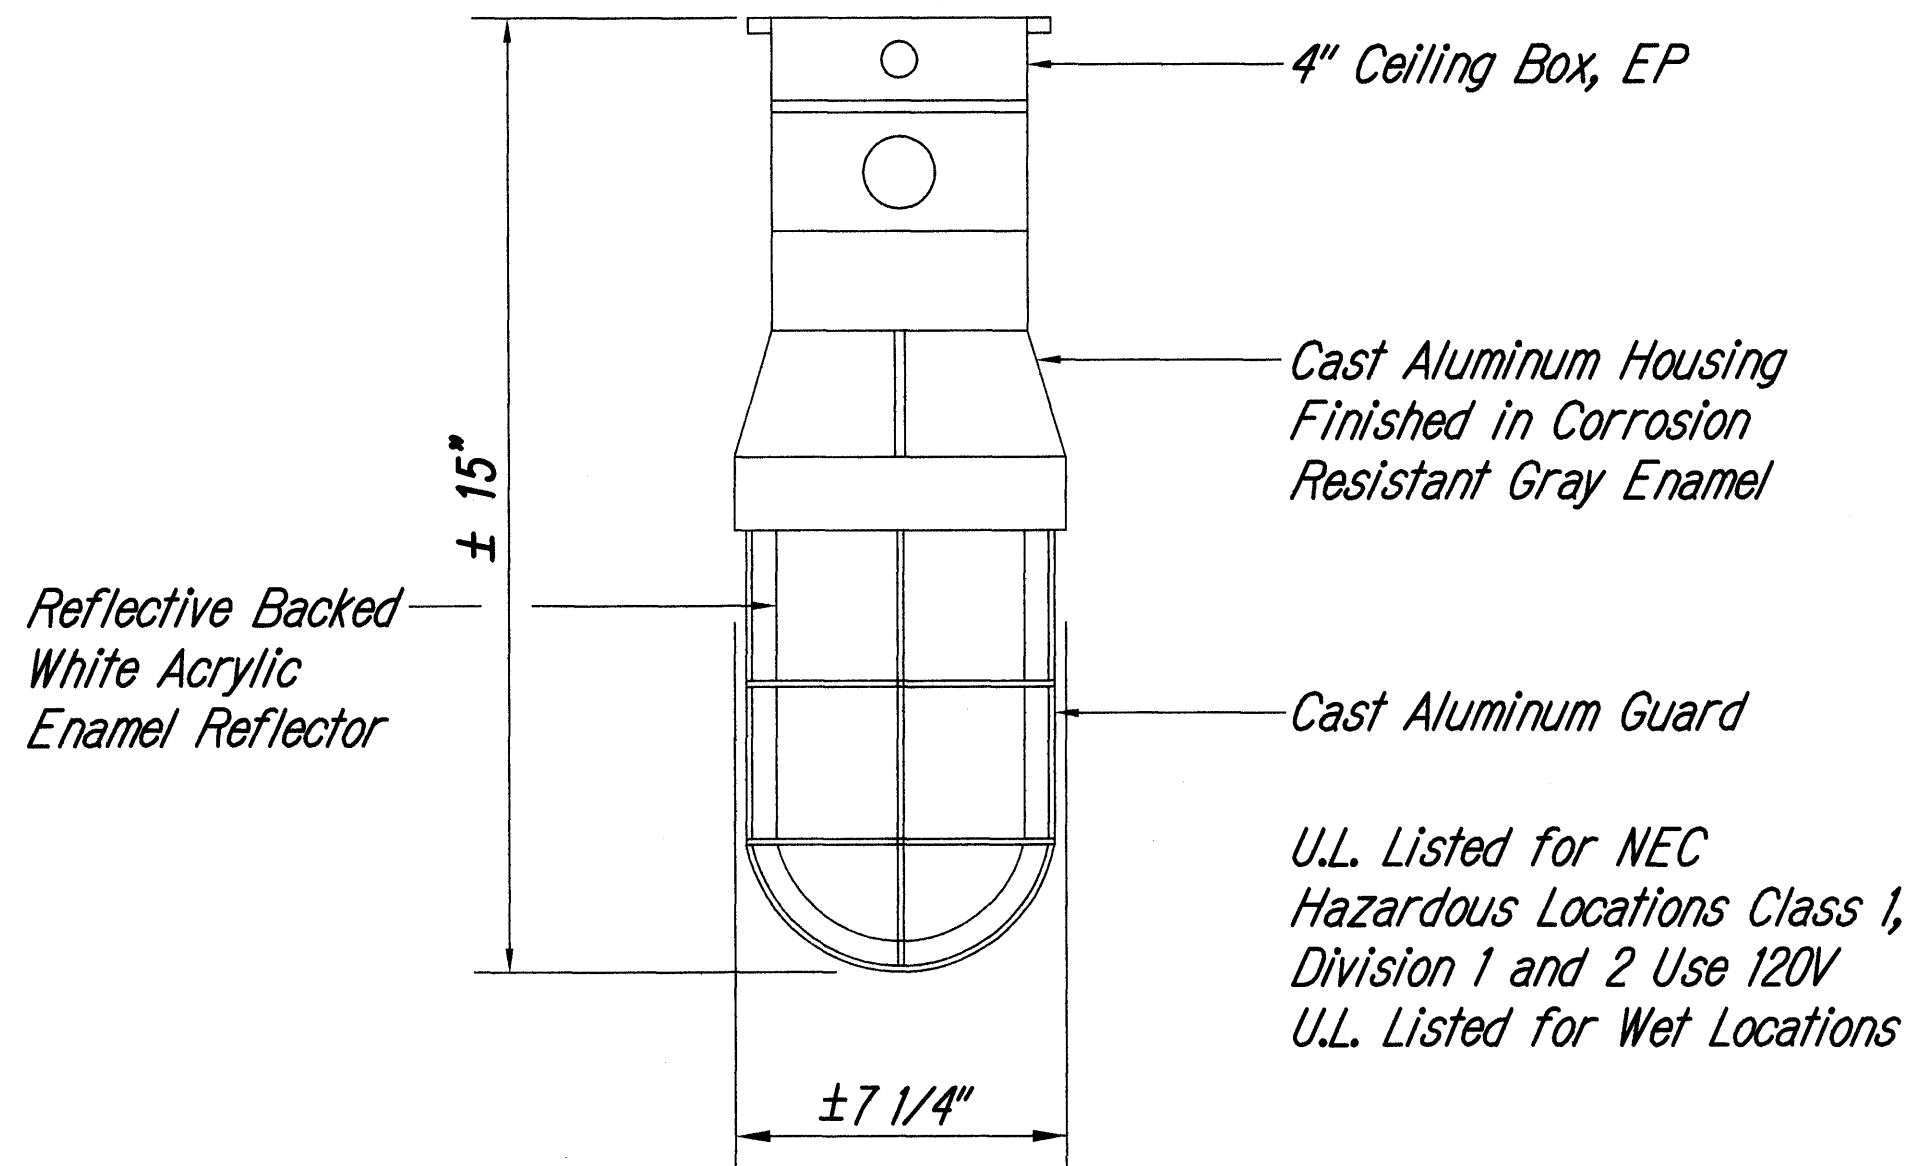


LUMINAIRE TYPE "A"-200W INCANDESCENT LAMP
Not To Scale

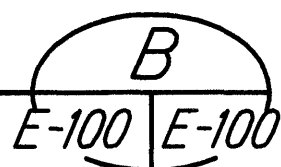

Paia
Hana Highway
Hana

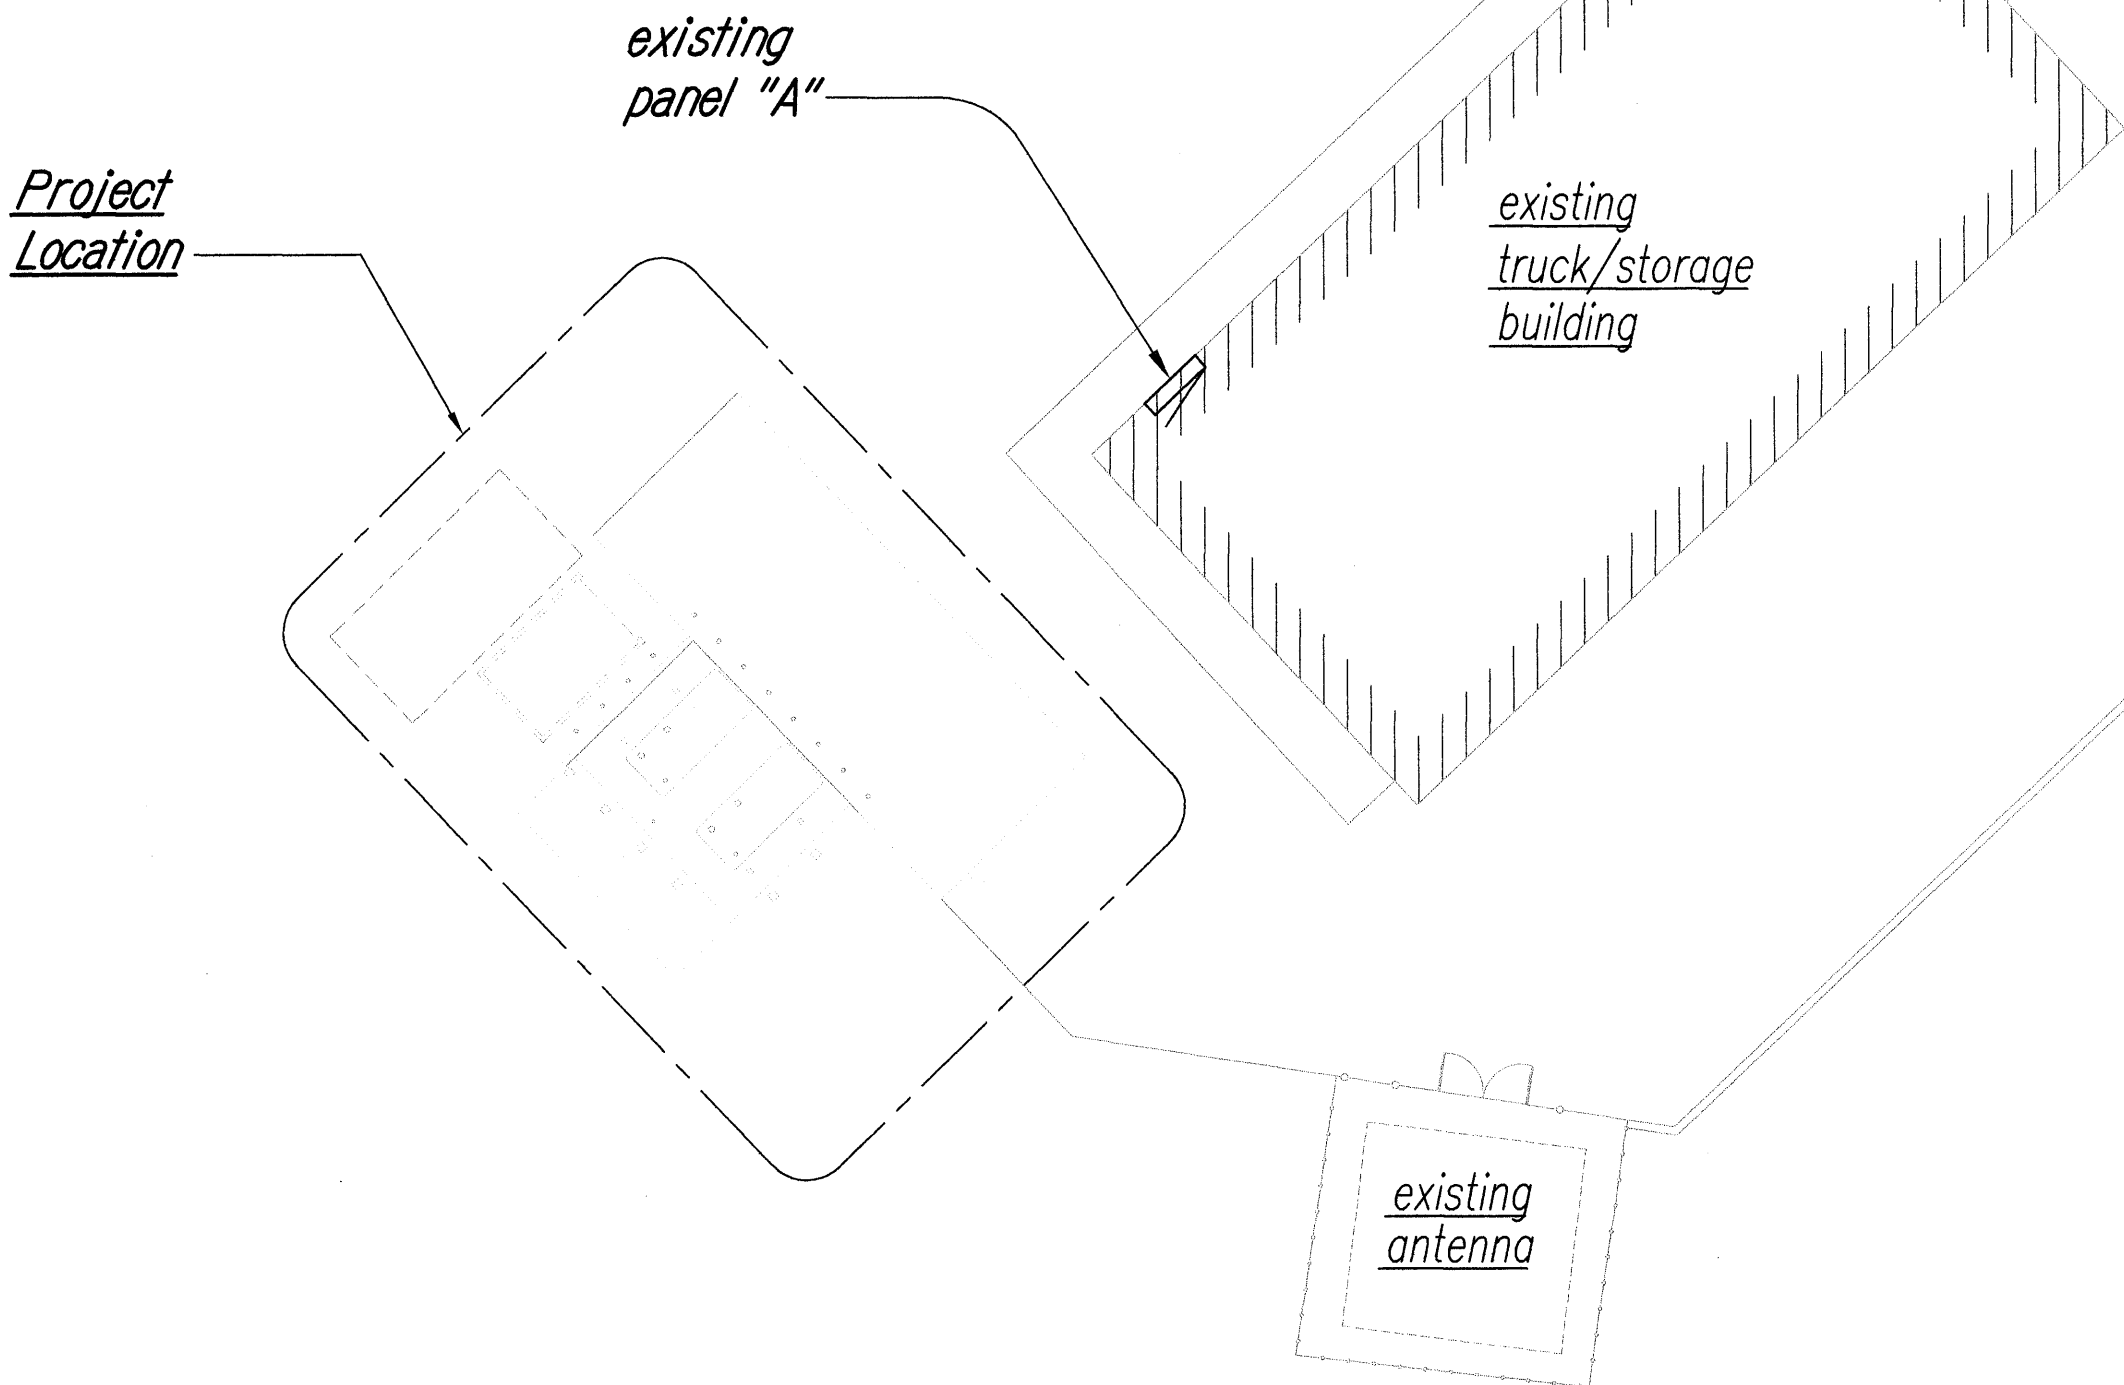

ELECTRICAL SITE PLAN
Scale: 1/8" = 1'-0"

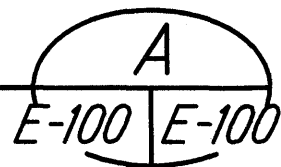

Jason Yogi
EXPIRATION DATE OF THE LICENSE 4/30/2012
THIS WORK WAS PREPARED BY
ME OR UNDER MY SUPERVISION

STATE OF HAWAII
DEPARTMENT OF TRANSPORTATION
HIGHWAYS DIVISION


ELECTRICAL SYMBOLS, LUMINAIRE
DETAIL, ELECTRICAL SITE PLAN
KEANAE BASEYARD
MAINTENANCE and REPAIRS
Project No. HWY-M-06-06M

Scale: AS NOTED
Date: APRIL 2010

SHEET No. E-100 OF 18 SHEETS


ORIGINAL PLAN	SURVEY PLOTTED BY	DATE
NOTE BOOK	DESIGNED BY	12/20/06
	QUANTITIES BY	
	CHECKED BY	
No.		

FED. ROAD DIST. NO.	STATE	PROJ. NO.	FISCAL YEAR	SHEET NO.	TOTAL SHEETS
HAWAII	HAW.	HWY-M-06-06M	2010	18	18

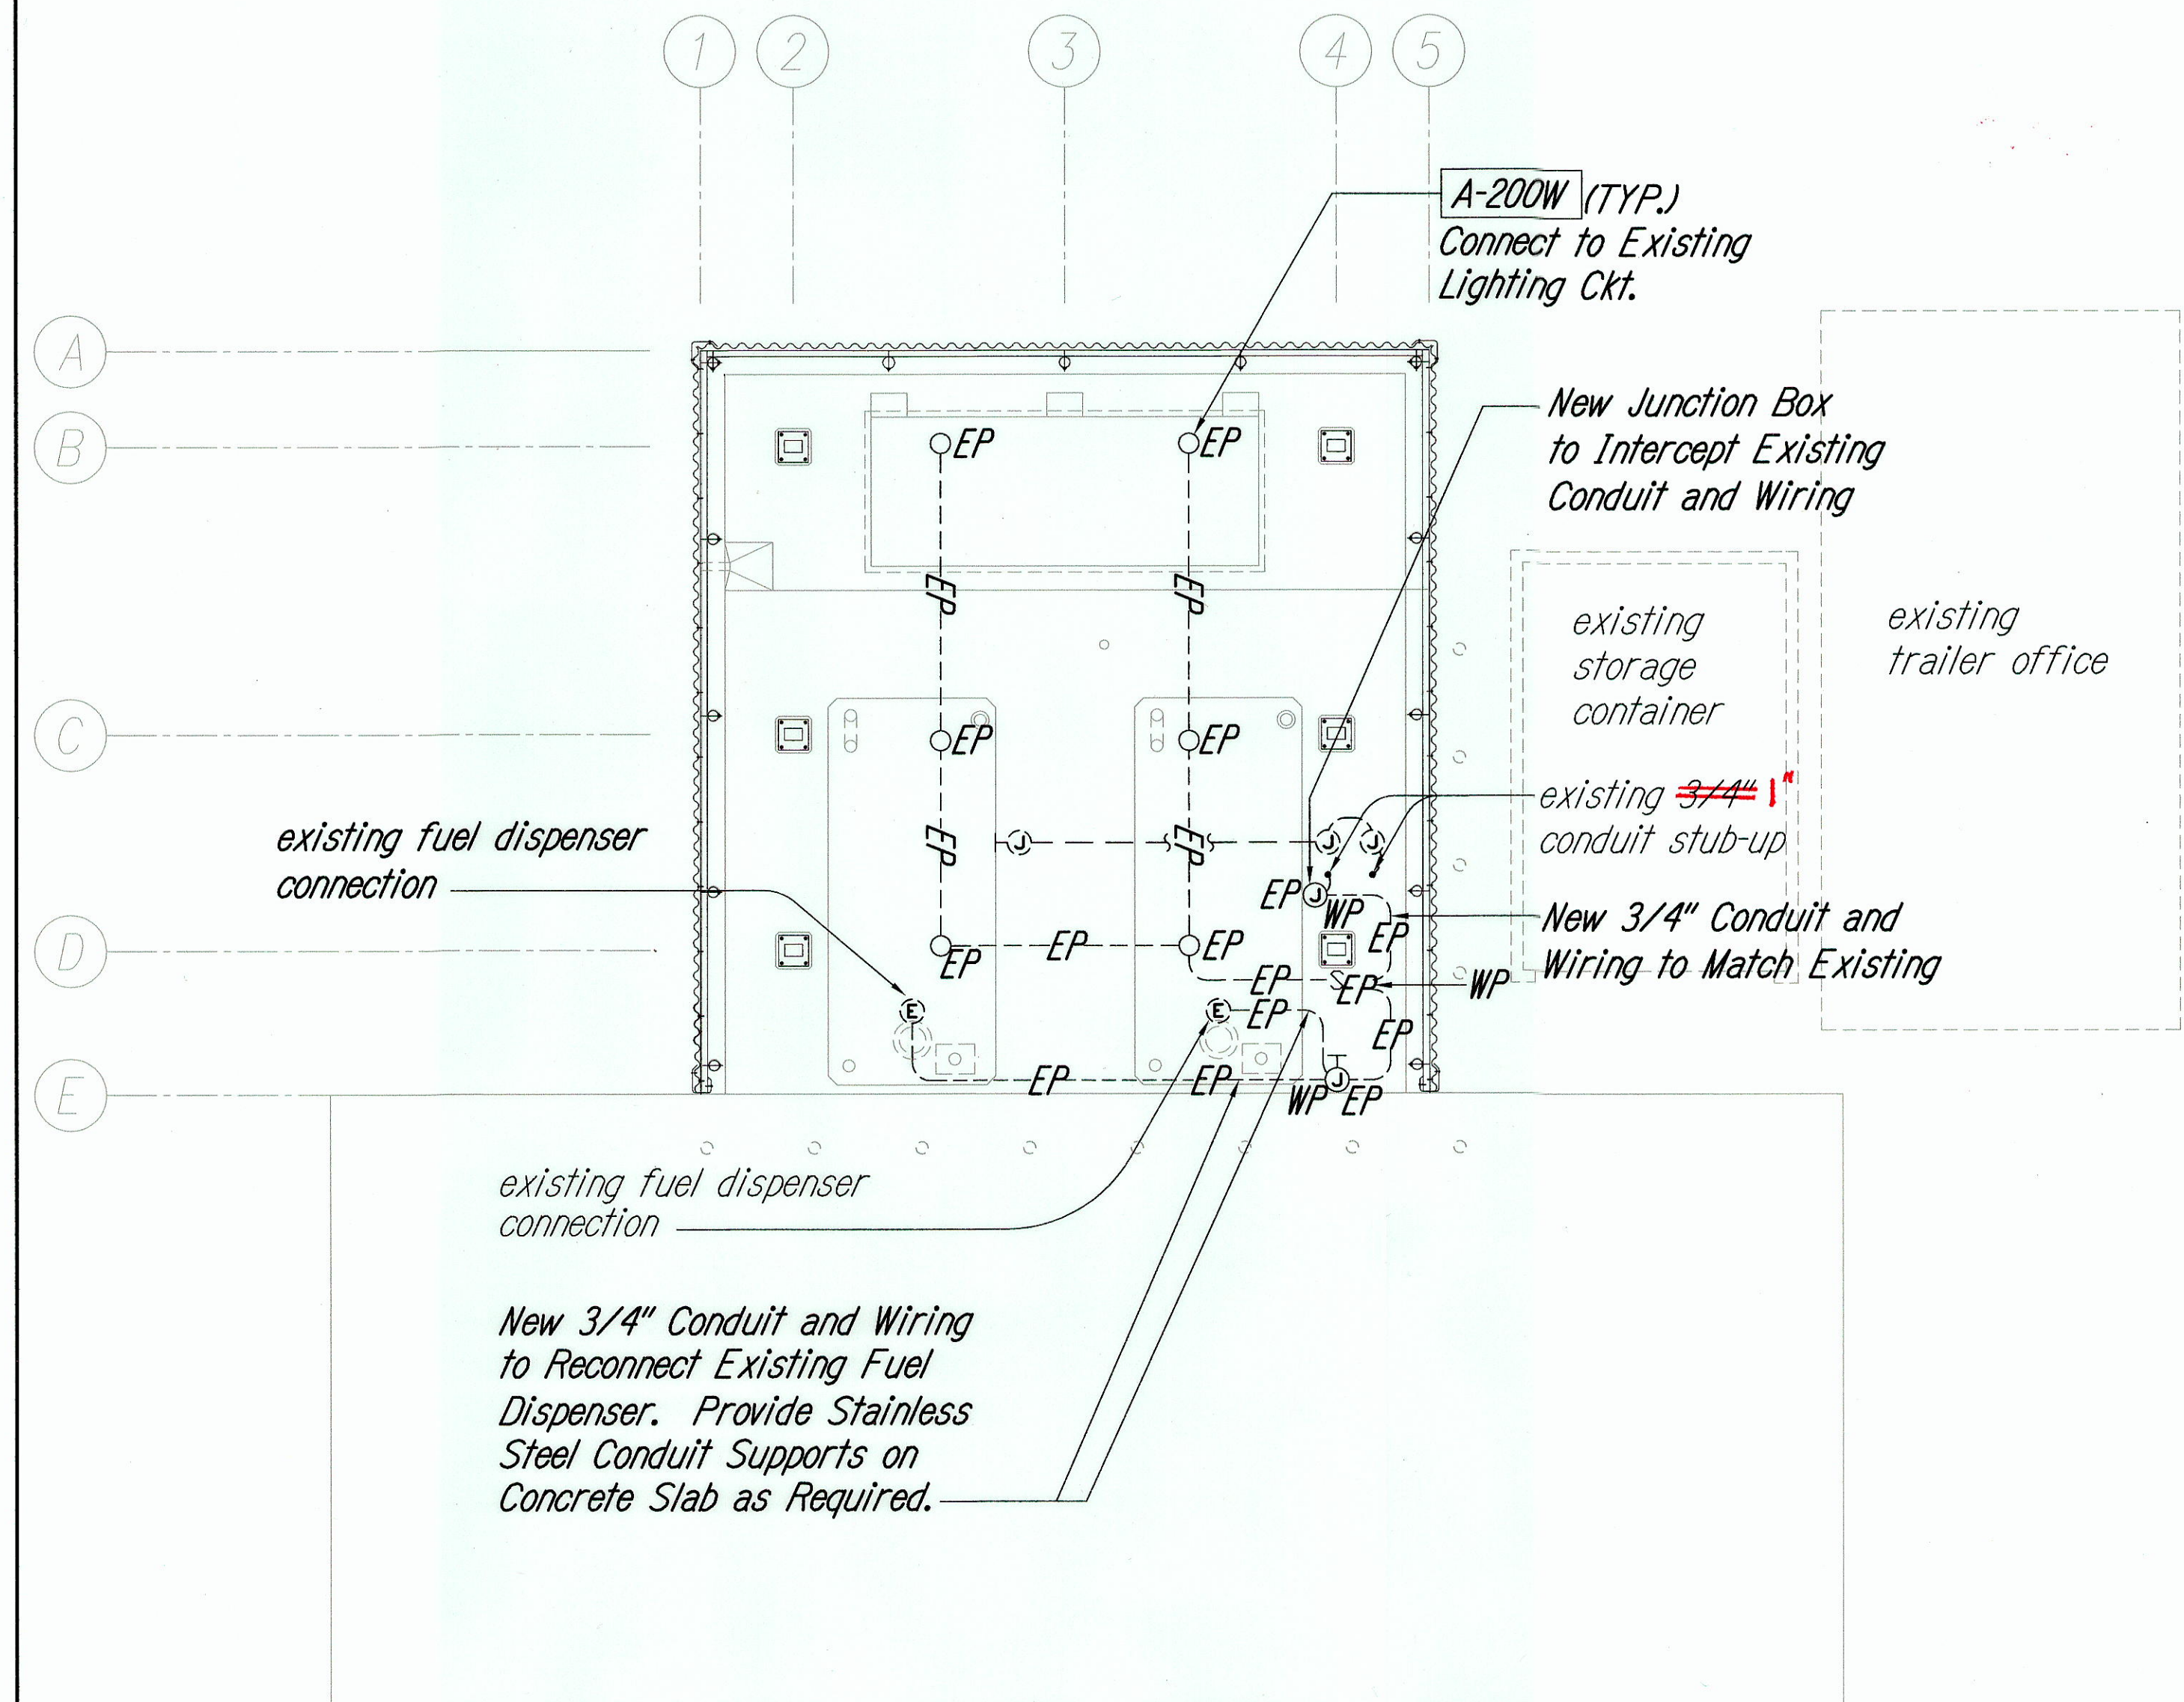

ELECTRICAL PLAN - NEW WORK
Scale: 1/4" = 1'-0"

A
E-101 E-101

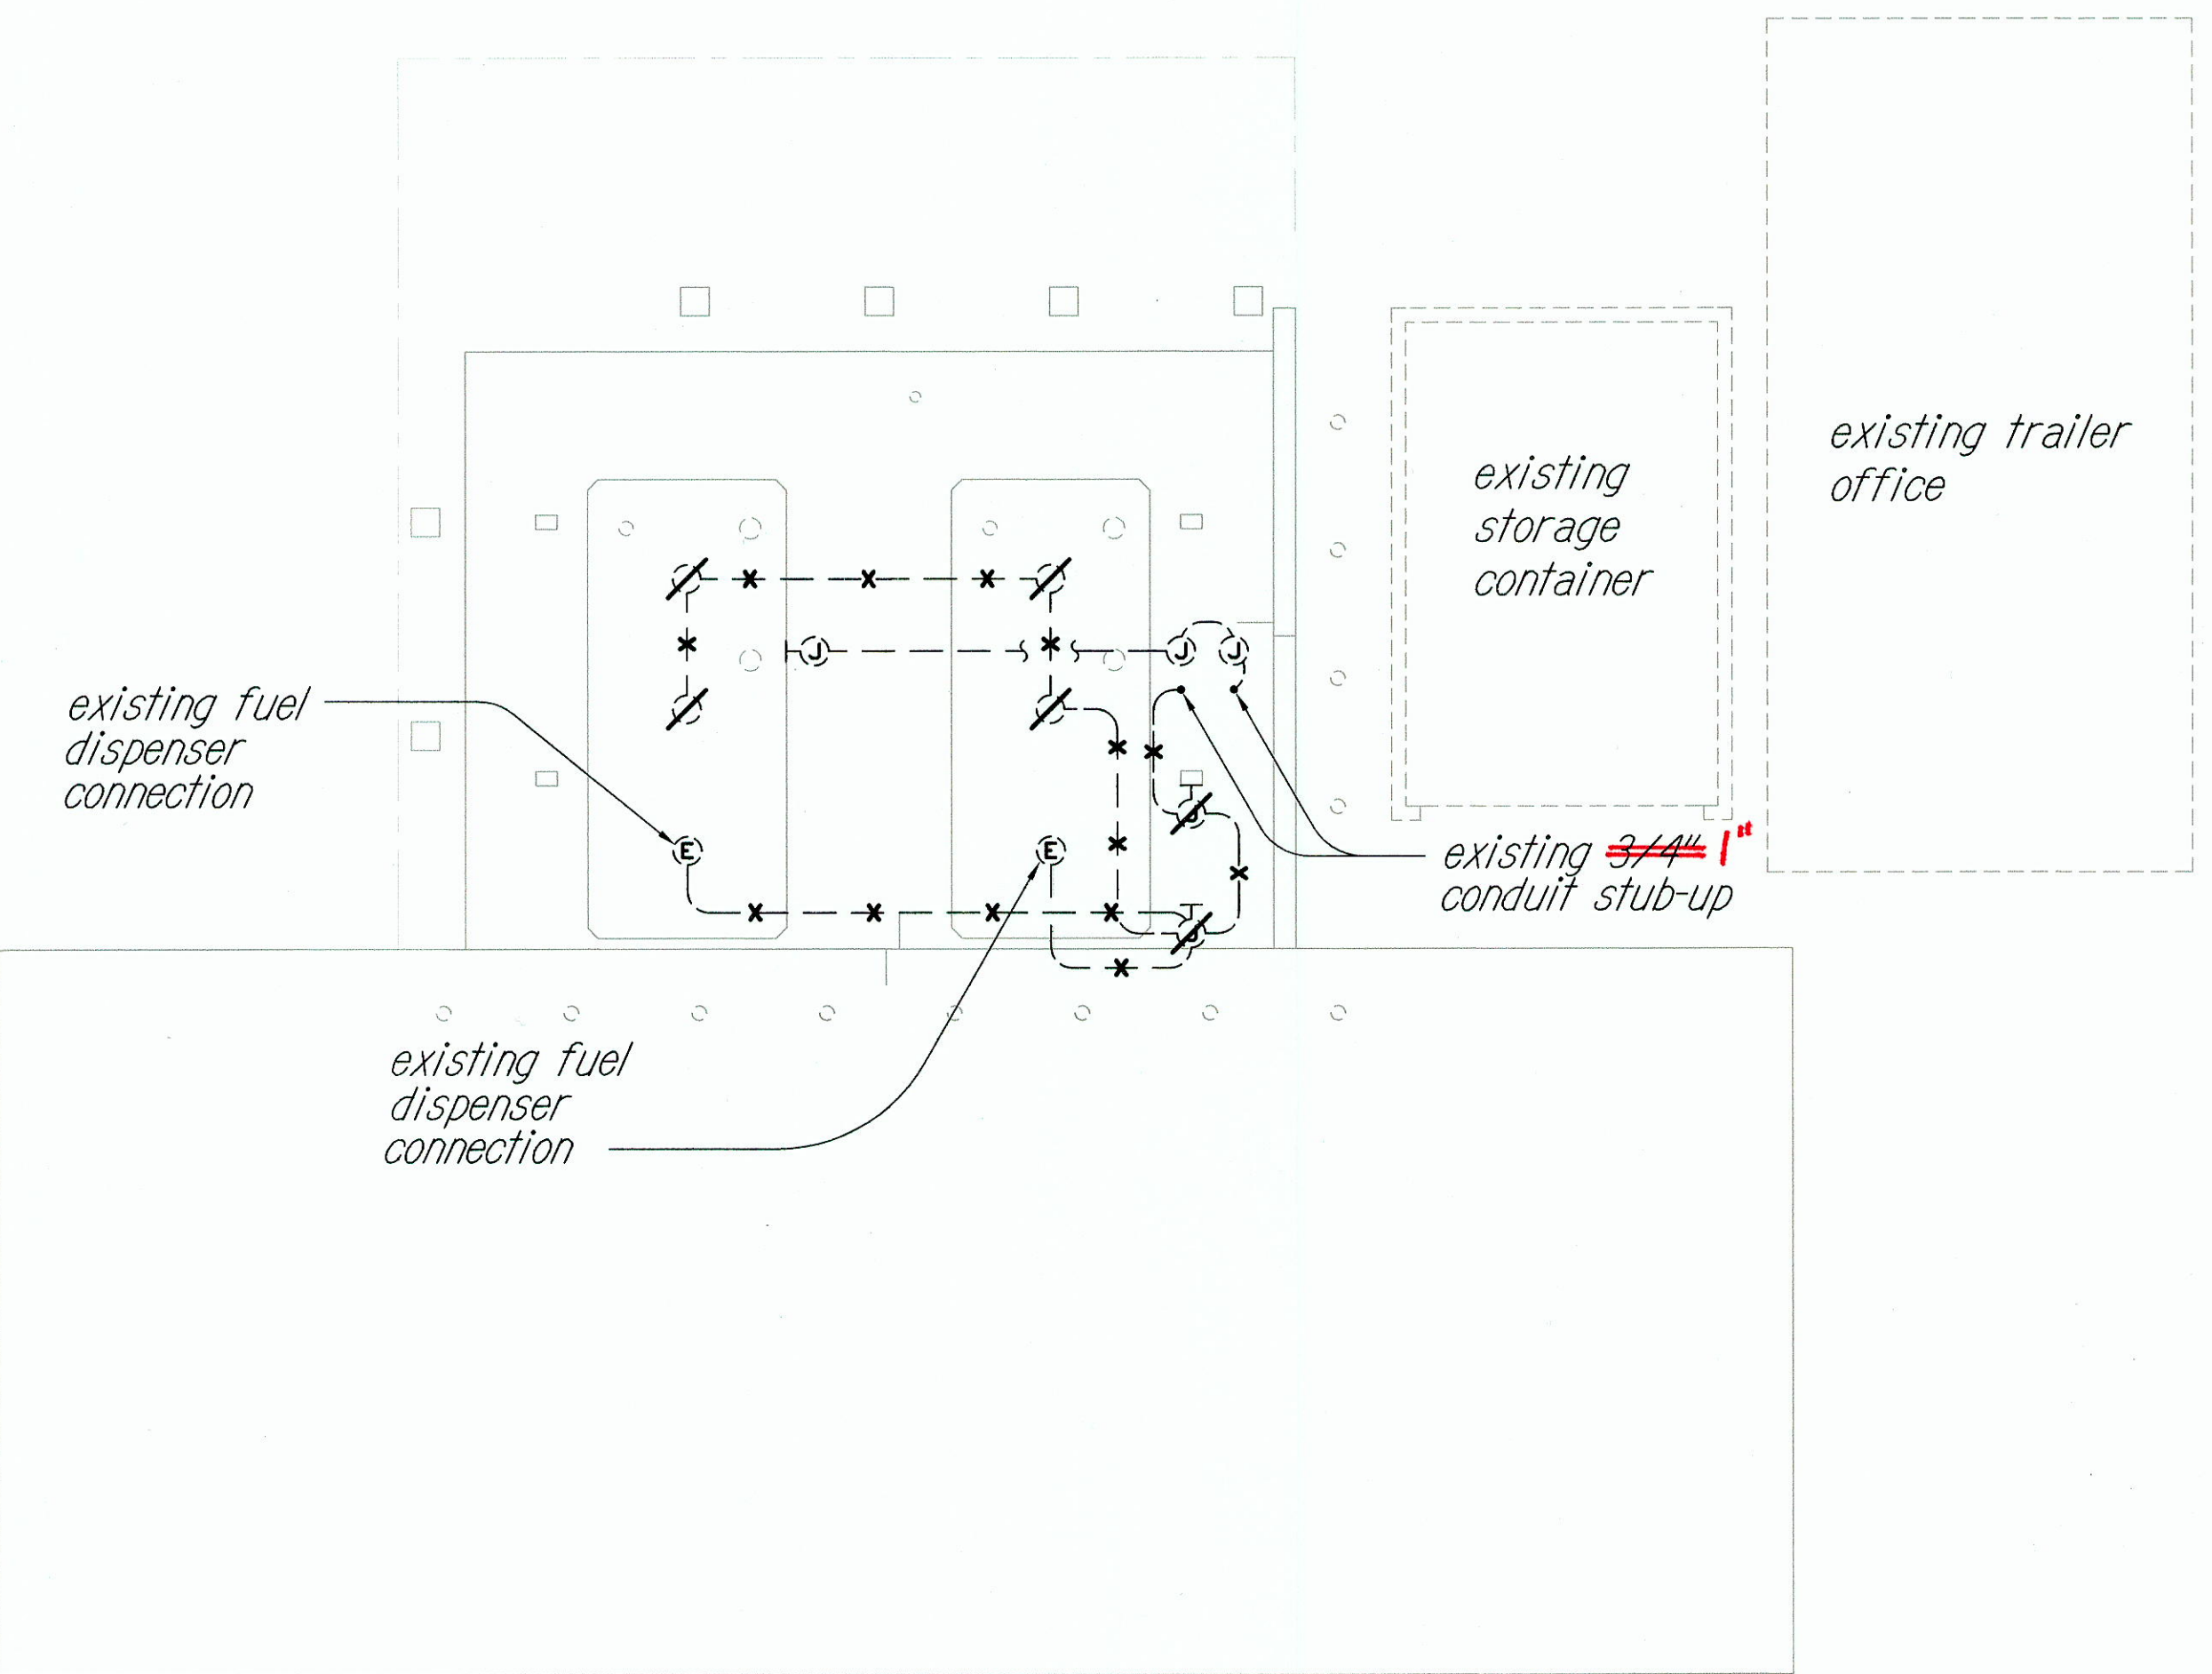

ELECTRICAL DEMOLITION PLAN
Scale: 1/4" = 1'-0"

B
E-101 E-101

ORIGINAL PLAN	SURVEY PLOTTED BY	DATE
NOTE BOOK	DESIGNED BY	"
QUANTITIES BY	"	"
CHECKED BY	"	"
No.	"	"



Jason Yogi
EXPIRATION DATE OF THE LICENSE 4/30/2012
THIS WORK WAS PREPARED BY
ME OR UNDER MY SUPERVISION

STATE OF HAWAII
DEPARTMENT OF TRANSPORTATION
HIGHWAYS DIVISION

**ELECTRICAL PLAN - NEW WORK,
ELECTRICAL DEMOLITION PLAN**

KEANAE BASEYARD
MAINTENANCE AND REPAIRS
Project No. HWY-M-06-06M

Scale: AS NOTED Date: APRIL 2010

SHEET No. E-101 OF 18 SHEETS

"AS-BUILT"