



INDEX TO DRAWINGS	
SHEET NO.	DESCRIPTION
1	TITLE SHEET
2	GENERAL NOTES
3 - 4	WATER POLLUTION AND EROSION CONTROL NOTES
5	SITE PLAN
6	DEMOLITION AND FOUNDATION FLOOR PLAN
7	RENOVATION AND SIGNAGE FLOOR PLAN
8	ROOF FRAMING, ROOF PLAN AND EXTERIOR ELEVATIONS
9	BUILDING SECTIONS AND DETAILS
10	SECTIONS AND DETAILS
11	SECTIONS AND DETAILS
12	FINISH AND SIGNAGE SCHEDULE
13	STRUCTURE GENERAL NOTES
14	STRUCTURE GENERAL NOTES TYPICAL DETAILS
15	FOUNDATION AND ROOF FRAMING PLANS, BUILDING SECTION
16	SECTIONS AND DETAILS
17	ELECTRICAL SYMBOLS, LUMINAIRE DETAIL, ELECTRICAL SITE PLAN
18	ELECTRICAL PLAN - NEW WORK, ELECTRICAL DEMOLITION PLAN



STATE OF HAWAII
DEPARTMENT OF TRANSPORTATION
HIGHWAYS DIVISION
HONOLULU, HAWAII
"AS-BUILT"
PLANS FOR
KEANAE BASEYARD
MAINTENANCE and REPAIRS
Project No. HWY-M-06-06M
DISTRICT OF HANA
ISLAND OF MAUI

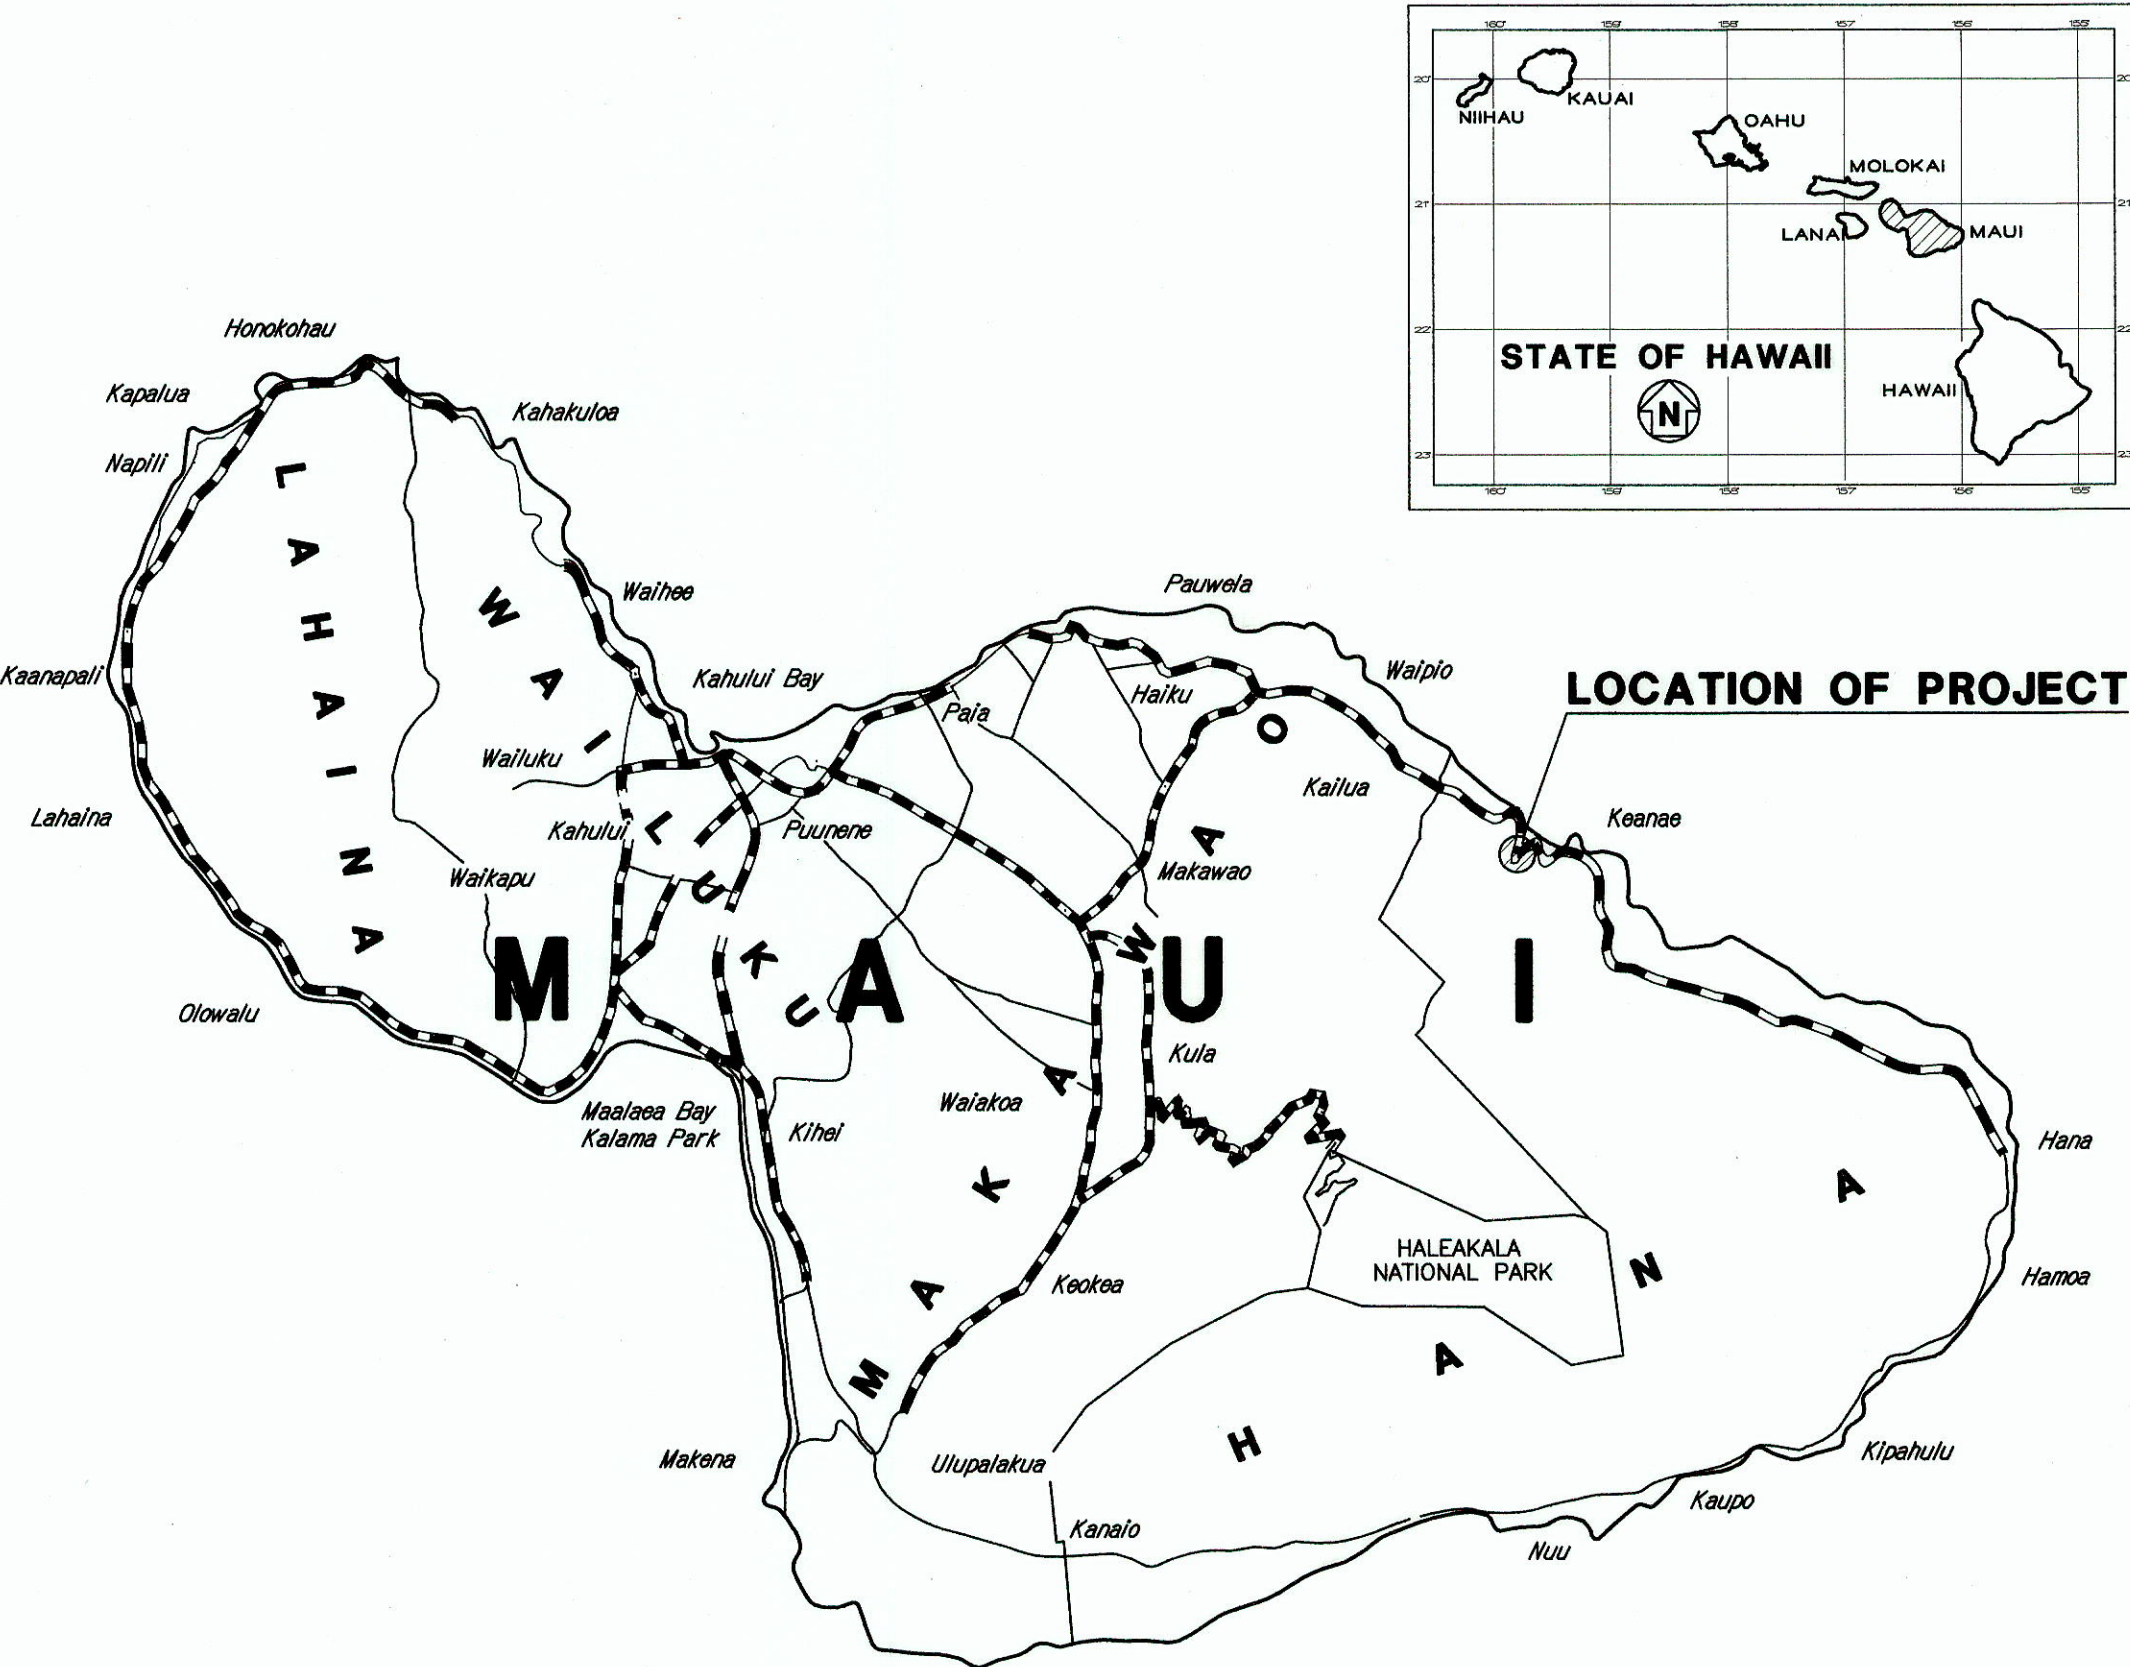

FED. ROAD DIST. NO.	STATE	PROJ. NO.	FISCAL YEAR	SHEET NO.	TOTAL SHEETS
HAWAII	HAW.	HWY-M-06-06M	2010	1	18

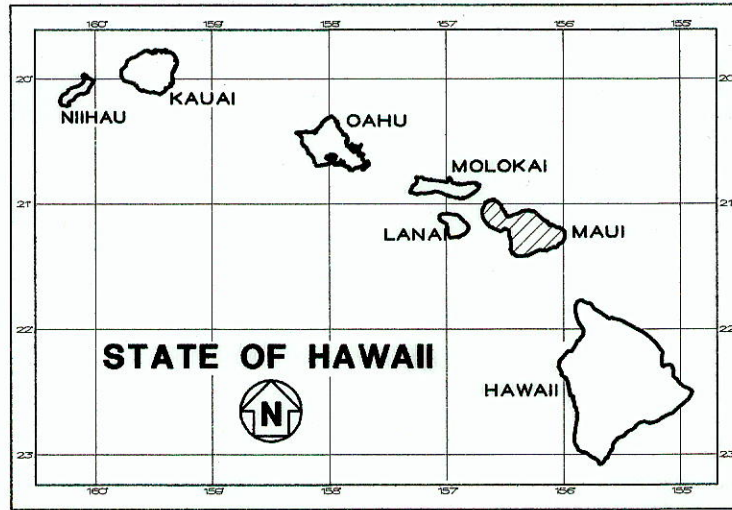

LOCATION OF PROJECT

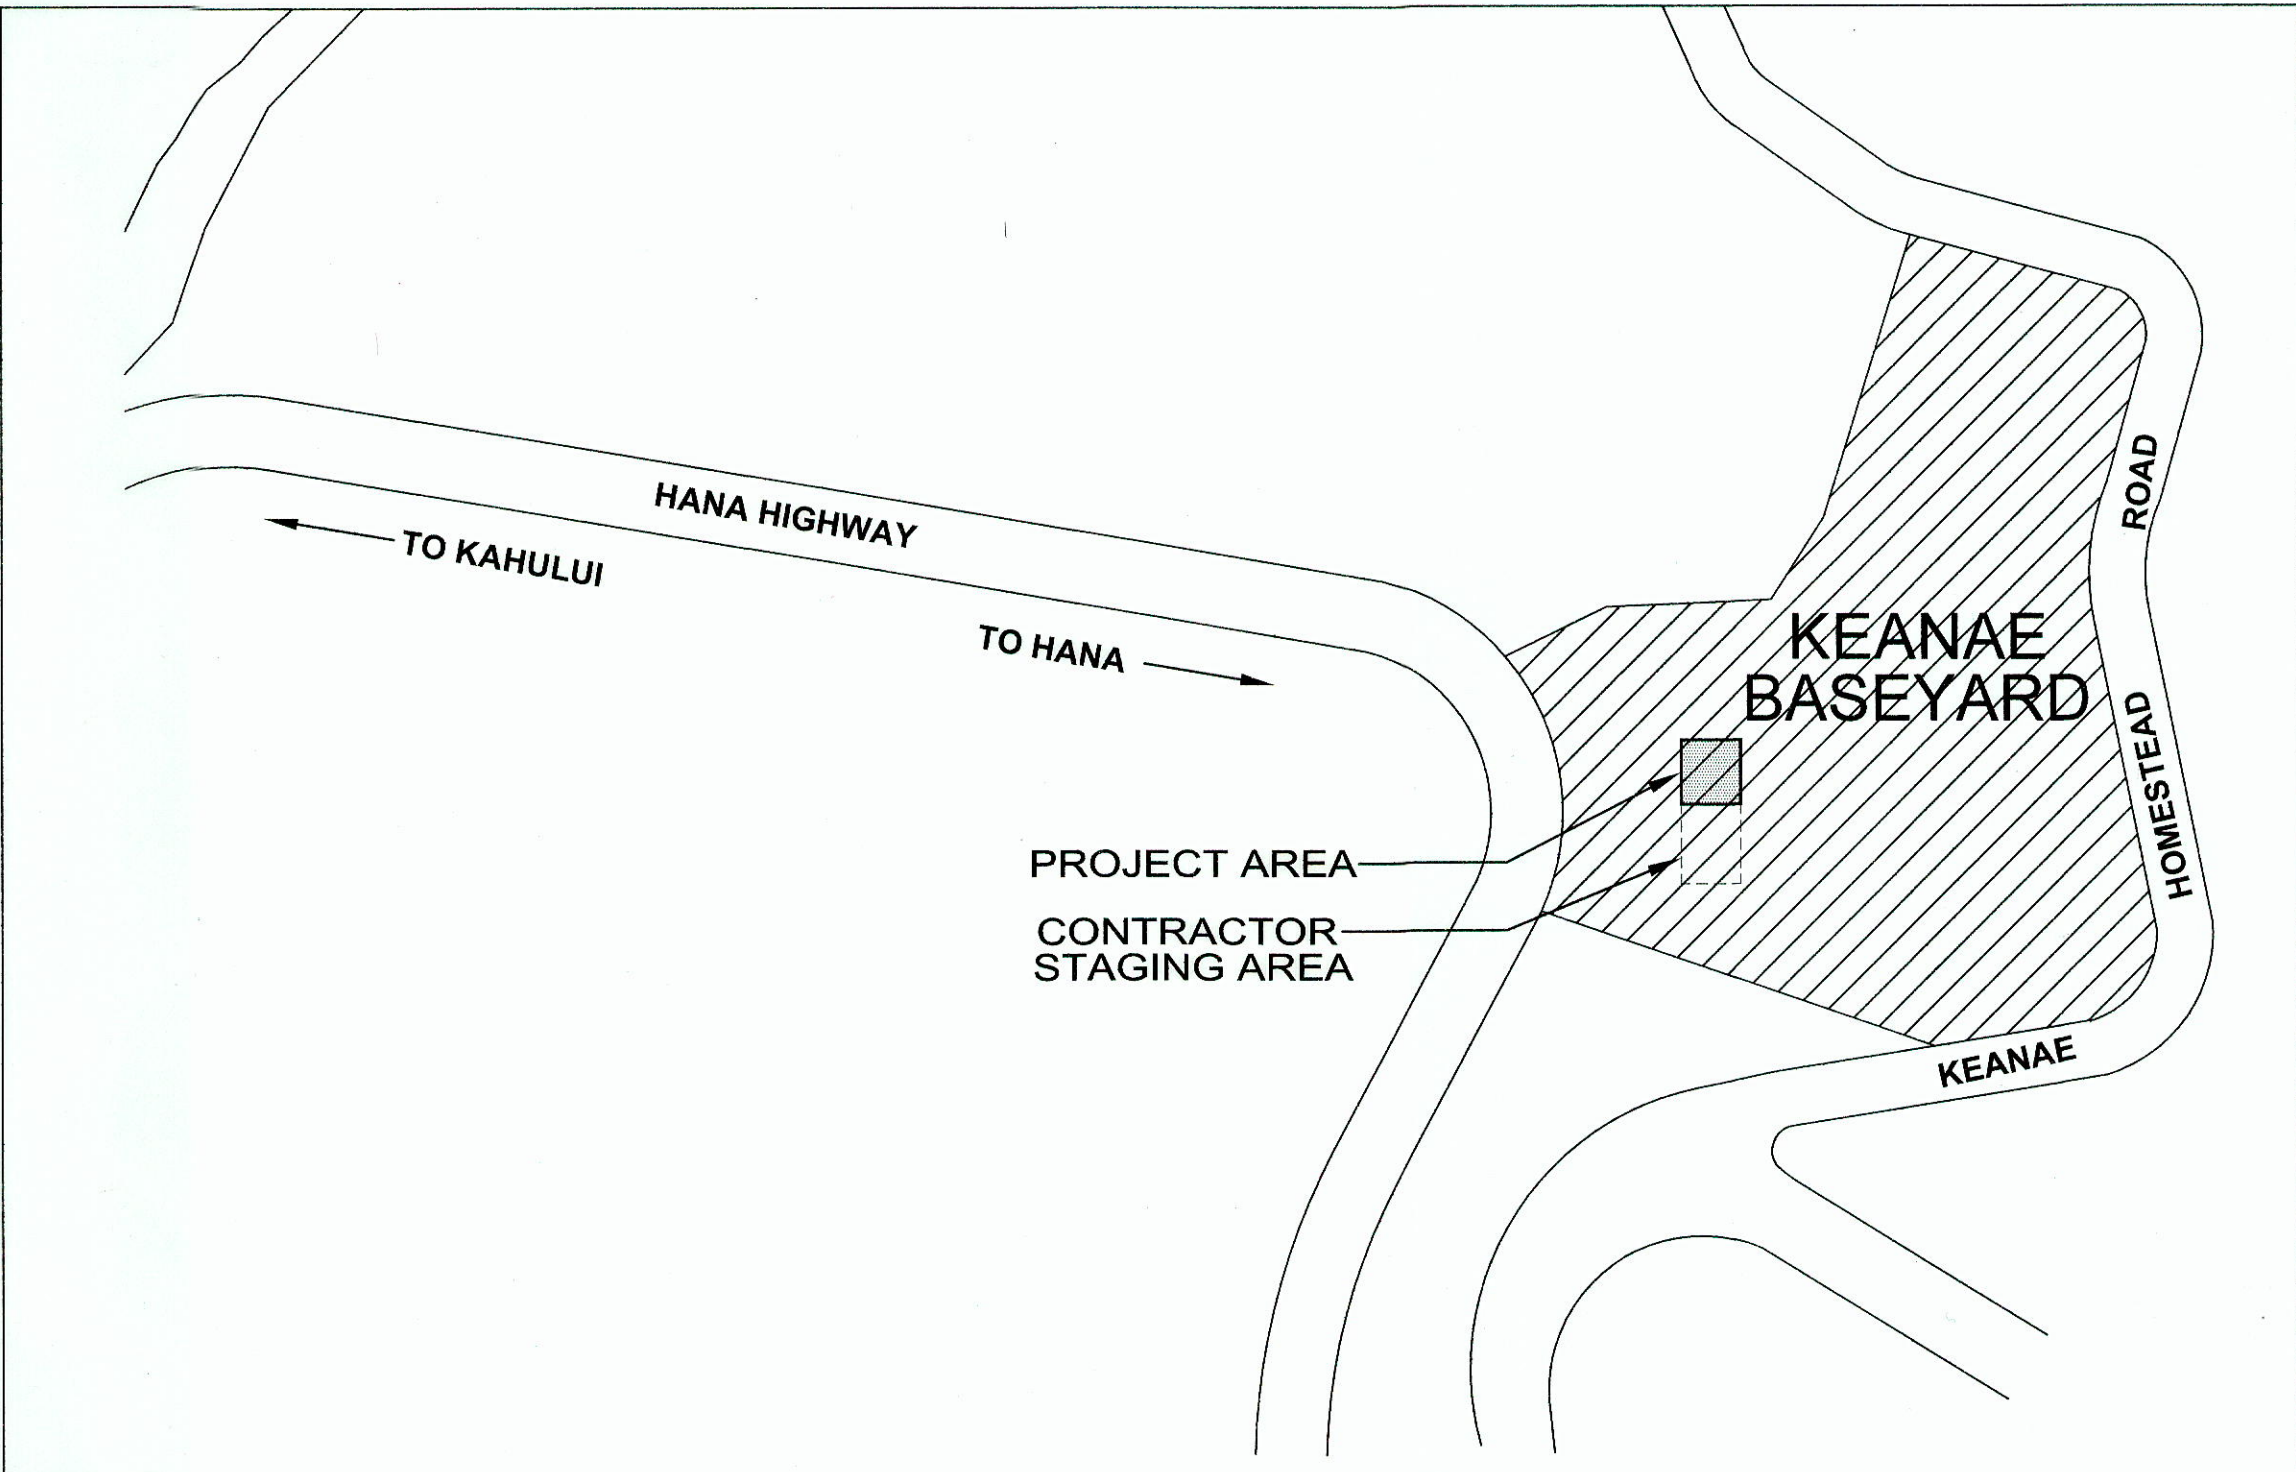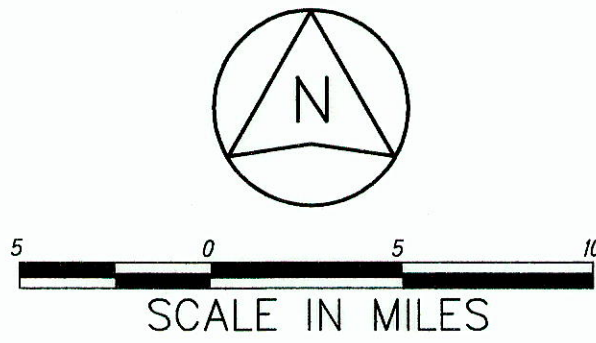

LOCATION PLAN
NOT TO SCALE

TAX MAP KEY 1-1-002:009,010

CHANGES MADE DURING CONSTRUCTION HAVE BEEN INCORPORATED ON THESE PLANS EXCEPT CHANGES IN THE ORIGINAL THEORETICAL QUANTITIES. FOR ACTUAL QUANTITIES, REFER TO PROJECT LEDGER AND/OR COMPUTATION BOOK.

RESIDENT ENGINEER
DATE 7/17/15

DEPARTMENT OF TRANSPORTATION
STATE OF HAWAII
APPROVED:
DIR. OF TRANSPORTATION
DATE 6/1/10

DESIGNED BY	DATE
NOTED BY	
CHECKED BY	
IN CHARGE	
PROJECT MANAGER	
PROJECT ENGINEER	
PROJECT SUPERVISOR	
PROJECT ASSISTANT	
PROJECT CLERK	
PROJECT OFFICE	
PROJECT PHONE	
PROJECT FAX	
PROJECT E-MAIL	
PROJECT ADDRESS	
PROJECT CITY	
PROJECT STATE	
PROJECT ZIP	
PROJECT COUNTY	
PROJECT DISTRICT	
PROJECT CDP	
PROJECT TRACT	
PROJECT LOT	
PROJECT SUBDIVISION	
PROJECT PLAT	
PROJECT MAP	
PROJECT RECORD	
PROJECT AS-BUILT	
PROJECT FINAL	

LOU CHAN & ASSOCIATES
DESIGNED BY
MANAGED BY
HWY-M
PHONE (808) 733-3535
DATE APRIL, 2010