


FED. ROAD DIST. NO.	STATE	PROJ. NO.	FISCAL YEAR	SHEET NO.	TOTAL SHEETS
HAWAII	HAW.	HWY-M-03-21, PHASE 2	2022	9	46

- NOTES:**
- Contractor shall protect all existing utilities, wether or not shown on plans, at all times unless indicated to be removed or relocated.
  - For additional demolition requirements, see Mechanical and Electrical plans.
  - Contractor may temporarily remove any bollards scheduled to remain in order to provide additional access during construction; however, Contractor will be required to replace bollards with new (see Def. 3/C105) at no additional cost to the State.
  - Contractor to restore pavement markings.

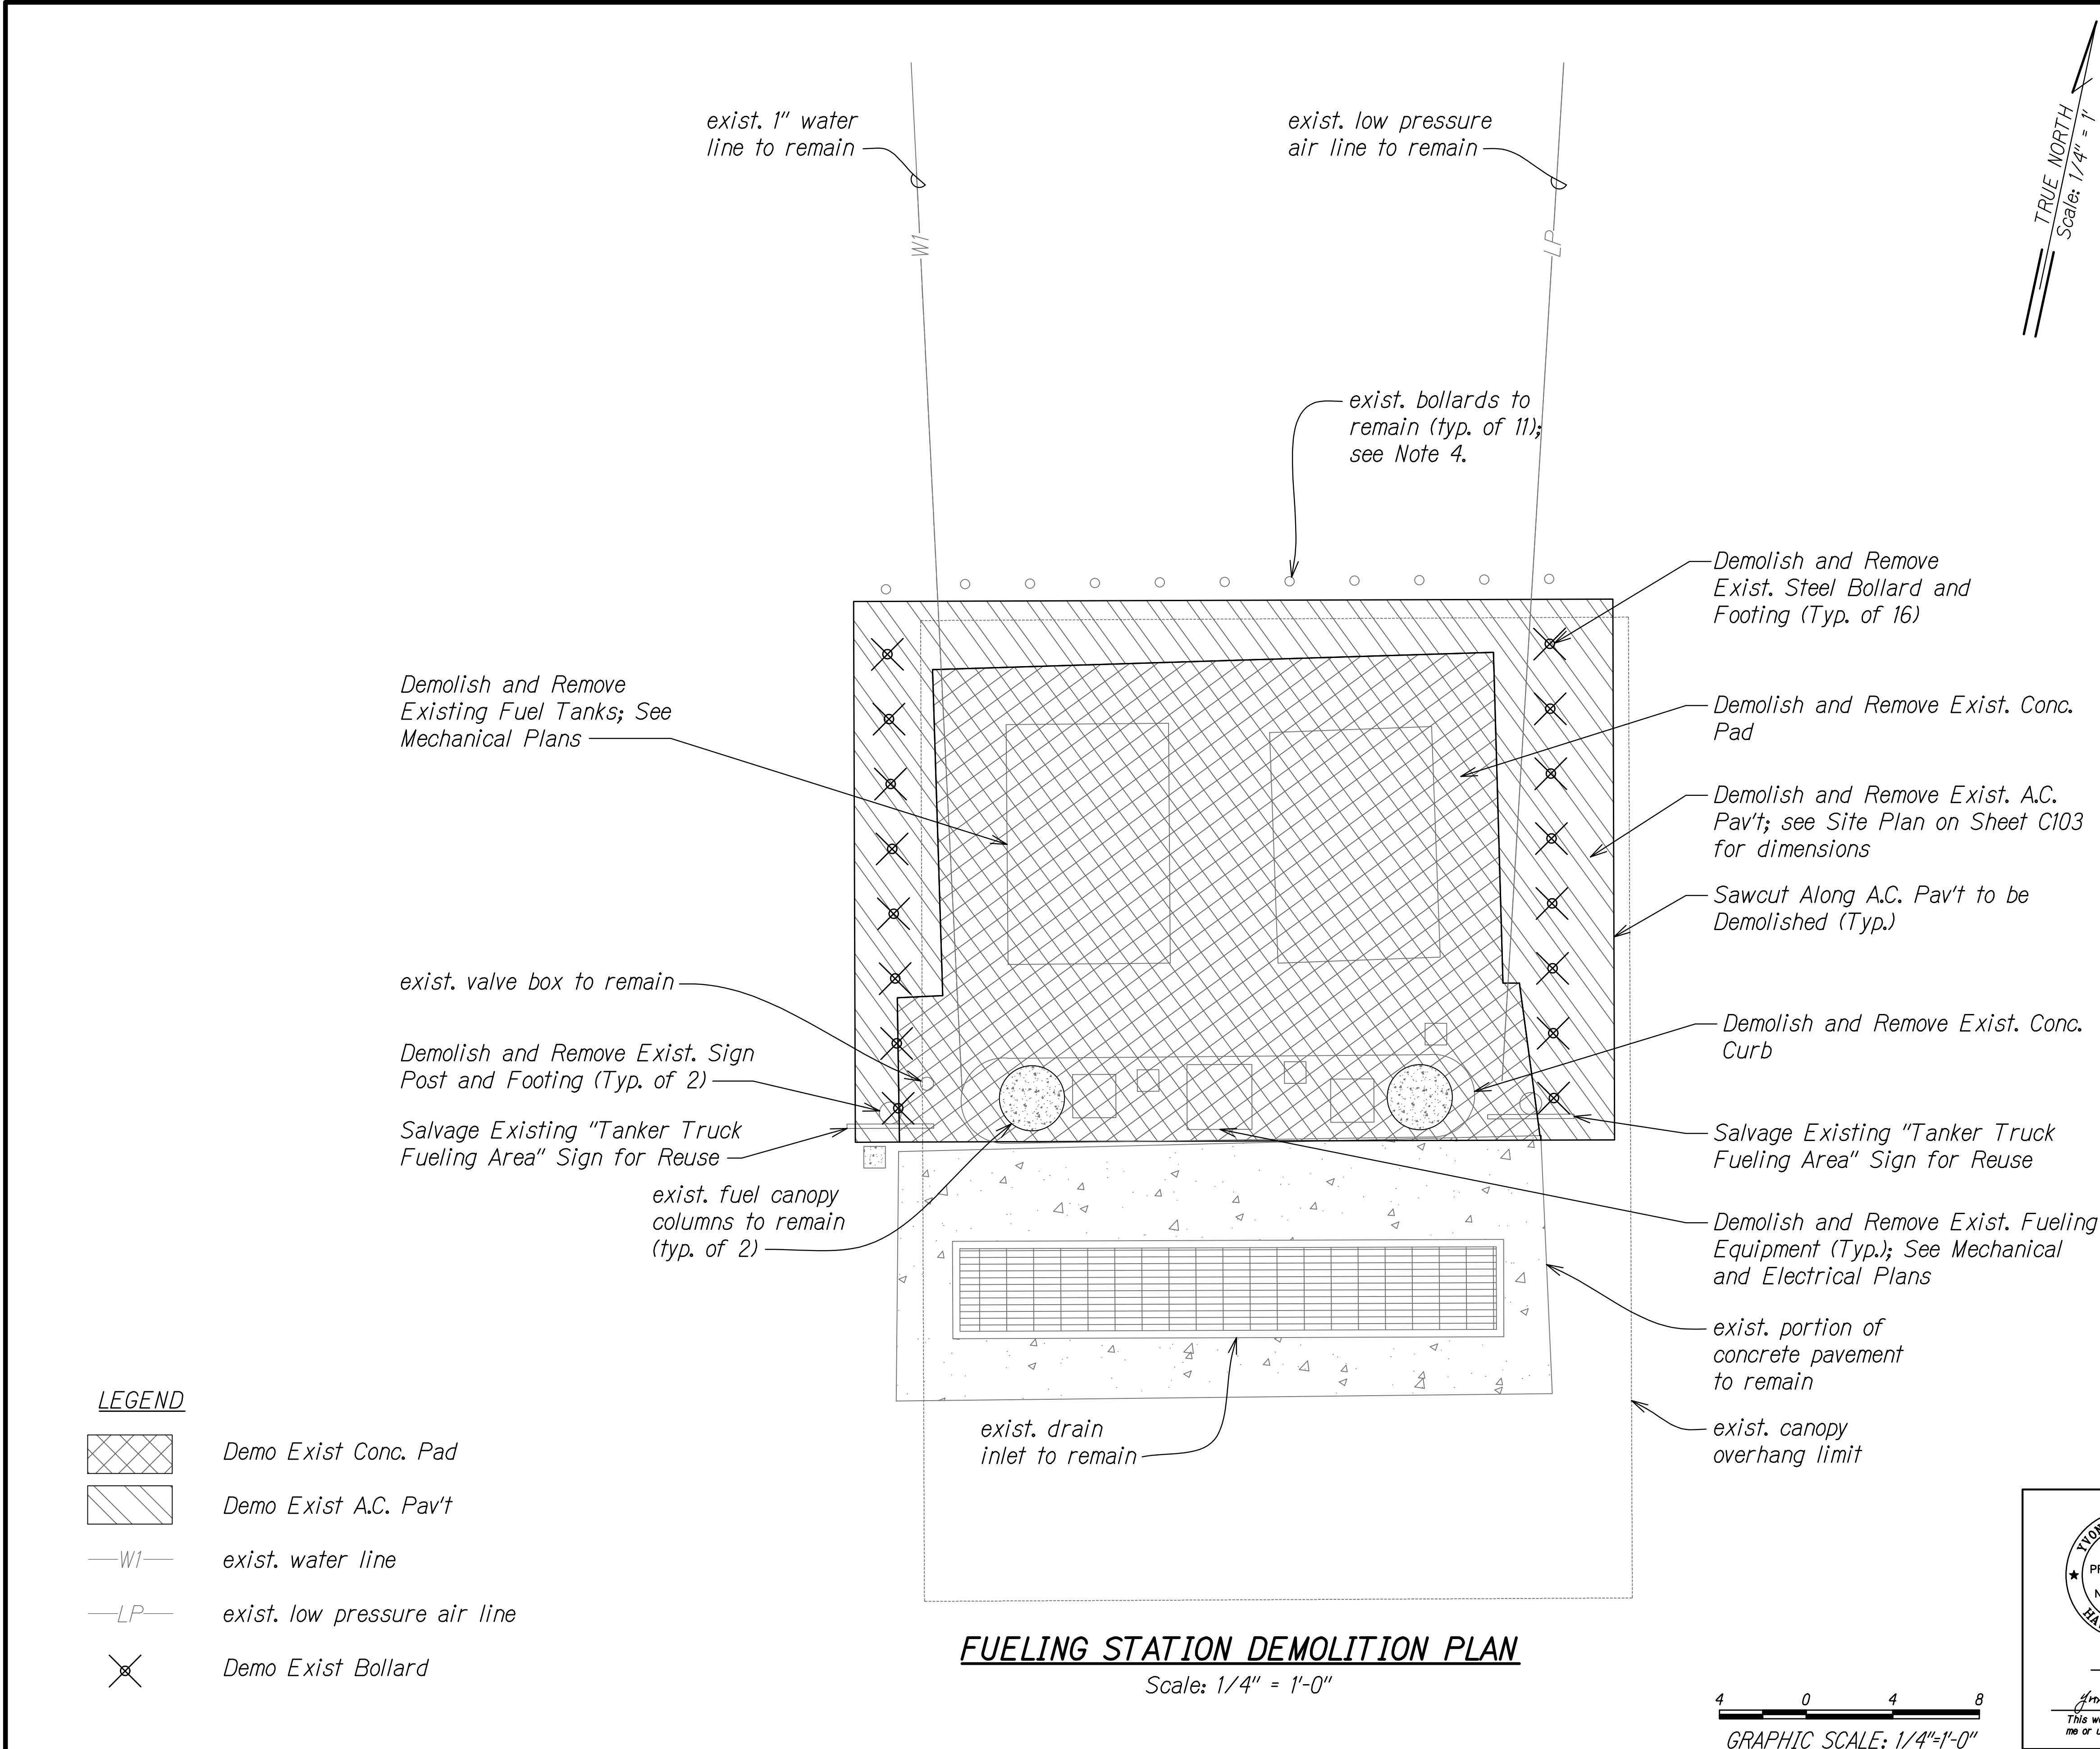

SURVEY PLOTTED BY: _____	DATE: _____
DESIGNED BY: _____	CHECKED BY: _____
NOTE BOOK: _____	QUANTITIES BY: _____
PROJECT NO.: _____	DATE: _____

DEMO PLANING 7/25/2022 3:02:00 PM

4/30/24  
EXP. DATE  
This work was prepared by me or under my supervision.

STATE OF HAWAII  
DEPARTMENT OF TRANSPORTATION  
HIGHWAYS DIVISION

**FUELING STATION  
DEMOLITION PLAN**

MAUI DISTRICT BASEYARD OFFICE EXPANSION \$

RENOVATION, PART 2  
Project No. HWY-M-03-21, Phase 2  
Scale: 1/4" = 1'-0" Date: July 2022