
 **1** ELECTRICAL SITE PLAN – PIER 1
E-2 SCALE: 1" = 60'-0"

GRAPHIC SCALE

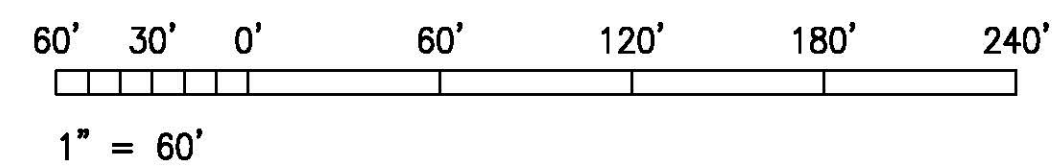

THIS WORK WAS PREPARED BY ME
OR UNDER MY SUPERVISION.

Michele N. Adorpio
PROJECT ENGINEER for ECS, Inc.

APRIL 30, 2024
EXPIRATION DATE OF THE LICENSE

REVISION	DATE	DESCRIPTION	BY	APPROVED
STATE OF HAWAII DEPARTMENT OF TRANSPORTATION HARBORS DIVISION				
JOB TITLE REPAIR LIGHTING AT PIER 1 SHED KAHALUI HARBOR, MAUI, HAWAII				
SHEET TITLE ELECTRICAL SITE PLAN – PIER 1				
DESIGNED BY: MA	JOB NUMBER S30226			SHEET E-2
DRAWN BY: OL				5 OF 10 SHEETS
CHECKED BY: MA				
DATE: APRIL 2023 SCALE: AS SHOWN				