


INDEX OF DRAWINGS		
SHEET NO.	DRAWING NO.	DESCRIPTION
1	T-1	TITLE SHEET, LOCATION MAP, VICINITY MAP
2	T-2	GENERAL PLAN, INDEX OF DRAWINGS
3	S-1	STRUCTURAL NOTES AND LIGHT POLE SL-2 REPAIR DETAILS
4	E-1	ELECTRICAL SYMBOL LIST AND GENERAL NOTES
5	E-2	ELECTRICAL SITE PLAN – PIER 1
6	E-3	PIER 1 SHED ELECTRICAL DEMOLITION PLAN
7	E-4	PIER 1 SHED ELECTRICAL PLAN
8	E-5	LIGHT POLE DETAILS
9	E-6	SHED LIGHTING DETAILS
10	E-7	LIGHTING CONTROL DIAGRAM, EQUIPMENT ELEVATION

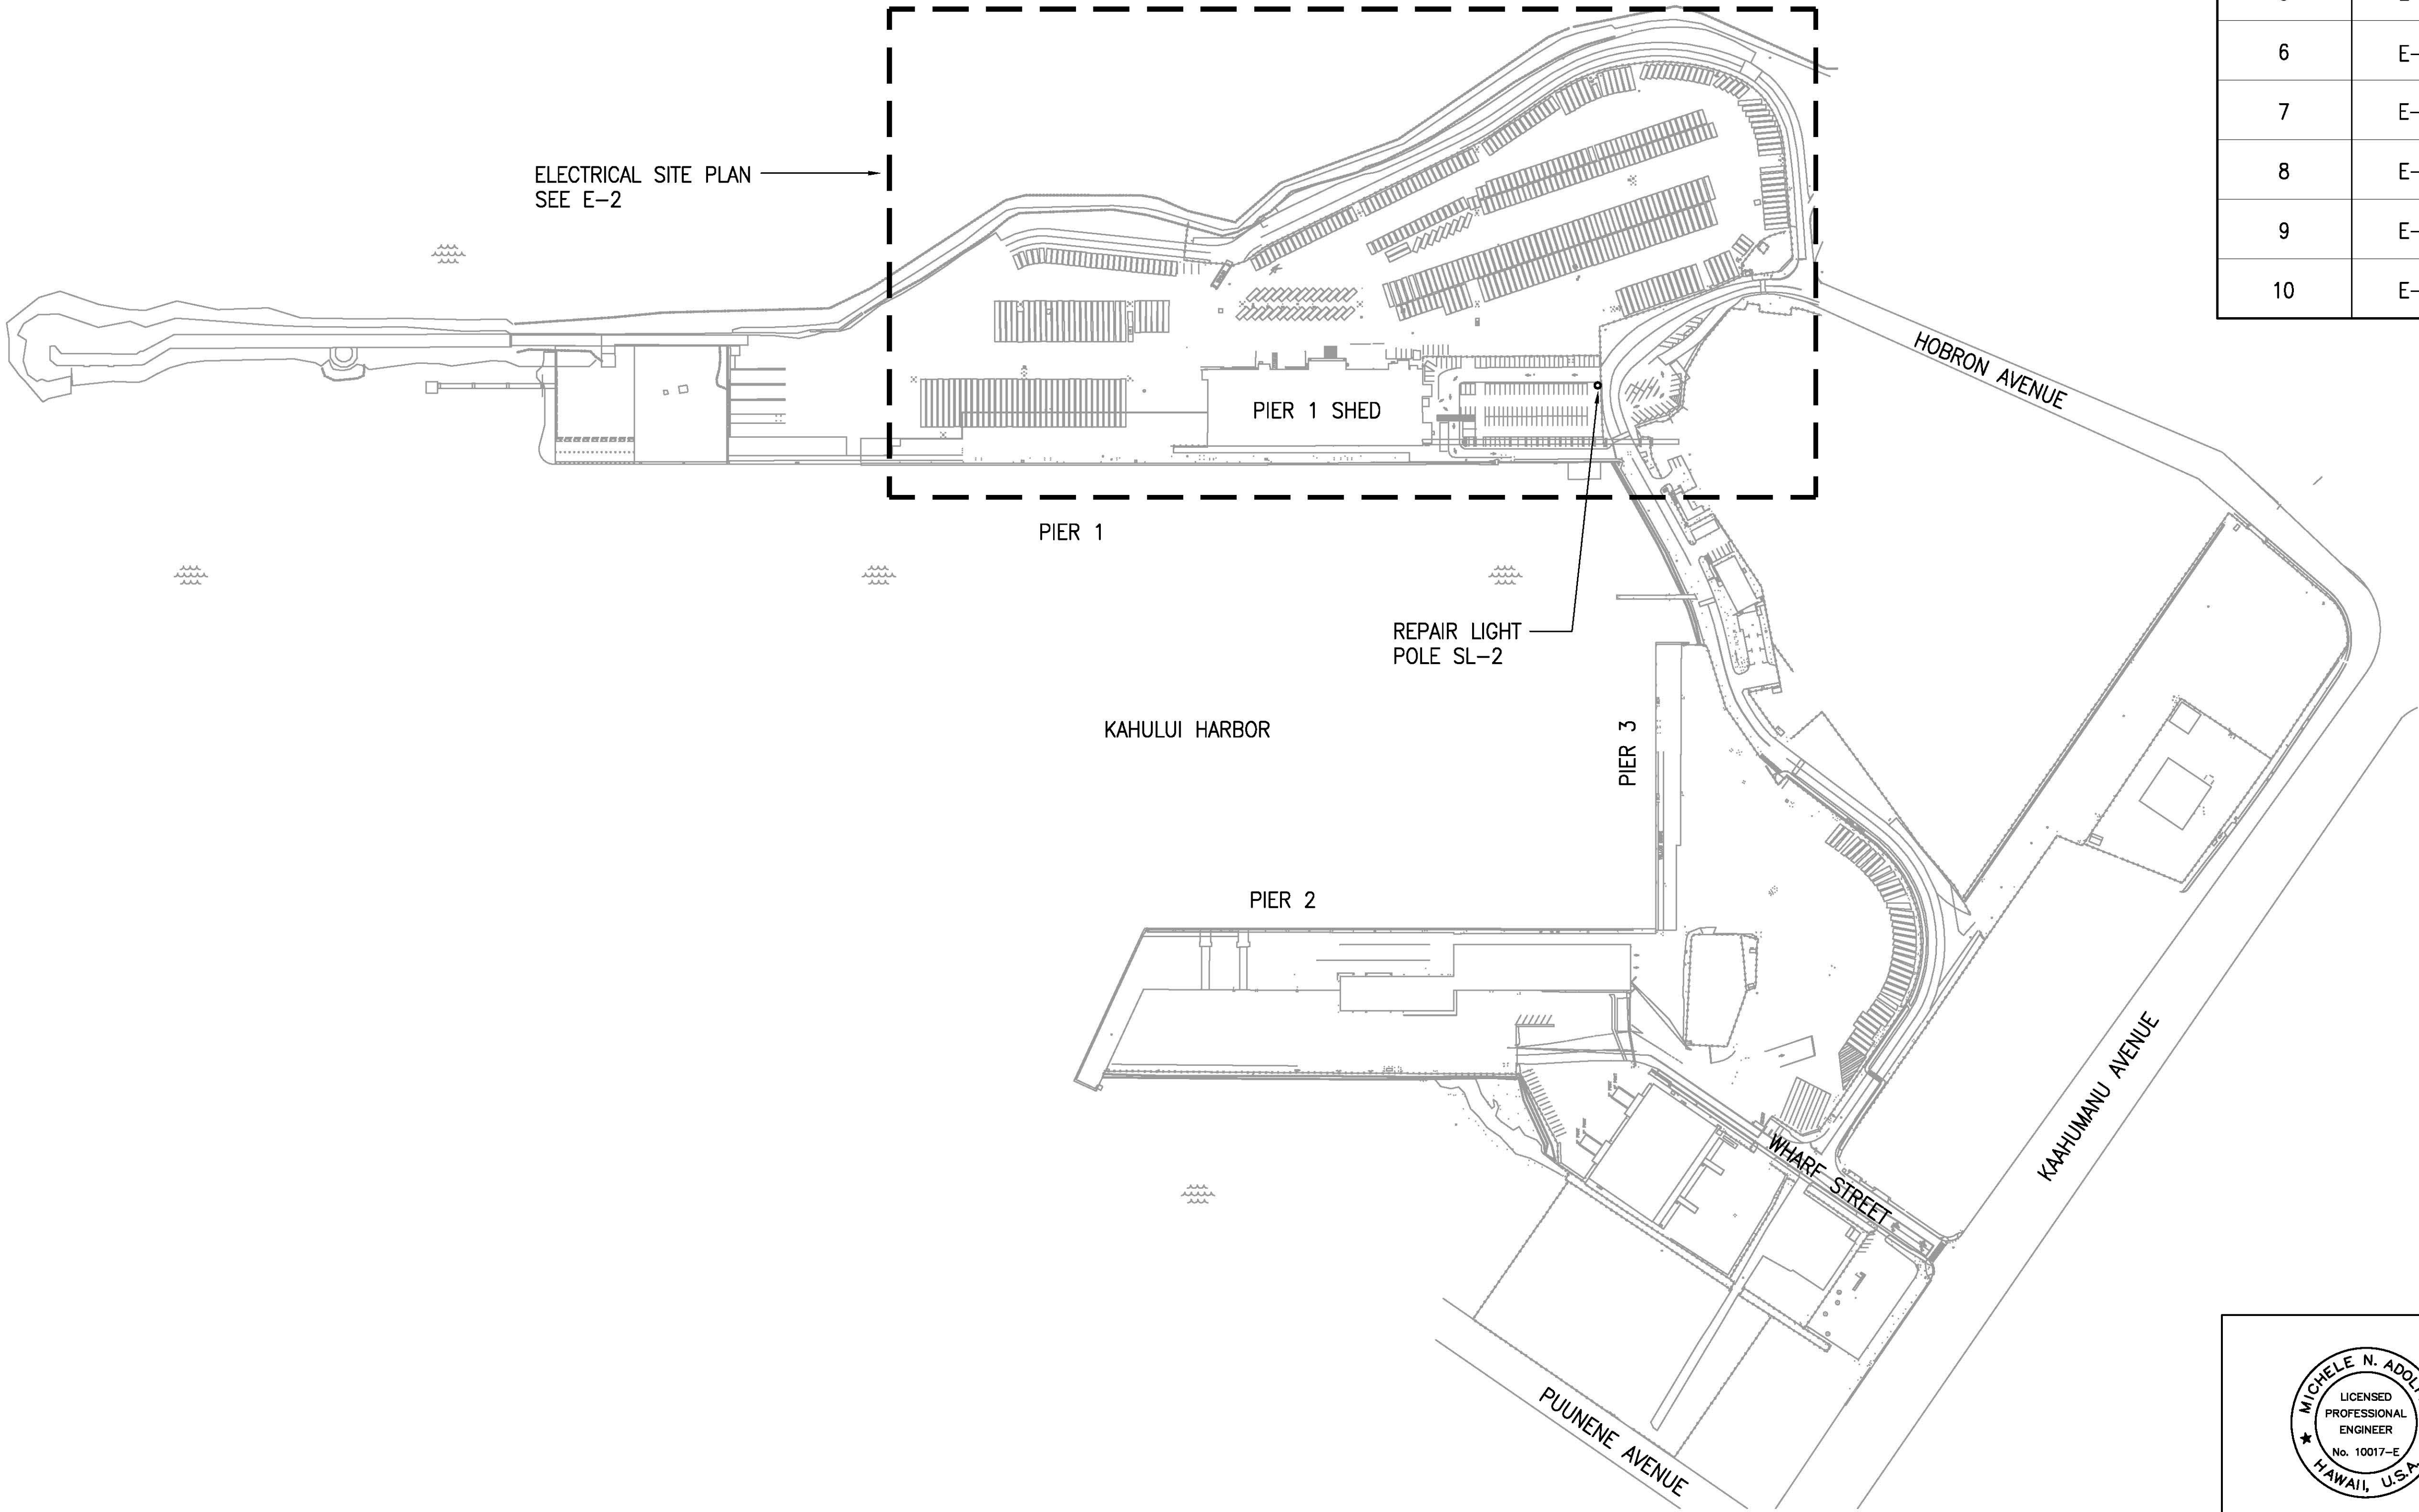

1
T-2 GENERAL PLAN
SCALE: NOT TO SCALE

REVISION	DATE	DESCRIPTION		BY APPROVED
STATE OF HAWAII DEPARTMENT OF TRANSPORTATION HARBORS DIVISION				
JOB TITLE				
REPAIR LIGHTING AT PIER 1 SHED KAHULUI HARBOR, MAUI, HAWAII				
SHEET TITLE				
GENERAL PLAN, INDEX OF DRAWINGS				
DESIGNED BY: MA	JOB NUMBER			SHEET
DRAWN BY: OL				T-2
CHECKED BY: MA				
DATE: APRIL 2023				
SCALE: AS SHOWN	S30226			



THIS WORK WAS PREPARED BY ME
OR UNDER MY SUPERVISION.
Michele Adorpio
PROJECT ENGINEER for ECS, Inc.
APRIL 30, 2024
EXPIRATION DATE OF THE LICENSE