




1 APRON LIGHTING CONTROL DIAGRAM
E-7 NOT TO SCALE

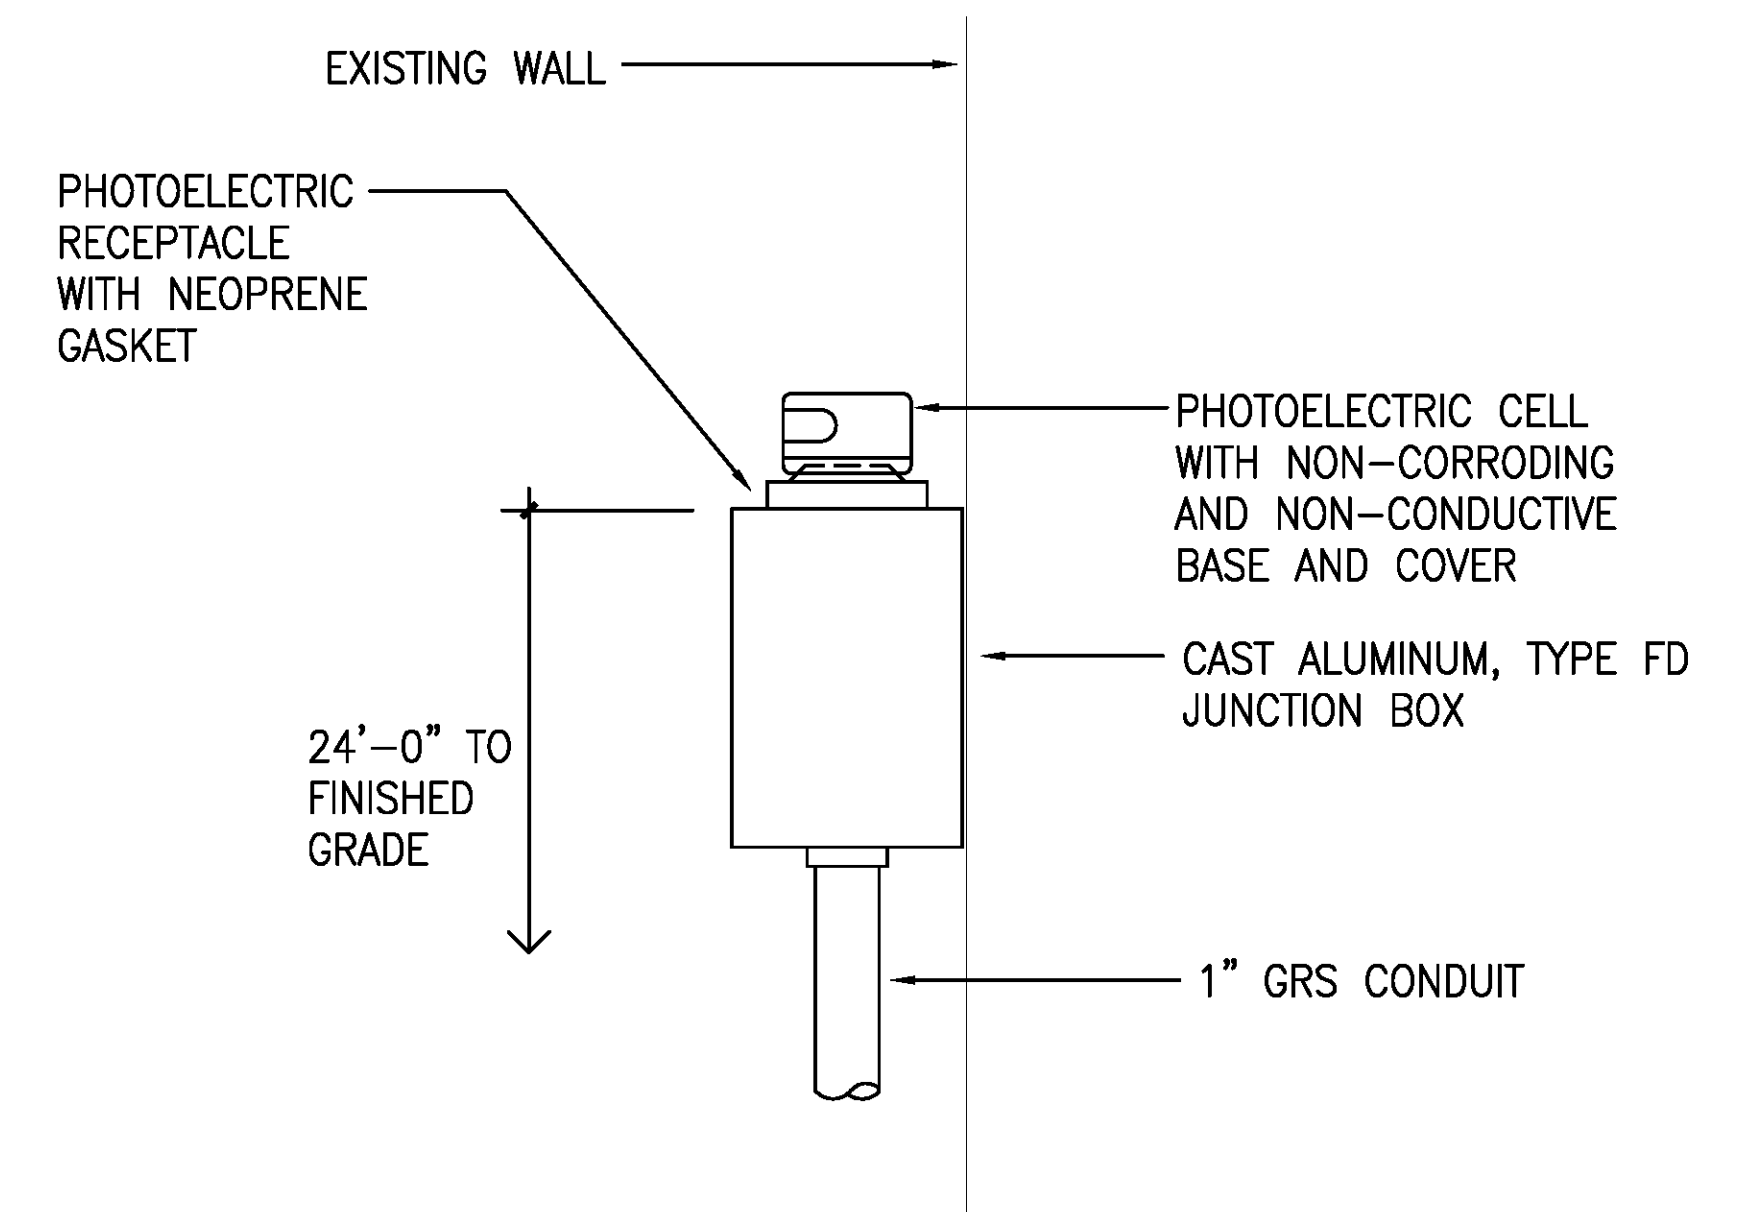

2 PHOTOELECTRIC CELL DETAIL
E-7 NOT TO SCALE

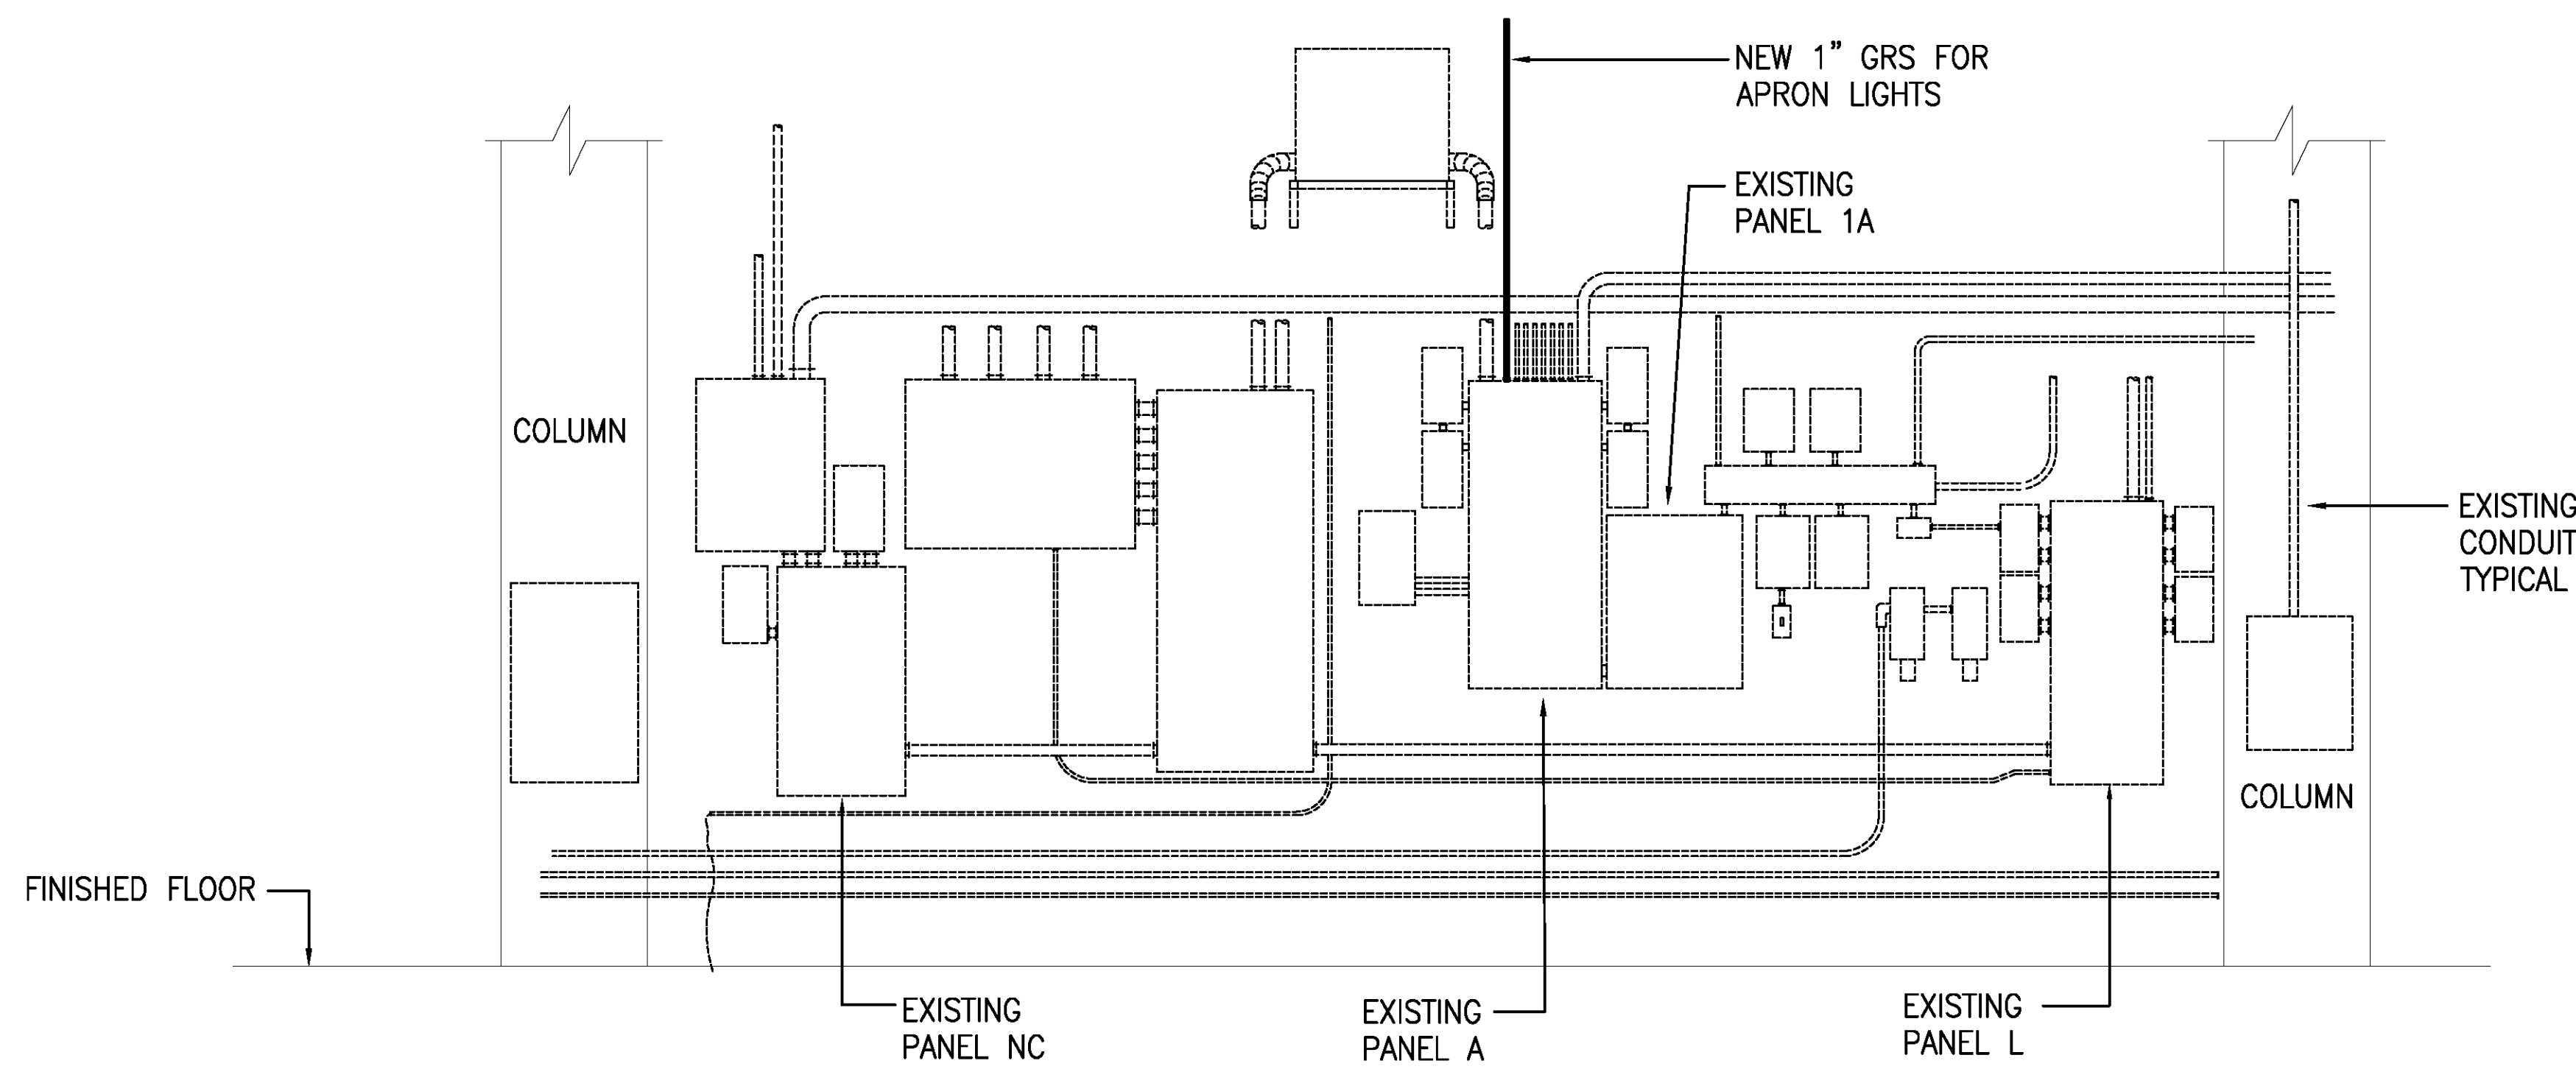

3 EQUIPMENT ELEVATION
E-7 NOT TO SCALE

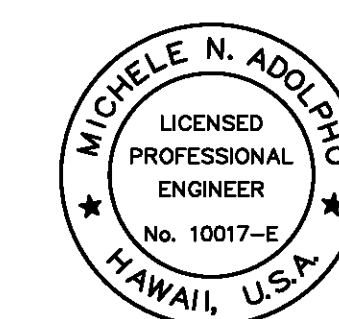

THIS WORK WAS PREPARED BY ME OR UNDER MY SUPERVISION.

Michele N. Adorpio

PROJECT ENGINEER for ECS, Inc.

APRIL 30, 2024

EXPIRATION DATE OF THE LICENSE

REVISION	DATE	DESCRIPTION	BY	APPROVED
STATE OF HAWAII DEPARTMENT OF TRANSPORTATION HARBORS DIVISION				
JOB TITLE REPAIR LIGHTING AT PIER 1 SHED KAHULUI HARBOR, MAUI, HAWAII				
SHEET TITLE LIGHTING CONTROL DIAGRAM, EQUIPMENT ELEVATION				
DESIGNED BY: MA	JOB NUMBER S30226		SHEET E-7 10 OF 10 SHEETS	
DRAWN BY: OL				
CHECKED BY: MA				
DATE: APRIL 2023				
SCALE: AS SHOWN				