



**NOTE:**  
1 REFER TO LIGHTING CALCULATION NOTES ON E-1 FOR LIGHTING CRITERIA.

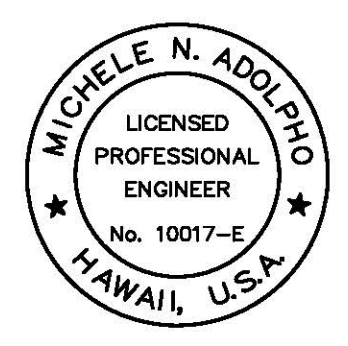

THIS WORK WAS PREPARED BY ME OR UNDER MY SUPERVISION.  
*Michele N. Adorpio*  
PROJECT ENGINEER for ECS, Inc.  
APRIL 30, 2024  
EXPIRATION DATE OF THE LICENSE

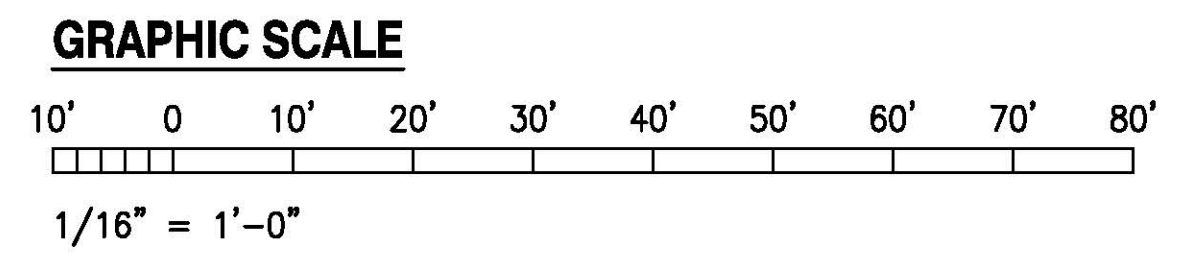

1 PIER 1 SHED ELECTRICAL PLAN  
E-4 SCALE: 1/16" = 1'-0"

REVISION	DATE	DESCRIPTION	BY	APPROVED
STATE OF HAWAII DEPARTMENT OF TRANSPORTATION HARBORS DIVISION				
JOB TITLE REPAIR LIGHTING AT PIER 1 SHED KAHULUI HARBOR, MAUI, HAWAII				
SHEET TITLE PIER 1 SHED ELECTRICAL PLAN				
DESIGNED BY: MA	JOB NUMBER S30226		SHEET E-4 7 OF 10 SHEETS	
DRAWN BY: OL				
CHECKED BY: MA				
DATE: APRIL 2023				
SCALE: AS SHOWN				