

INDEX TO DRAWINGS	
SHEET NO.	DESCRIPTION
1	TITLE SHEET
2	STANDARD PLANS SUMMARY
3 - 9	CONSTRUCTION, UTILITY, AND EROSION CONTROL NOTES
10	LEGEND AND ABBREVIATIONS
11 - 14	GENERAL PLANS AND TYPICAL ROADWAY SECTIONS
15 - 16	PHASING PLANS
17 - 24	EROSION CONTROL PLAN AND DETAILS
25 - 34	DEMOLITION AND DETOUR ROAD PLANS
35 - 36	PLAN AND PROFILE - KAMEHAMEHA V HIGHWAY
37 - 41	MISCELLANEOUS PLANS
42	PLAN AND PROFILE - 8" WATERLINE/18" DRAINLINE
43-45	SUPERELEVATION DIAGRAM, CROSS SECTIONS
46	STRIPING AND SIGNAGE PLAN
47	MISCELLANEOUS DETAILS
48 - 50	TRAFFIC CONTROL PLANS
51 - 52	WATERLINE DETAILS
53 - 57	BORING LOGS
58 - 83	STRUCTURAL PLANS
84 - 90	ELECTRICAL PLANS
91 - 93	LANDSCAPING PLANS

Sheet Nos. ① ADD 39.5-1 thru ADD 39.5-5; ② ADD 48.5-1 are Supplementary Sheets to this Project. Total Sheet Count After "AS-BUILT" Postings 99 Sheets.

STATE OF HAWAII

DEPARTMENT OF TRANSPORTATION

HIGHWAYS DIVISION

HONOLULU, HAWAII

"AS-BUILT"

PLANS FOR

KAMEHAMEHA V HIGHWAY



KAWELA BRIDGE REPLACEMENT

FEDERAL AID PROJECT NO. BR-0450(8)

DISTRICT OF MOLOKAI

ISLAND OF MOLOKAI


FED. ROAD DIST. NO.	STATE	FED. AID PROJ. NO.	FISCAL YEAR	SHEET NO.	TOTAL SHEETS
HAWAII	HAW.	BR-0450(8)	2011	1	93

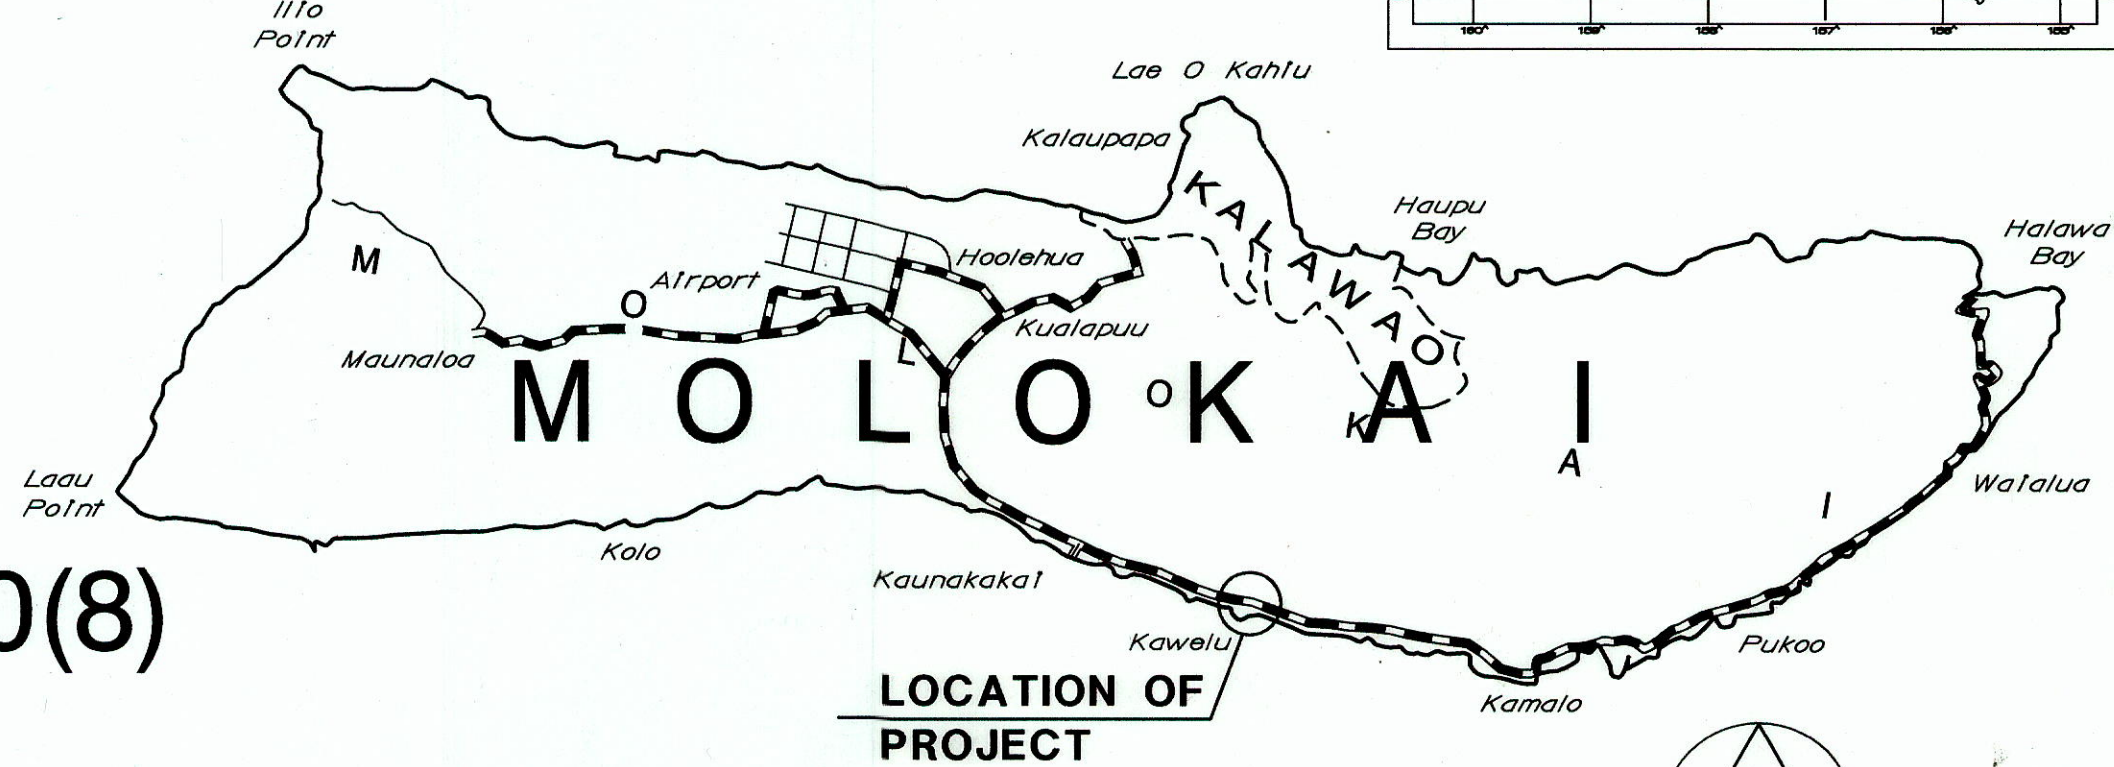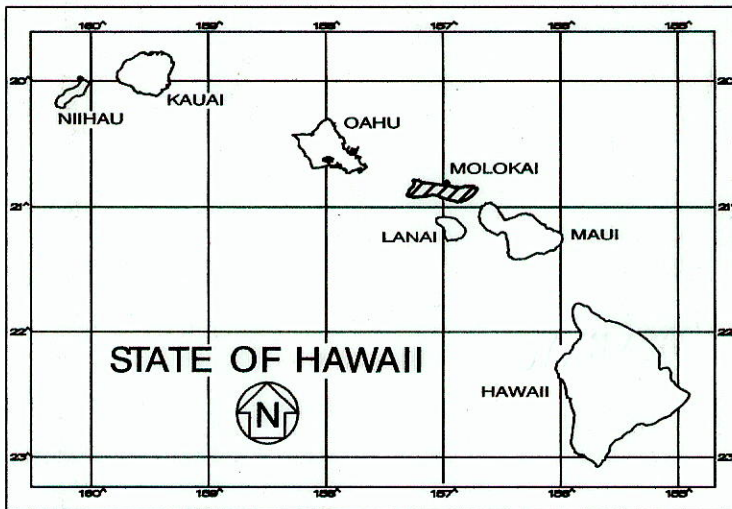

CHANGES MADE DURING CONSTRUCTION HAVE BEEN INCORPORATED ON THESE PLANS EXCEPT CHANGES IN THE ORIGINAL THEORETICAL QUANTITIES. FOR ACTUAL QUANTITIES, REFER TO PROJECT LEDGER AND/OR COMPUTATION BOOK.

Chandra
RESIDENT ENGINEER

10/24/16
DATE

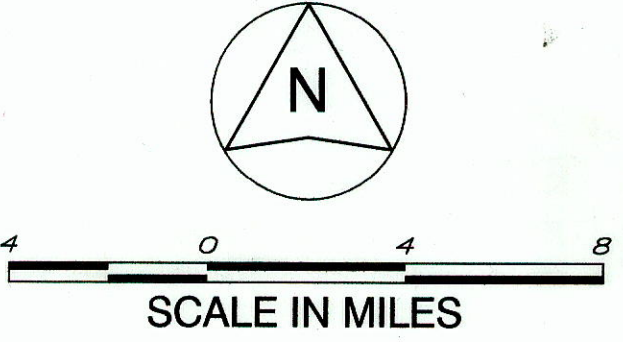


KAI HAWAII INC
DESIGNED BY

HWY DS
MANAGED BY

692-7544
PHONE

7/21/10
DATE

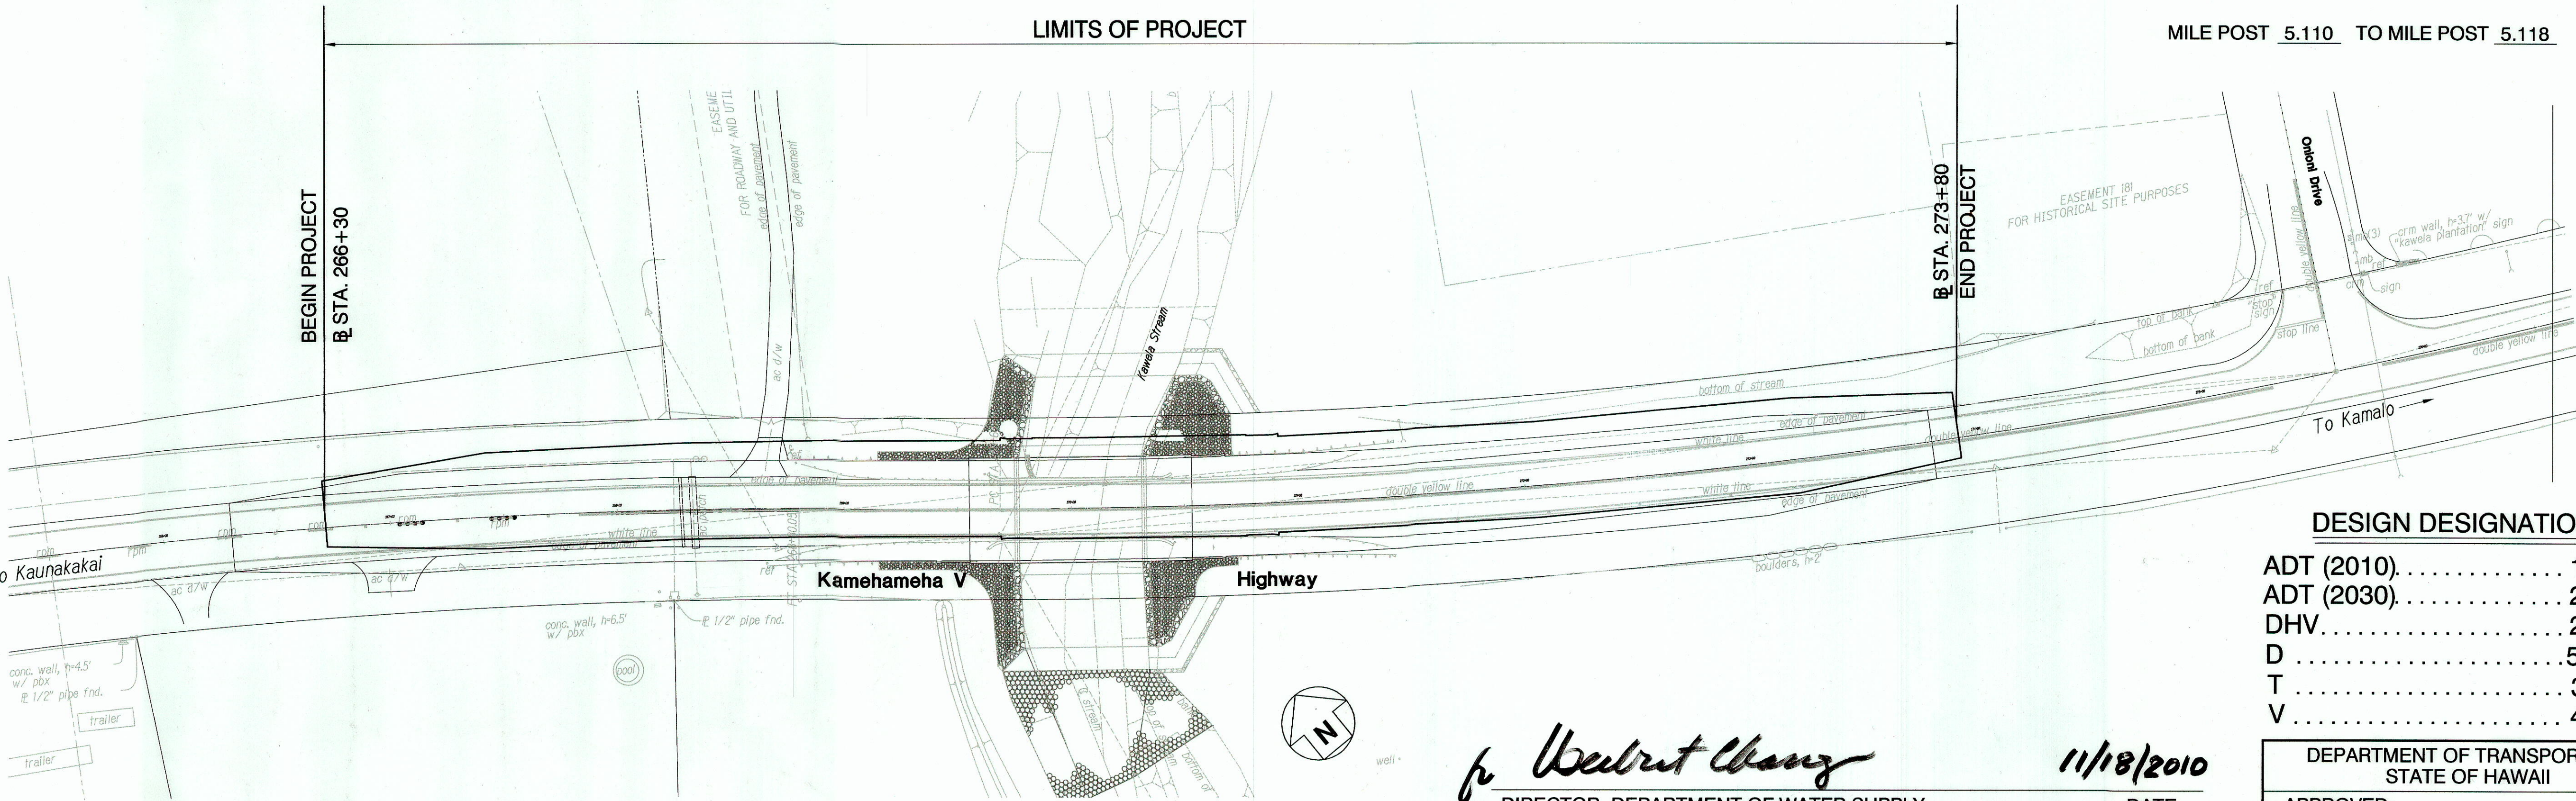

SCALE : 1" = 40'-0"

LAYOUT PLAN

Wendy Chang
DIRECTOR, DEPARTMENT OF WATER SUPPLY
COUNTY OF MAUI
(ONLY APPLICABLE TO IMPROVEMENTS TO BE DEDICATED TO DWS)

11/18/2010
DATE

DESIGN DESIGNATION	
ADT (2010)	1,850
ADT (2030)	2,600
DHV	230
D	55/45
T	3.0 %
V	45 M.P.H.

DEPARTMENT OF TRANSPORTATION STATE OF HAWAII	
APPROVED:	
DIR. OF TRANSPORTATION	01/19/11 DATE