

CURB RAMP NO. 10104-2 DETAILS
Scale: 1"= 5'

Scale: 1" = 5'

Install new PPB and pedestal
See Electrical Plans

Exist. flare as landing area (6'x6')

STREET

MAIN

High STREET

To Wailuku

To Iao Needle

Sawcut and match exist. ramp

Sawcut and level portion of raised island (6"x18"±)

Sawcut and match exist. gutter

Sawcut and match exist. ramp

48"x50" Landing area

retaining rockwall

Technical infeasibility
comment to be filed

CURB RAMP NO. 10104-1 DETAILS
Scale: 1" = 5'

STATE OF HAWAII
DEPARTMENT OF TRANSPORTATION
HIGHWAYS DIVISION
MAIN ST./HIGH ST. (101)
CURB RAMP PLAN
CURB RAMP REPAIRS
AT VARIOUS LOCATIONS, MAUI
Project No. HWY-M-02-05M
Scale: As Shown Date: February 2005

CURB RAMP NO. 10104-1 DETAILS
Scale: 1"= 5'

**Technical infeasibility statement to be filed*


STATE OF HAWAII
DEPARTMENT OF TRANSPORTATION
HIGHWAYS DIVISION

MAIN ST./HIGH ST. (10104)
CURB RAMP PLAN
CURB RAMP REPAIRS
AT VARIOUS LOCATIONS, MAUI
Project No. HWY-M-02-05M

Scale: As Shown Date: February, 2005


SHEET No. CC-3 OF 19 SHEETS

FED. ROAD DIST. NO.	STATE	PROJ. NO.	FISCAL YEAR	SHEET NO.	TOTAL SHEETS
HAWAII	HAW.	HWY-M-02-05M	2005	18	44

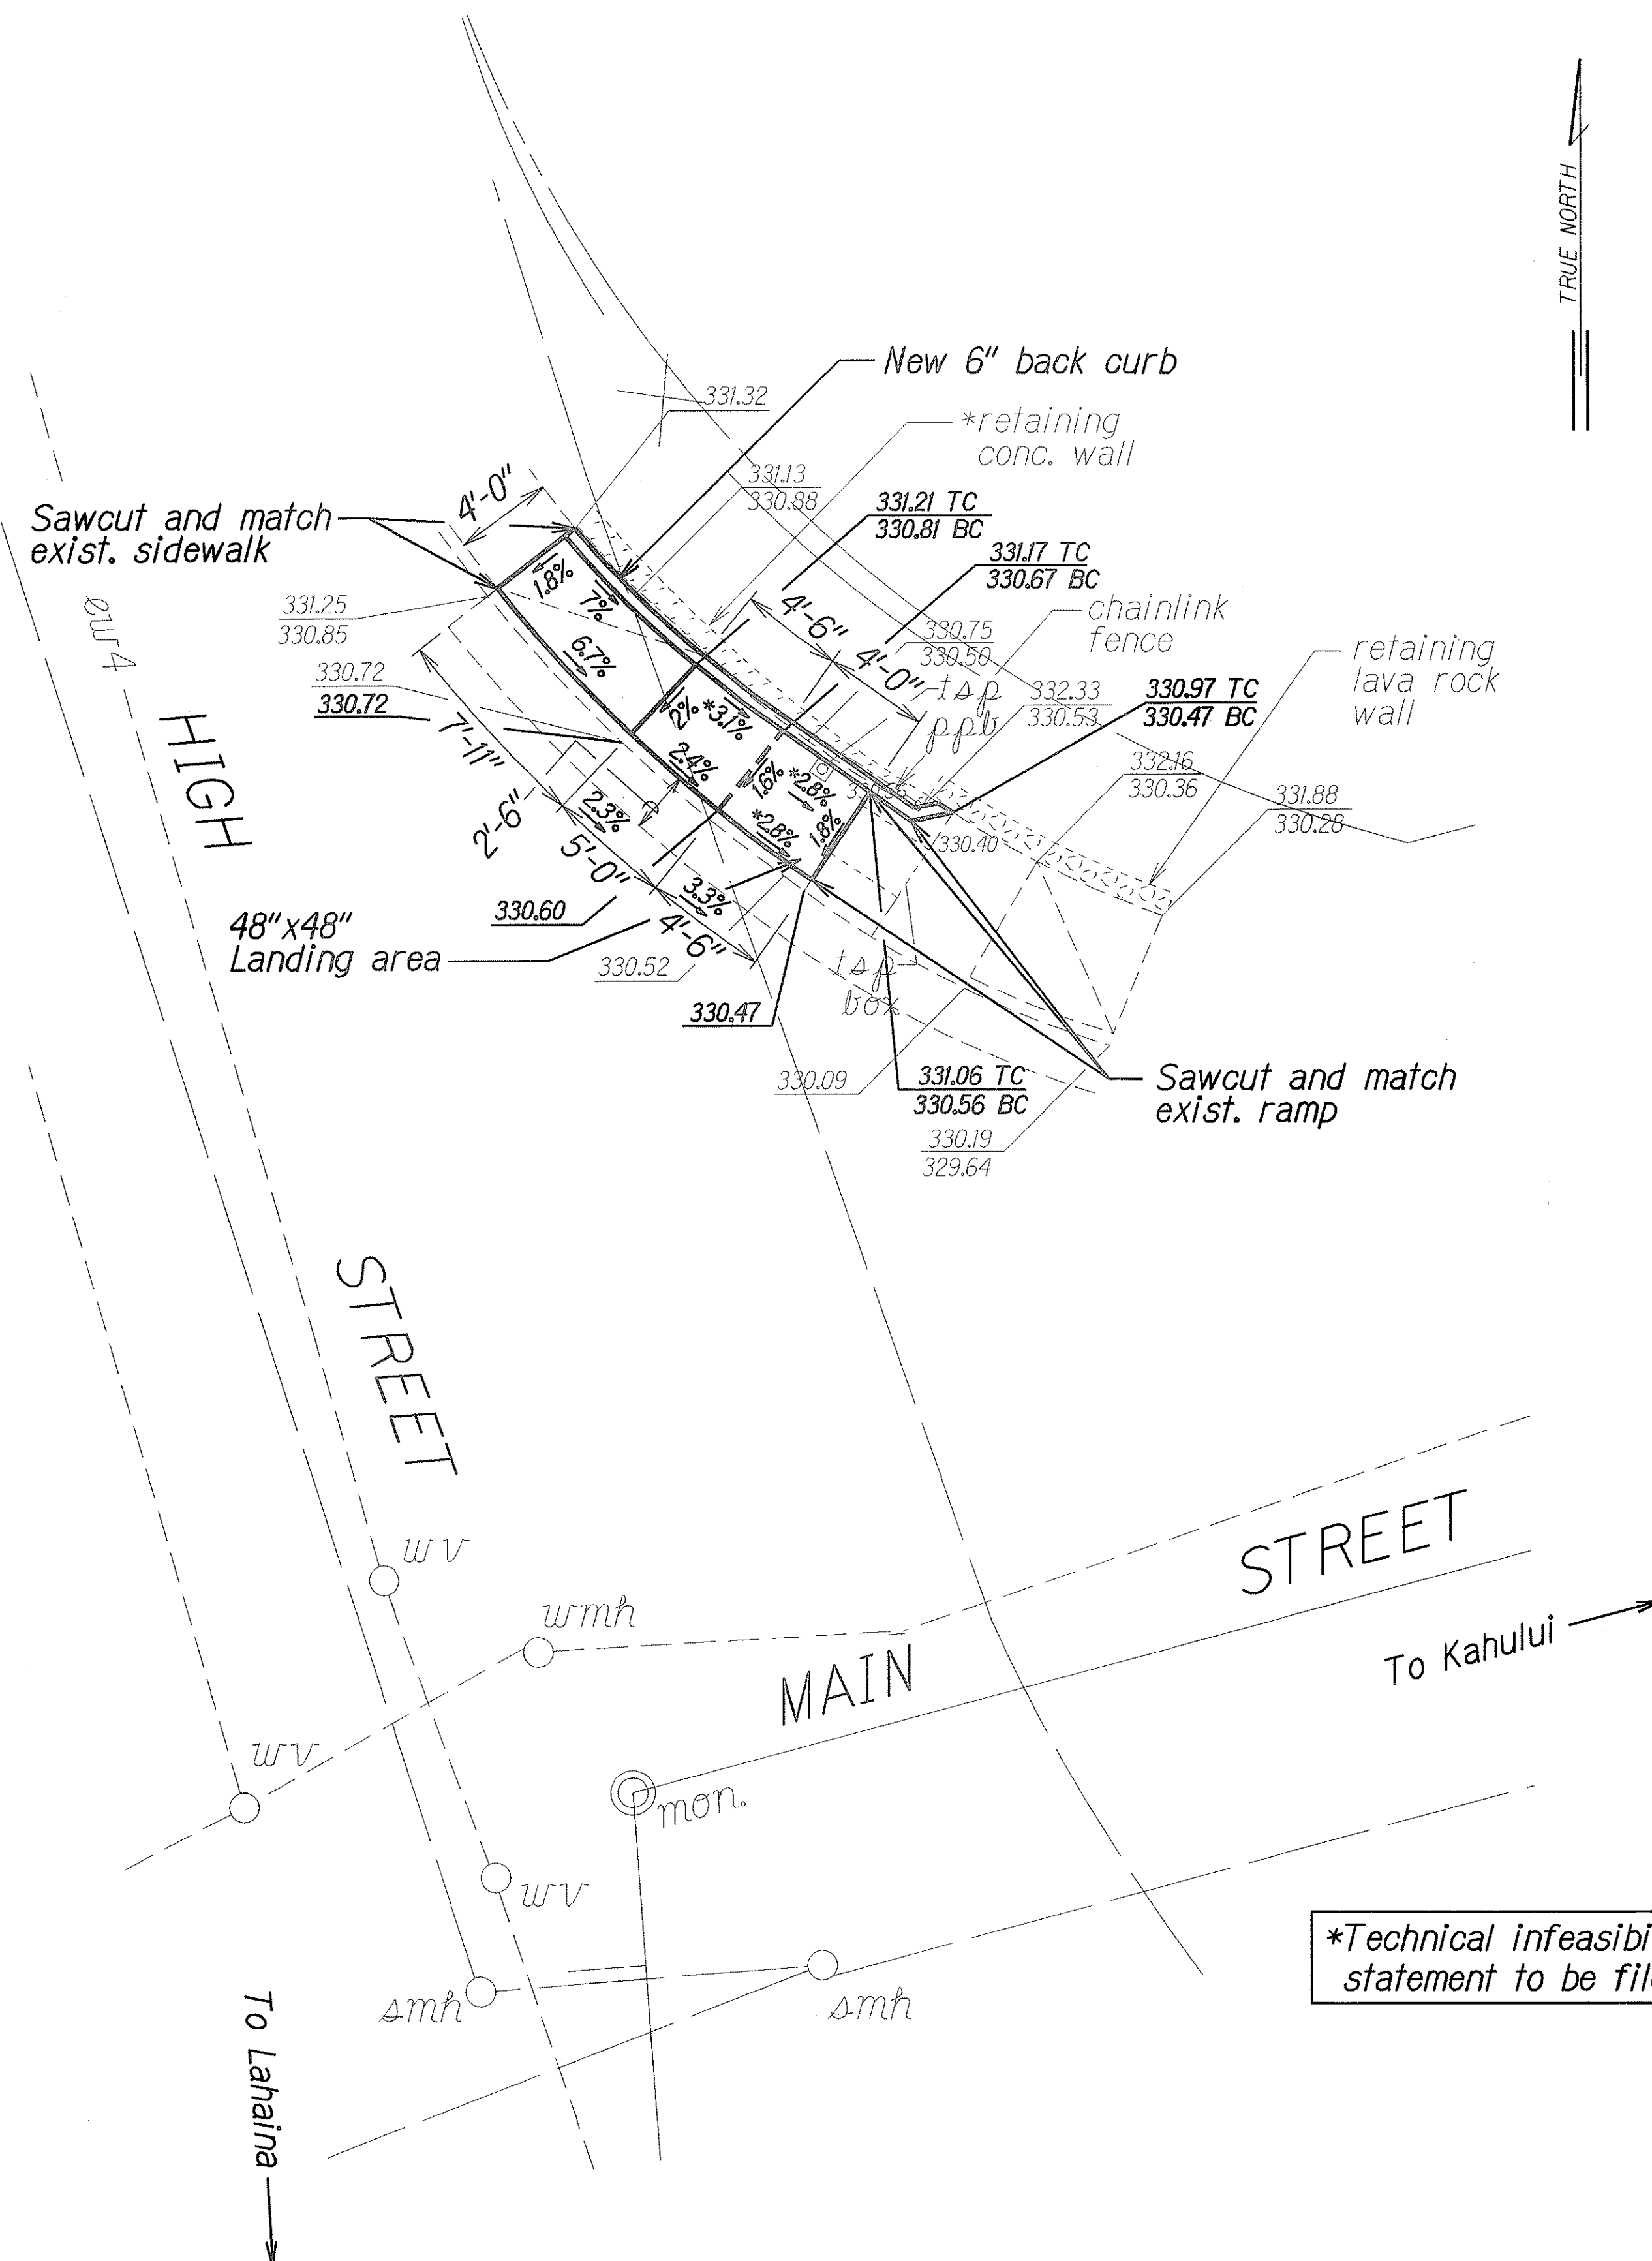

CURB RAMP NO. 10104-4 DETAILS
Scale: 1"= 5'

*Technical infeasibility statement to be filed

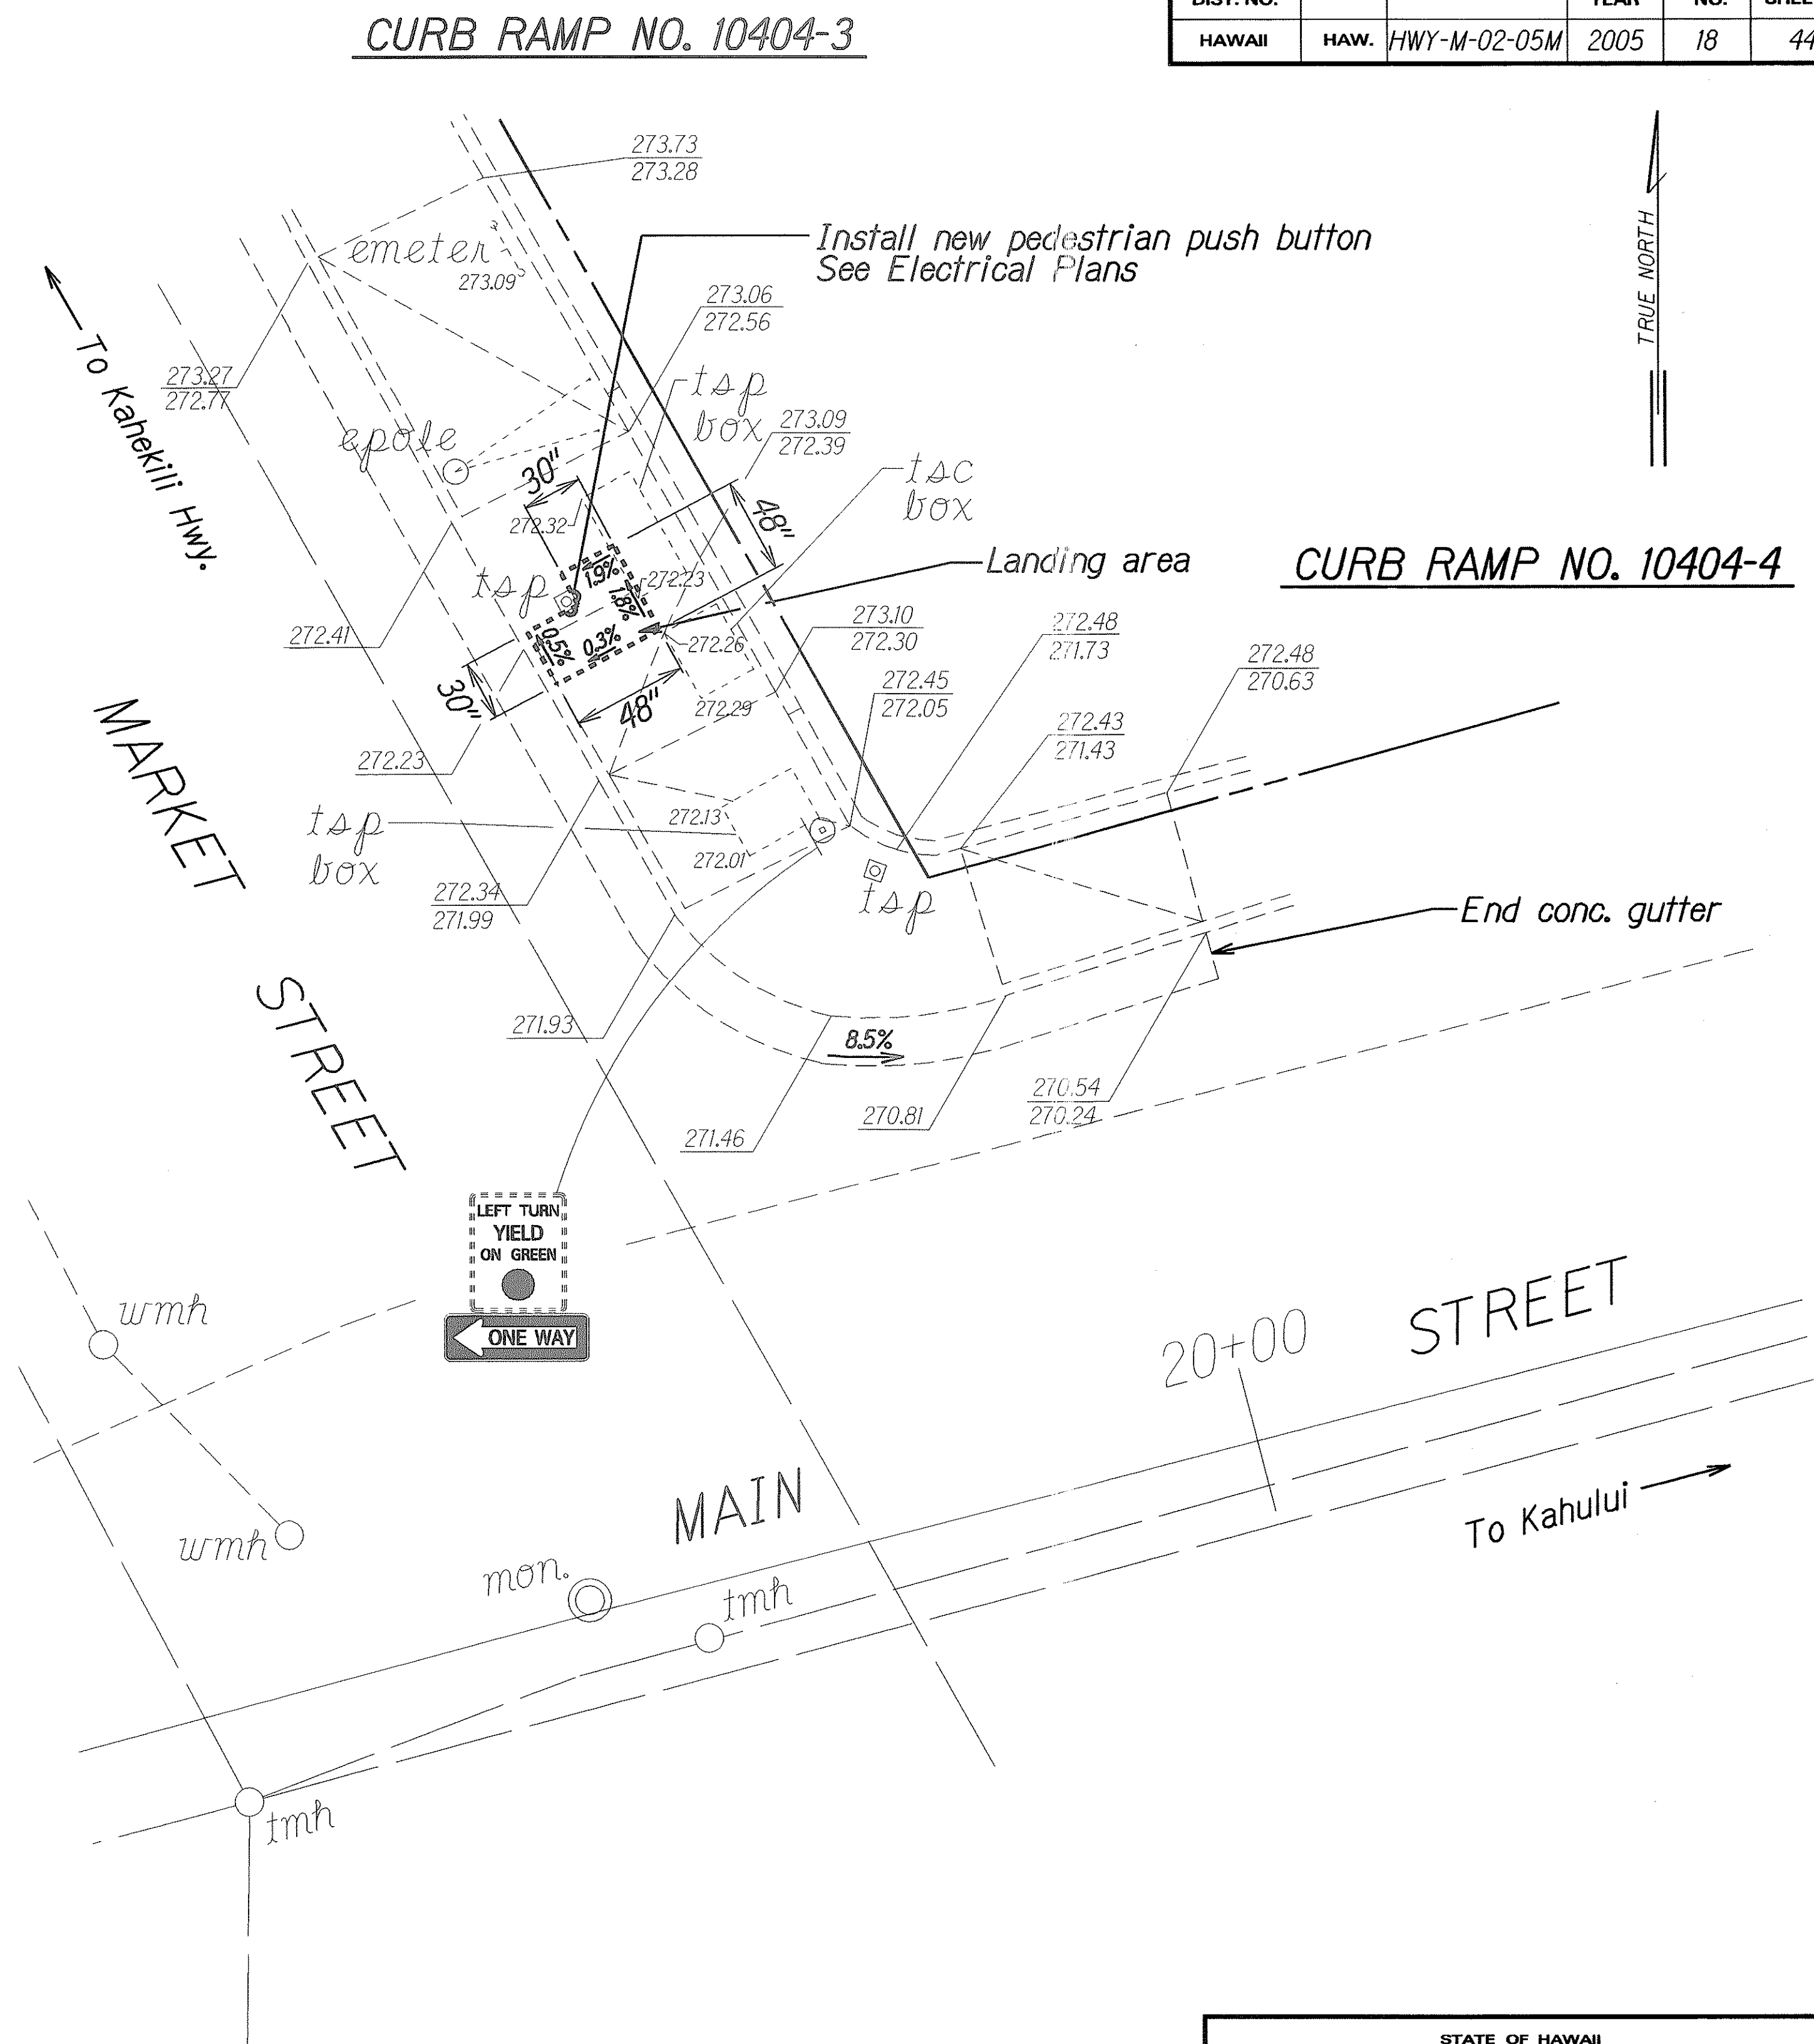

CURB RAMP NO. 10404-3 & -4 DETAILS
Scale: 1"= 5'



STATE OF HAWAII
DEPARTMENT OF TRANSPORTATION
HIGHWAYS DIVISION

MAIN ST./MARKET ST. (10104)
CURB RAMP PLAN
CURB RAMP REPAIRS
AT VARIOUS LOCATIONS, MAUI
Project No. HWY-M-02-05M


Scale: As Shown Date: February, 2005

SHEET No. CC-4 OF 19 SHEETS

FED. ROAD DIST. NO.	STATE	PROJ. NO.	FISCAL YEAR	SHEET NO.	TOTAL SHEETS
HAWAII	HAW.	HWY-M-02-05M	2005	19	44

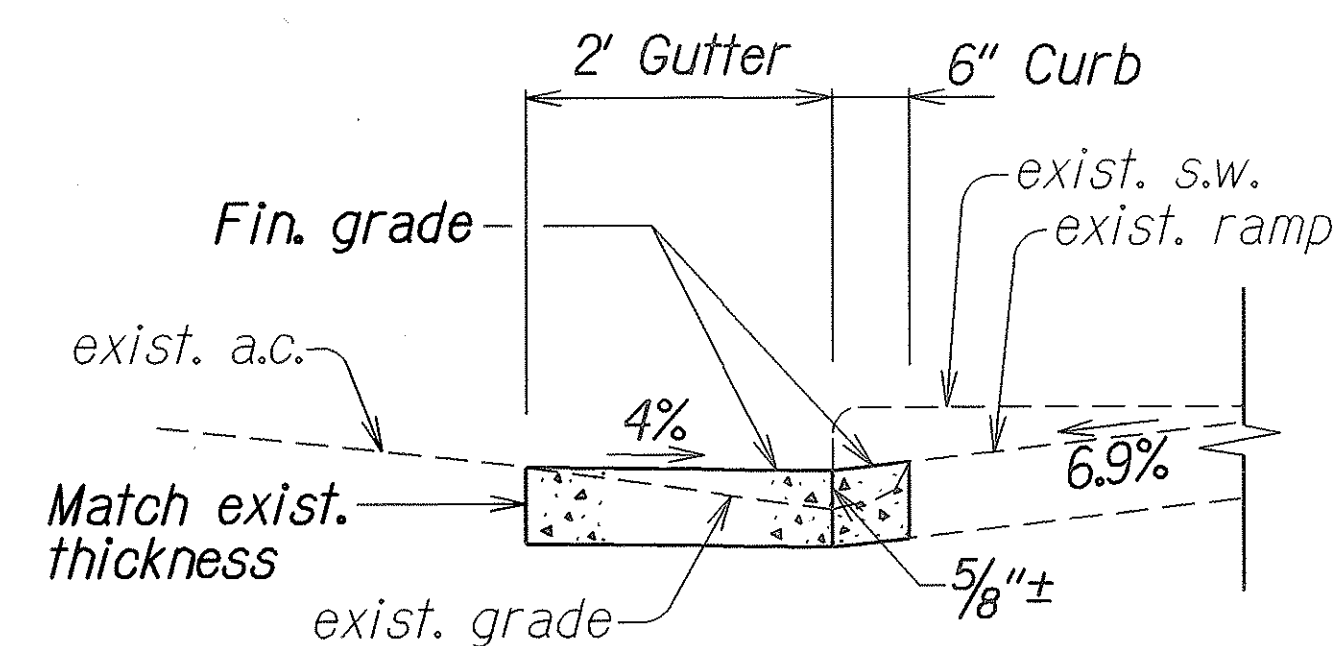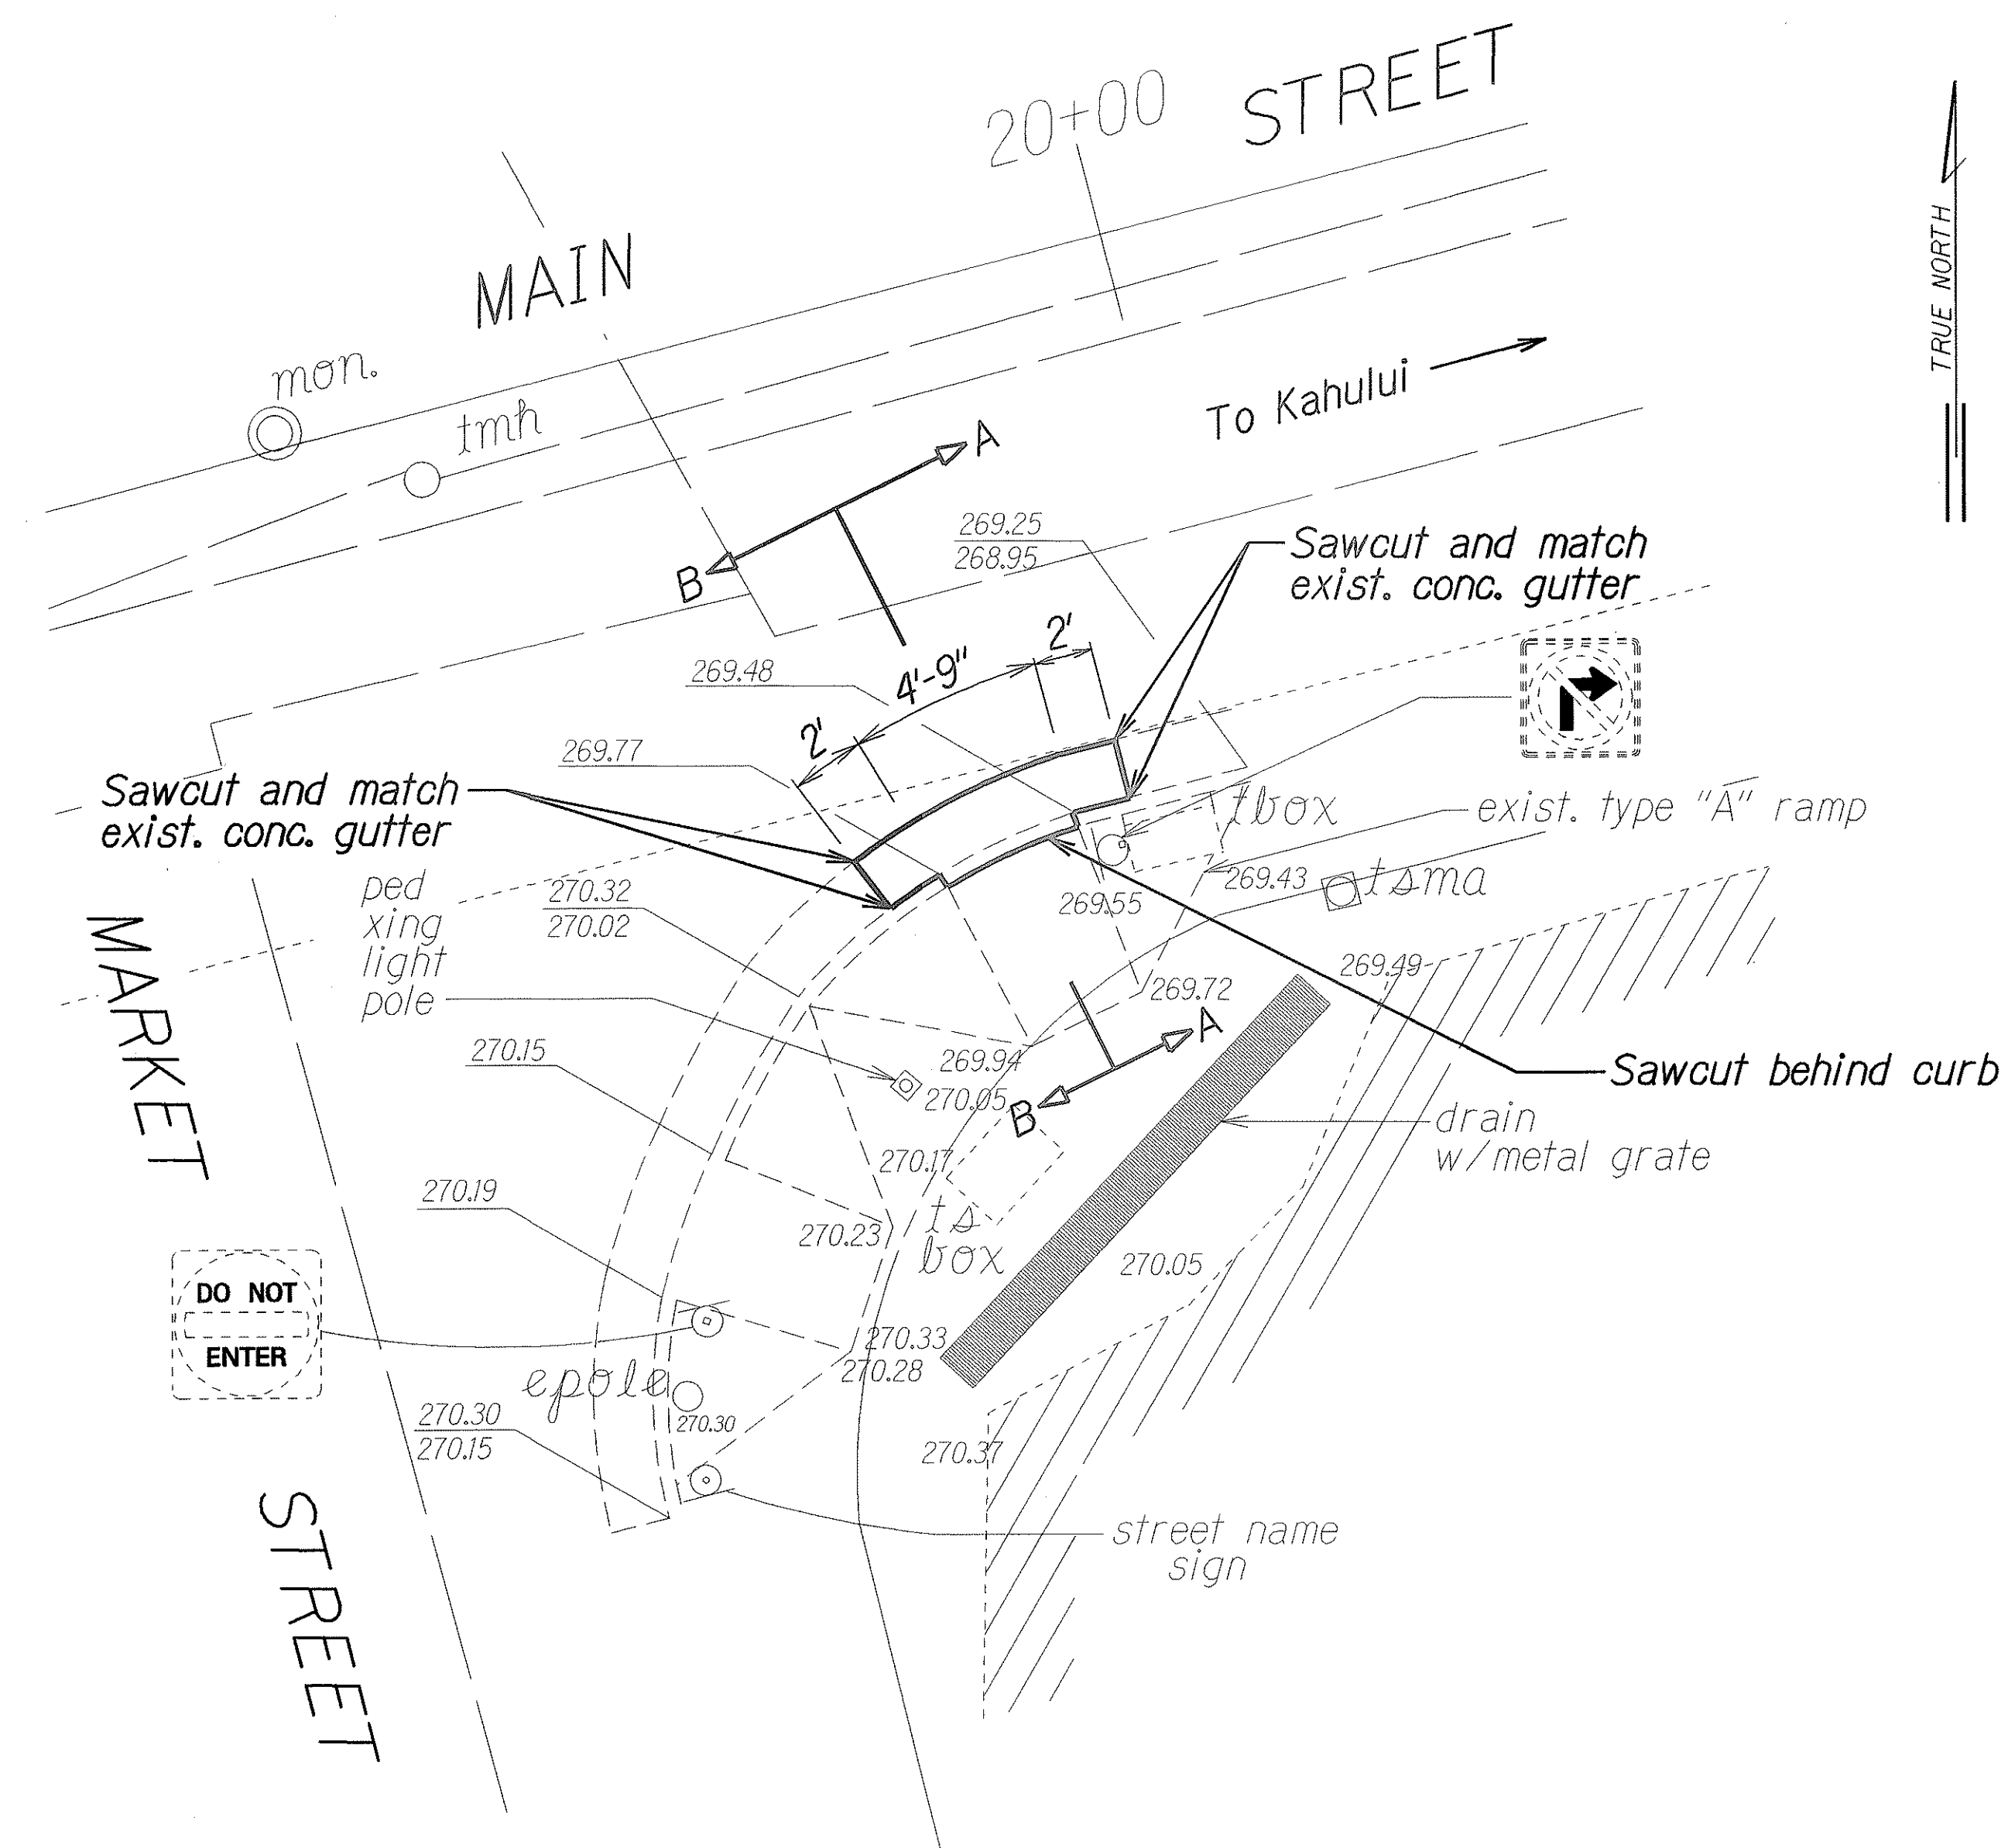


SECTION A-A
Not To Scale

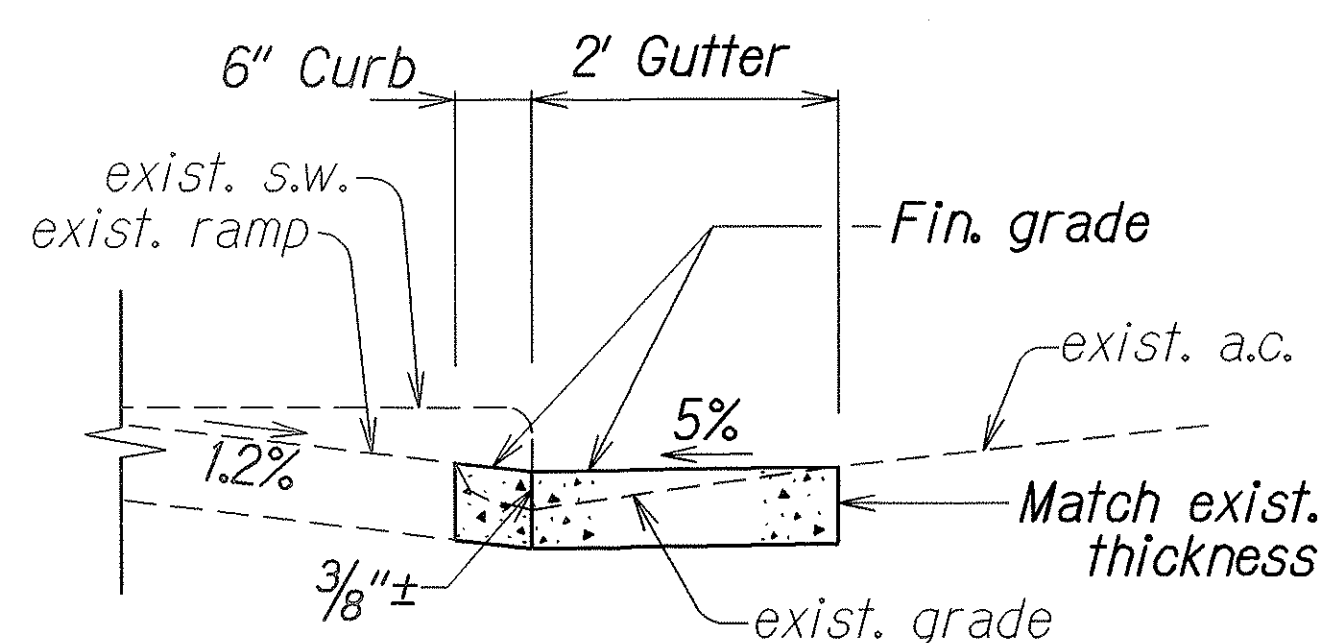

SECTION B-B
Not To Scale

CURB RAMP NO. 10404-5 DETAILS
Scale: 1" = 5'

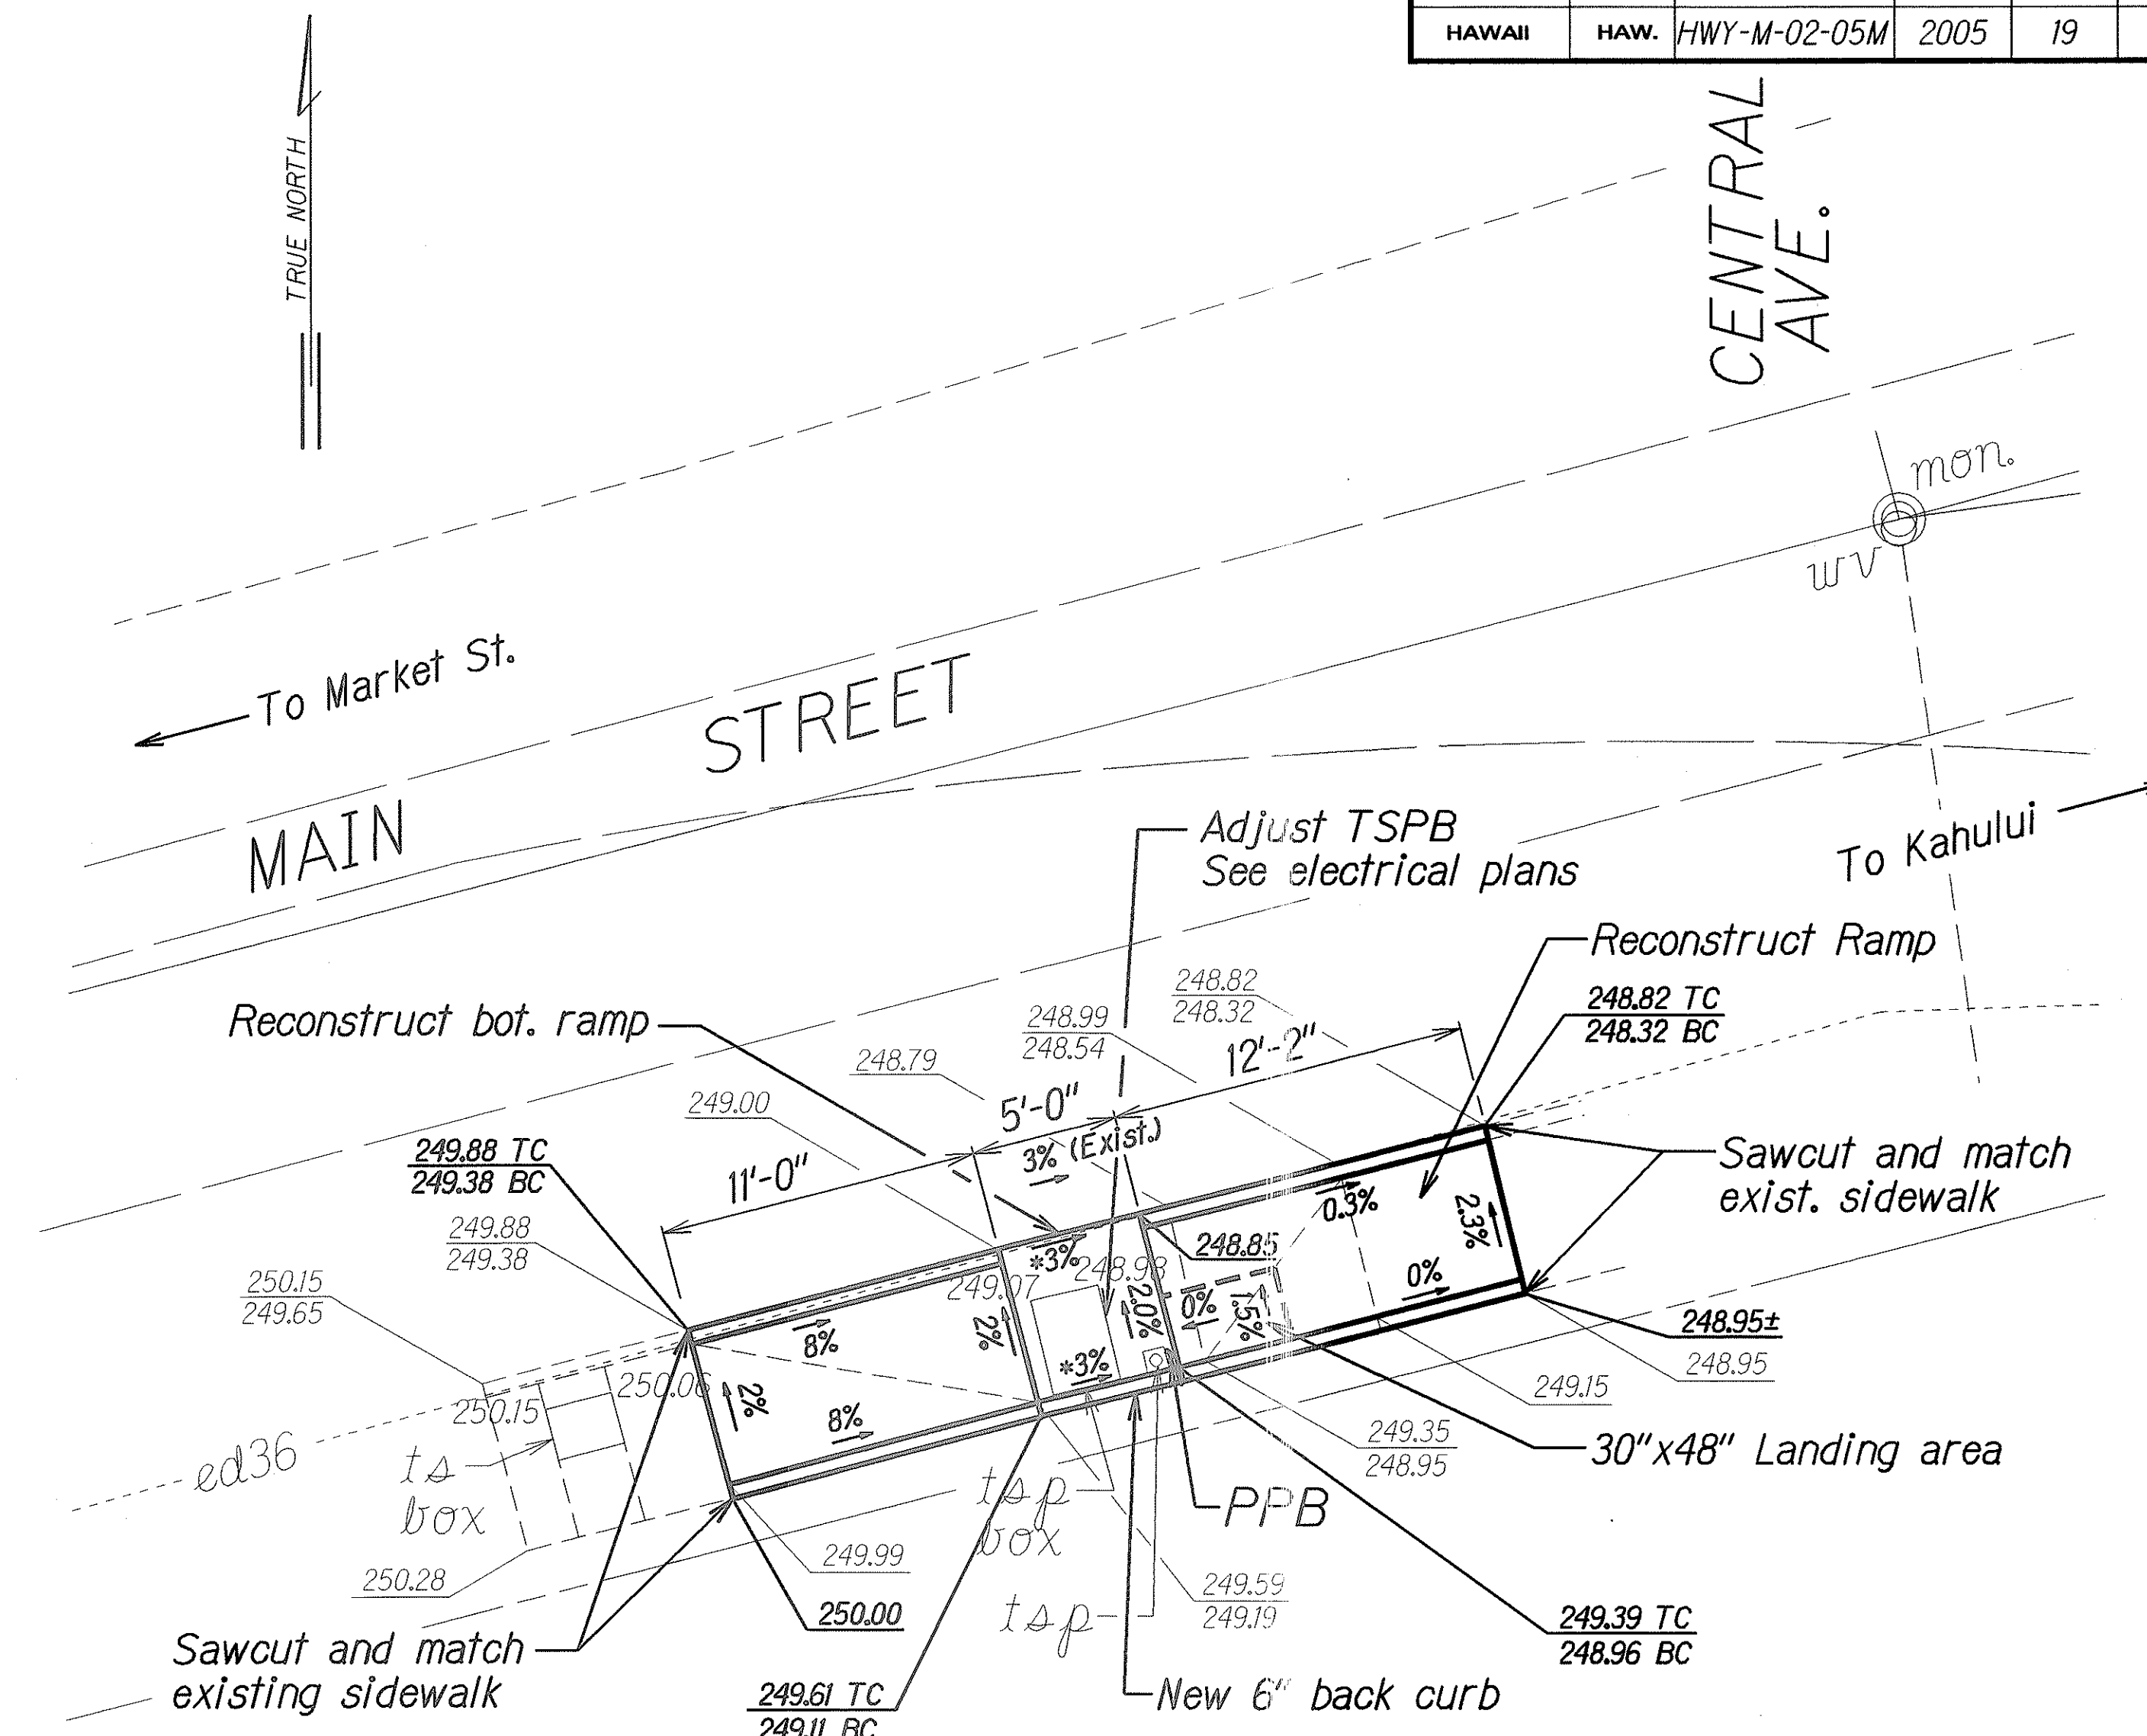


CURB RAMP NO. 10504-1 DETAILS
Scale: 1" = 5'

*Technical infeasibility statement to be filed


STATE OF HAWAII
DEPARTMENT OF TRANSPORTATION
HIGHWAYS DIVISION
MAIN ST./MARKET ST./ (10104)
CENTRAL AVE. (10504) CURB RAMP PLAN
CURB RAMP REPAIRS
AT VARIOUS LOCATIONS, MAUI
Project No. HWY-M-02-05M
Scale: As Shown Date: February, 2005
SHEET No. CC-5 OF 19 SHEETS

FED. ROAD DIST. NO.	STATE	PROJ. NO.	FISCAL YEAR	SHEET NO.	TOTAL SHEETS
HAWAII	HAW.	HWY-M-02-05M	2005	20	44

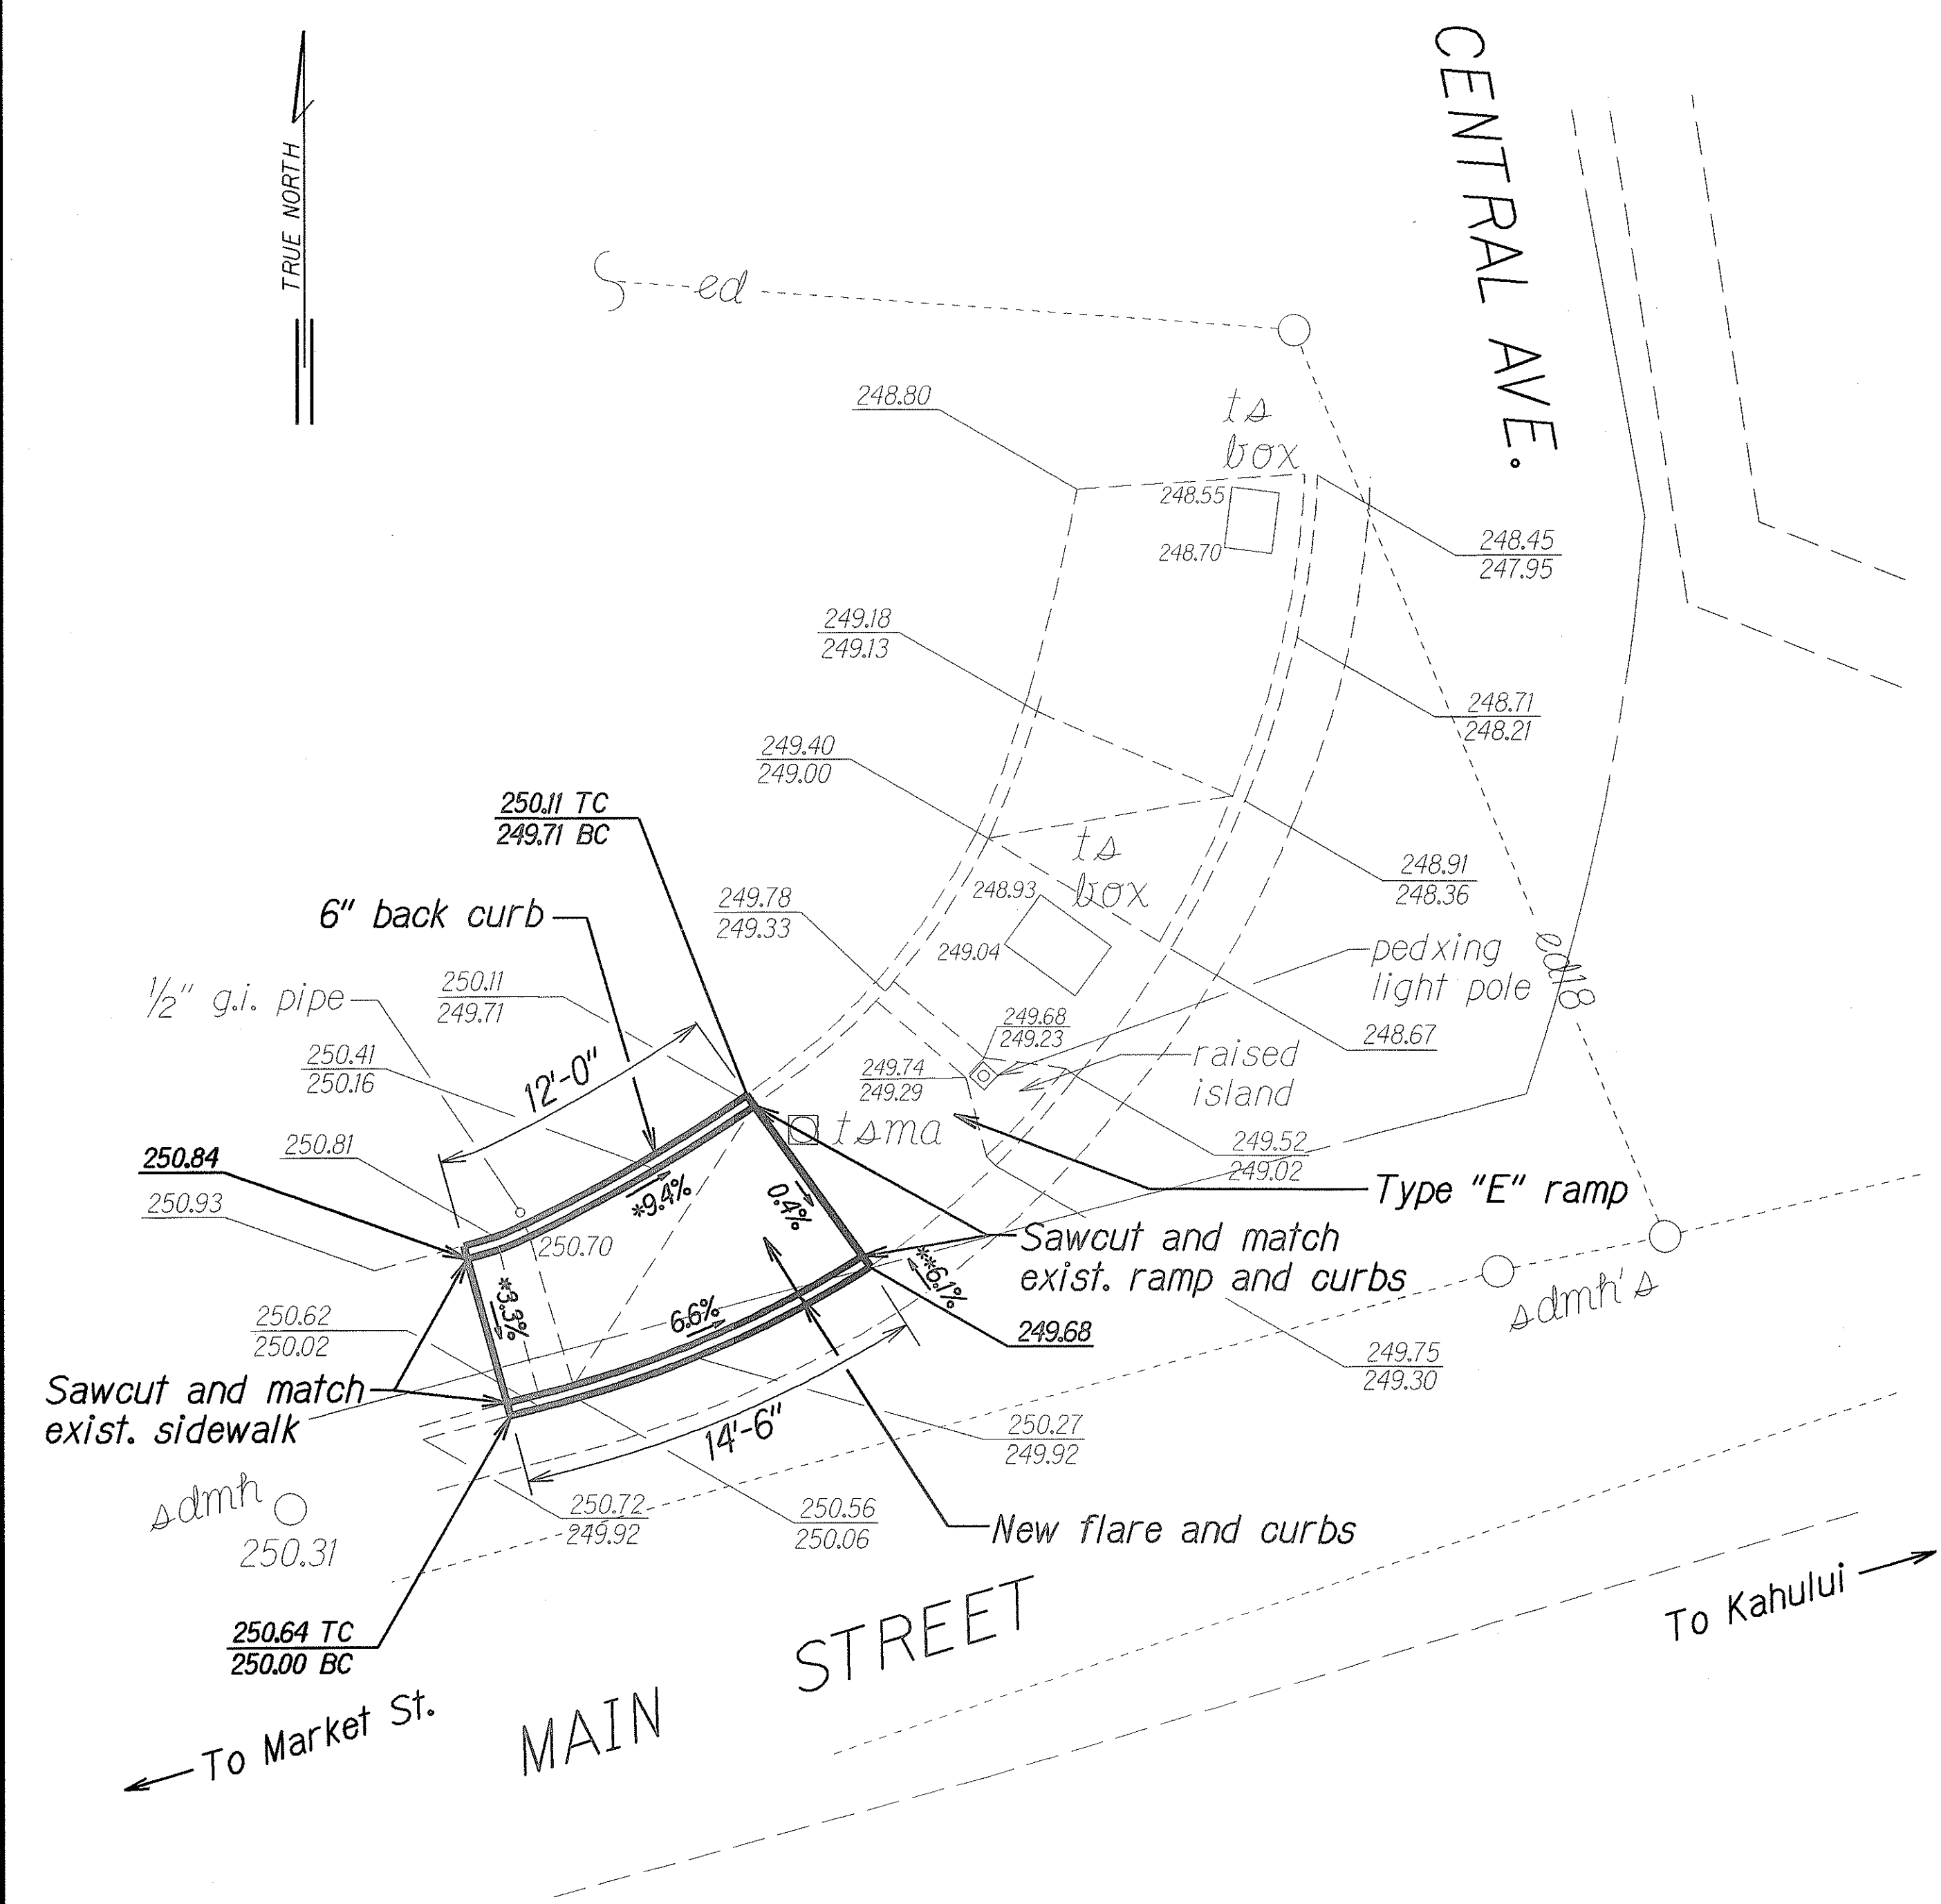

CURB RAMP NO. 10504-2 DETAILS
Scale: 1"= 5'

**Max gutter slope for Type "E" ramp is 8.33% (See curb ramp notes, Sht. No. 8)

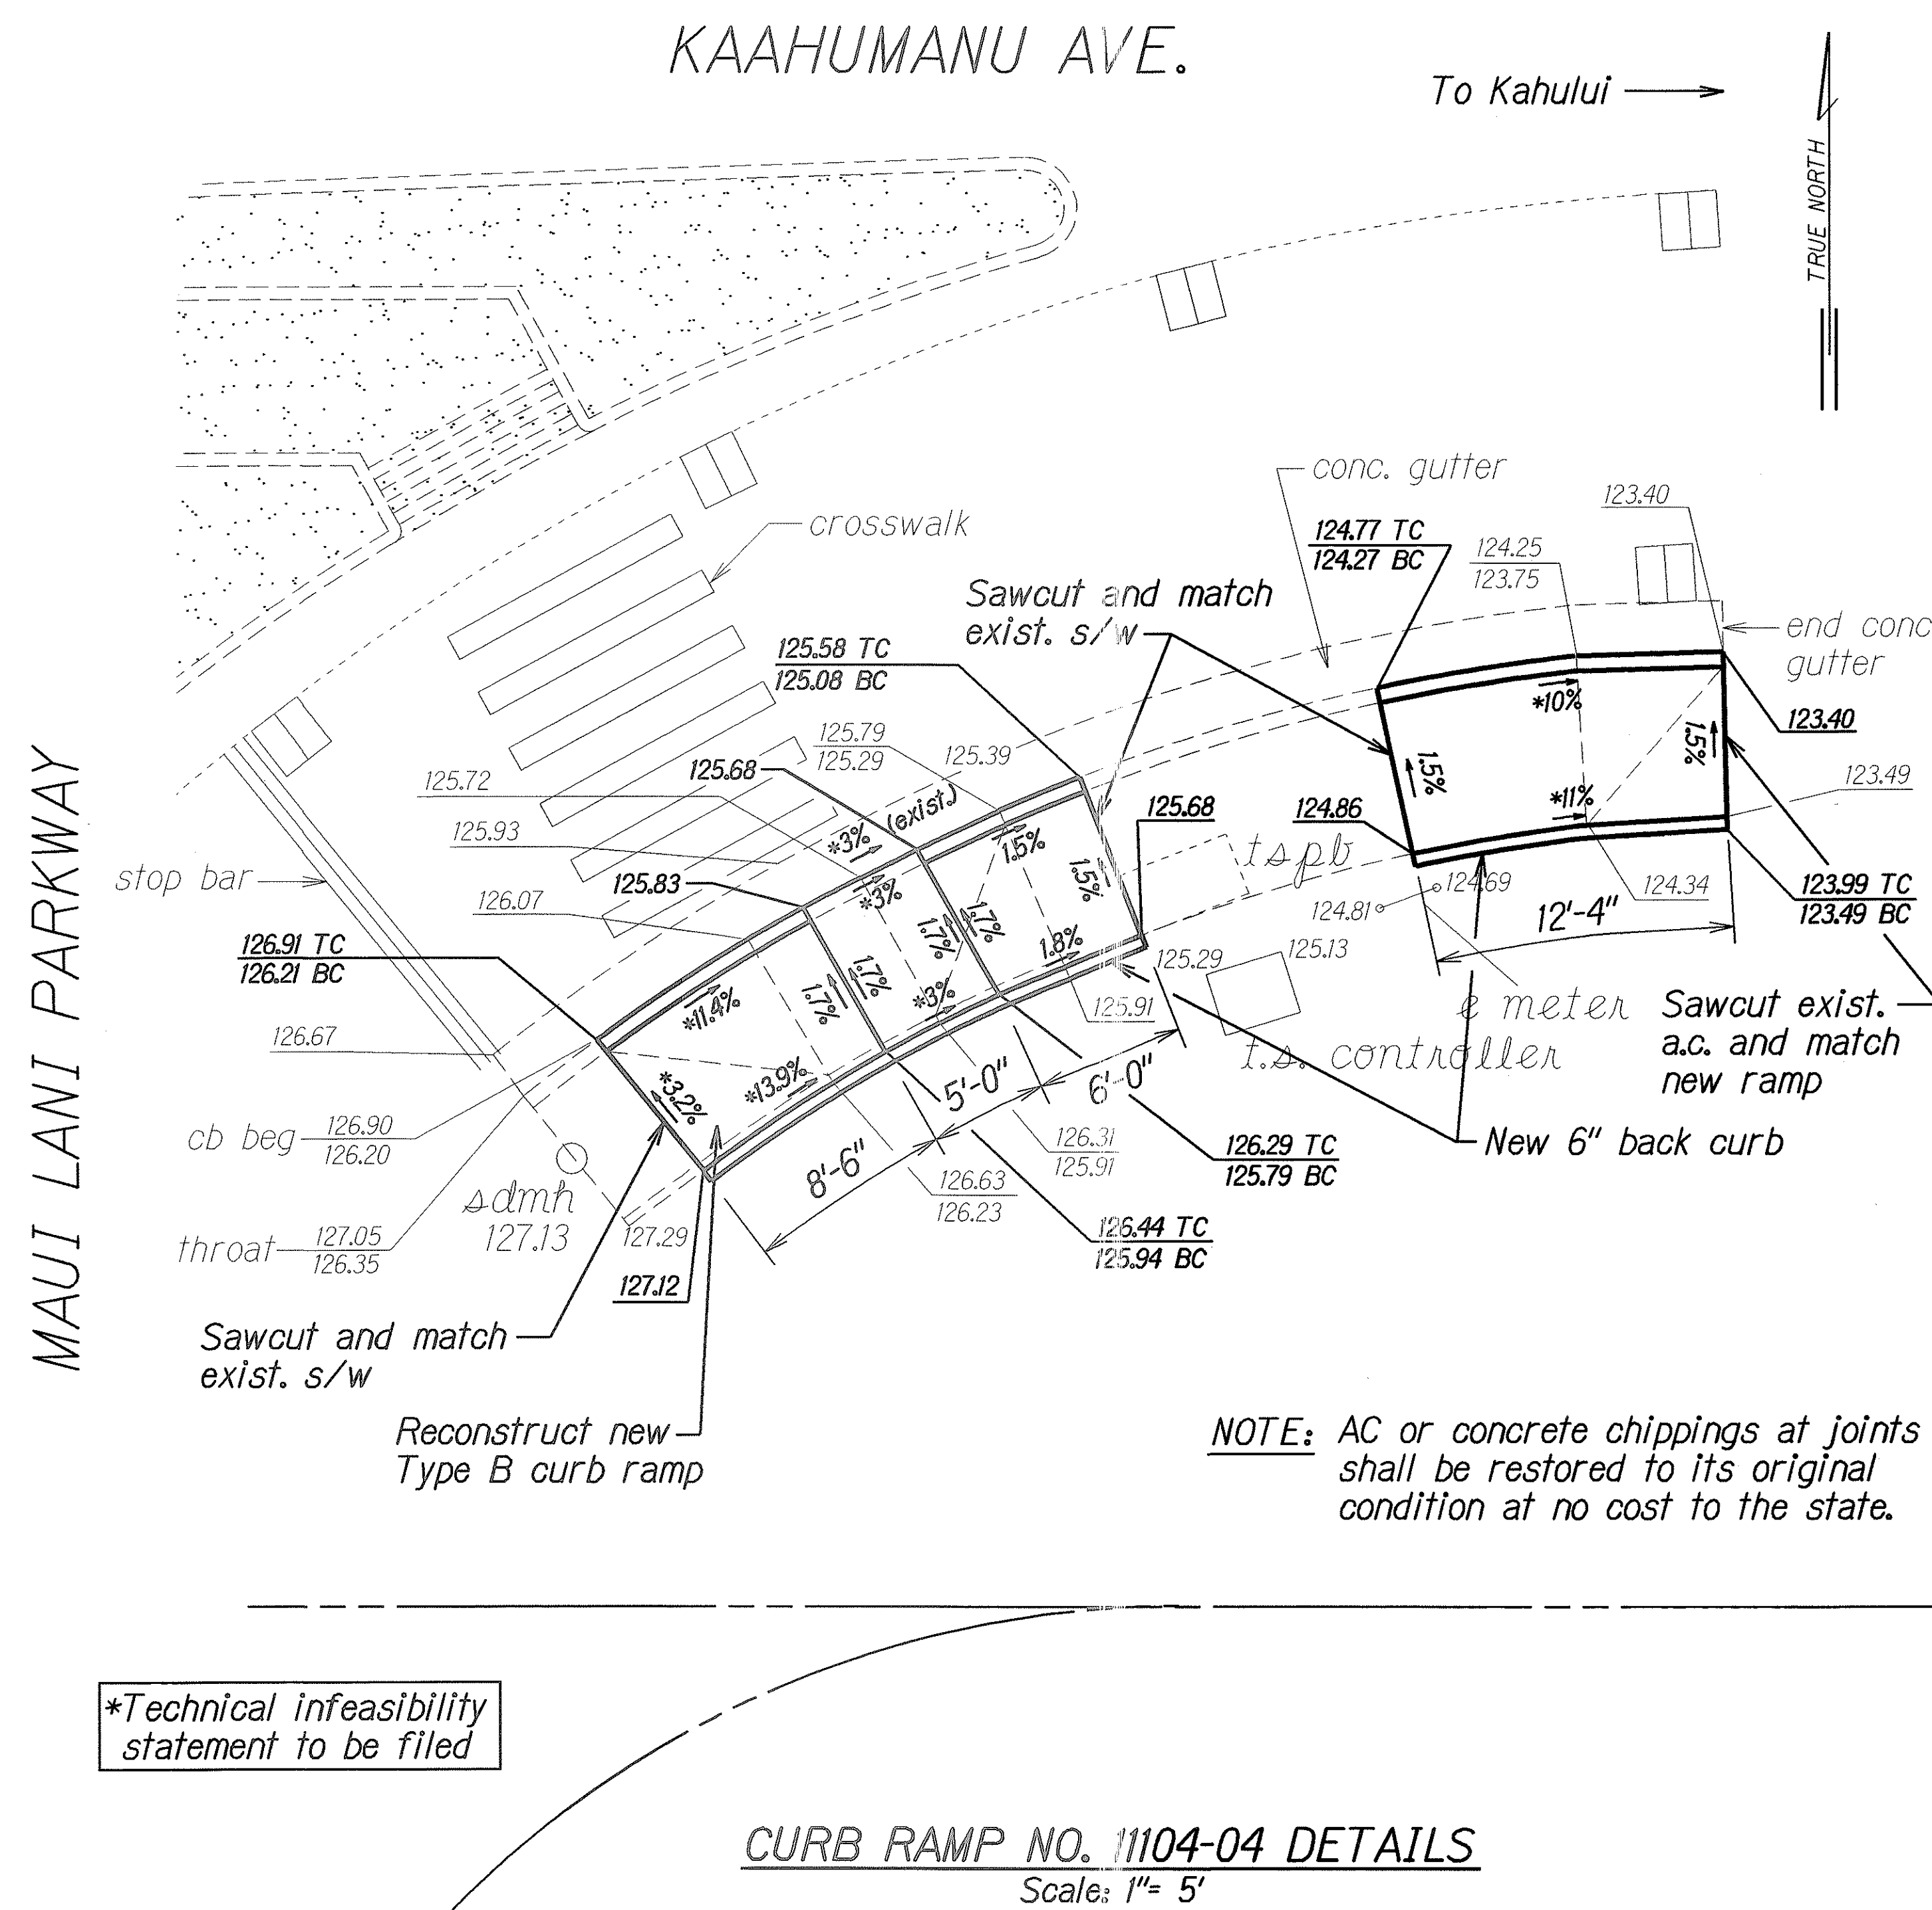

CURB RAMP NO. 11104-04 DETAILS
Scale: 1"= 5'

STATE OF HAWAII
DEPARTMENT OF TRANSPORTATION
HIGHWAYS DIVISION

MAIN ST./CENTRAL AVE. (10504), KAAHUMANU AVE./
MAUI LANI PARKWAY (11104) CURB RAMP PLAN


CURB RAMP REPAIRS AT
VARIOUS LOCATIONS, MAUI
Project No. HWY-M-02-05M

Scale: As Shown Date: February, 2005

SHEET No. CC-6 OF 19 SHEETS


ORIGINAL PLAN	DATE
SURVEY PLOTTED BY	3/05
DRAWN BY	
DESIGNED BY	
CHECKED BY	
NOTED BY	
IN CHARGE	

FED. ROAD DIST. NO.	STATE	PROJ. NO.	FISCAL YEAR	SHEET NO.	TOTAL SHEETS
HAWAII	HAW.	HWY-M-02-05M	2005	21	44

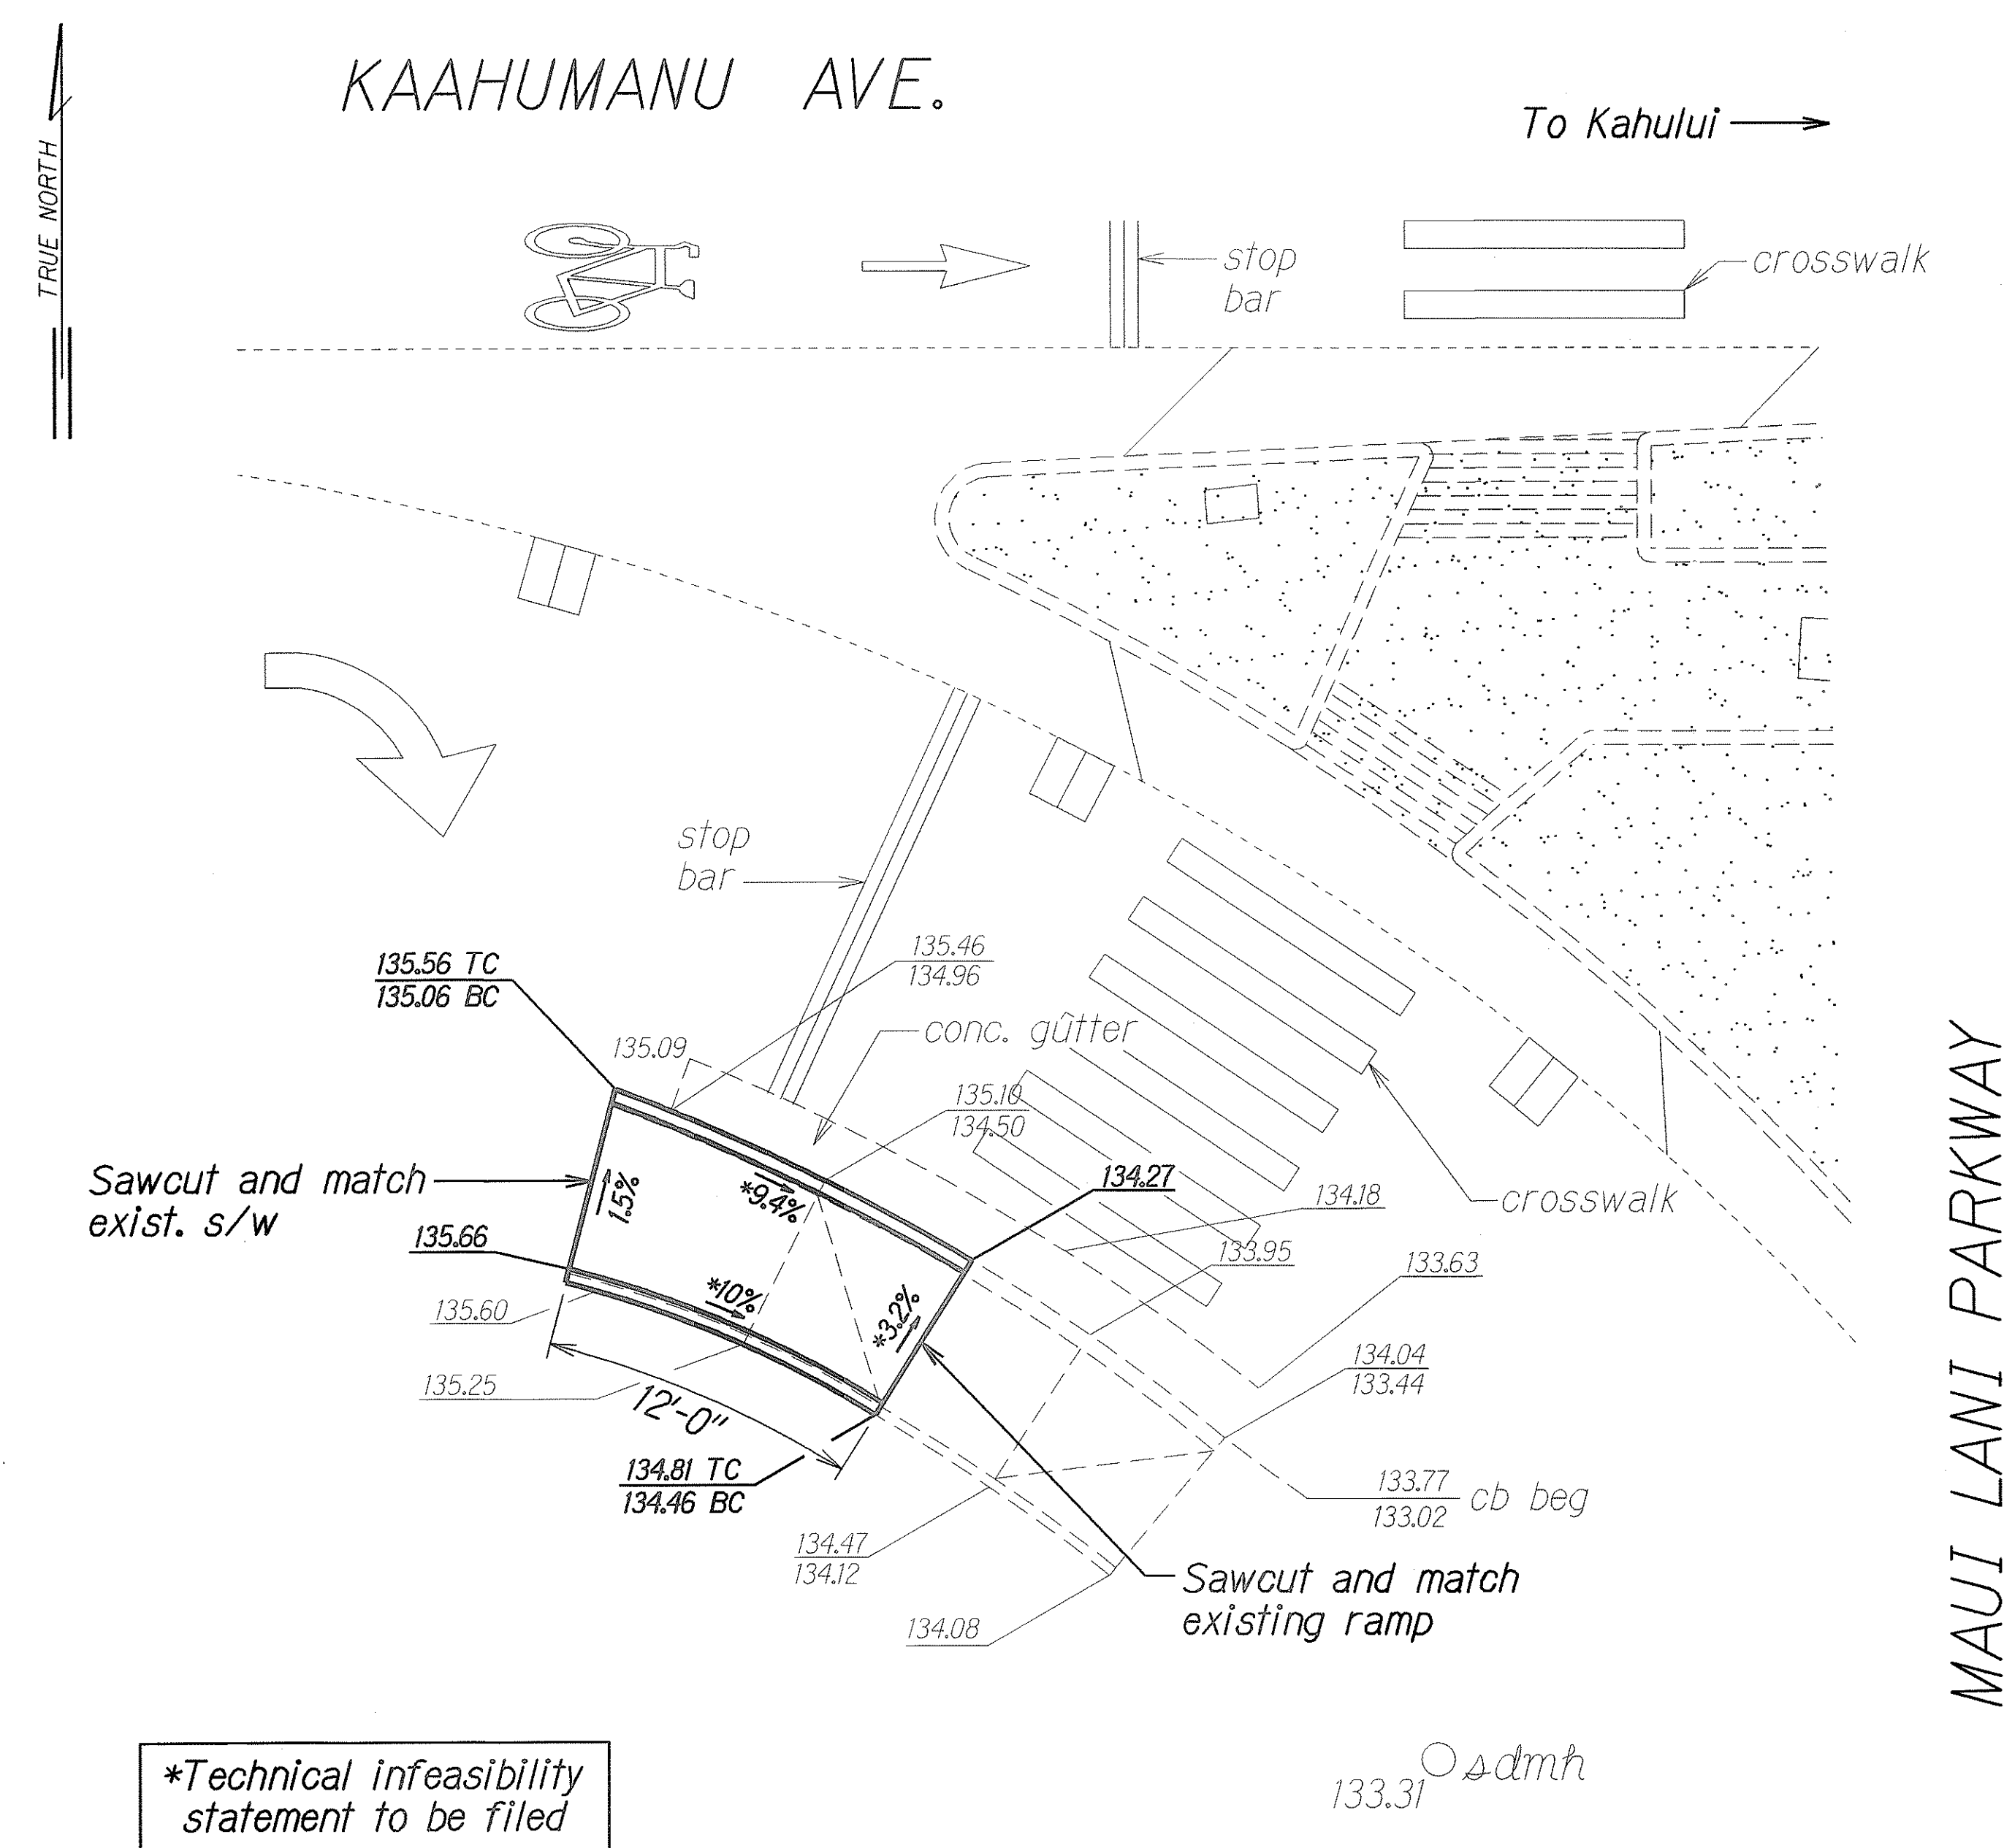

CURB RAMP NO. 11104-10 DETAILS
Scale: 1"= 5'

ORIGINAL PLAN	SURVEY PLOTTED BY	DATE
NOTE BOOK	DRAWN BY	3/05
re-ley	TRACED BY	
psdgn	QUANTITIES BY	
	CHECKED BY	

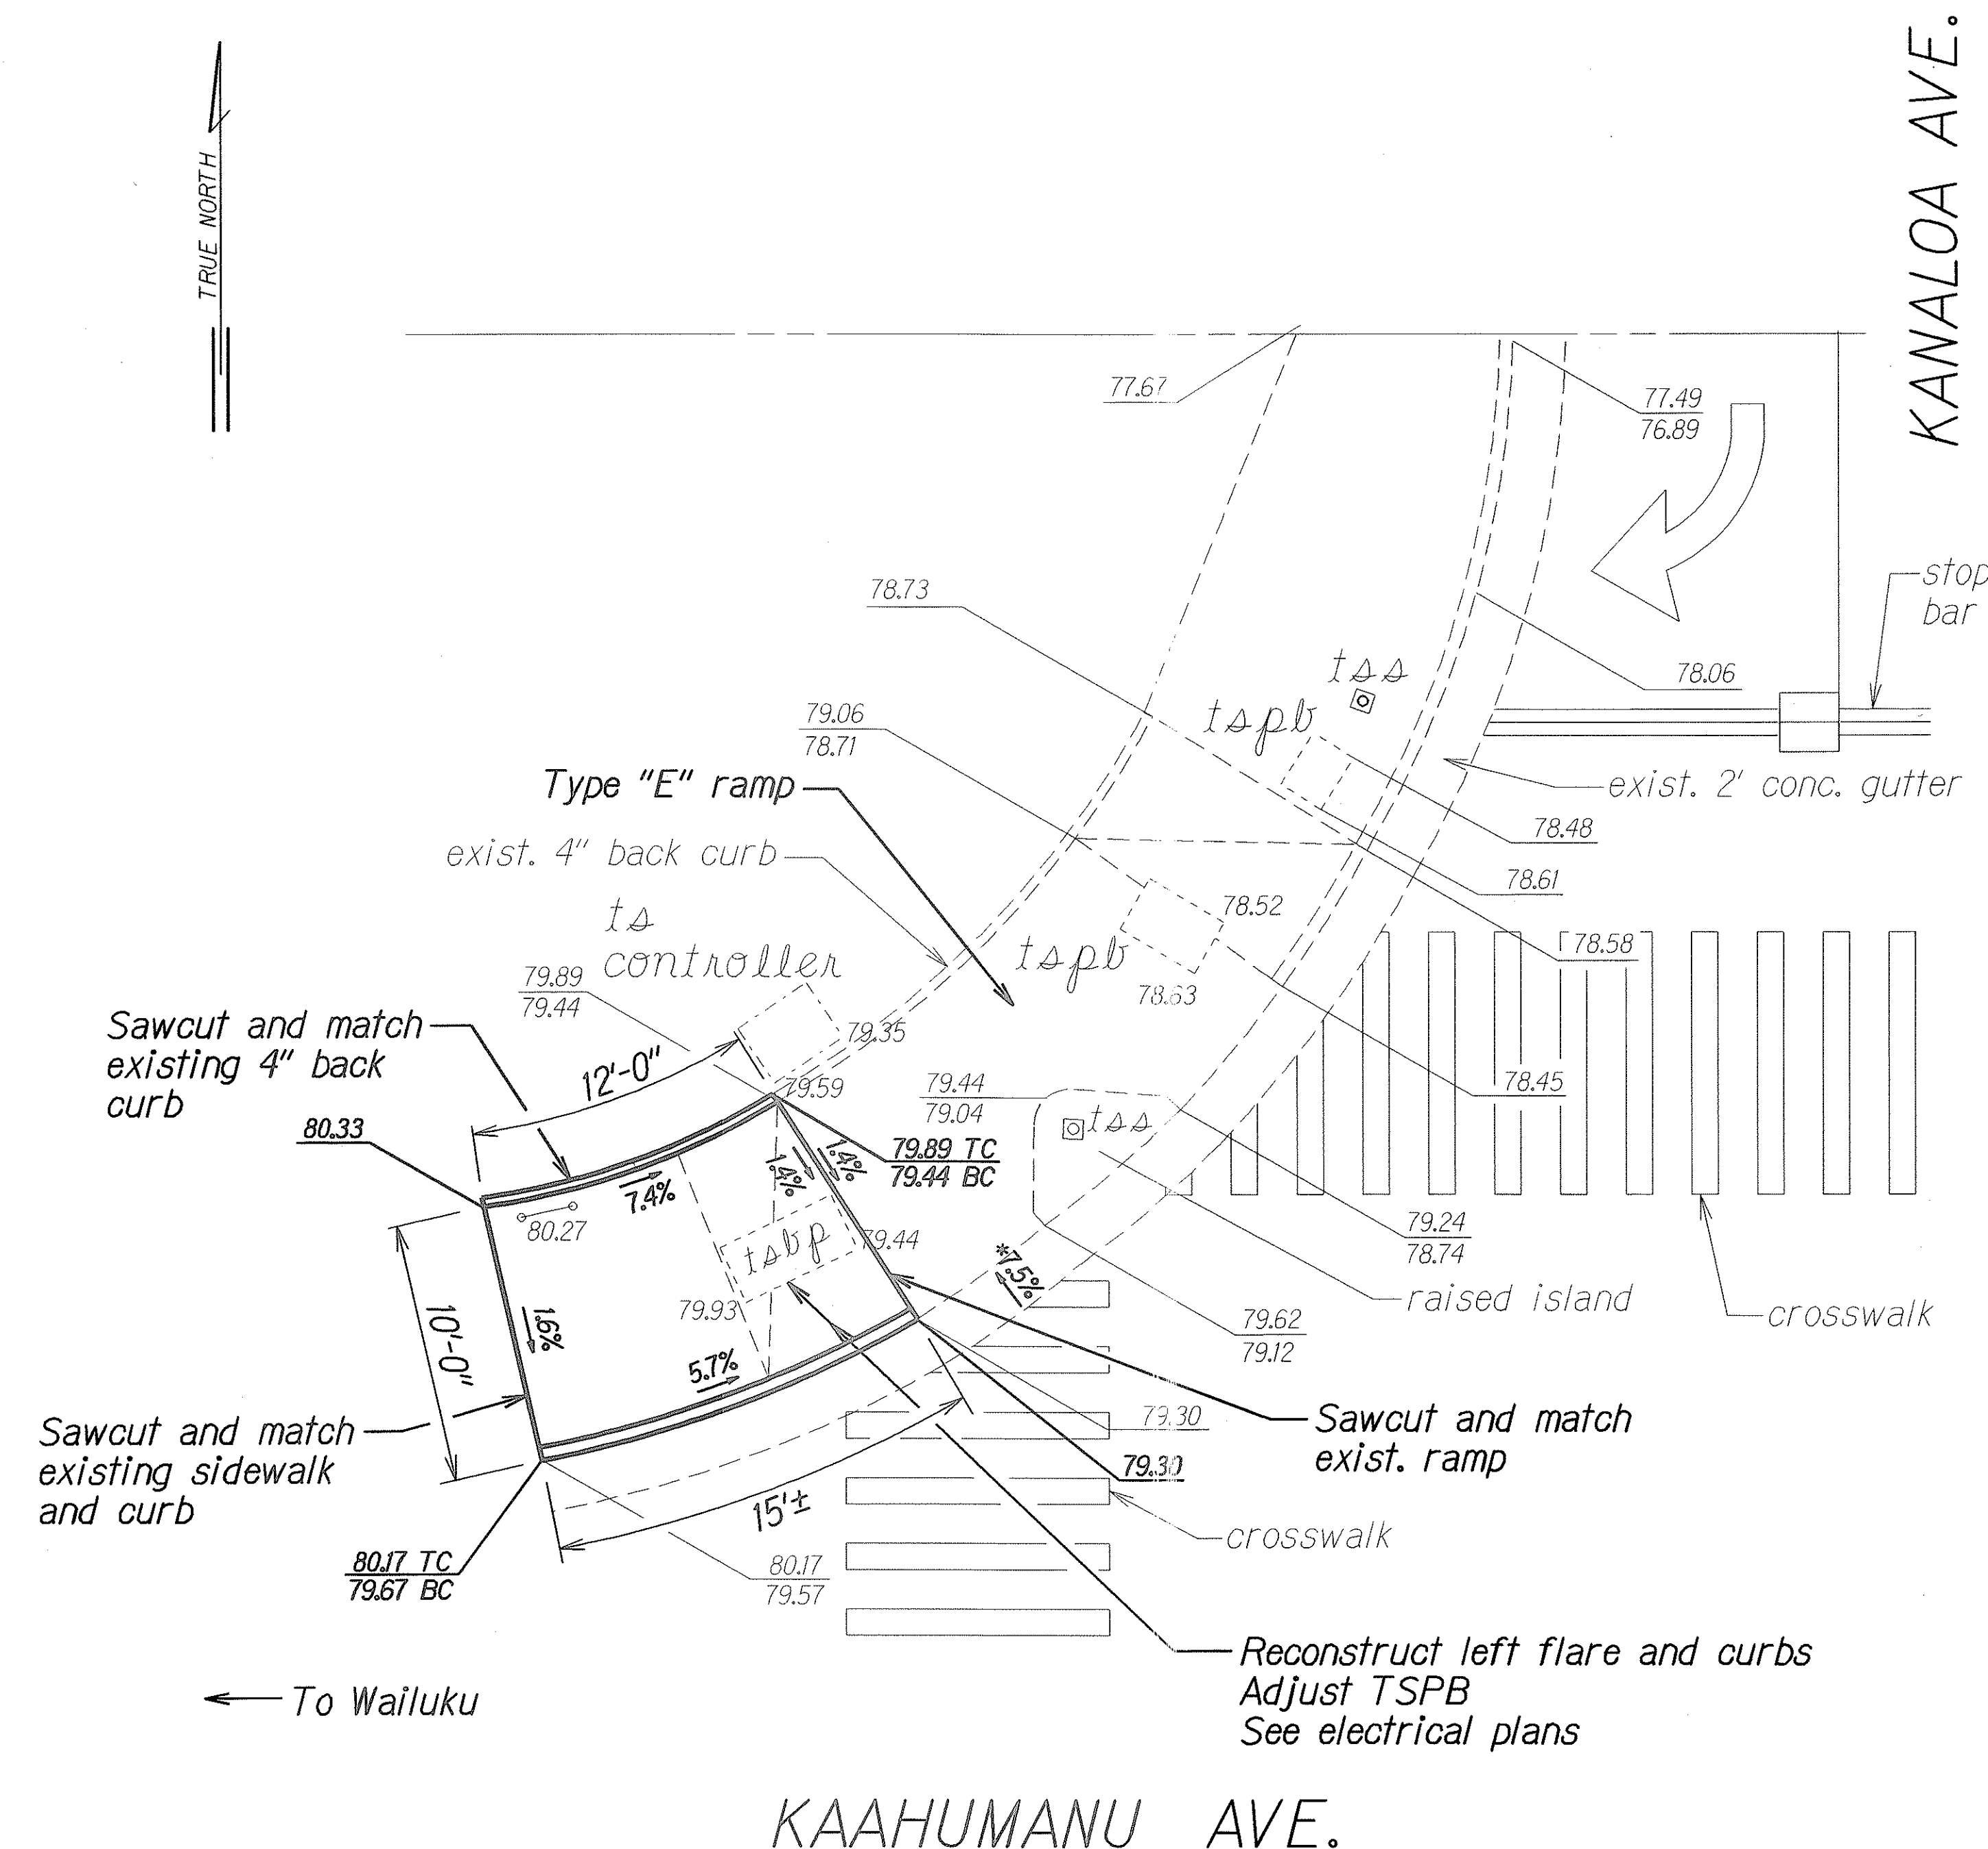

CURB RAMP NO. 11204-1 DETAILS
Scale: 1"= 5'

*Max. gutter slope for Type "E" ramp is 8.33% (See curb ramp notes, Shf. No. 8)

STATE OF HAWAII
DEPARTMENT OF TRANSPORTATION
HIGHWAYS DIVISION

**KAAHUMANU AVE./MAUI LANI PARKWAY (11104)/
KANALOA AVE. (11204) CURB RAMP PLAN**


**CURB RAMP REPAIRS AT
VARIOUS LOCATIONS, MAUI**

Project No. HWY-M-02-05M

Scale: As Shown Date: February, 2005

SHEET No. CC-7 OF 19 SHEETS

FED. ROAD DIST. NO.	STATE	PROJ. NO.	FISCAL YEAR	SHEET NO.	TOTAL SHEETS
HAWAII	HAW.	HWY-M-02-05M	2005	22	44

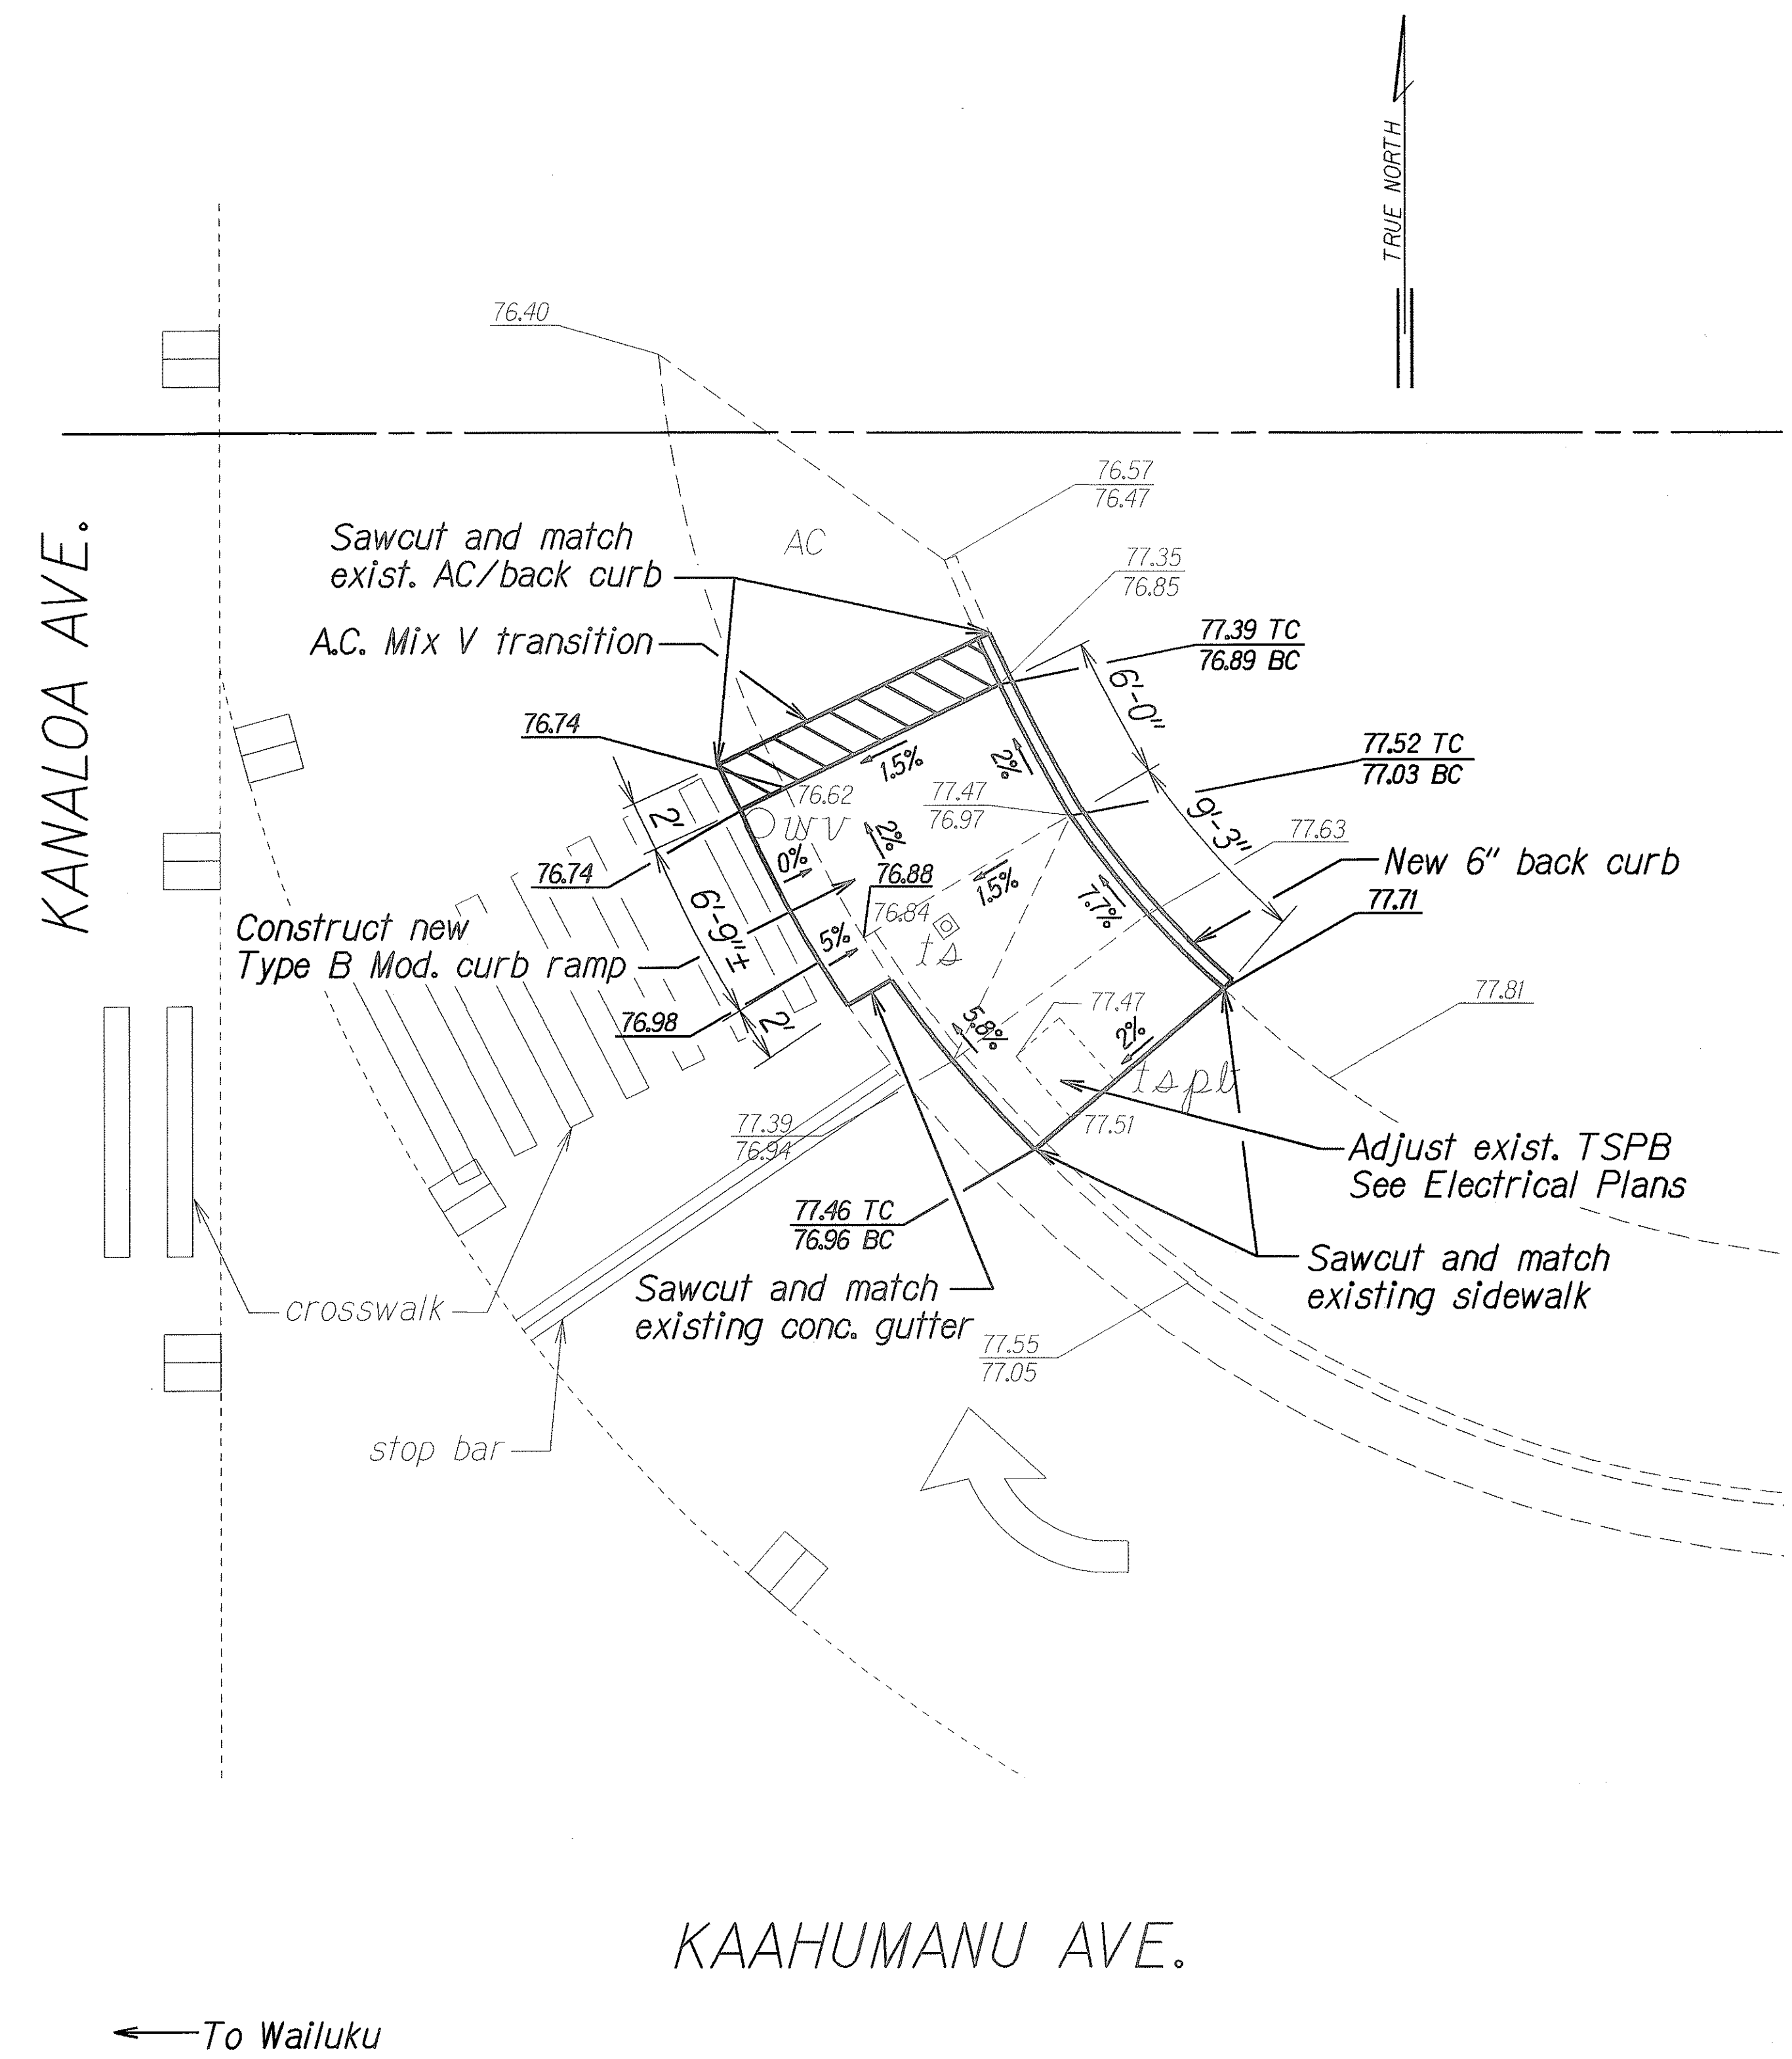

CURB RAMP NO. 11204-5 DETAILS
 Scale: 1"= 5'

ORIGINAL PLAN	DATE
DESIGNED BY	3/2/05
NOTED BY	
QUANTITIES BY	
CHECKED BY	


STATE OF HAWAII
DEPARTMENT OF TRANSPORTATION
HIGHWAYS DIVISION

KAAHUMANU AVE./KANALOA AVE. (11204)/
MAHALANI ST. (X) CURB RAMP PLAN
CURB RAMP REPAIRS AT
VARIOUS LOCATIONS, MAUI
Project No. HWY-M-02-05M


Scale: As Shown
Date: February, 2005

SHEET No. CC-8 OF 19 SHEETS

FED. ROAD DIST. NO.	STATE	PROJ. NO.	FISCAL YEAR	SHEET NO.	TOTAL SHEETS
HAWAII	HAW.	HWY-M-02-05M	2005	23	44

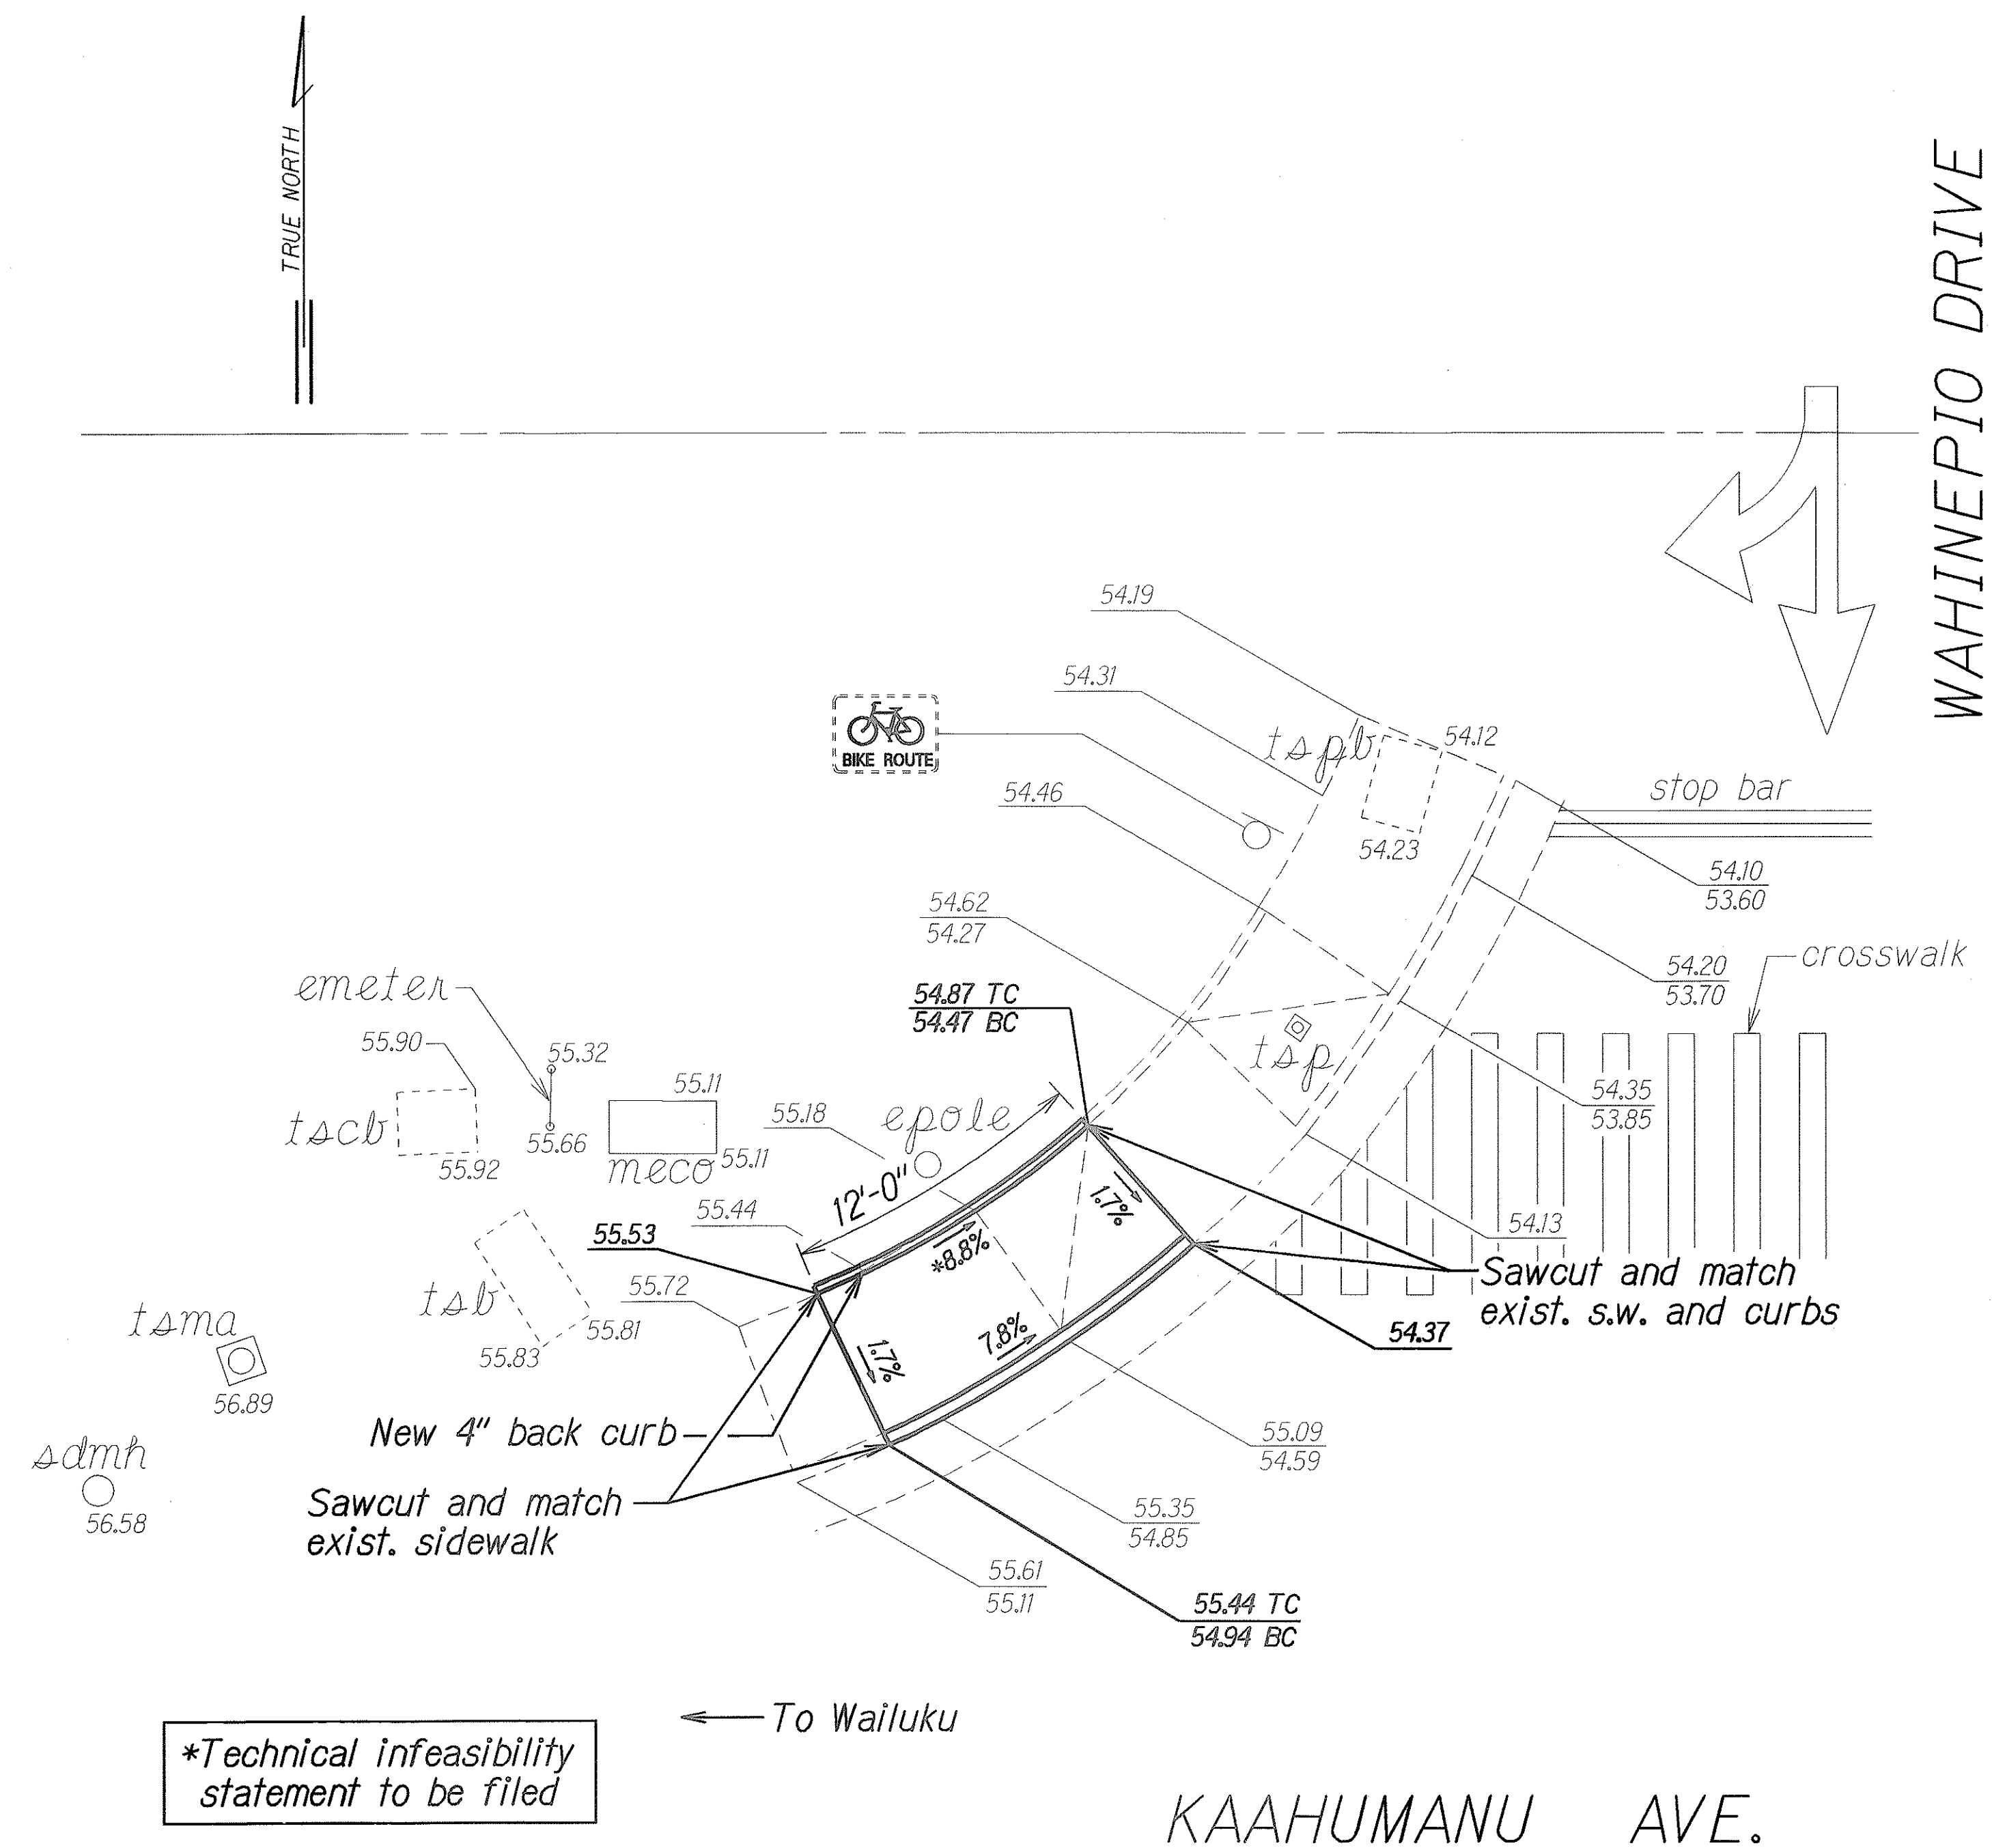

CURB RAMP NO. 11304-1 DETAILS
Scale: 1"= 5'

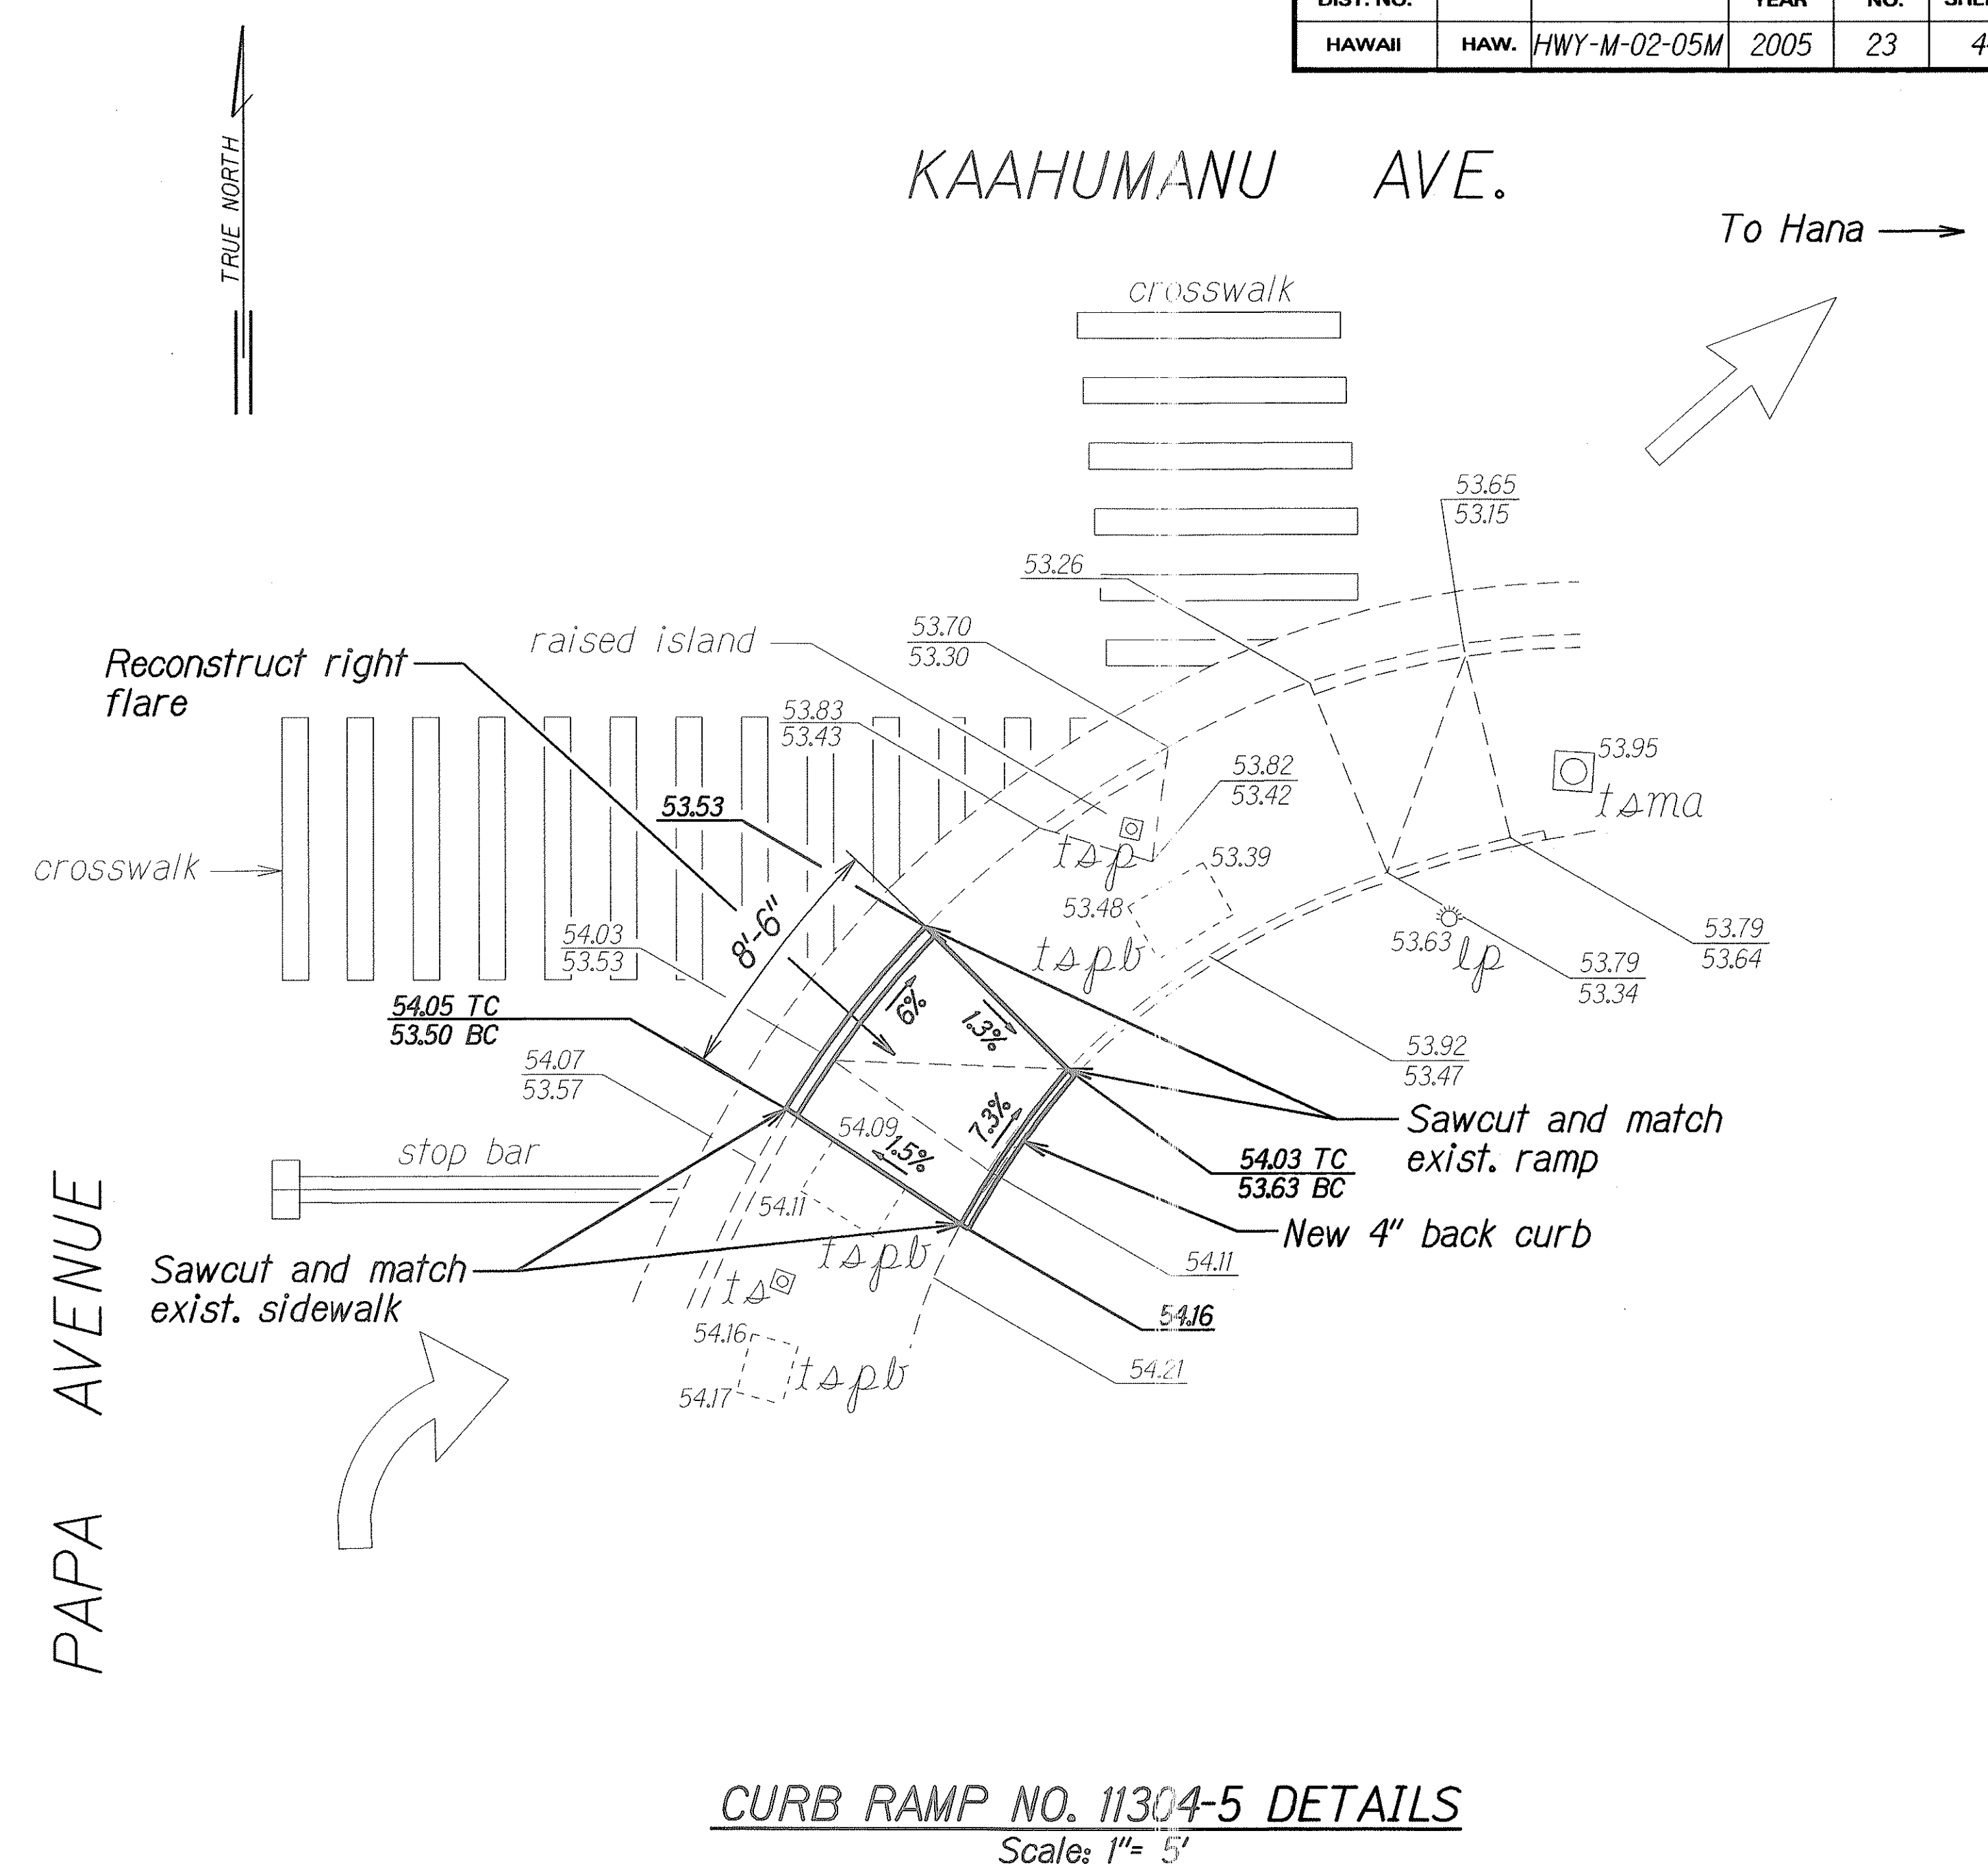

CURB RAMP NO. 11304-5 DETAILS
Scale: 1" = 5'

ORIGINAL PLAN	SURVEY PLOTTED BY _____ DATE <u>3/05</u>
NOTE BOOK melay pt.dgn	DRAWN BY <u>jo</u>
	TRACED BY _____
	DESIGNED BY <u>sd</u>
	QUANTITIES BY _____
	CHECKED BY _____

STATE OF HAWAII
DEPARTMENT OF TRANSPORTATION
HIGHWAYS DIVISION


KAAHUMANU AVE./WAHINEPIO DR. (11304)/
PAPA AVE. (11304) CURB RAMP PLAN

CURB RAMP REPAIRS AT
VARIOUS LOCATIONS, MAUI
Project No. HWY-M-02-05M

Scale: As Shown Date: February, 2005

SHEET No. CC-9 OF 19 SHEETS


MCC CAMPUS DRWY.

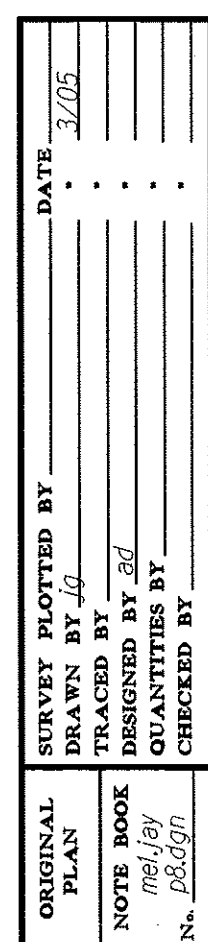


STATE OF HAWAII
DEPARTMENT OF TRANSPORTATION
HIGHWAYS DIVISION
KAAHUMANU AVE./PAPA AVE. (11304)/
MCC CAMPUS DRWY. (11404) CURB RAMP PLAN
CURB RAMP REPAIRS AT
VARIOUS LOCATIONS, MAUI
Project No. HWY-M-02-05M
Scale: As Shown Date: February, 2005
SHEET No. CC-10 OF 19 SHEETS



FED. ROAD DIST. NO.	STATE	PROJ. NO.	FISCAL YEAR	SHEET NO.	TOTAL SHEETS
HAWAII	HAW.	HWY-M-02-05M	2005	25	44

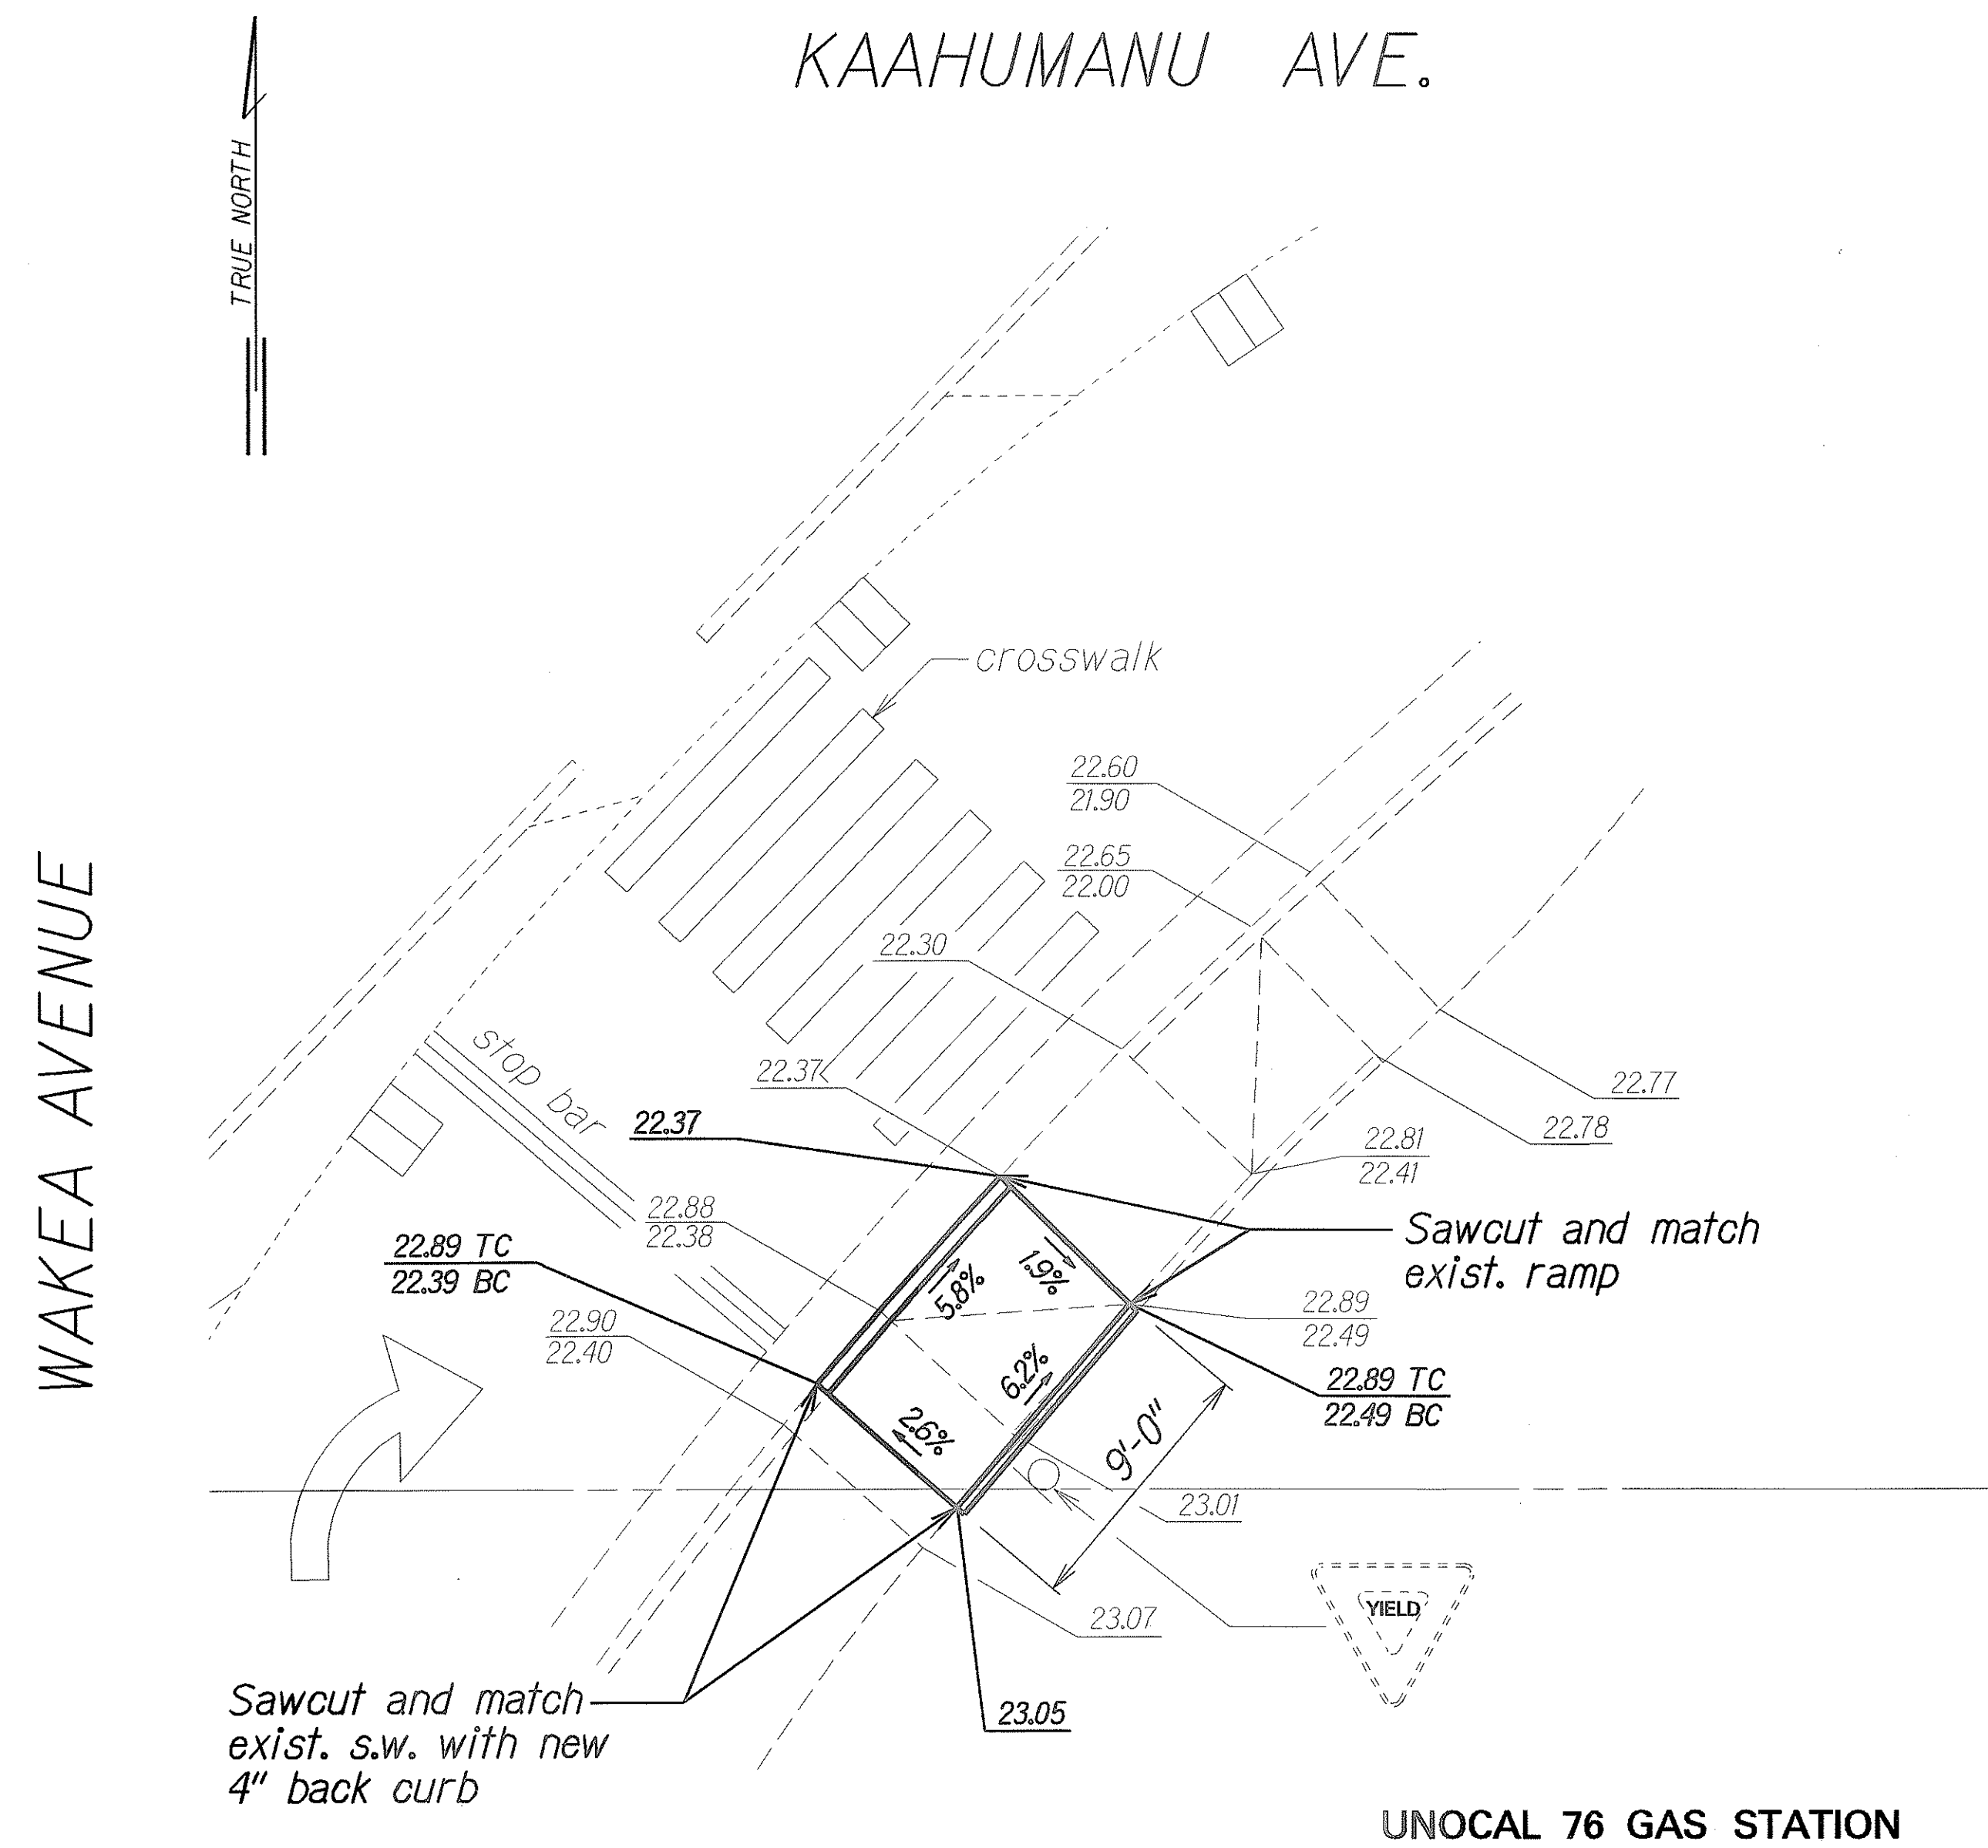

CURB RAMP NO. 11404-6 DETAILS
Scale: 1"= 5'

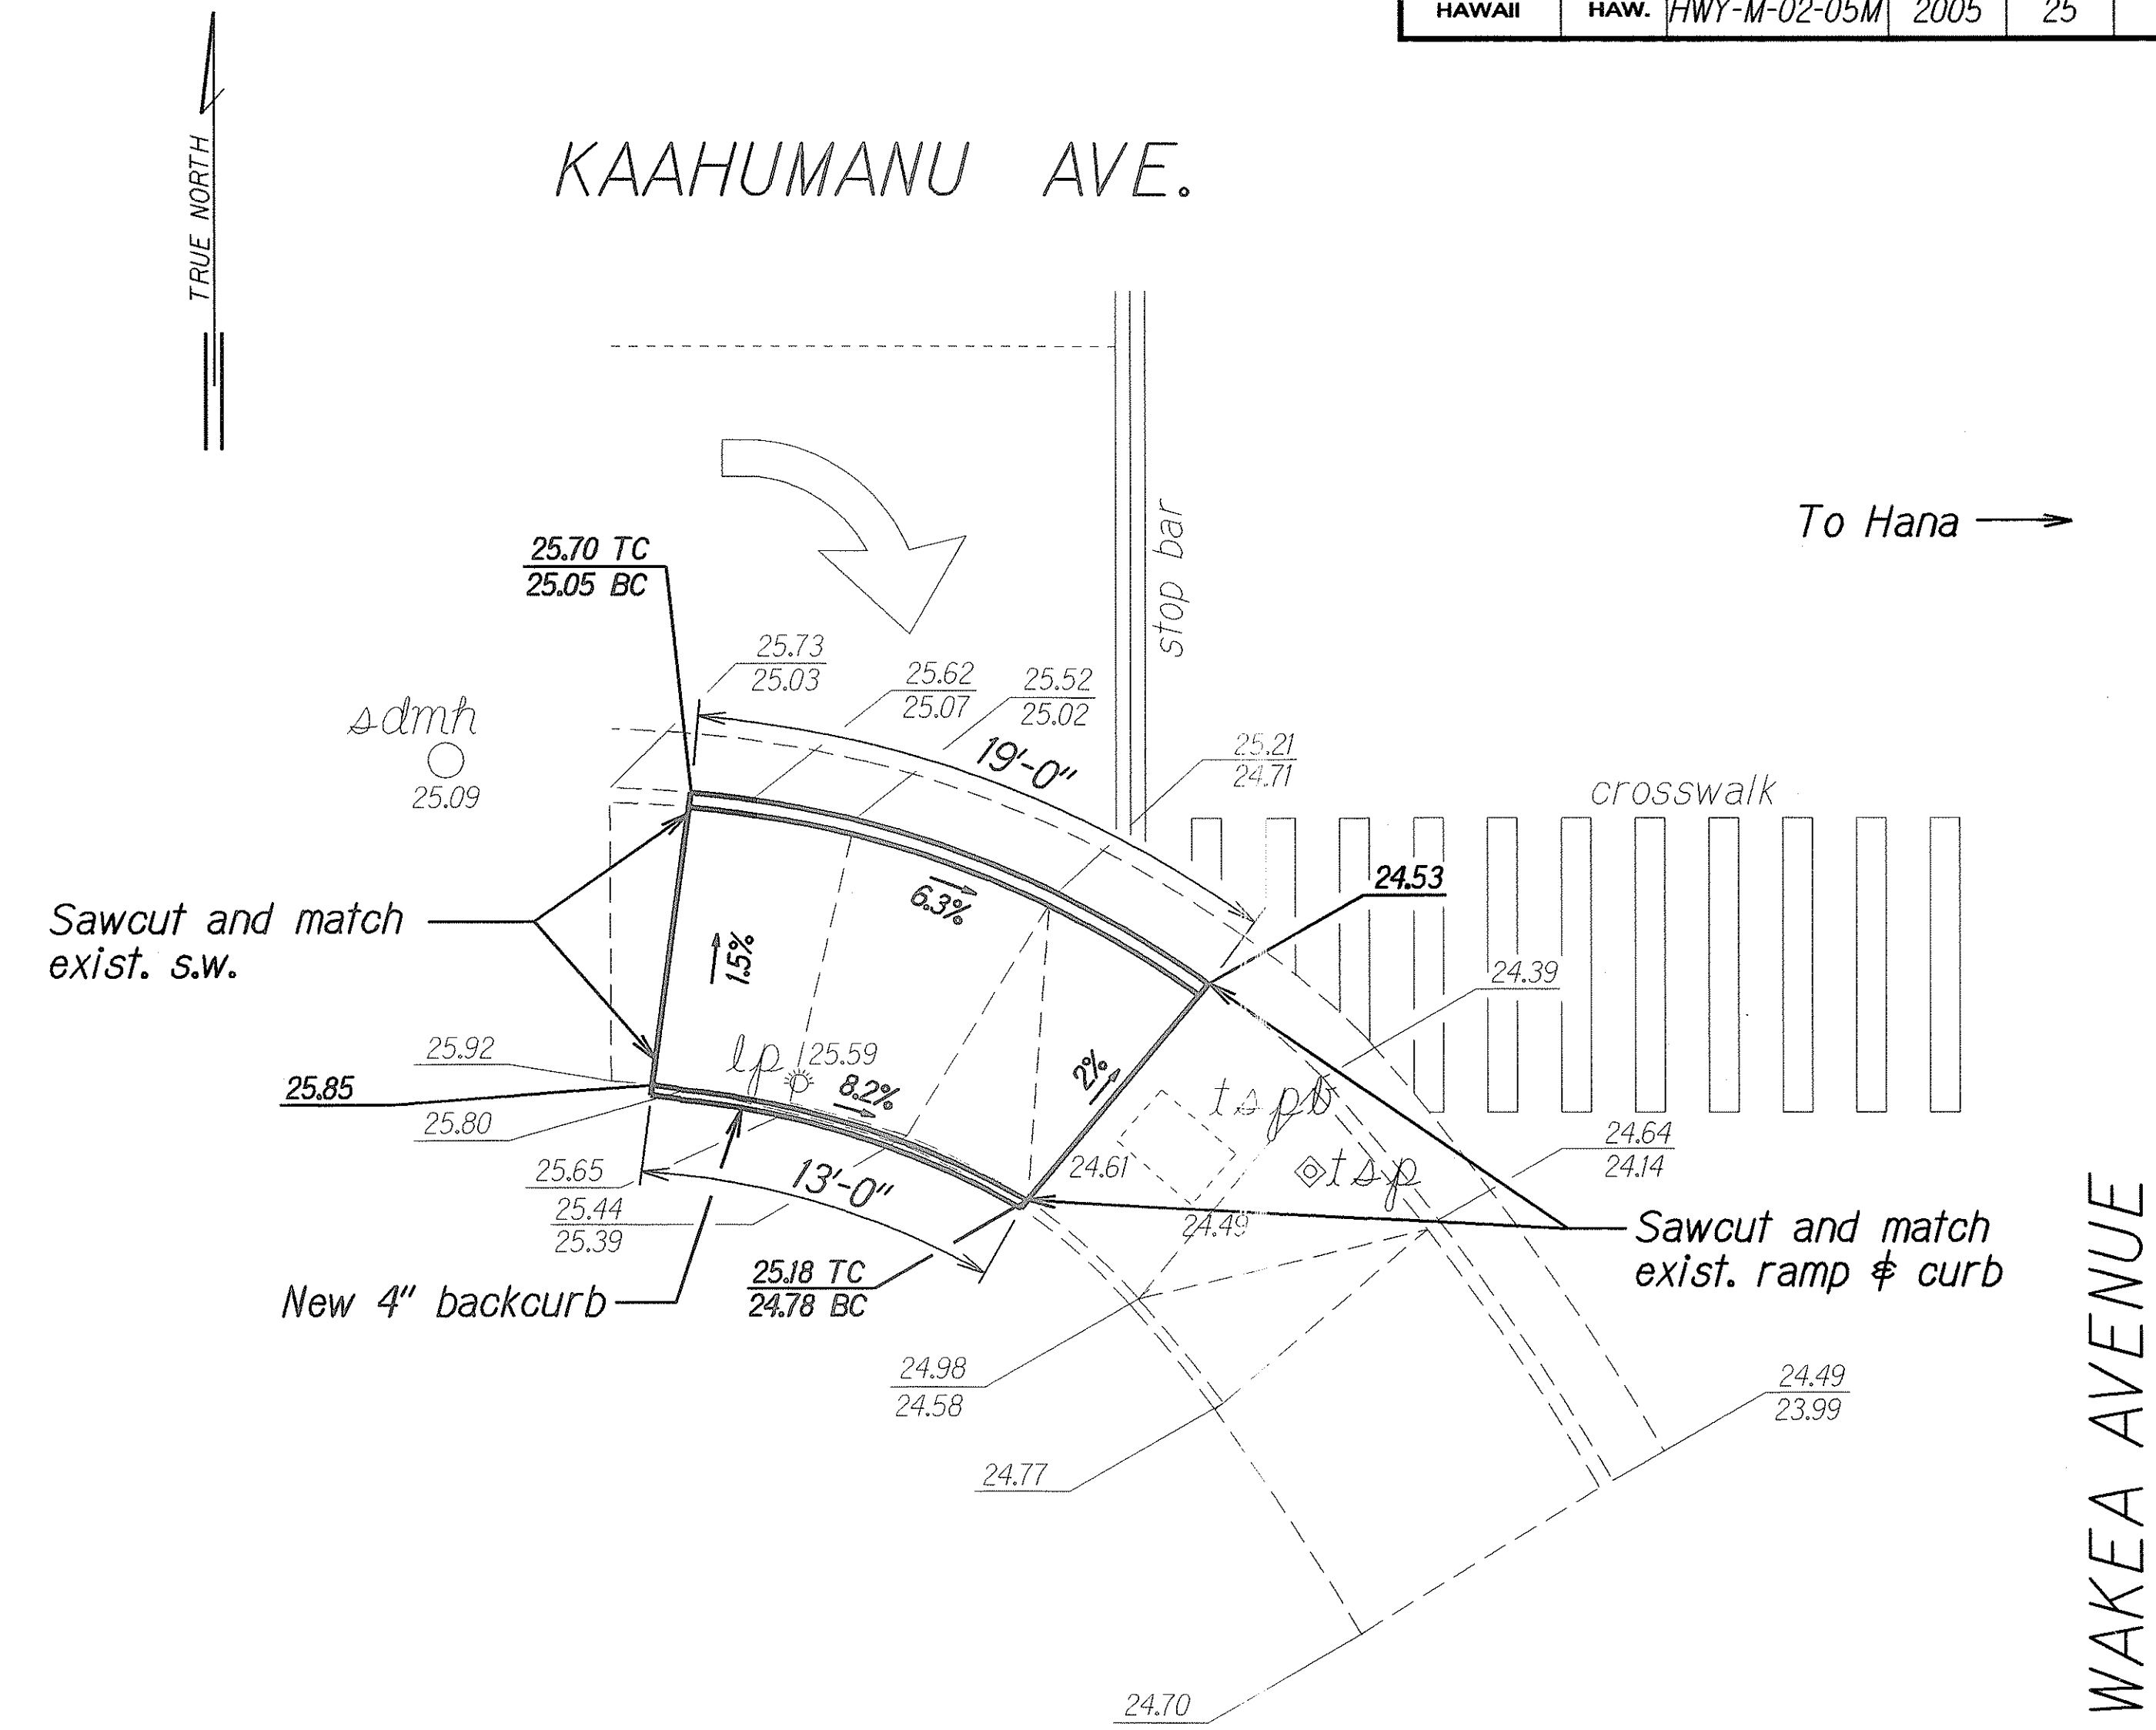

CURB RAMP NO. 11404-7 DETAILS
Scale: 1"= 5'

ORIGINAL PLAN	SURVEY PLOTTED BY	DATE
NOTE BOOK	DRAWN BY	3/05
DESIGNED BY	TRACED BY	
CHECKED BY	DESIGNED BY	
	CHECKED BY	

STATE OF HAWAII
DEPARTMENT OF TRANSPORTATION
HIGHWAYS DIVISION

KAAHUMANU AVE./WAKEA AVE. (11404)

CURB RAMP PLAN


CURB RAMP REPAIRS AT
VARIOUS LOCATIONS, MAUI

Project No. HWY-M-02-05M

Scale: As Shown Date: February, 2005

SHEET No. CC-11 OF 19 SHEETS

FED. ROAD DIST. NO.	STATE	PROJ. NO.	FISCAL YEAR	SHEET NO.	TOTAL SHEETS
HAWAII	HAW.	HWY-M-02-05M	2005	26	44

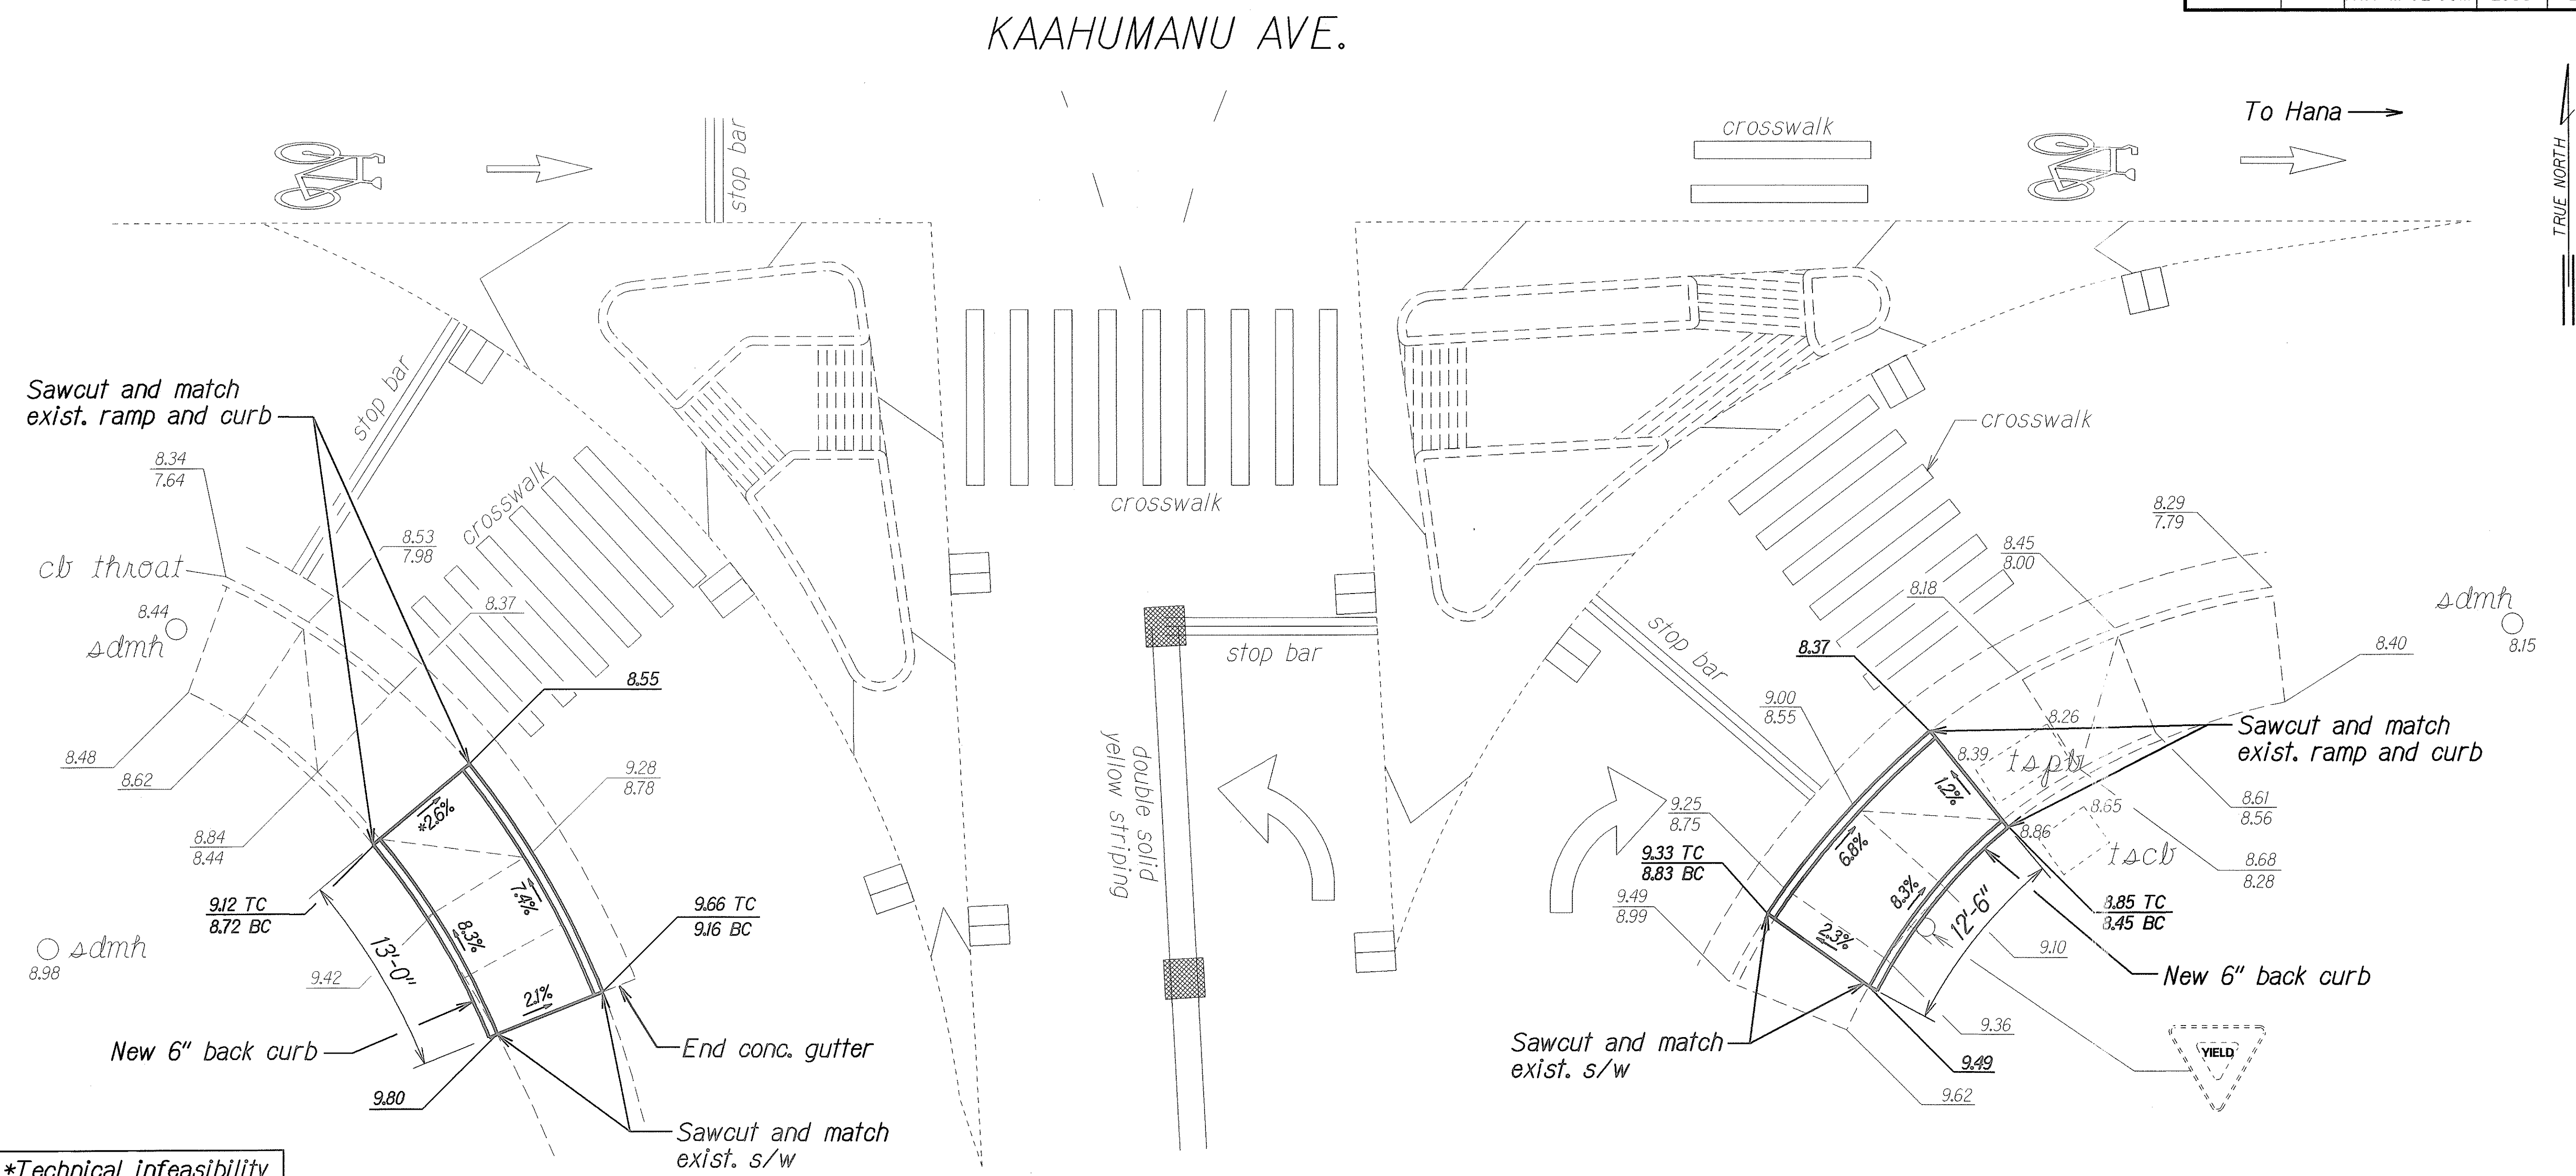

*Technical infeasibility statement to be filed

CURB RAMP NO. 11504-6 DETAILS
Scale: 1"= 5'

CURB RAMP NO. 11504-3 DETAILS
Scale: 1"= 5'

ORIGINAL PLAN	SURVEY PLOTTED BY	DATE
NOTE BOOK	DRAWN BY	3/05
me/ley	CHECKED BY	
pladen		

STATE OF HAWAII
DEPARTMENT OF TRANSPORTATION
HIGHWAYS DIVISION

KAAHUMANU AVE./KAAHUMANU CENTER
DRWY. (11504) CURB RAMP PLAN

CURB RAMP REPAIRS AT
VARIOUS LOCATIONS, MAUI
Project No. HWY-M-02-05M

Scale: As Shown Date: February, 2005

SHEET No. CC-12 OF 19 SHEETS

FED. ROAD DIST. NO.	STATE	PROJ. NO.	FISCAL YEAR	SHEET NO.	TOTAL SHEETS
HAWAII	HAW.	HWY-M-02-05M	2005	28	44

← To Wailuku

CURB RAMP NO. 11904-09 DETAILS


Scale: 1"= 5'

KAAHUMANU AVENUE

CURB RAMP NO. 11904-06 DETAILS

Scale: 1"= 5'

To Hana →

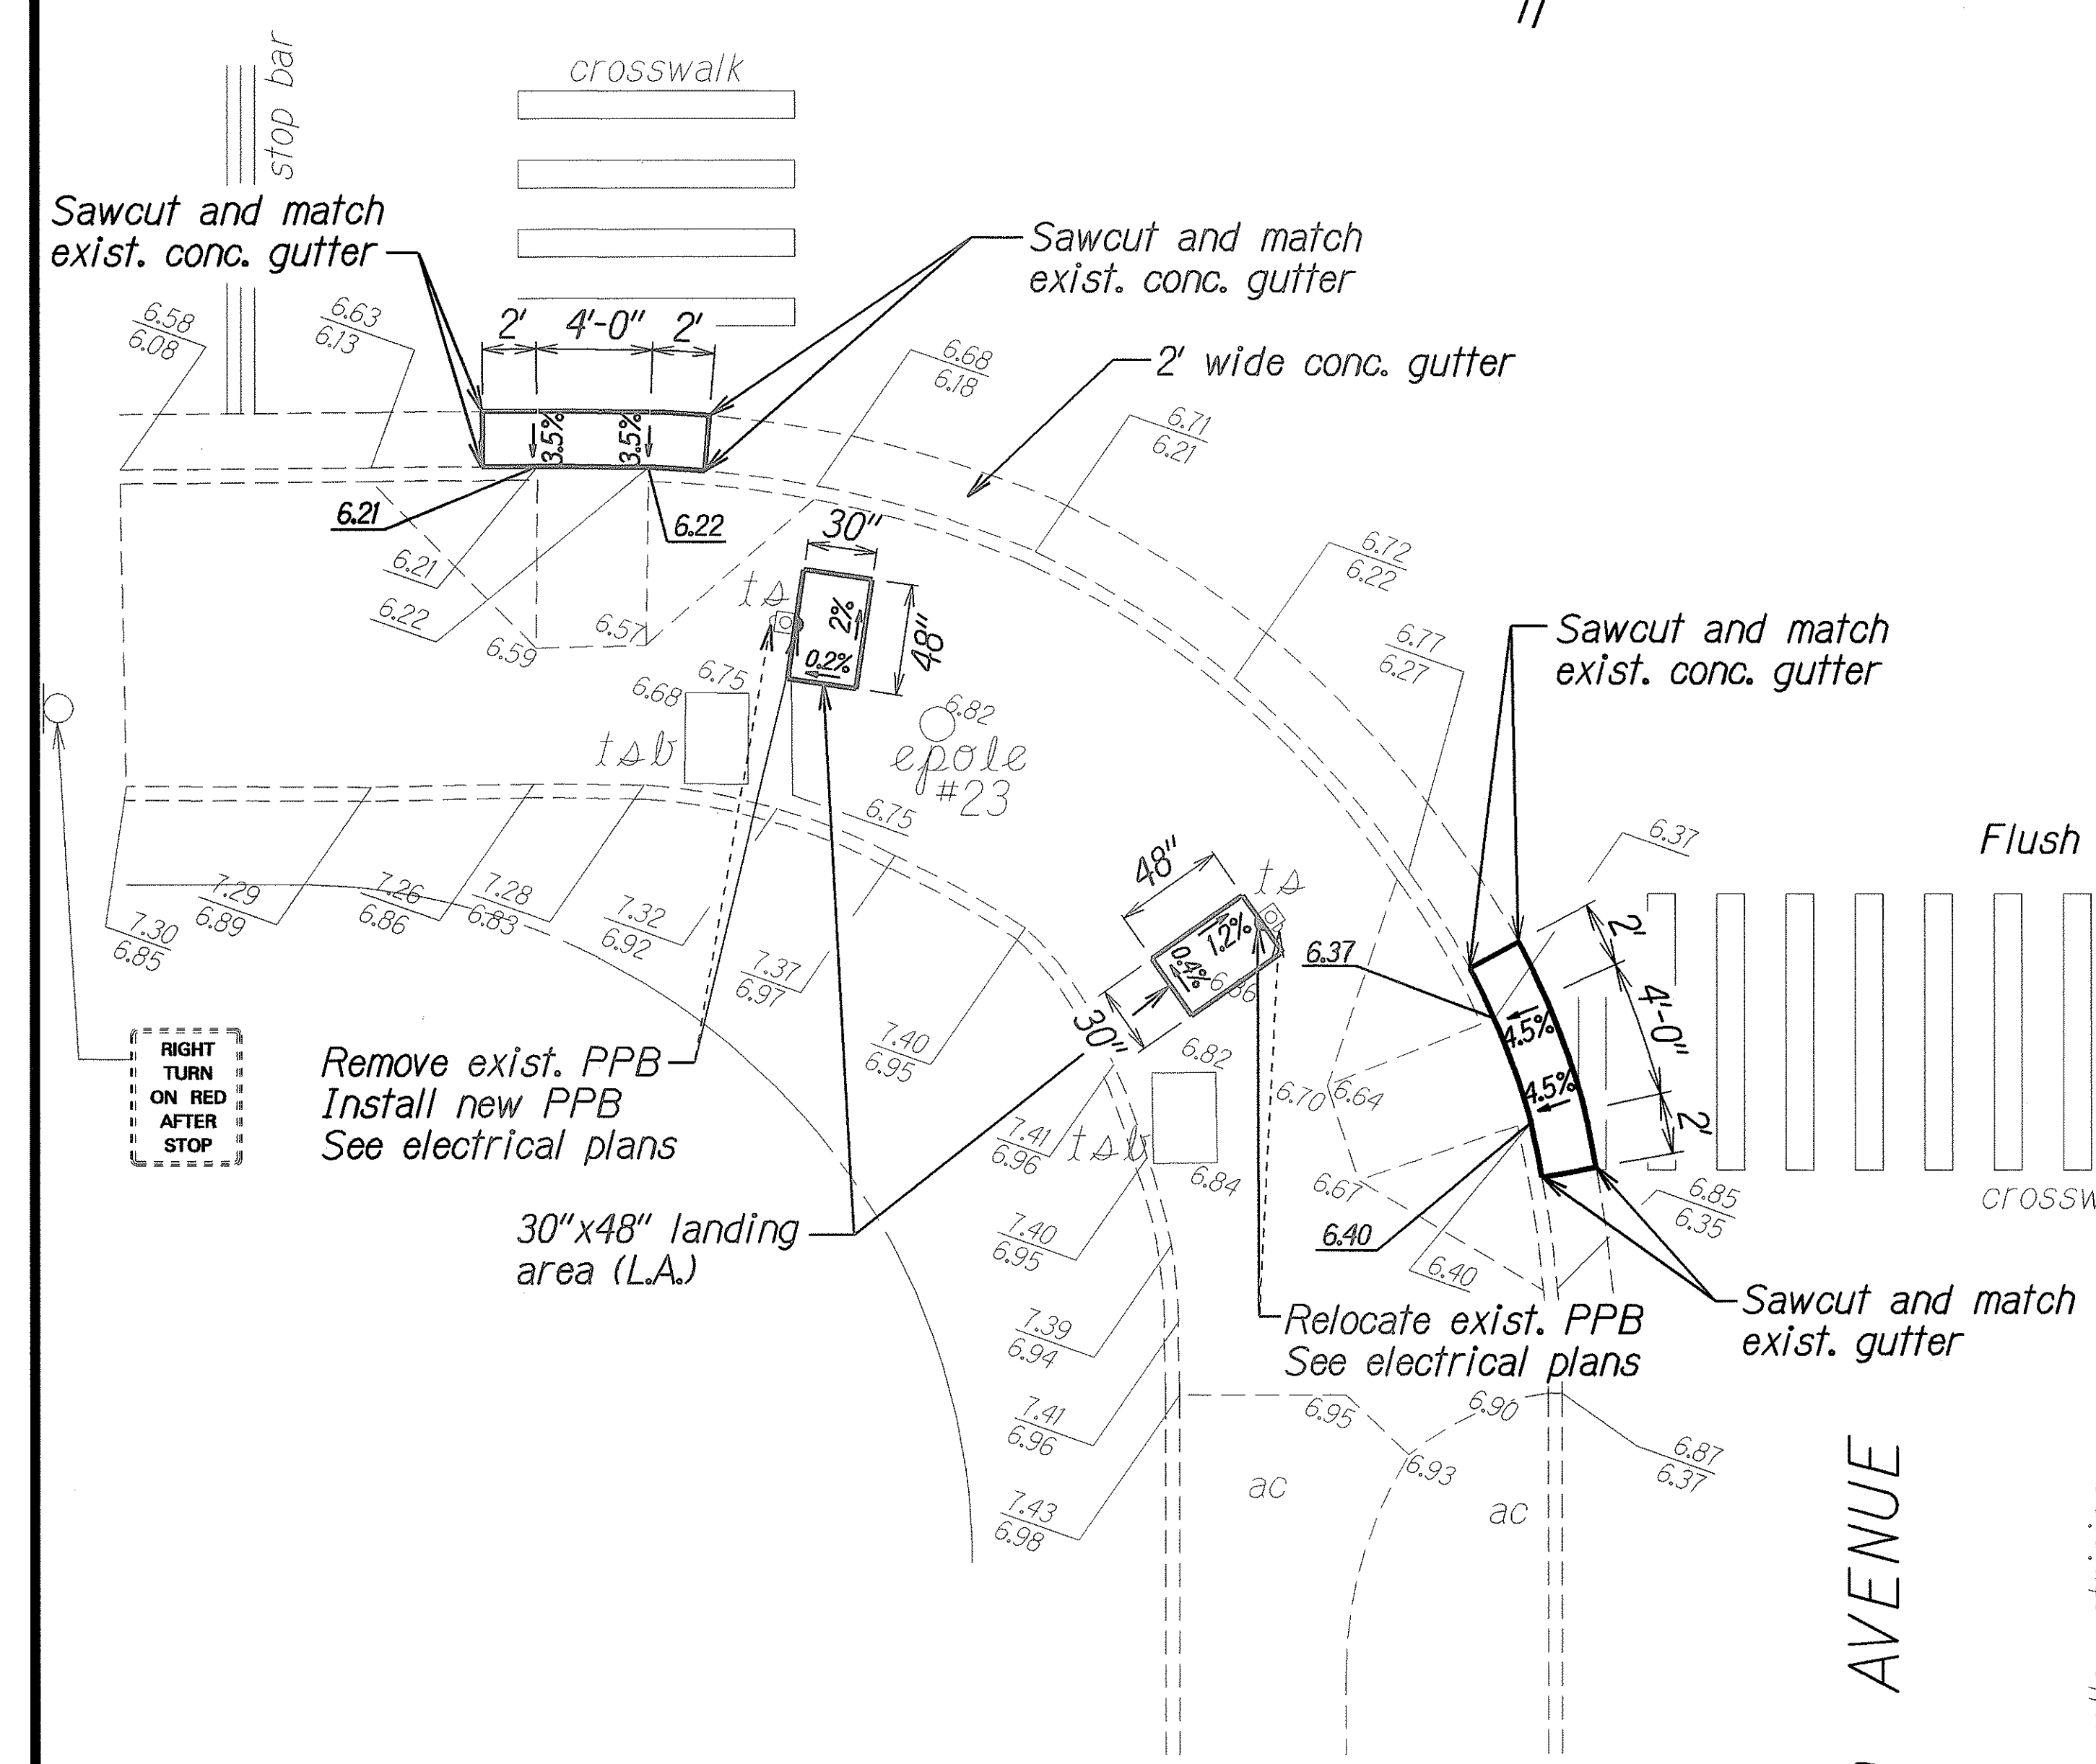


Remove exist. PPB
Install new PPB
See electrical plans

Relocate exist. PPB
See electrical plans

CURB RAMP NO. 11904-08 DETAILS


Scale: 1"= 5'

LONO AVENUE

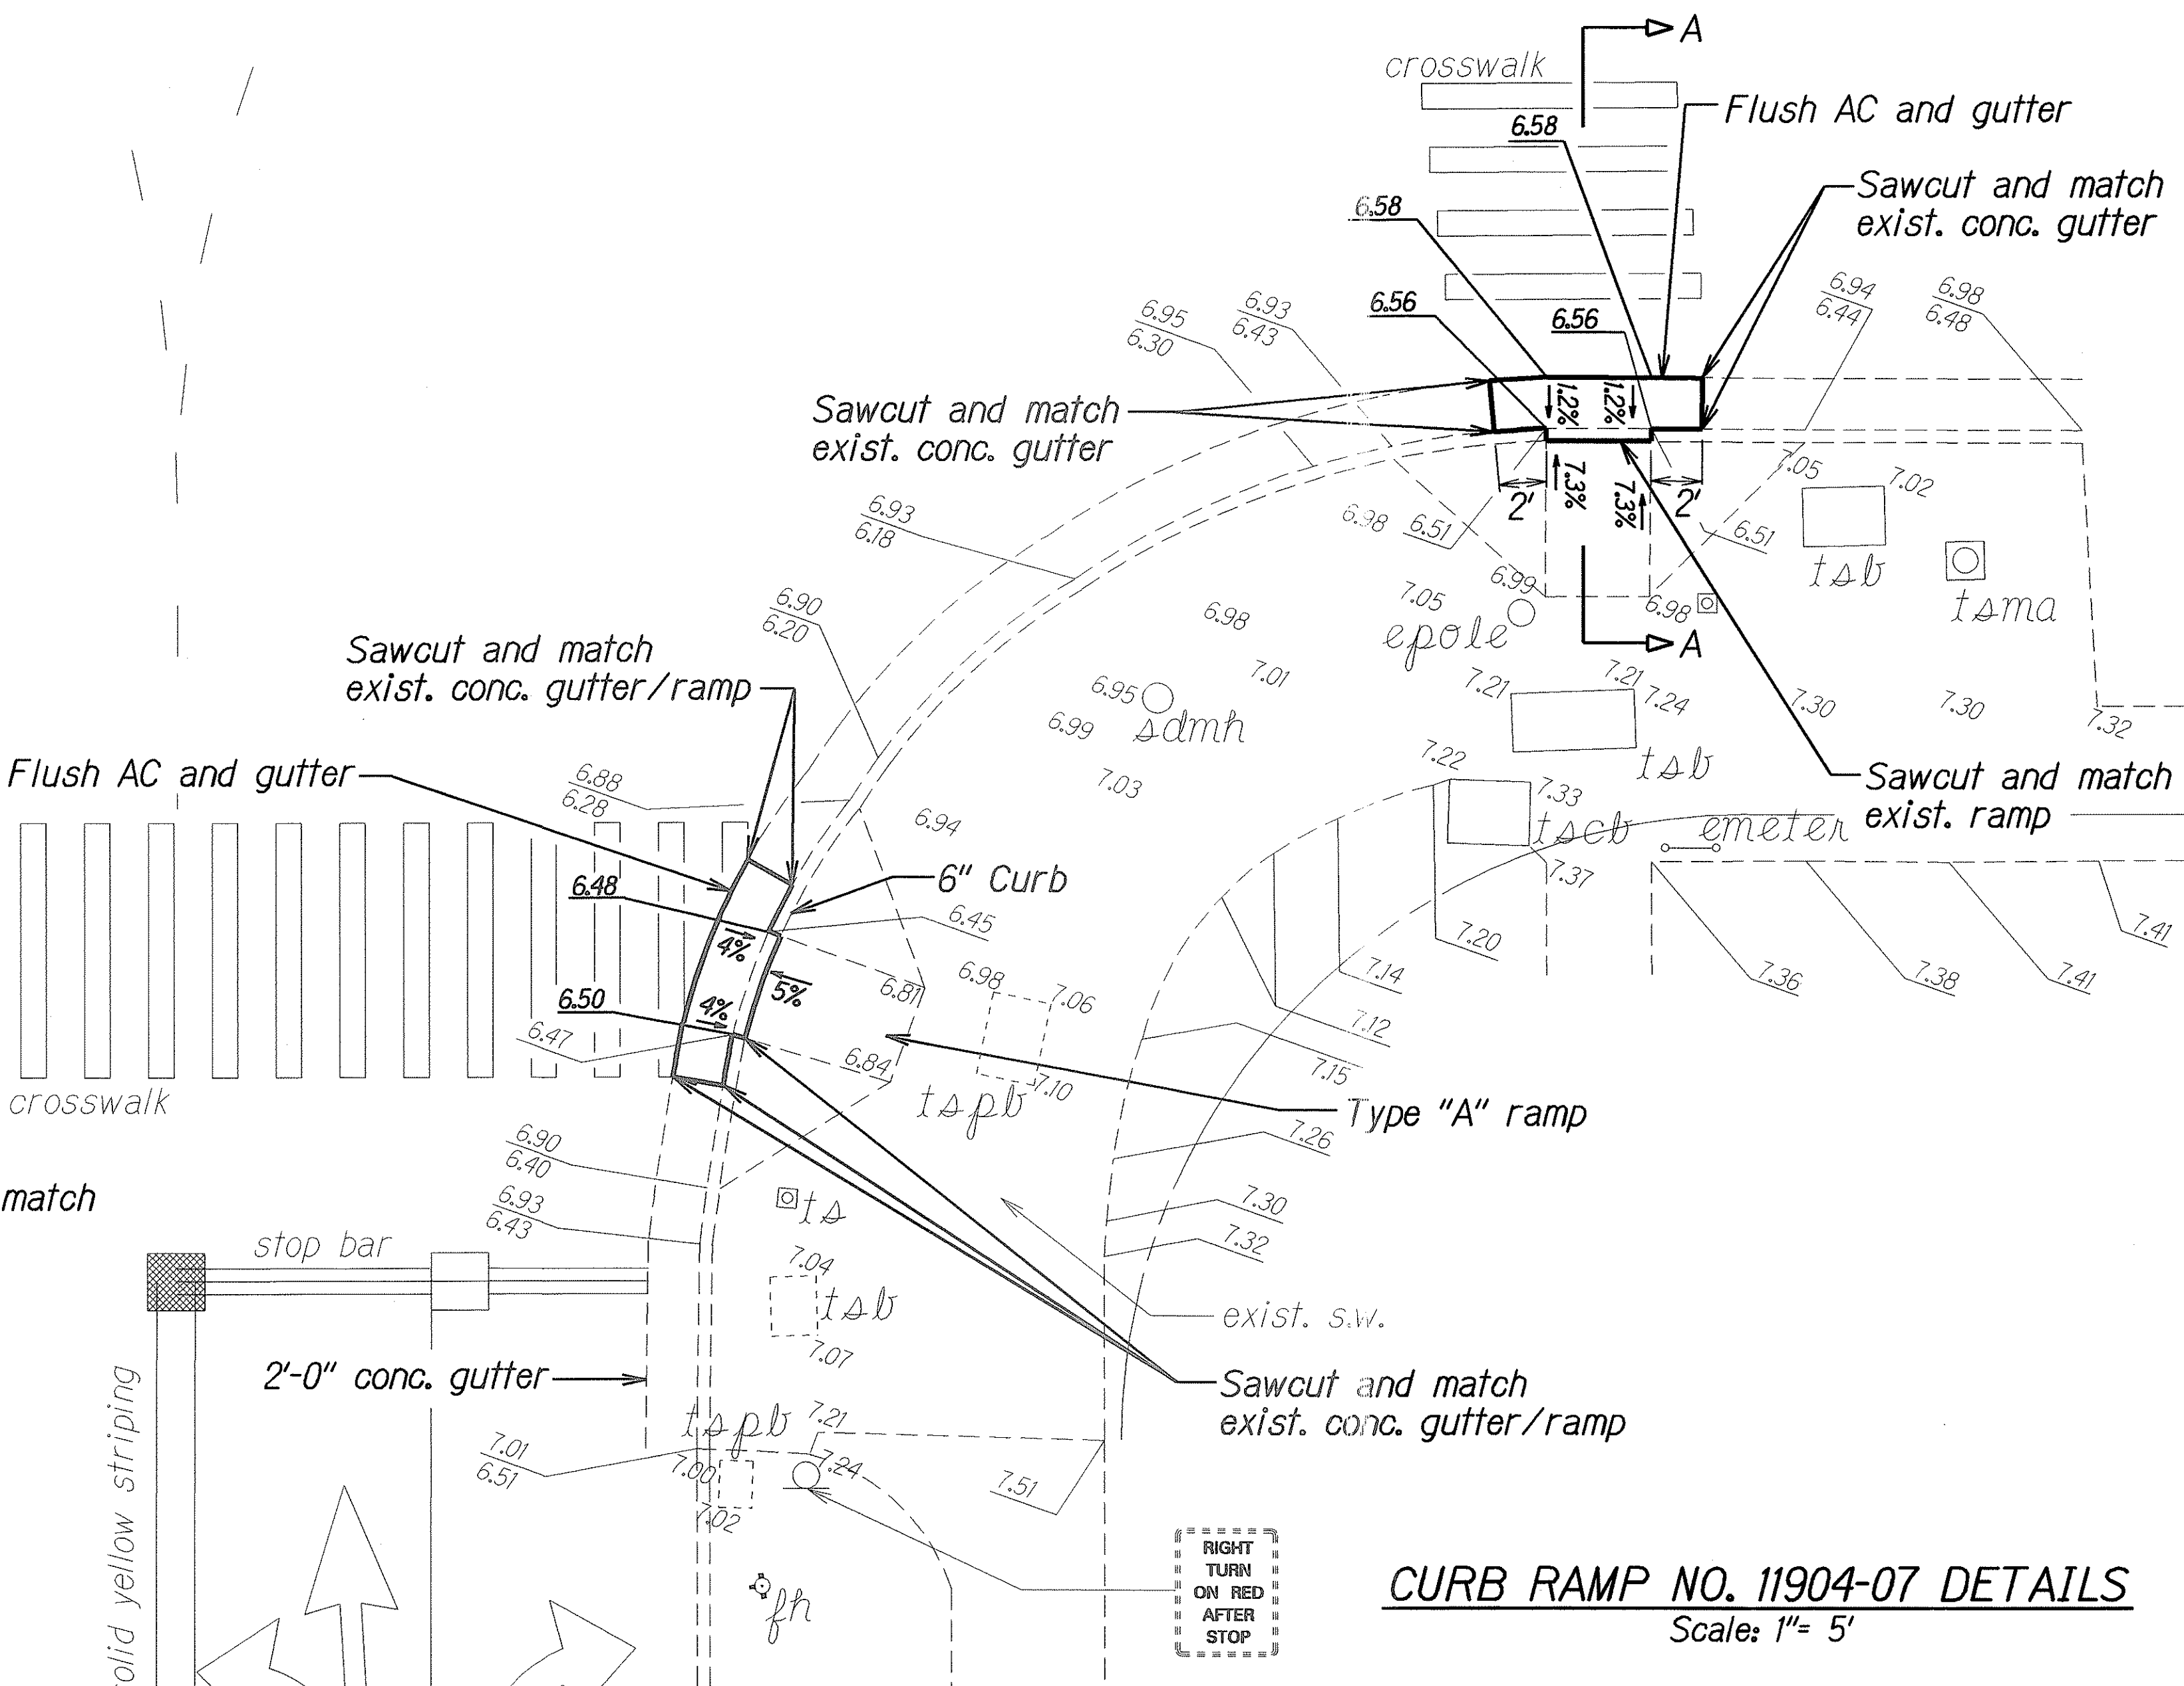

CURB RAMP NO. 11904-07 DETAILS

Scale: 1"= 5'

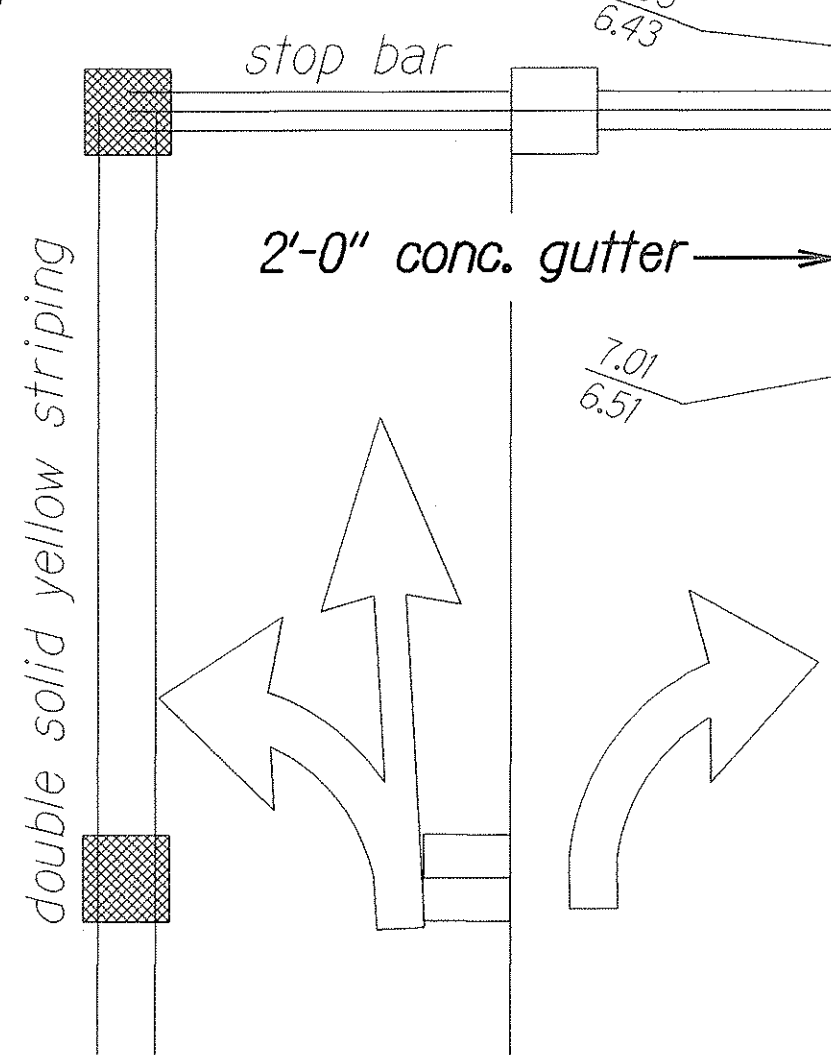


SECTION A-A
Not To Scale

DATE	3/05
SURVEY PLOTTED BY	
DRAWN BY	
DESIGNED BY	
CHECKED BY	
NOTE BOOK	
QUANTITIES BY	
CHECKED BY	
ORIGINAL PLAN	


STATE OF HAWAII
DEPARTMENT OF TRANSPORTATION
HIGHWAYS DIVISION
KAAHUMANU AVE./LONO AVE (11904)
CURB RAMP PLAN
CURB RAMP REPAIRS AT
VARIOUS LOCATIONS, MAUI
Project No. HWY-M-02-05M
Scale: As Shown Date: February, 2005
SHEET No. CC-14 OF 19 SHEETS

28

FED. ROAD DIST. NO.	STATE	PROJ. NO.	FISCAL YEAR	SHEET NO.	TOTAL SHEETS
HAWAII	HAW.	HWY-M-02-05M	2005	29	44

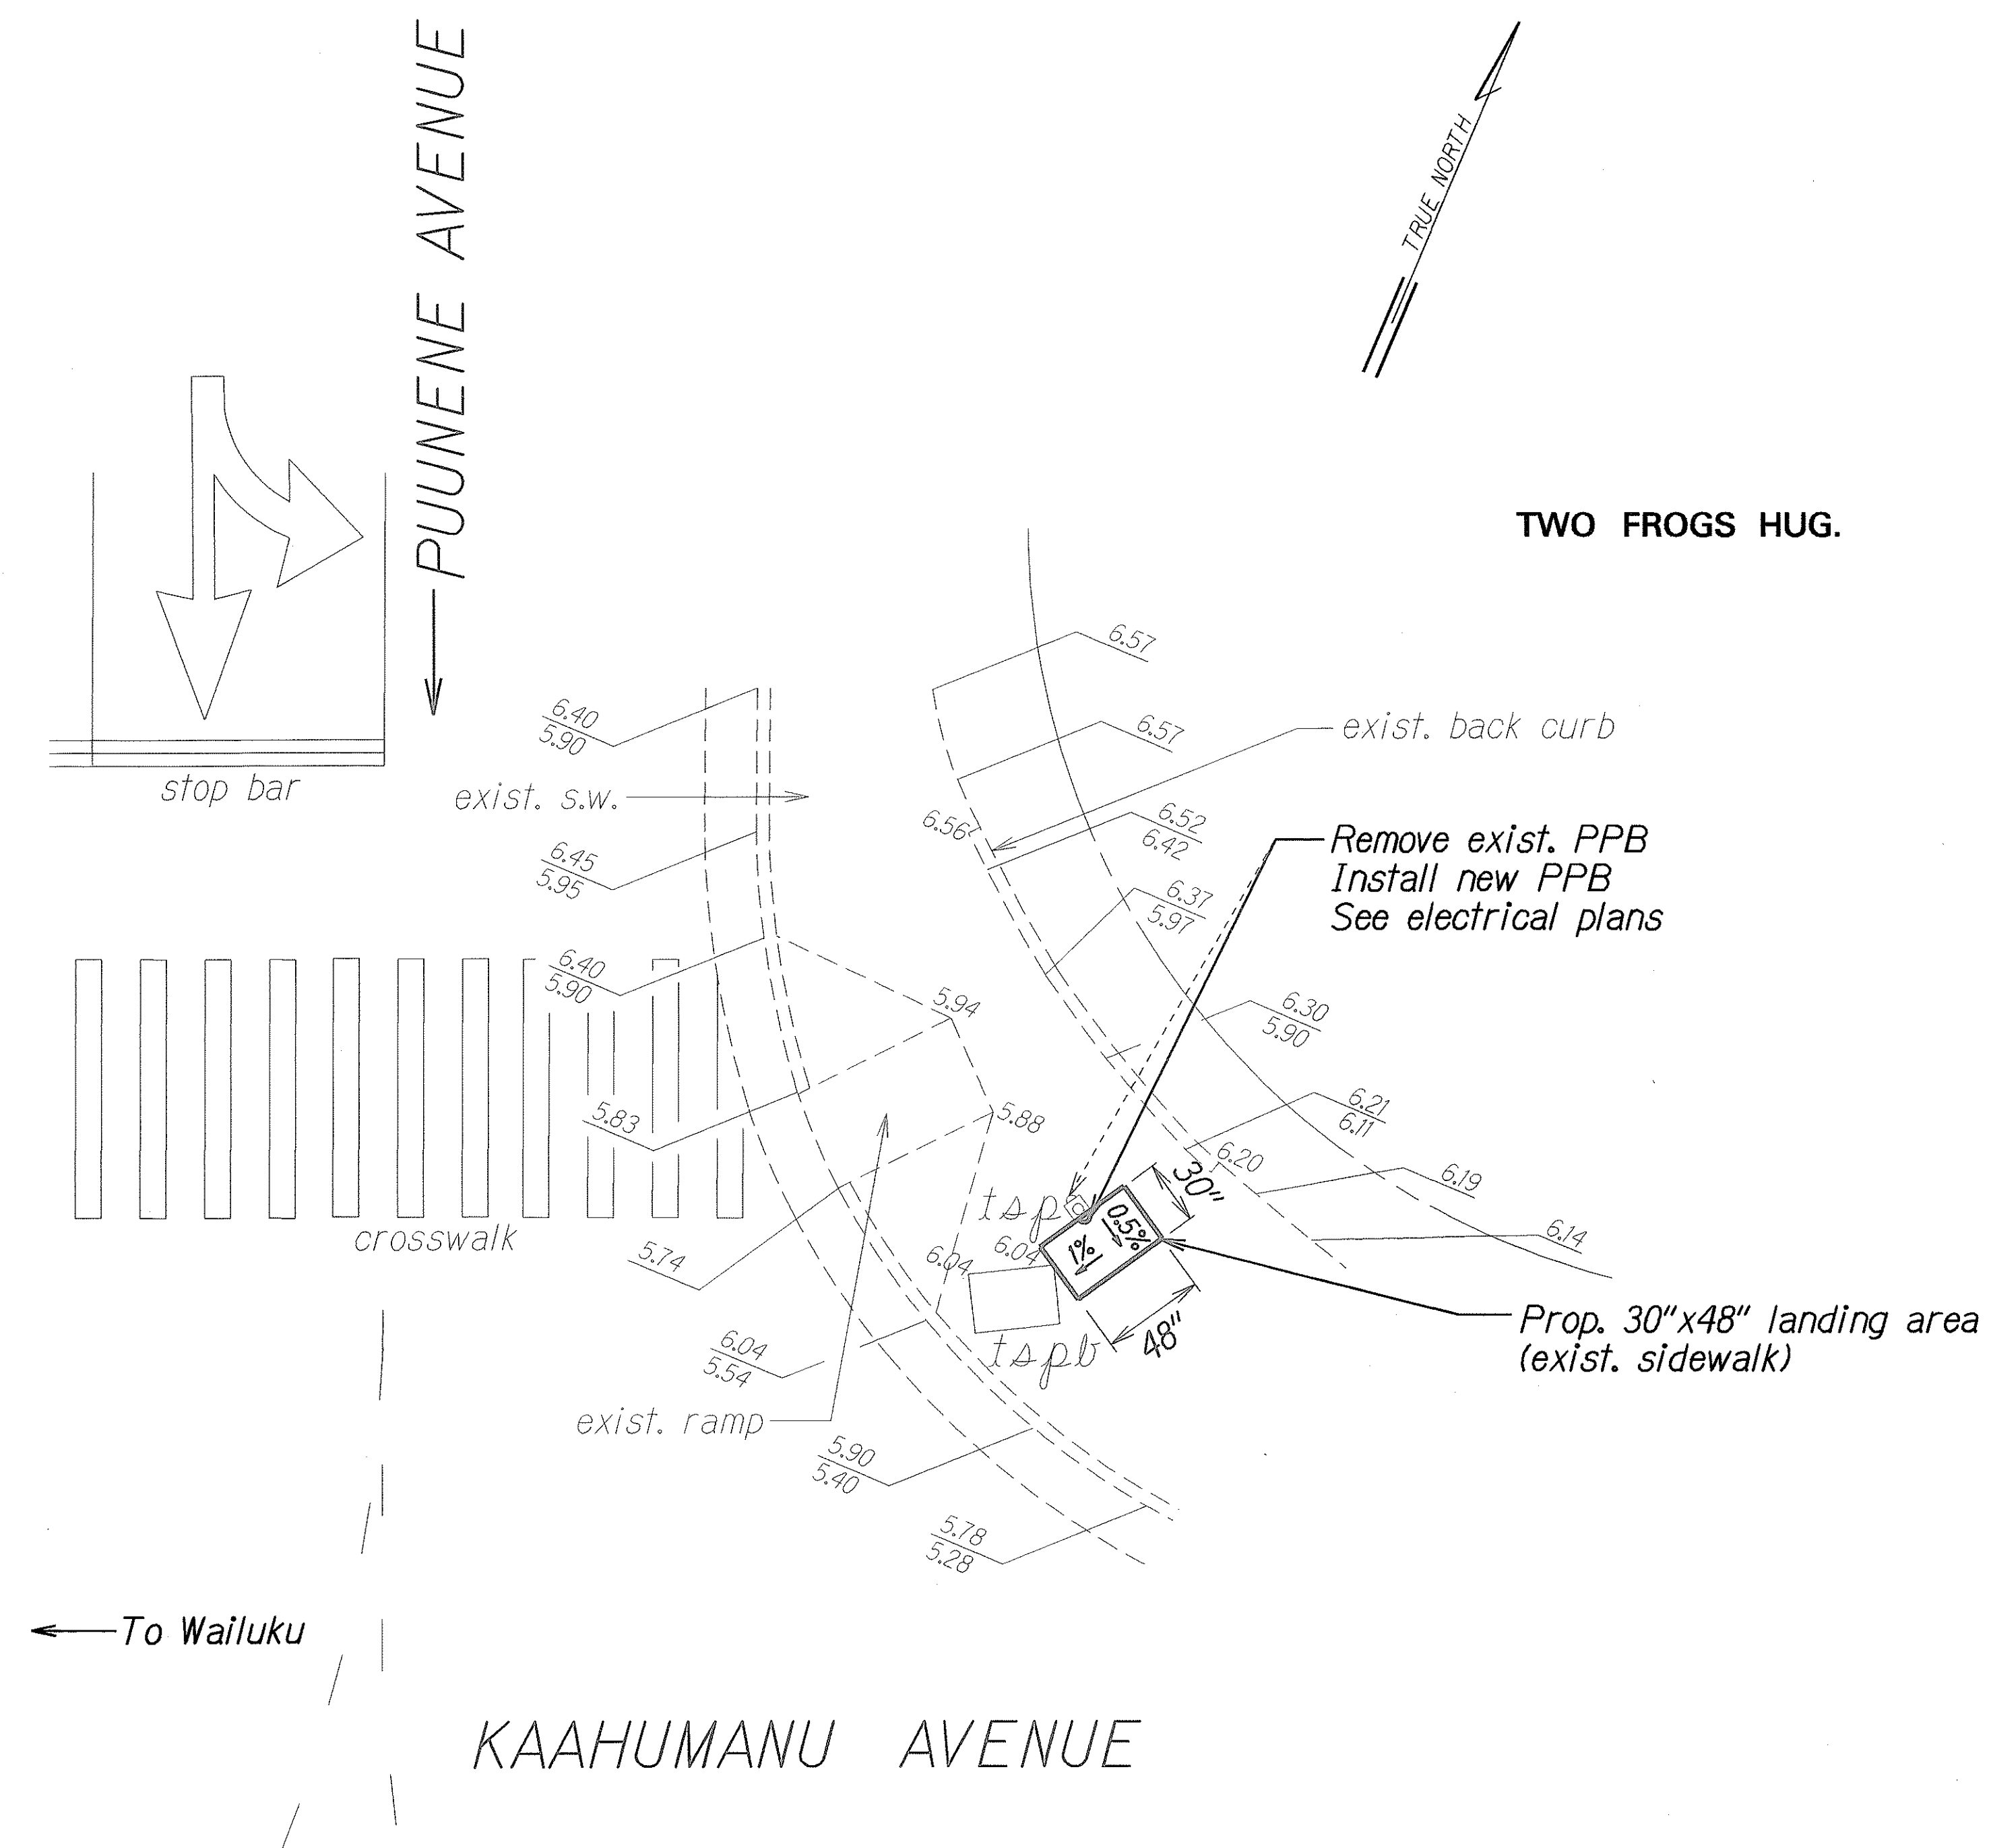

CURB RAMP NO. 12104-2 DETAILS
Scale: 1"= 5'

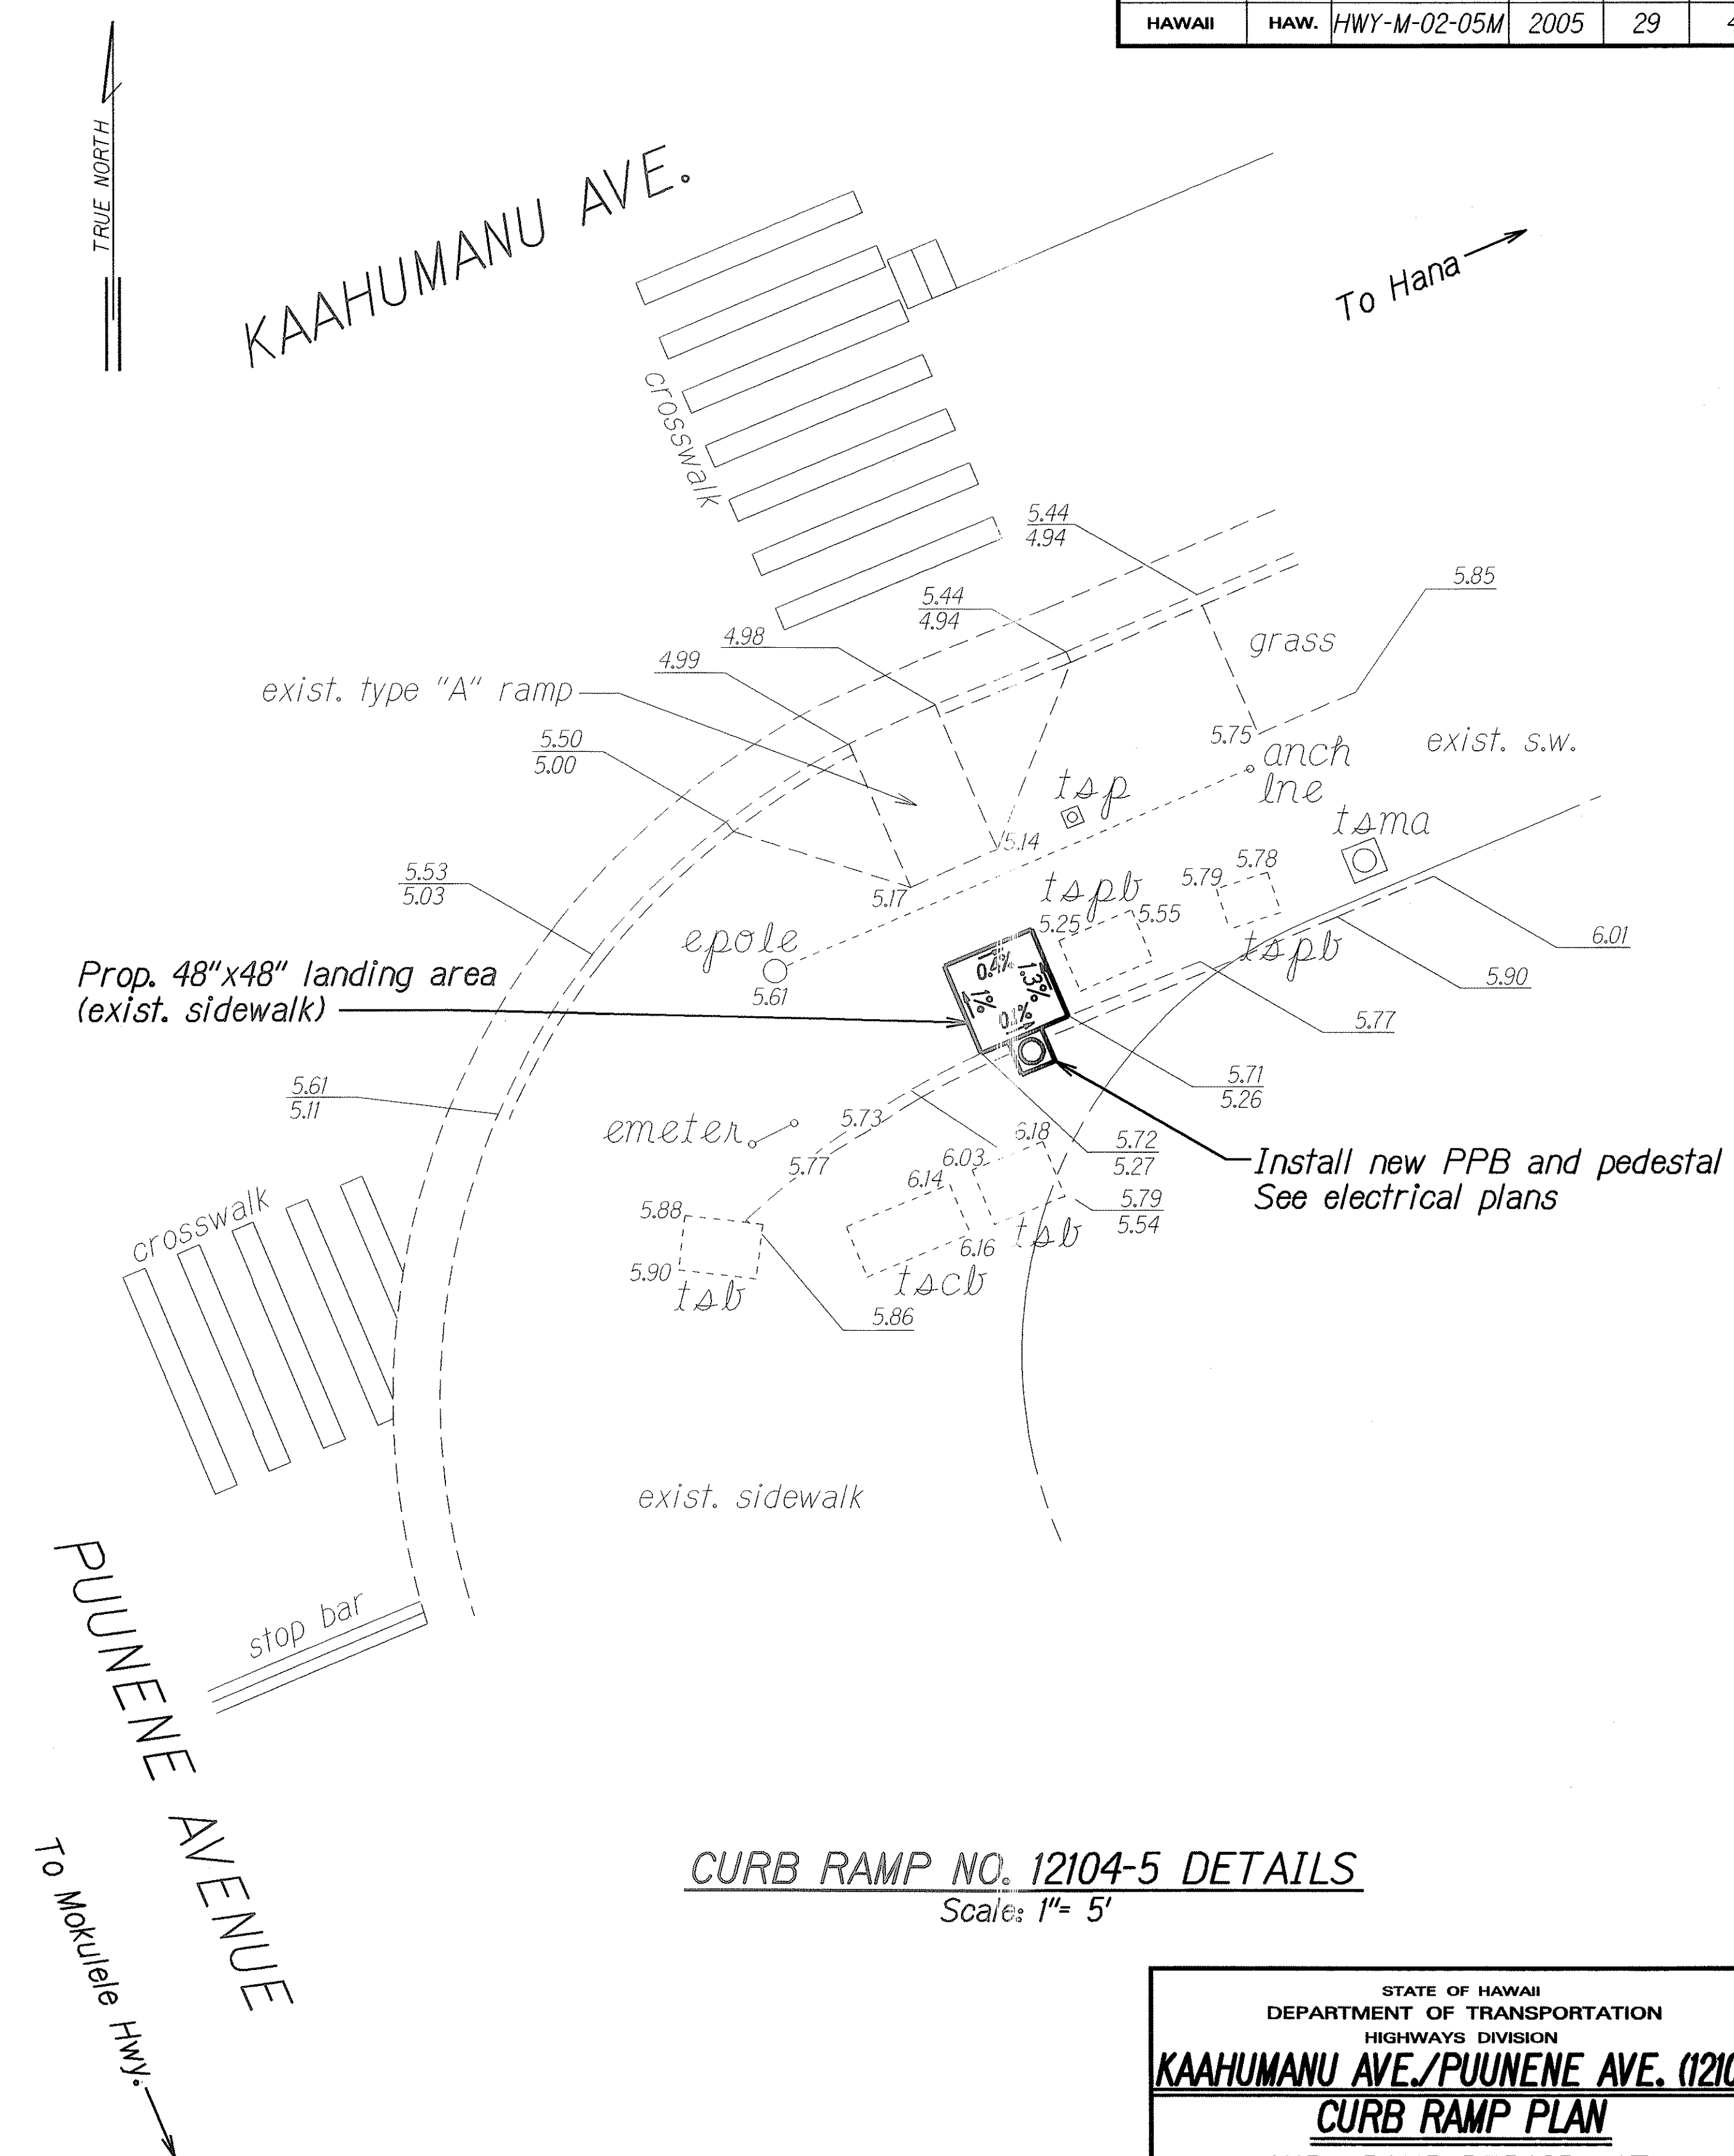


CURB RAMP NO. 12104-5 DETAILS
Scale: 1" = 5'


ORIGINAL PLAN	SURVEY PLOTTED BY _____	DATE _____
NOTE BOOK	DRAWN BY <u>40</u>	<u>3.05</u>
<u>mel, jay</u>	TRACED BY _____	_____
<u>pl30gh</u>	DESIGNED BY <u>ad</u>	_____
	QUANTITIES BY _____	_____
	CHECKED BY _____	_____

STATE OF HAWAII
DEPARTMENT OF TRANSPORTATION
HIGHWAYS DIVISION
KAAHUMANU AVE./PUUNENE AVE. (12104)
CURB RAMP PLAN
CURB RAMP REPAIRS AT
VARIOUS LOCATIONS, MAUI
Project No. HWY-M-02-05M
Scale: As Shown Date: February, 2005
SHEET No. CC-15 OF 19 SHEETS


FED. ROAD DIST. NO.	STATE	PROJ. NO.	FISCAL YEAR	SHEET NO.	TOTAL SHEETS
HAWAII	HAW.	HWY-M-02-05M	2005	30	44

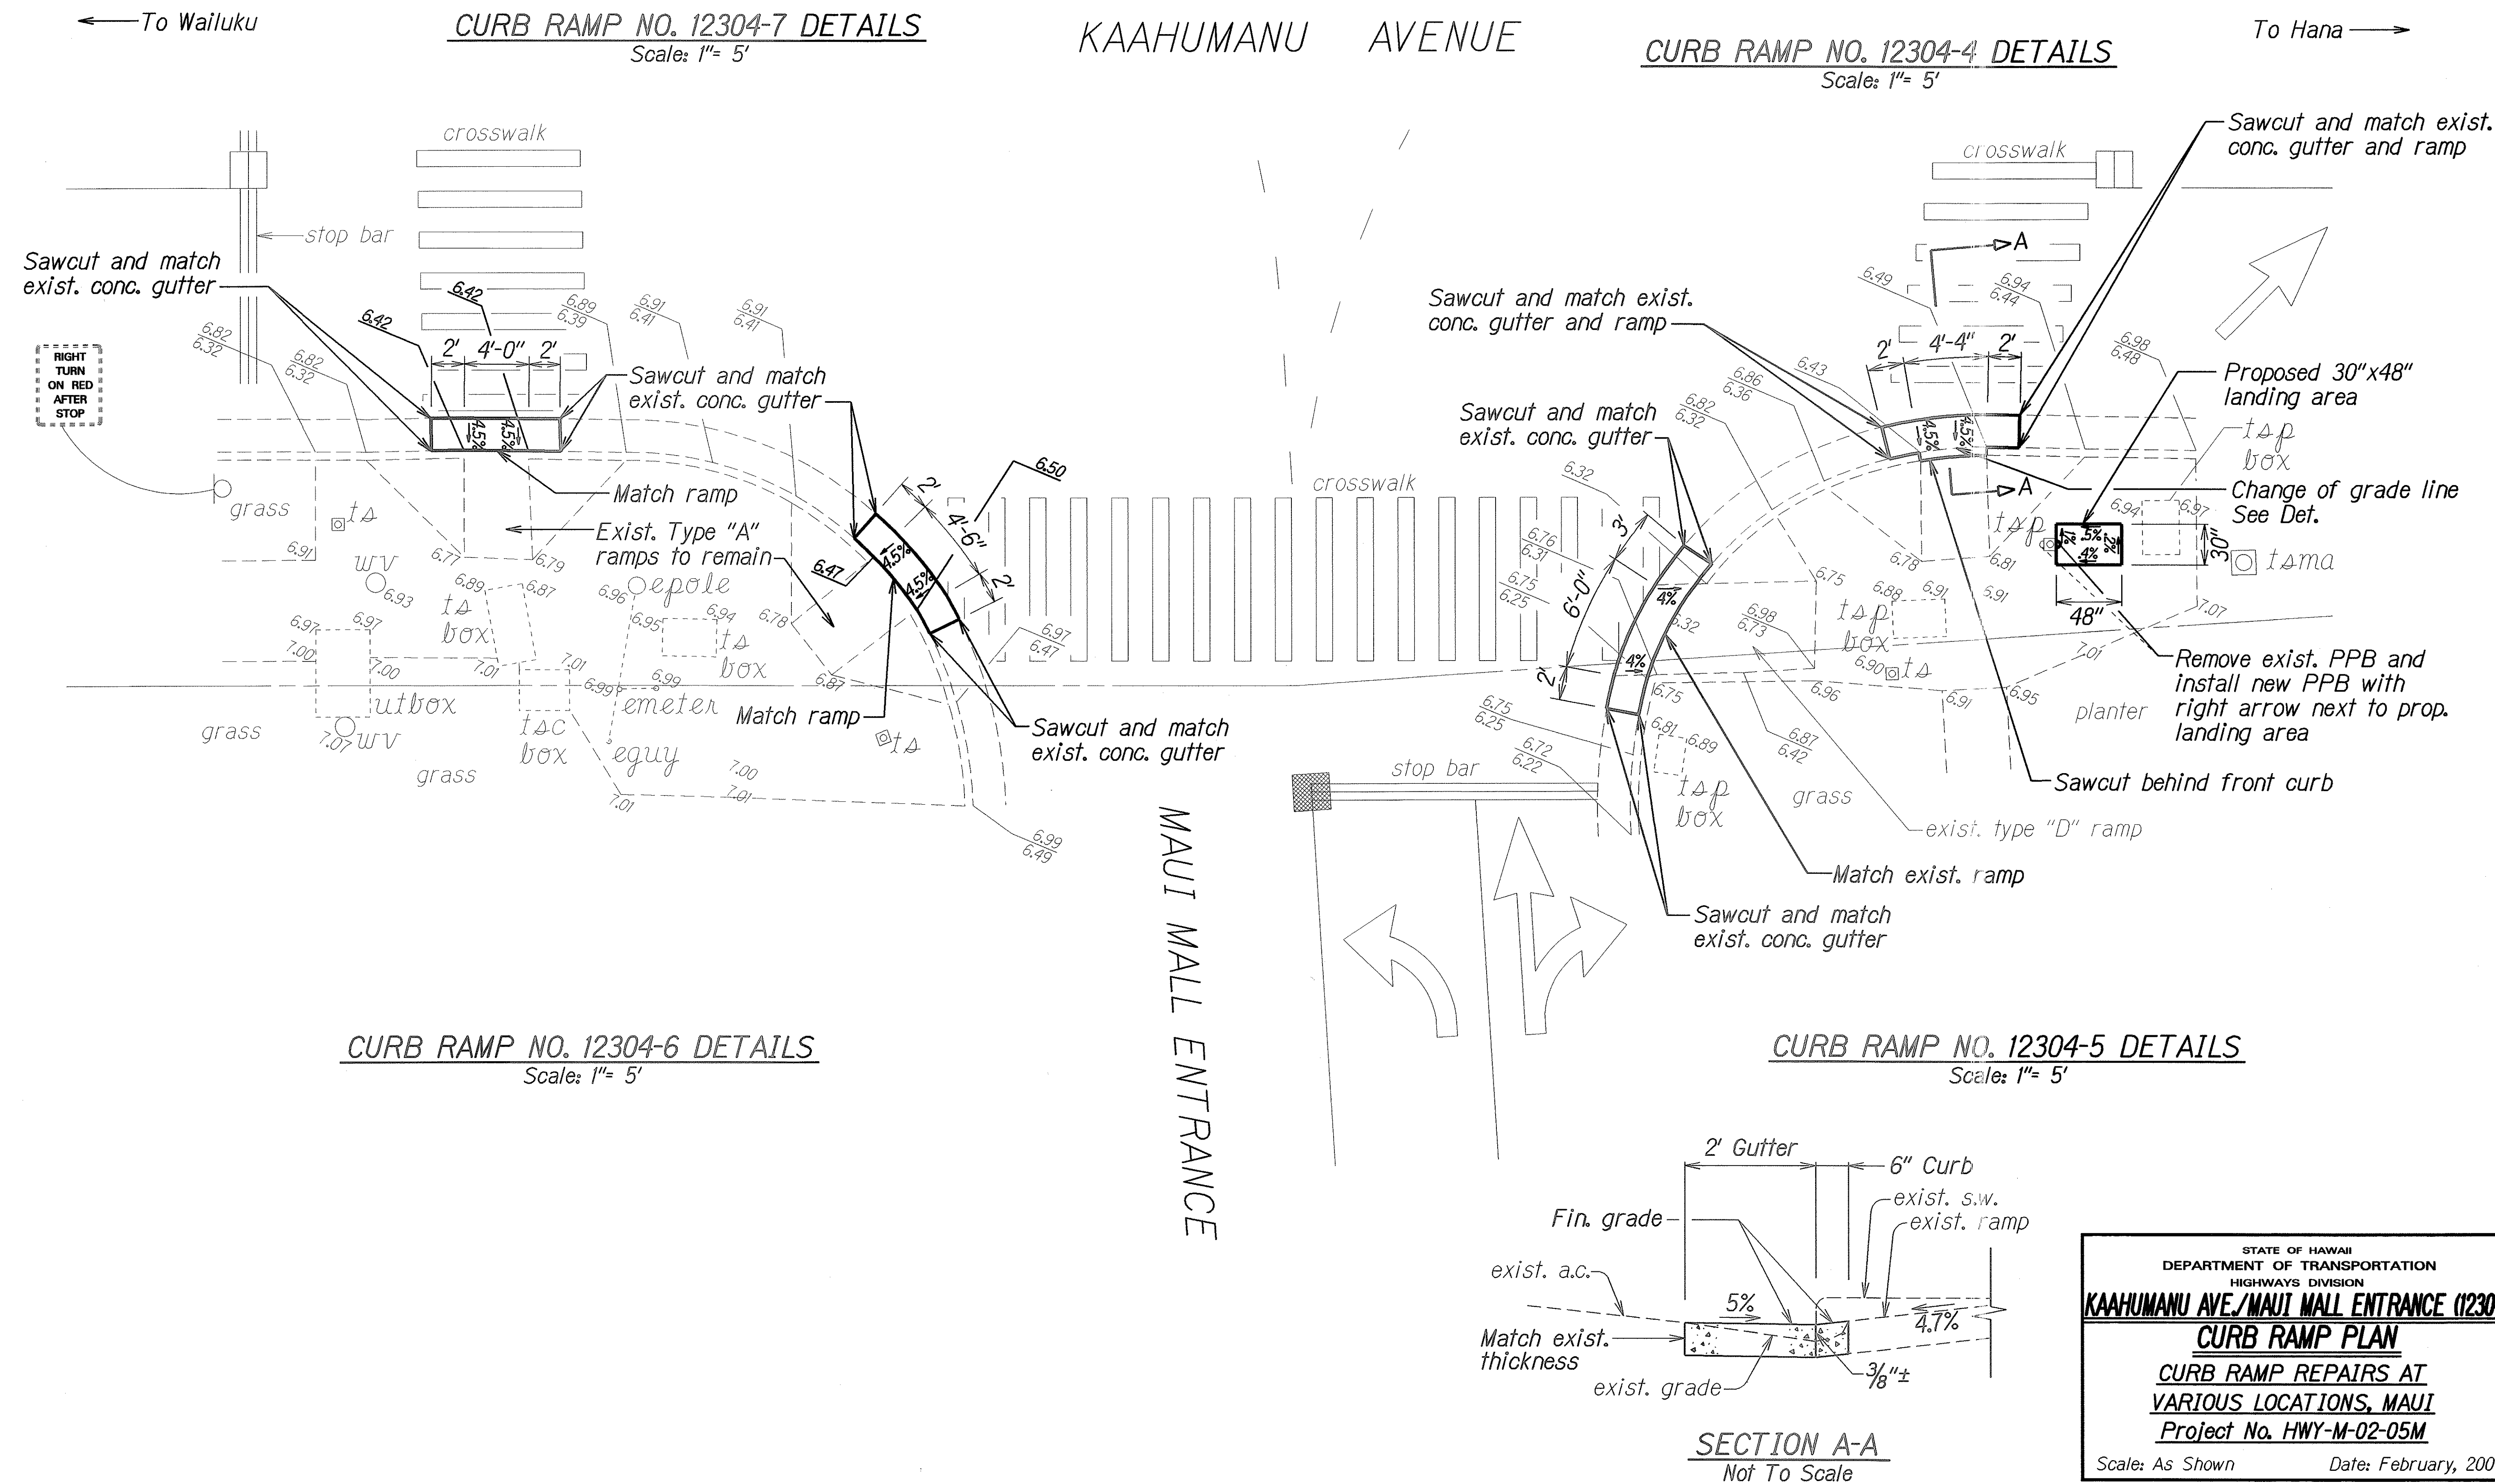

FED. ROAD DIST. NO.	STATE	PROJ. NO.	FISCAL YEAR	SHEET NO.	TOTAL SHEETS
HAWAII	HAW.	HWY-M-02-05M	2005	31	44

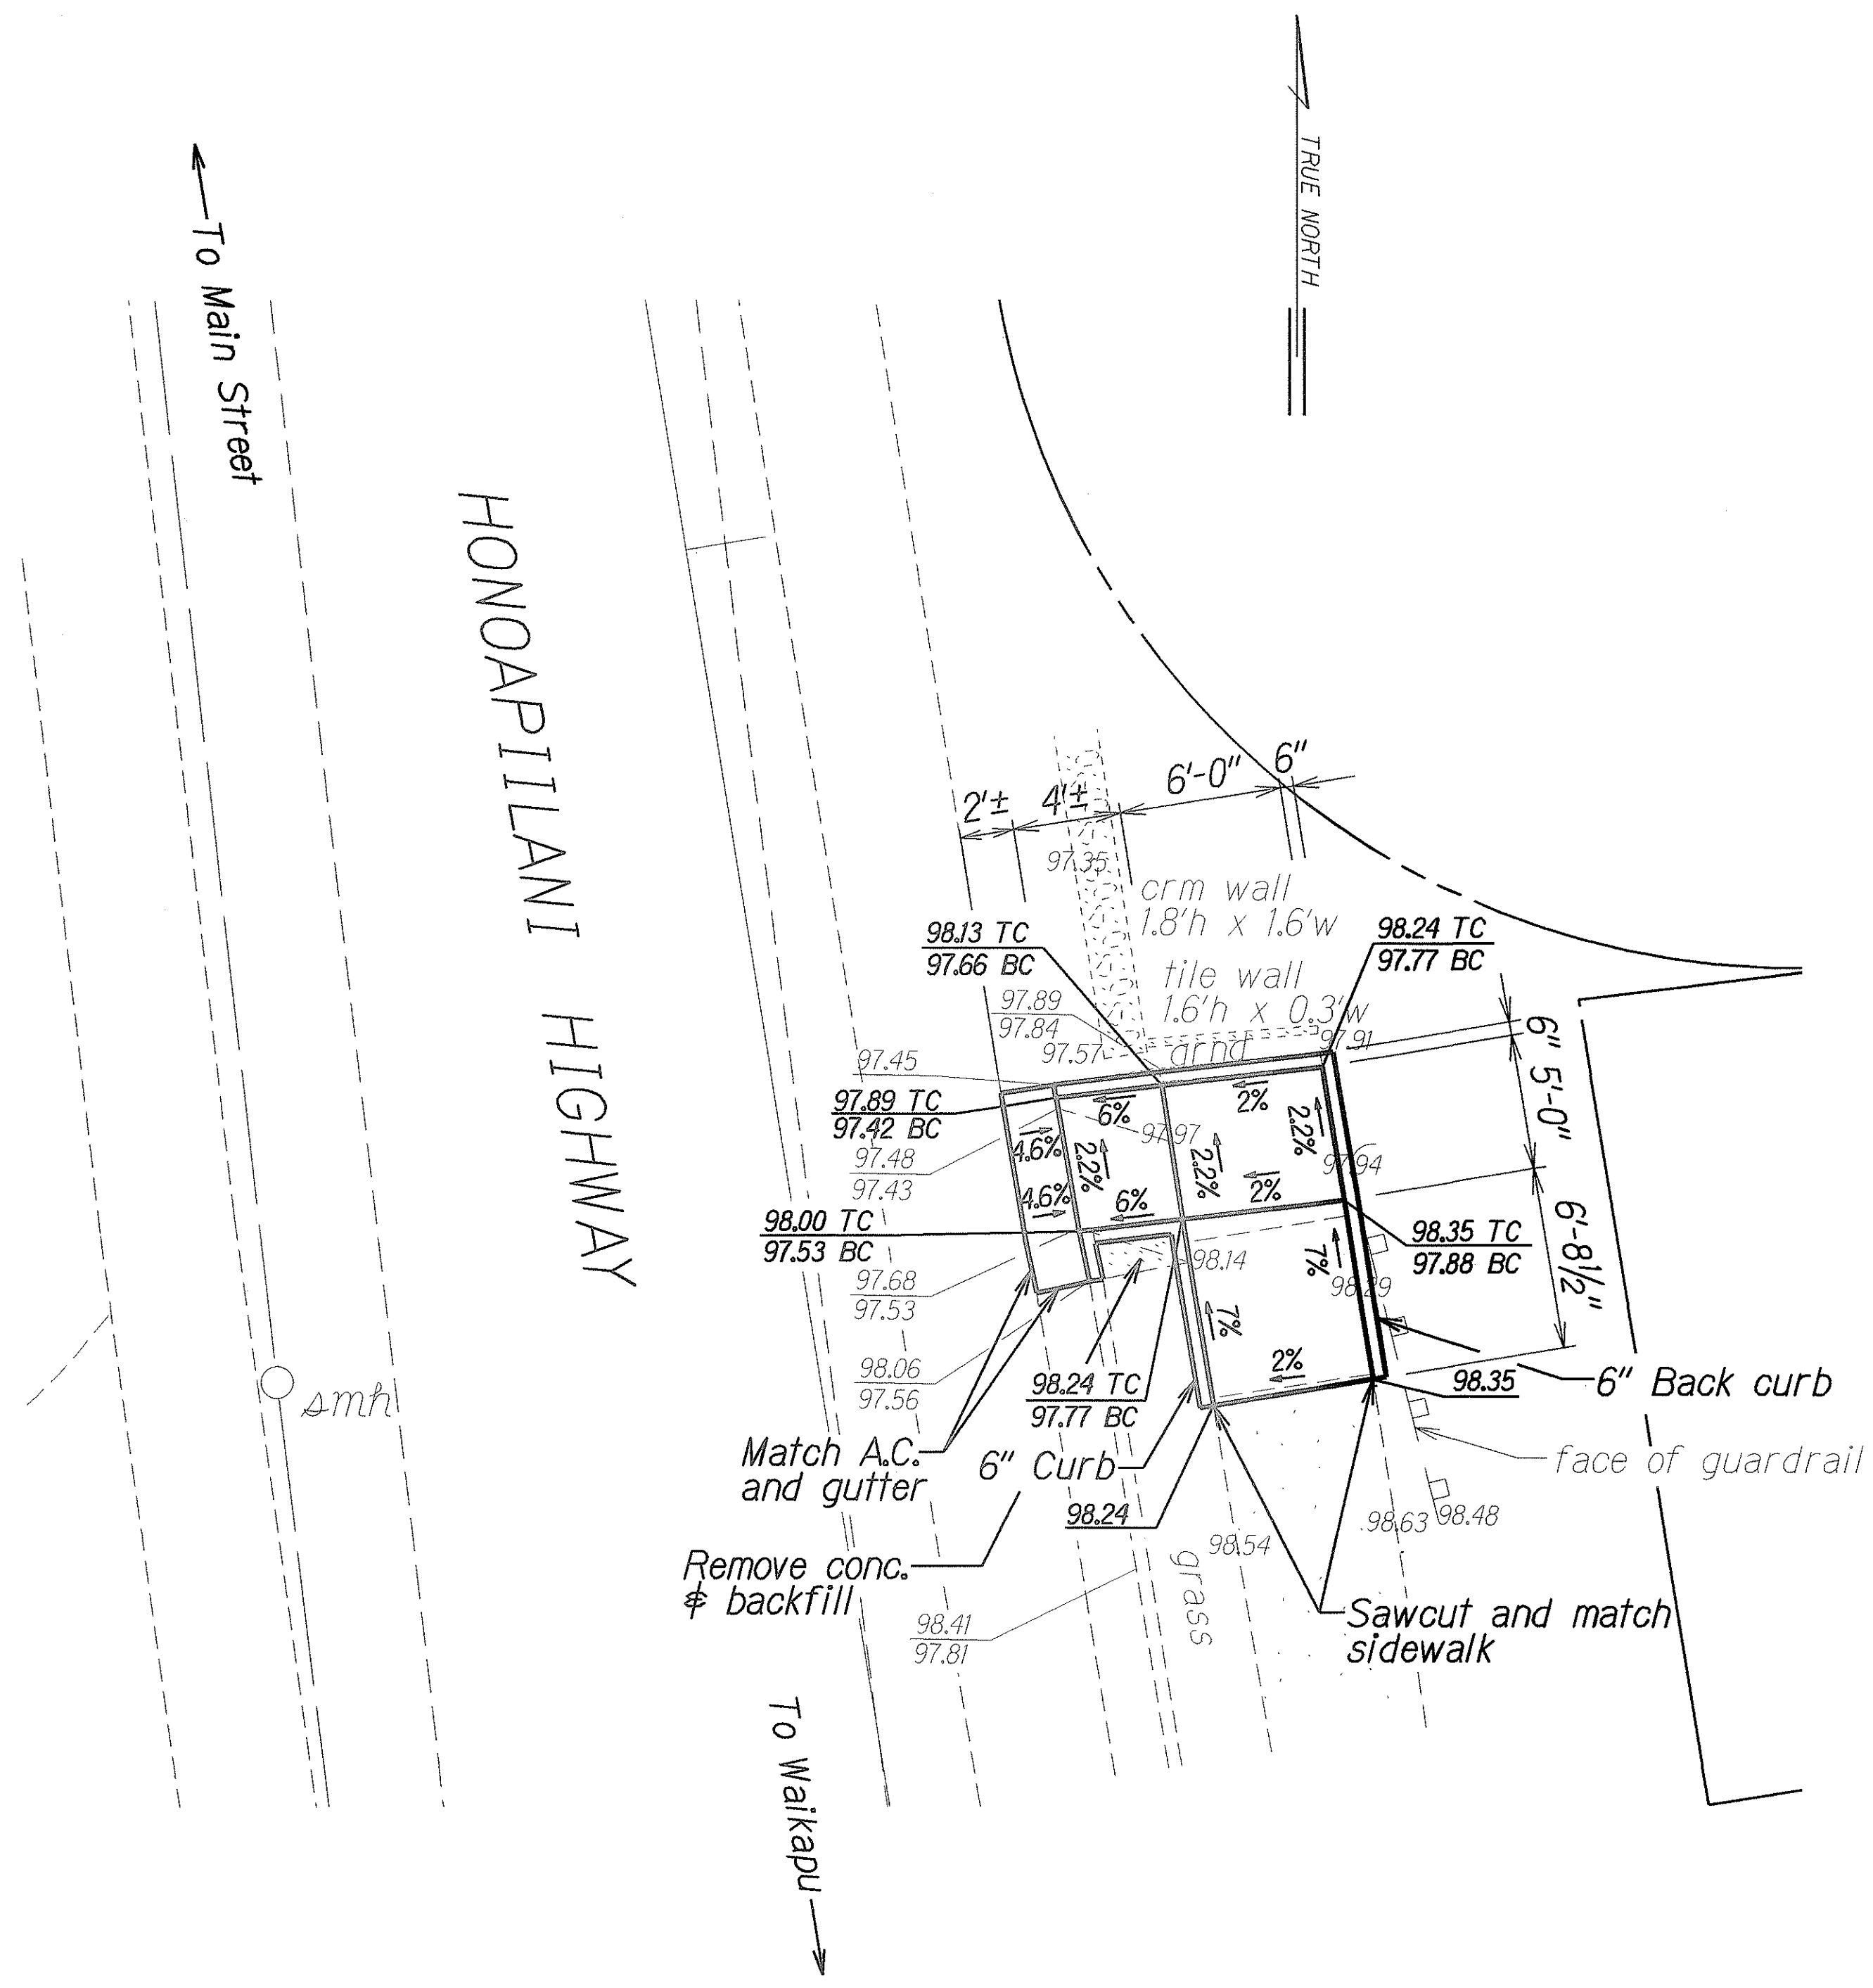

CURB RAMP NO. 31504-1 DETAILS
Scale: 1"= 5'

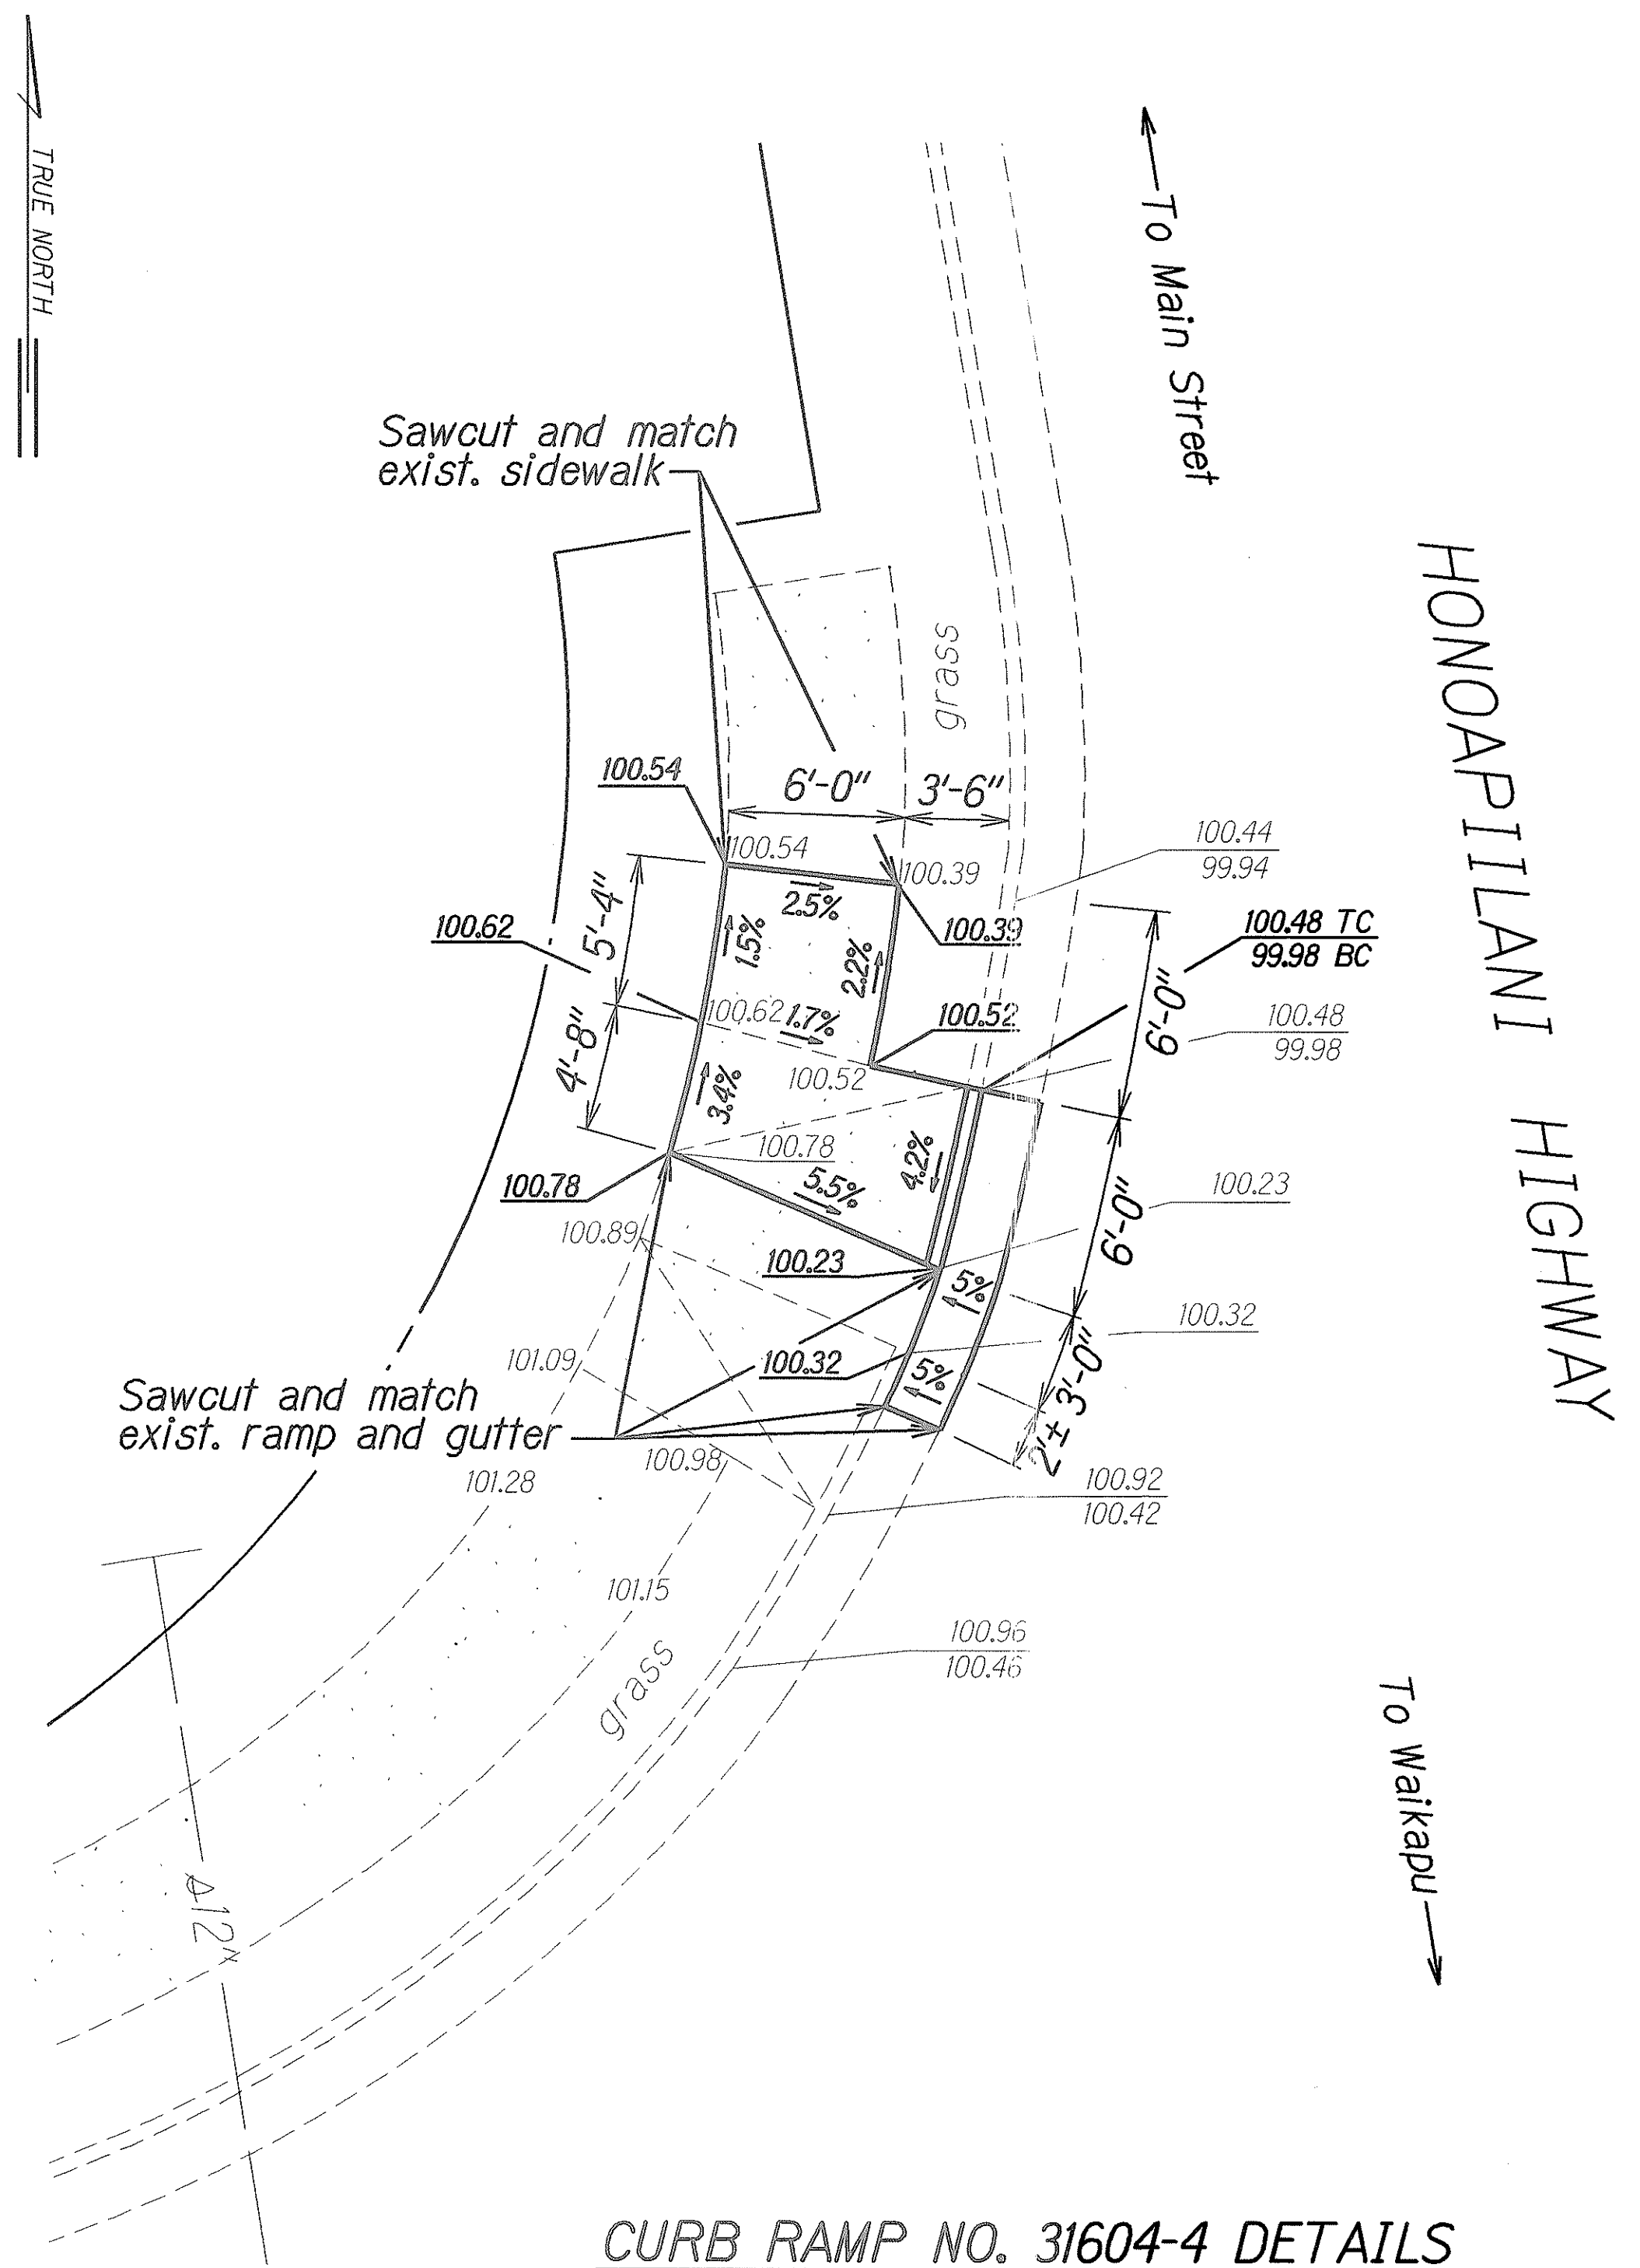

CURB RAMP NO. 31604-4 DETAILS
Scale: 1"= 5'

ORIGINAL PLAN	DATE
DESIGNED BY	3/05
CHECKED BY	
NOTED BY	
PLANNED BY	

STATE OF HAWAII
DEPARTMENT OF TRANSPORTATION
HIGHWAYS DIVISION

HONOPIILANI HWY. (31504)/KEHALANI


MAUKA (31604) CURB RAMP PLAN

CURB RAMP REPAIRS AT
VARIOUS LOCATIONS, MAUI
Project No. HWY-M-02-05M

Scale: As Shown Date: February, 2005

SHEET No. CC-17 OF 19 SHEETS

FED. ROAD DIST. NO.	STATE	PROJ. NO.	FISCAL YEAR	SHEET NO.	TOTAL SHEETS
HAWAII	HAW.	HWY-M-02-05M	2005	32	44

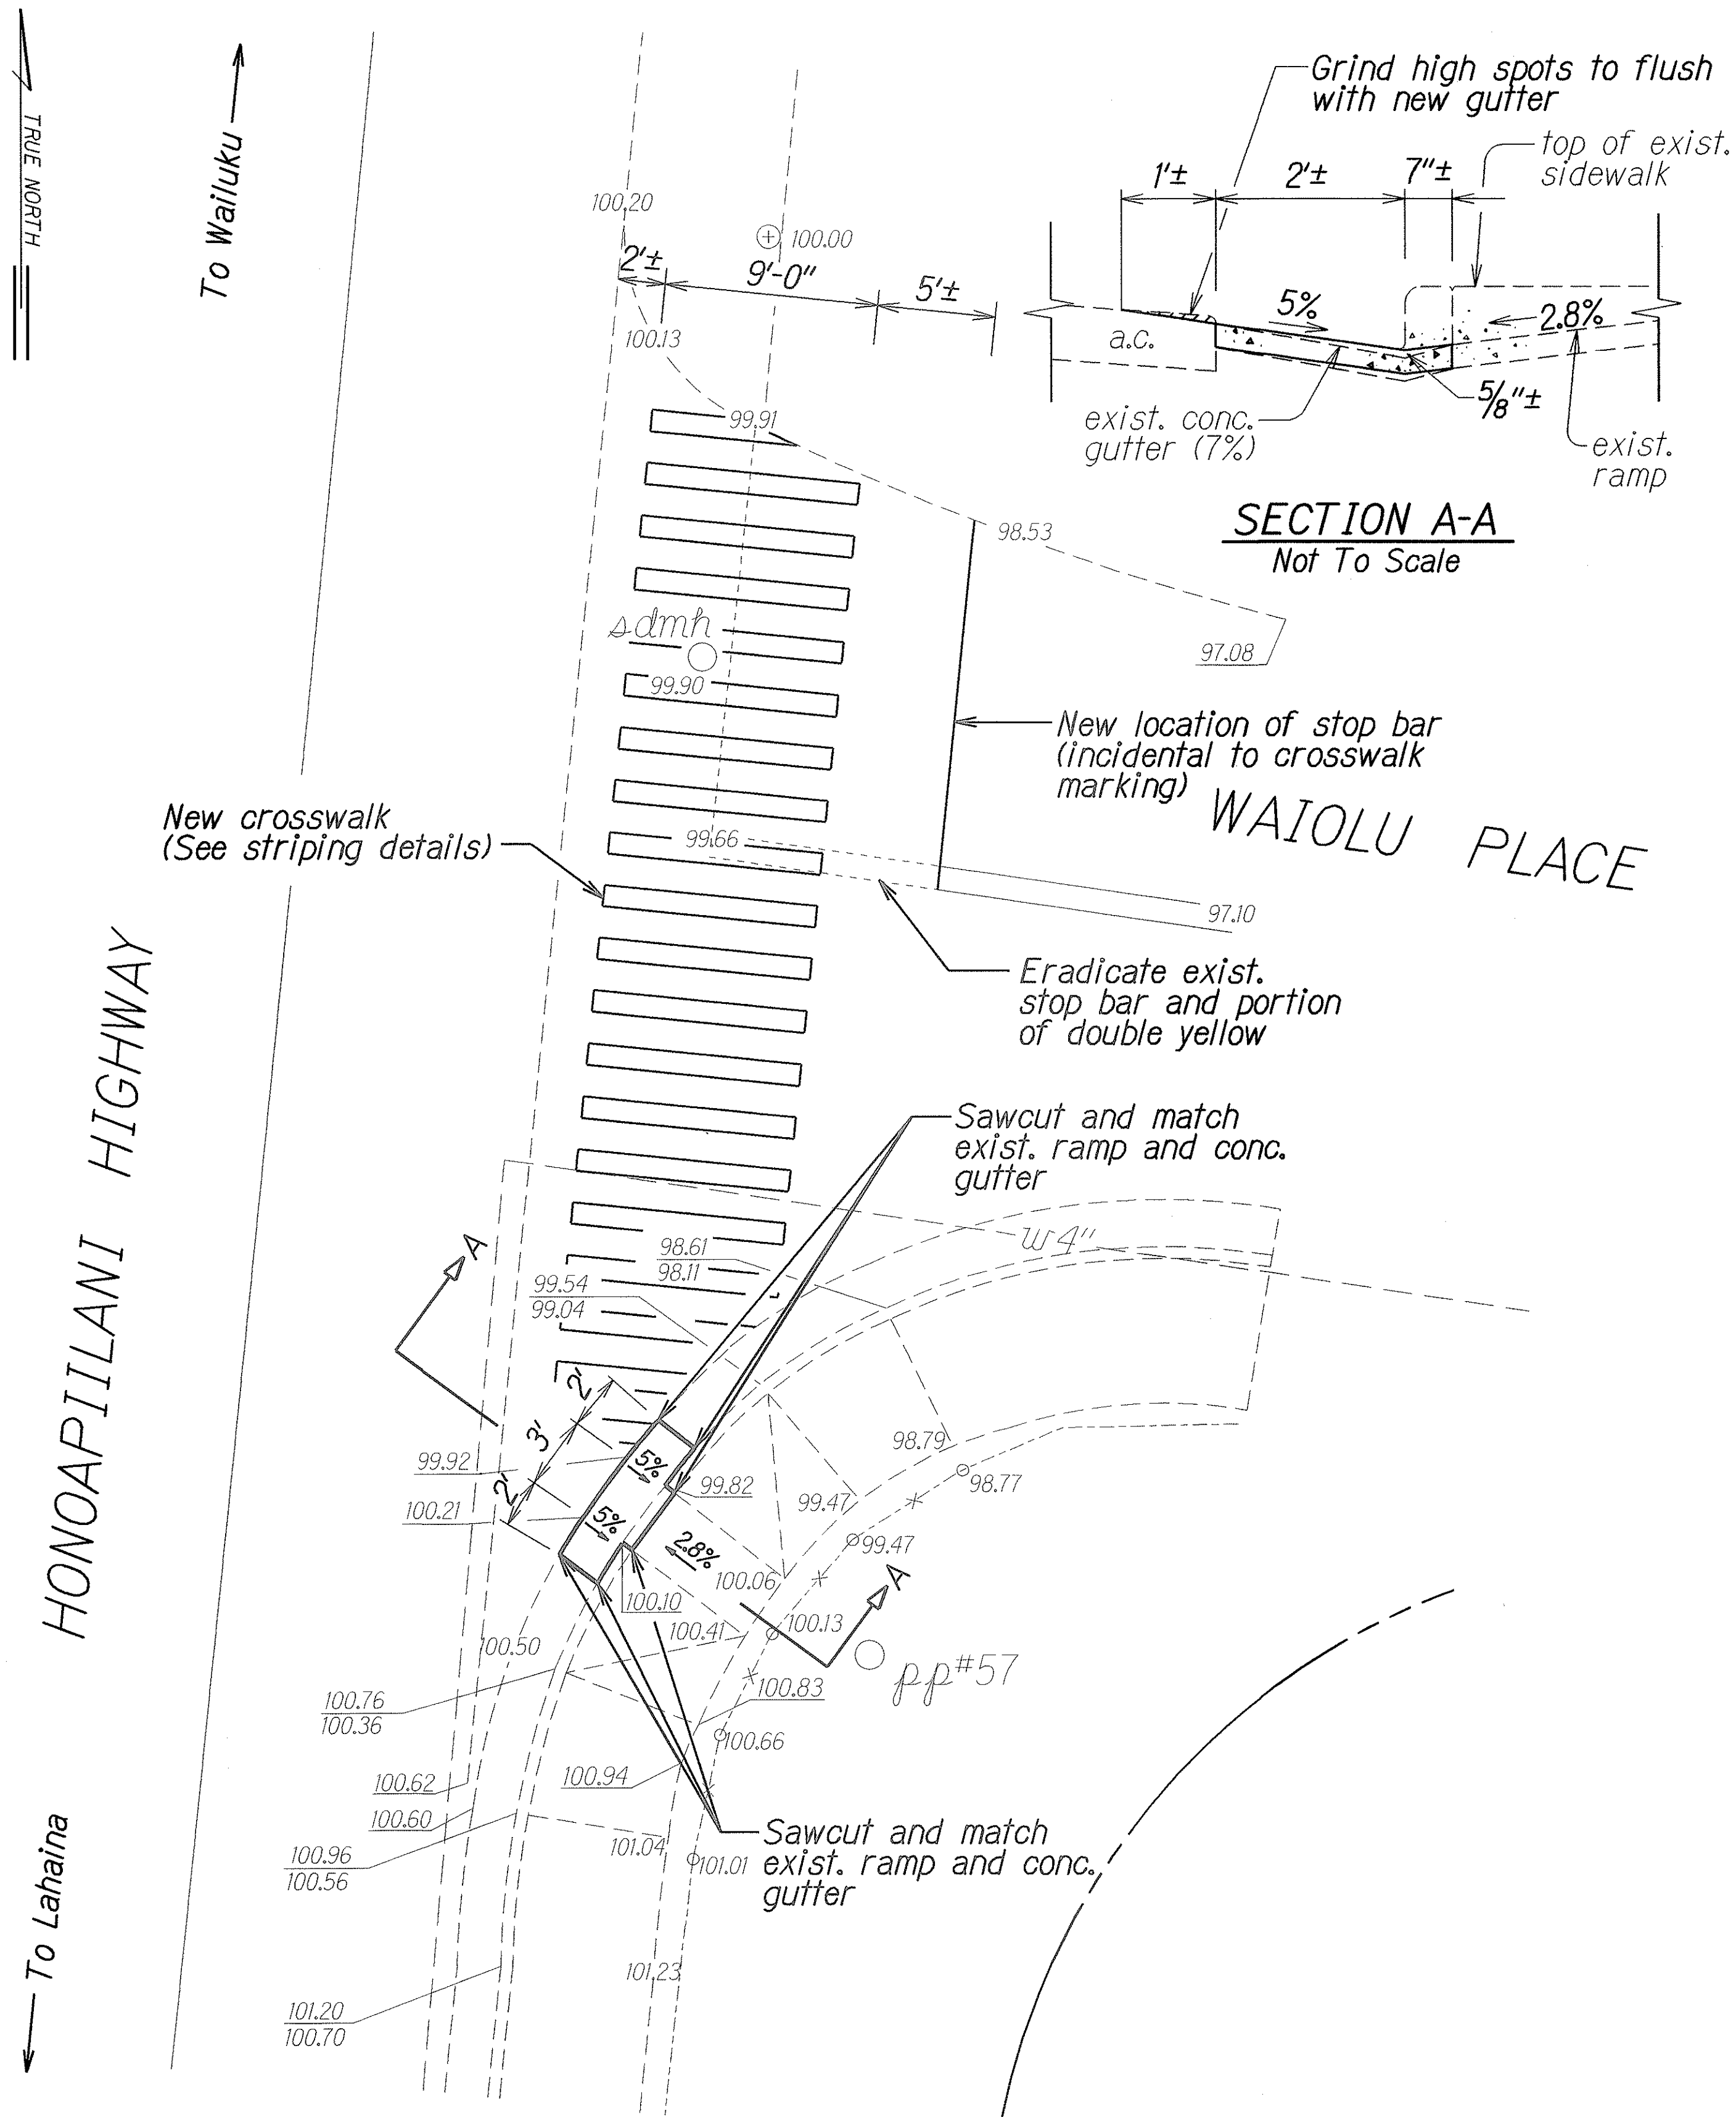

CURB RAMP NO. 31704-1 DETAILS
 Scale: 1"= 5'

ORIGINAL PLAN	SURVEY PLOTTED BY	DATE
NOTE BOOK	DRAWN BY	3/05
DESIGNED BY	CHECKED BY	
NOTED BY		
PLANNED BY		

STATE OF HAWAII
 DEPARTMENT OF TRANSPORTATION
 HIGHWAYS DIVISION
HONOAPIILANI HWY./WAIOLU PL. (31704)
CURB RAMP PLAN
CURB RAMP REPAIRS AT
VARIOUS LOCATIONS, MAUI
Project No. HWY-M-02-05M
 Scale: As Shown Date: February, 2005
 SHEET No. CC-18 OF 19 SHEETS

