
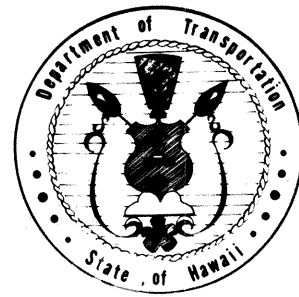


| INDEX TO DRAWINGS |                                                                                                                              |
|-------------------|------------------------------------------------------------------------------------------------------------------------------|
| SHEET NO.         | DESCRIPTION                                                                                                                  |
| 1                 | TITLE SHEET                                                                                                                  |
| 2                 | TYPICAL SECTIONS                                                                                                             |
| 3-5               | PLAN & PROFILE                                                                                                               |
| 6                 | INTERSECTION DETAIL                                                                                                          |
| 7-14              | MISCELLANEOUS & STANDARD ROADWAY DETAILS                                                                                     |
| 15                | RESURFACING & GRASSED SURFACES PLAN                                                                                          |
| 16-22             | DRAINAGE PLANS & DETAILS                                                                                                     |
| 23-53             | TRAFFIC MARKINGS, SIGNING & SIGNAL/HWY. LIGHTING PLANS, MISCELLANEOUS, TYPICAL AND STANDARD TRAFFIC/HIGHWAY LIGHTING DETAILS |
| 54-57             | CROSS SECTIONS                                                                                                               |

SUPPLEMENTARY SHEETS TO THIS PROJECT ARE SHEET NOS. (a.) C.O.4S-1 & C.O.12S-1. TOTAL SHEET COUNT AFTER "AS-BUILT" POSTINGS: 59 SHEETS




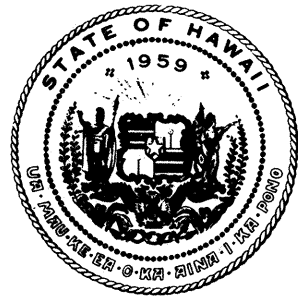


STATE OF HAWAII  
DEPARTMENT OF TRANSPORTATION  
HIGHWAYS DIVISION  
"AS-BUILT"  
PLANS FOR

PUUNENE AVENUE IMPROVEMENTS, PHASE II  
HAWAII STREET TO KUIHELANI HIGHWAY  
F.A.M. PROJECT NO. M-3500(I)

DISTRICT OF WAILUKU  
ISLAND OF MAUI

| FED. ROAD DIST. NO. | STATE | FEDERAL AID PROJ. NO. | FISCAL YEAR | SHEET NO. | TOTAL SHEETS |
|---------------------|-------|-----------------------|-------------|-----------|--------------|
| HAWAII              | HAW.  | M-3500(I)             | 1980        | 1         | 57           |

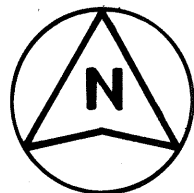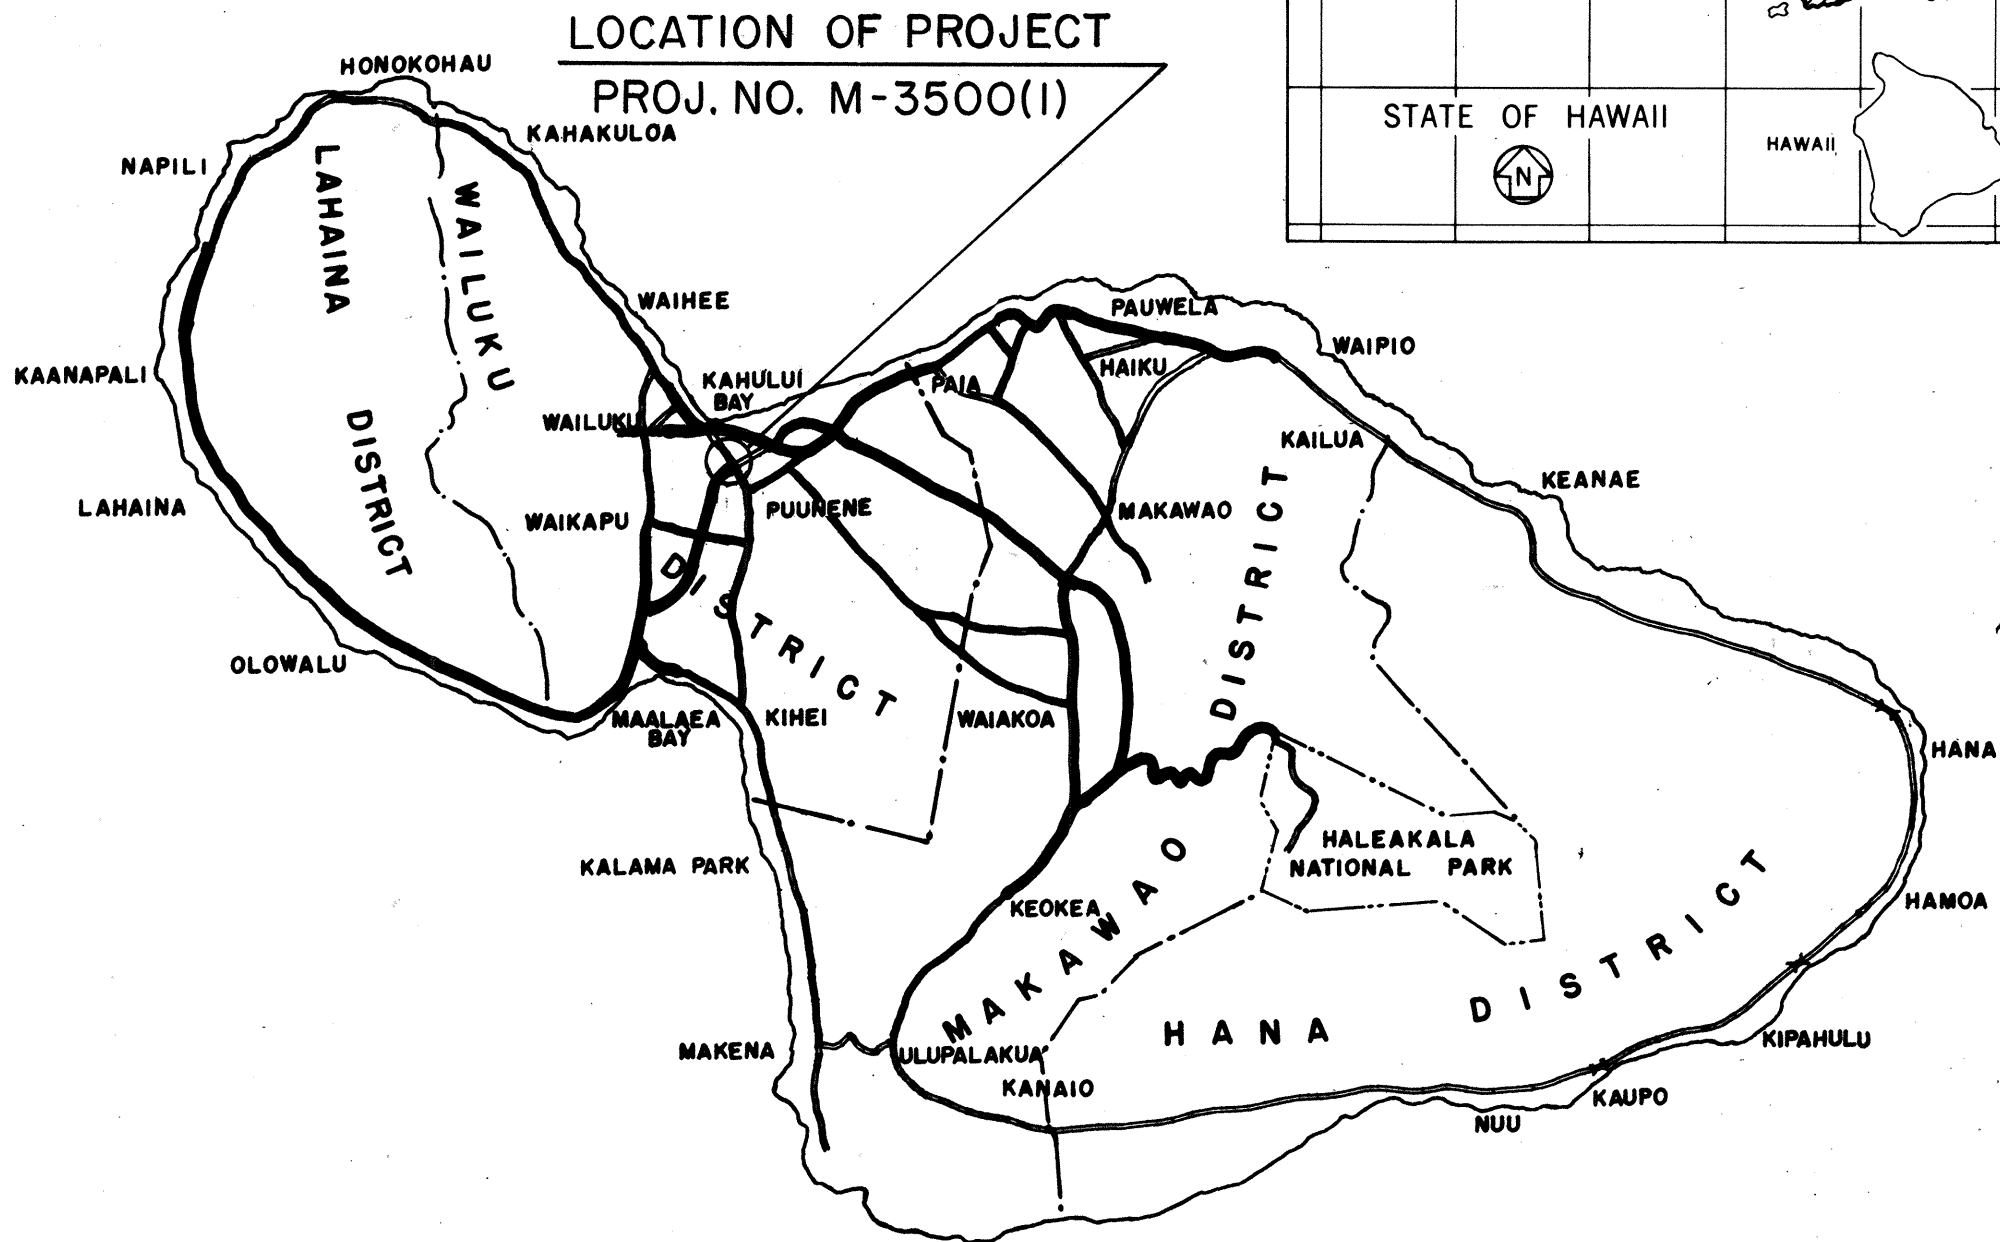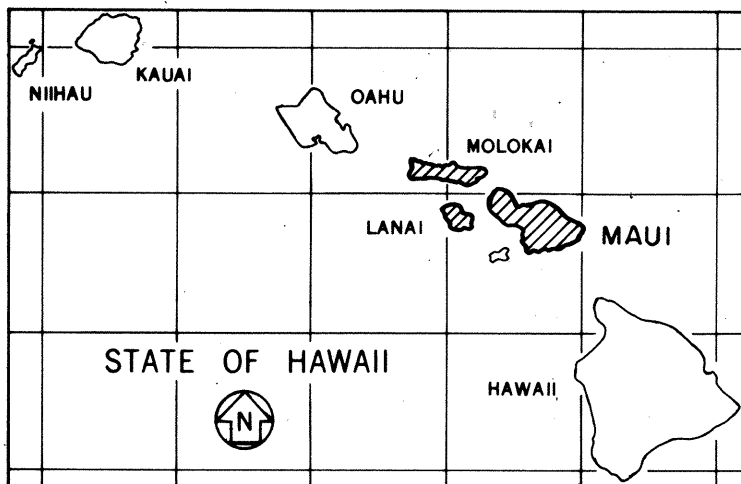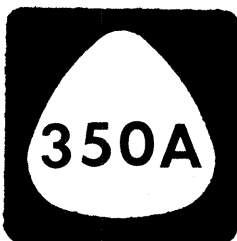

FEDERAL AID PROJECTS PREVIOUSLY CONSTRUCTED OR UNDER CONSTRUCTION

END PROJECT  
N.B. LANE STA. 100+00

DESIGN DESIGNATION

|                    |        |
|--------------------|--------|
| CURRENT ADT (1980) | 14,600 |
| DESIGN ADT (2000)  | 28,100 |
| DHV                | 3,045  |
| D                  | 65/35  |
| T                  | 3.5 %  |
| V                  | 35 MPH |


ALL CHANGES MADE DURING CONSTRUCTION HAVE BEEN INCORPORATED ON THESE PLANS IN RED EXCEPT CHANGES IN THE ORIGINAL THEORETICAL QUANTITIES. FOR ACTUAL QUANTITIES, REFER TO PROJECT LEDGER AND/OR COMPUTATION BOOK.

Manuel J. Silva  
RESIDENT ENGINEER

11 MAY 1981  
DATE


DEPARTMENT OF TRANSPORTATION  
FEDERAL HIGHWAY ADMINISTRATION  
APPROVED: [Signature]  
DIVISION ADMINISTRATOR DATE 5-16-80

DEPARTMENT OF TRANSPORTATION  
STATE OF HAWAII  
APPROVED: [Signature]  
DIR. OF TRANSPORTATION DATE May 8, 1980

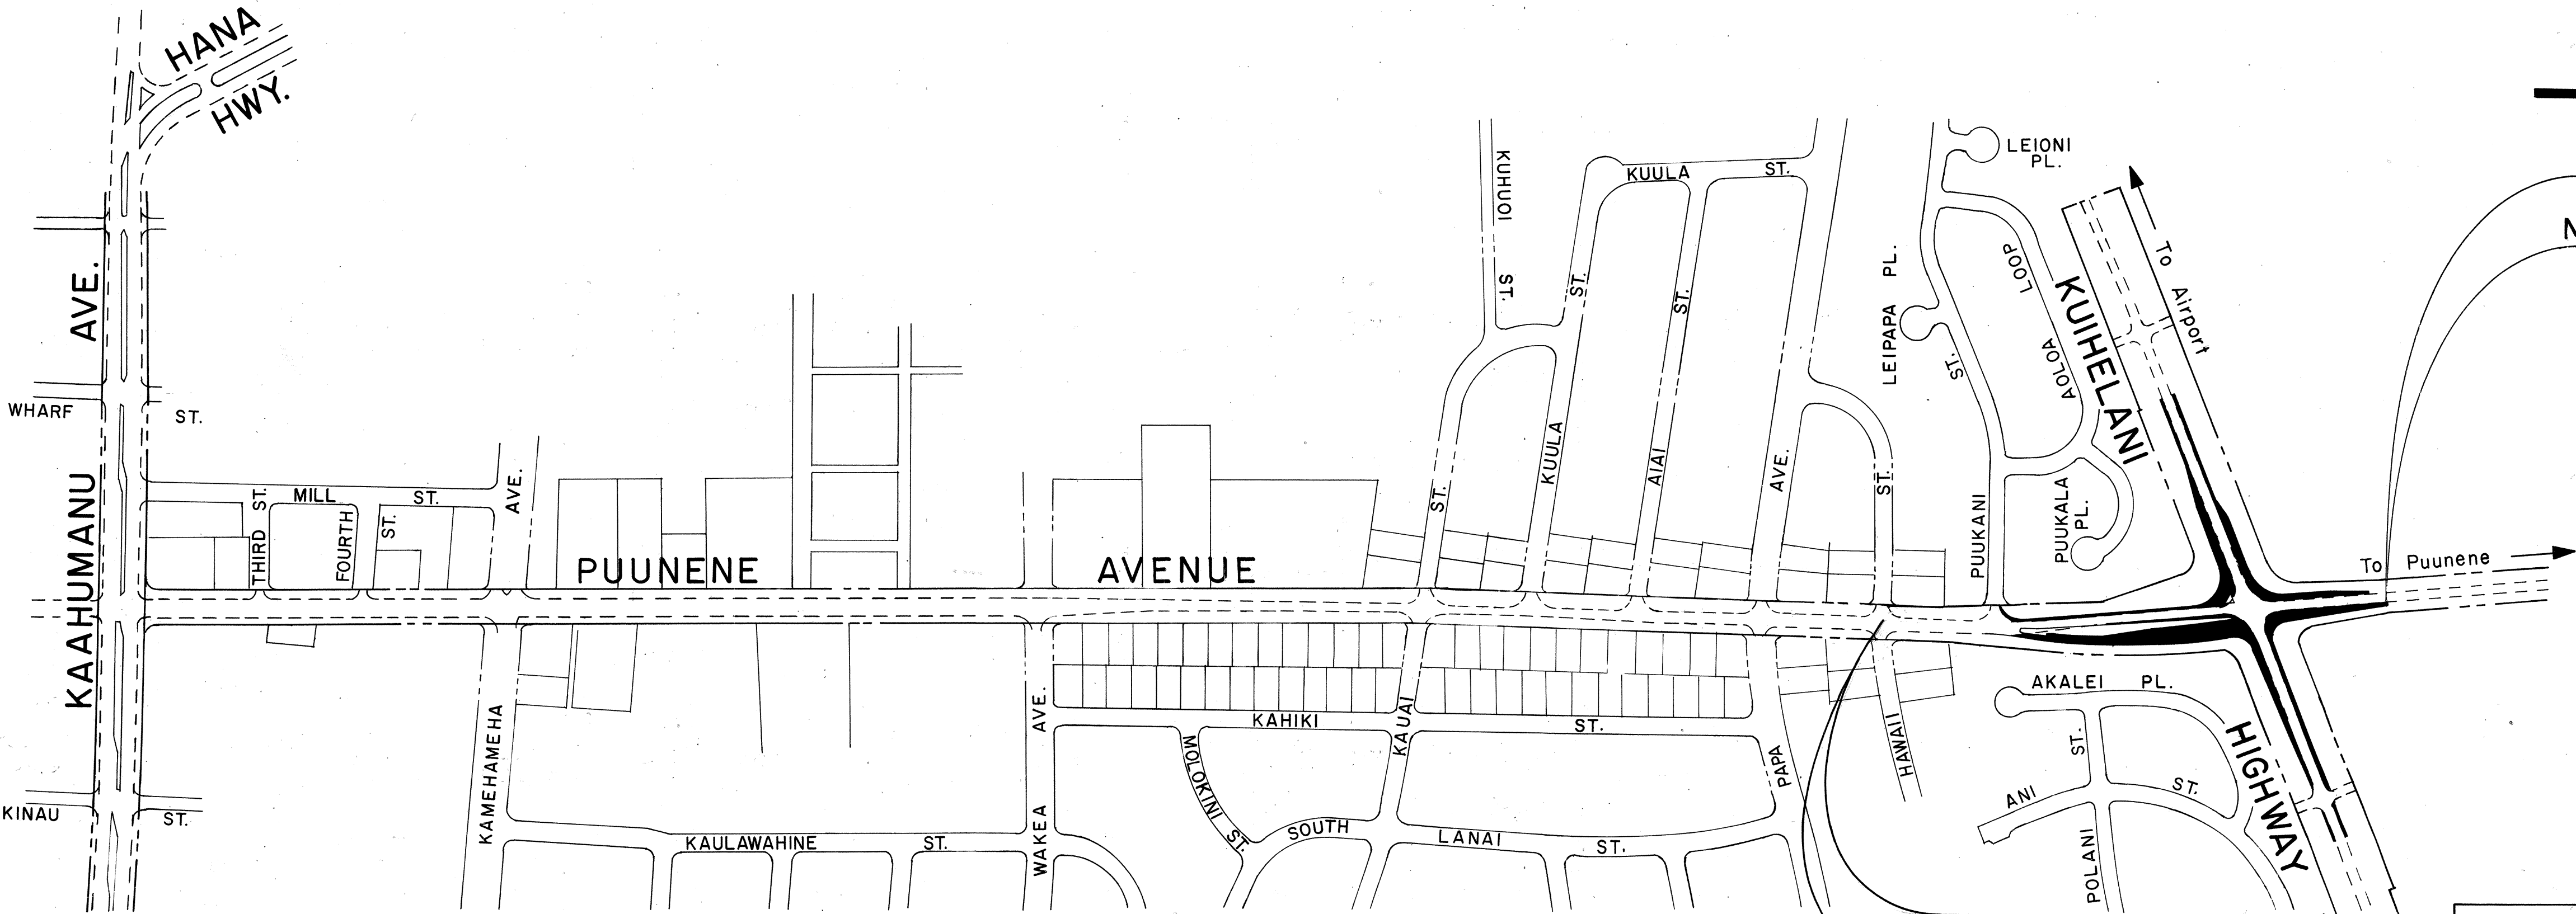

LAYOUT PLAN

LENGTH OF PROJECT .... 0.270 MILE

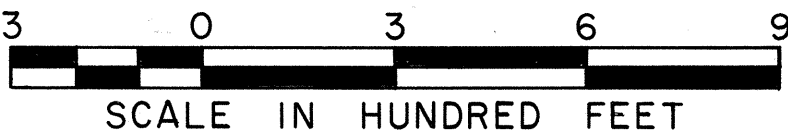

DESIGNED BY A. Nishimura 548-7537 May 1980  
P. S. & E. BY DATE