




FED. ROAD DIST. NO.	STATE	PROJ. NO.	FISCAL YEAR	SHEET NO.	TOTAL SHEETS
HAWAII	HAW.	HWY-M-06-98	2000	7	14

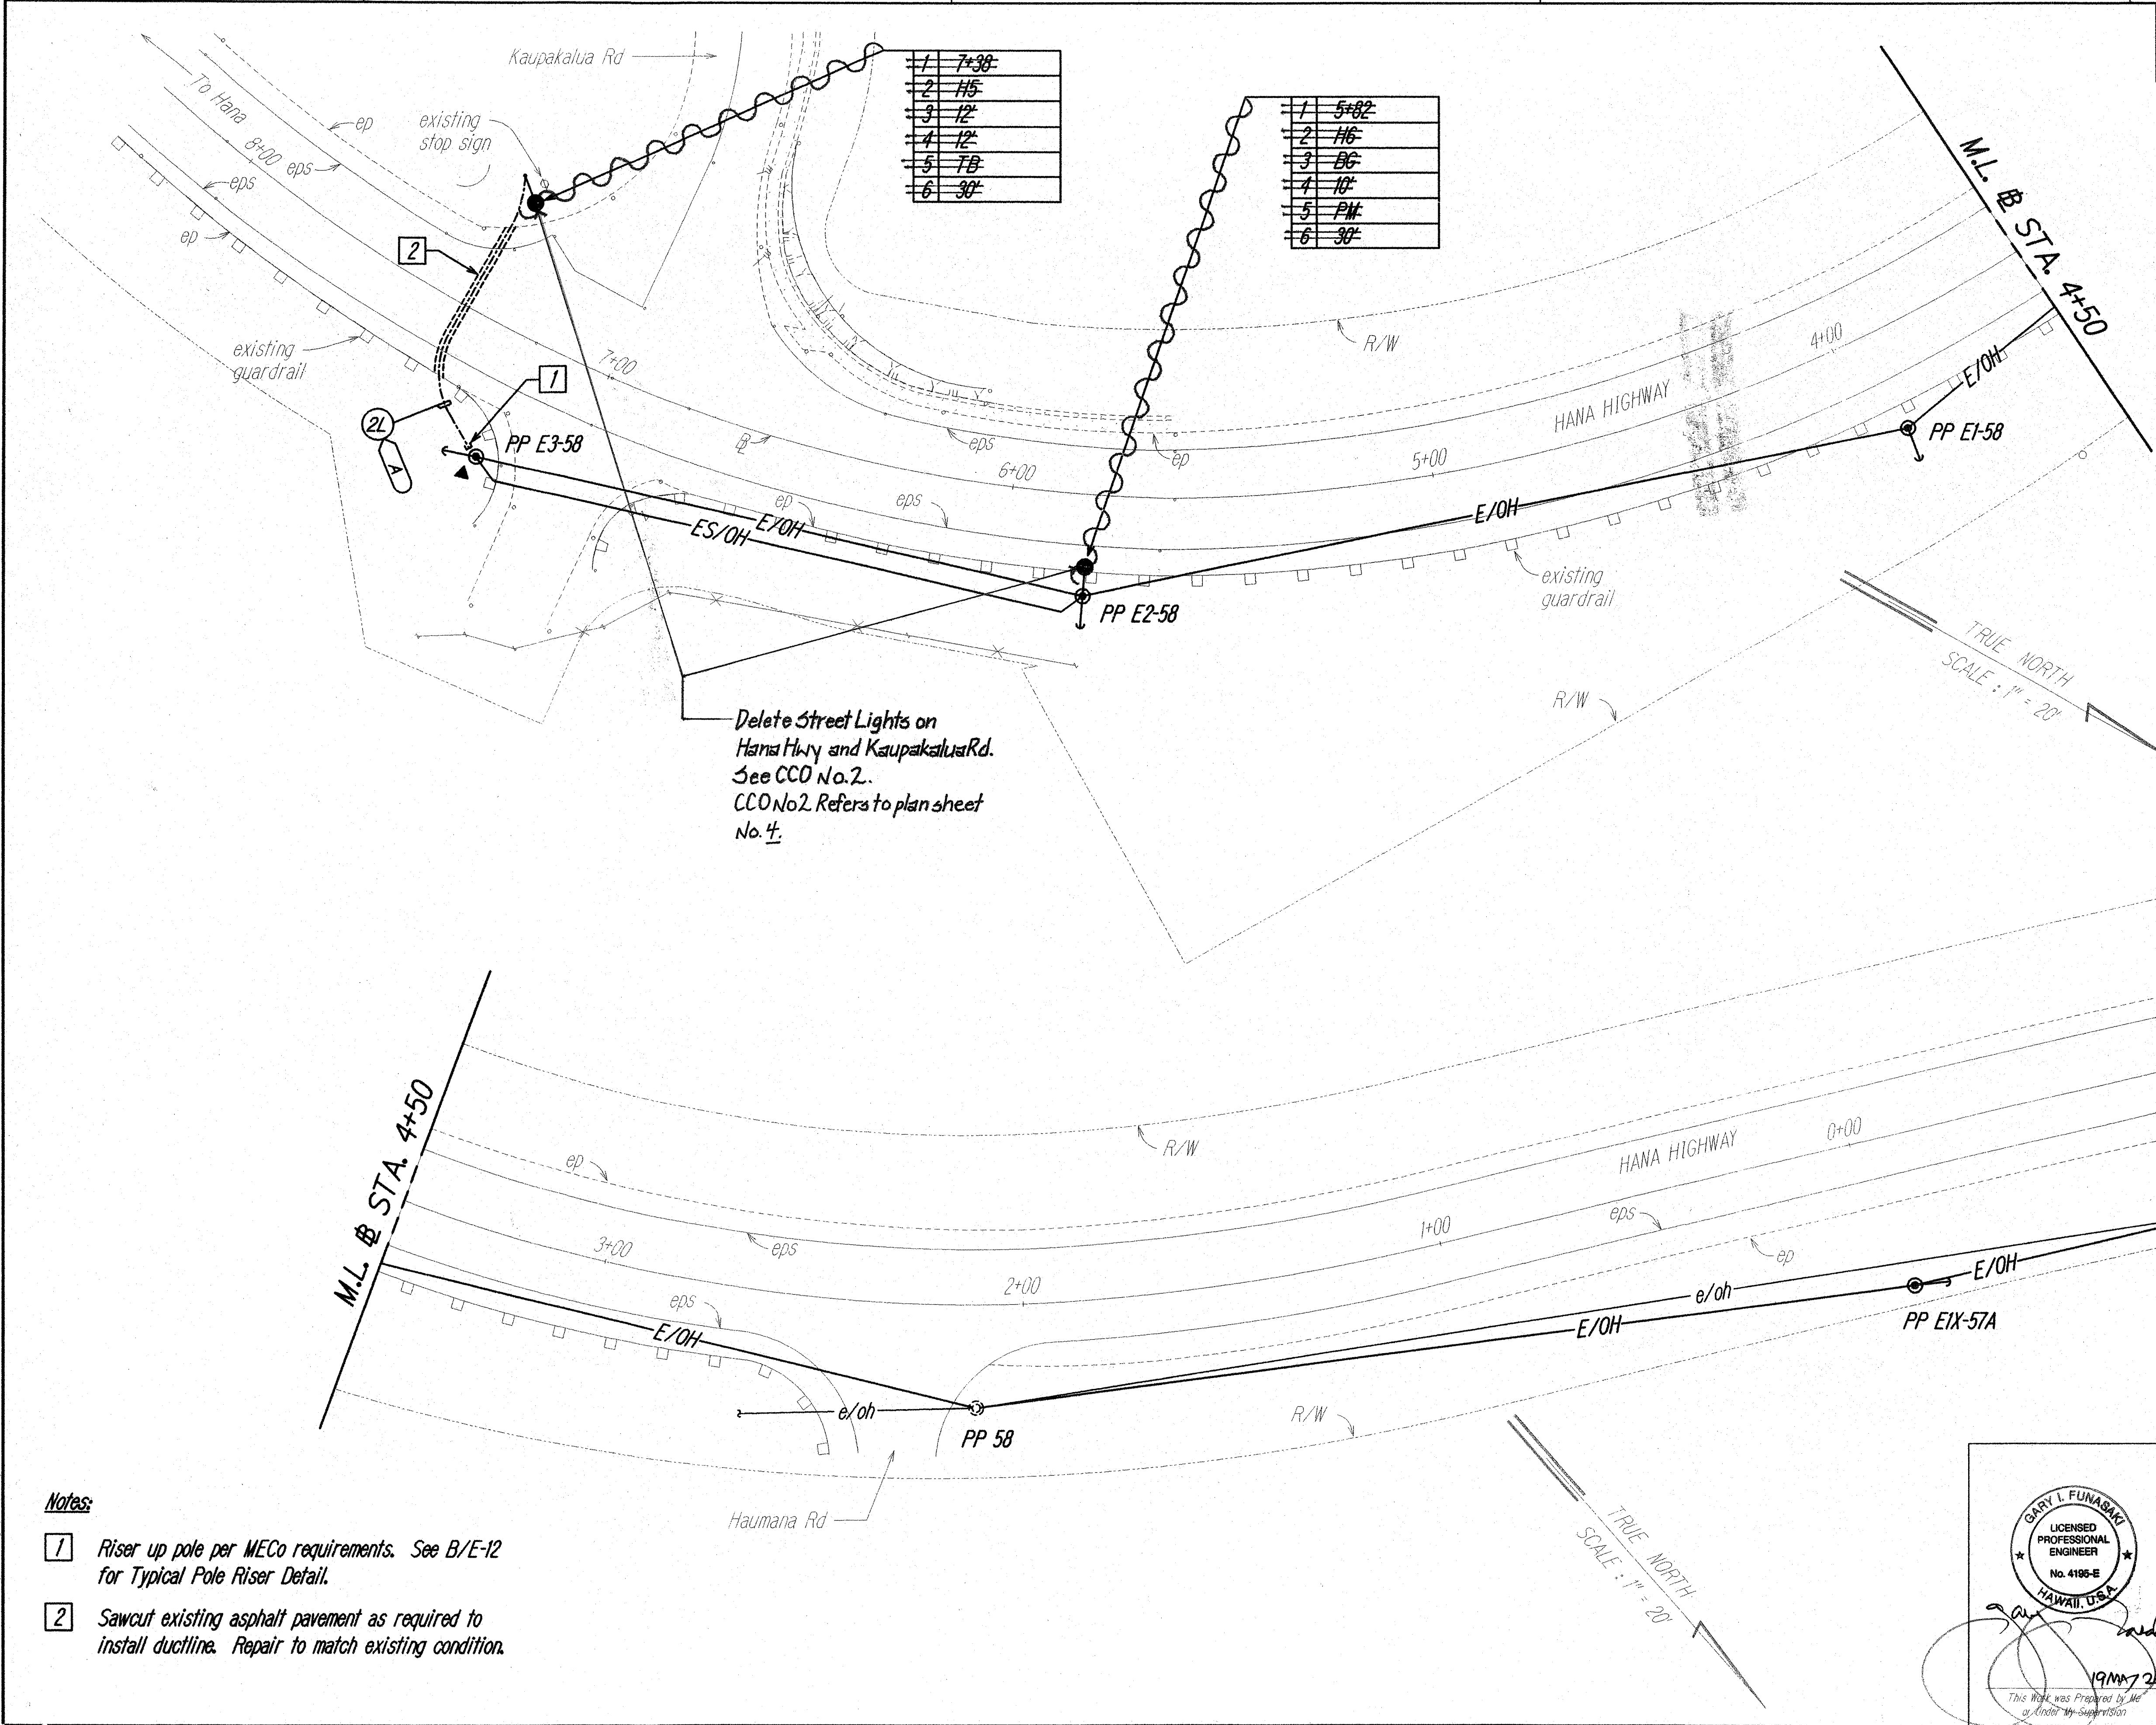

ORIGINAL PLAN	SURVEY PLOTTED BY	DATE
NOTE BOOK	DRAWN BY	
	DESIGNED BY	
	QUANTITIES BY	
	CHECKED BY	

Notes:

- 1 Riser up pole per MECo requirements. See B/E-12 for Typical Pole Riser Detail.
- 2 Sawcut existing asphalt pavement as required to install ductline. Repair to match existing condition.

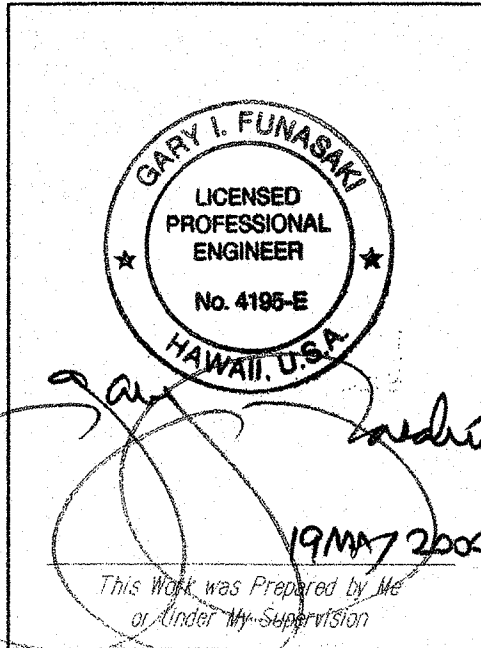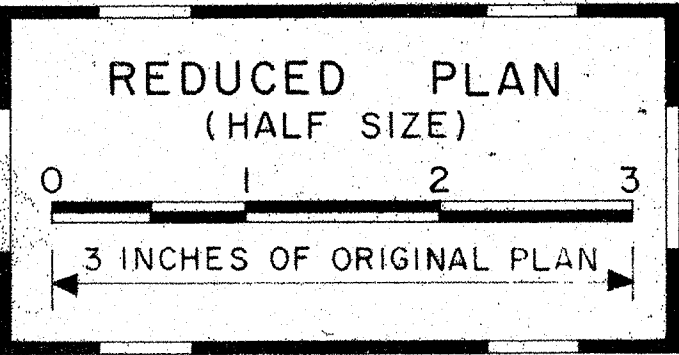

STATE OF HAWAII
DEPARTMENT OF TRANSPORTATION
HIGHWAYS DIVISION

HANA HWY @ KAUPAKALUA RD
LIGHTING PLAN

Street Lights at
Various Highway Locations
Project No. HWY-M-06-98

Scale: 1"=20' Date: May, 2000
SHEET No. E-5 OF 12 SHEETS

"AS-BUILT"