



FED. ROAD DIST. NO.	STATE	PROJ. NO.	FISCAL YEAR	SHEET NO.	TOTAL SHEETS
HAWAII	HAW.	HWY-M-06-98	2000	6	14

- Notes:
- 1 Riser up pole per MECo requirements. See B/E-12 for Typical Pole Riser Detail.
 - 2 Sawcut existing asphalt pavement as required to install ductline. Repair to match existing condition.

TRUE NORTH
SCALE: 1" = 20'

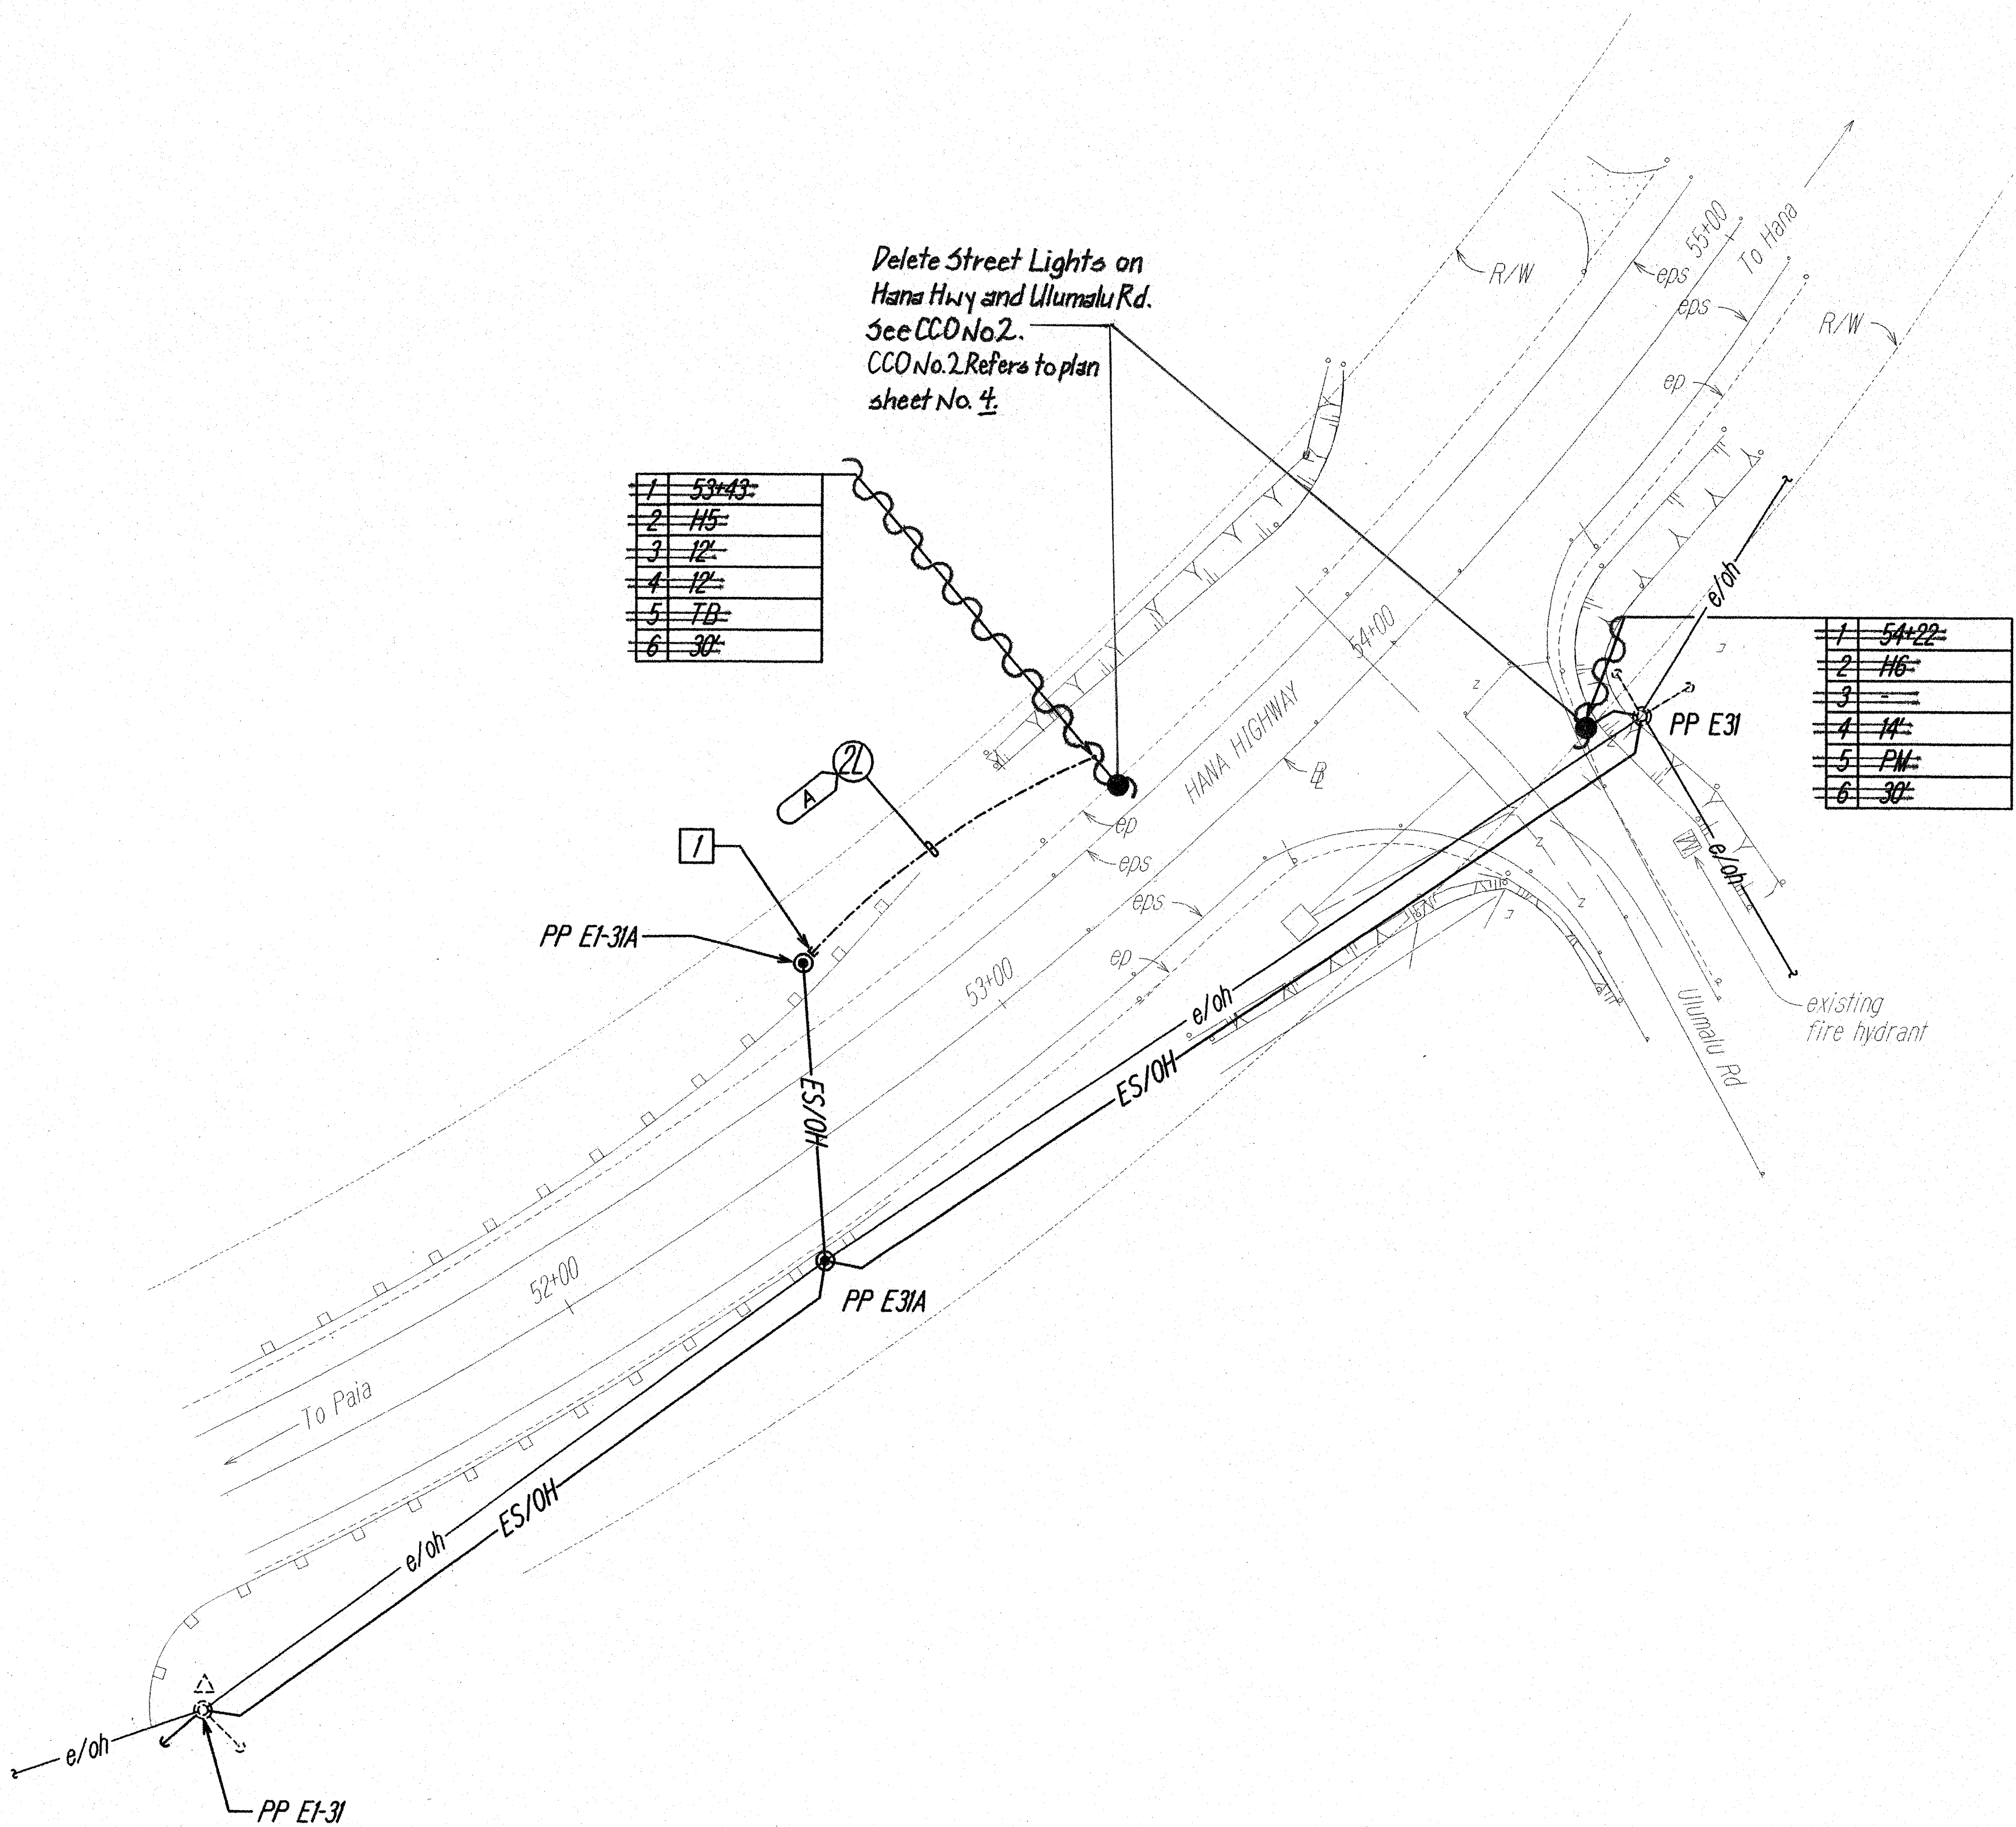

SURVEY PLOTTED BY	DATE
DRAWN BY	
TRACED BY	
QUANTITIES BY	
CHECKED BY	
ORIGINAL PLAN	
NOTE BOOK	
NO.	

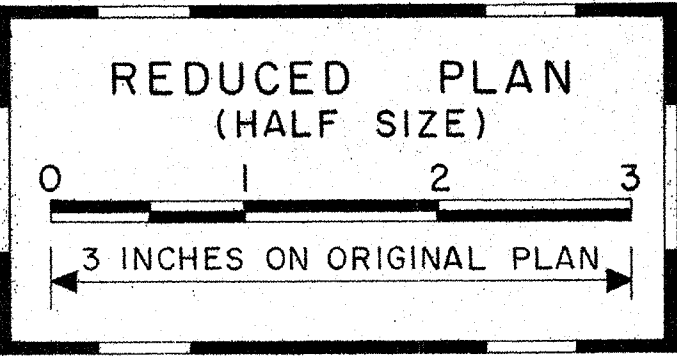

19 May 2000
This Work was Prepared by Me or Under My Supervision

STATE OF HAWAII
DEPARTMENT OF TRANSPORTATION
HIGHWAYS DIVISION

**HANA HWY @ ULUMALU RD
LIGHTING PLAN**

Street Lights at
Various Highway Locations
Project No. HWY-M-06-98

Scale: 1"=20' Date: May, 2000

SHEET No. E-4 OF 12 SHEETS

"AS-BUILT"