

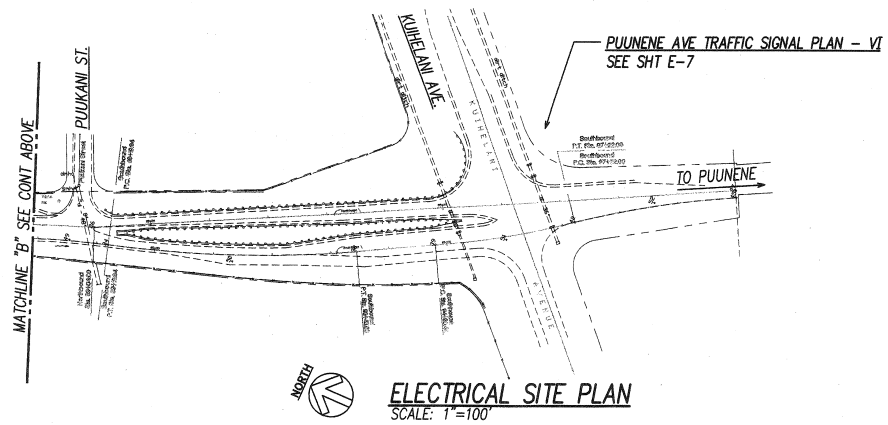



FED. ROAD DIST. NO.	STATE	PROJ. NO.	FISCAL YEAR	SHEET NO.	TOTAL SHEETS
HAWAII	HAWAII	HWY-M-04-00	2002	12	63

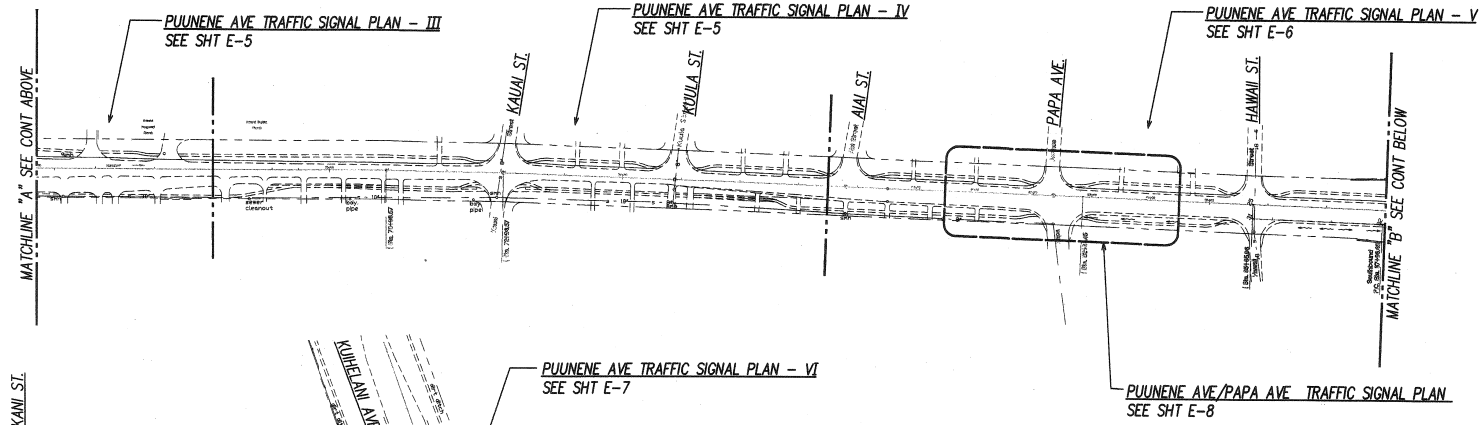

DESIGNED BY	DATE
DRAWN BY	
CHECKED BY	
IN CHARGE	

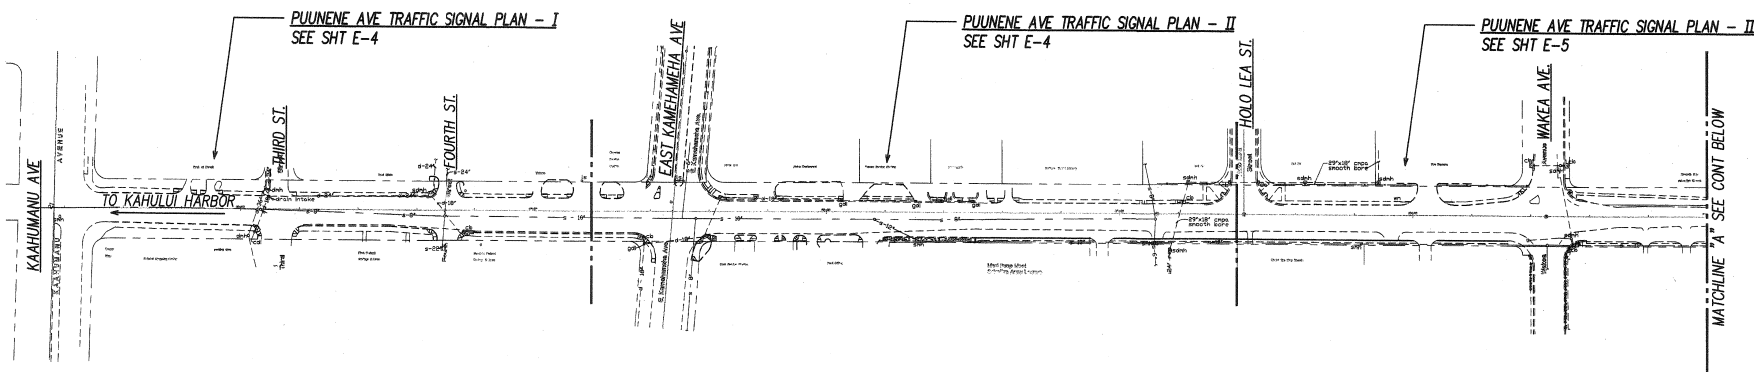

ELECTRICAL SITE PLAN
SCALE: 1"=100'

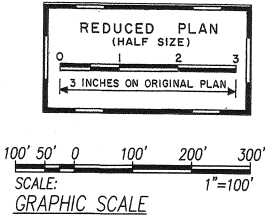

THIS WORK WAS PREPARED BY ME
OR UNDER MY SUPERVISION
Steven H. Sack

STATE OF HAWAII
DEPARTMENT OF TRANSPORTATION
HIGHWAYS DIVISION

**PUUNENE AVENUE
ELECTRICAL SITE PLAN**

TRAFFIC OPERATIONAL IMPROVEMENTS
AT VARIOUS LOCATIONS
PUUNENE AVENUE

Scale: AS NOTED Date: April 2002
SHEET No. E-3 OF 22 SHEETS